




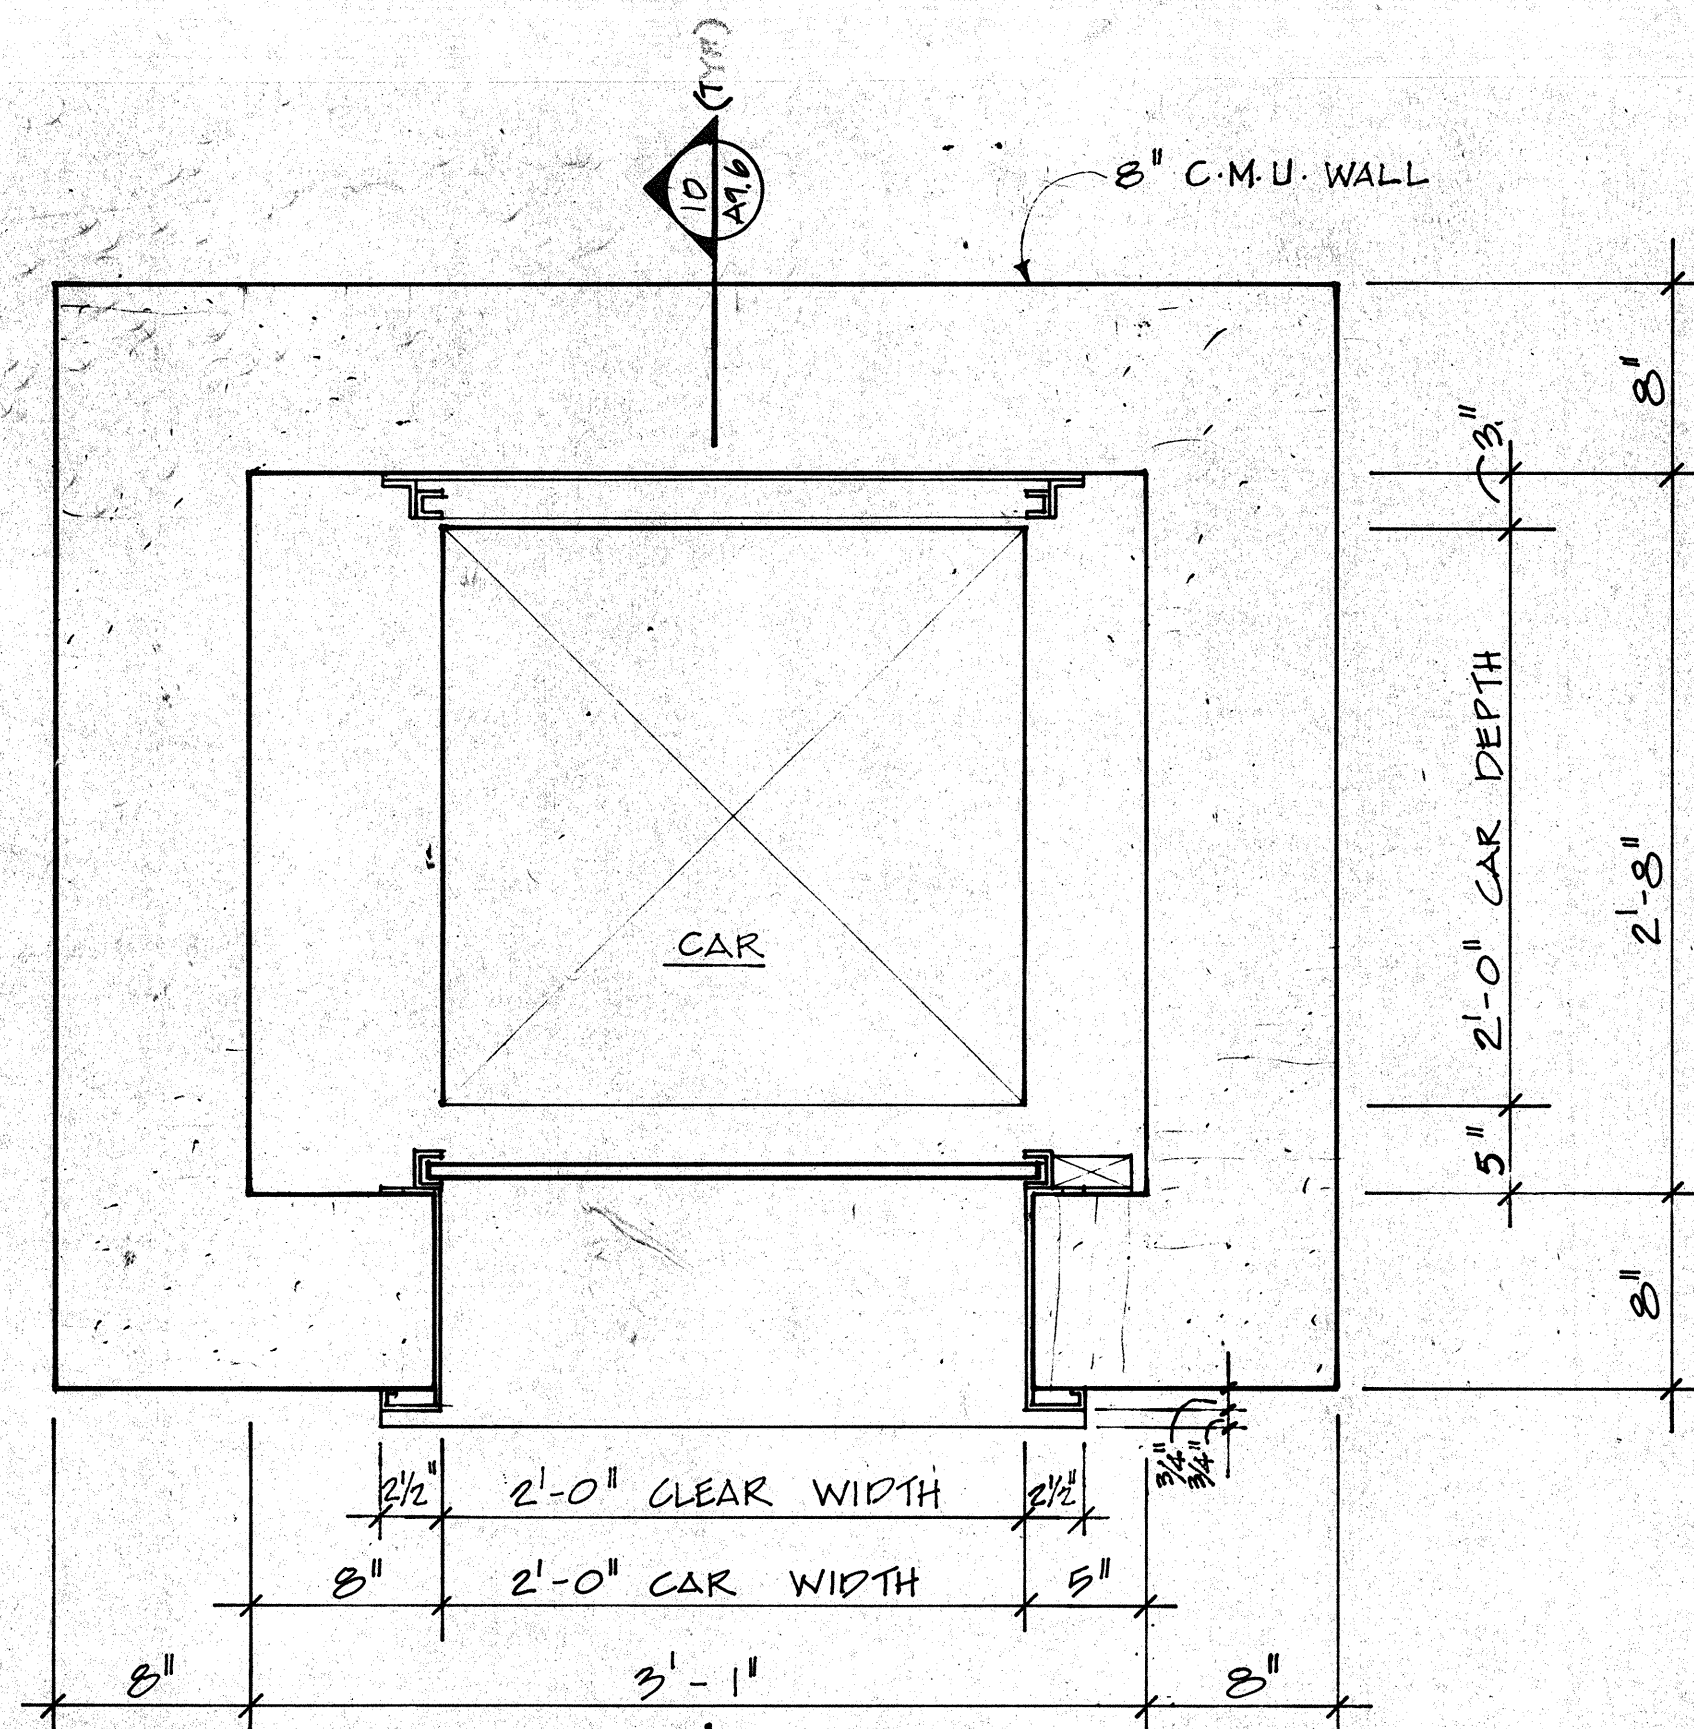


1 DUMBWATER PLAN
SCALE: 1 1/2" = 1'-0"

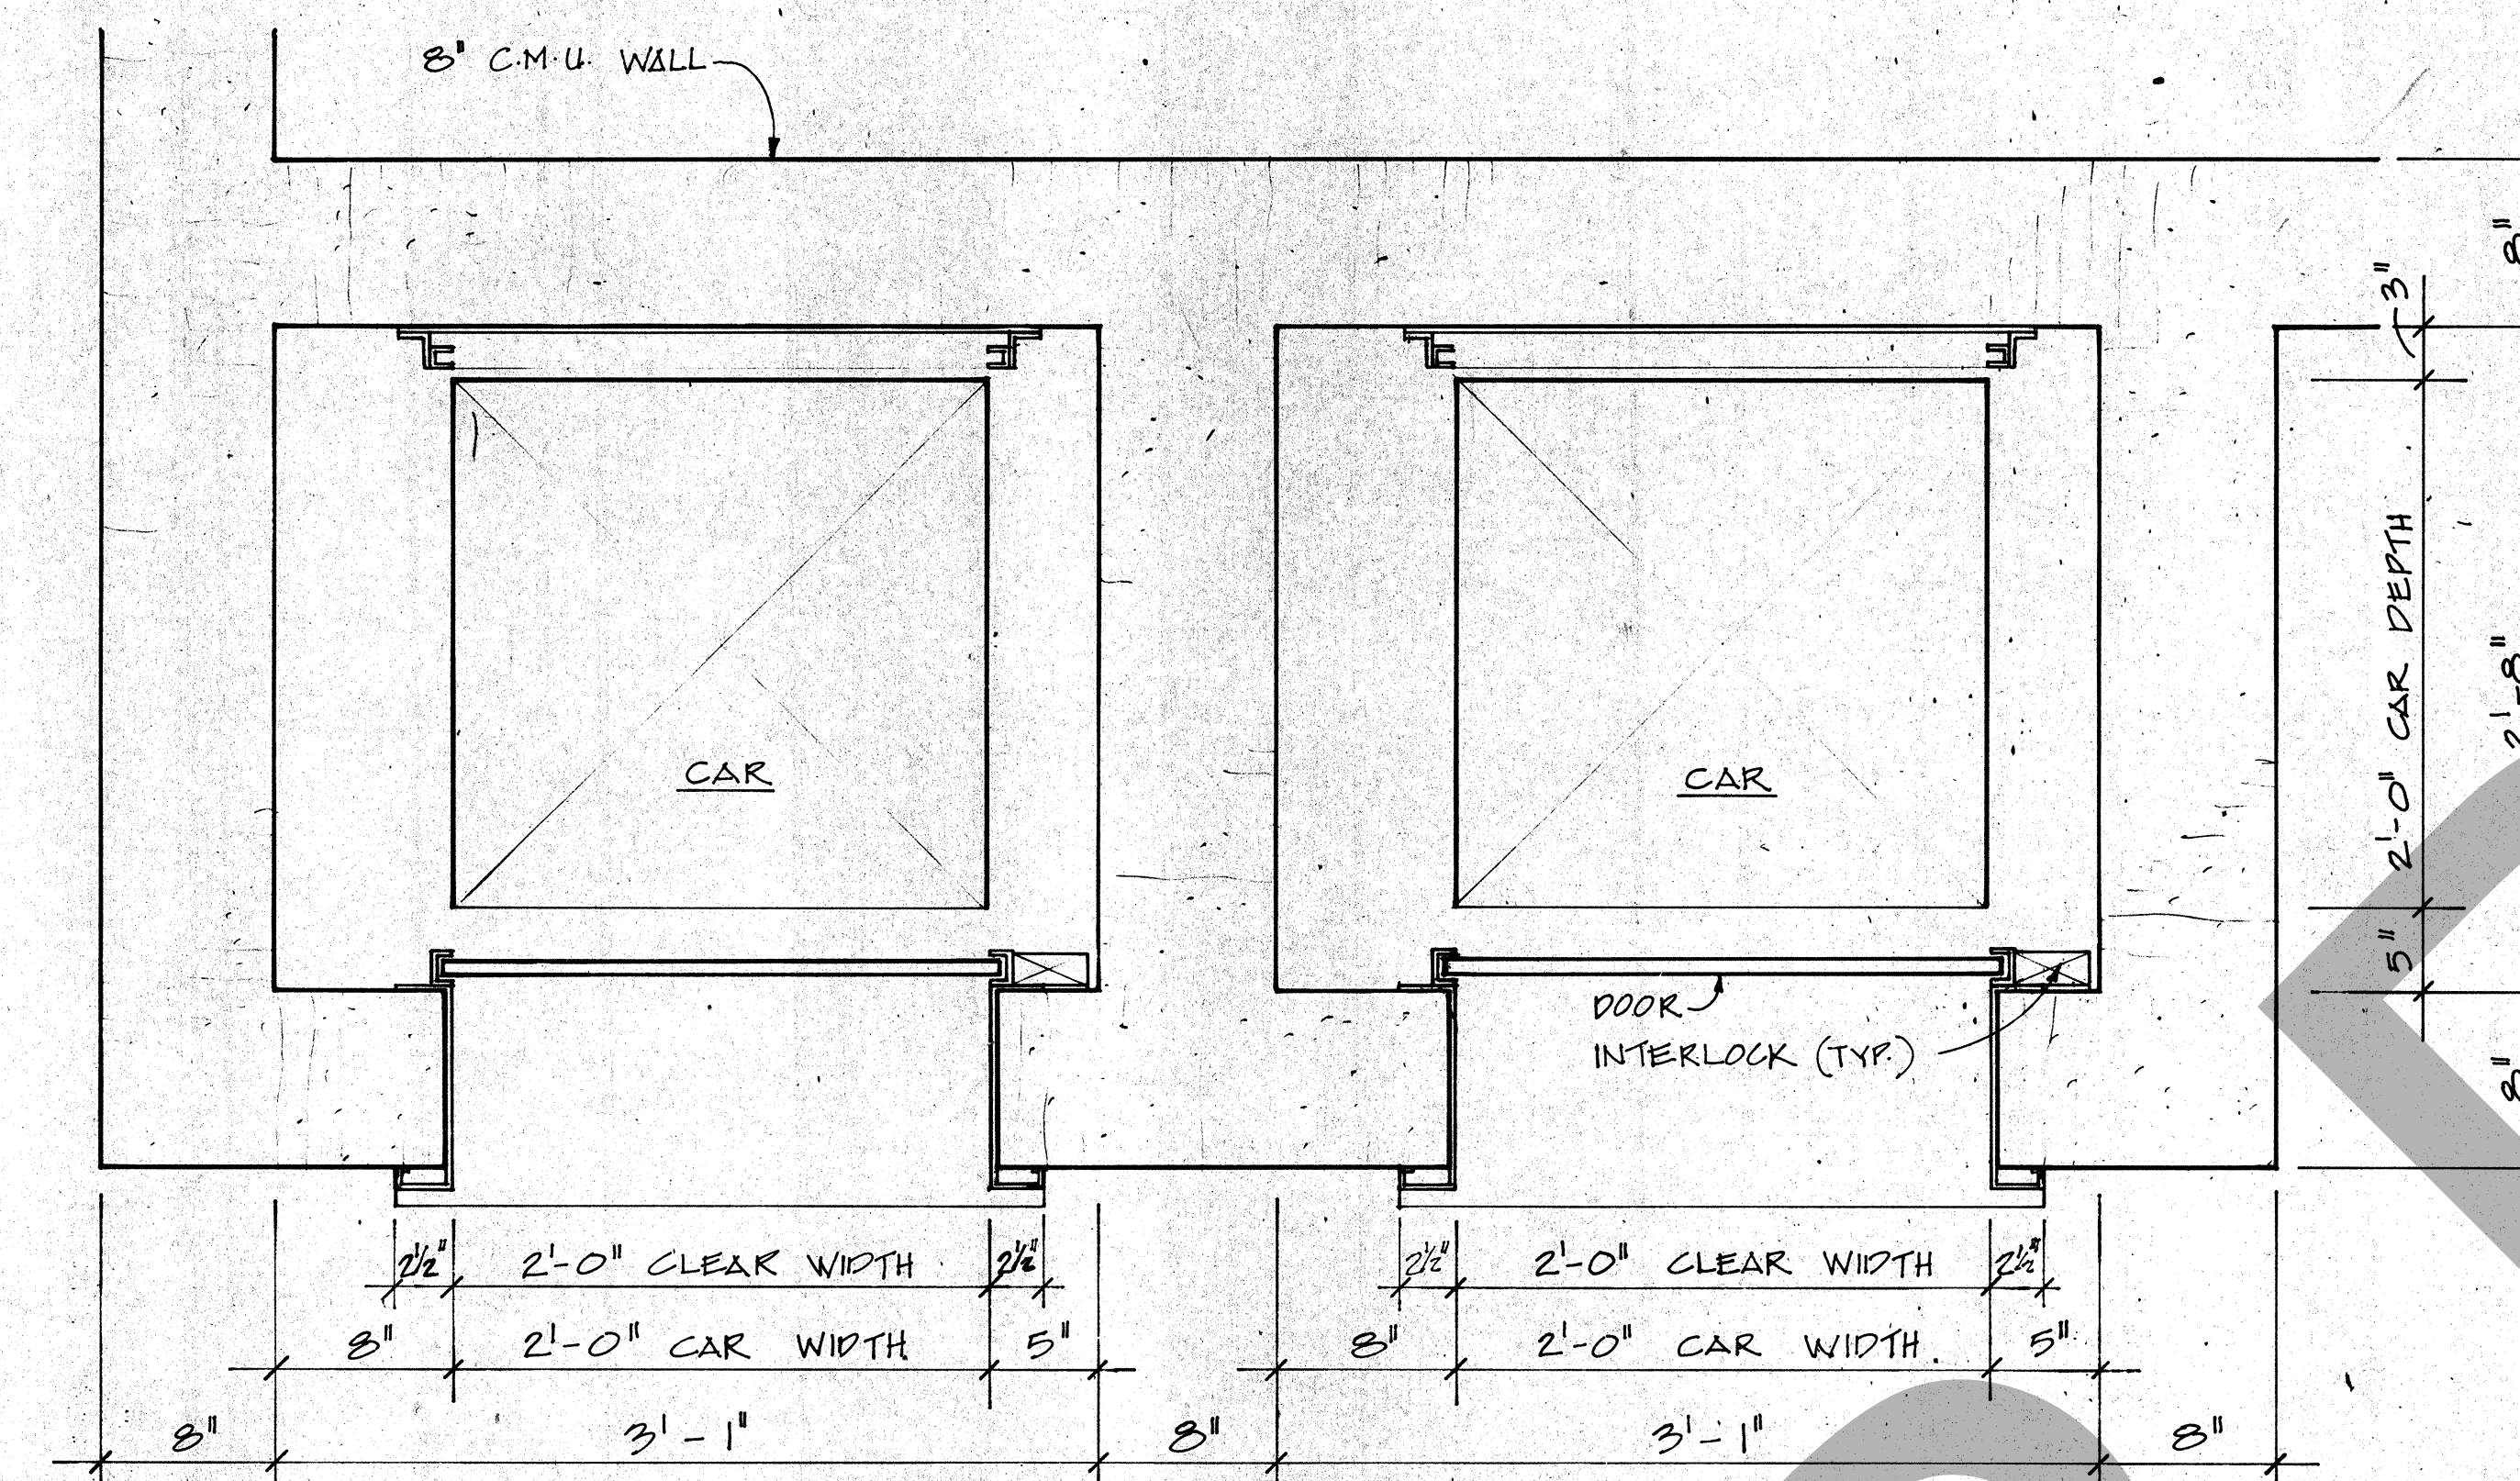


2 DUMBWATER PLAN
SCALE: 1 1/2" = 1'-0"

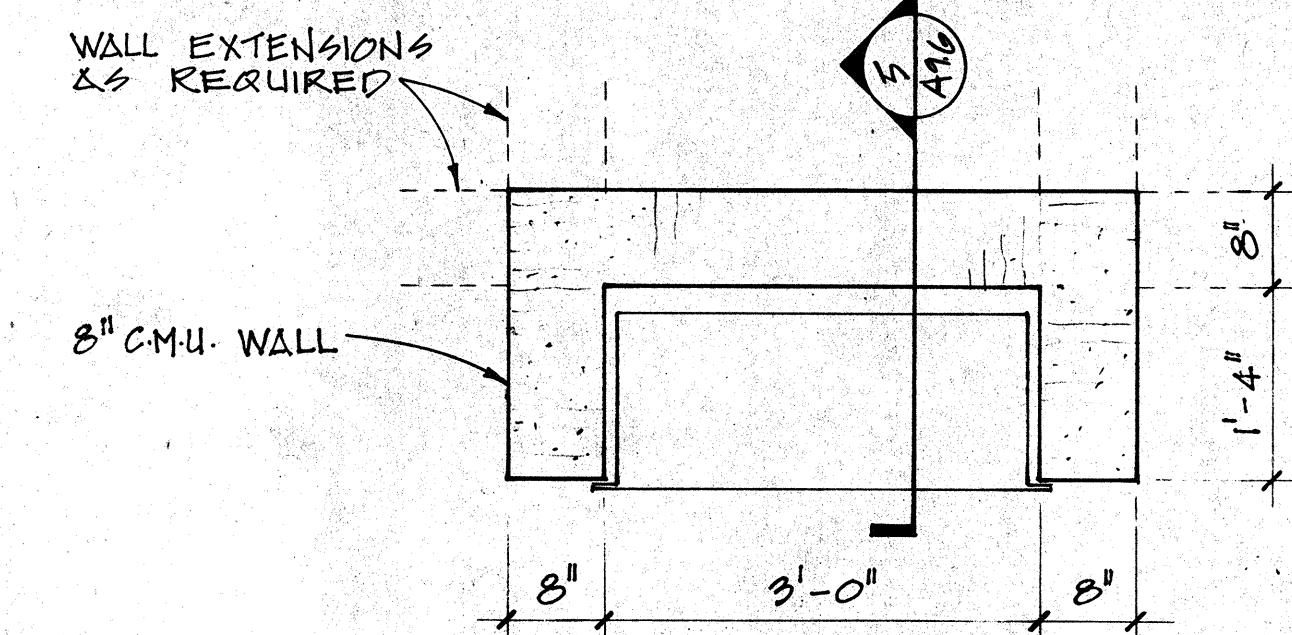


3 PNEUMATIC TUBE PLAN
SCALE: 3/4" = 1'-0"

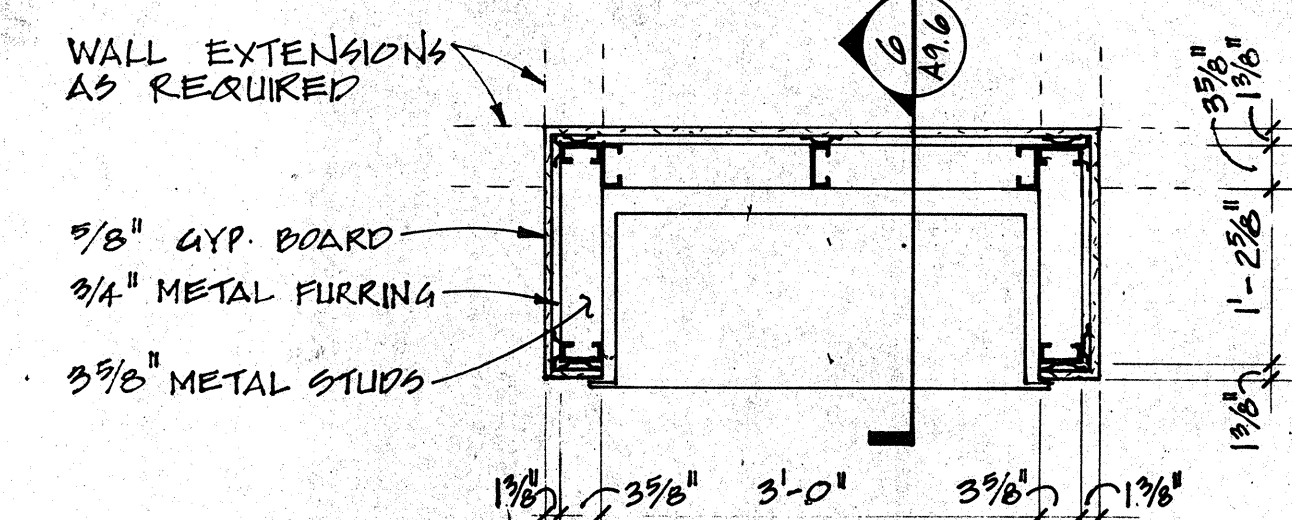


4 PNEUMATIC TUBE PLAN
SCALE: 3/4" = 1'-0"

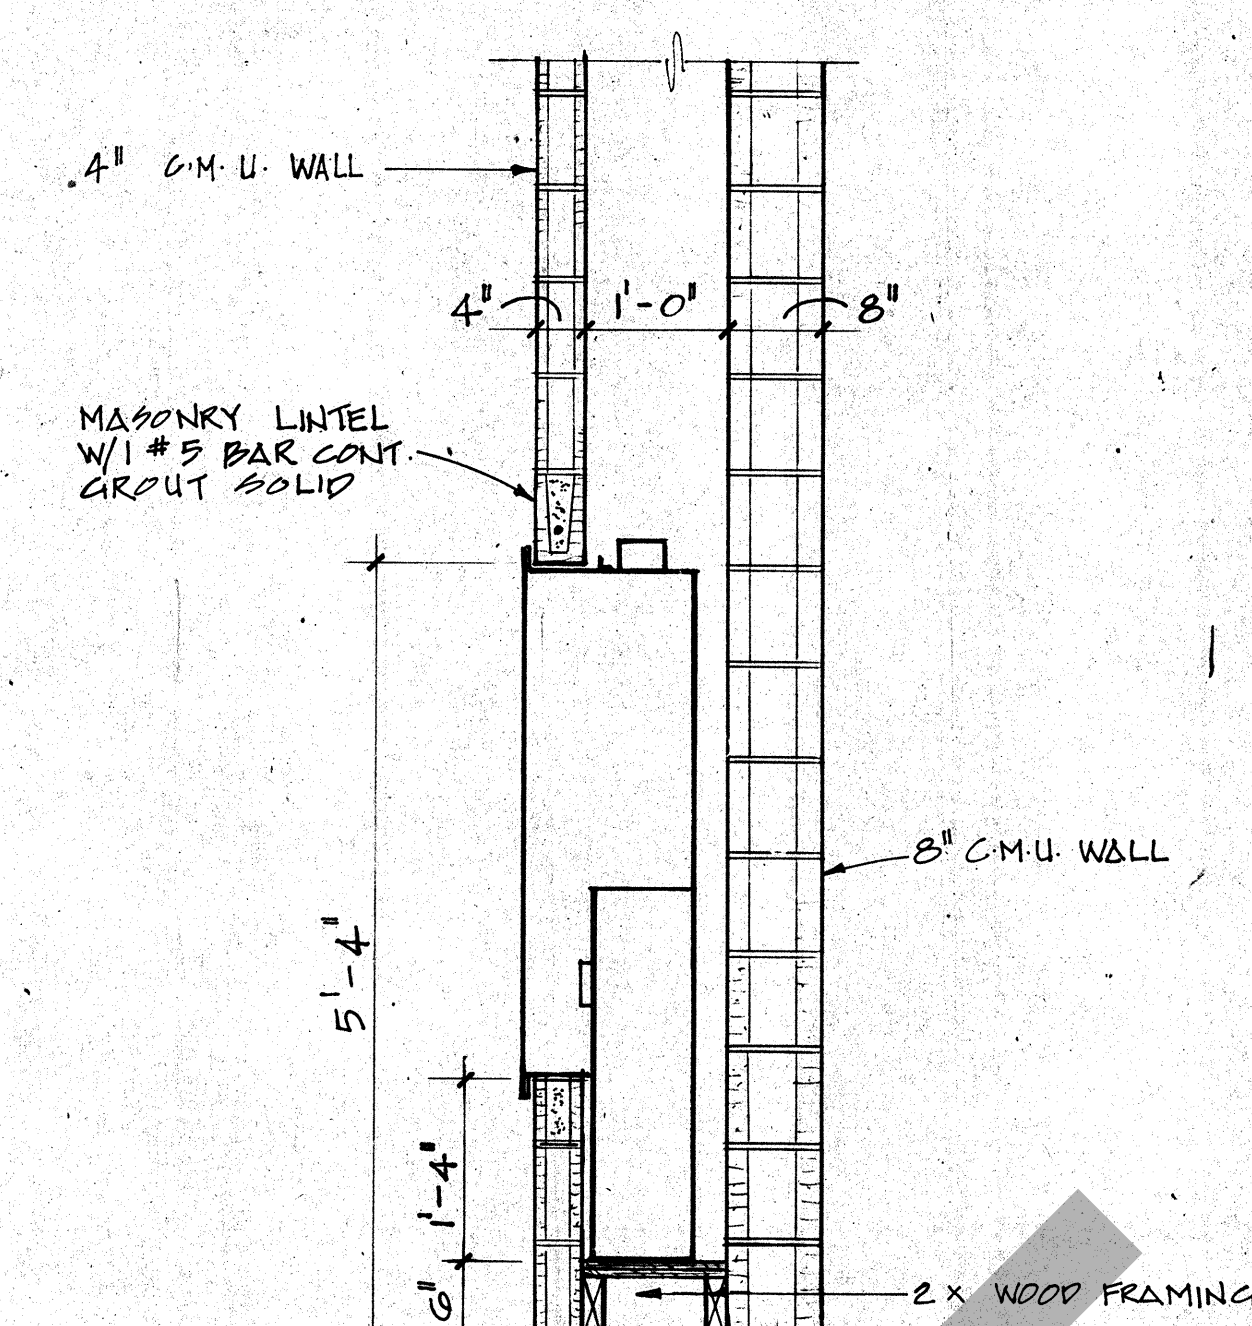


5 PNEUMATIC TUBE SECTION
SCALE: 3/4" = 1'-0"

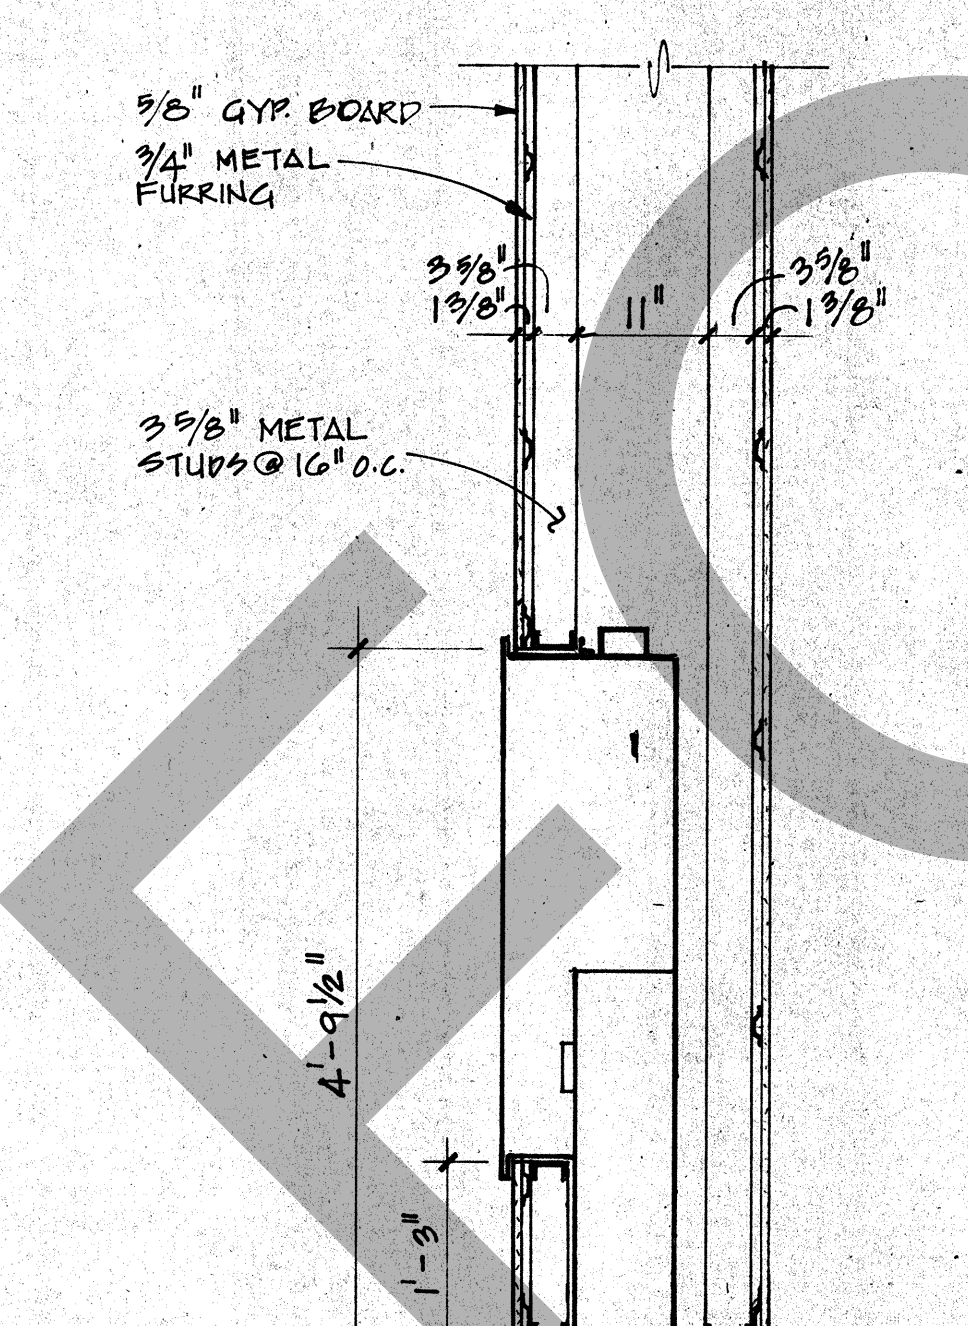


6 PNEUMATIC TUBE SECTION
SCALE: 3/4" = 1'-0"

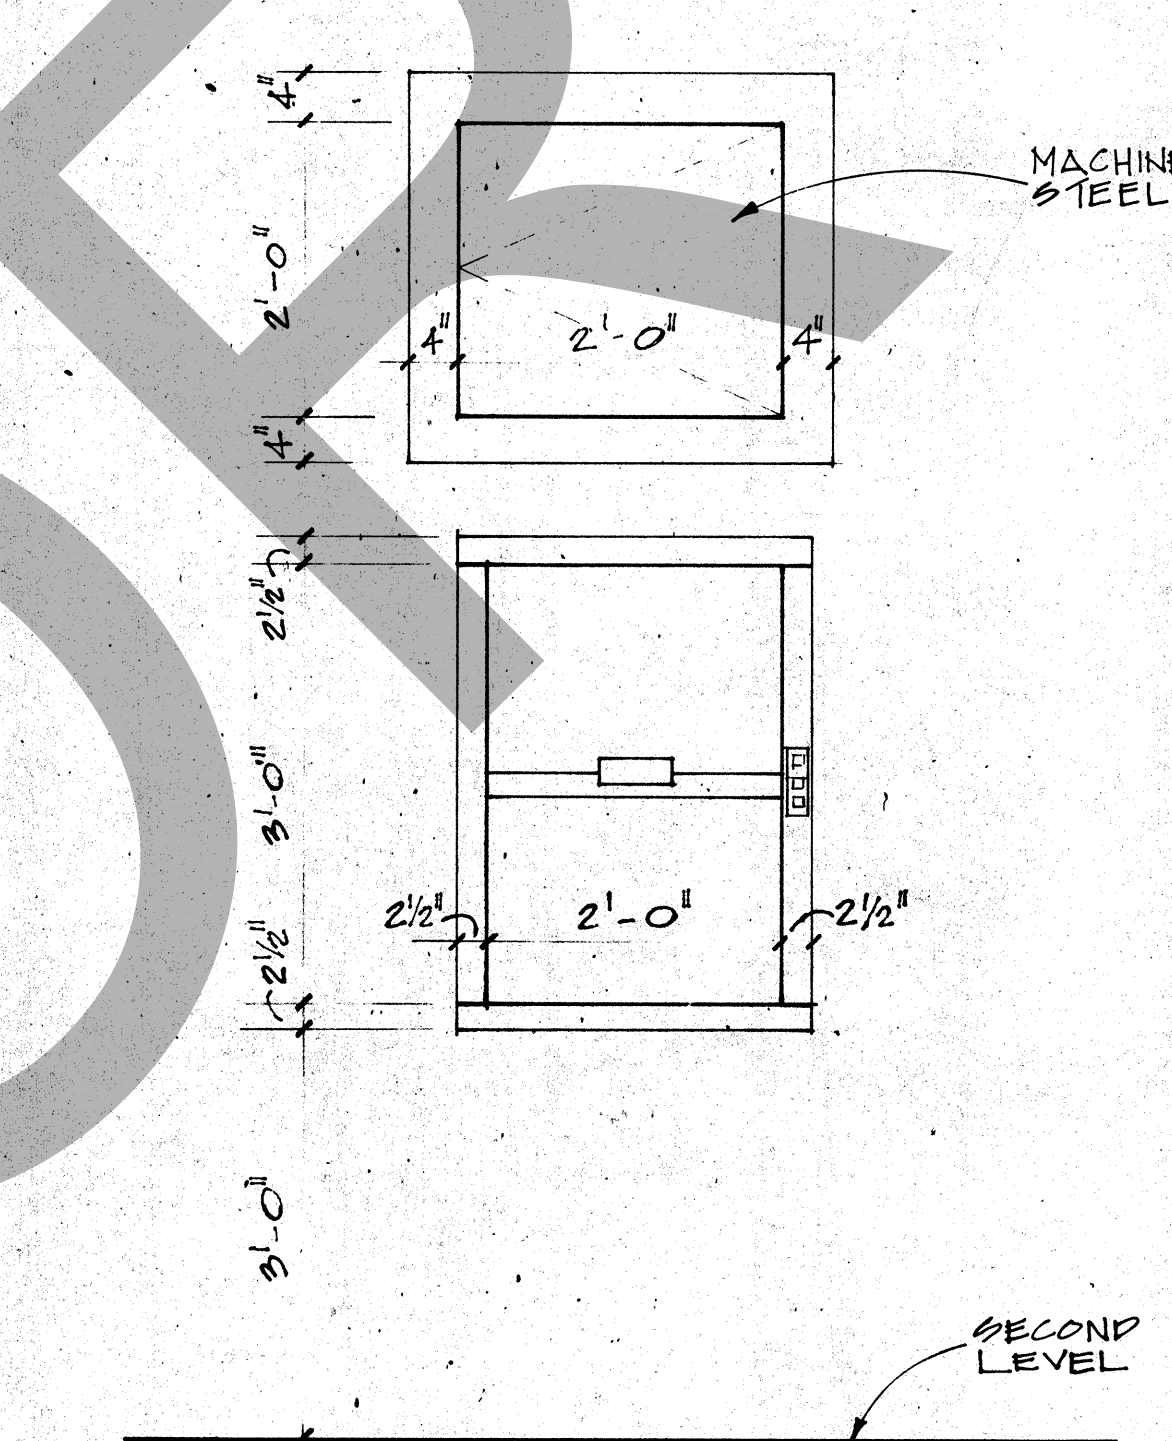


7 DUMBWATER ELEVATION
SCALE: 3/4" = 1'-0"

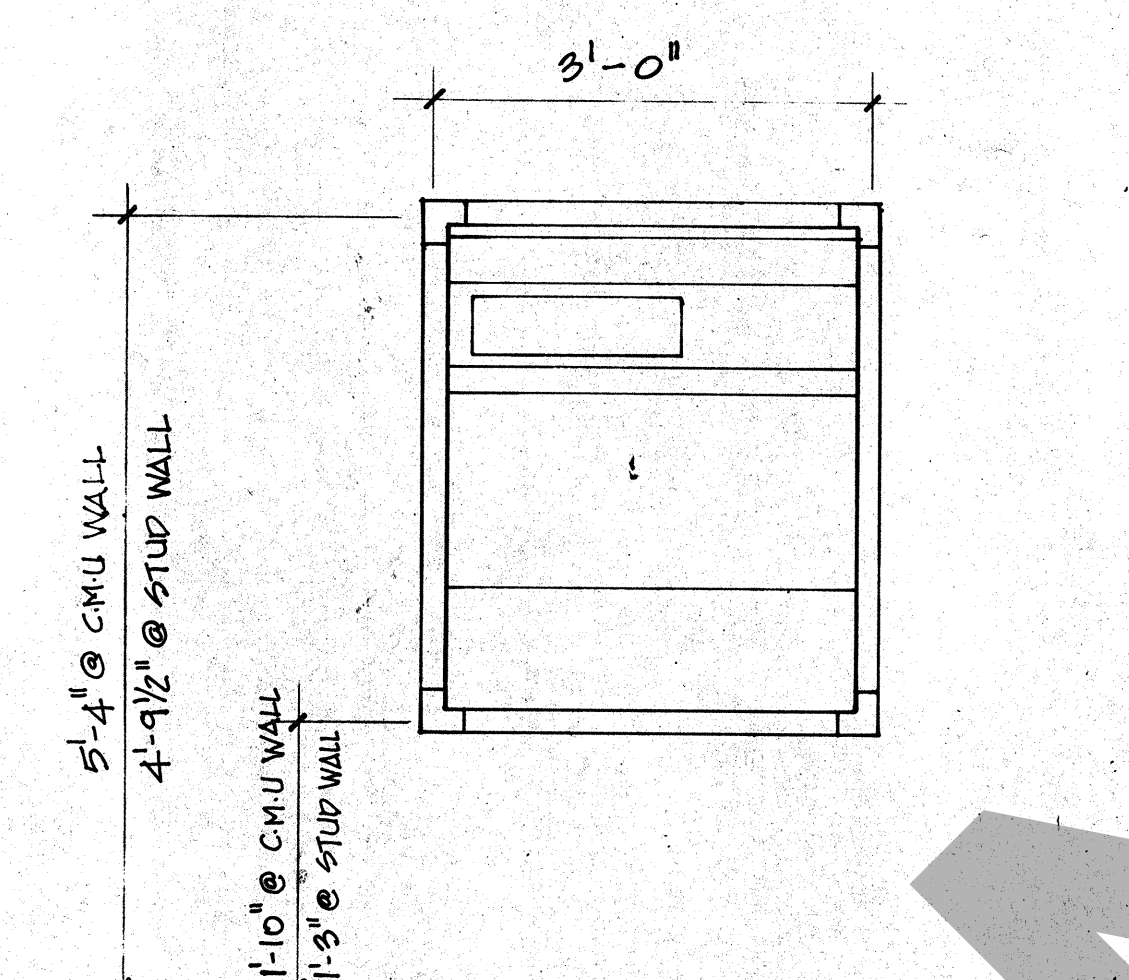


8 PNEUMATIC TUBE ELEVATION
SCALE: 3/4" = 1'-0"

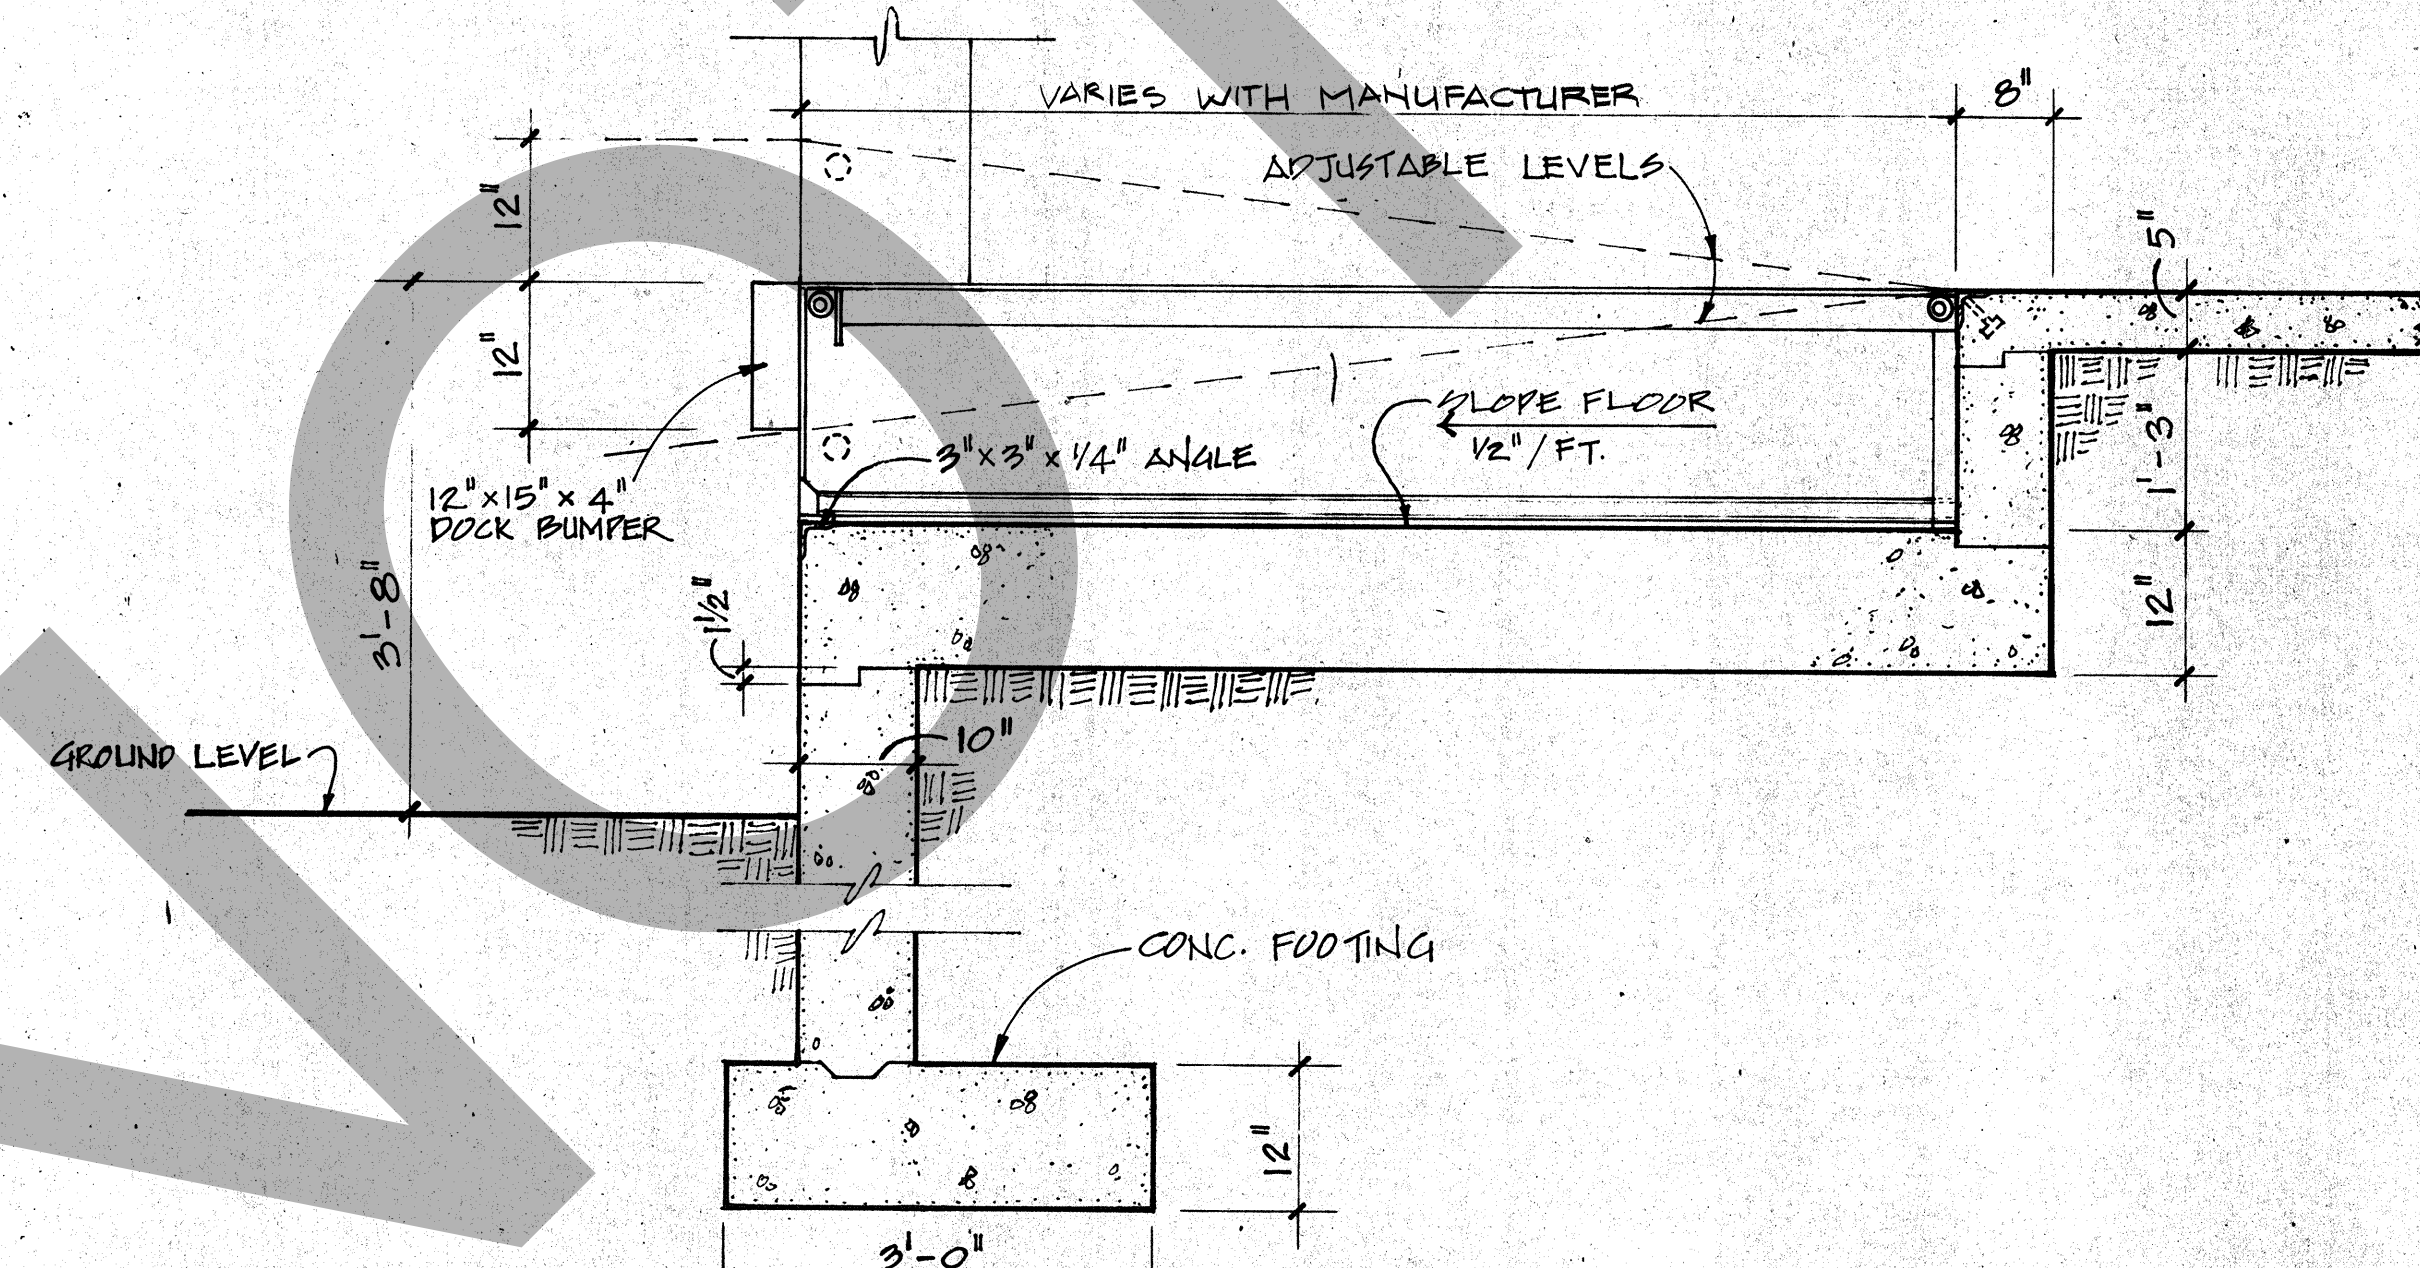


9 DOCK LEVELER SECTION
SCALE: 3/4" = 1'-0"

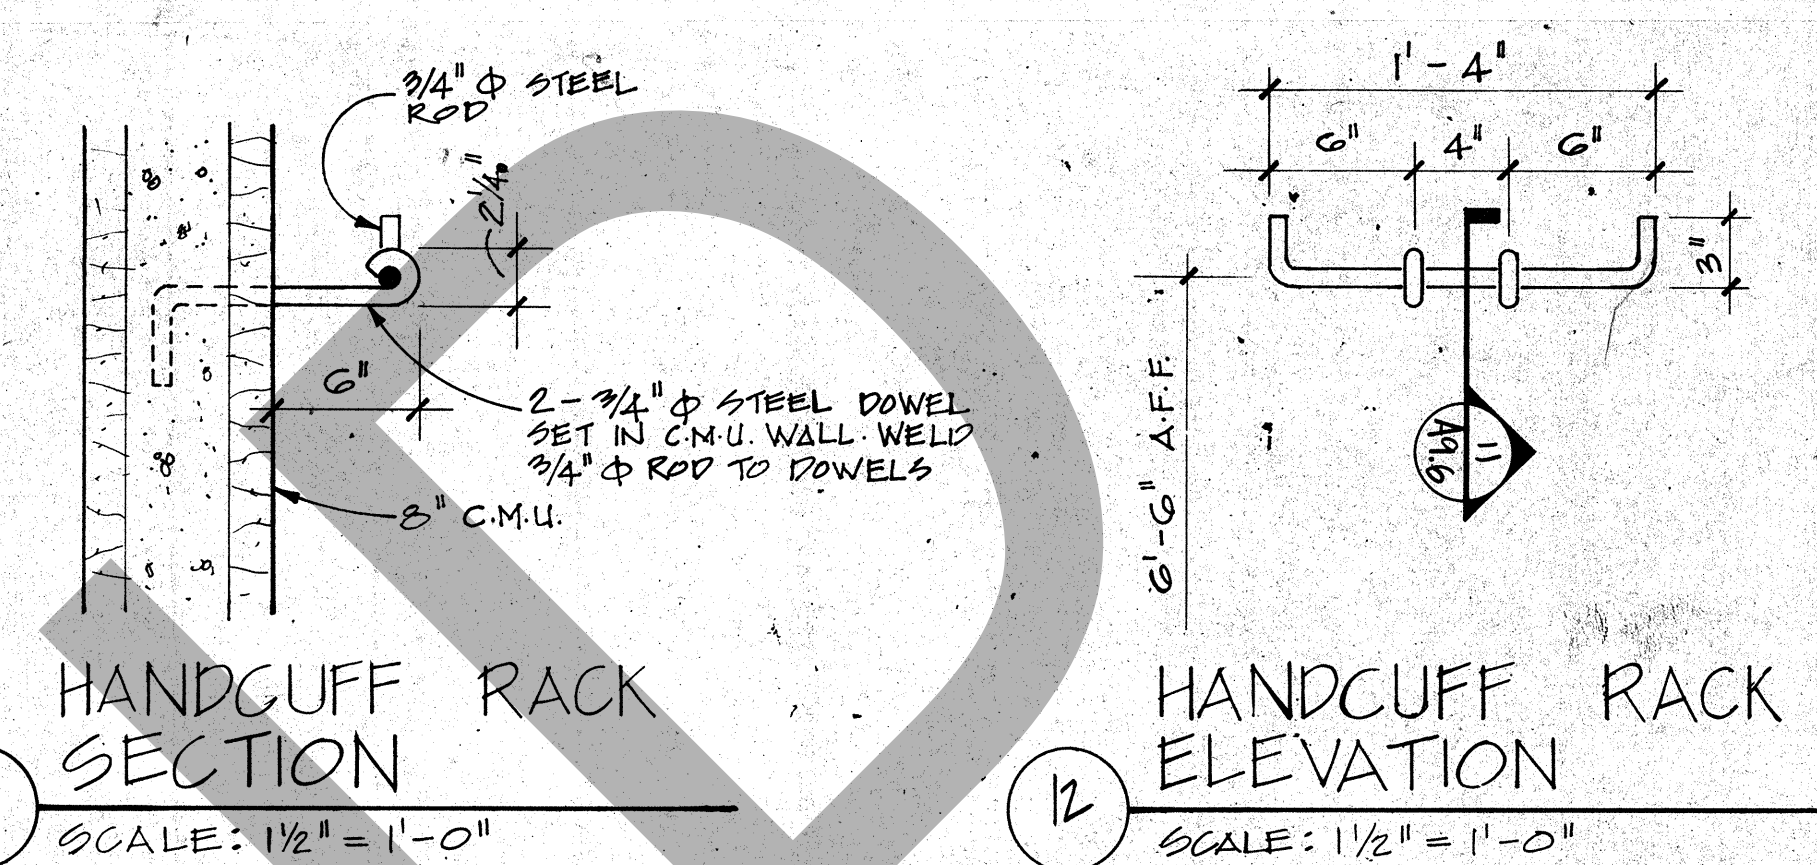

11 HANDCUFF RACK SECTION
SCALE: 1 1/2" = 1'-0"

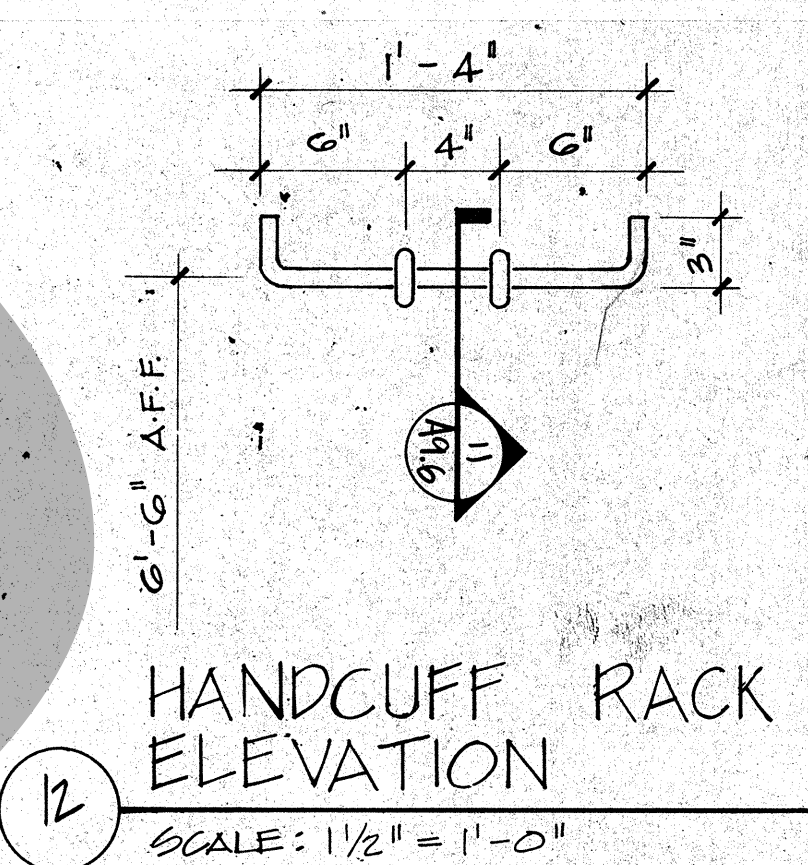

12 HANDCUFF RACK ELEVATION
SCALE: 1 1/2" = 1'-0"

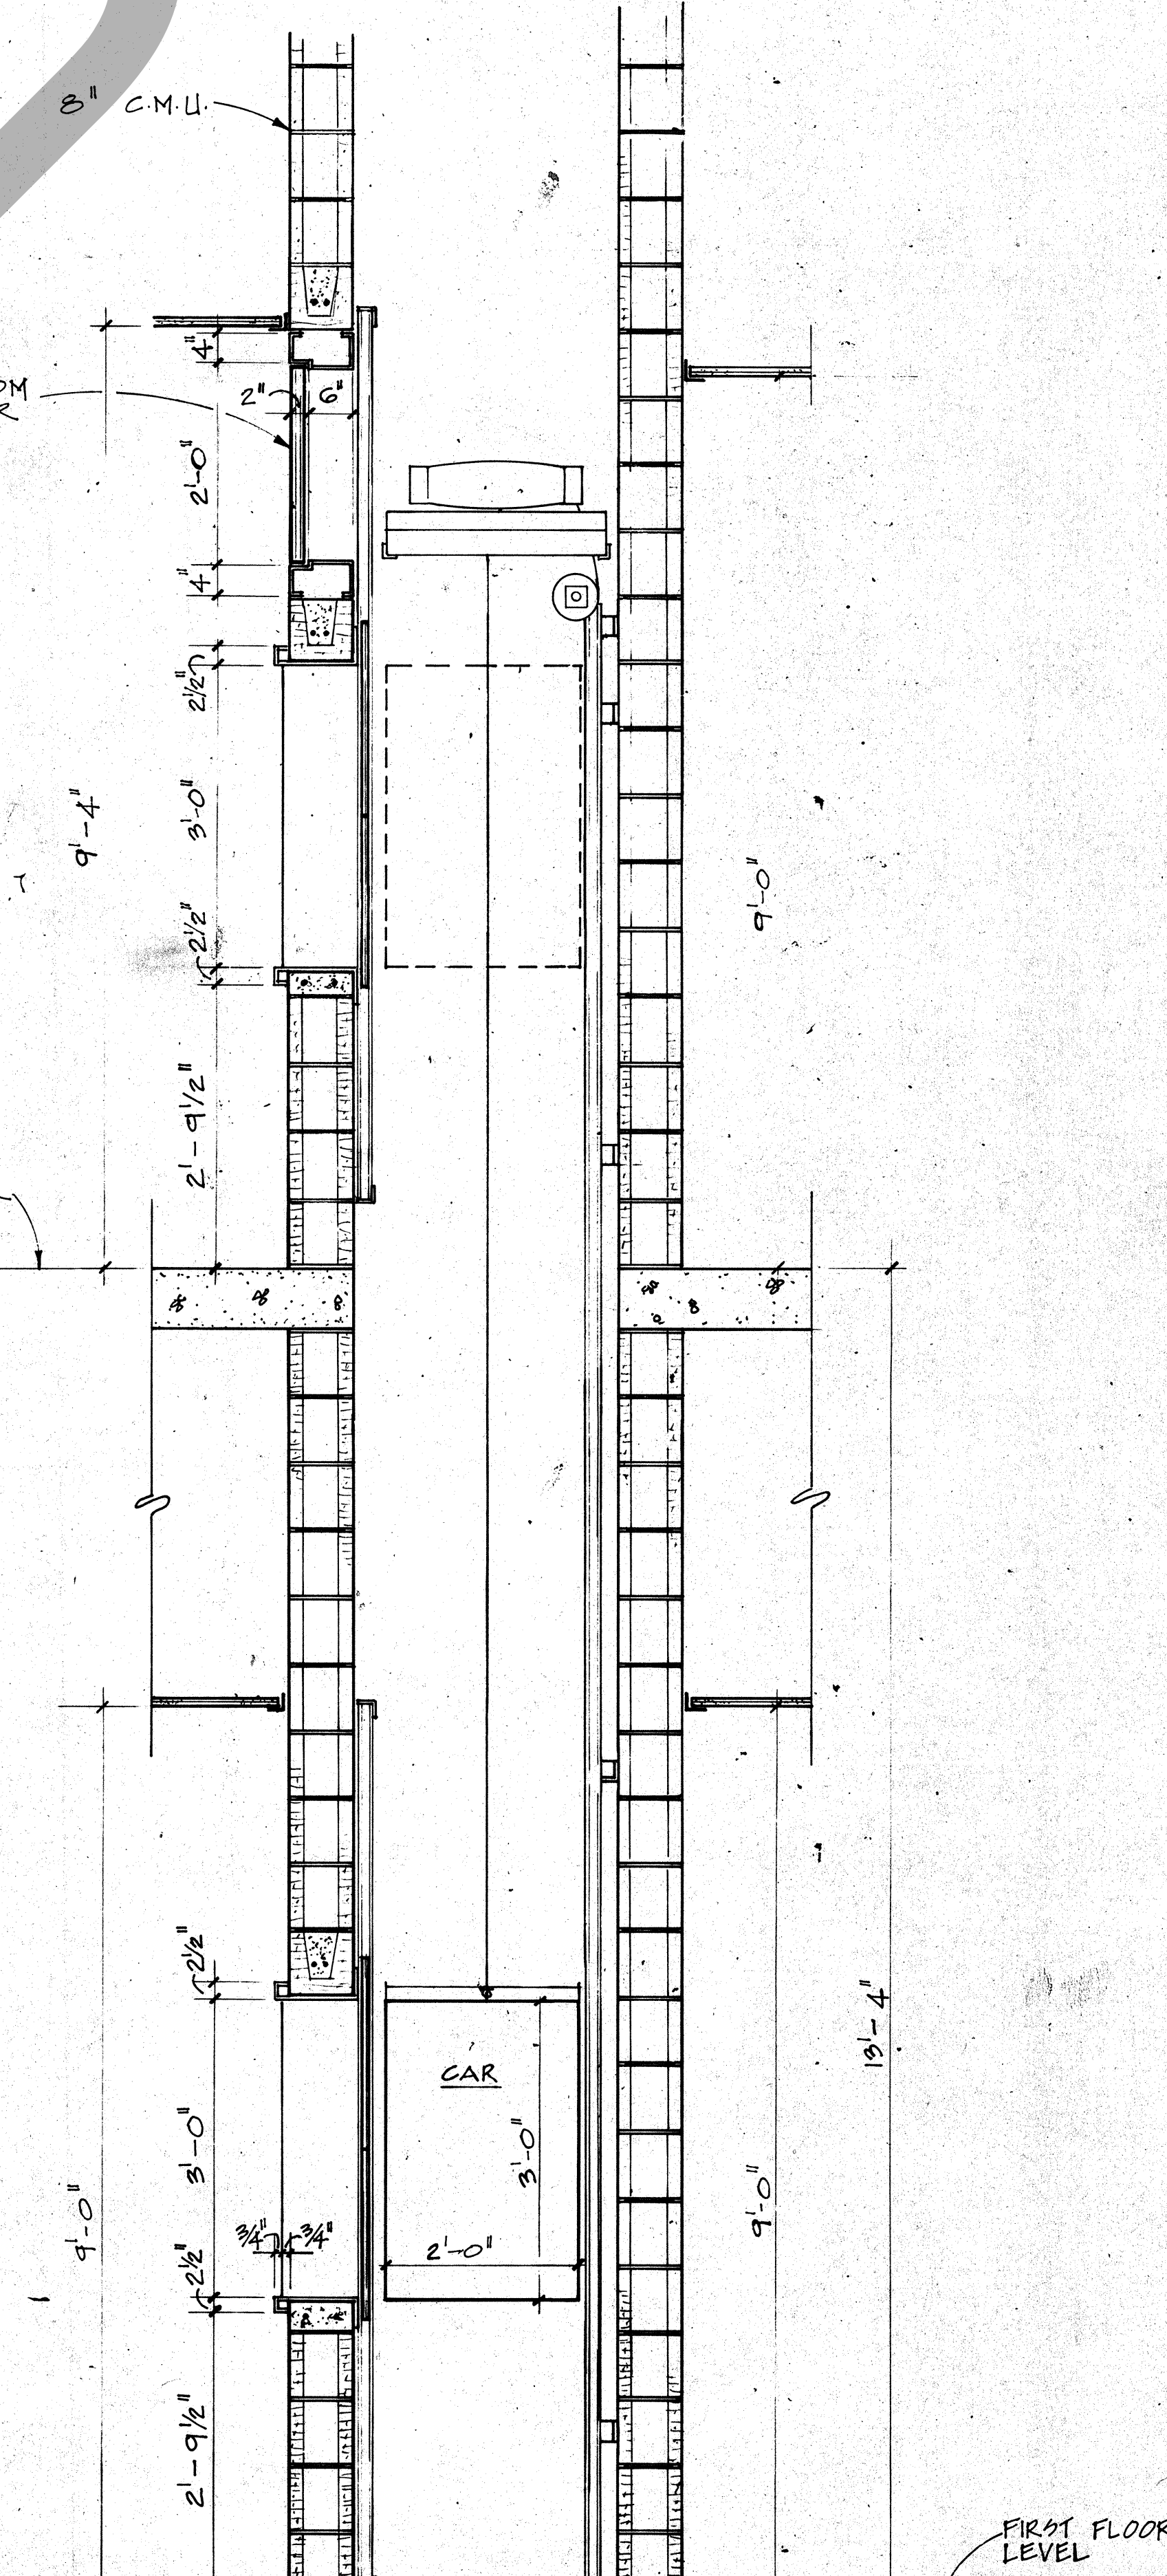

10 DUMBWATER SECTION
SCALE: 3/4" = 1'-0"

ROSSER FABRAP INTERNATIONAL
 Criminal Justice Architecture, Technology Planning, Interiors,
 Mechanical, Electrical, Plumbing, Security, & Civil Engineering.

JUSTICE SYSTEMS INCORPORATED
 Criminal Justice Operations, Programming
JOHNSON & NIELSEN
 Structural Engineering


WEST - VALLEY - DETENTION - CENTER
 FOR THE COUNTY OF SAN BERNARDINO, CALIFORNIA
HARRY MAYS, COUNTY ADMINISTRATION OFFICER
FLOYD TIDWELL, SHERIFF
BOARD OF SUPERVISORS
 John J. Jorgensen, Chairman, Ryan E. Bickel, Vice Chairman,
 Barbara C. Cramer, Director, David L. Hester, Director,
 Robert J. Hester, Director, John J. Jorgensen, Director

REVISIONS
 No. Date Description
 1 2/17/89 ADDENDA POSTED/ISSUED FOR CONSTRUCTION


STATE OF CALIFORNIA
 CIVIL ENGINEER
 No. C-015872
 EXPIRATION DATE 12/31/92
 REGISTERED ARCHITECT

DUMBWATER/ MISCELLANEOUS DETAILS

Job No. **WDC-0301**
 Date **10/17/88**

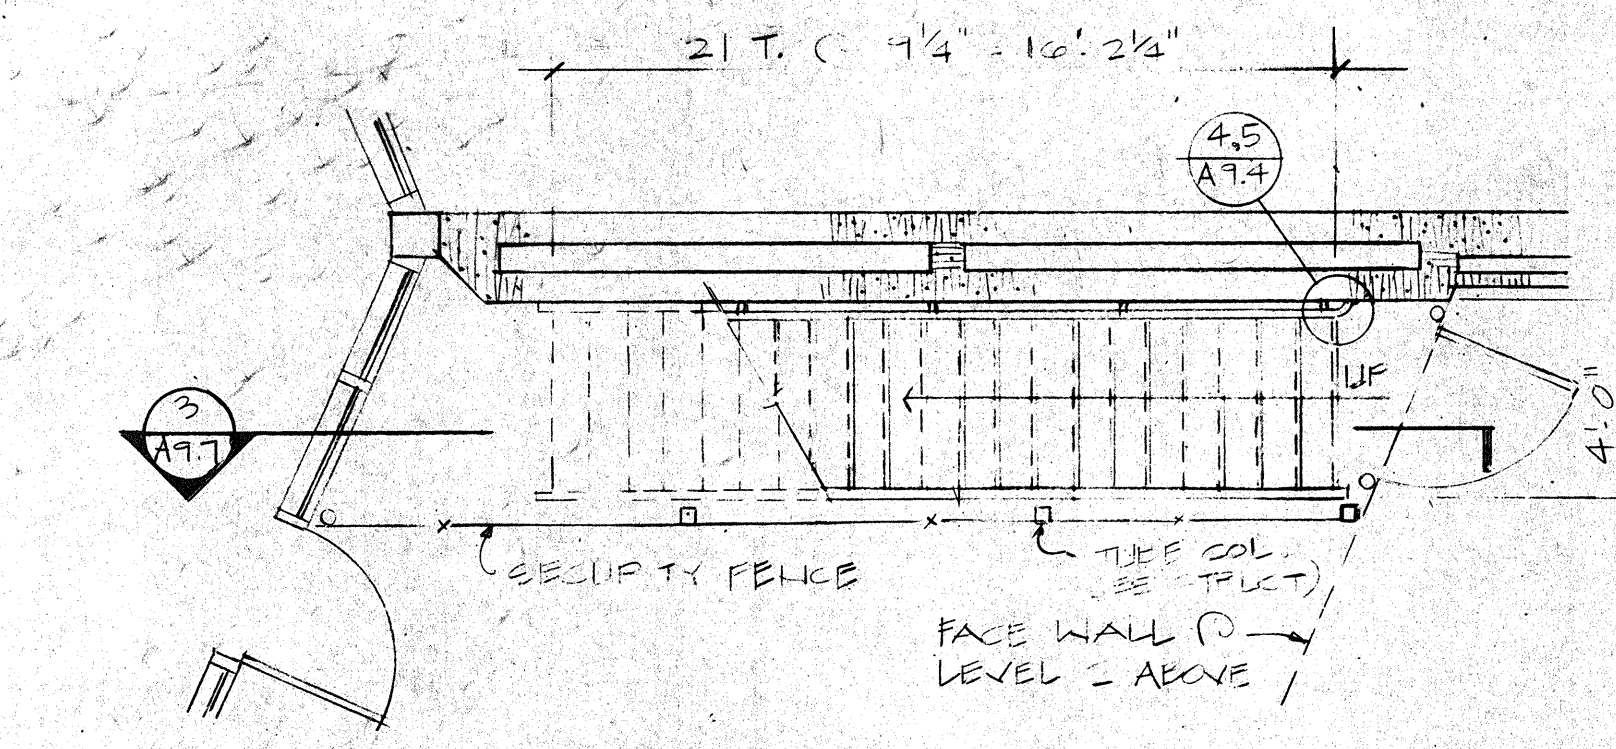


1 LEVEL 1 PLAN

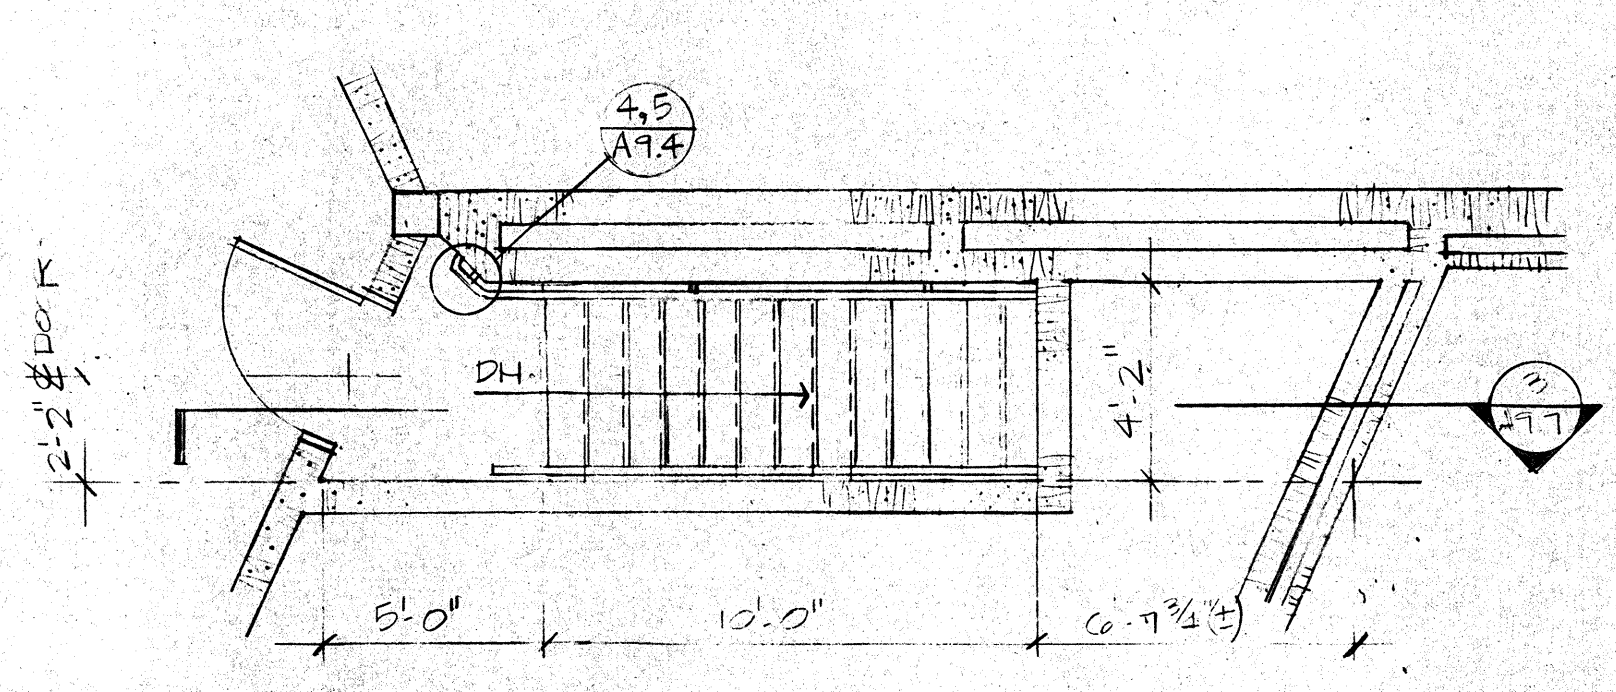


2 LEVEL 2 PLAN

STAIRS EACH HOUSING UNIT SEGMENT "H"

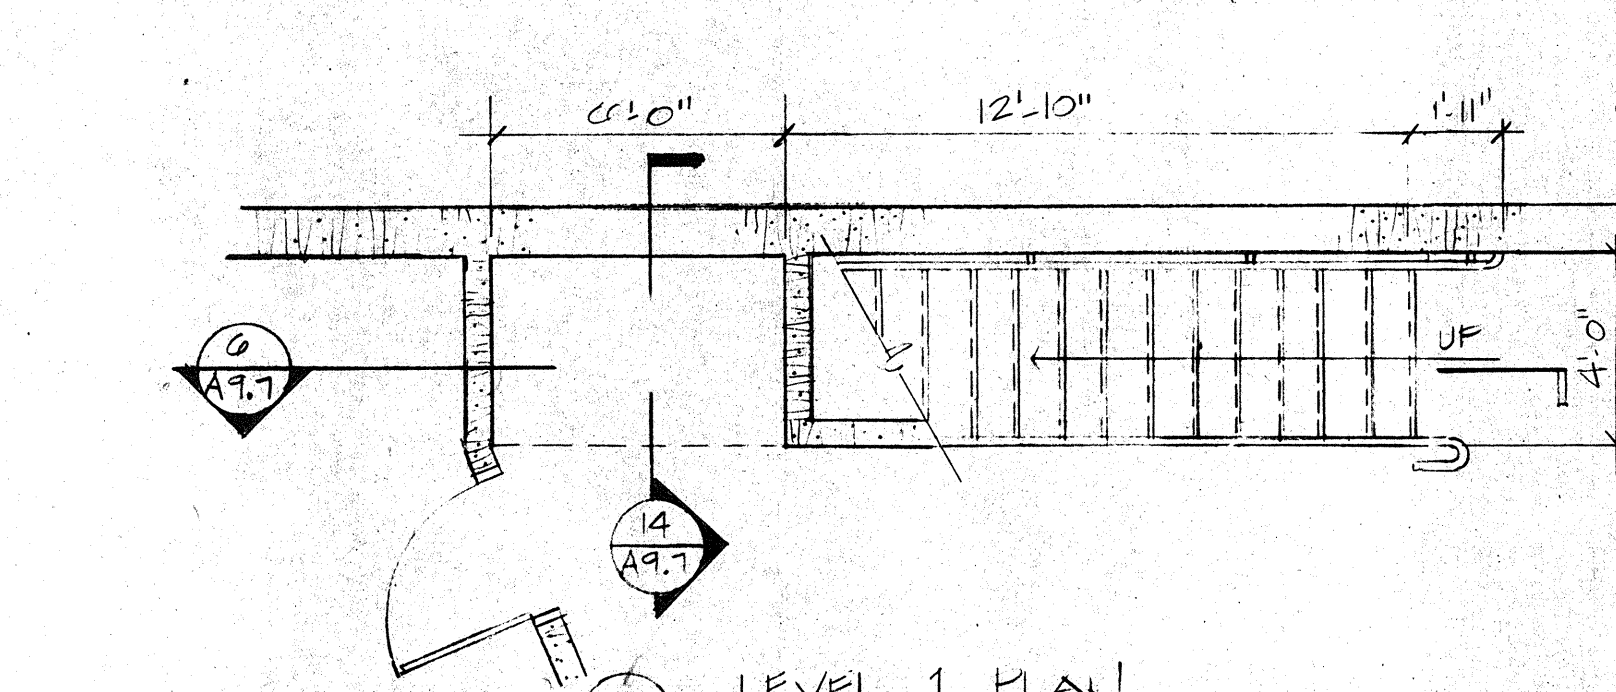


3 LEVEL 1 PLAN

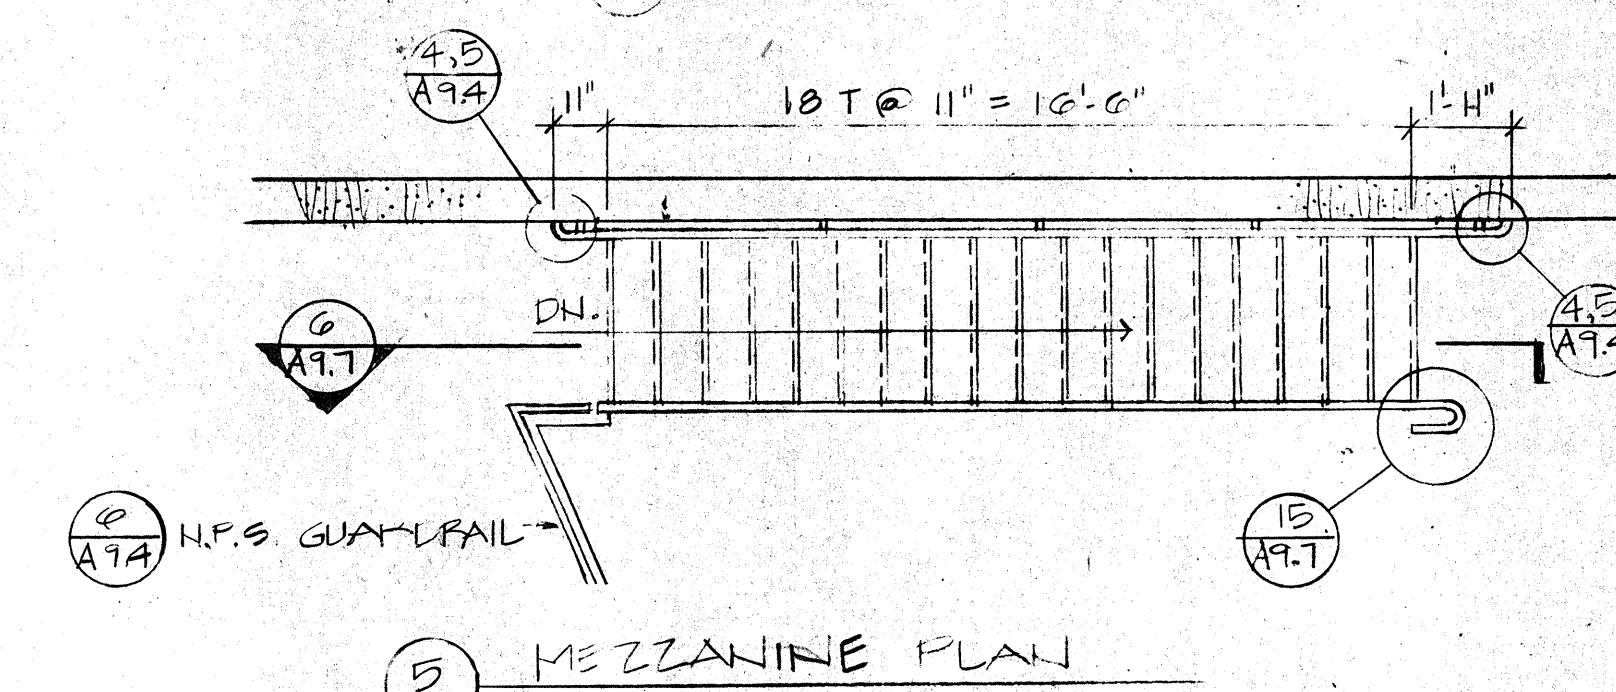


4 MEZZANINE PLAN

STAIRS EACH HOUSING UNIT SEGMENT "G"

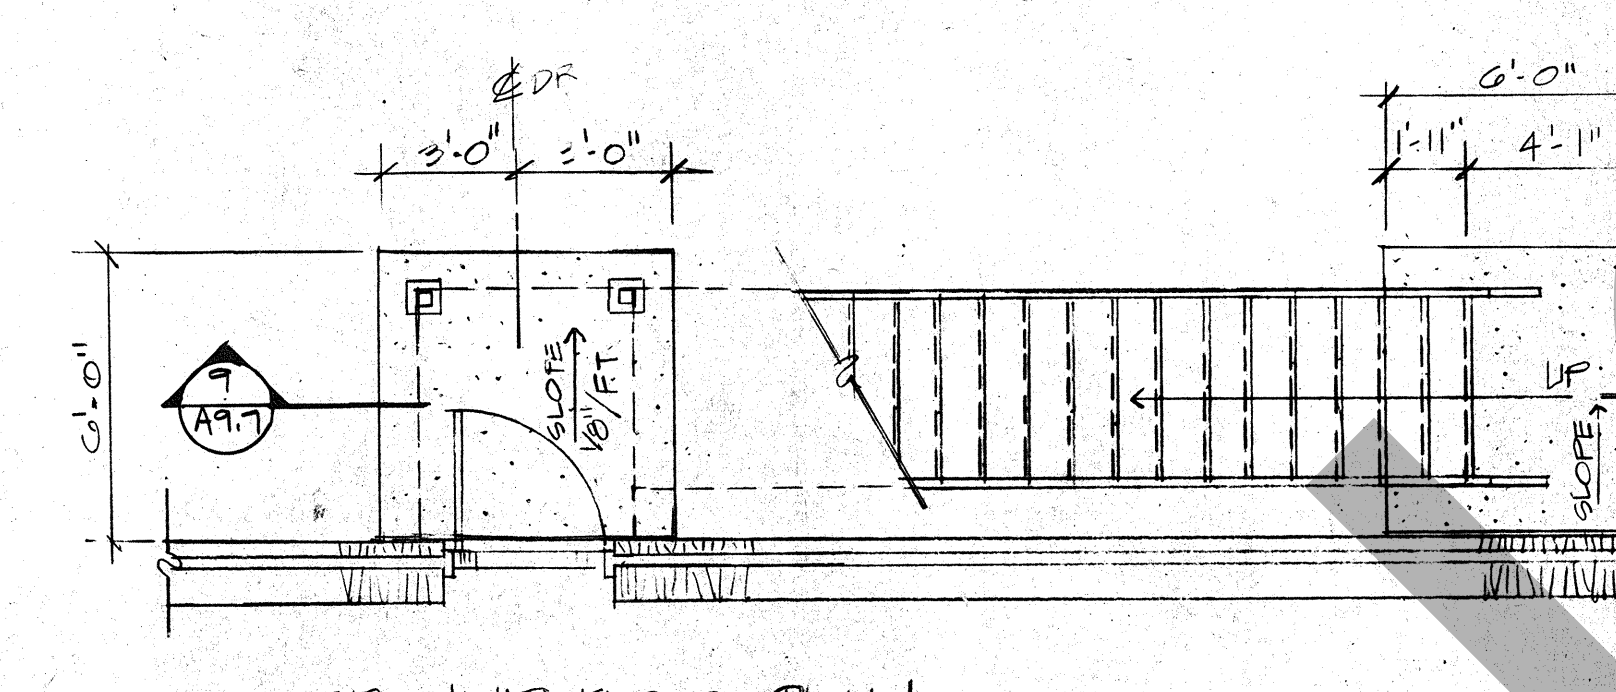


5 GROUND FLOOR PLAN

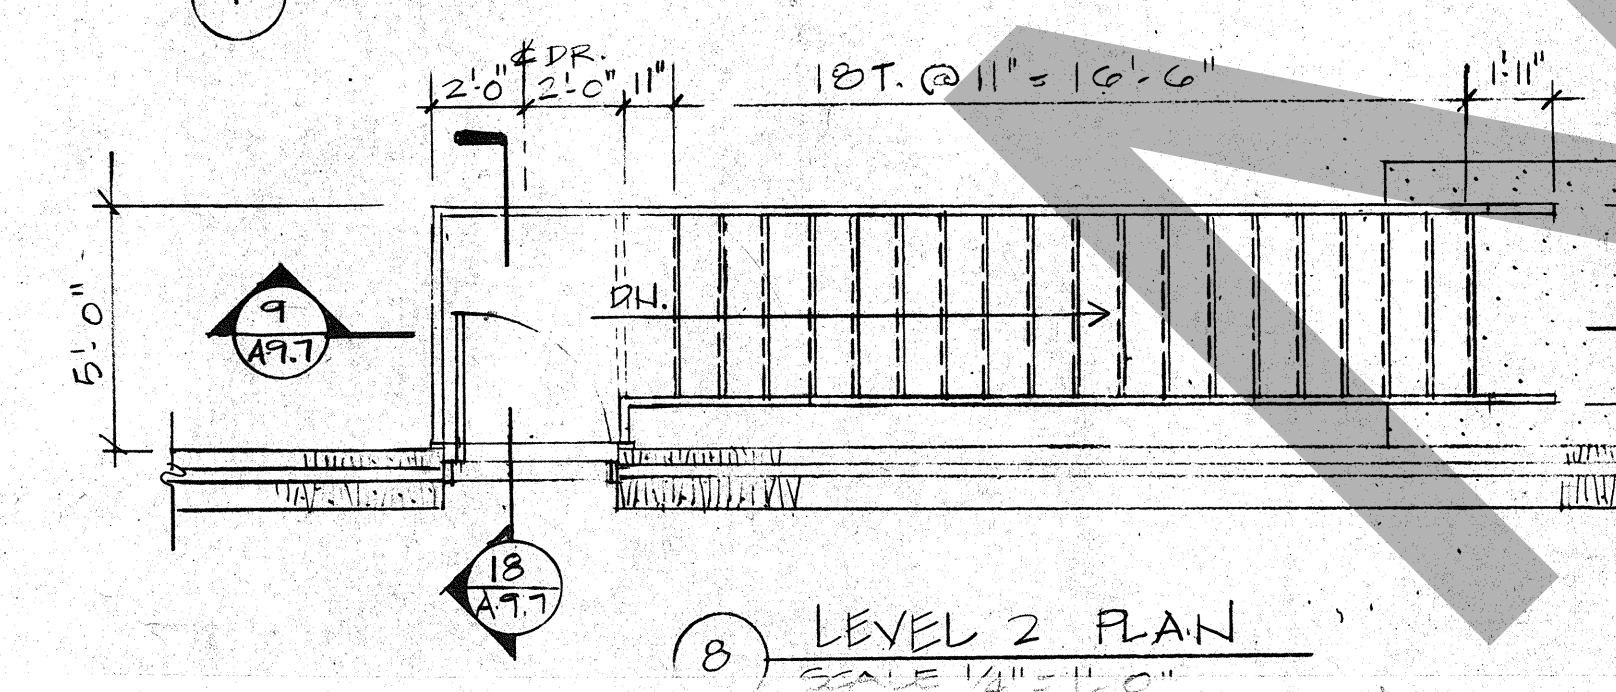


6 LEVEL 2 PLAN


STAIRS E1, E2, E3, E4, E5, E6, E7, E8
SEE PLANS FOR DETAIL CONDITIONS

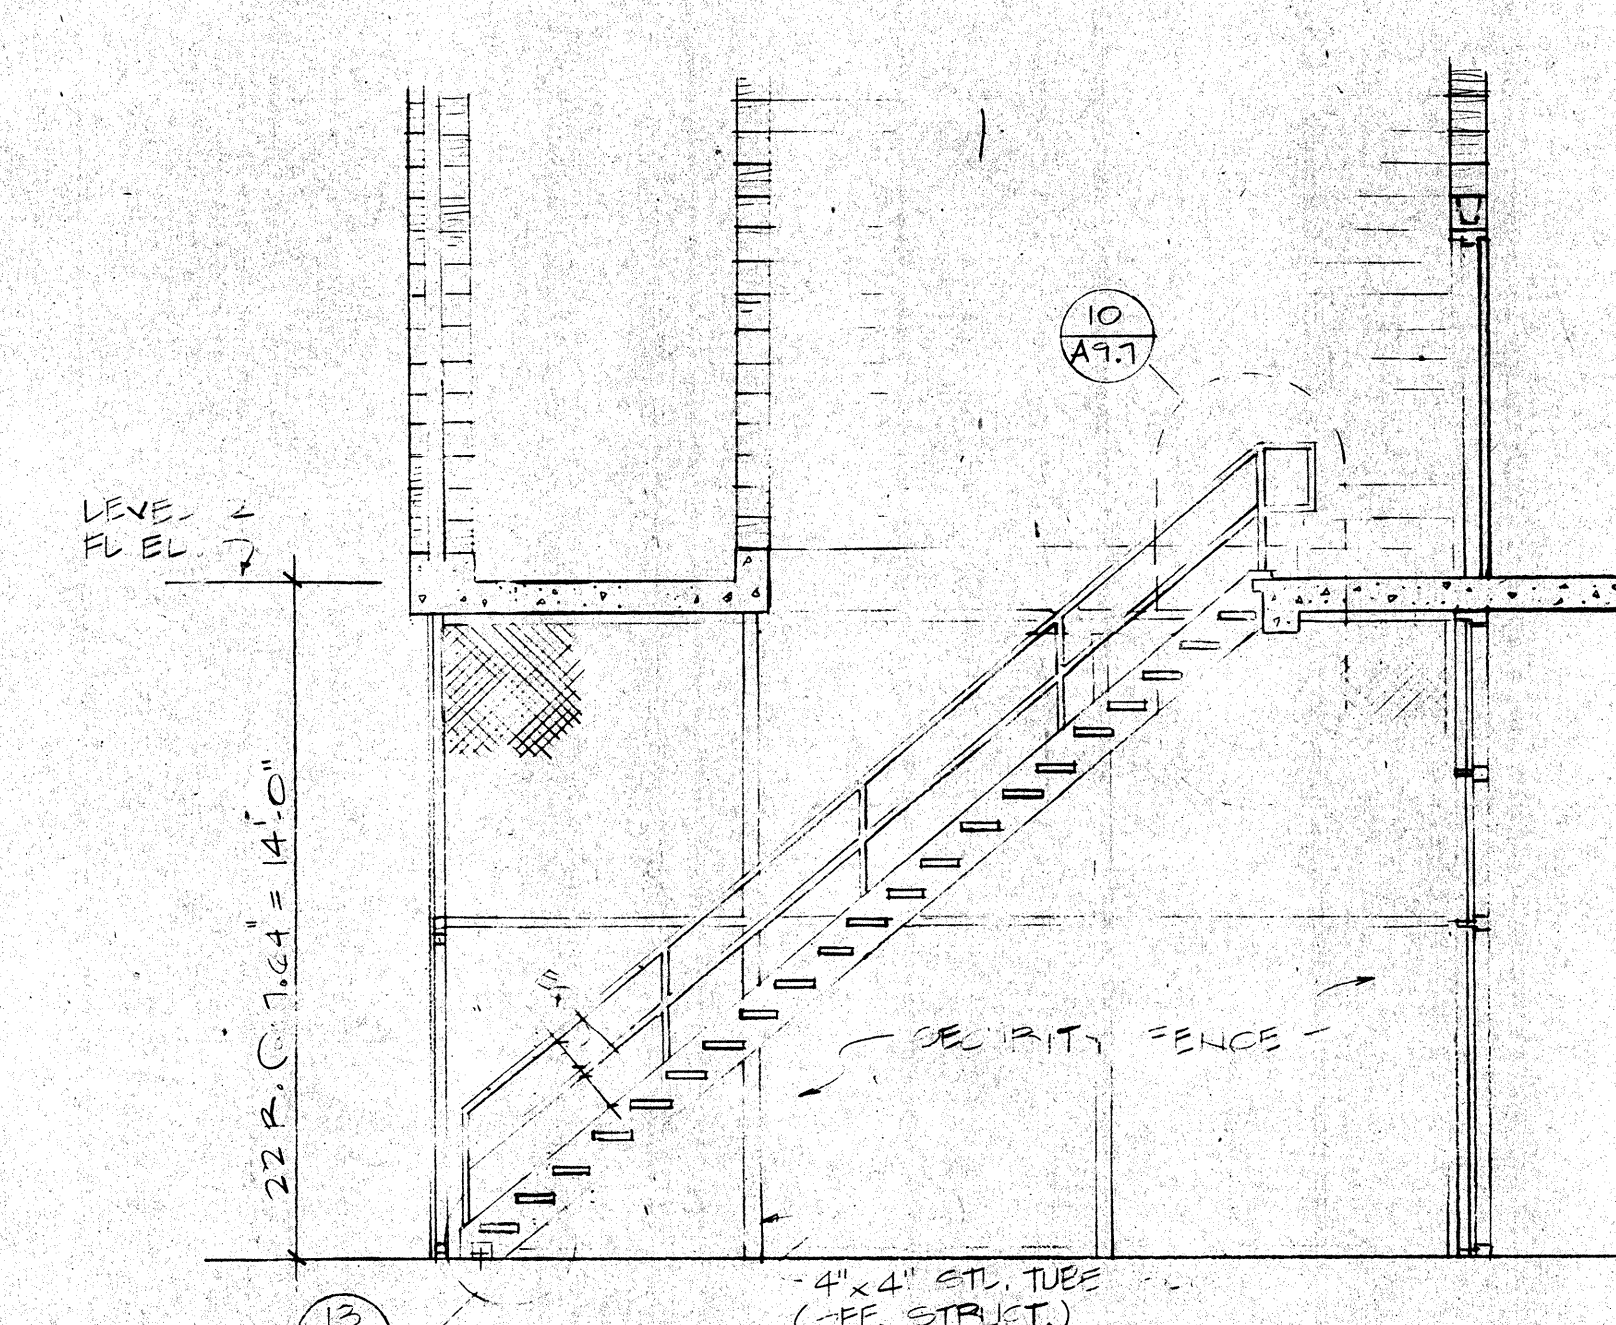


7 SECTION THRU STAIR

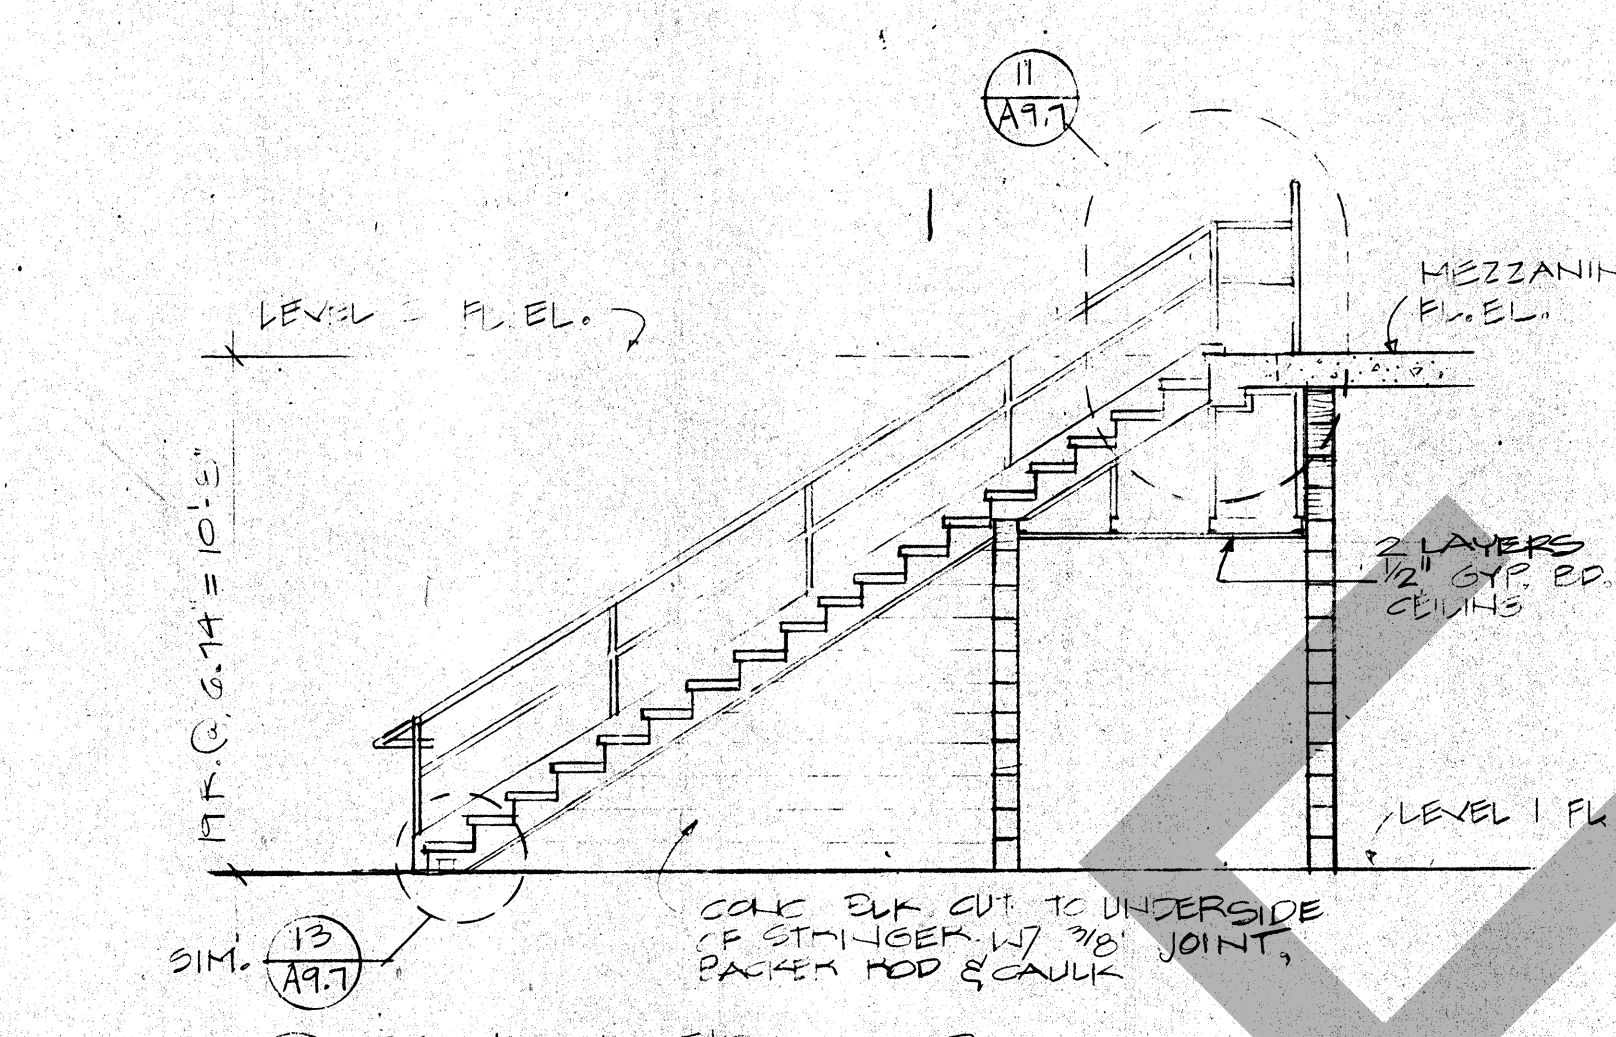


8 SECTION THRU STAIR

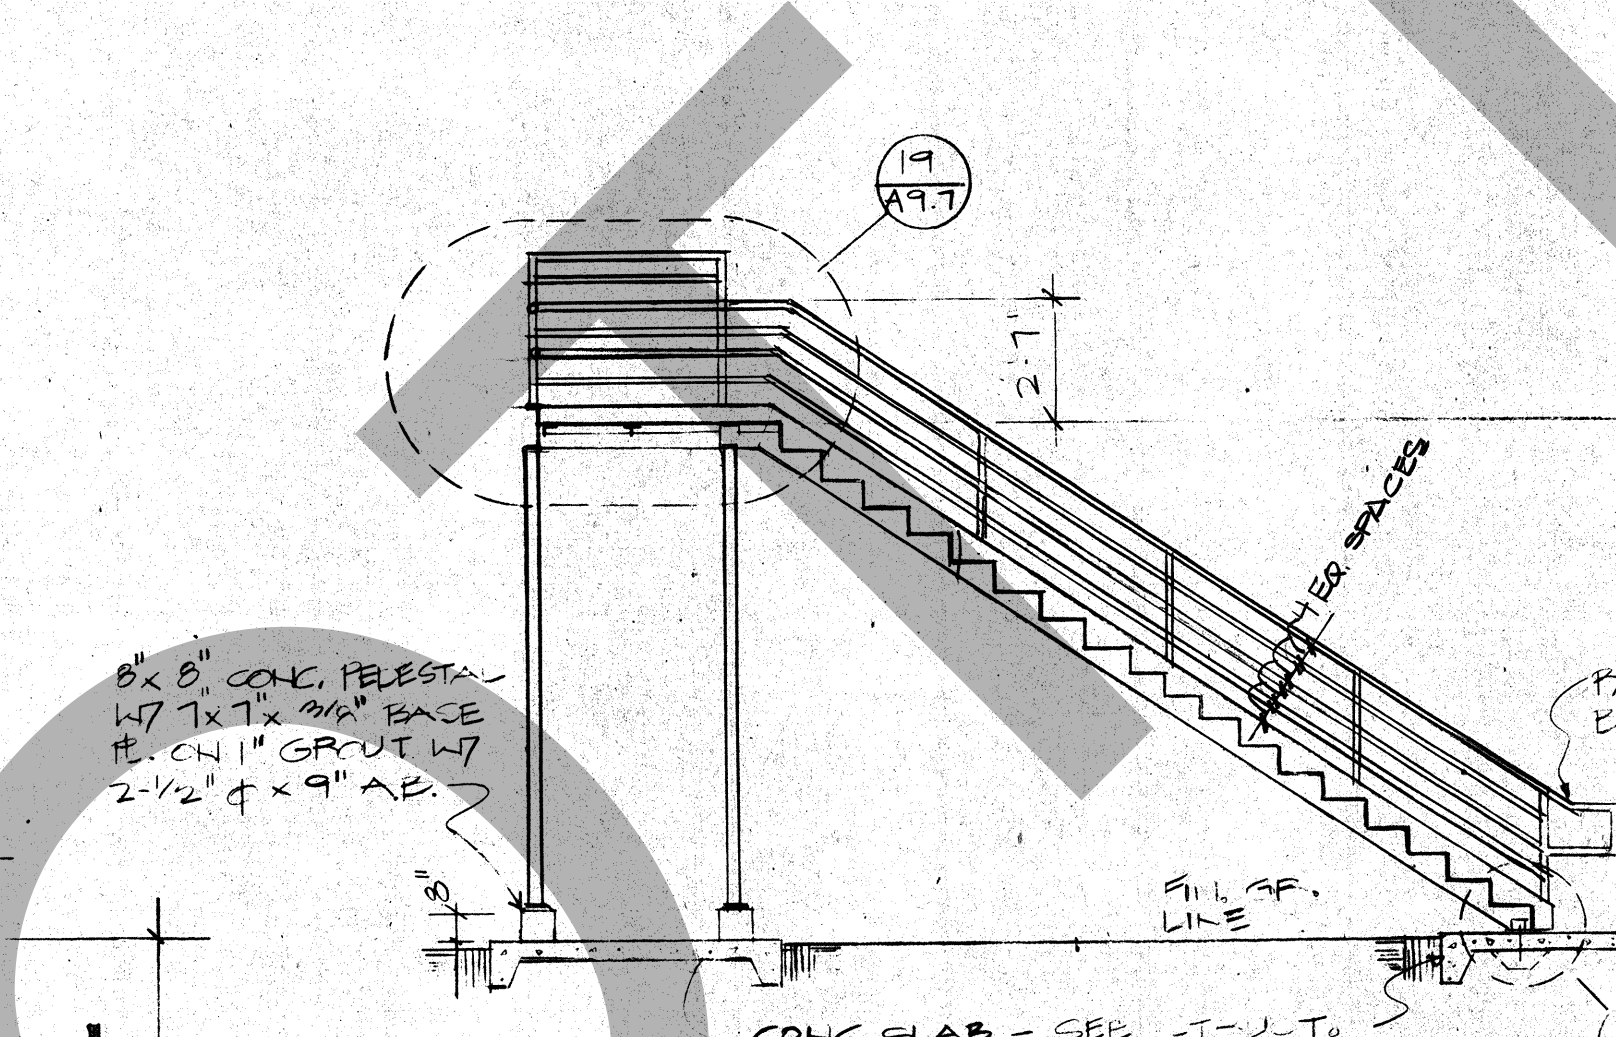


9 SECTION THRU STAIR

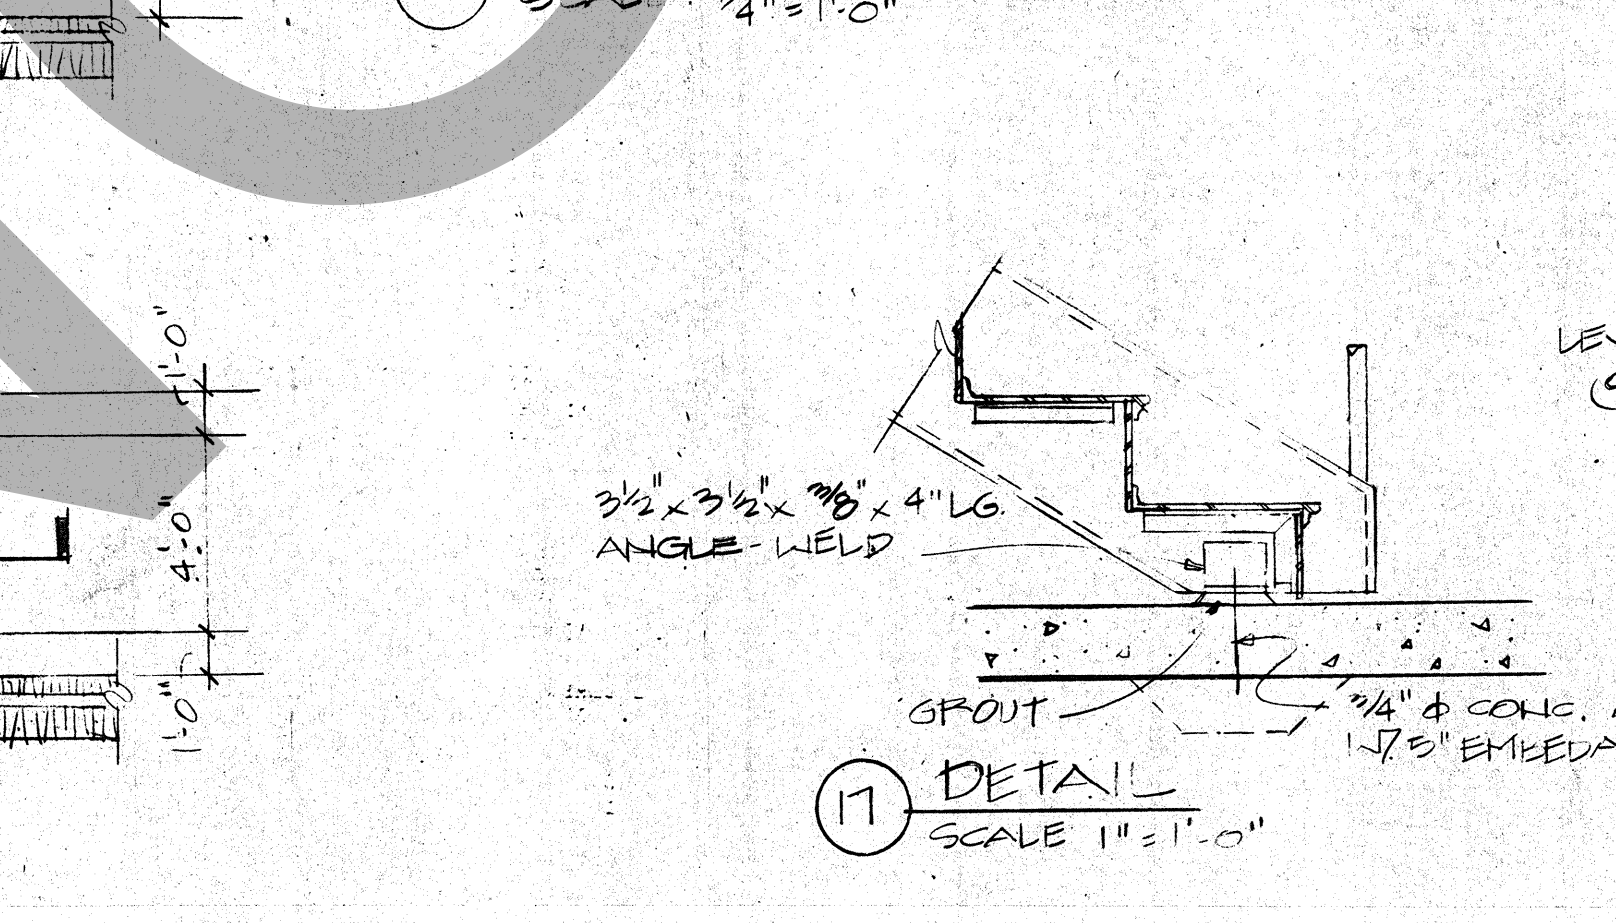


10 DETAIL

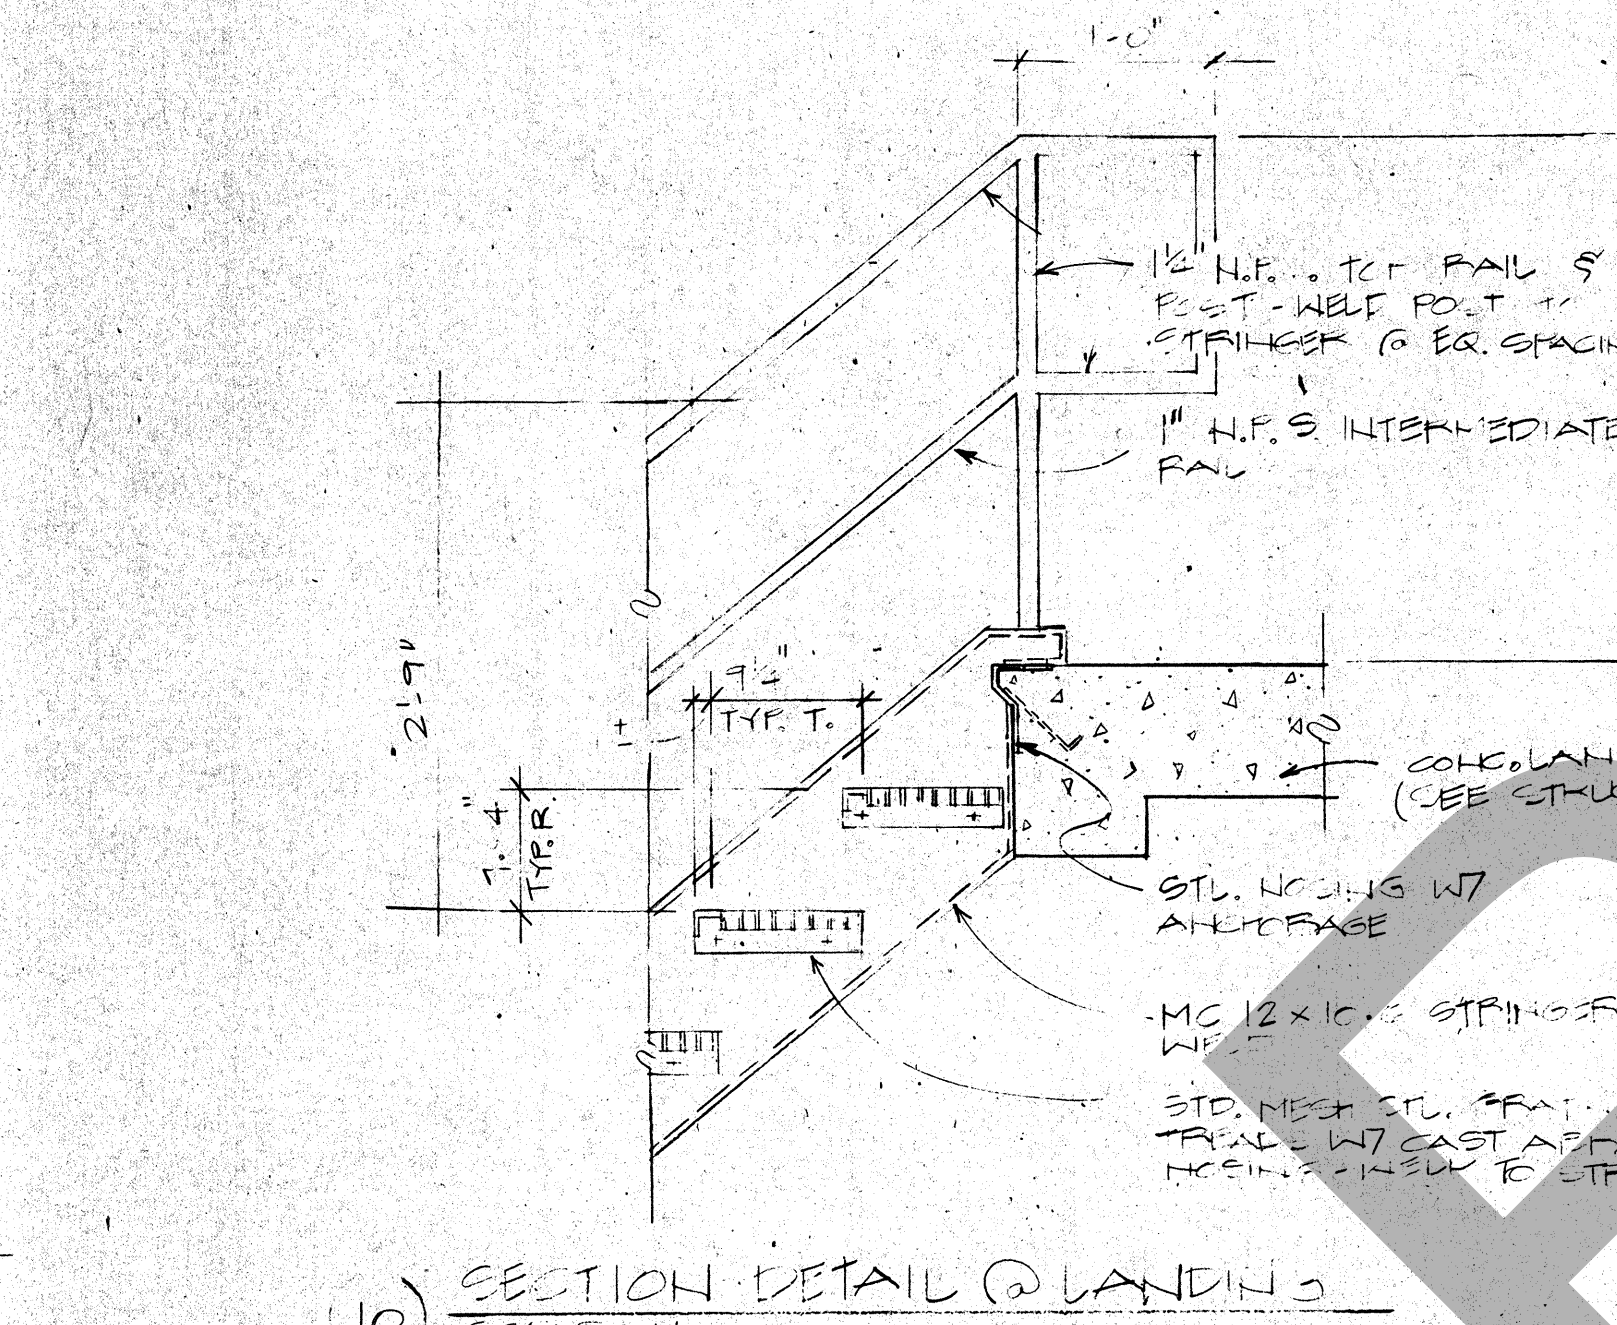


11 SECTION DETAIL @ LANDING

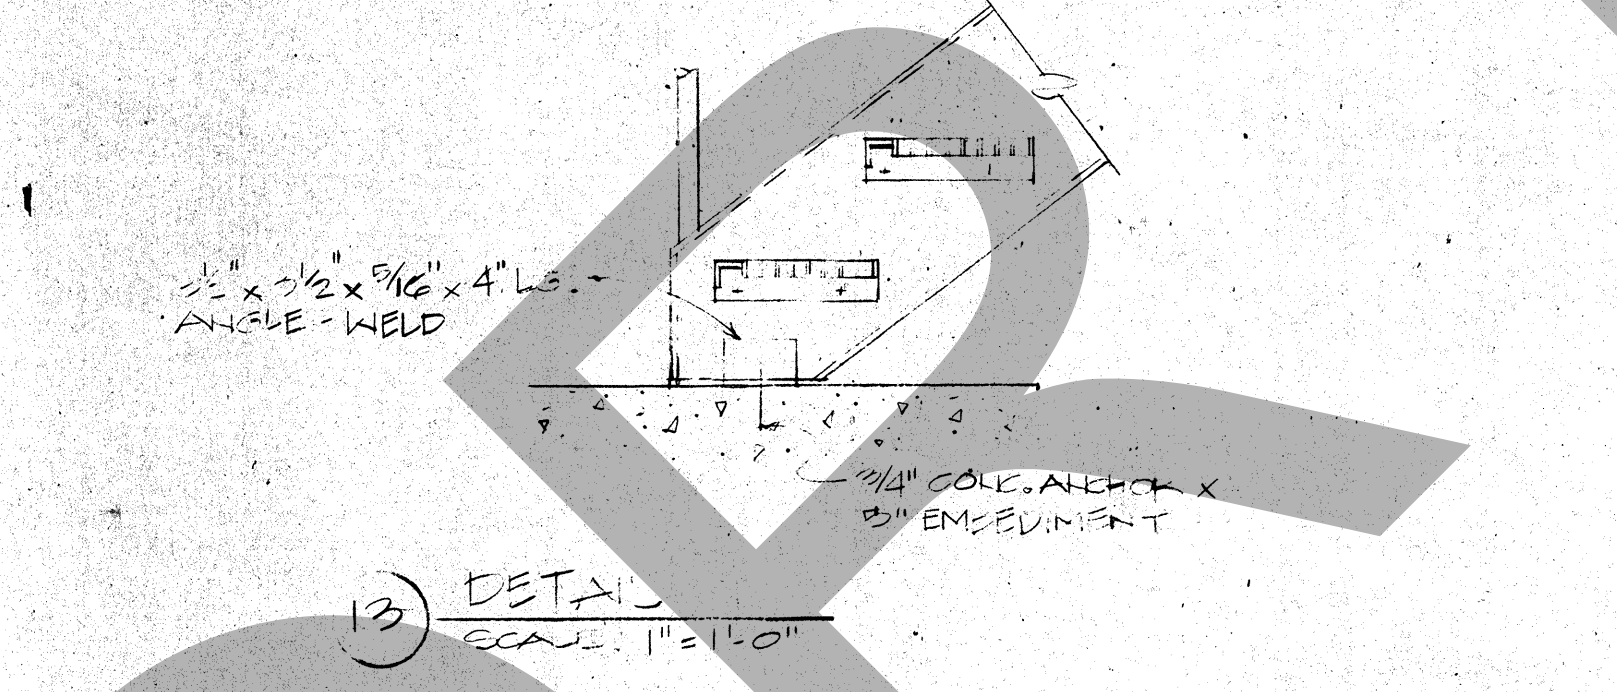


12 DETAIL

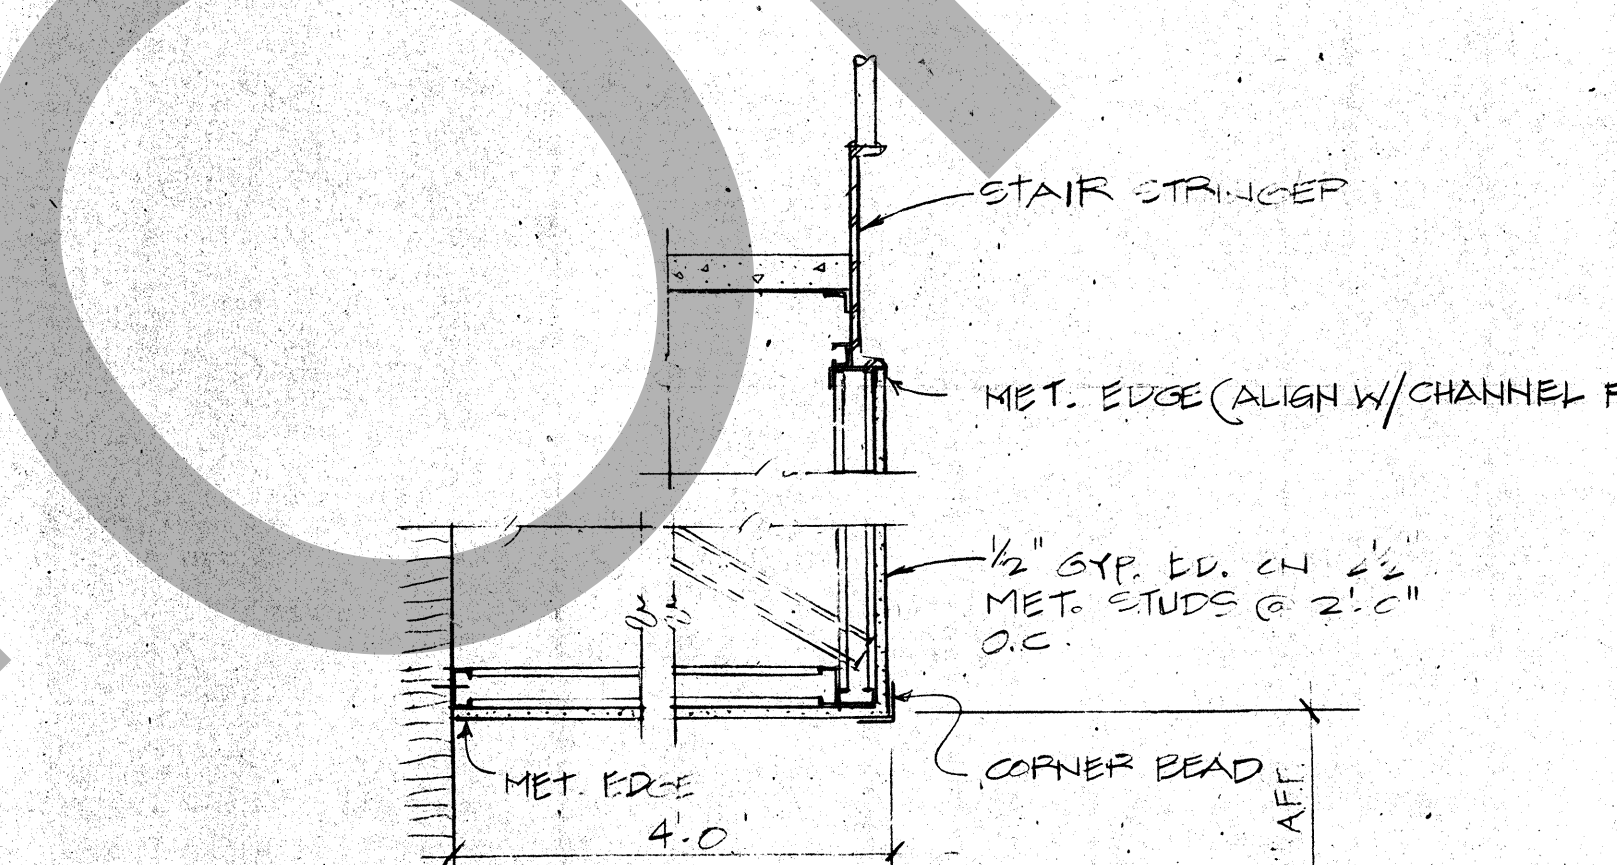


13 SECTION

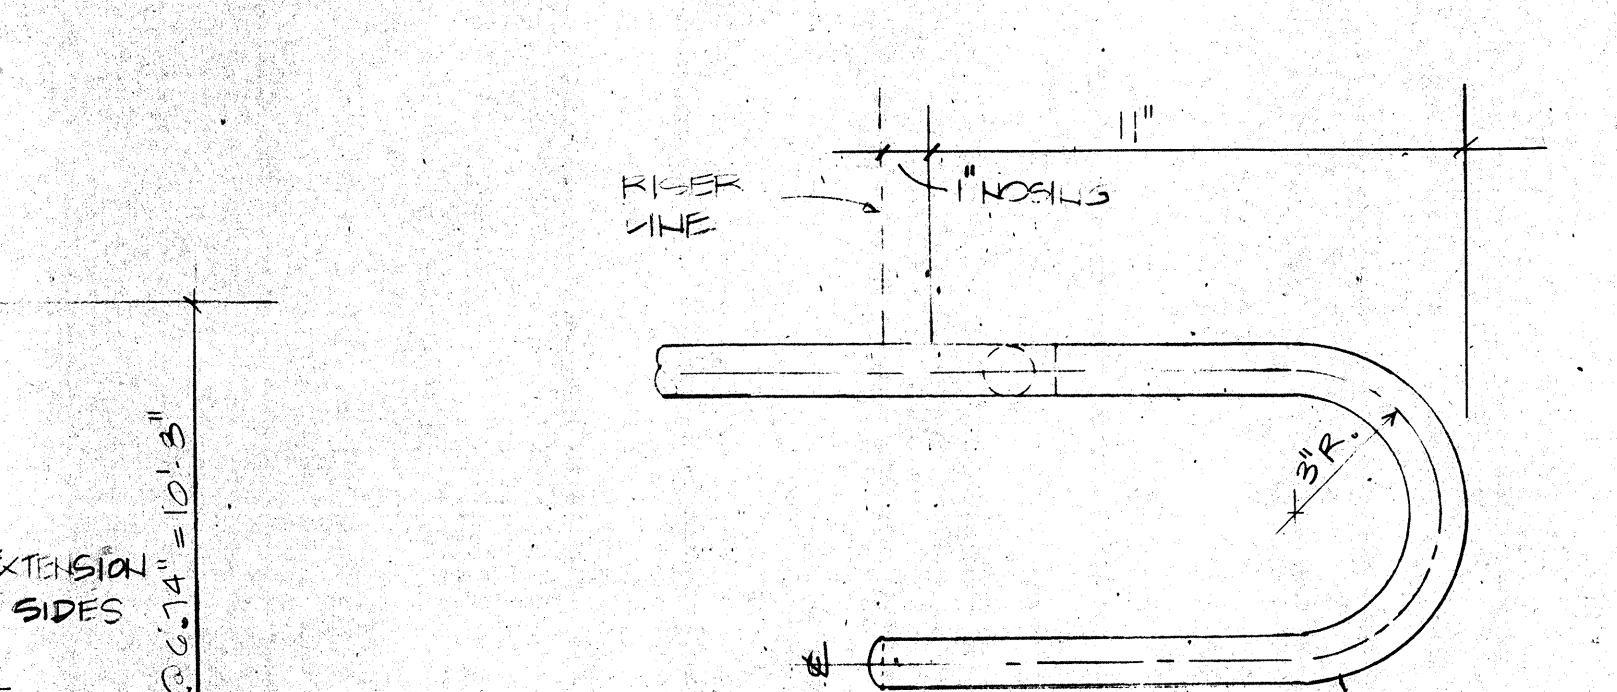


14 PLAN DETAIL - HANDRAIL

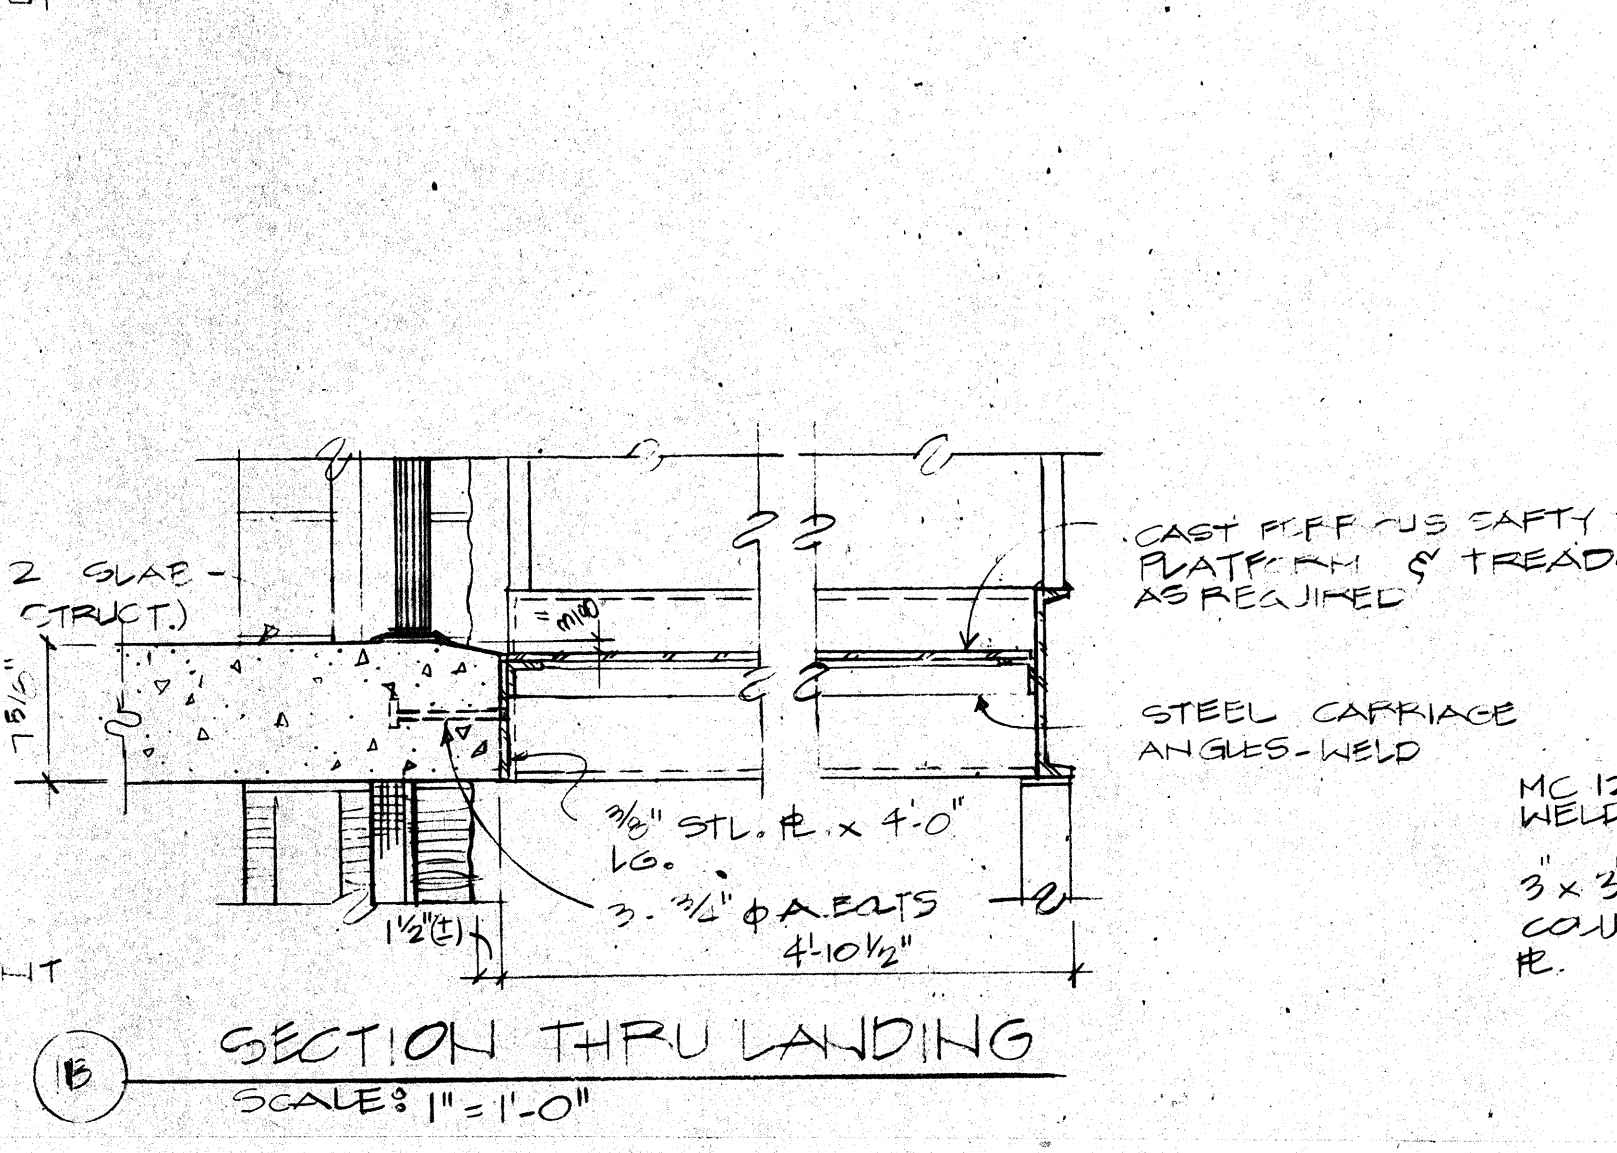


15 SECTION THRU LANDING

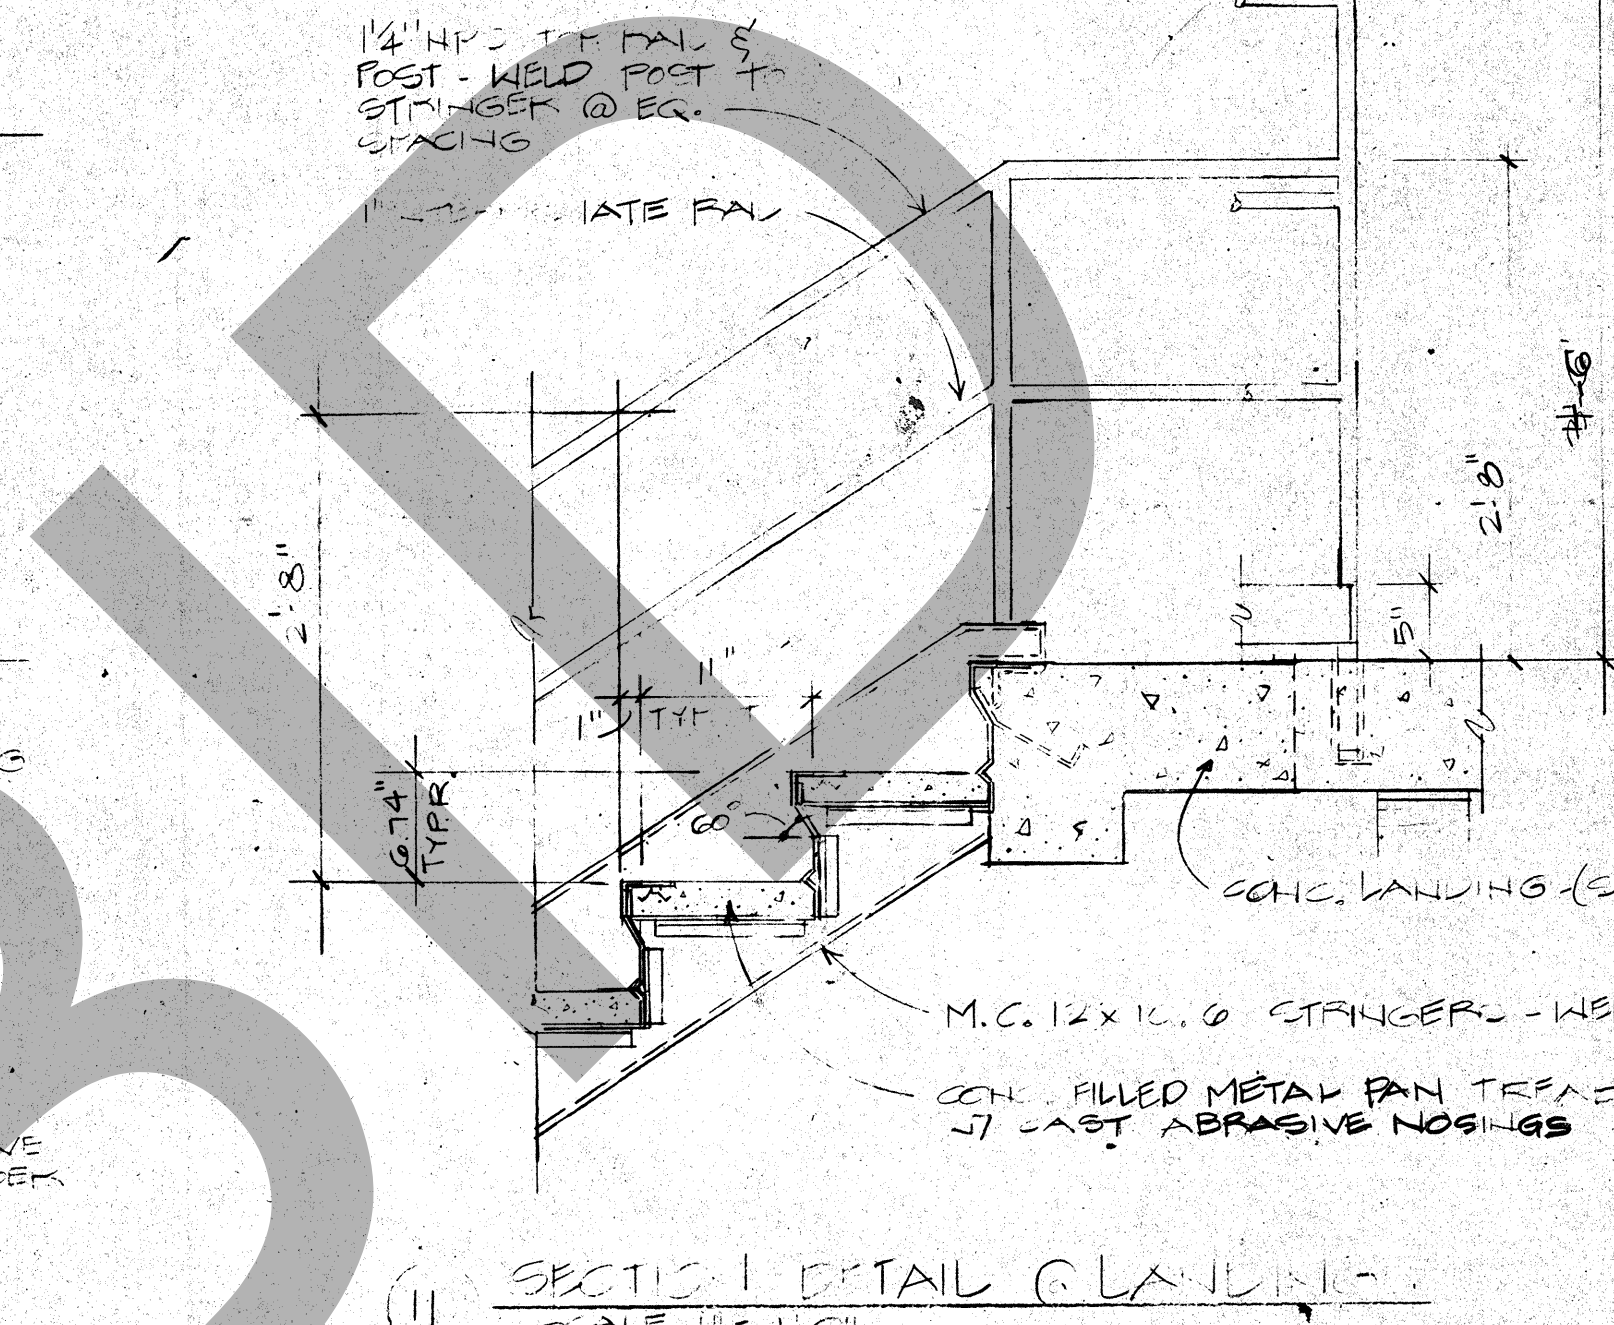


16 SECTION DETAIL @ LANDING

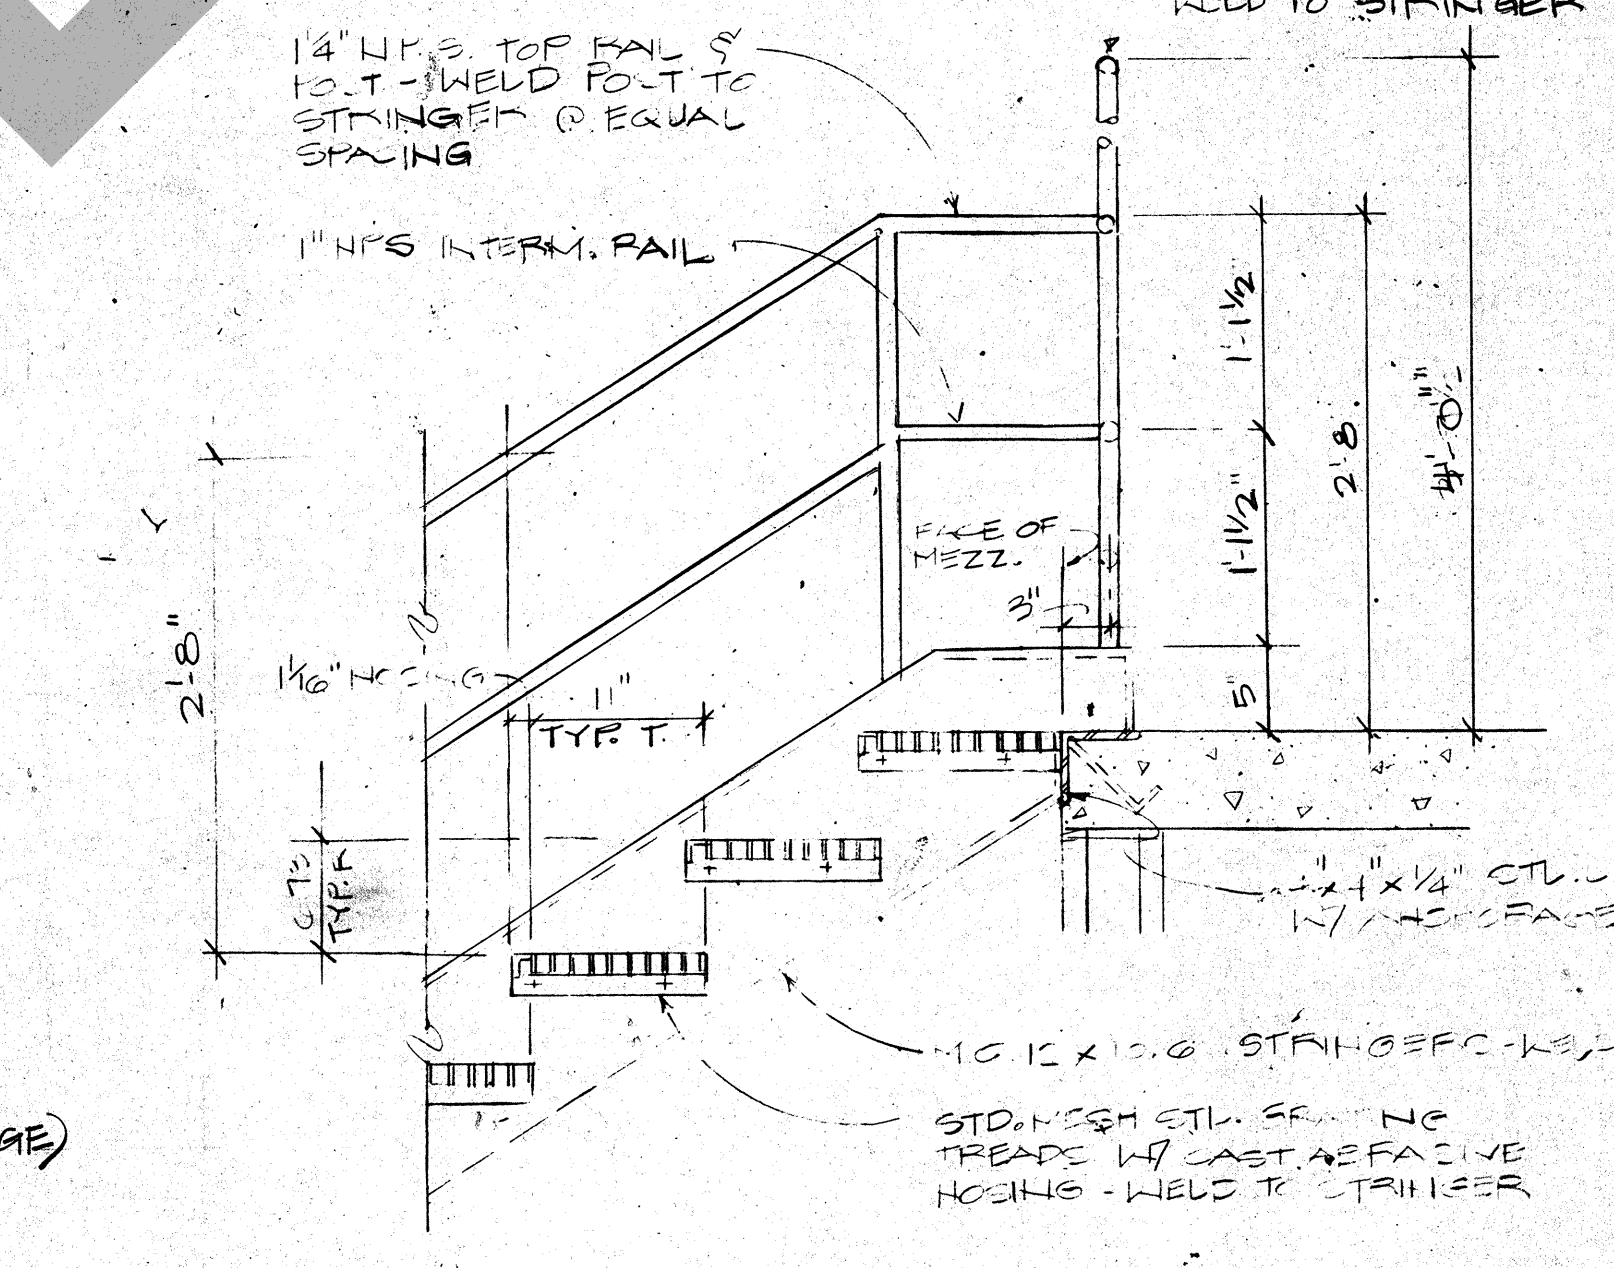

17 SECTION DETAIL @ LANDING

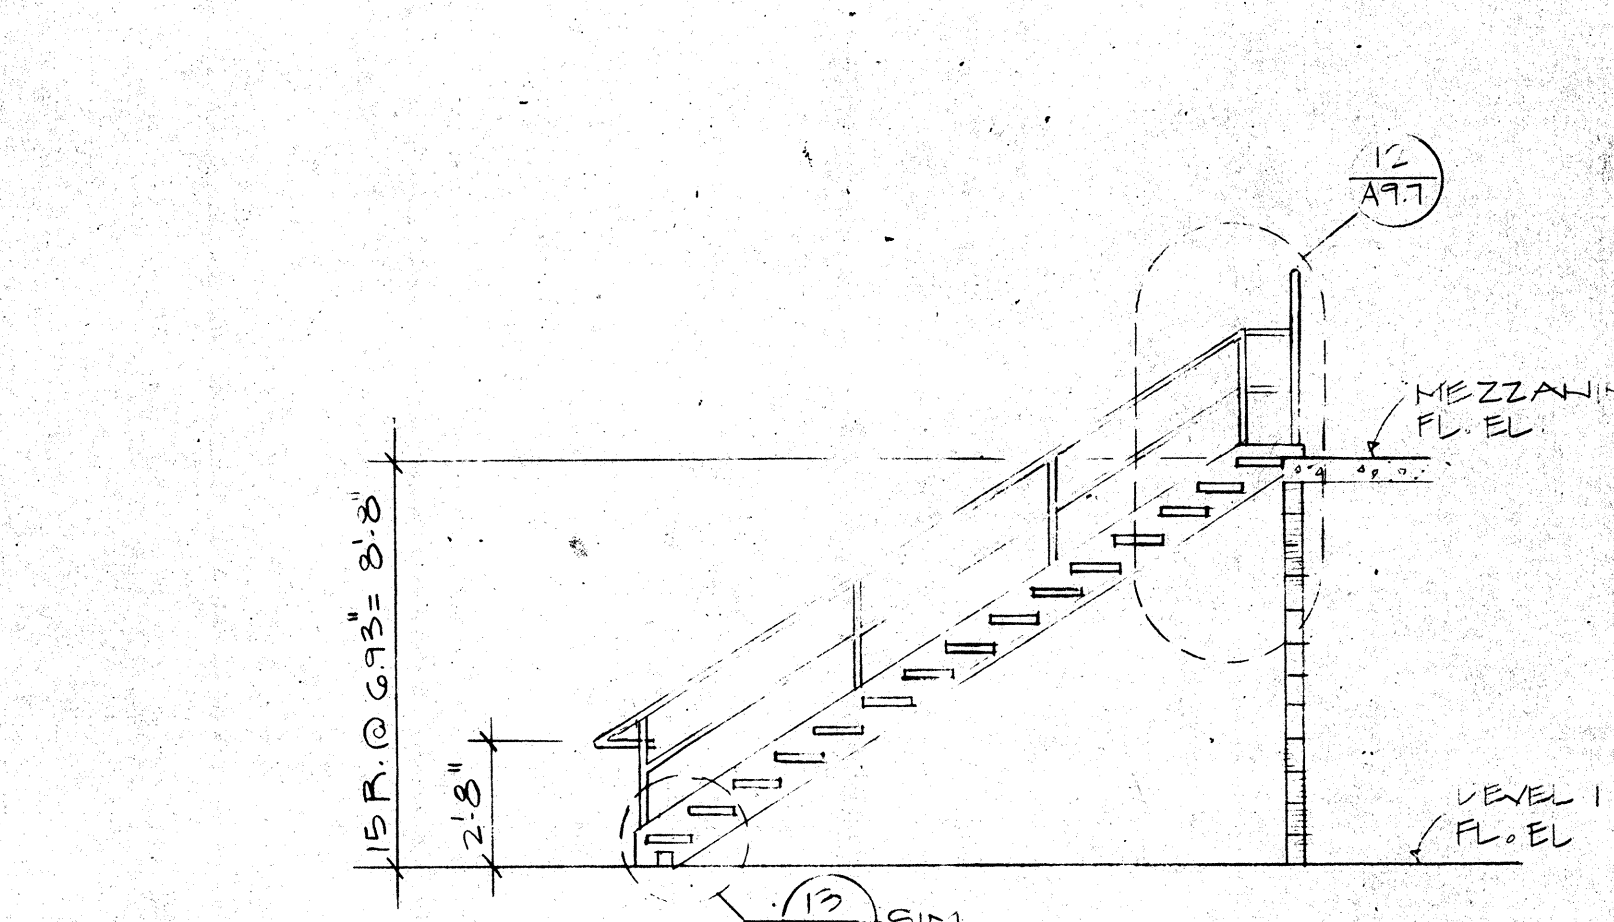

18 SECTION THRU STAIR NO.

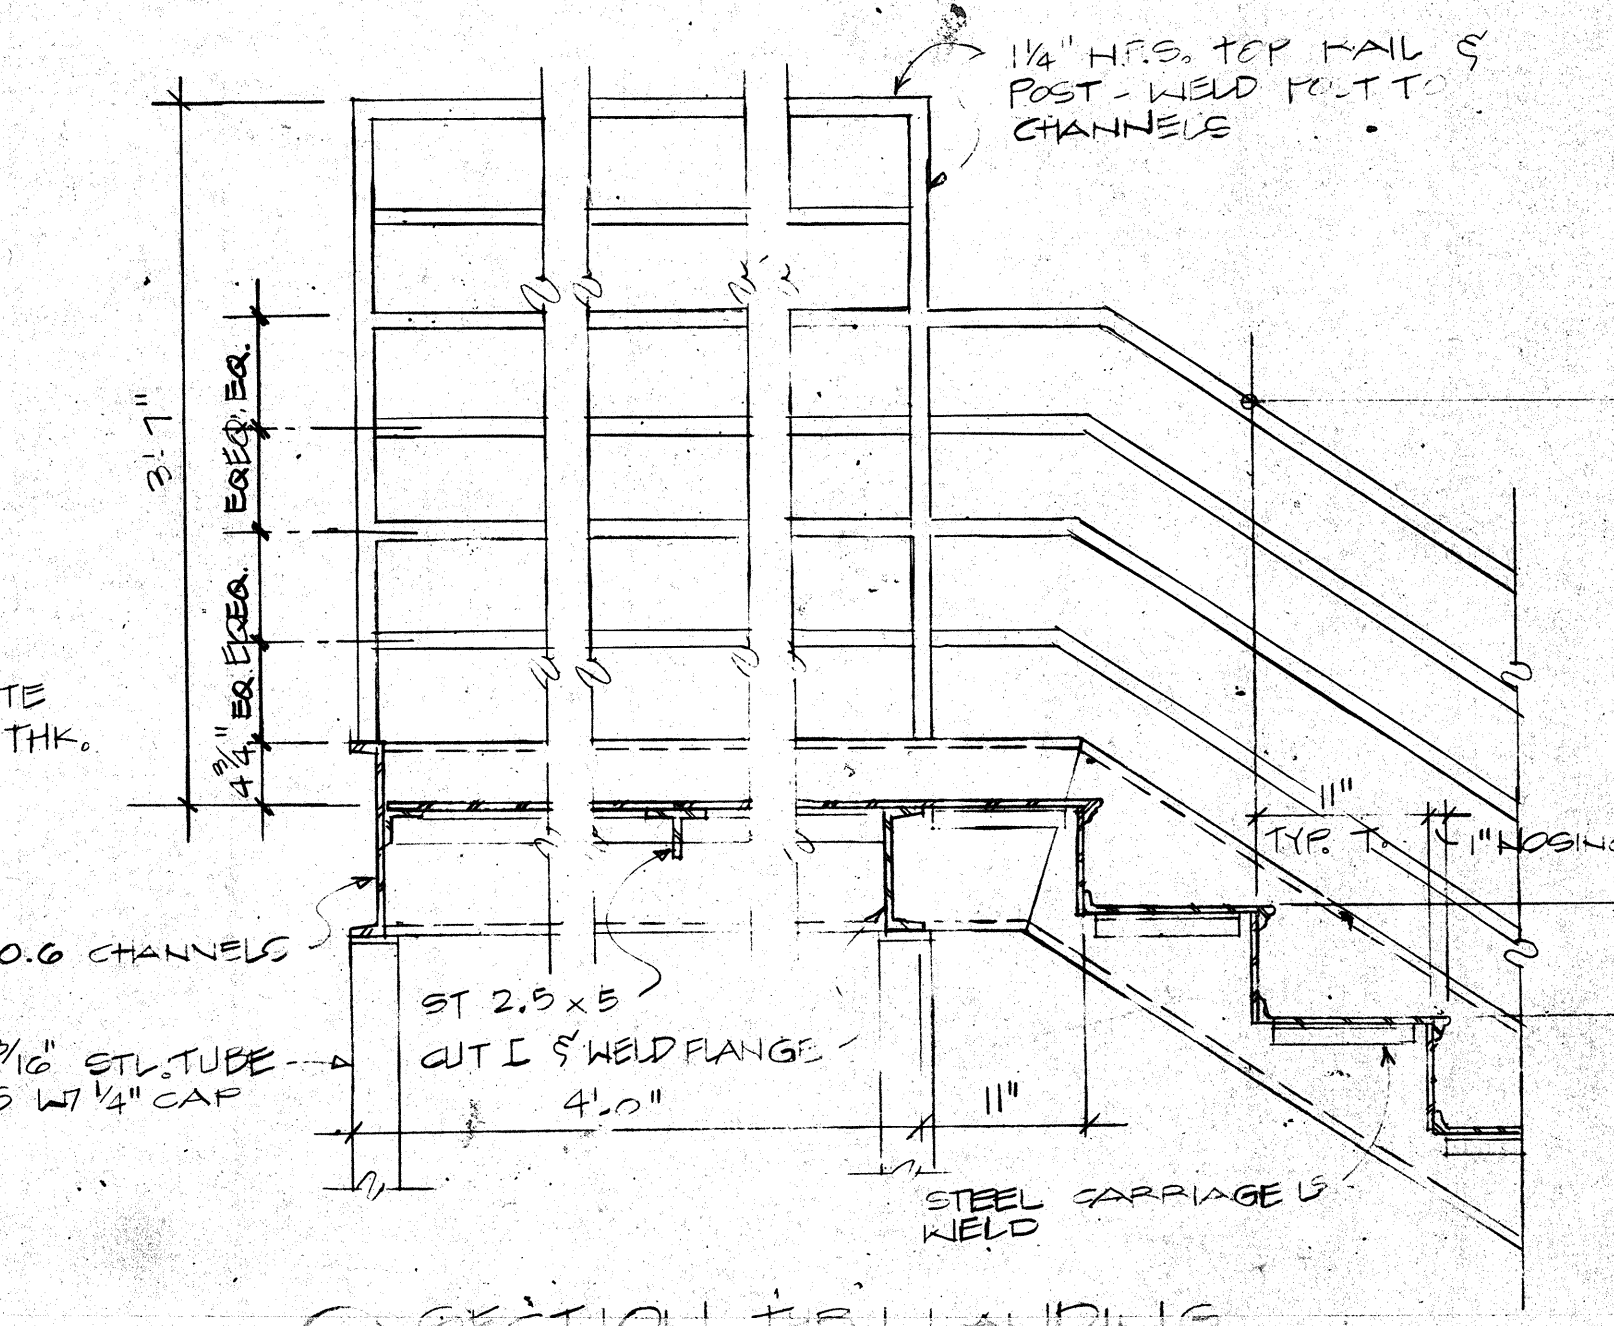

19 SECTION THRU LANDING

ROSSER FABRAP INTERNATIONAL
 Revisions
 No. Date Description
 1 2/17/88 ADDENDUM POSTED DURING FOR CONSTRUCTION

ROSSER FABRAP INTERNATIONAL, Inc.
 Corporate Office: 1000 Peachtree Street, N.E.
 Atlanta, Georgia 30309
 Phone: (404) 525-1100

ROSSER FABRAP INTERNATIONAL
 Criminal Justice Architecture, Technology, Planning, Interiors,
 Mechanical, Electrical, Plumbing, Security, & Civil Engineering


JUSTICE SYSTEMS INCORPORATED
 Criminal Justice Operations, Programming
JOHNSON & NIELSEN
 Structural Engineering

WEST - VALLEY - DETENTION - CENTER
 FOR THE COUNTY OF SAN BERNARDINO, CALIFORNIA

HARRY JAMES COUNTY ADMINISTRATION OFFICER
FLOYD TIDWELL, SHERIFF
 BOARD OF SUPERVISORS
 1000 West Valley Blvd., Suite 100
 West Valley, California 92686
 Phone: (714) 861-1100

STATE OF CALIFORNIA
 DAVID A. CLARK
 REGISTERED ARCHITECT
 No. 12178

HOUSING UNIT STAIR PLANS AND SECTIONS
 Job No. 880104
 Date 12-17-88

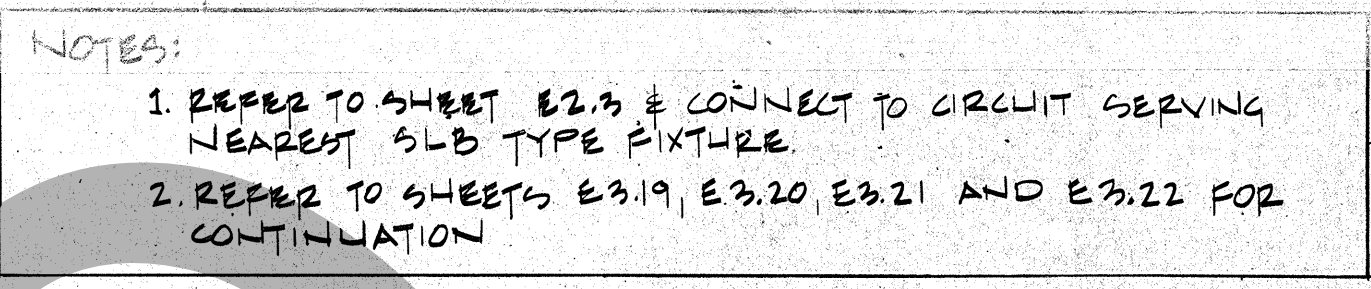

ROSSER FABRAP INTERNATIONAL
Criminal Justice Architecture, Technology, Planning, Interiors,
Mechanical, Electrical, Plumbing, Security, & Civil Engineering.

■

JUSTICE SYSTEMS INCORPORATED
Criminal Justice Operations, Programming

■


JOHNSON & NIELSEN
Structural Engineering

HARRY MAYS, COUNTY ADMINISTRATION OFFICER

FLOYD TIDWELL, SHERIFF

BOARD OF SUPERVISORS

John Joyce, Chairman, First District
Jon Mikels, Second District
Barbara Crain Riordan, Third District
Larry Walker, Fourth District
Robert Hammond, Fifth District

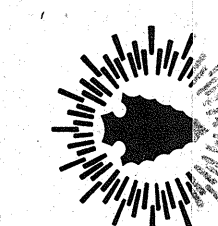

Seal of the State of California, Department of Corrections. The seal is circular with a rope-like border. Inside the border, the text "STATE OF CALIFORNIA" is at the top and "DEPARTMENT OF CORRECTIONS" is at the bottom. In the center, there is a star and the text "DAVID A. C. [illegible]". Below the star, the number "C-015872" is printed. A handwritten signature is scrawled across the center of the seal.

Job No. 38058.01 AS
Date 11/7/88

