

SAVELY ARCHITECTS
 ARCHITECTURE + PLANNING + DESIGN
 505 Technology Drive, Suite 175
 Irvine, CA 92618
 (949) 431-0071

PROJECT
ARROWHEAD REGIONAL MEDICAL CENTER
 480 N. BEYER AVE.
 COLTON, CALIFORNIA 92334



HYBRID OPERATING ROOMS

GOSS ENGINEERING
 205 E. Foothill St., Suite 301
 Colton, CA 92379
 P: 951.346.1977 | F: 951.346.1090
 www.gossengineering.com

Project Number: 120-12-17

NO.	DATE	REVISIONS
1	08-11-23	BACK CHECK #1
2	03-11-23	BACK CHECK #2

PROFESSIONAL SEALS

AGENCY APPROVAL

REVIEWED IN ACCORDANCE WITH THE REQUIREMENTS OF PIA, COM APPROVED WITH COMMENTS

Department of Health Care Services & Rehabilitation
 Office of Public Health Planning & Development
 Alison Cheng

DATE: MEDICAL GAS RISER DIAGRAM

DESIGNED BY: [Name]
 CHECKED BY: [Name]
 DATE: [Date]

P3.36

FOR REFERENCE ONLY

PROJECT NUMBER
 SHA # P336-09
 HCA # S22148-38-00

SHEET TITLE
MEDICAL GAS RISER DIAGRAM-PERI-OPERATIVE INSTALLATION
 SHEET NUMBER

P403F

NO.	DATE	REVISIONS
1	08-11-23	BACK CHECK #1
2	09-11-23	BACK CHECK #2

PROFESSIONAL SEALS




AGENCY APPROVAL



DRAWN BY: [Name] | CHECKED BY: [Name] | DATE: 02.20.2023

PROJECT NUMBER: [Number]
 HCA # : S22214535-00

SHEET TITLE: MEDICAL GAS RISER
 DIAGRAM-HYBRID/ROOM INSTALLATION
 SHEET NUMBER: [Number]

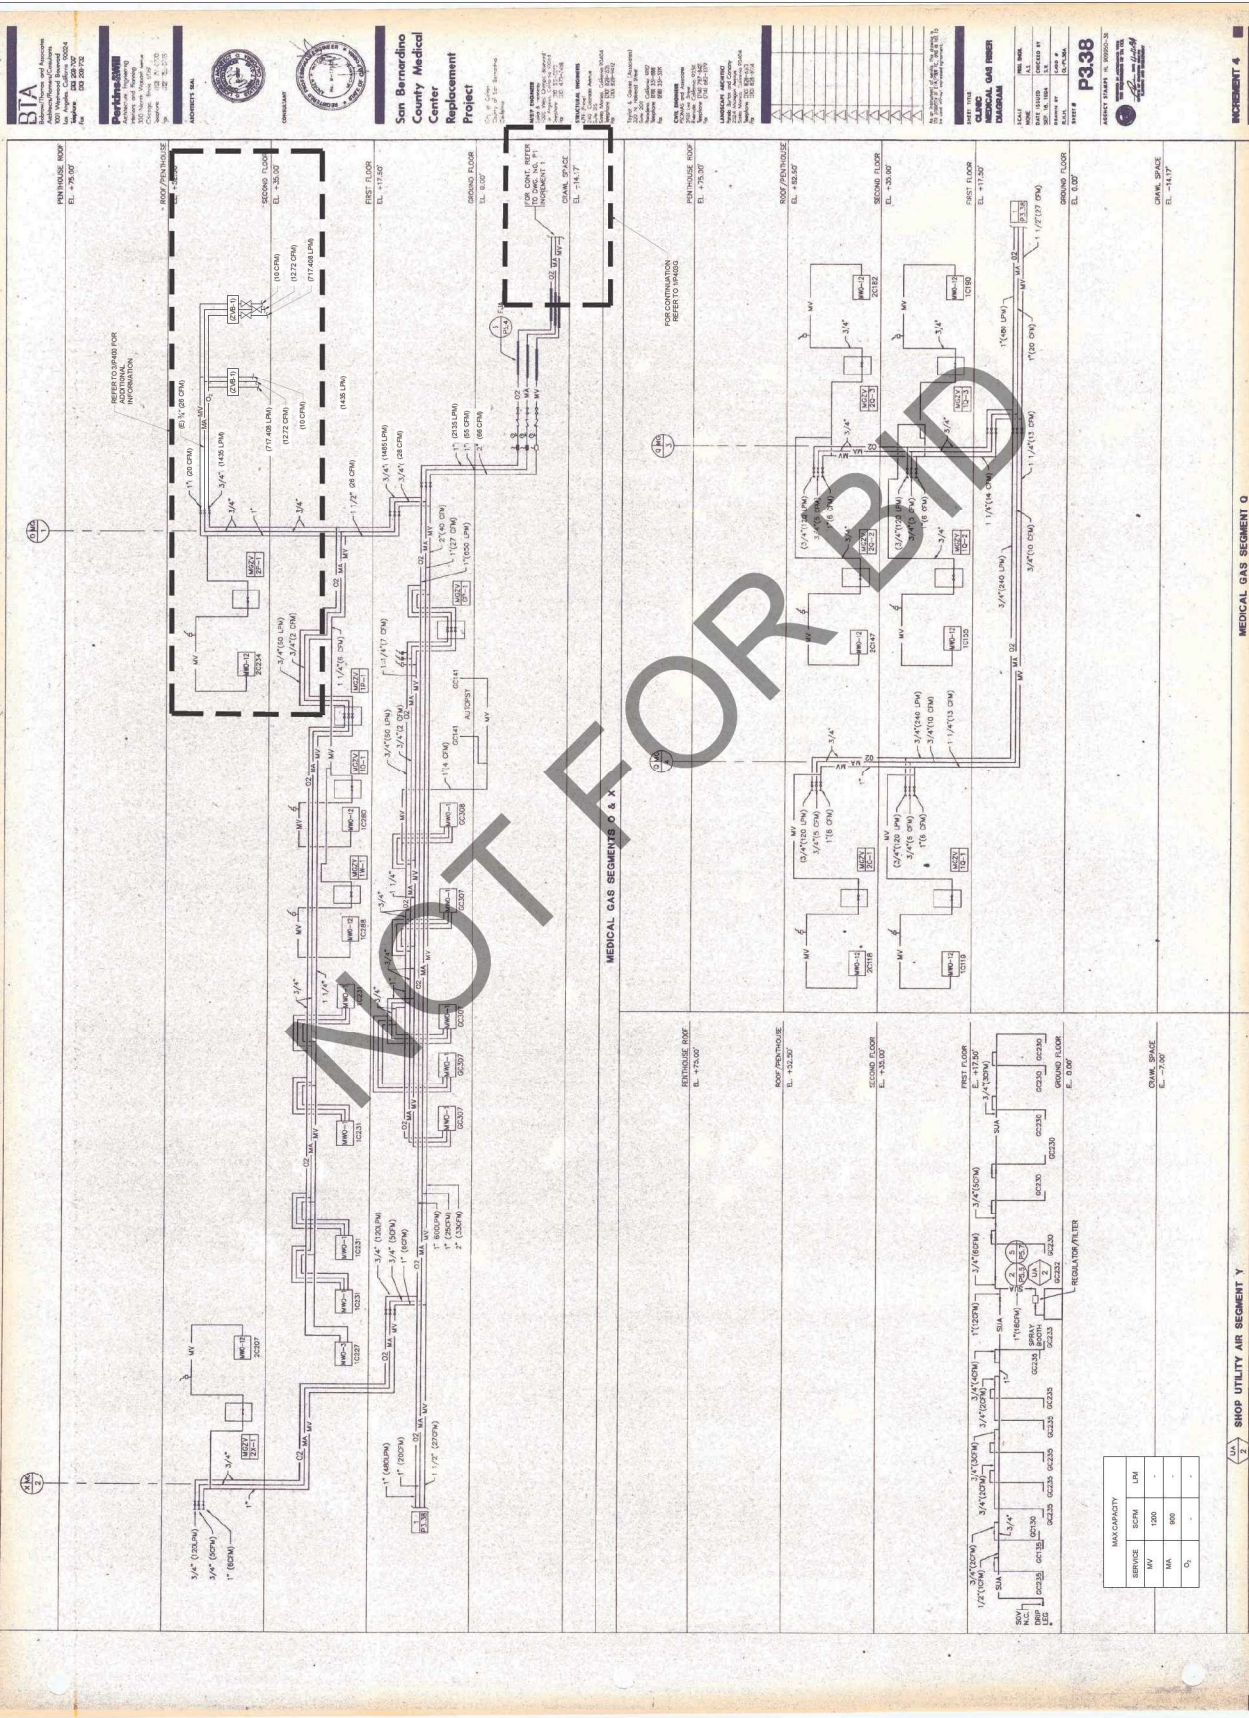

MEDICAL GAS SEGMENT O

SHOP UTILITY AIR SEGMENT Y

FOR REFERENCE ONLY

MEDICAL GAS RISER DIAGRAM-HYBRID/ROOM INSTALLATION

SCALE: NONE

1

MAX CAPACITY	
SERVICE	SCFM
O ₂	1000
N ₂ O	800
Air	-


NO.	DATE	REVISIONS
1	08-11-23	BACK CHECK #1
2	09-11-23	BACK CHECK #2



DRAWN BY: [Signature] | CHECKED BY: DATE: 12/20/2023

PROJECT NUMBER: 120-12-17
 HCAI #: S22714338-00


SHEET TITLE: MEDICAL GAS RISER DIAGRAM-SITE
 PLAN INSTALLATION
 SHEET NUMBER

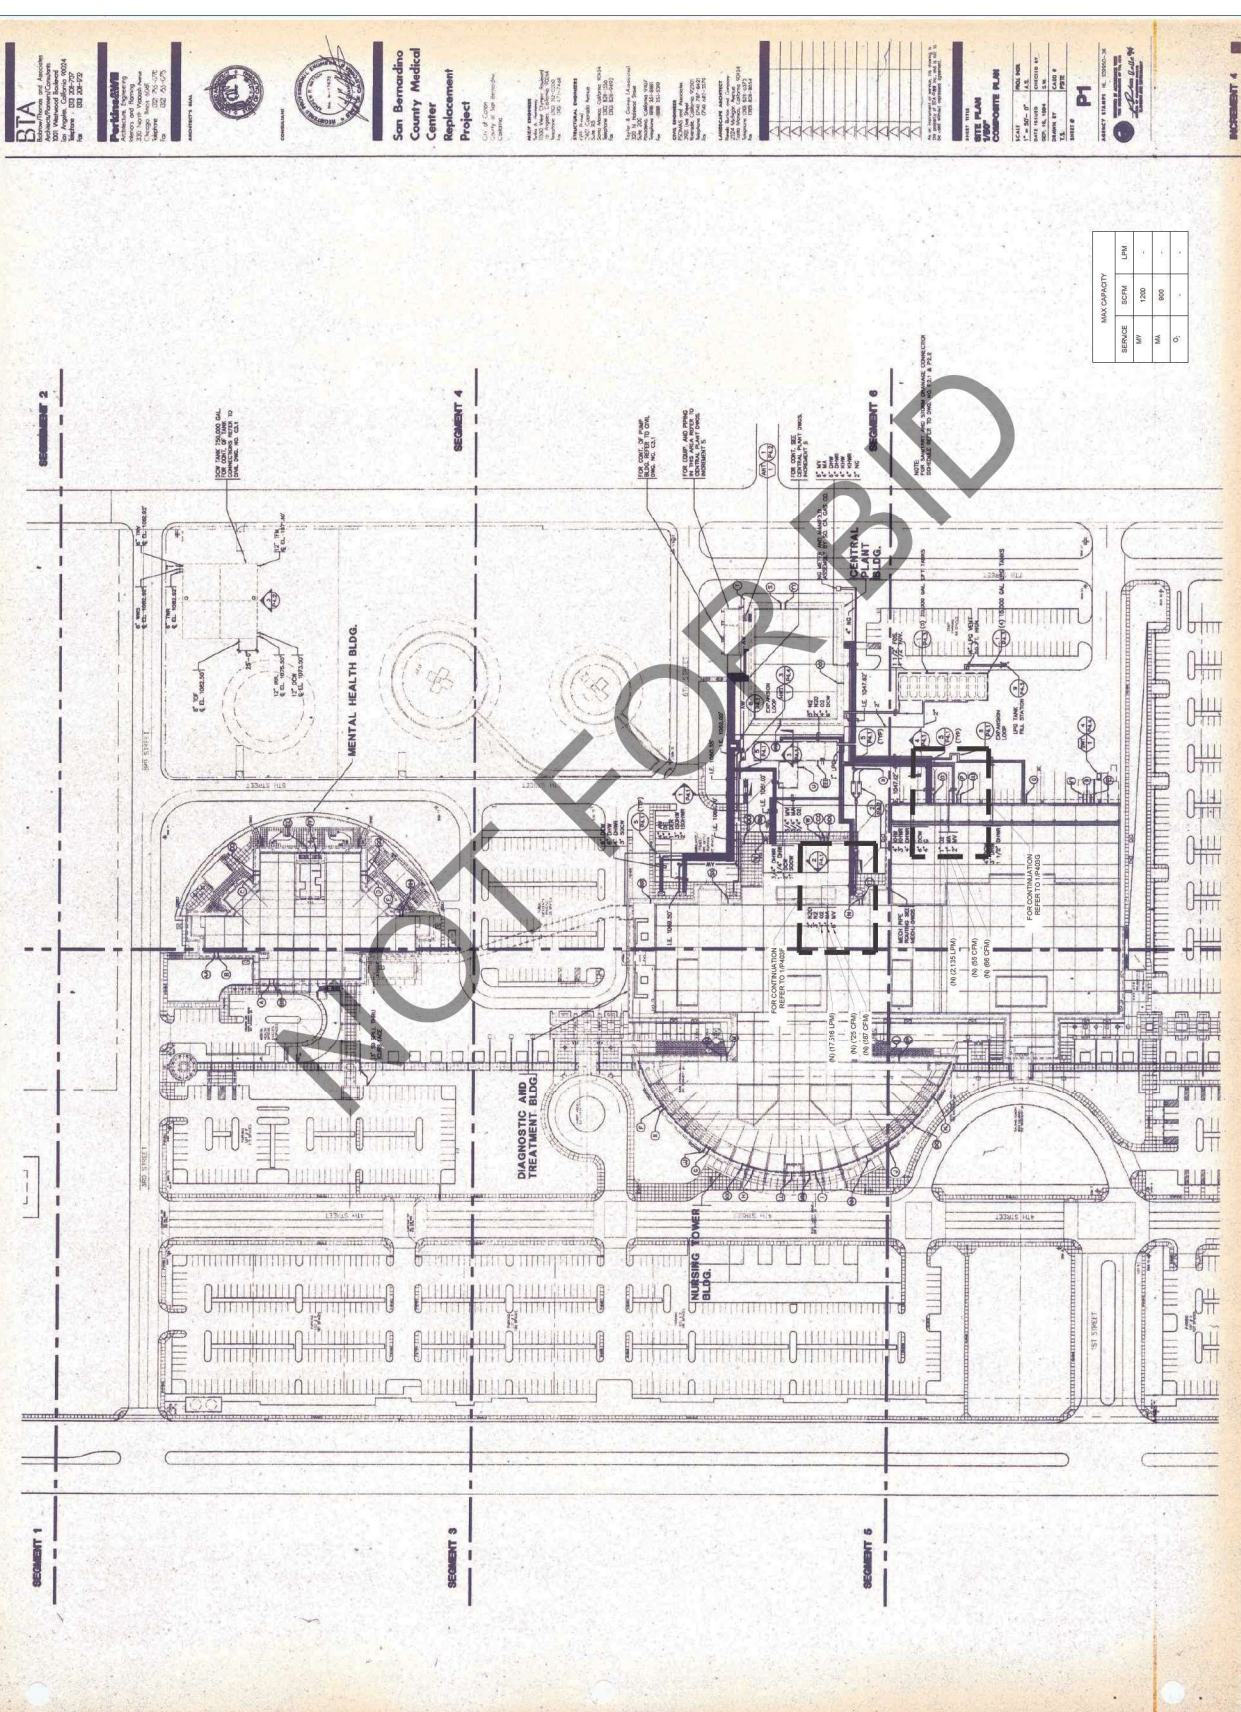

MAX CAPACITY	SCFM	LPM
BT	1500	-
MA	800	-
G	-	-

FOR REFERENCE ONLY

NO.	DATE	REVISIONS
1	08-11-23	BACK CHECK #1
2	09-11-23	BACK CHECK #2


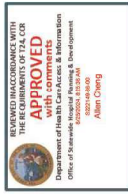


DRAWN BY: [Redacted] | CHECKED BY: [Redacted] | DATE: 12.20.2023

PROJECT NUMBER: [Redacted]
 SHEET NUMBER: [Redacted]
 HCA # : S222149336-00

SHEET TITLE: PLUMBING DETAILS

SHEET NUMBER

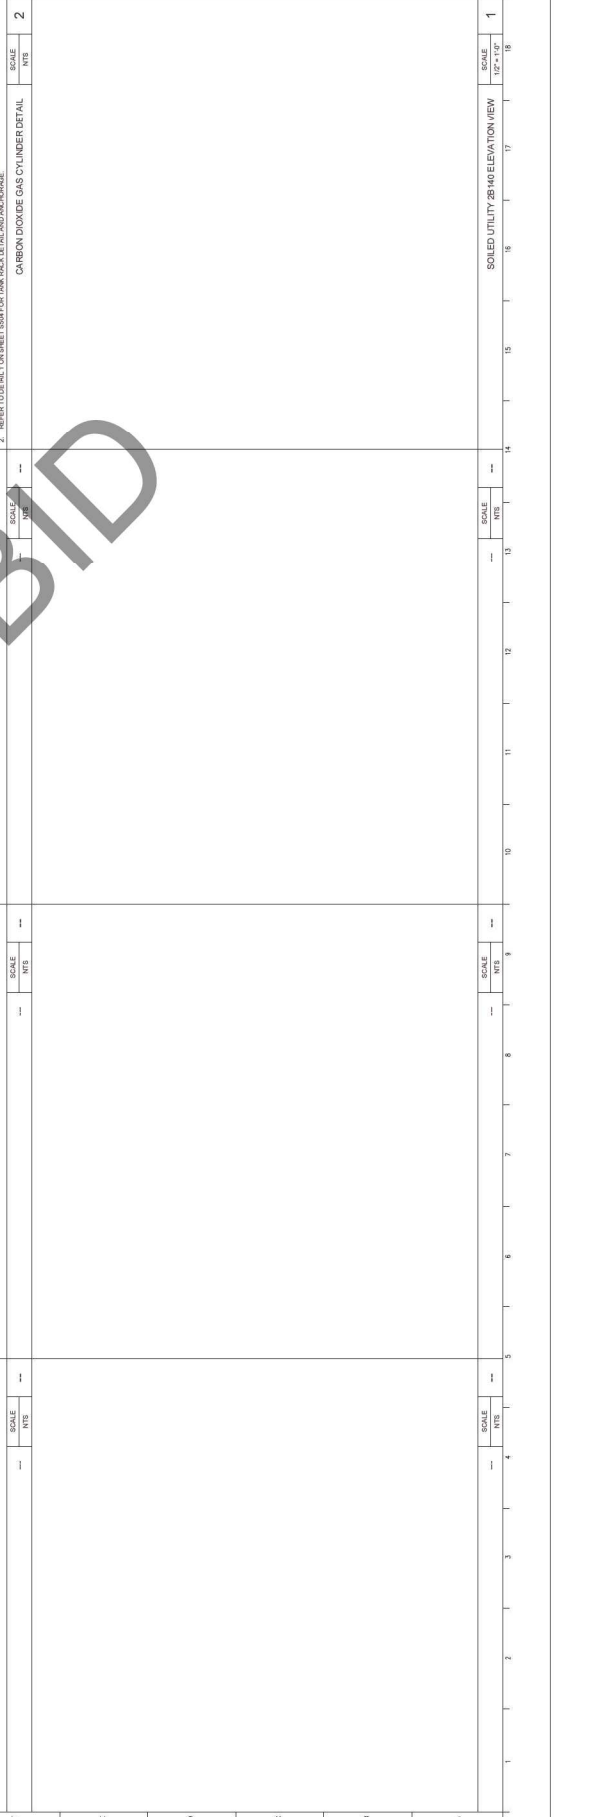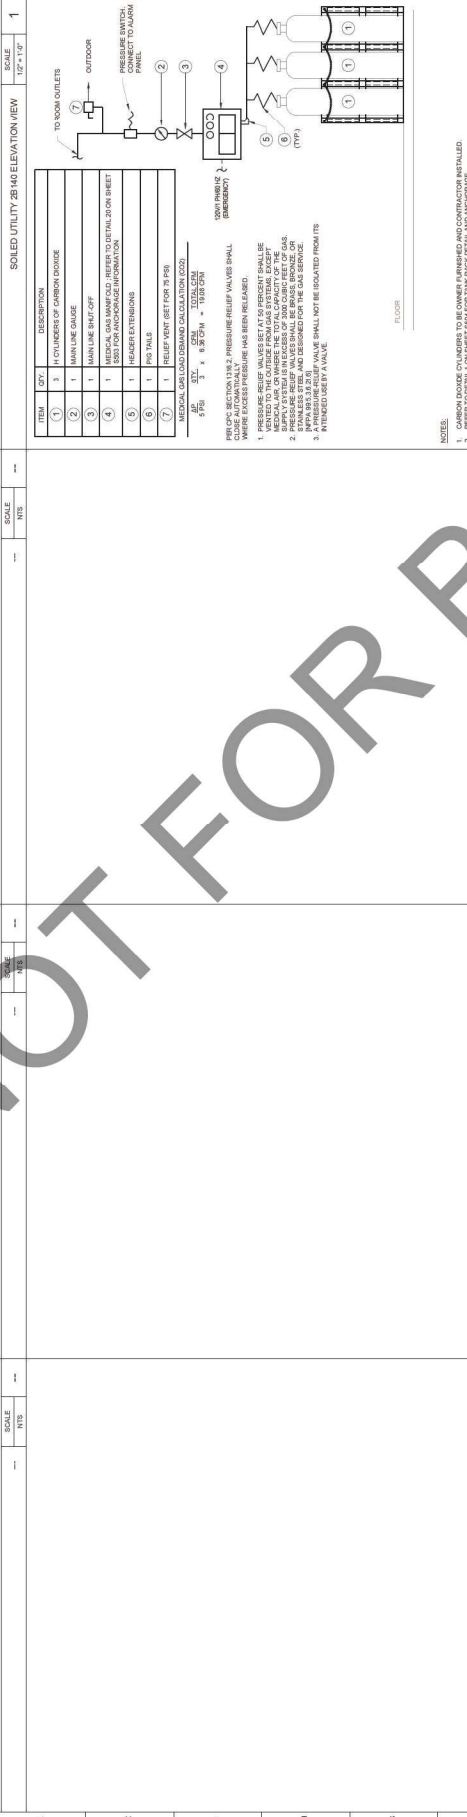

NOT FOR BID

