


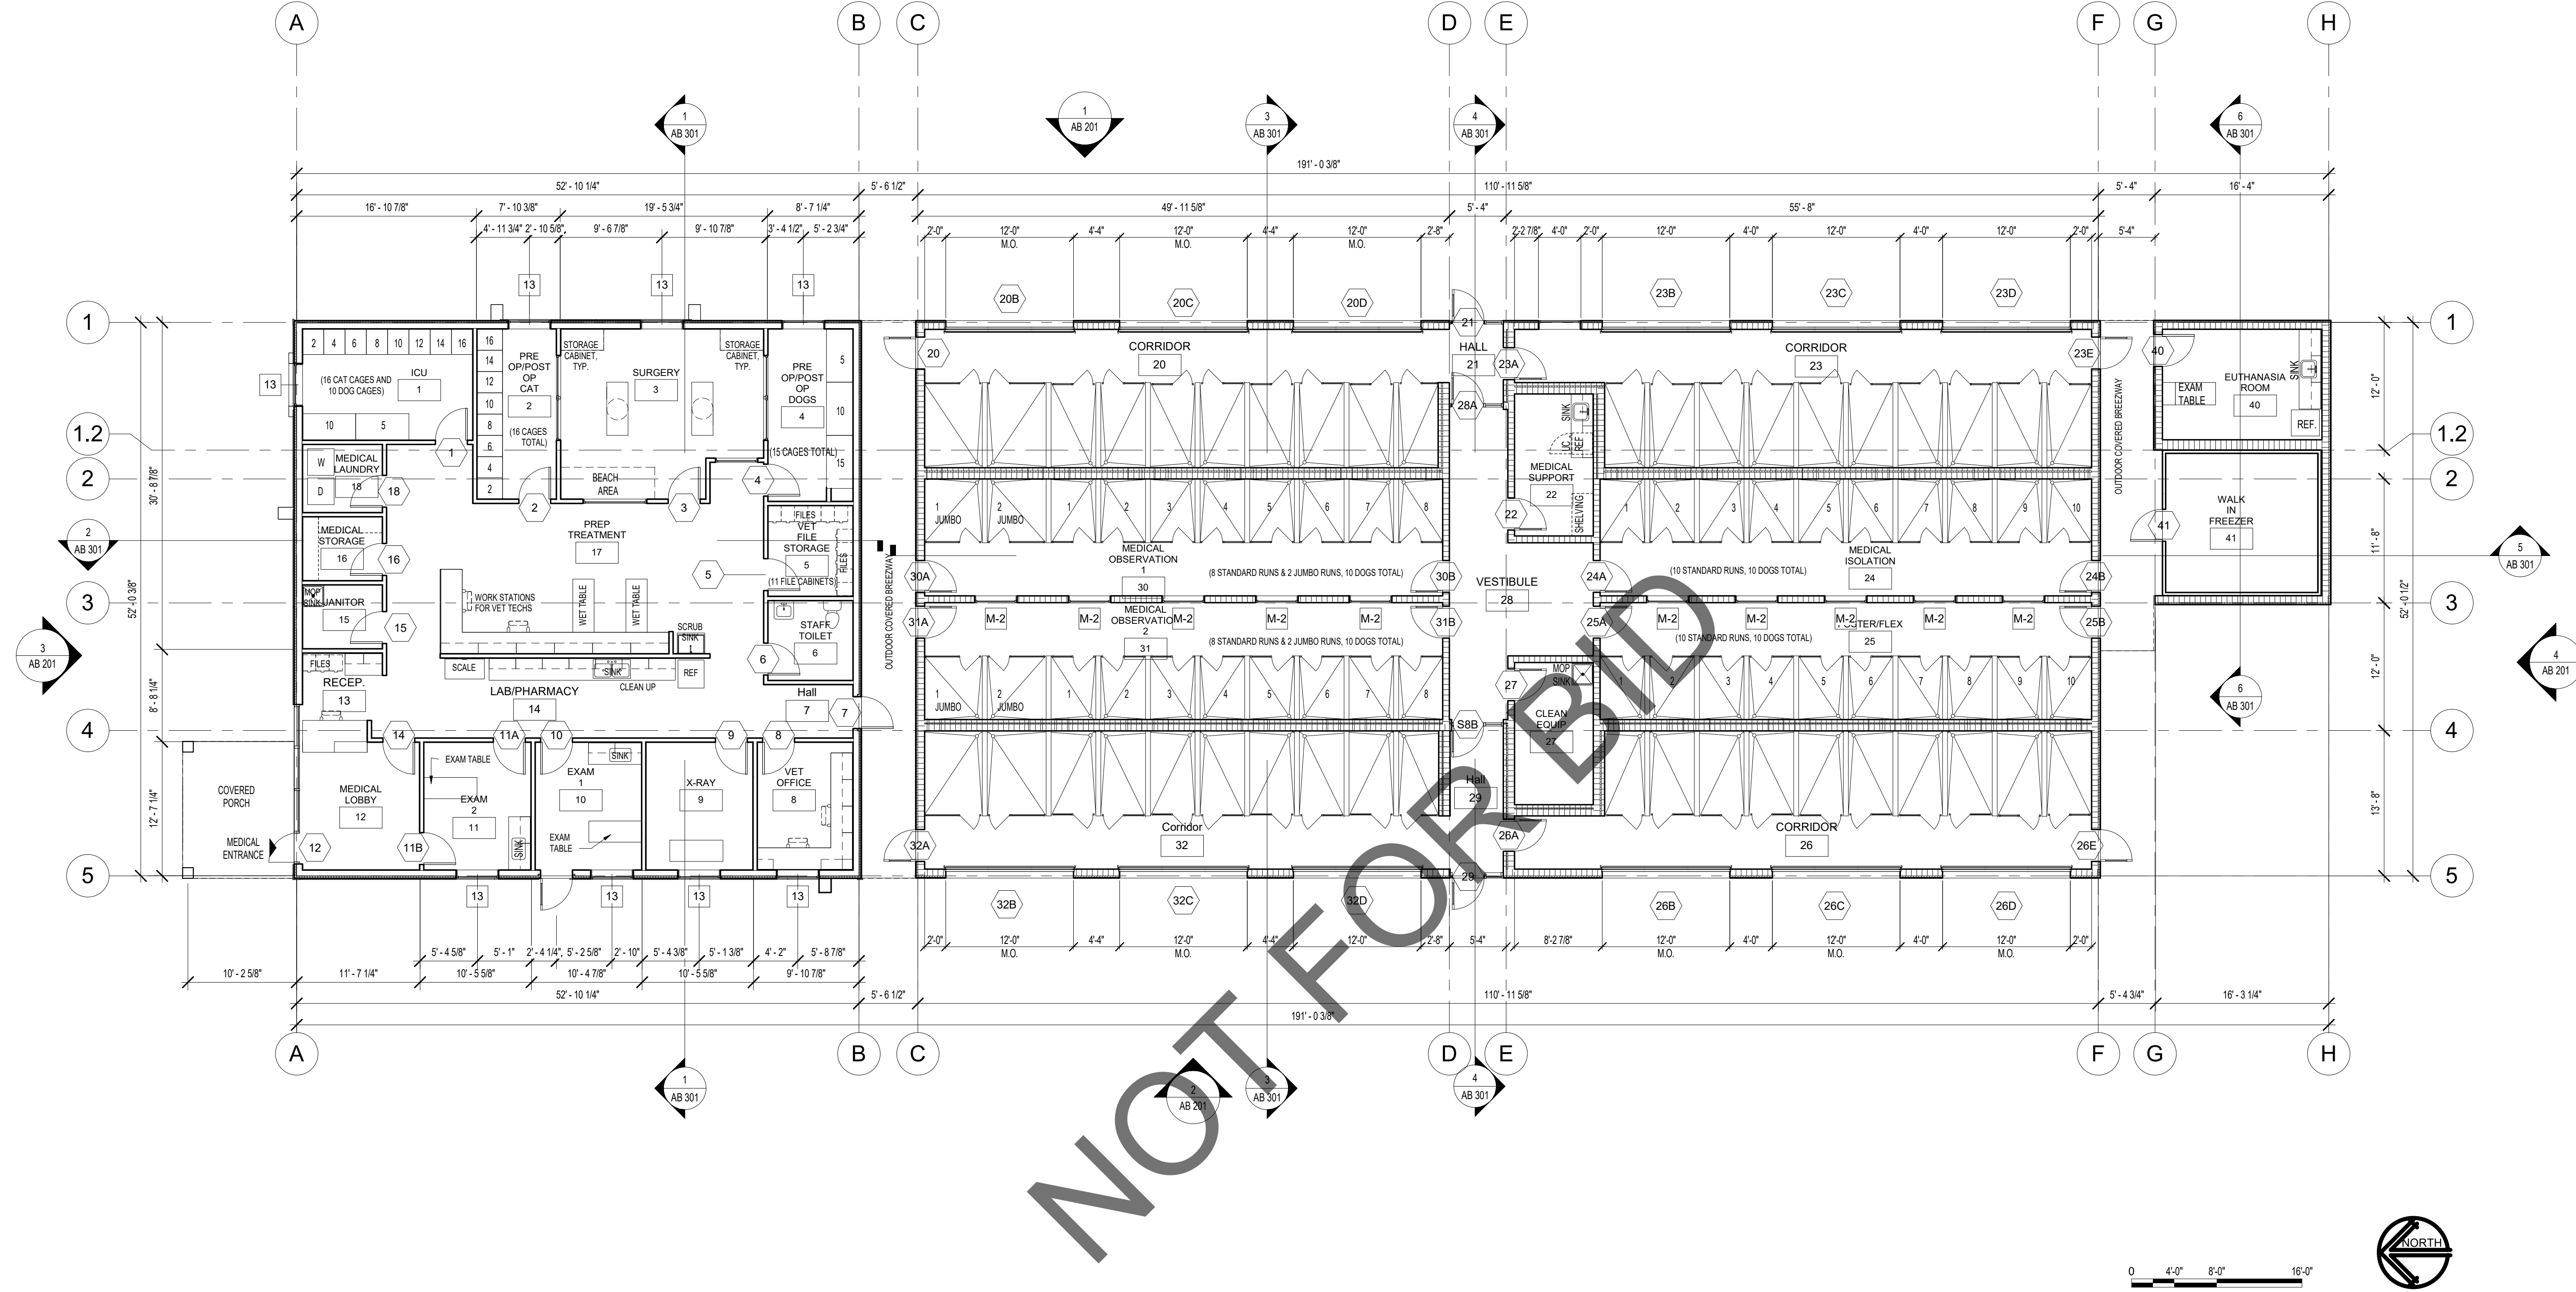

FLOOR PLAN - MEDICAL AND DOG BUILDING

SCALE	1
1/8" = 1'-0"	

GENERAL FLOOR PLAN NOTES:

- QUANTITIES LISTED ON THESE DOCUMENTS ARE FOR AGENCY APPROVAL ONLY. THE CONTRACTOR IS RESPONSIBLE FOR VERIFYING ALL QUANTITIES FOR BIDDING PURPOSES.
- ALL NEW WORK SHALL CONFORM TO CURRENT BUILDING STANDARDS, UNLESS NOTED OTHERWISE.
- CONTRACTOR TO VERIFY EXISTING CONSTRUCTION WITHIN THE SCOPE OF WORK TO ENSURE CONFORMANCE WITH NOTED RATINGS AND LOCAL CODES. RETROFIT NON-CONFORMING CONSTRUCTION AS REQUIRED.
- FINISH: PREPARE SUB-FLOOR AND LEAVE IN BROOM CLEAN CONDITION TO RECEIVE NEW FINISH AS REQUIRED. FLOOR SHALL BE LEVEL AND FREE OF DIPS, DIMPLES AND JOINTS.
- REFER TO MECHANICAL, ELECTRICAL, AND PLUMBING DRAWINGS FOR ADDITIONAL SCOPE.

KEYNOTES

Key Value	Keynote Text
-----------	--------------

GENERAL - FLOOR PLAN NOTES

SCALE
1/8" = 1'-0"

ANIMAL CARE CENTER

18313 VALLEY BLVD. BLOOMINGTON, CA 92313

SAN BERNARDINO COUNTY

PROJECT INFORMATION

Project Number: 1227
Drawn By: AE
Checked By: GWM
Issue Date: 03/22/23

SHEET NAME

MEDICAL AND
DOG CLINIC
FLOOR PLAN


SHEET NUMBER

AB 101

Sheet Of Sheets




1177 Idaho Street, Suite 200
Redlands, CA 92374
Phone: 909-335-7400
Fax: 909-335-7299
info@miller-aip.com

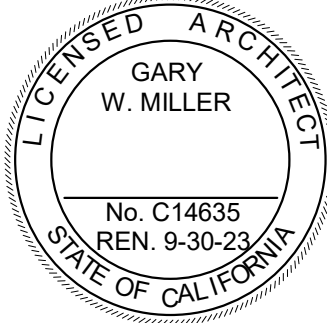

REVISIONS/ADDENDA

#	Date	Comment
---	------	---------

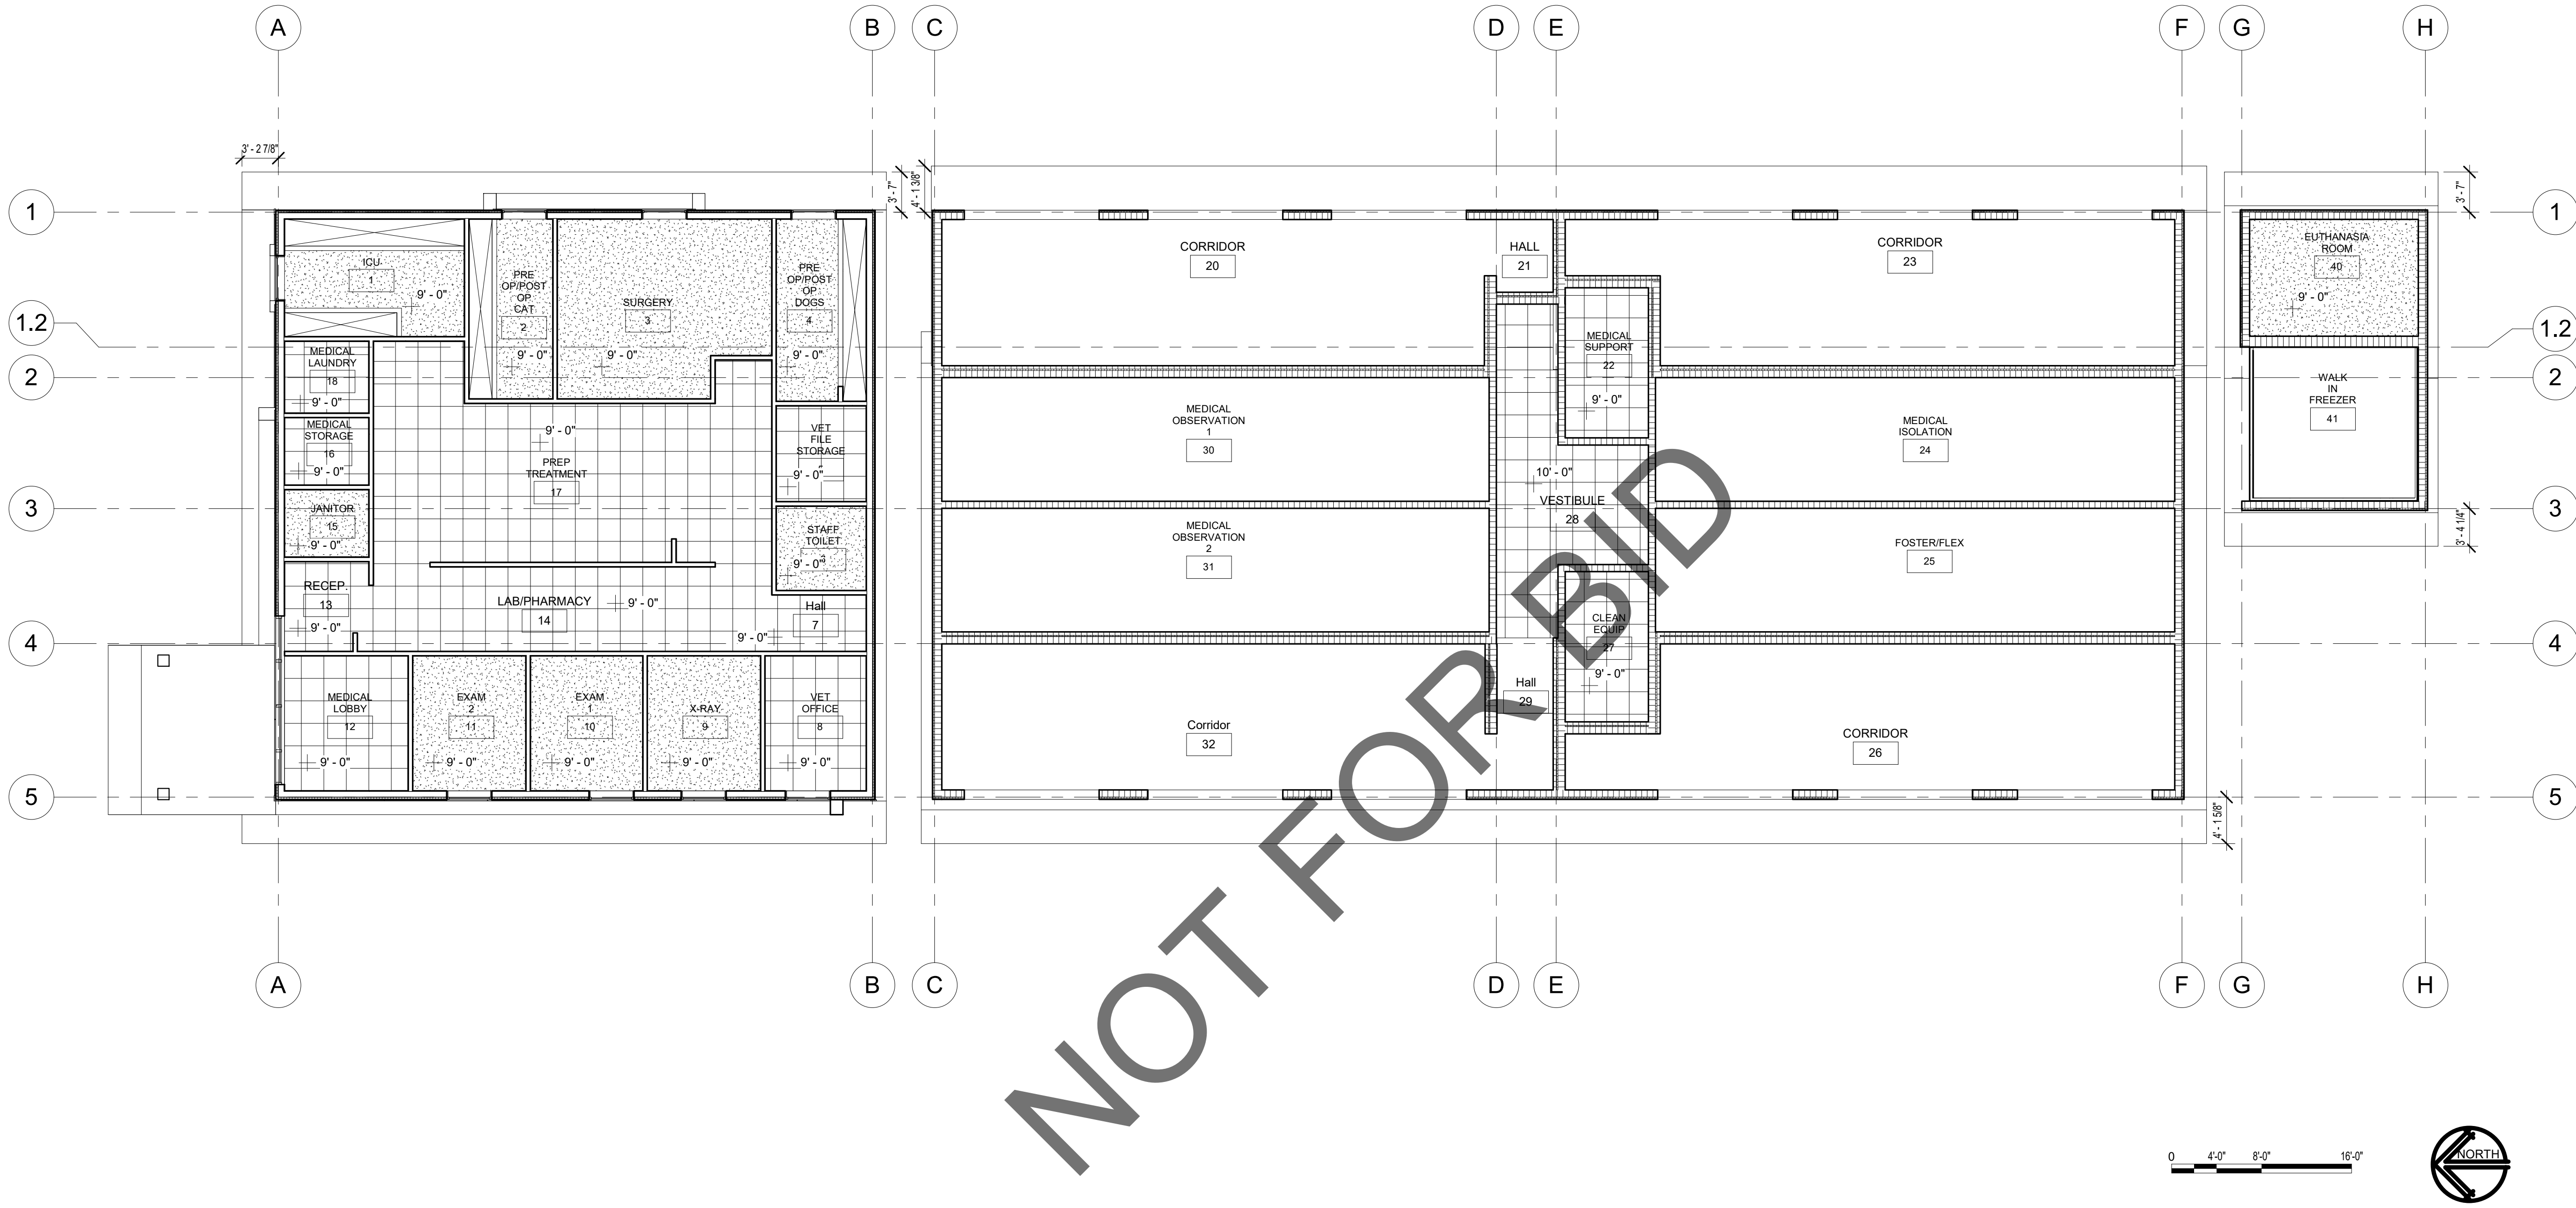

LEVEL 1 RCP

REFLECTED CEILING LEGEND:

- 2x2 ACT SUSPENDED CEILING
- GYPSUM BOARD CEILING
- CEMENT PLASTER CEILING
- OPEN TO ABOVE - NO CEILING
- PENDANT LIGHT FIXTURE. SEE ELECTRICAL
- RECESSED LIGHT FIXTURE. SEE ELECTRICAL
- SURFACE MOUNTED LIGHT FIXTURE. SEE ELECTRICAL
- EXIT SIGN. SEE ELECTRICAL DRAWINGS.
- EXHAUST. SEE ELECTRICAL DRAWINGS.
- SUPPLY / RETURN GRILLE. SEE MECHANICAL
- CEILING HEIGHT

GENERAL REFLECTED CEILING PLAN NOTES:

- QUANTITIES LISTED ON THESE DOCUMENTS ARE FOR AGENCY APPROVAL ONLY. THE CONTRACTOR IS RESPONSIBLE FOR VERIFYING ALL QUANTITIES FOR BIDDING PURPOSES.
- ALL NEW WORK SHALL CONFORM TO CURRENT BUILDING STANDARDS, UNLESS NOTED OTHERWISE.
- CONTRACTOR TO VERIFY EXISTING CONSTRUCTION WITHIN THE SCOPE OF WORK TO ENSURE CONFORMANCE WITH NOTED RATINGS AND LOCAL CODES. RETROFIT NON-CONFORMING CONSTRUCTION AS REQUIRED.
- SUSPENSION SYSTEM TO BE "PRELUDE XL" AS MANUFACTURED BY ARMSTRONG WORLD INDUSTRIES, INC. OR EQUAL AS APPROVED BY ARCHITECT.
- PERIODIC INSPECTION OF THE CEILING SUSPENSION SYSTEM SHALL BE PROVIDED IN ACCORDANCE WITH MANUFACTURER'S REQUIREMENTS FOR SPECIFIED COMPONENTS AND CEILING ANCHORAGE SYSTEM.
- REFER TO MECHANICAL, ELECTRICAL, AND PLUMBING DRAWINGS FOR ADDITIONAL SCOPE.

KEYNOTES

Key Value Keynote Text

SCALE
1/8" = 1'-0"

ANIMAL CARE CENTER
18313 VALLEY BLVD. BLOOMINGTON, CA 92313

SAN BERNARDINO COUNTY

PROJECT INFORMATION

Project Number: 1227
Drawn By: TWS
Checked By: GWM
Issue Date: 03/22/23

SHEET NAME

MEDICAL AND
DOG CLINIC
RCP

SHEET NUMBER

AB 103

Sheet Of Sheets

owner approval

initials date phase

REVISIONS/ADDENDA

Date Comment



1177 Idaho Street, Suite 200
Redlands, CA 92374
Phone: 909-335-7400
Fax: 909-335-7299
info@milller-aip.com



owner approval

initials	date	phase

REVISIONS/ADDENDA

#	Date	Comment
---	------	---------

ANIMAL CARE CENTER

18313 VALLEY BLVD. BLOOMINGTON, CA 92313

SAN BERNARDINO COUNTY

PROJECT INFORMATION

Project Number:	1227
Drawn By:	TWS
Checked By:	GWM
Issue Date:	03/22/23


SHEET NAME

MEDICAL AND DOG CLINIC ROOF PLAN

SHEET NUMBER

AB 105

Sheet Of Sheets

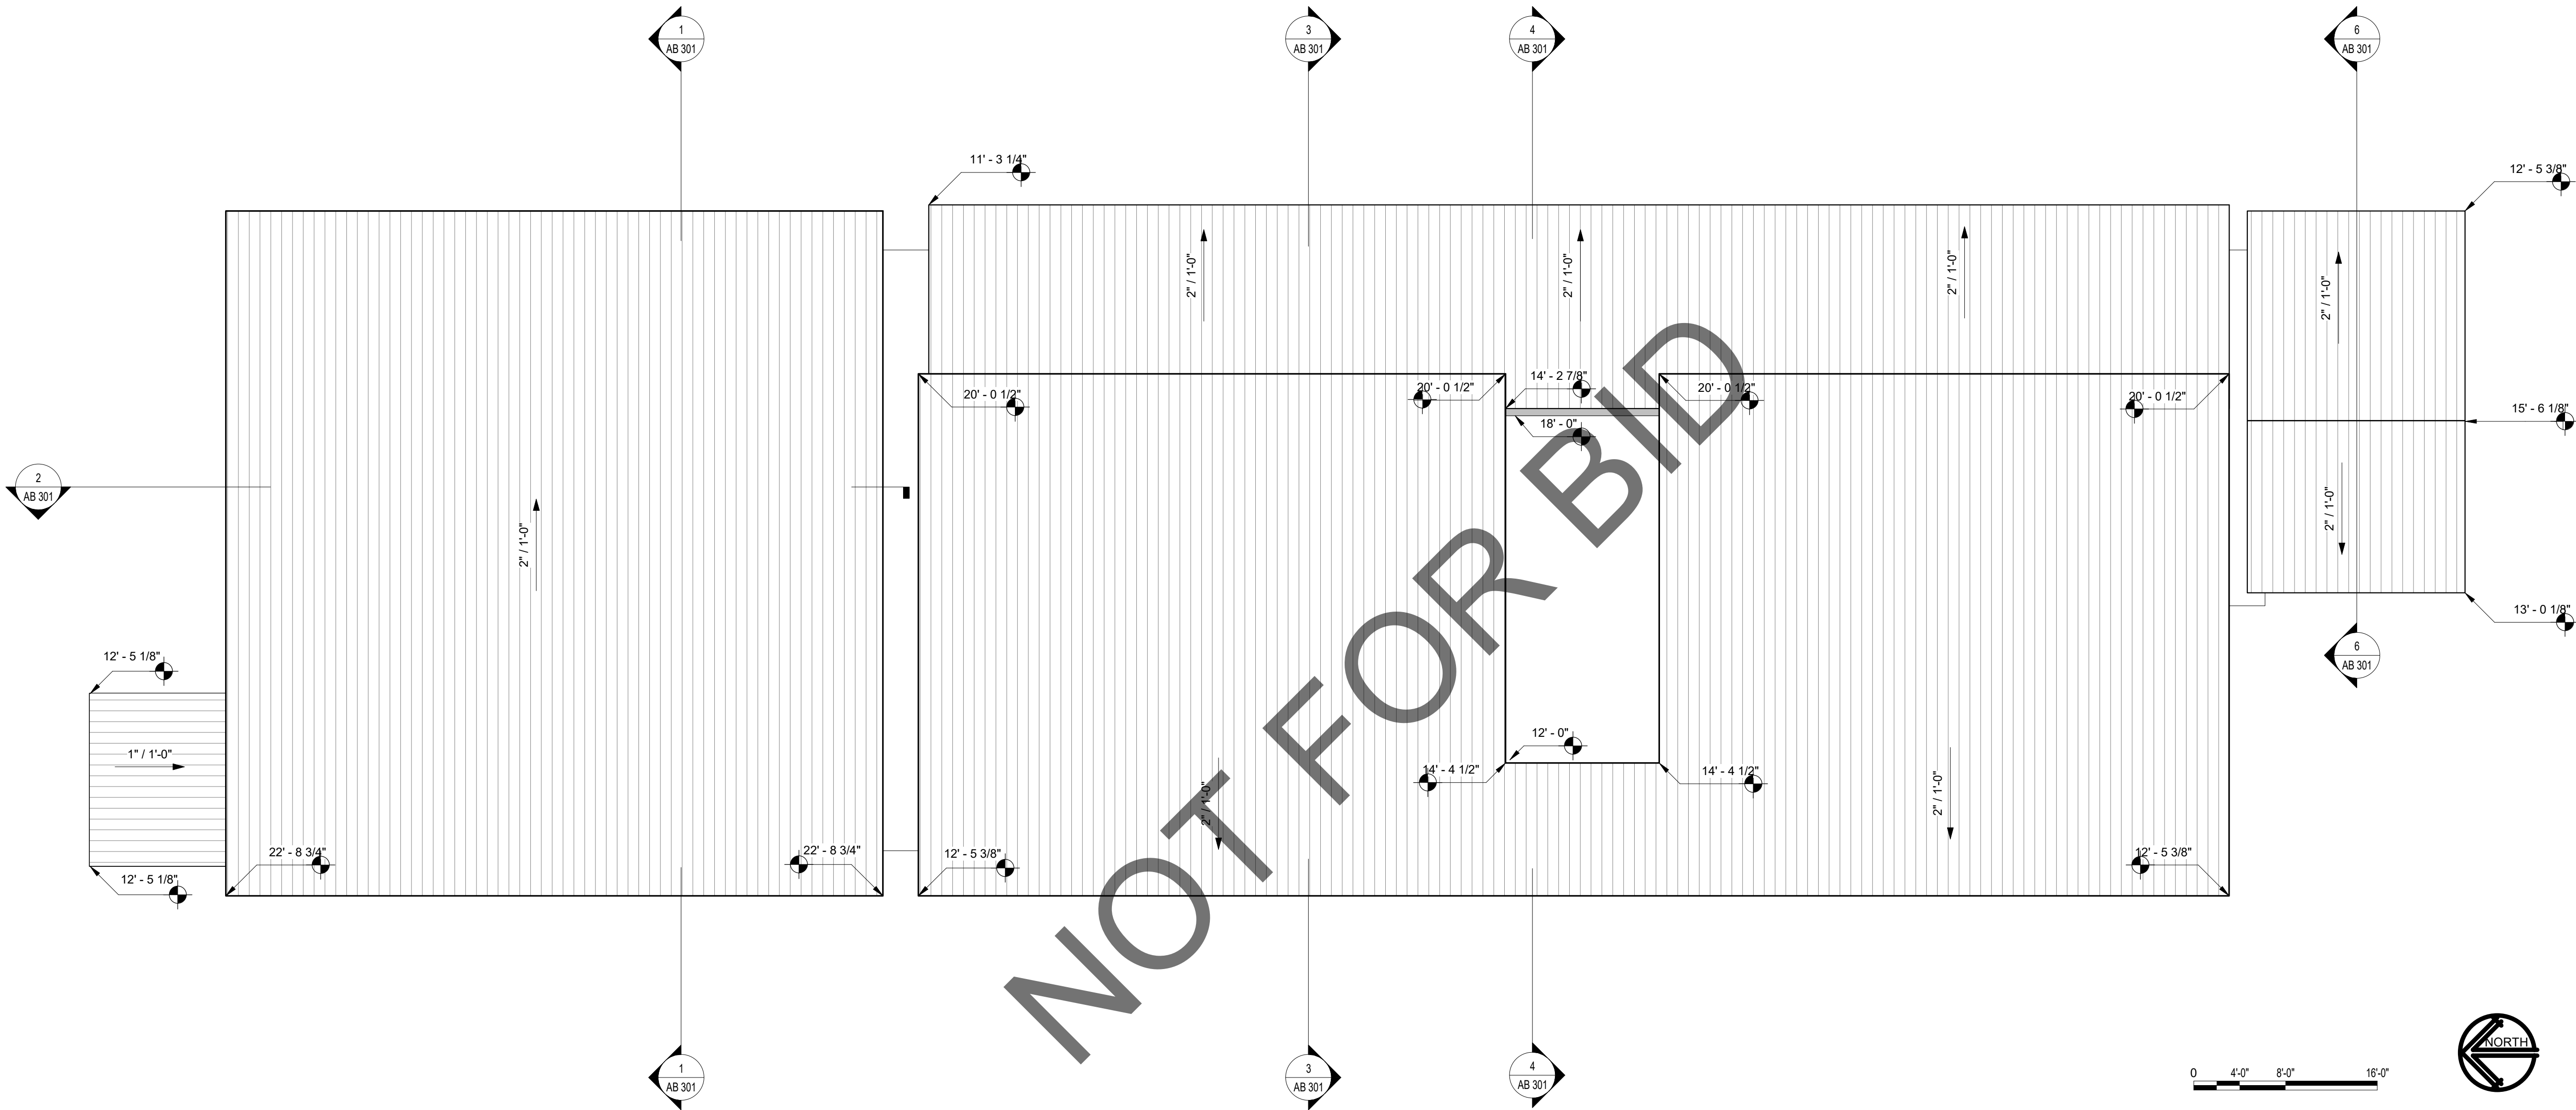

ROOF PLAN

SCALE	1
1/8" = 1'-0"	

[illegible]



owner approval

initials	date	phase

REVISIONS/ADDENDA

#	Date	Comment
---	------	---------

ANIMAL CARE CENTER

18313 VALLEY BLVD. BLOOMINGTON, CA 92313

SAN BERNARDINO COUNTY

PROJECT INFORMATION


Project Number:	1227
Drawn By:	TWS
Checked By:	GWM
Issue Date:	03/22/23

SHEET NAME

MEDICAL AND
DOG CLINIC
EXT. ELEV.

SHEET NUMBER


AB 201

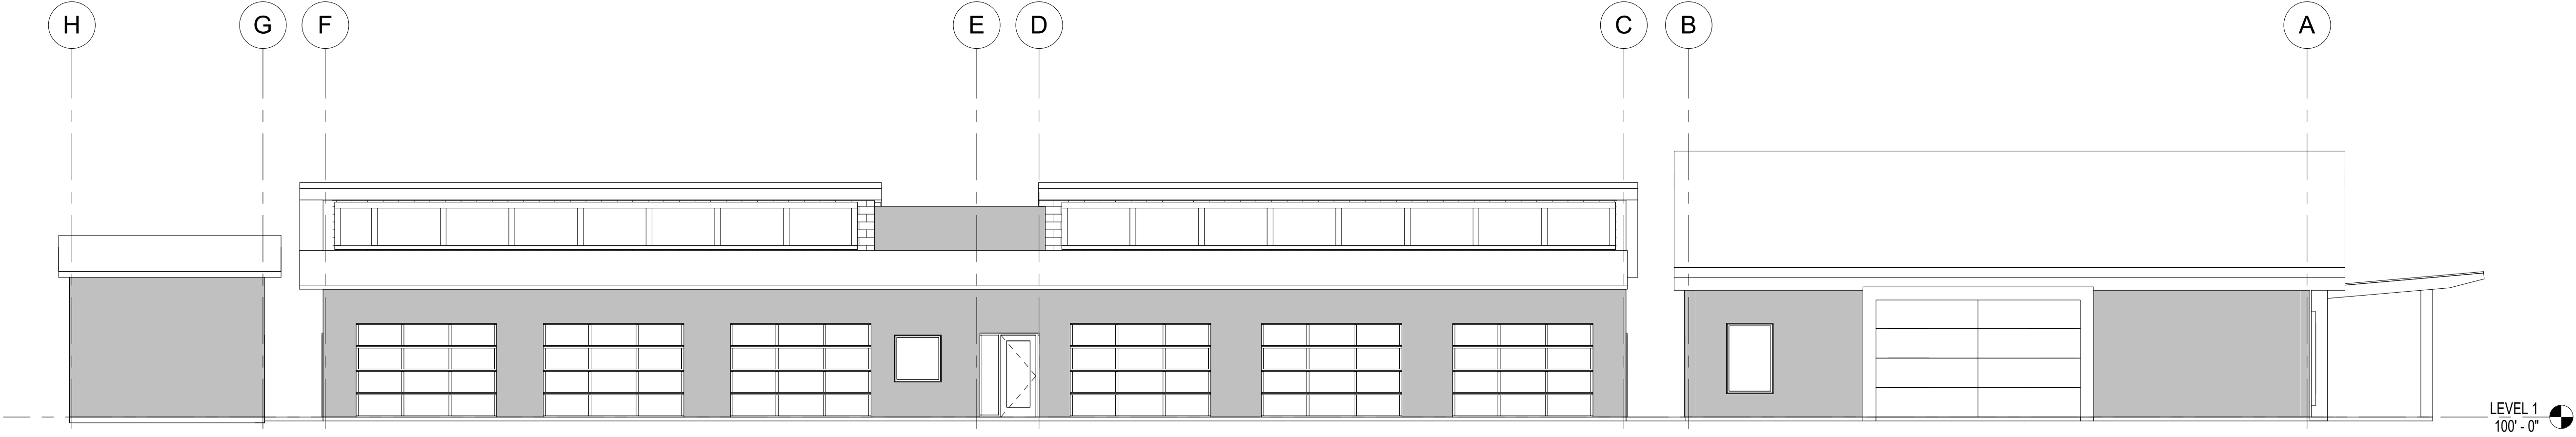

WEST ELEVATION

SCALE
1/8" = 1'-0"


1

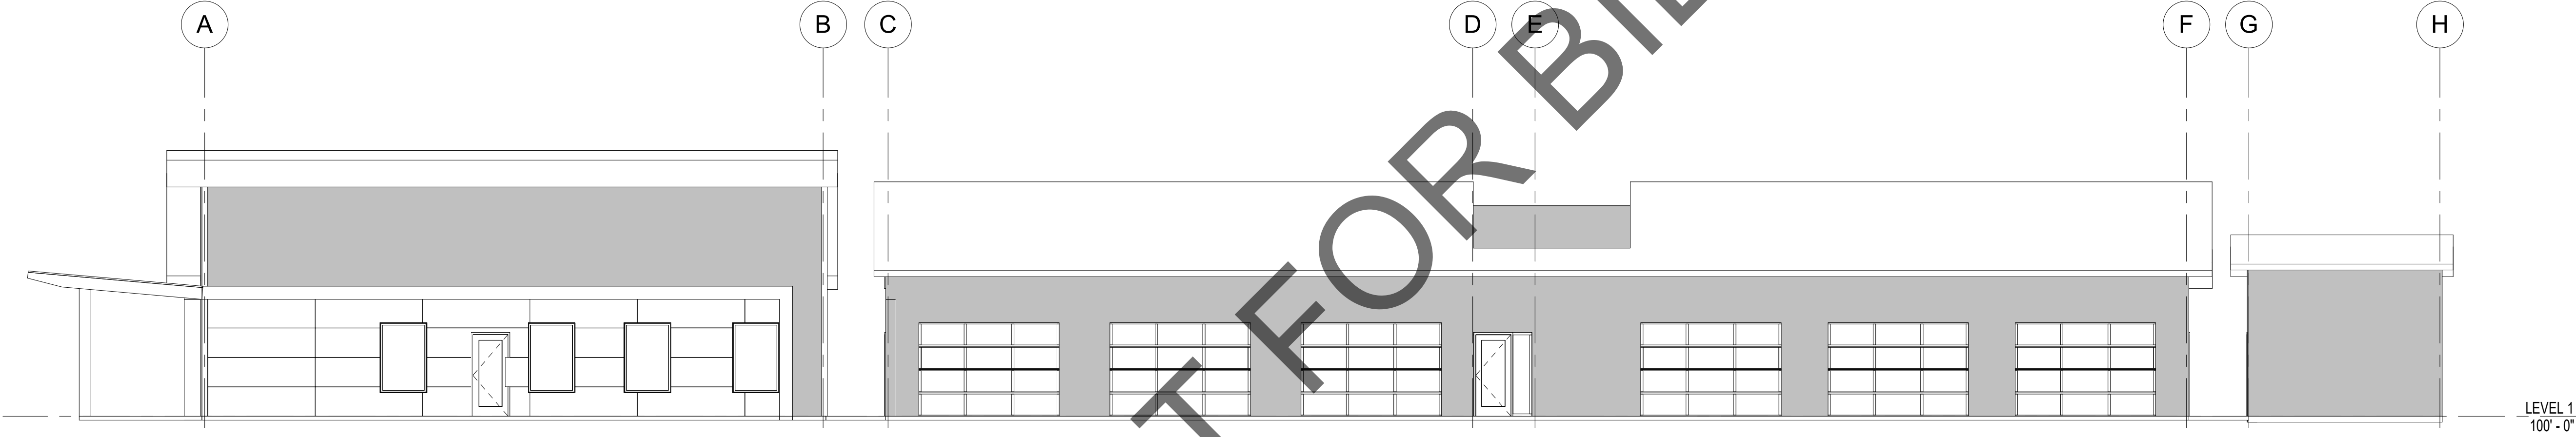

EAST ELEVATION

SCALE
1/8" = 1'-0"

2

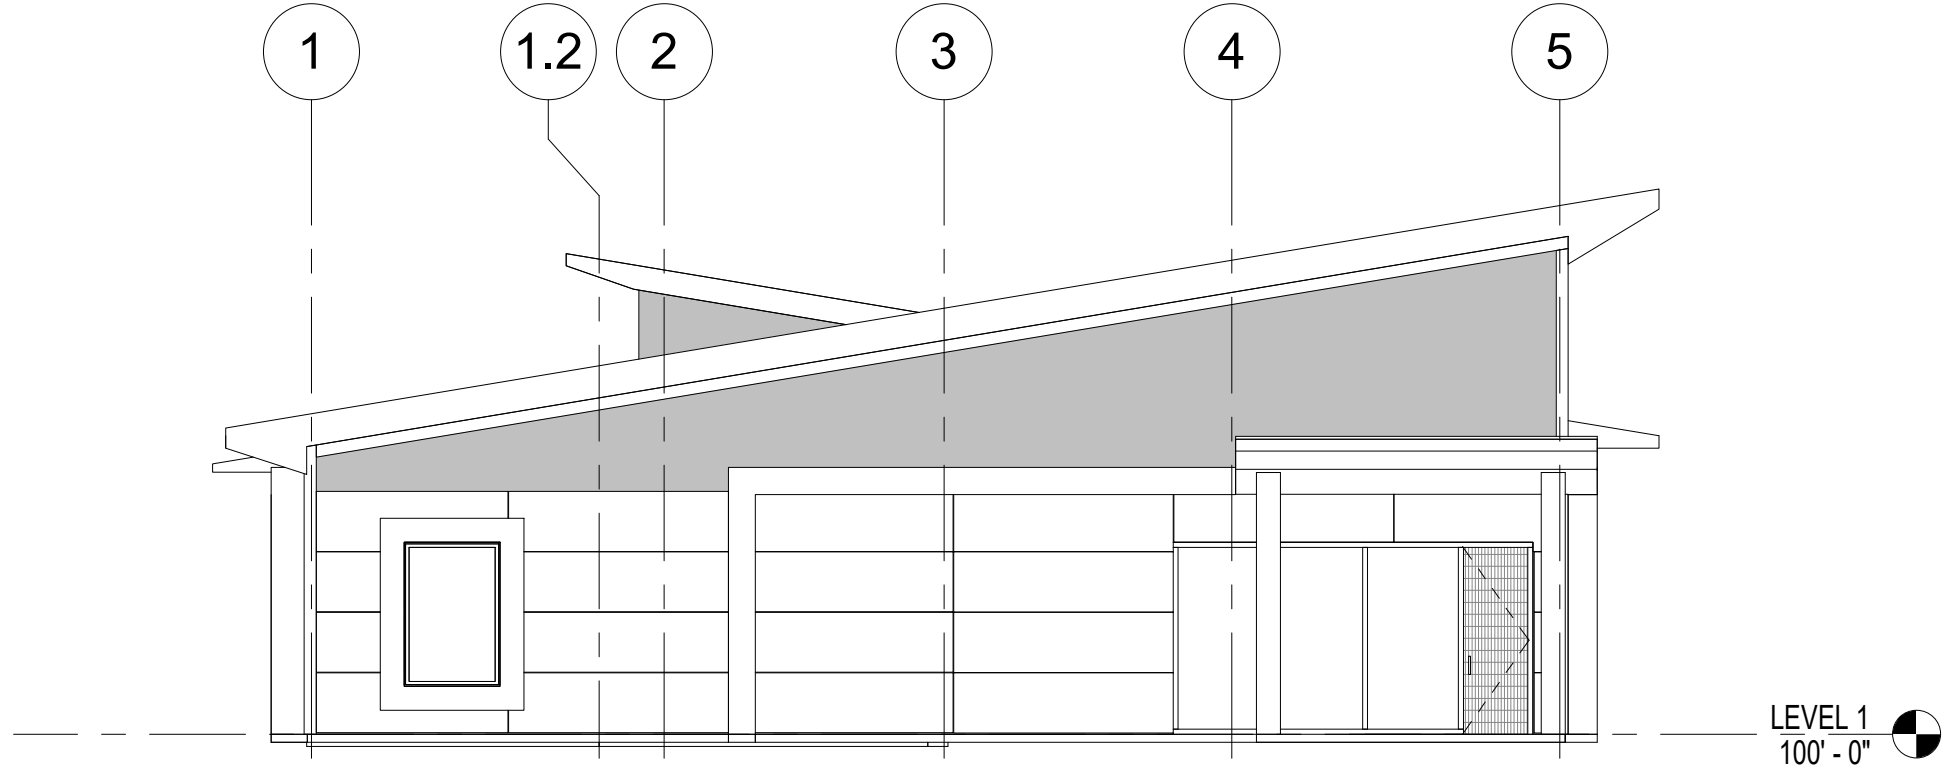


NORTH ELEVATION

SCALE
1/8" = 1'-0"


3

SOUTH ELEVATION

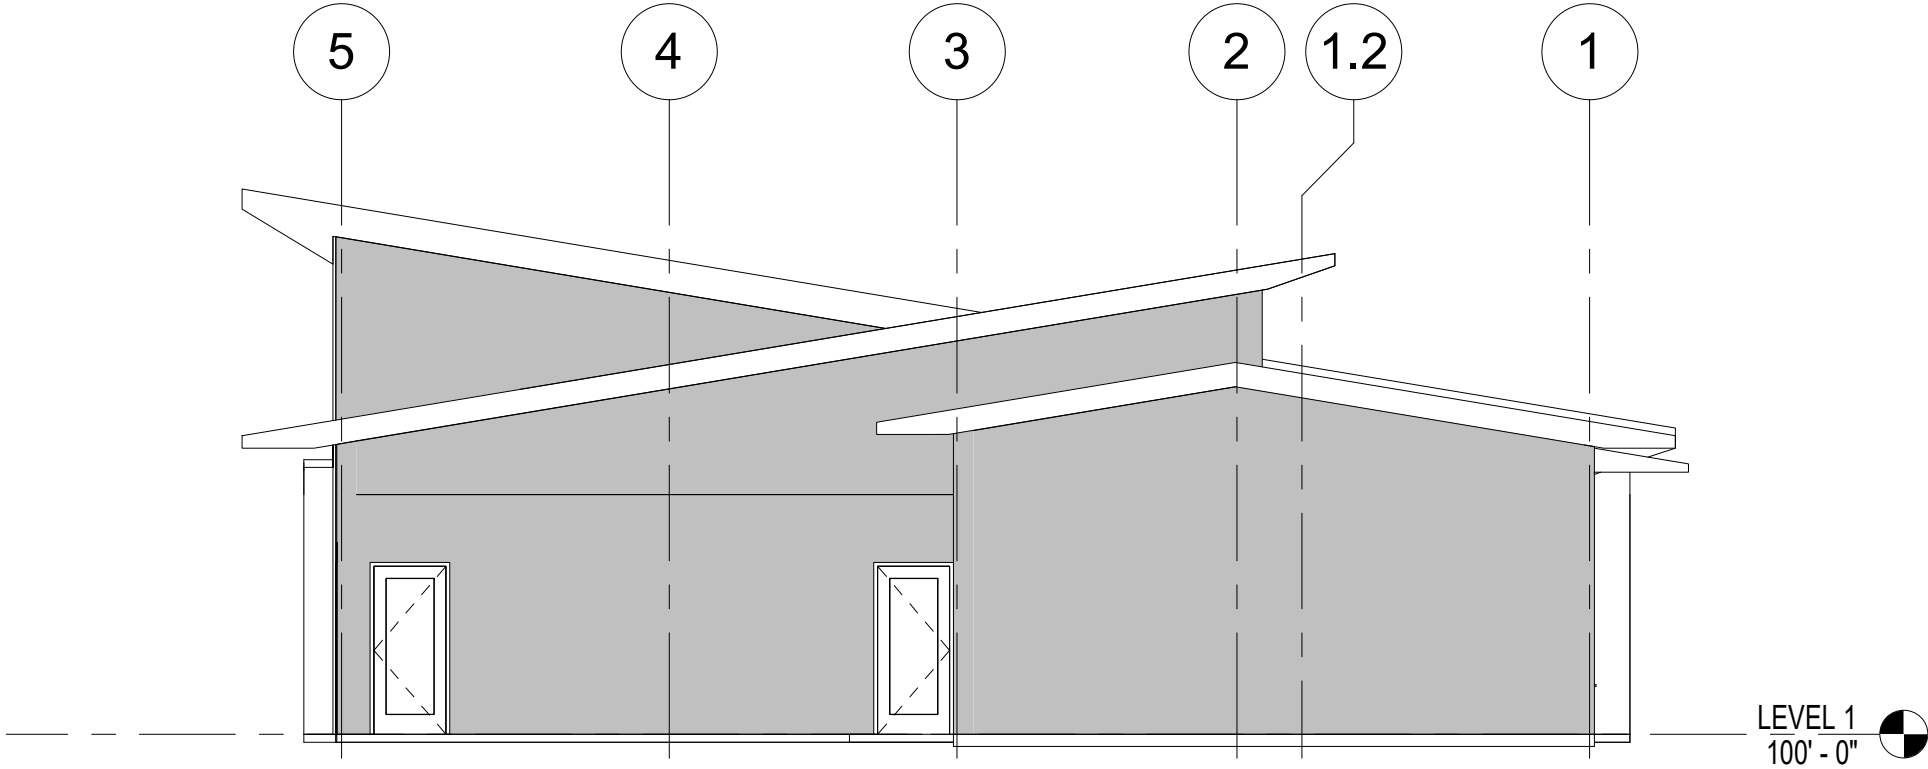


SCALE
1/8" = 1'-0"

4

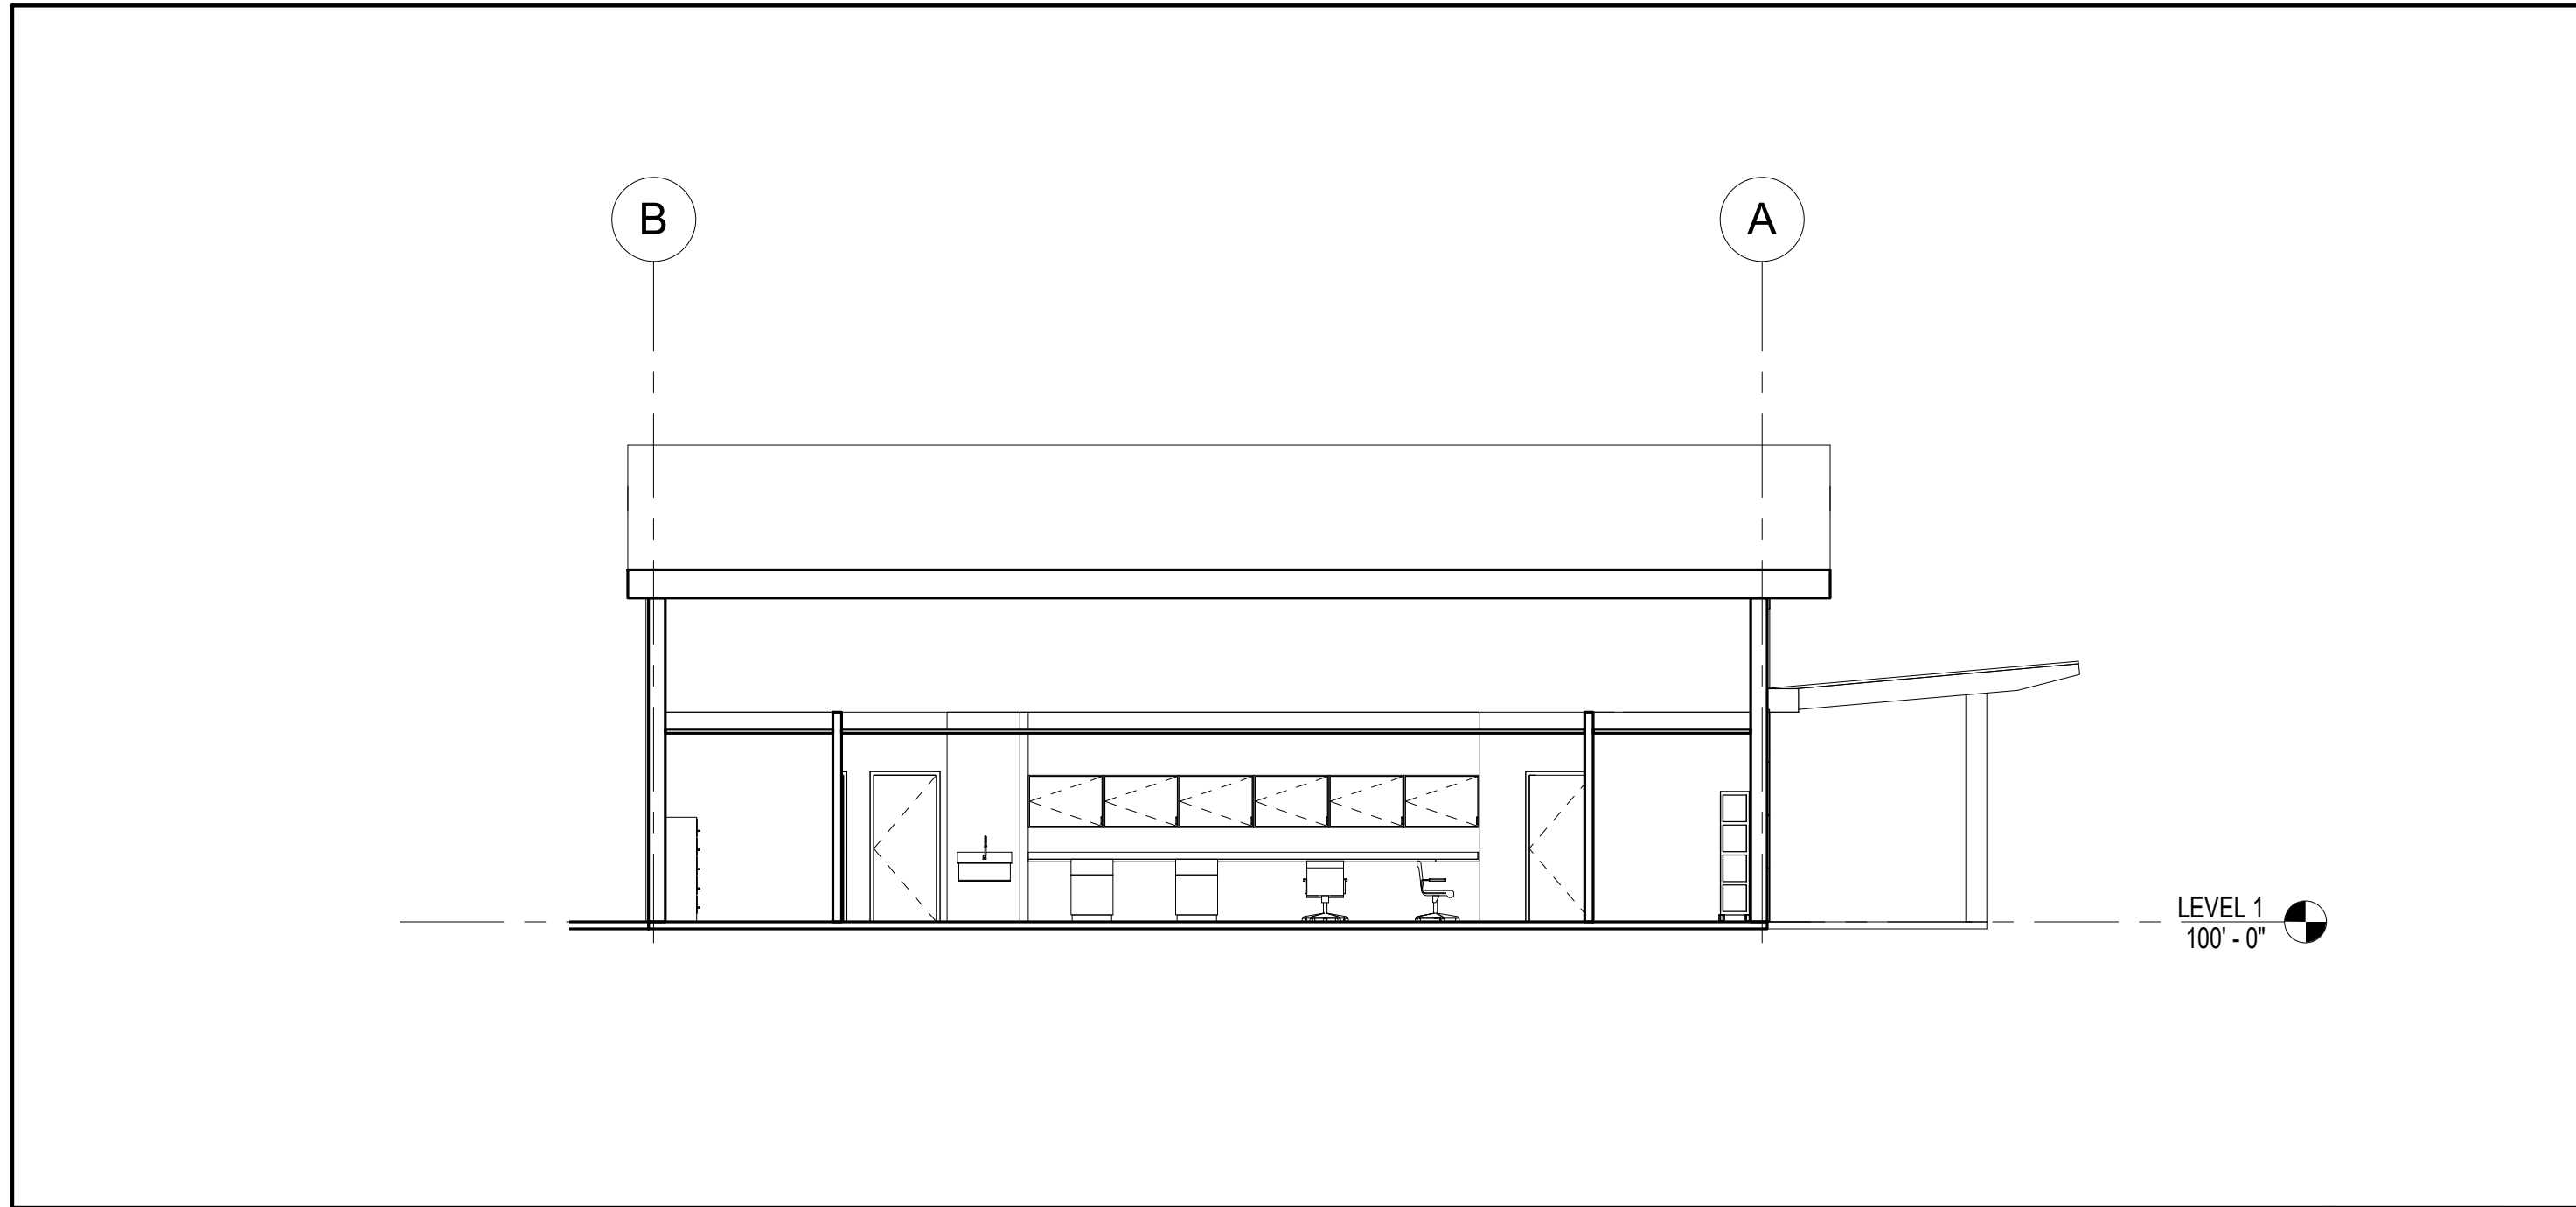


SECTION 2

SCALE	2
1/8" = 1'-0"	

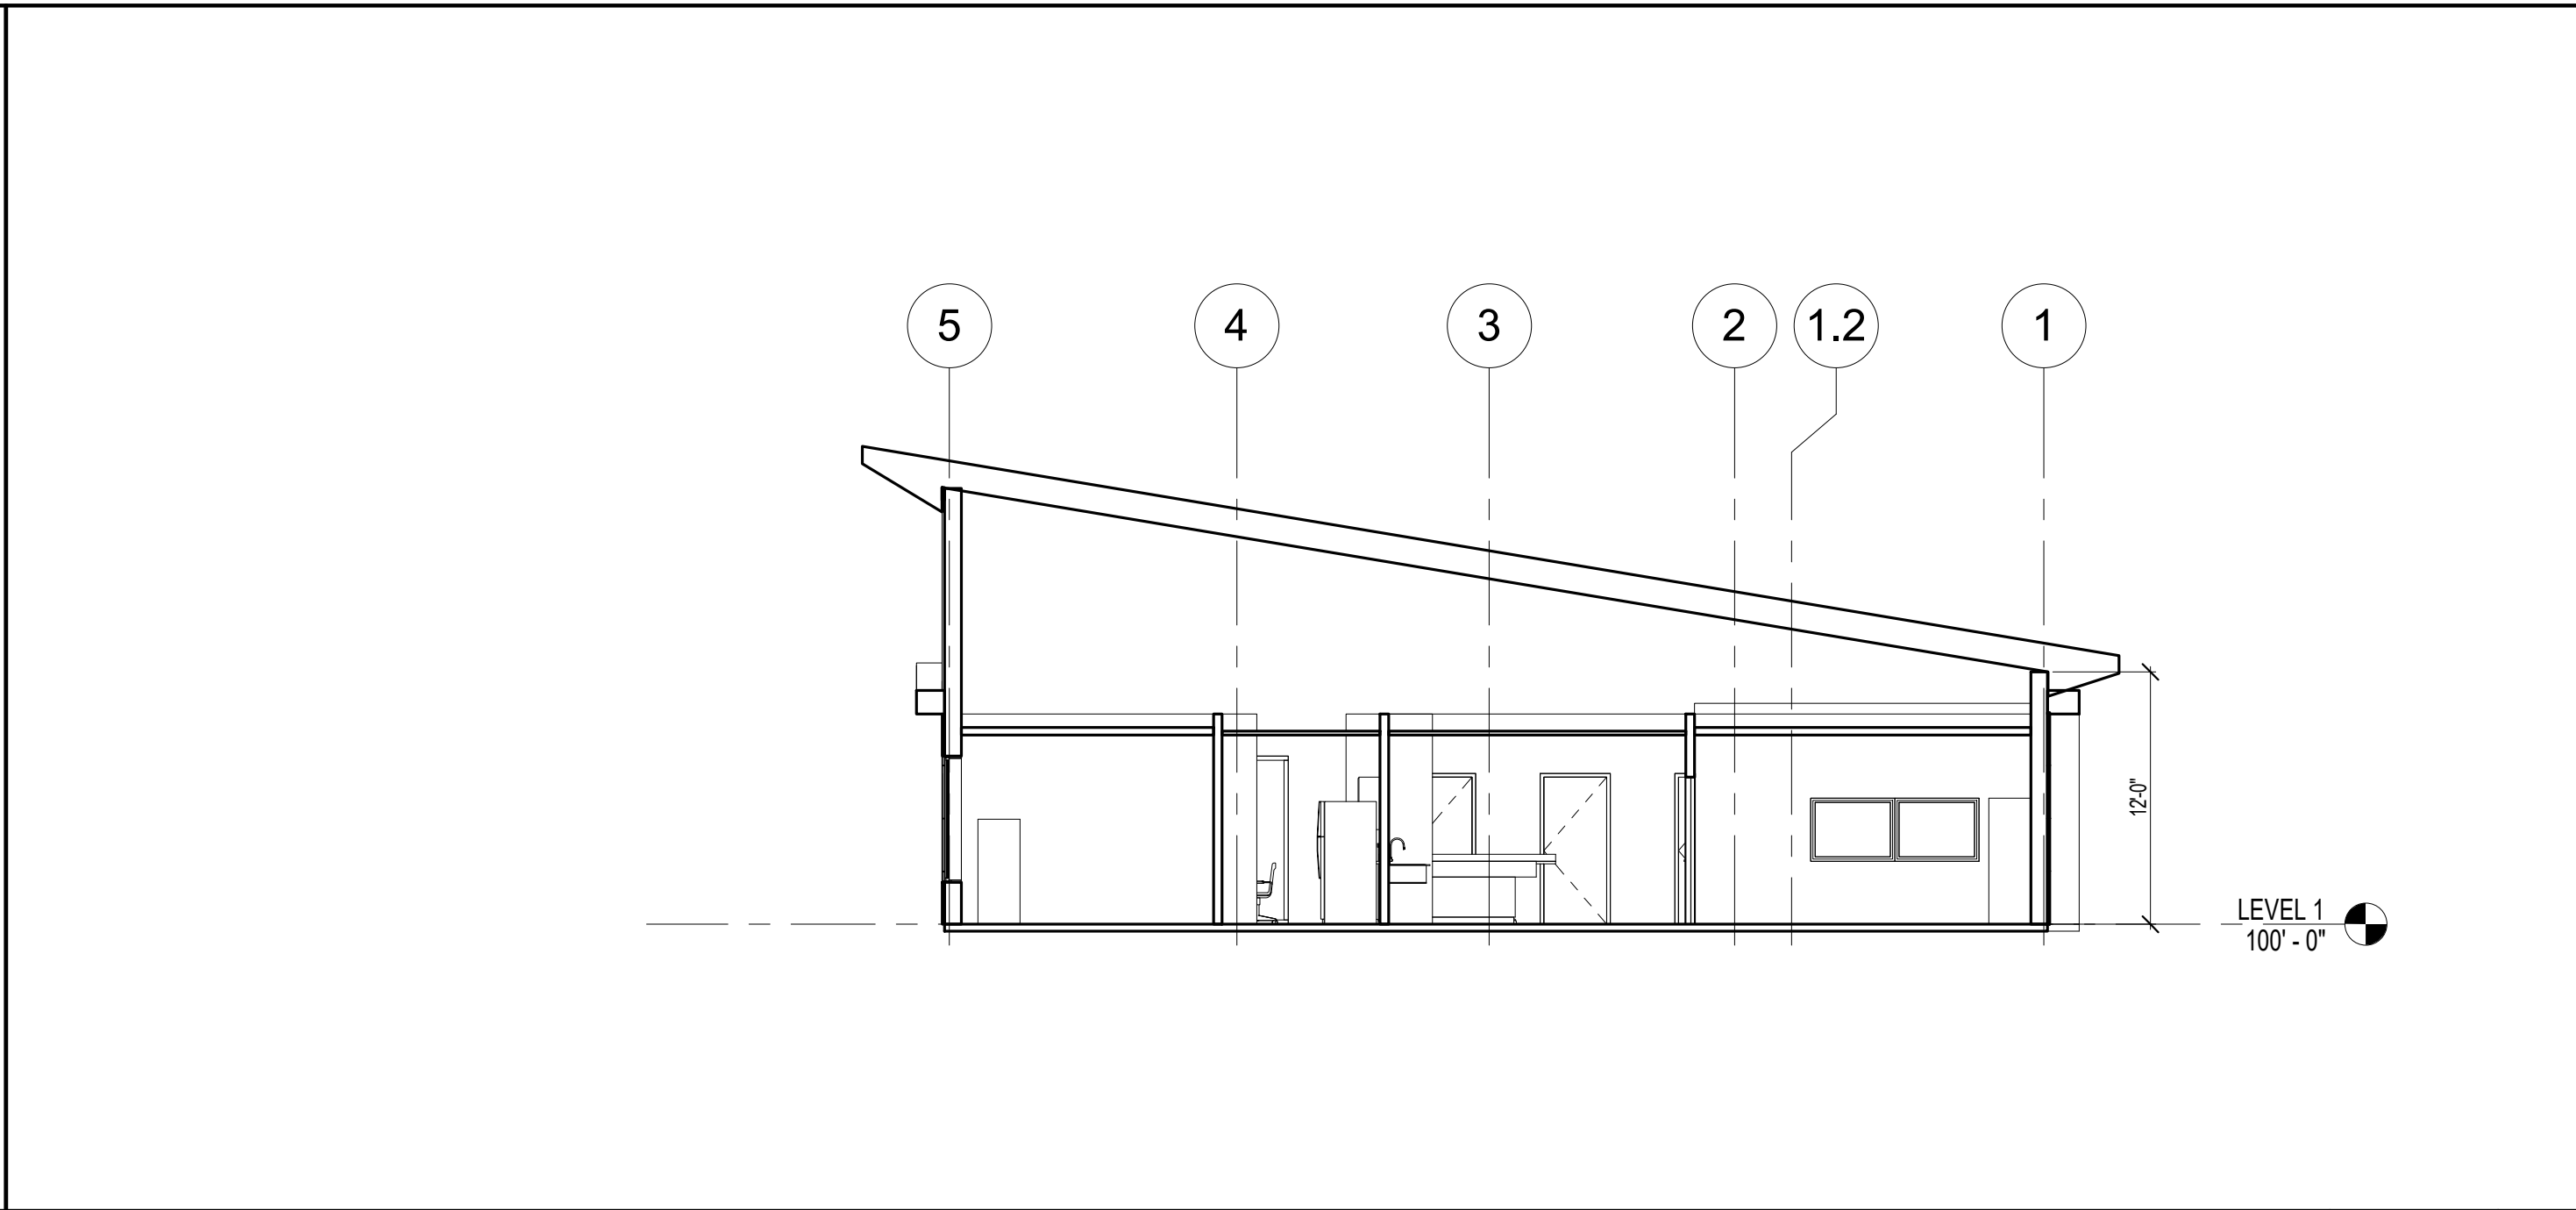


SECTION 1

SCALE	1
1/8" = 1'-0"	

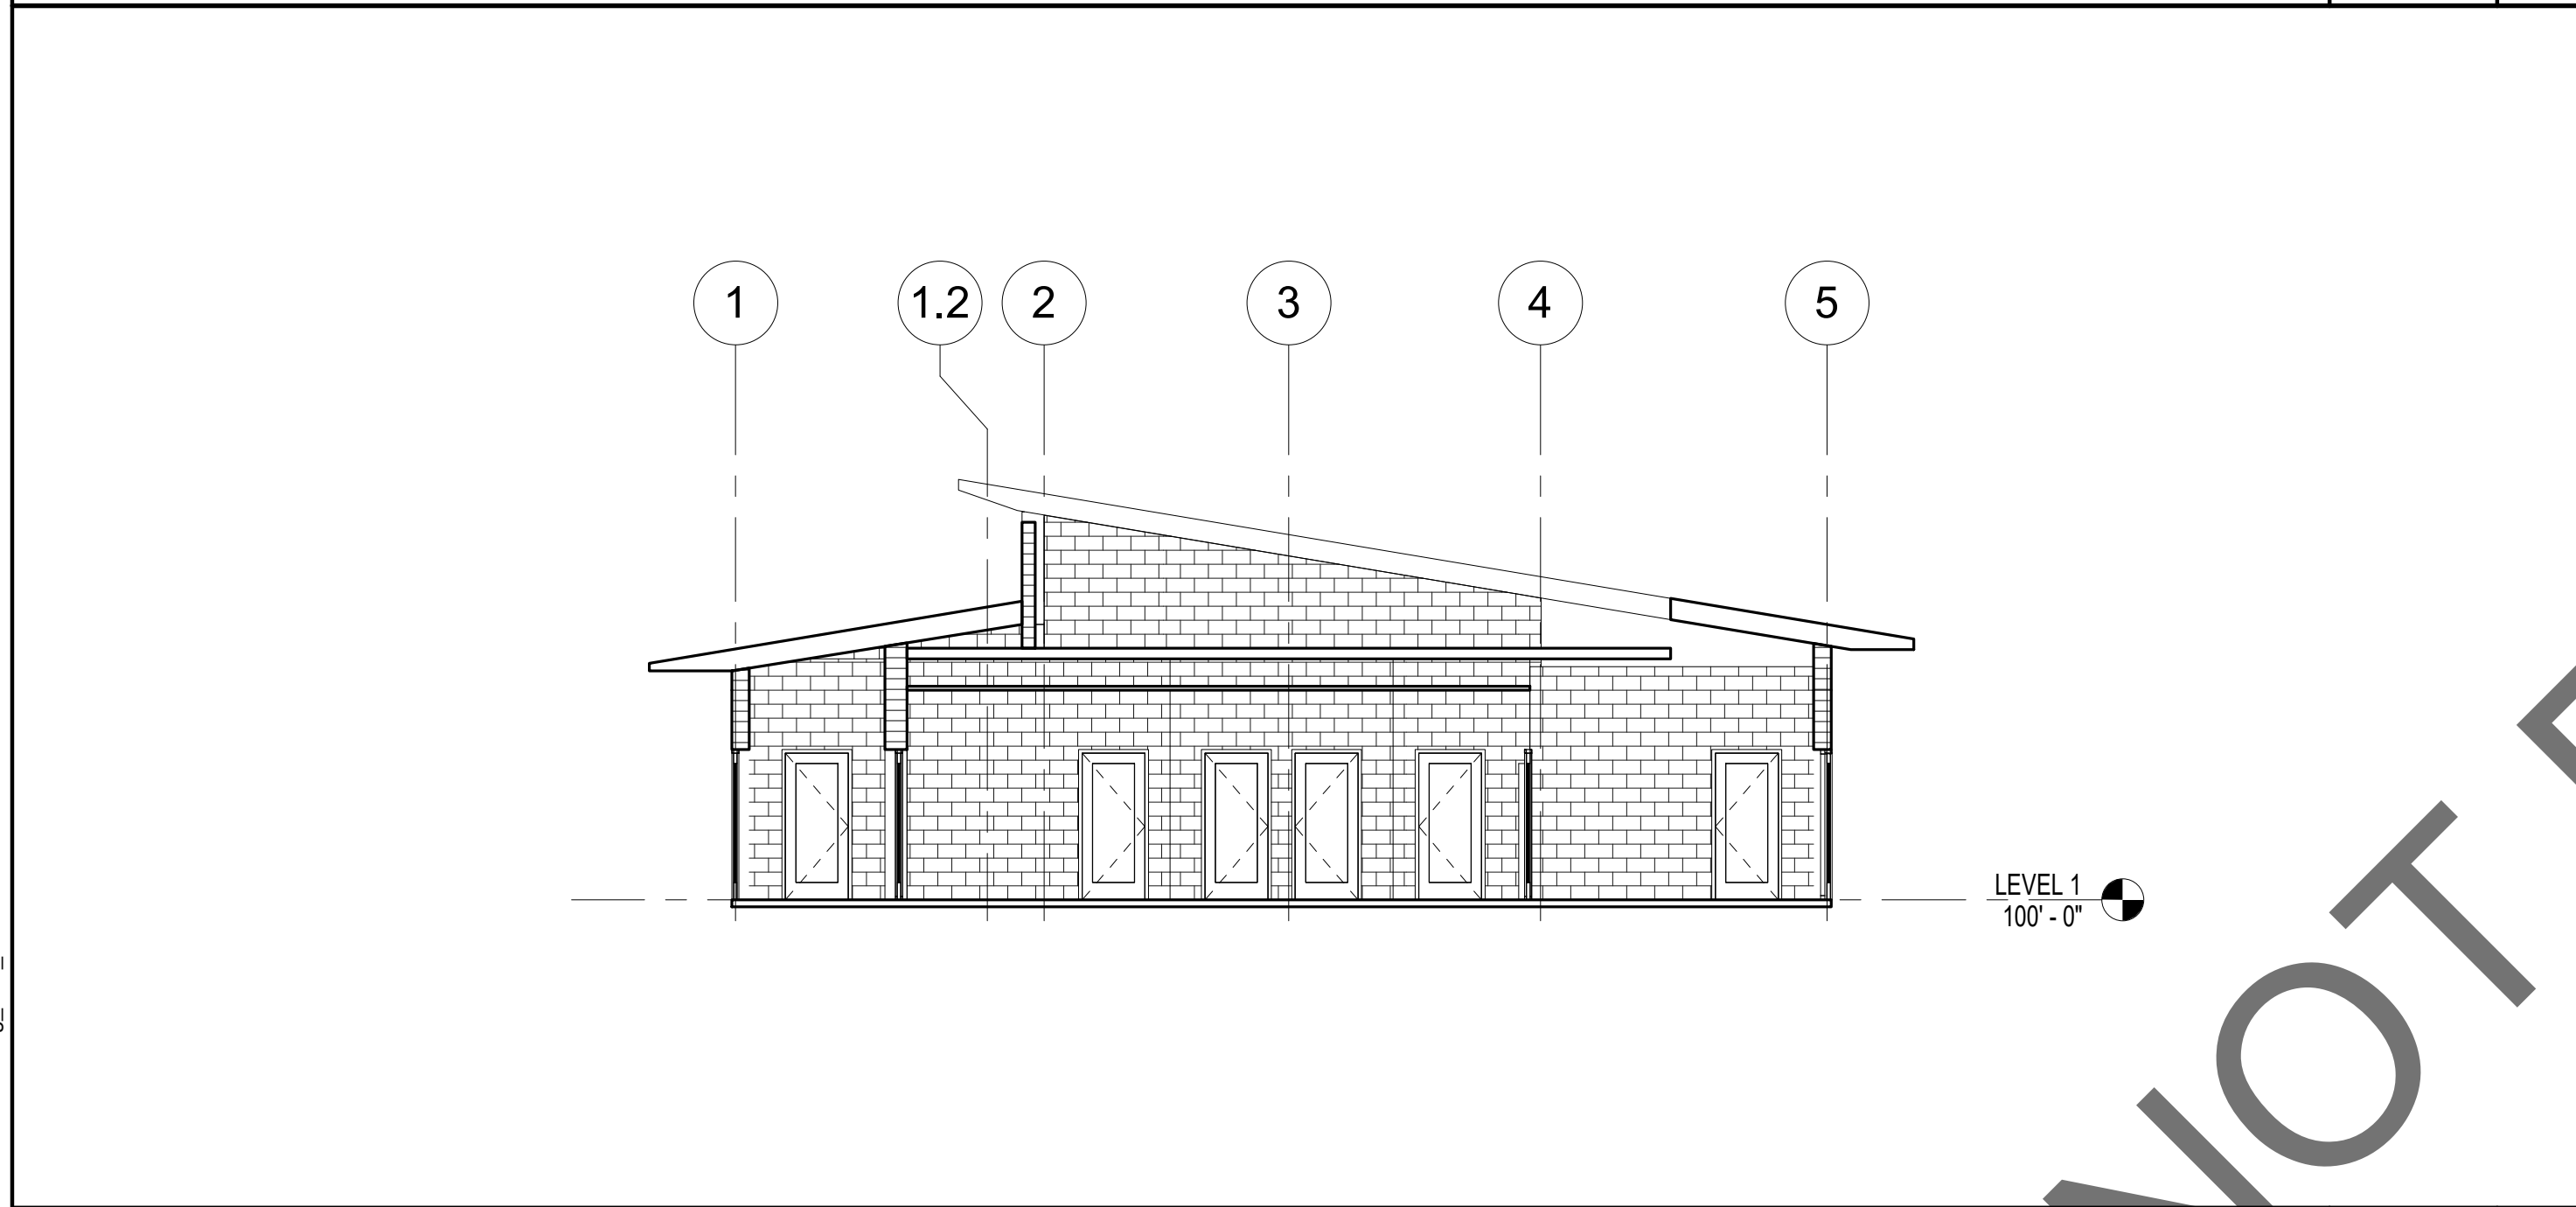


SECTION 4

SCALE	4
1/8" = 1'-0"	

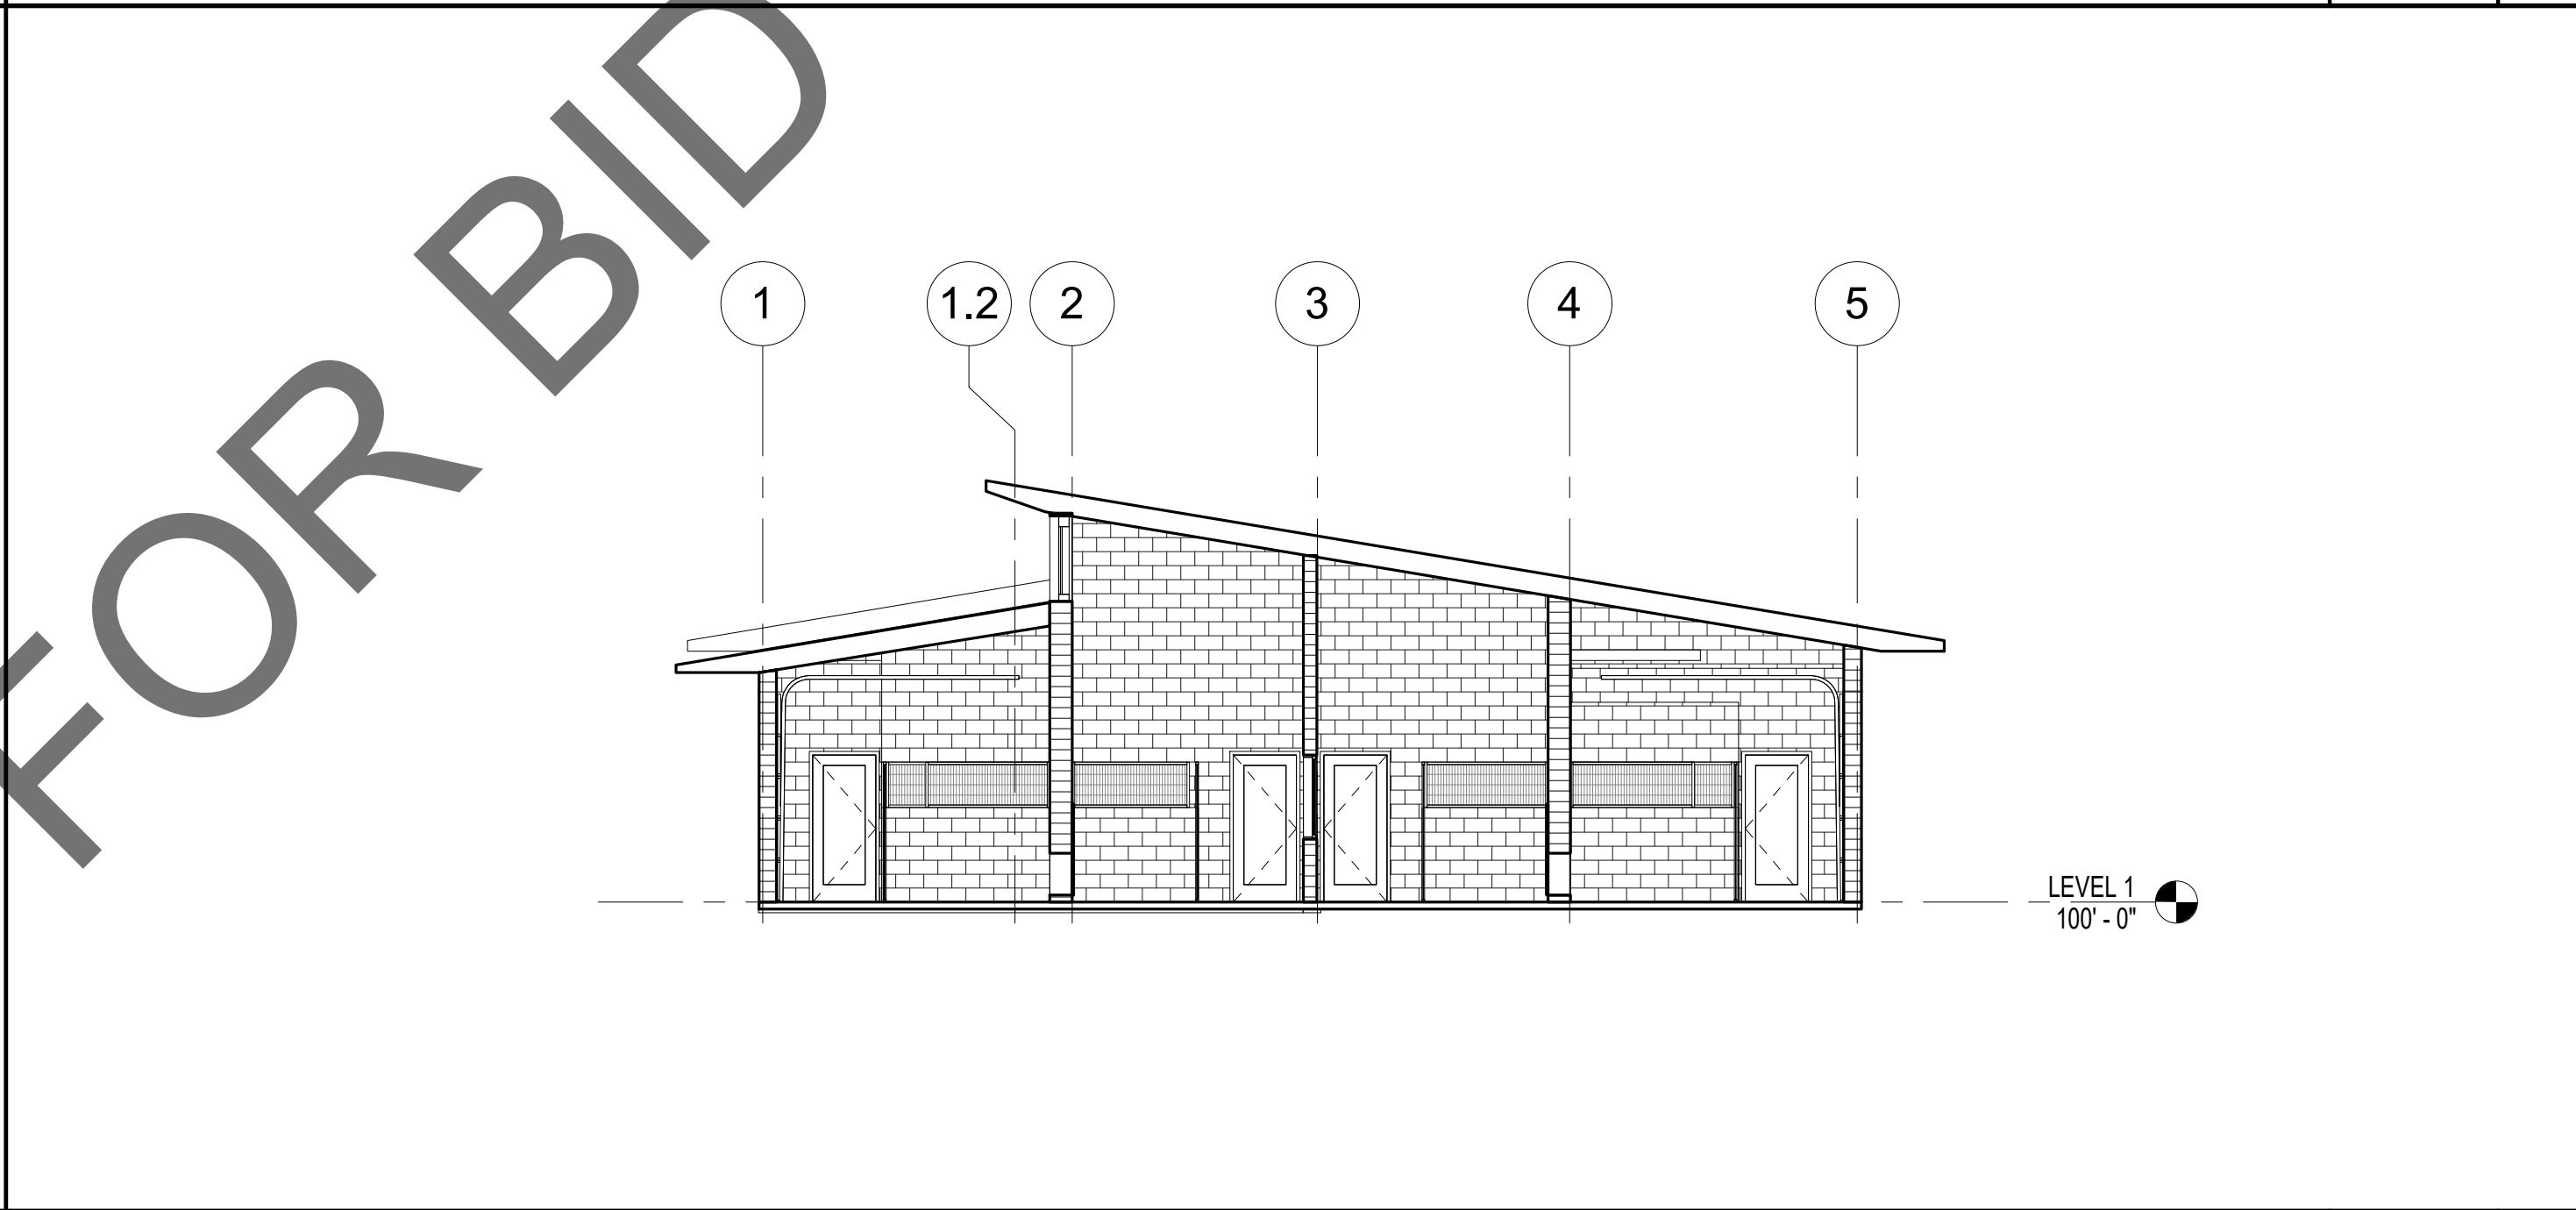


SECTION 3

SCALE	3
1/8" = 1'-0"	

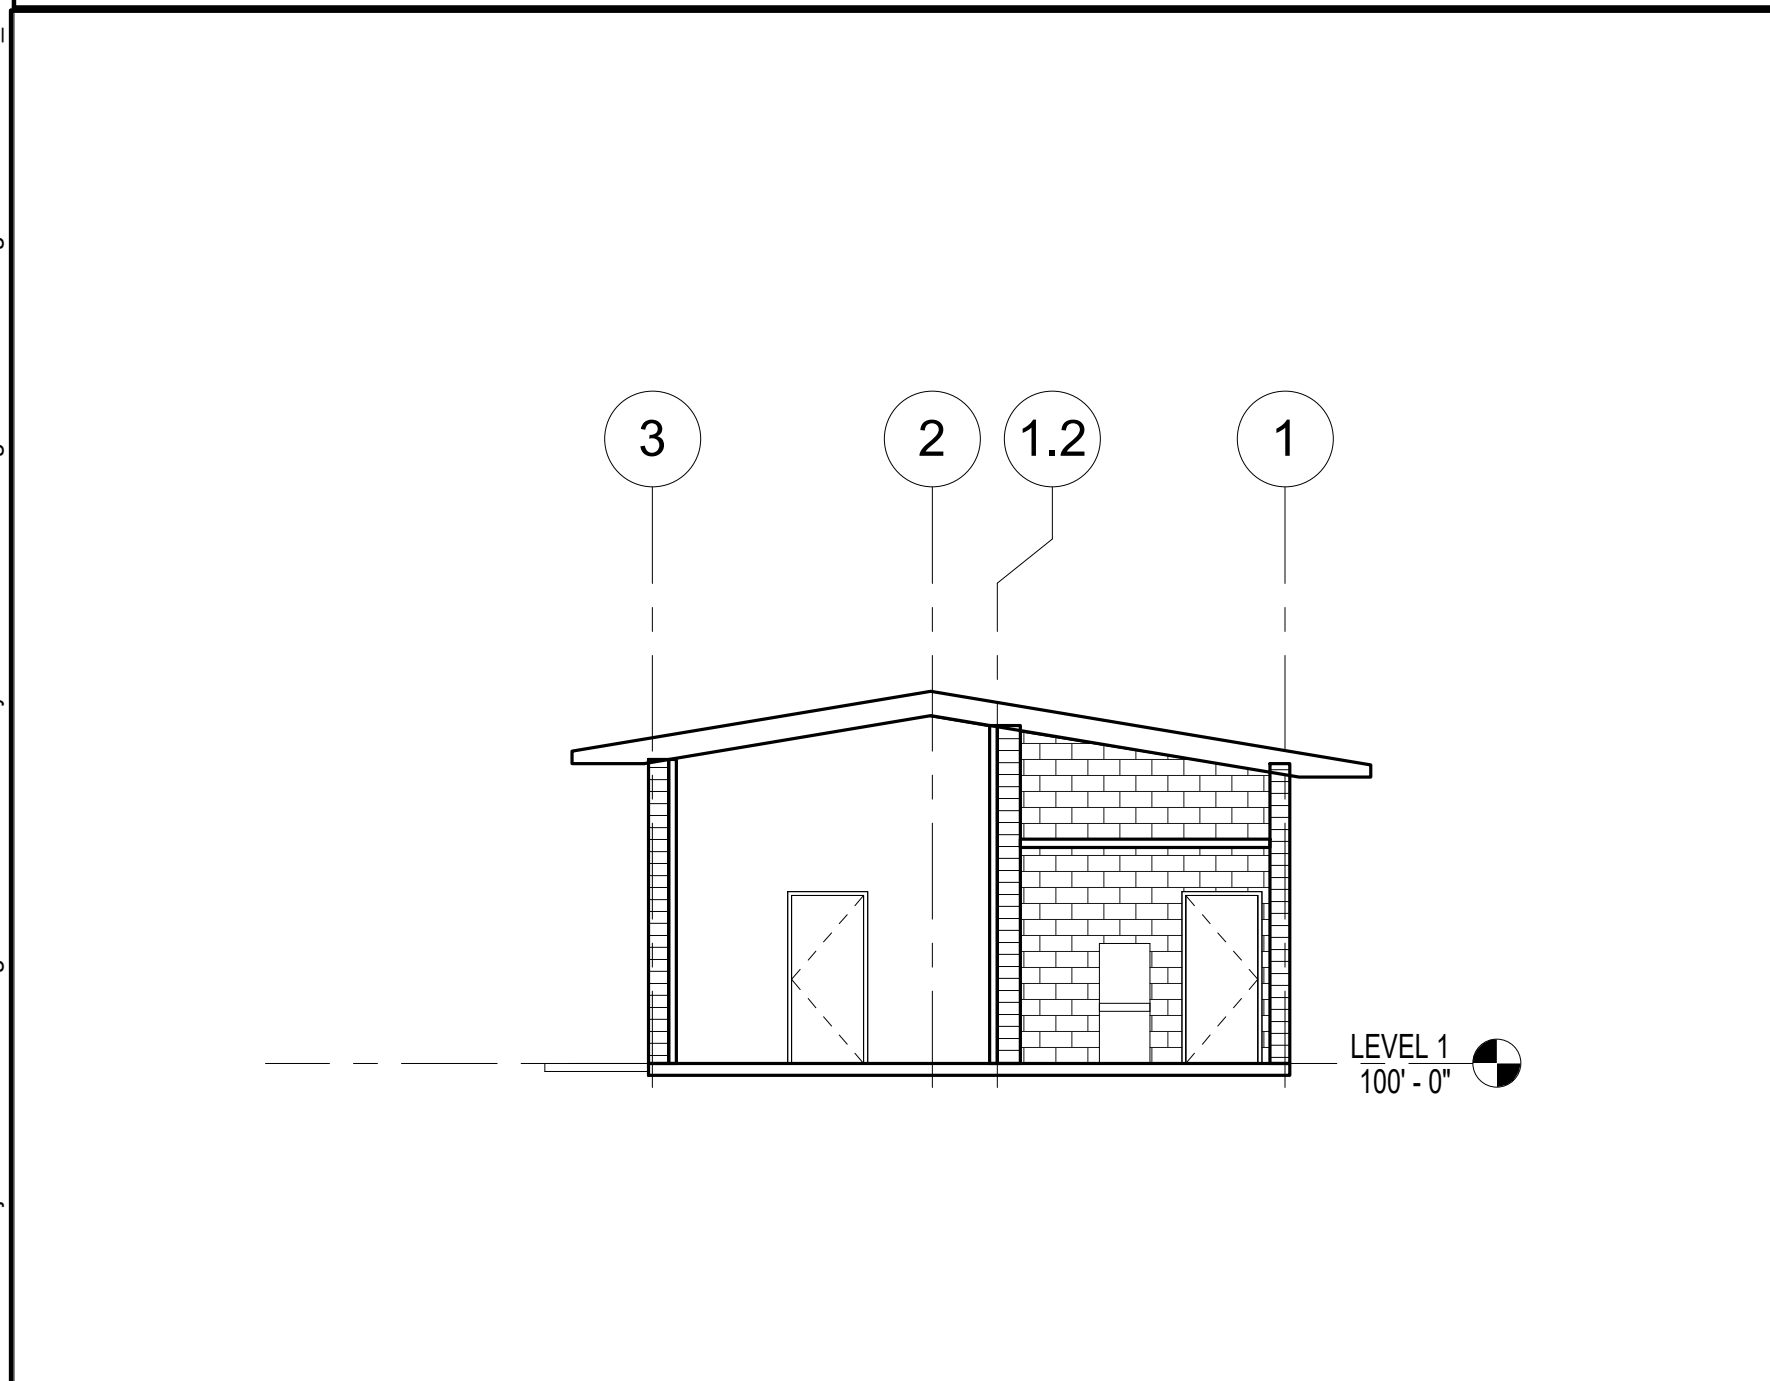


SECTION 6

SCALE	6
1/8" = 1'-0"	

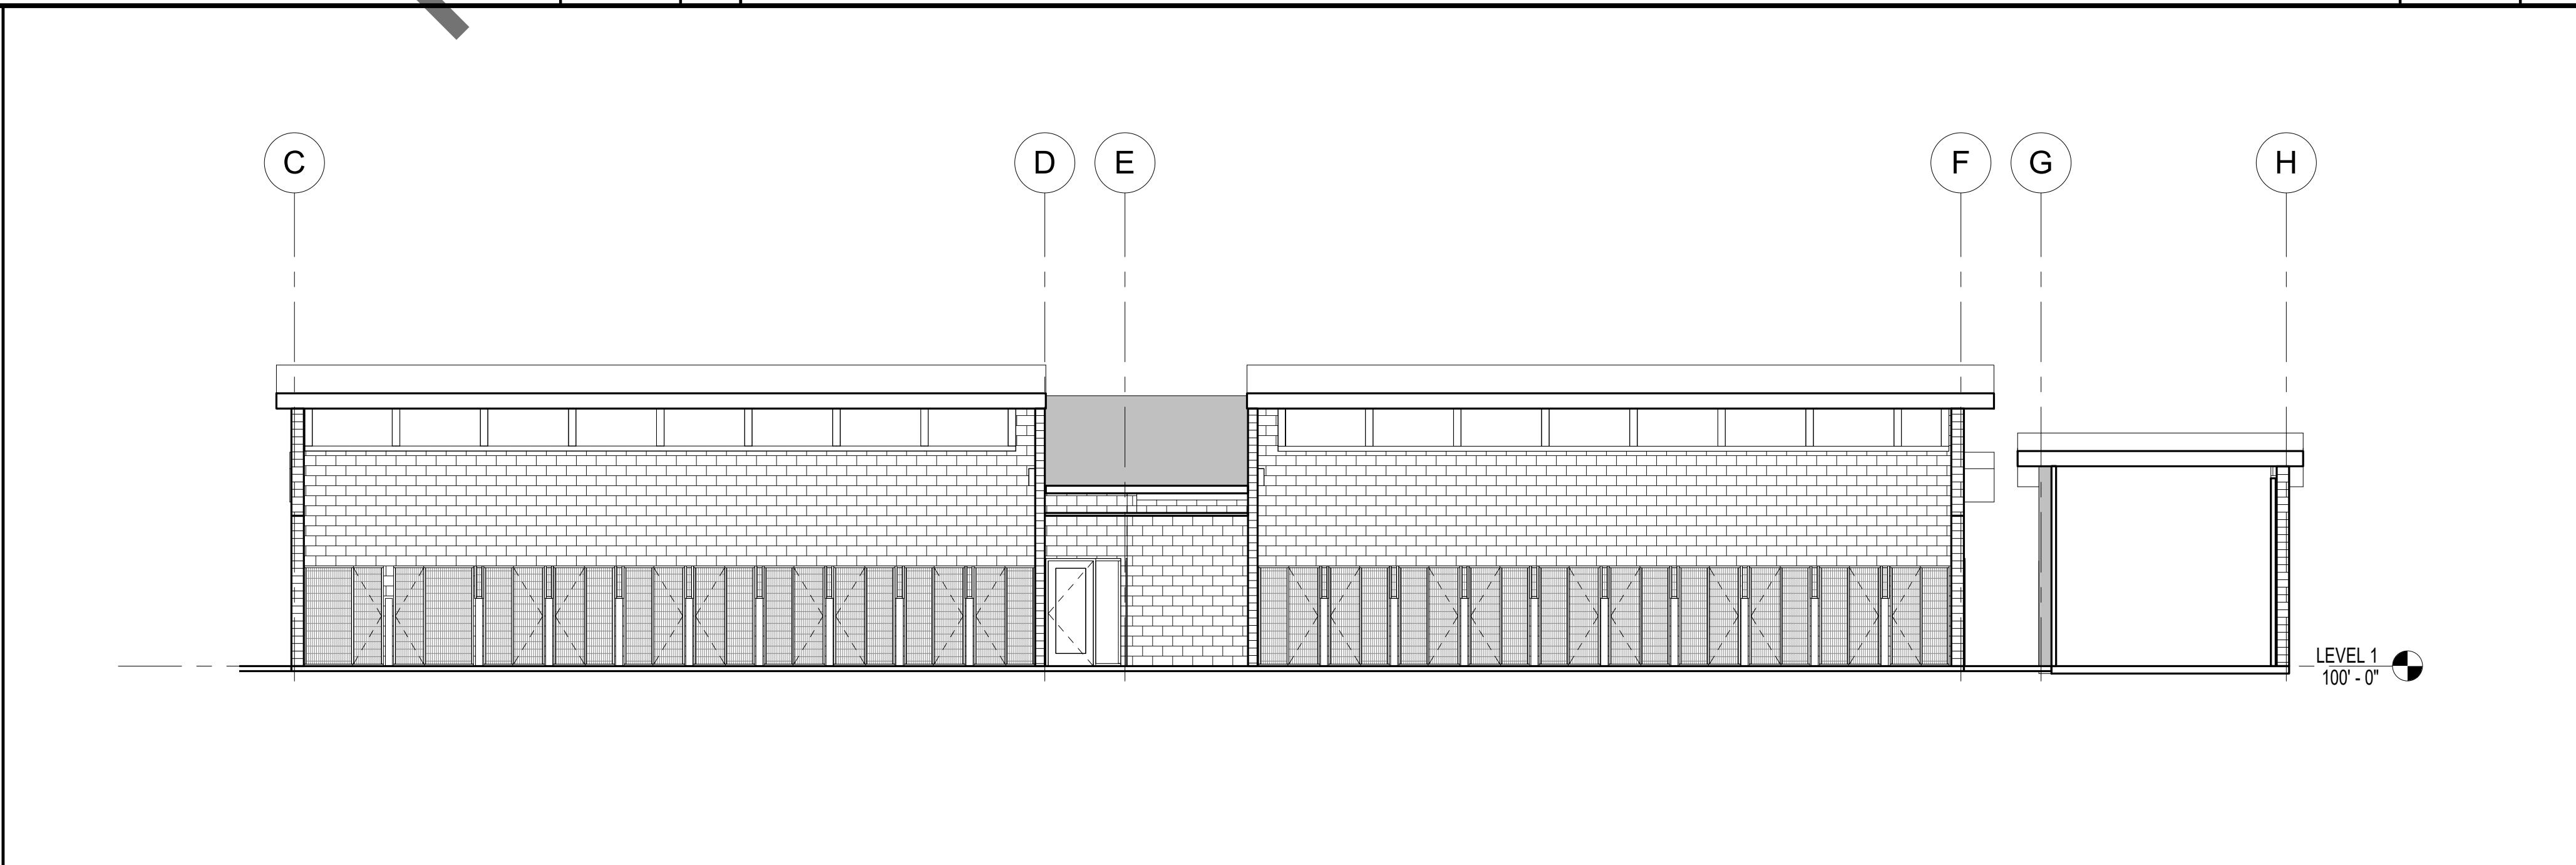

SECTION 5

SCALE	5
1/8" = 1'-0"	

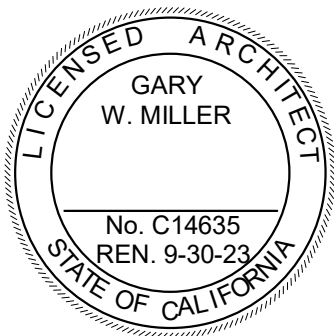

owner approval		
initials	date	phase

REVISIONS/ADDENDA		
#	Date	Comment

ANIMAL CARE CENTER
18313 VALLEY BLVD. BLOOMINGTON, CA 92313
SAN BERNARDINO COUNTY


PROJECT INFORMATION	
Project Number:	1227
Drawn By:	TWS
Checked By:	GWM
Issue Date:	03/22/23

SHEET NAME
**MEDICAL AND
DOG CLINIC
BUILD. SECT.**

SHEET NUMBER
AB 301

DOOR SCHEDULE - STANDARD												
DOOR NUMBER	DOOR TYPE	DOORS				FRAME			CARD READER	HARDWARE SET	REMARKS	
		WIDTH	HEIGHT	MATERIAL	GLASS	ELEV	MATERIAL	GLASS				
1	F1	3'-0"	7'-0"	WOOD			STEEL					
2	F1	3'-0"	7'-0"	WOOD			STEEL					
3	F1	3'-0"	7'-0"	WOOD			STEEL					
4	F1	3'-0"	7'-0"	WOOD			STEEL					
5	F1	3'-0"	7'-0"	WOOD			STEEL					
6	F1	3'-0"	7'-0"	WOOD			STEEL					
7	F2	3'-0"	7'-0"	STEEL			STEEL					
8	F1	3'-0"	7'-0"	WOOD			STEEL					
9	F1	3'-0"	7'-0"	WOOD			STEEL					
10	F1	3'-0"	7'-0"	WOOD			STEEL					
11A	F1	3'-0"	7'-0"	WOOD			STEEL					
11B	F1	3'-0"	7'-0"	WOOD			STEEL					
12	D	2'-9"	8'-0"									
14	F1	3'-0"	7'-0"	WOOD			STEEL					
15	F1	3'-0"	7'-0"	WOOD			STEEL					
16	F1	3'-0"	7'-0"	WOOD			STEEL					
18	F1	3'-0"	7'-0"	WOOD			STEEL					
20	FG2	3'-0"	7'-0"	STEEL			STEEL					
20B	F37	12'-0"	8'-0"									
20C	F37	12'-0"	8'-0"									
20D	F37	12'-0"	8'-0"									
21	FG4	3'-0"	7'-0"	FBG			FBG					
22	FG2	3'-0"	7'-0"	STEEL	YES		STEEL					
23A	FG2	3'-0"	7'-0"	STEEL			STEEL					
23B	F37	12'-0"	8'-0"									
23C	F37	12'-0"	8'-0"									
23D	F37	12'-0"	8'-0"									
23E	FG2	3'-0"	7'-0"	STEEL			STEEL					
24A	FG2	3'-0"	7'-0"	STEEL			STEEL					
24B	FG2	3'-0"	7'-0"	STEEL			STEEL					
25A	FG2	3'-0"	7'-0"	STEEL			STEEL					
25B	FG2	3'-0"	7'-0"	STEEL			STEEL					
26A	FG2	3'-0"	7'-0"	STEEL			STEEL					
26B	F37	12'-0"	8'-0"									
26C	F37	12'-0"	8'-0"									
26D	F37	12'-0"	8'-0"									
26E	FG2	3'-0"	7'-0"	STEEL			STEEL					
27	FG2	3'-0"	7'-0"	STEEL	YES		STEEL					
28A	FG4	3'-0"	7'-0"	FBG			FBG					
29	FG4	3'-0"	7'-0"	FBG			FBG					
30A	FG2	3'-0"	7'-0"	STEEL			STEEL					
30B	FG2	3'-0"	7'-0"	STEEL			STEEL					
31A	FG2	3'-0"	7'-0"	STEEL			STEEL					
31B	FG2	3'-0"	7'-0"	STEEL			STEEL					
32A	FG2	3'-0"	7'-0"	STEEL			STEEL					
32B	F37	12'-0"	8'-0"									
32C	F37	12'-0"	8'-0"									
32D	F37	12'-0"	8'-0"									
40	F2	3'-0"	7'-0"	STEEL			STEEL					
41	F2	3'-0"	7'-0"	STEEL			STEEL					


WINDOW SCHEDULE														
TYPE	COUNT	HEIGHT	WIDTH	HEAD HEIGHT	SILL HEIGHT	FIRE RATING (MIN)	STC RATING	MATERIAL	HEAD	JAMB	SILL	WINDOW AREA	NOTES	
13	8	6'-0"	4'-0"	8'-0"	2'-0"							24 SF		
23	6	3'-0"	<varies>	6'-0"	3'-0"							<varies>		
M-2	11	4'-0"	4'-0"	7'-0"	3'-0"							16 SF		
Grand total: 25		25												

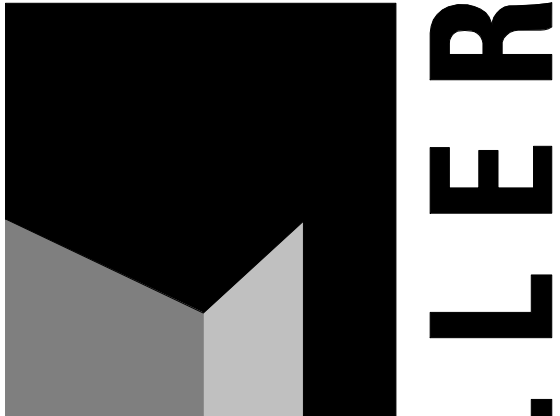

architecture
interiors
planning

MILLER

1177 Idaho Street, Suite 200
Redlands, CA 92374
Phone: 909-335-7400
Fax: 909-335-7299
info@miller-aip.com

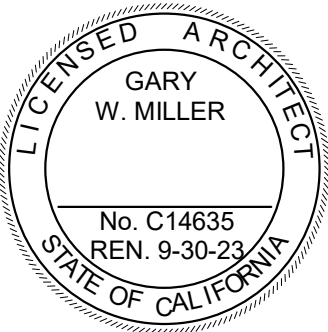

owner approval

initials	date	phase

REVISIONS/ADDENDA

#	Date	Comment
---	------	---------

ANIMAL CARE CENTER

18313 VALLEY BLVD. BLOOMINGTON, CA 92313

SAN BERNARDINO COUNTY

PROJECT INFORMATION


Project Number:	1227
Drawn By:	Author
Checked By:	GWM
Issue Date:	03/22/23

SHEET NAME

DOOR &
WINDOW
SCHEDULES

SHEET NUMBER

 AB 601



CAT REFLECTED CEILING PLAN

SCALE

2 FLOOR PLAN - CAT AND OTHER ANIMALS BUILDING

GENERAL REFLECTED CEILING PLAN NOTES:

1. QUANTITIES LISTED ON THESE DOCUMENTS ARE FOR AGENCY APPROVAL ONLY. THE CONTRACTOR IS RESPONSIBLE FOR VERIFYING ALL QUANTITIES FOR BIDDING PURPOSES.
2. ALL NEW WORK SHALL CONFORM TO CURRENT BUILDING STANDARDS, UNLESS NOTED OTHERWISE.
3. CONTRACTOR TO VERIFY EXISTING CONSTRUCTION WITHIN THE SCOPE OF WORK TO ENSURE CONFORMANCE WITH NOTED RATINGS AND LOCAL CODES. RETROFIT NON-CONFORMING CONSTRUCTION AS REQUIRED.
4. SUSPENSION SYSTEM TO BE "PRELUDE XL" AS MANUFACTURED BY ARMSTRONG WORLD INDUSTRIES, INC. OR EQUAL AS APPROVED BY ARCHITECT.
5. PERIODIC INSPECTION OF THE CEILING SUSPENSION SYSTEM SHALL BE PROVIDED IN ACCORDANCE WITH MANUFACTURER'S REQUIREMENTS FOR SPECIFIED COMPONENTS AND CEILING ANCHORAGE SYSTEM.
6. REFER TO MECHANICAL, ELECTRICAL, AND PLUMBING DRAWINGS FOR ADDITIONAL SCOPE.

REFLECTED CEILING LEGEND:

- | | |
|---|---|
|  | 2x4 ACT SUSPENDED CEILING |
|  | GYPSUM BOARD CEILING |
|  | FIBER CEMENT BOARD CEILING |
|  | RECESSED LIGHT FIXTURE. SEE ELECTRICAL |
|  | PENDANT LIGHT FIXTURE. SEE ELECTRICAL |
|  | RECESSED LIGHT FIXTURE. SEE ELECTRICAL |
|  | SURFACE MOUNTED LIGHT FIXTURE. SEE ELECTRICAL |
|  | EXIT SIGN. SEE ELECTRICAL DRAWINGS. |
|  | EXHAUST. SEE ELECTRICAL DRAWINGS. |
|  | SUPPLY / RETURN GRILLE. SEE MECHANICAL |
|  | CEILING HEIGHT |

 
GENERAL - RCP NOTES

SCALE
12" = 1'-0"

CEILING LEGEND

SCALE
1/8" = 1'-0"

GENERAL - FLOOR PLAN NOTES



FLOOR PLAN - CAT AND OTHER ANIMALS BUILDING

GENERAL FLOOR PLAN NOTES:

1. QUANTITIES LISTED ON THESE DOCUMENTS ARE FOR AGENCY APPROVAL ONLY. THE CONTRACTOR IS RESPONSIBLE FOR VERIFYING ALL QUANTITIES FOR BIDDING PURPOSES.
2. ALL NEW WORK SHALL CONFORM TO CURRENT BUILDING STANDARDS, UNLESS NOTED OTHERWISE.
3. CONTRACTOR TO VERIFY EXISTING CONSTRUCTION WITHIN THE SCOPE OF WORK TO ENSURE CONFORMANCE WITH NOTED RATINGS AND LOCAL CODES RETROFIT NON-CONFORMING CONSTRUCTION AS REQUIRED.
4. FINISH: PREPARE SUB-FLOOR AND LEAVE IN BROOM CLEAN CONDITION TO RECEIVE NEW FINISH AS REQUIRED. FLOOR SHALL BE LEVEL AND FREE OF DIPS, DIMPLES AND JOINTS.
5. REFER TO MECHANICAL, ELECTRICAL, AND PLUMBING DRAWINGS FOR ADDITIONAL SCOPE.

KEYNOTES

Key Value	Keynote Text
-----------	--------------

The logo for Miller Architecture Interiors Planning. It features a square graphic on the left composed of three geometric shapes: a large black triangle at the top, a medium gray trapezoid at the bottom left, and a light gray trapezoid at the bottom right. To the right of the graphic, the word "MILLER" is written vertically in a large, bold, black, sans-serif font. Below the graphic, the words "architecture", "interiors", and "planning" are stacked horizontally in a smaller, bold, black, sans-serif font.

**1177 Idaho Street, Suite 200
Redlands, CA 92374
Phone: 909-335-7400
Fax: 909-335-7299
info@miller-aip.com**



owner approval

initials	date	phase

REVISIONS/ADDENDA

#	Date	Comment
---	------	---------

ANIMAL CARE CENTER

18313 VALLEY BLVD. BLOOMINGTON, CA 92313

SAN BERNARDINO COUNTY

PROJECT INFORMATION

Project Number: 1227
 Drawn By: PF
 Checked By: GWM
 Issue Date: 05/08/23


SHEET NAME


BUILDING D
FLOOR PLAN &
RCP

SHEET NUMBER

AD101


Sheet Of Sheets

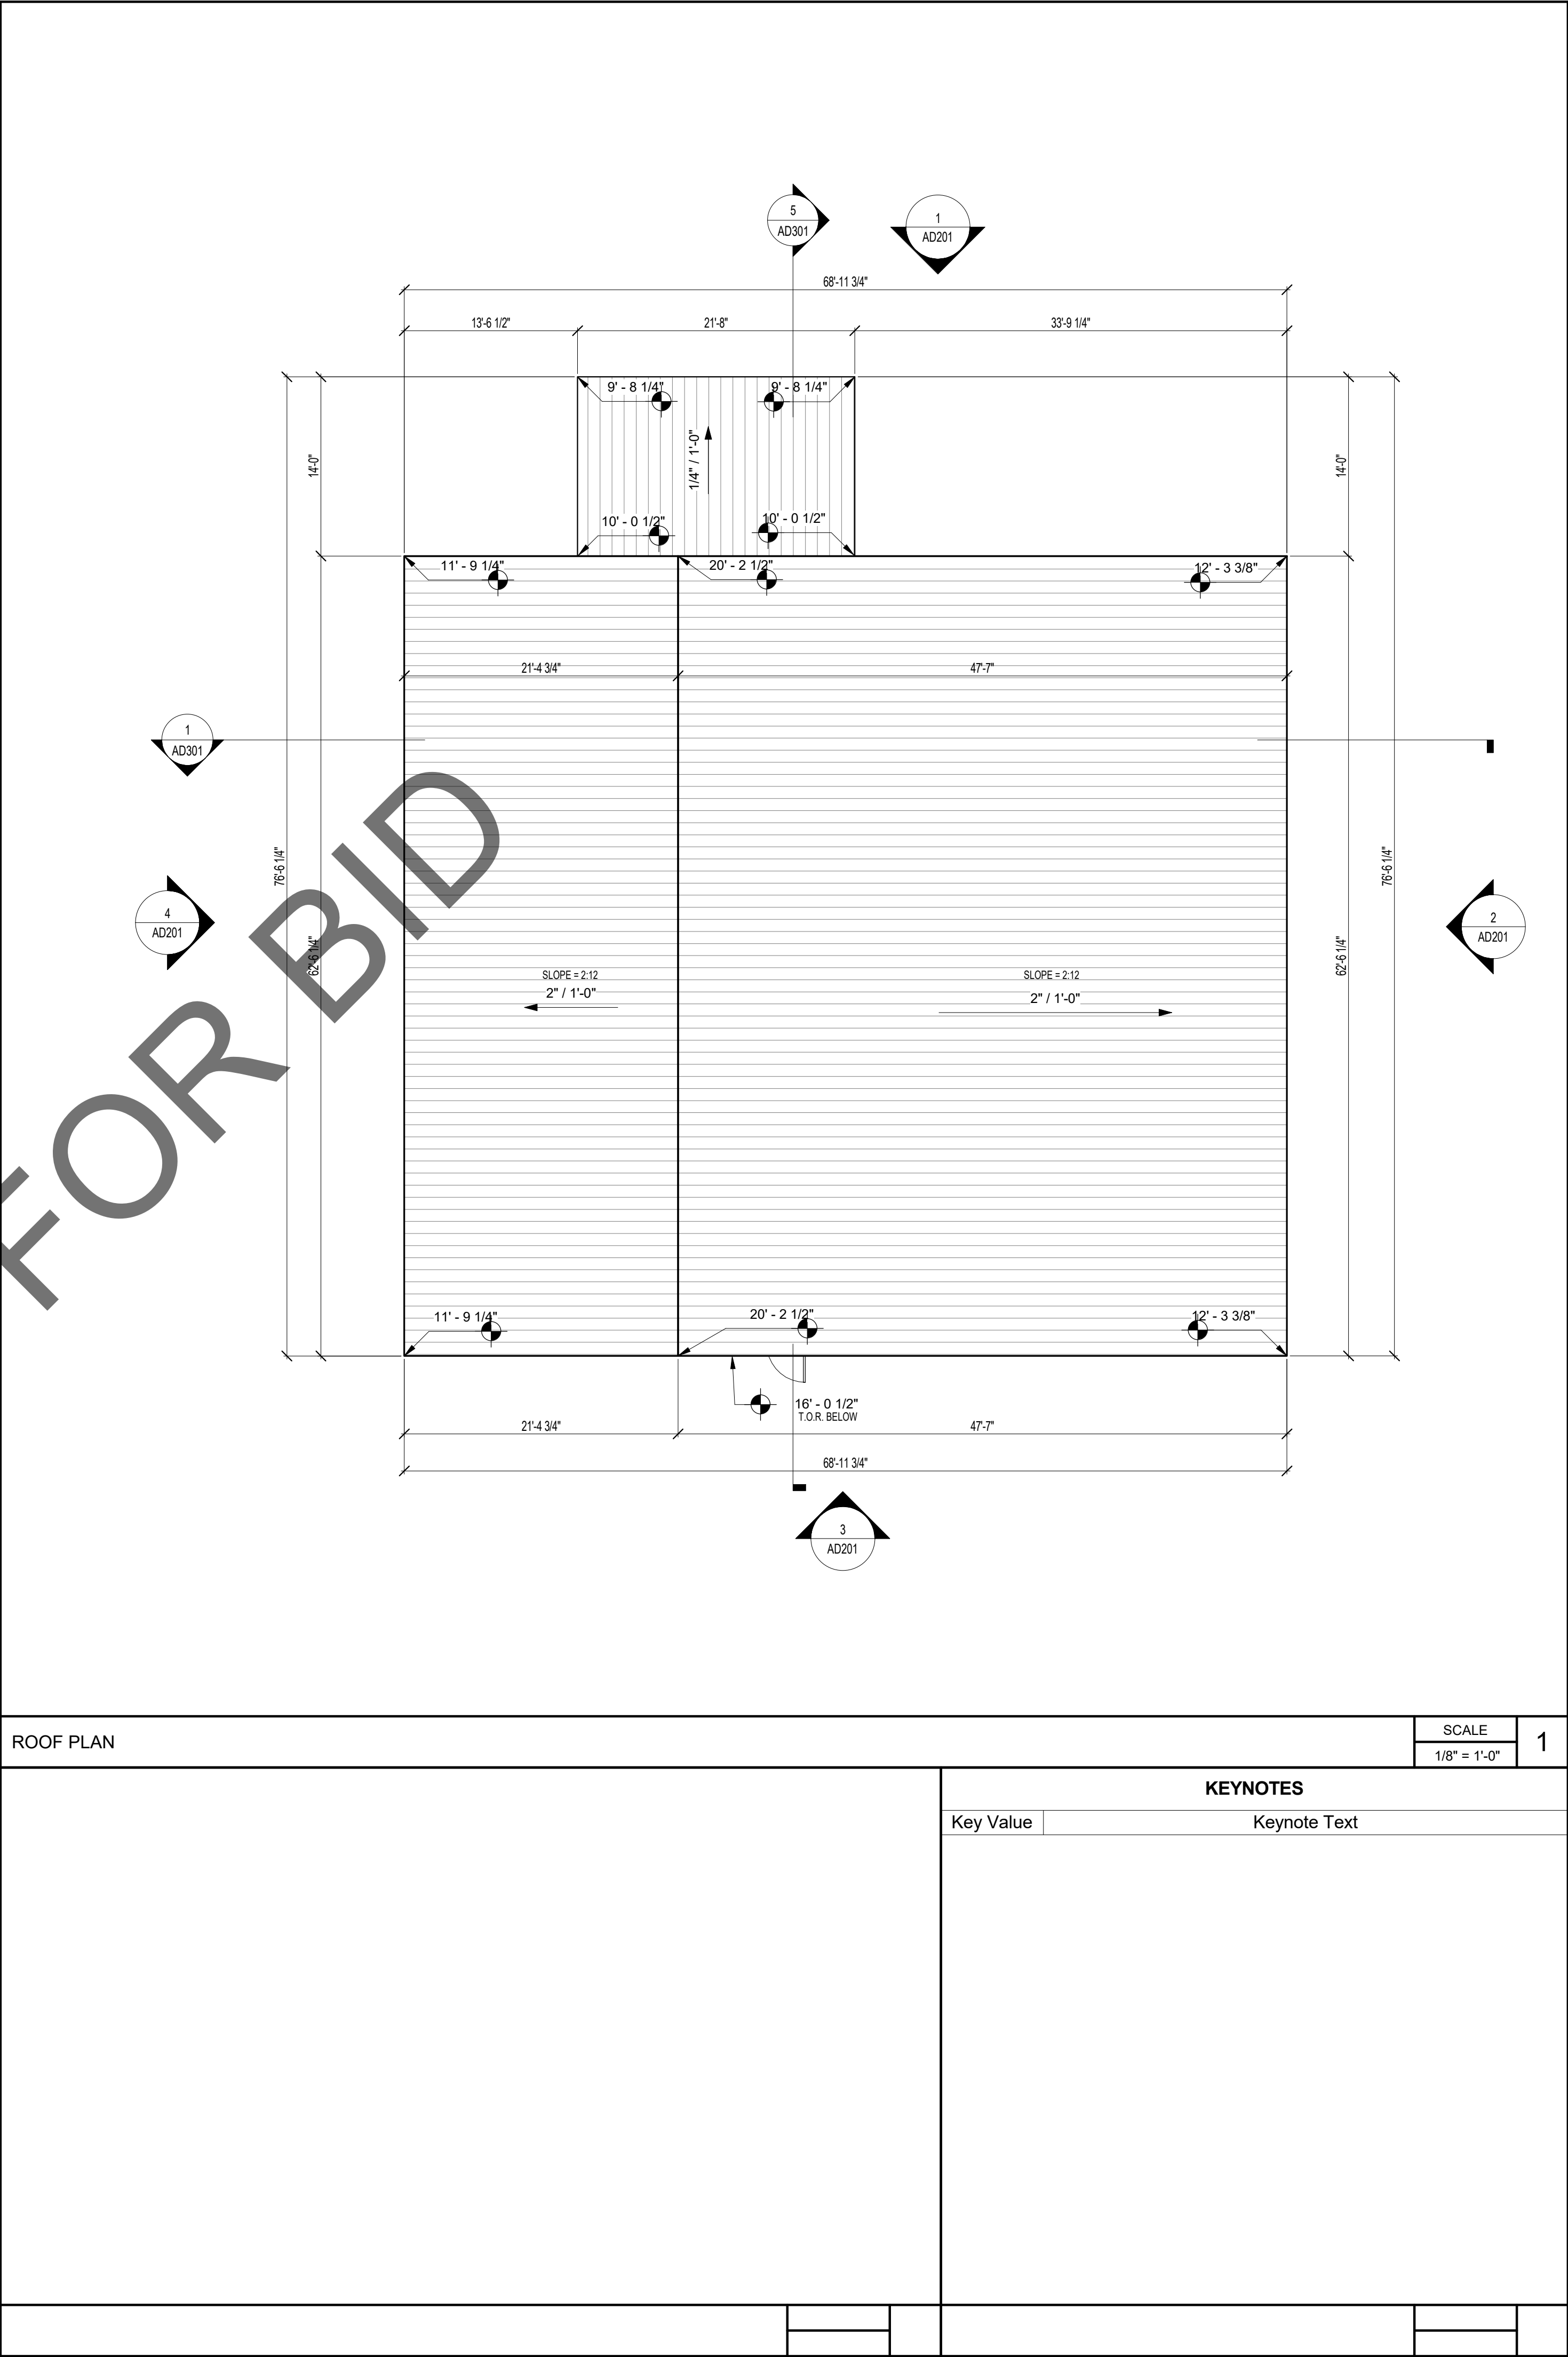

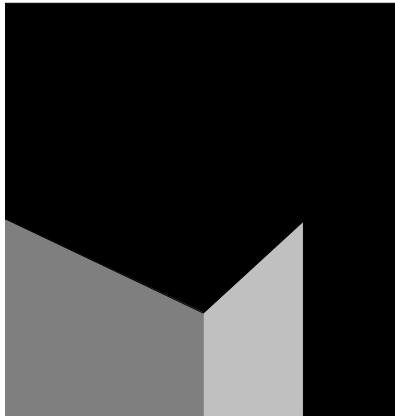

architecture
interiors
planning

1177 Idaho Street, Suite 200
Redlands, CA 92374
Phone: 909-335-7400
Fax: 909-335-7299
info@miller-aip.com

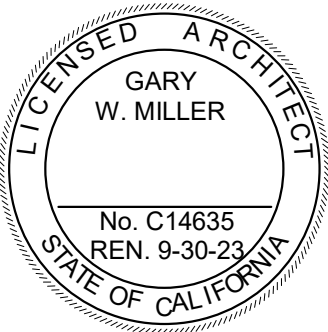

"Shelter Planners
of America"

owner approval

initials	date	phase

REVISIONS/ADDENDA

#	Date	Comment

ANIMAL CARE CENTER

18313 VALLEY BLVD. BLOOMINGTON, CA 92313

SAN BERNARDINO COUNTY

PROJECT INFORMATION

Project Number: 1227
Drawn By: Author
Checked By: GWM
Issue Date: 05/08/23

SHEET NAME

CAT AND
OTHER ROOF
PLAN





SHEET NUMBER

AD105

Sheet

Of


Sheets

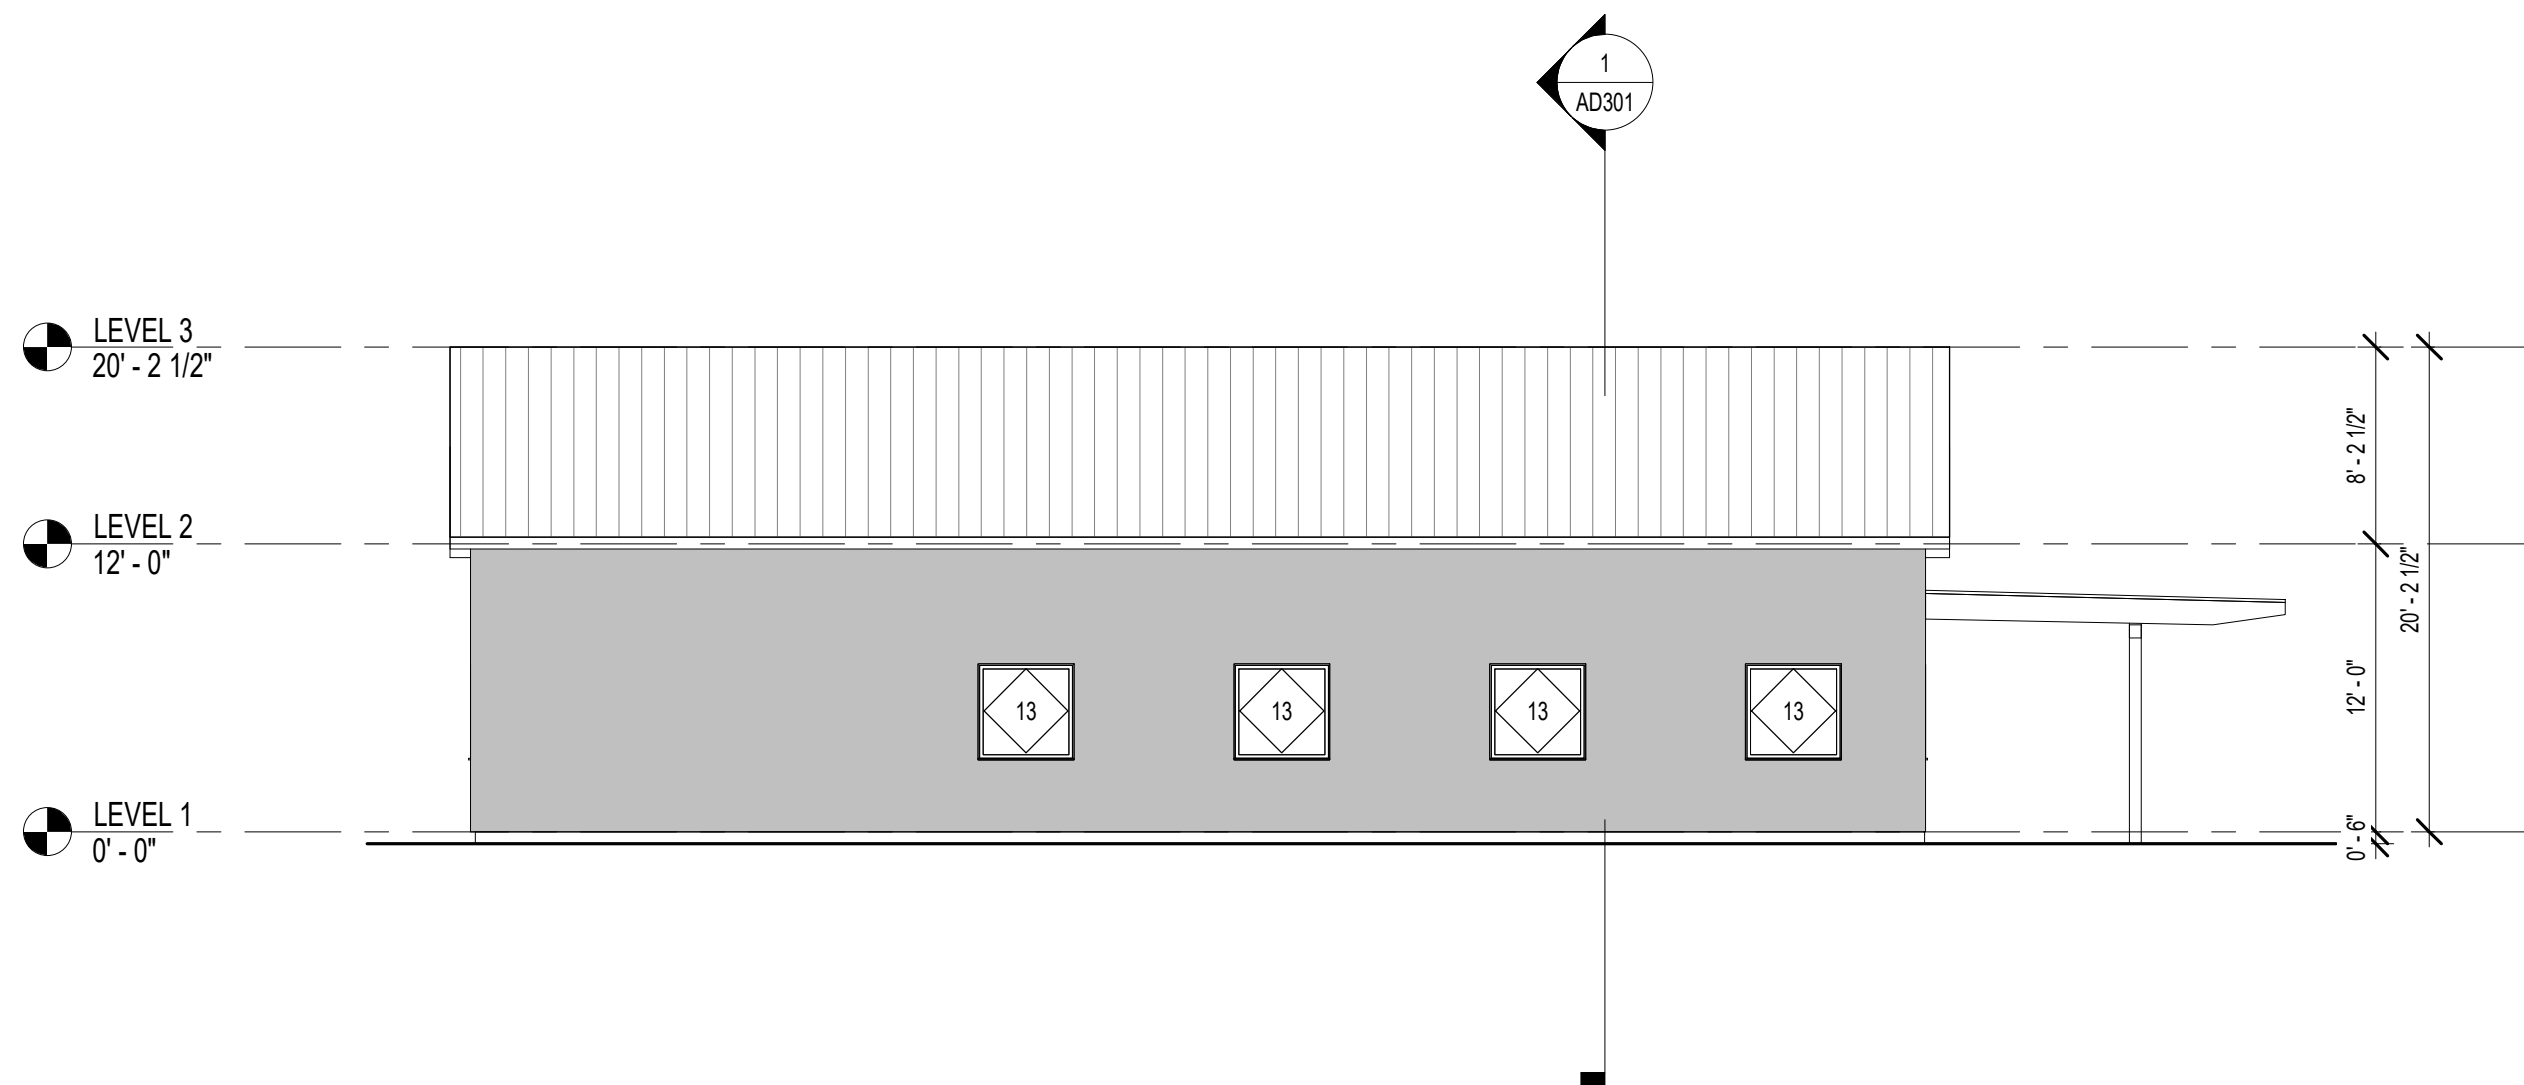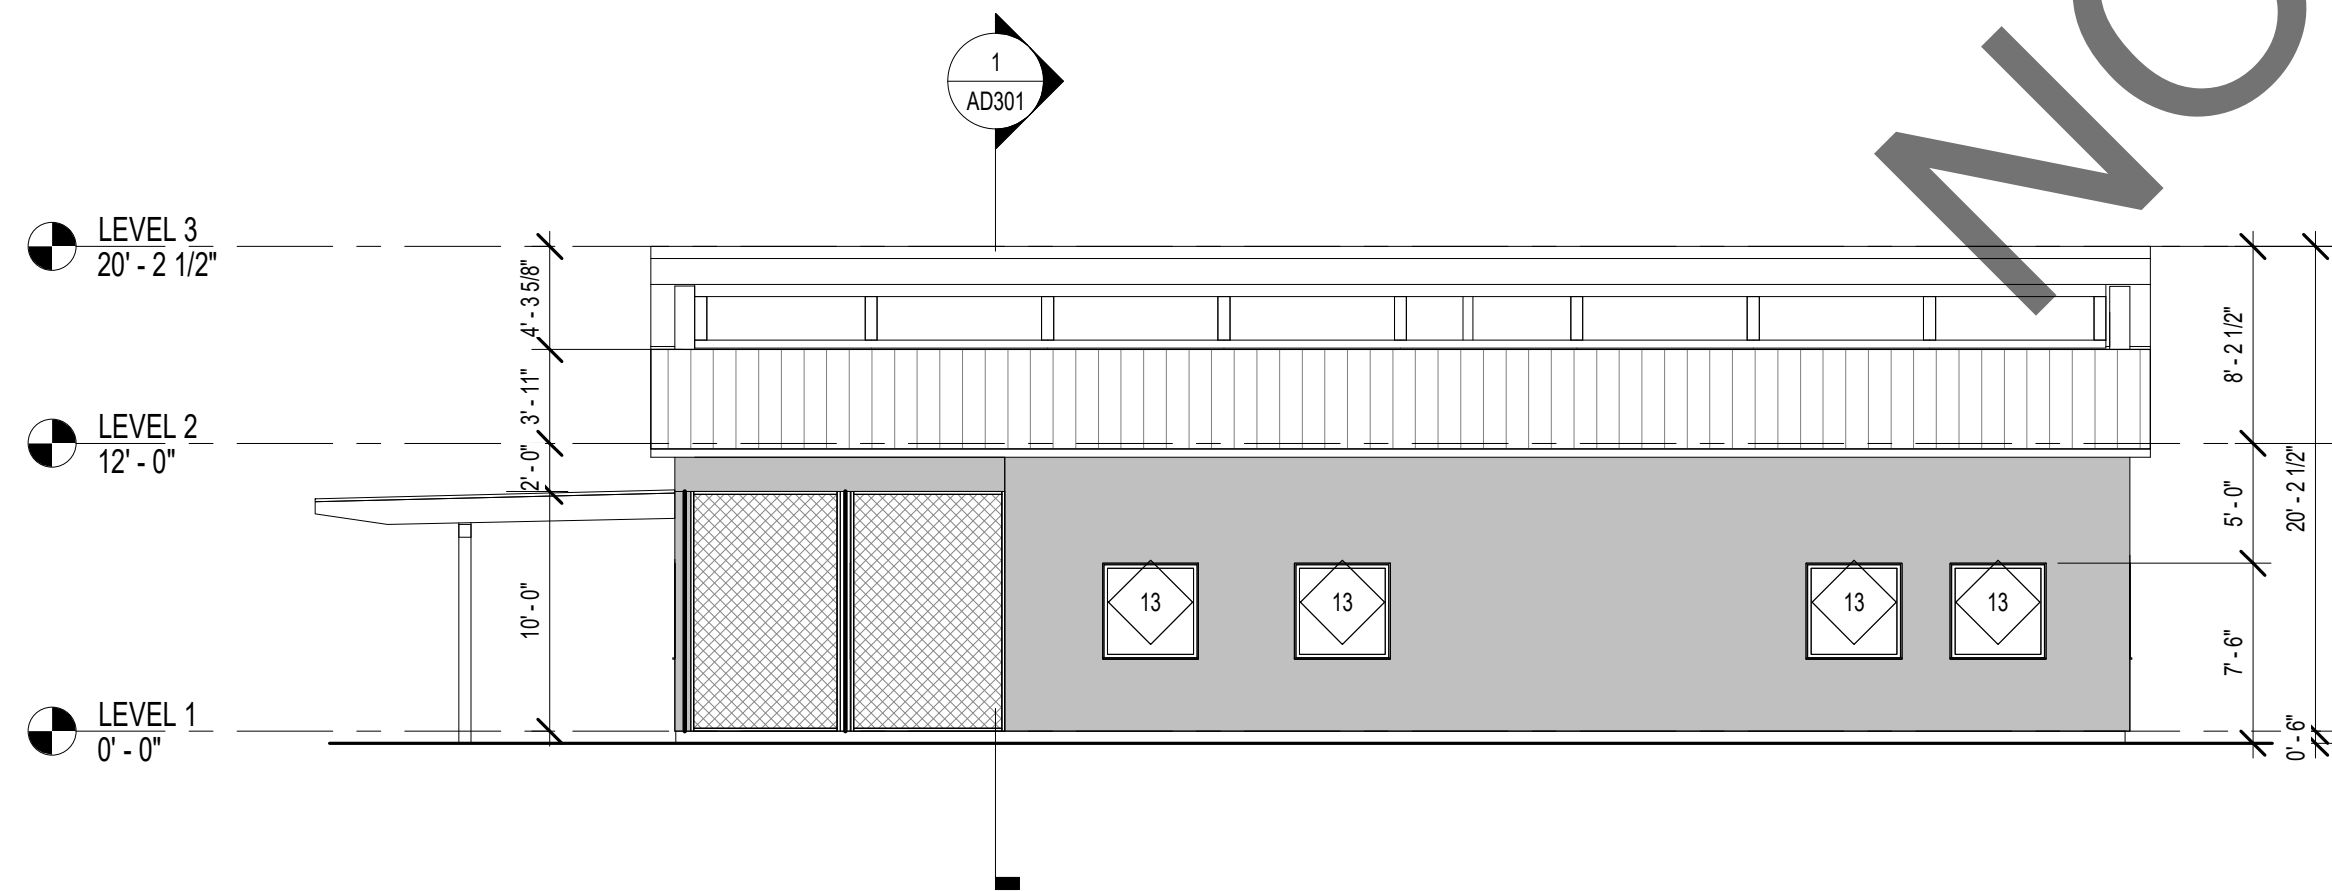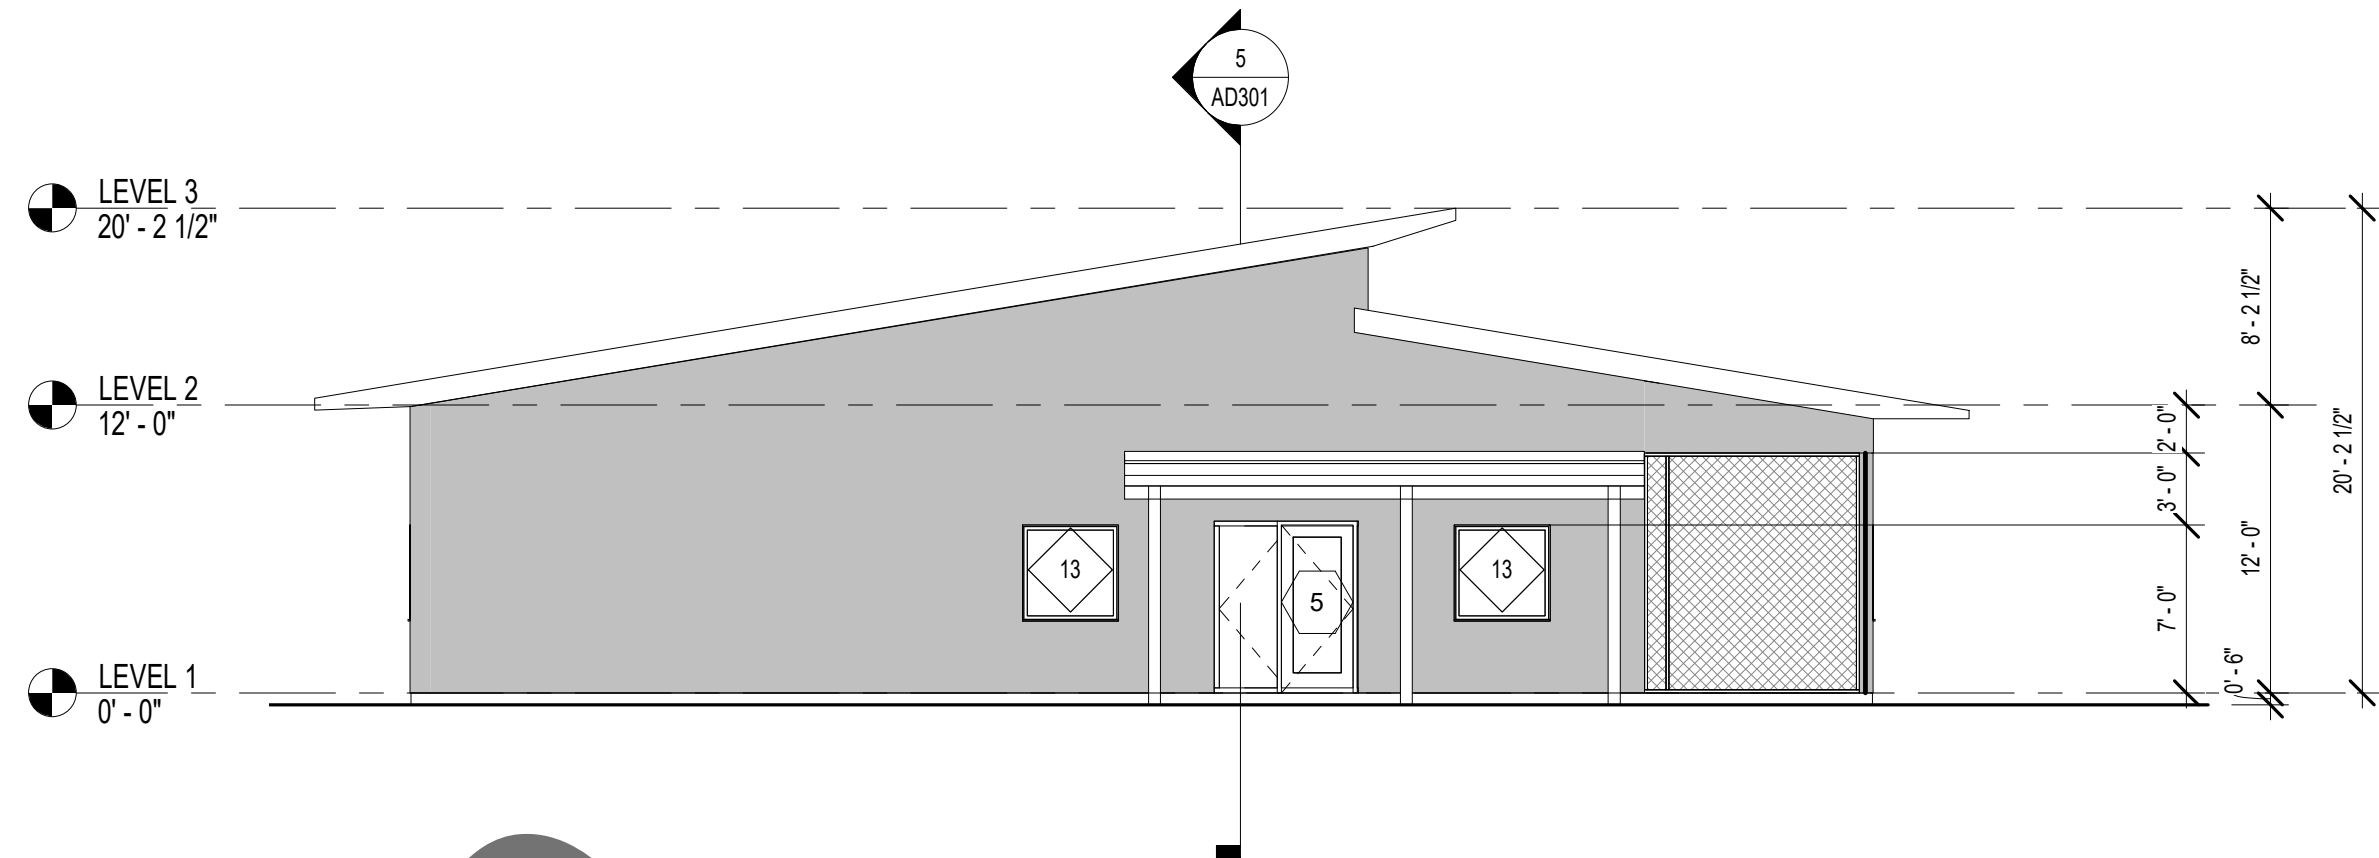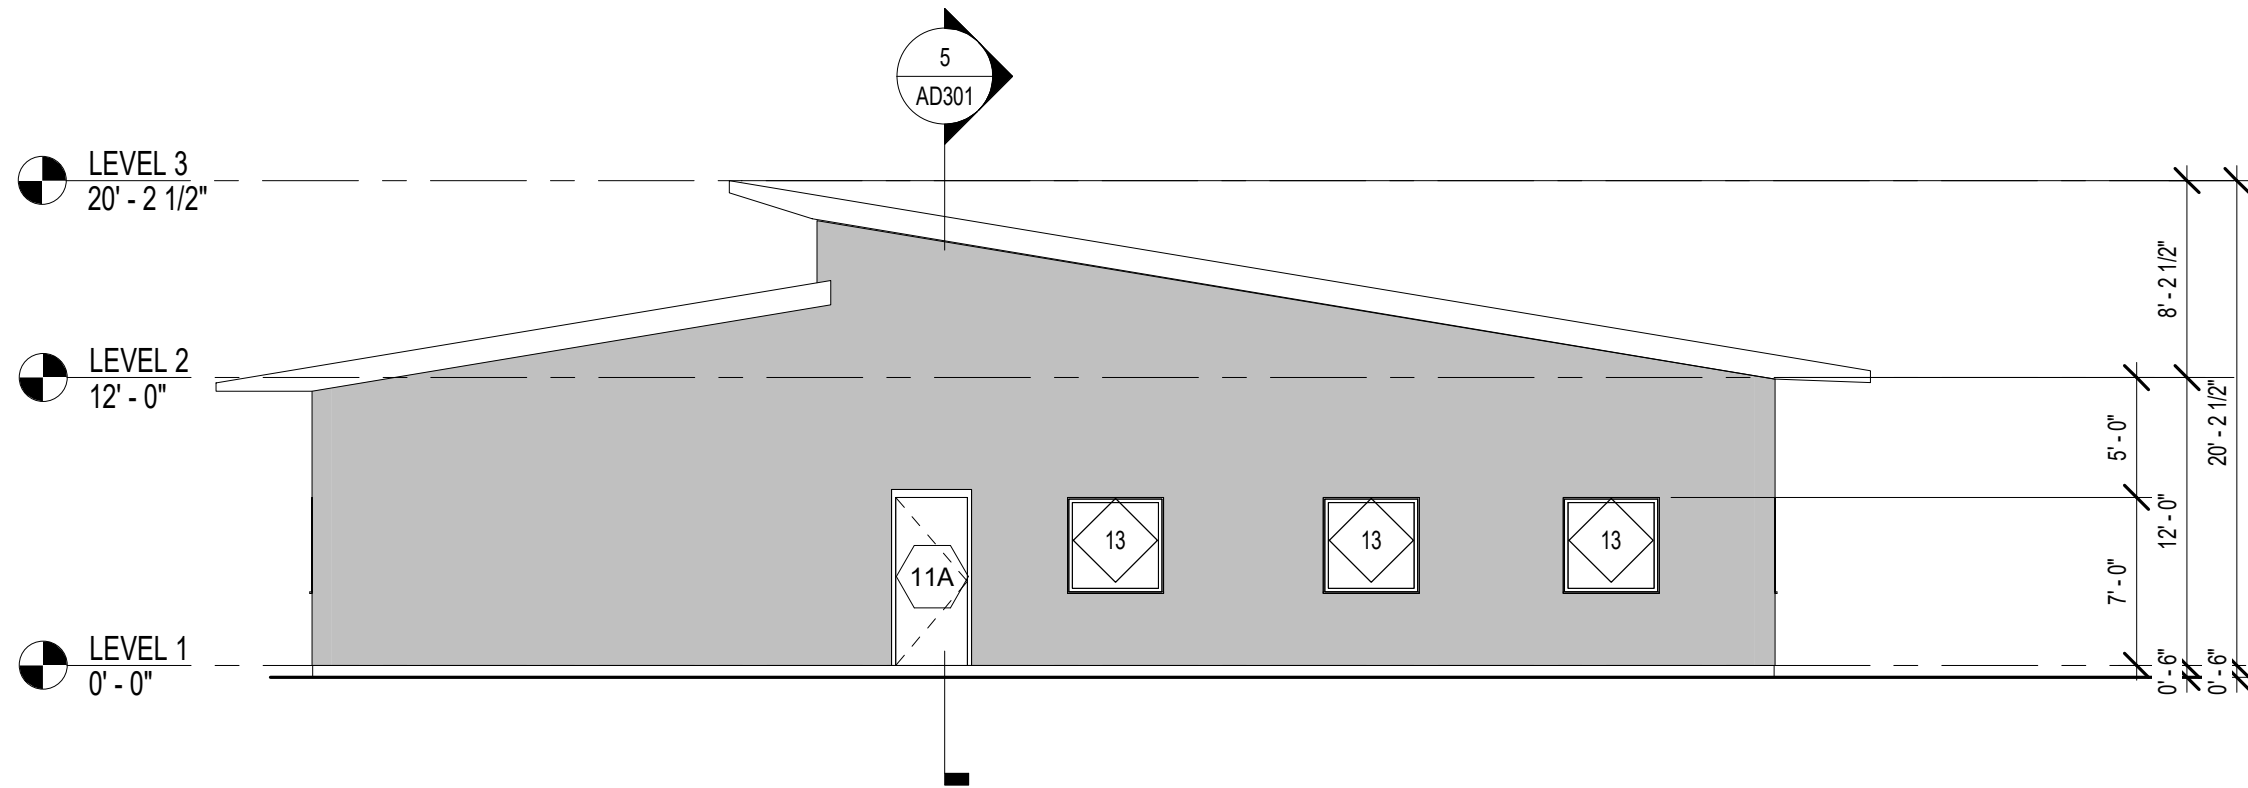

architecture
interiors
planning

MILLER

1177 Idaho Street, Suite 200
Redlands, CA 92374
Phone: 909-335-7400
Fax: 909-335-7299
info@miller-aip.com

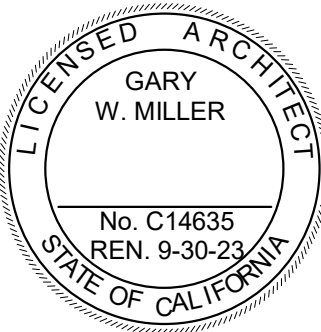

owner approval

initials	date	phase

REVISIONS/ADDENDA

#	Date	Comment
---	------	---------

ANIMAL CARE CENTER

18313 VALLEY BLVD. BLOOMINGTON, CA 92313

SAN BERNARDINO COUNTY

PROJECT INFORMATION

Project Number:	1227
Drawn By:	PF
Checked By:	GWM
Issue Date:	05/08/23






SHEET NAME

BUILDING D
EXTERIOR
ELEVATIONS

SHEET NUMBER

AD201


Sheet Of Sheets

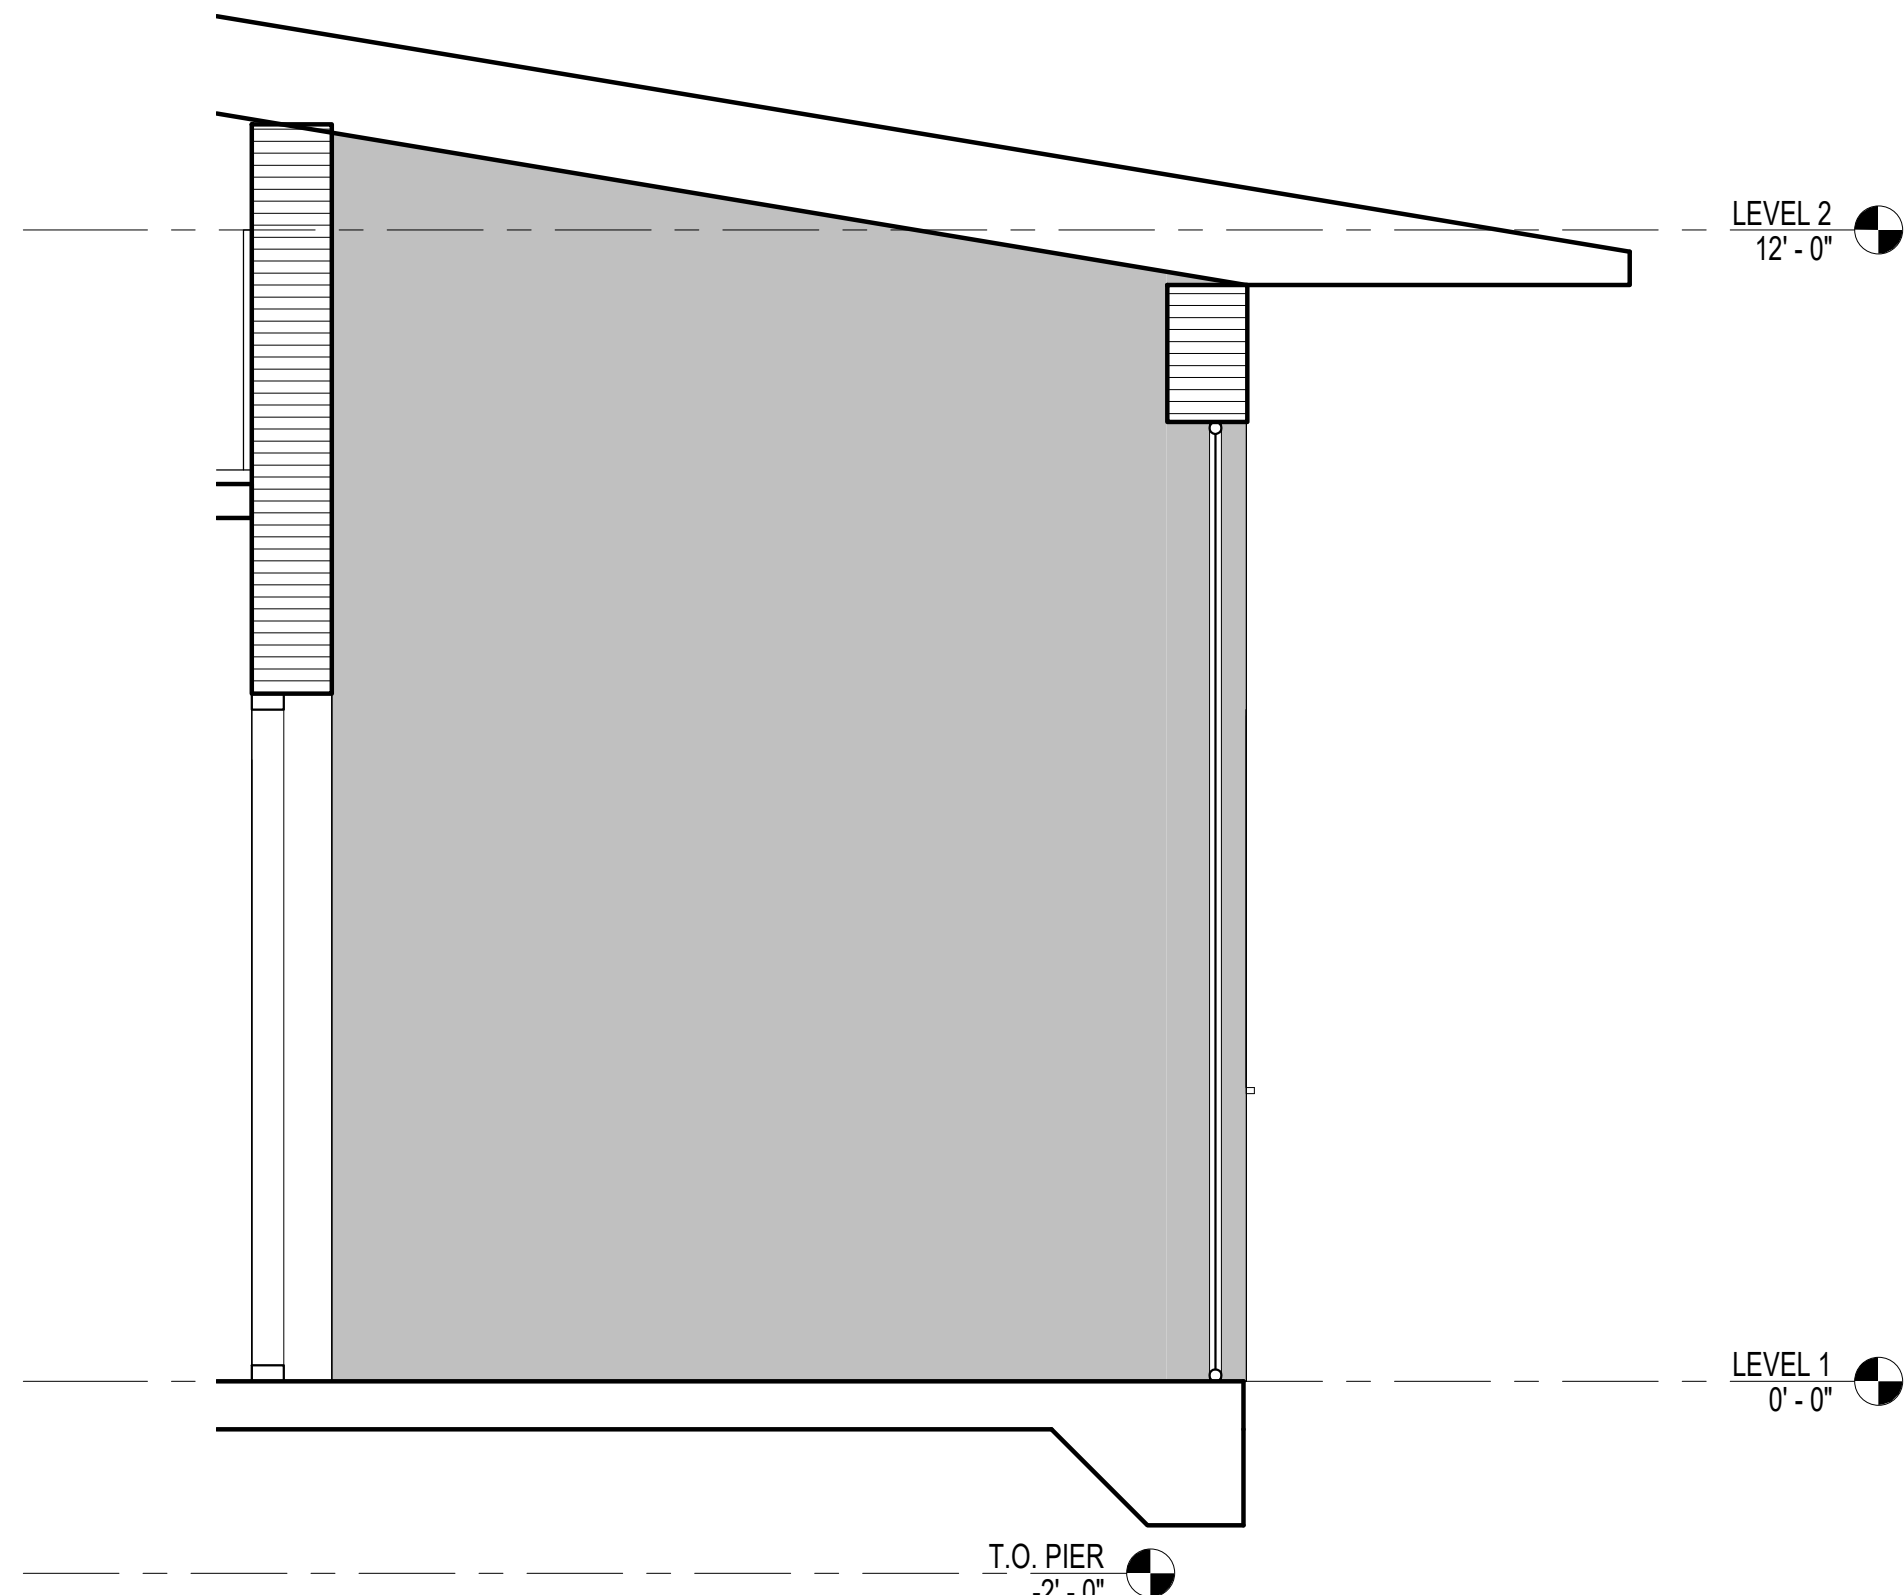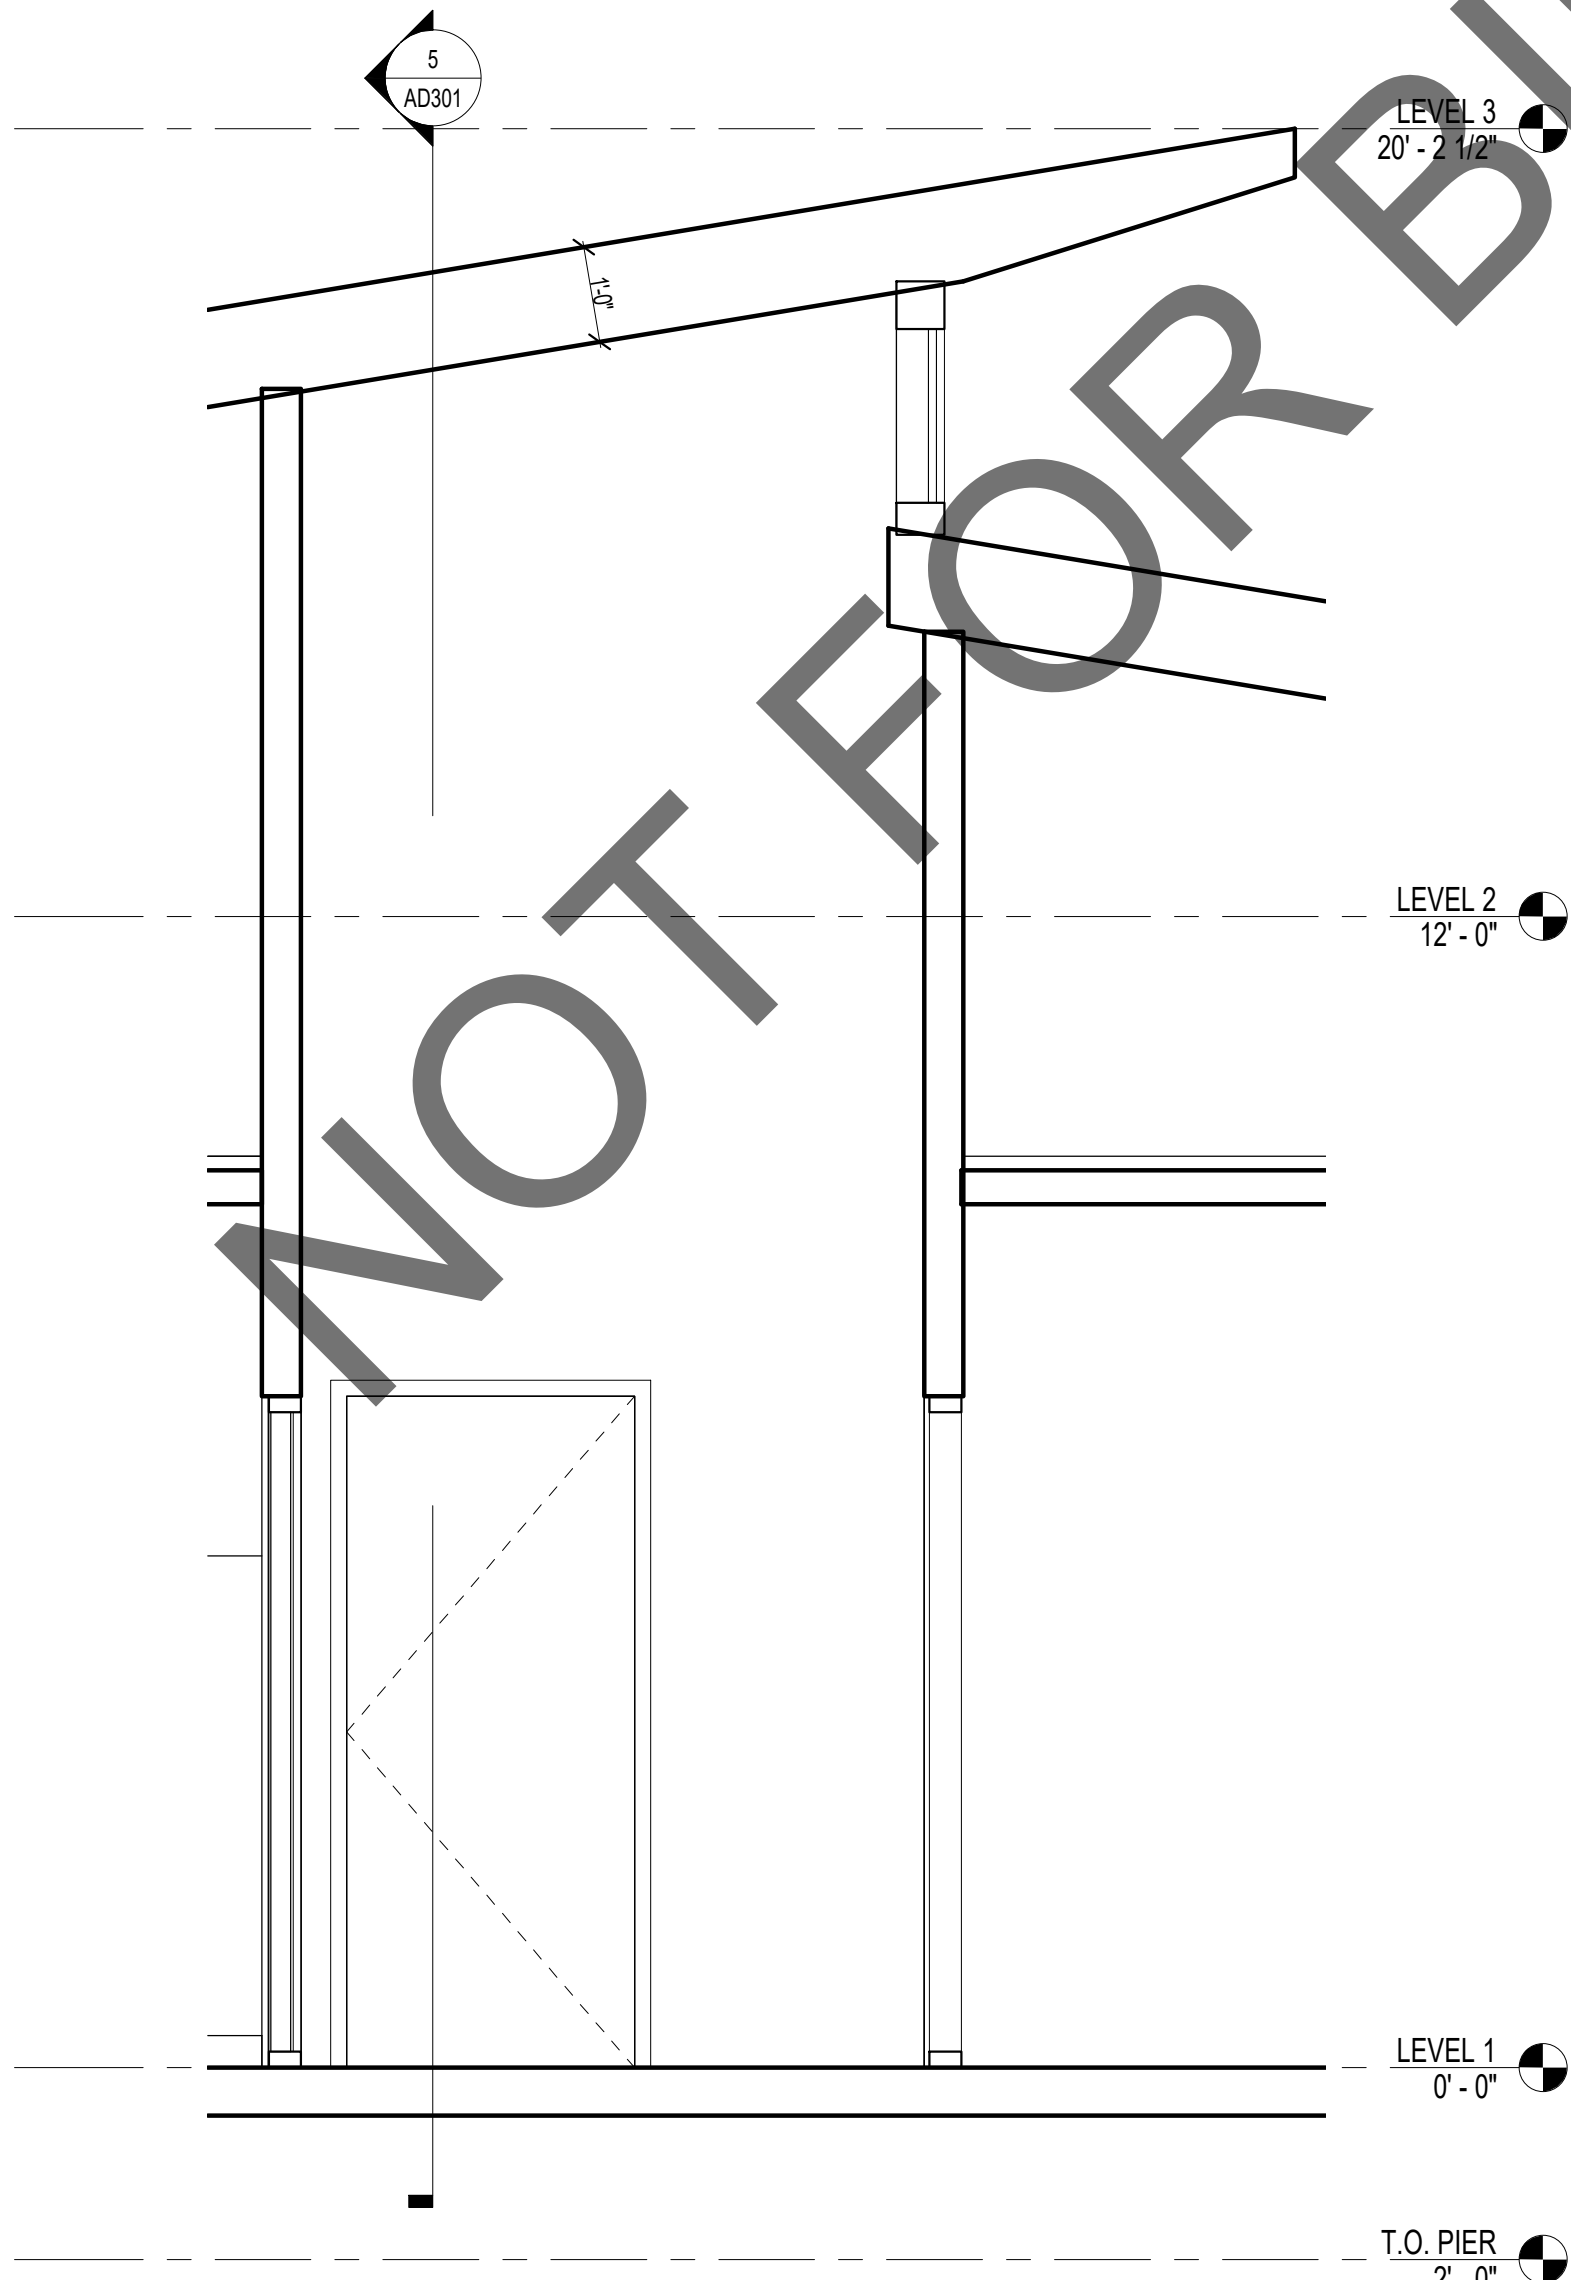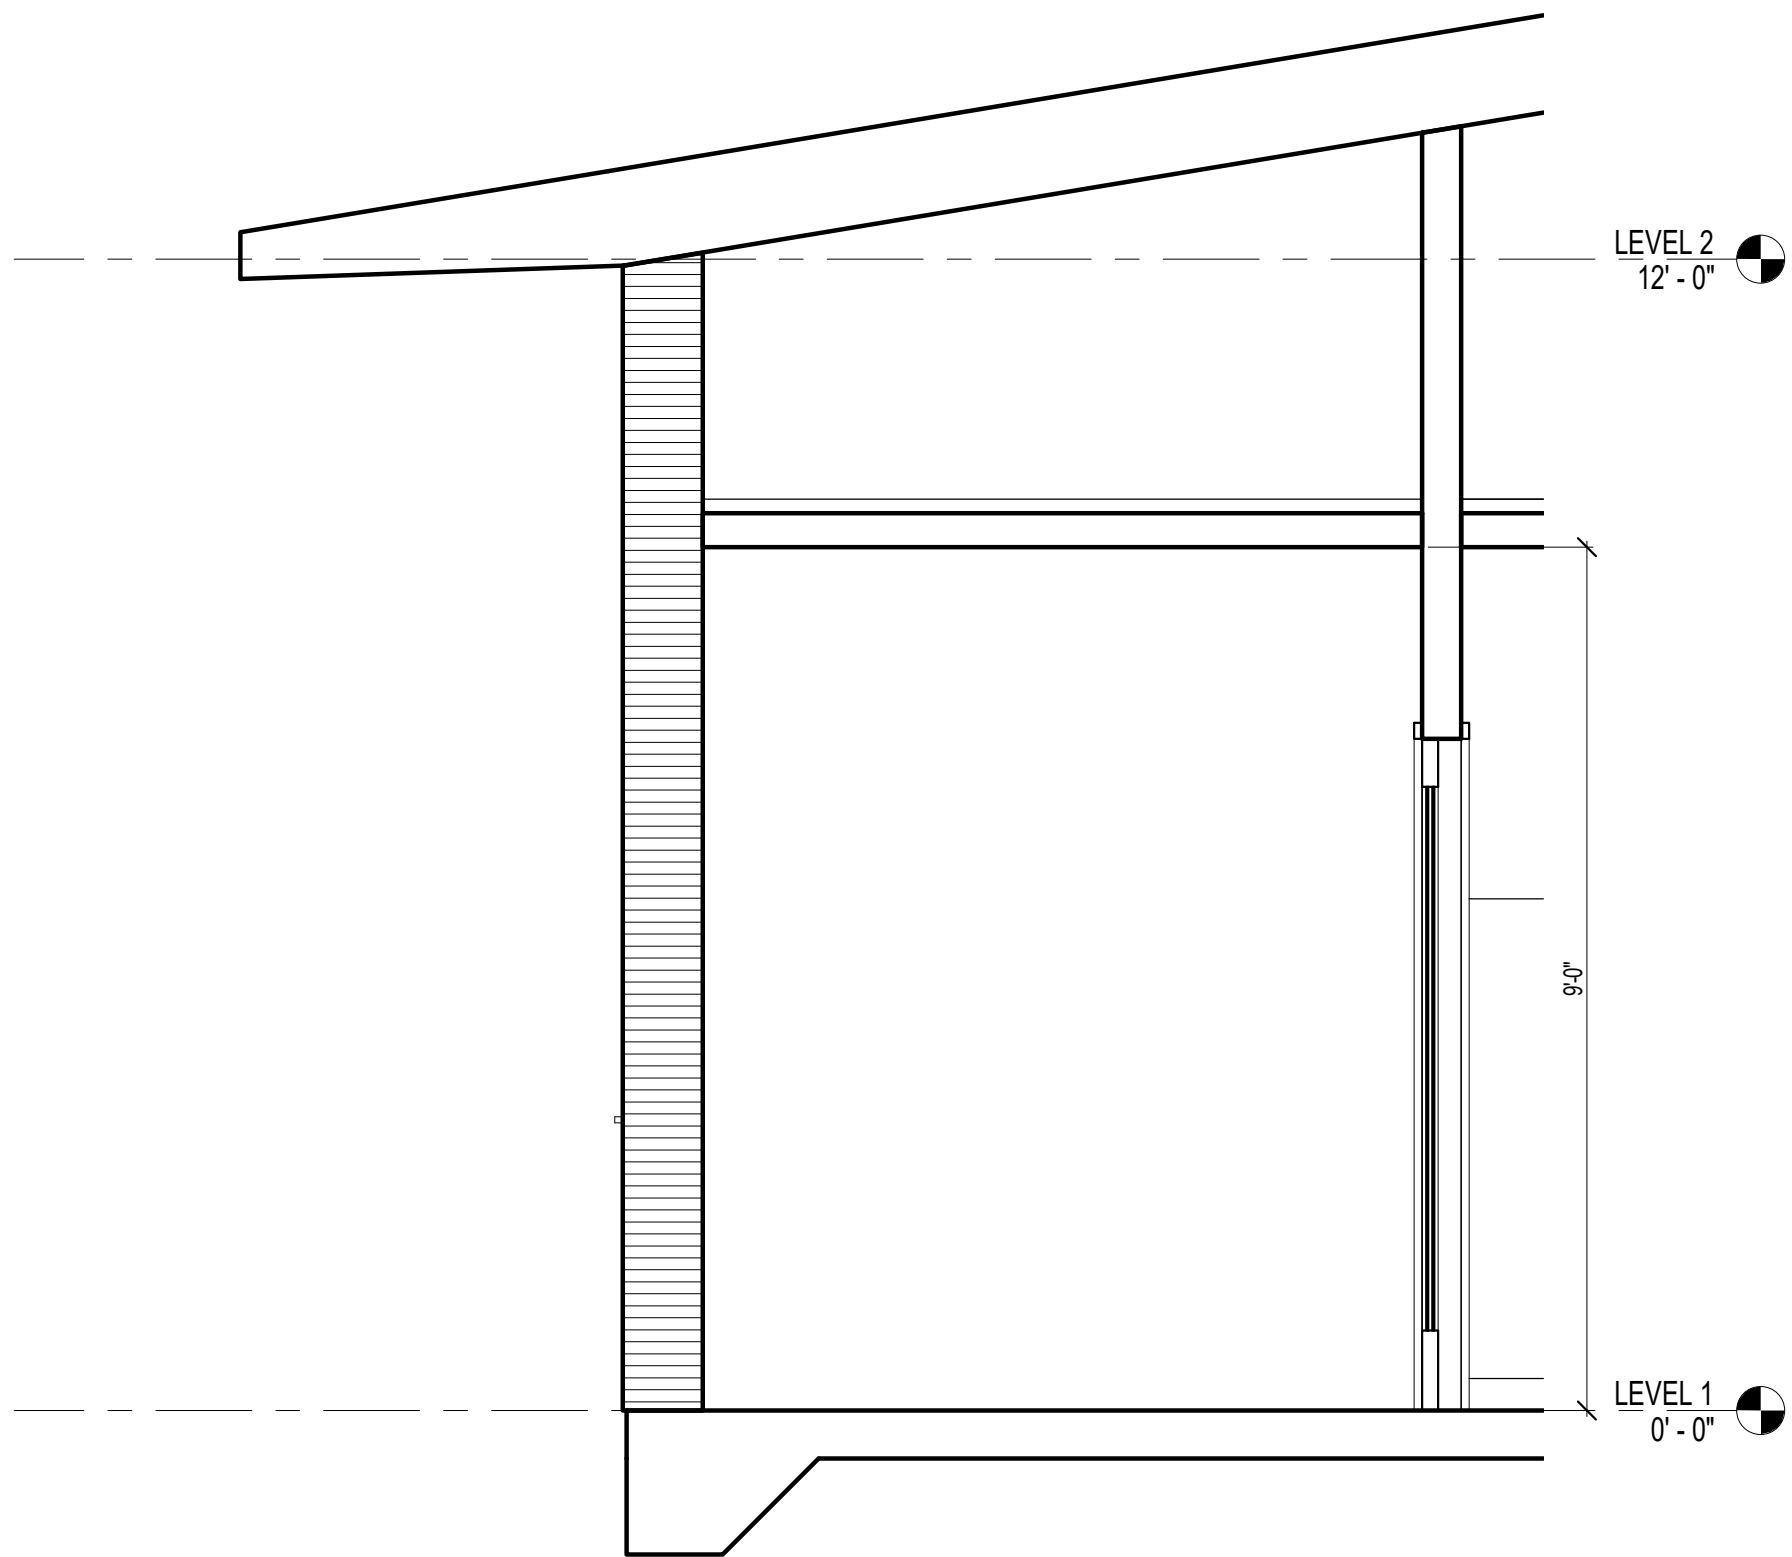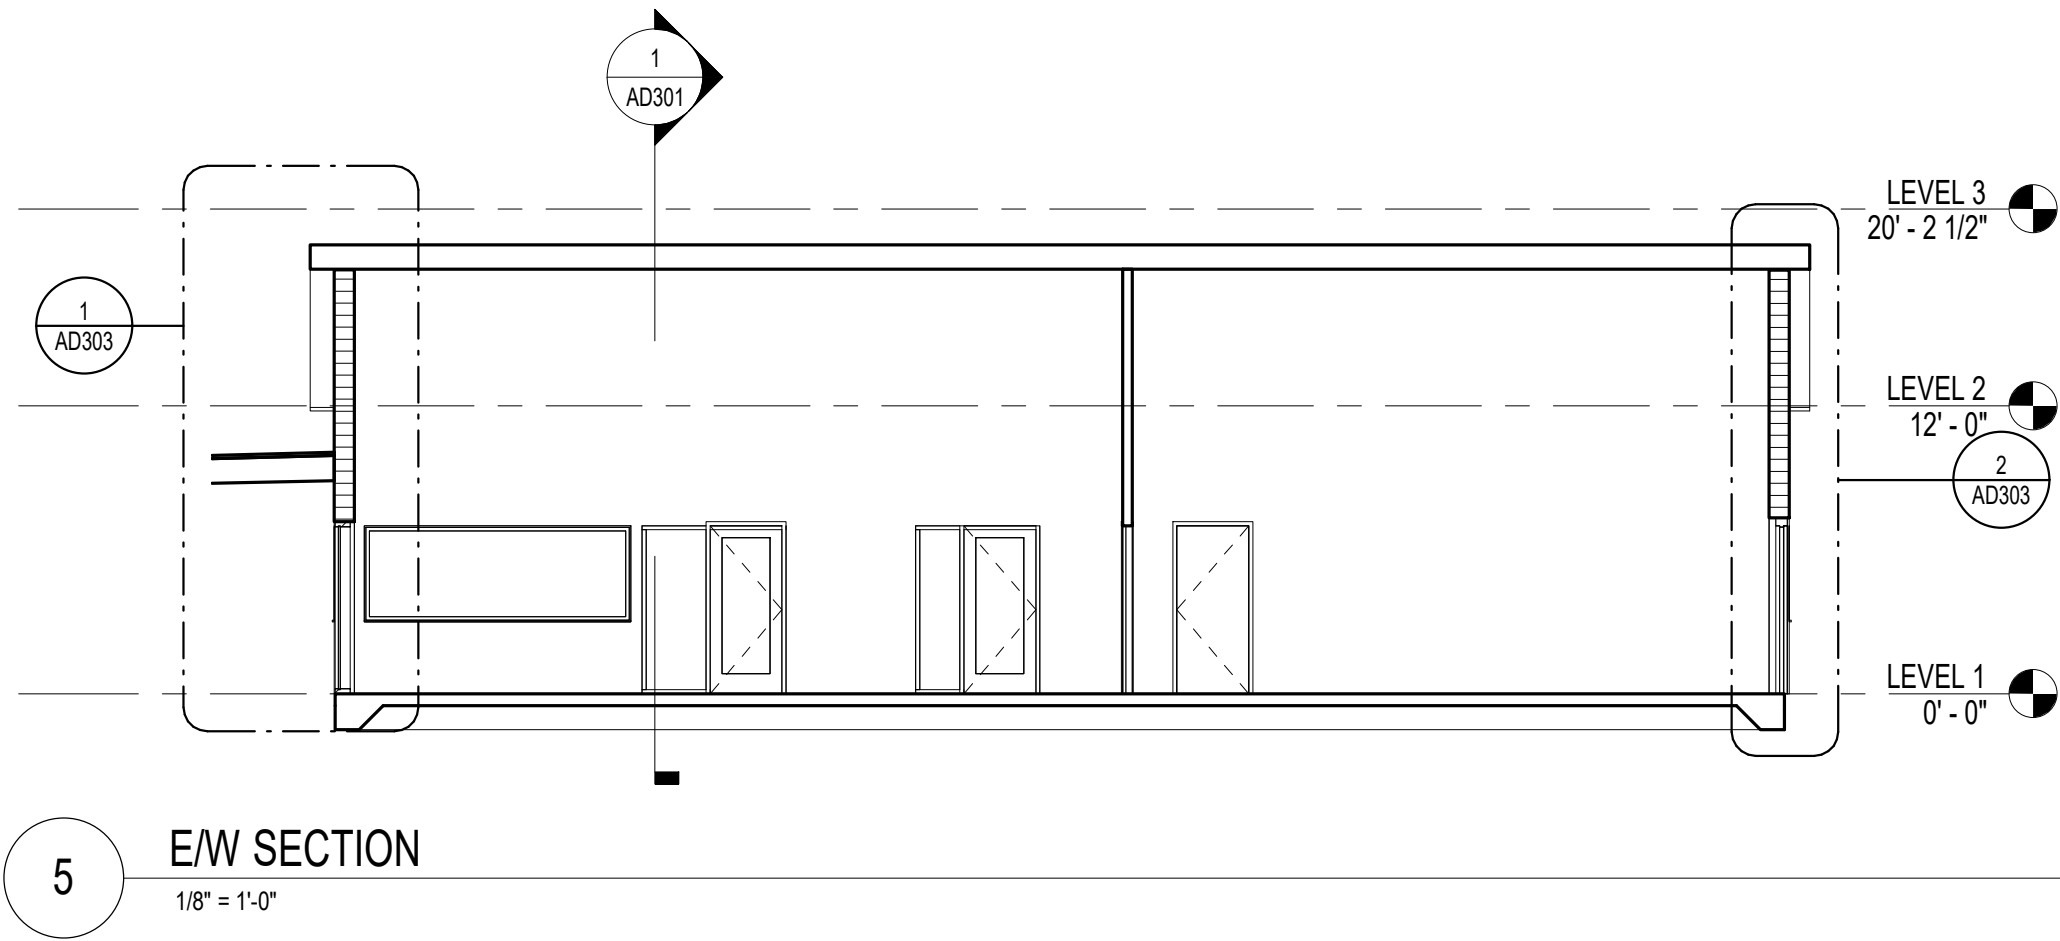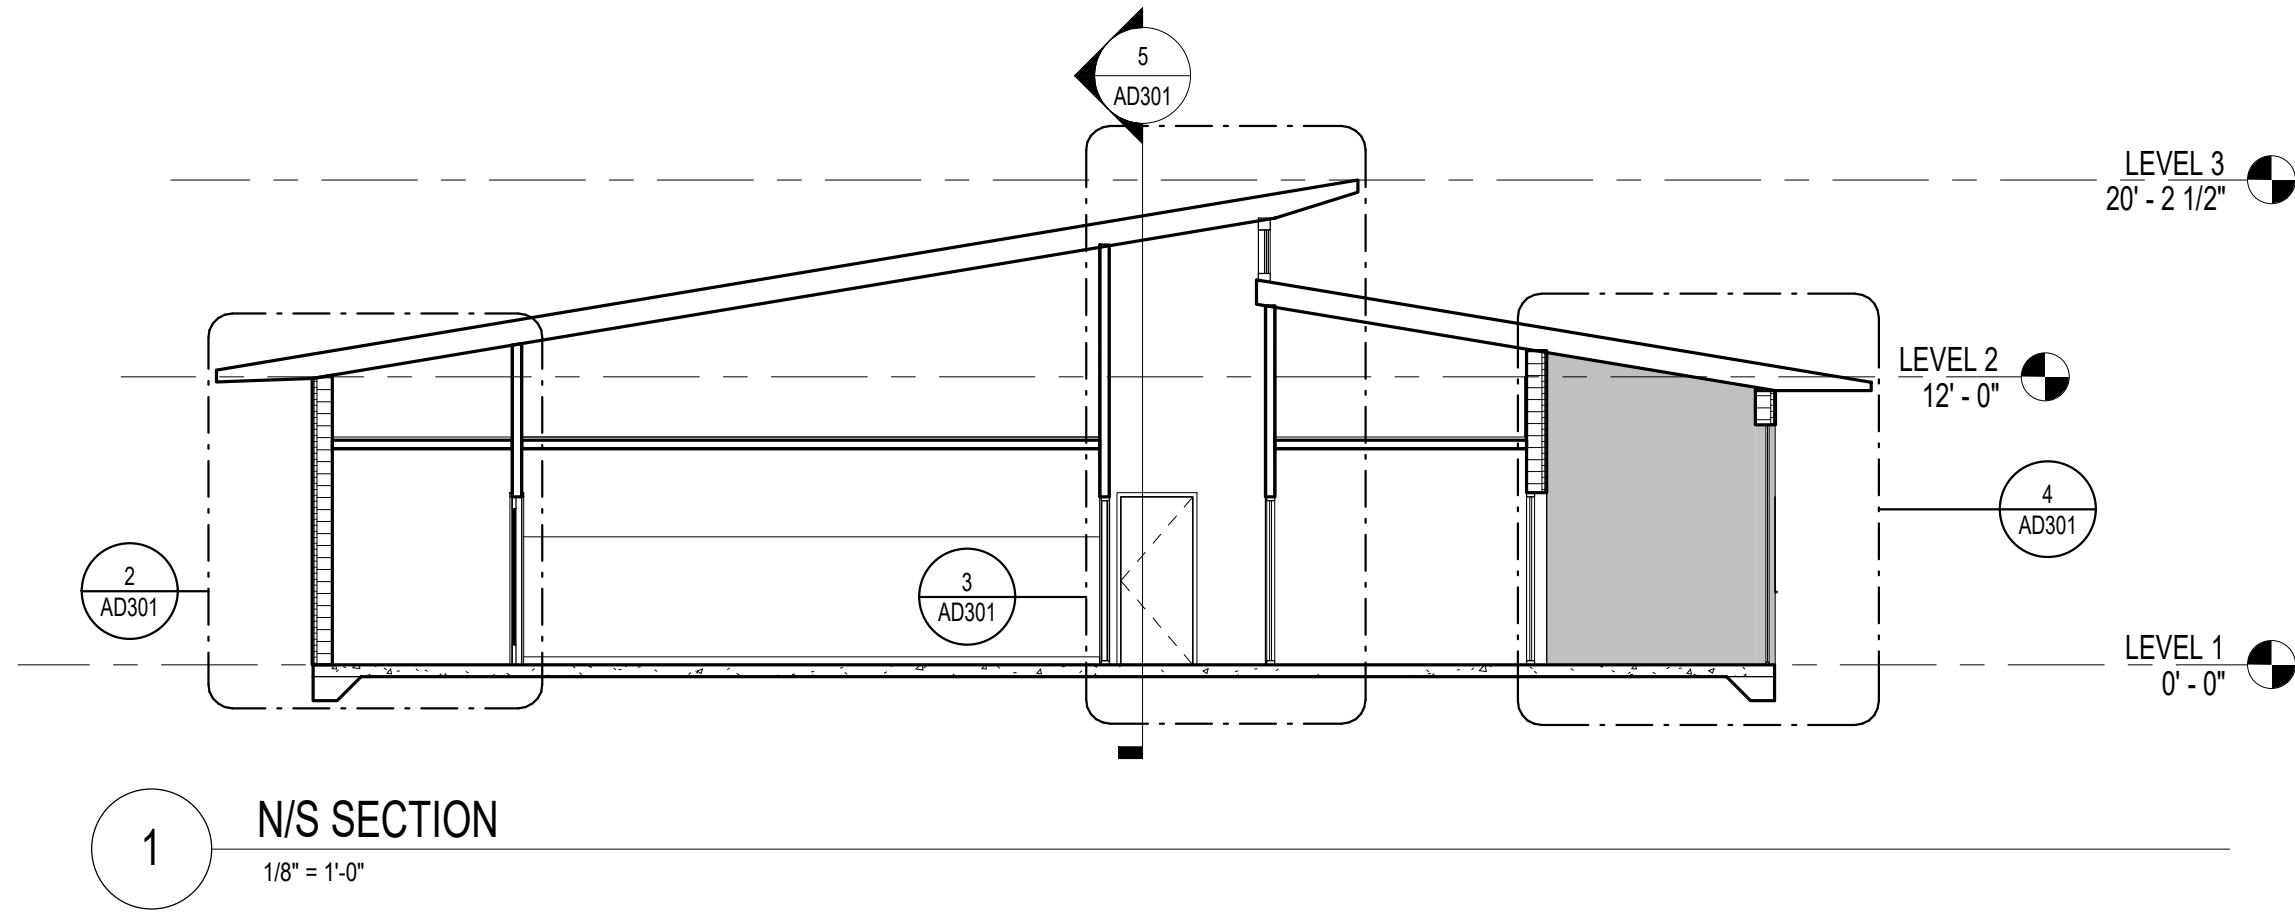

architecture
interiors
planning

MILLER

1177 Idaho Street, Suite 200
Redlands, CA 92374
Phone: 909-335-7400
Fax: 909-335-7299
info@miller-aip.com

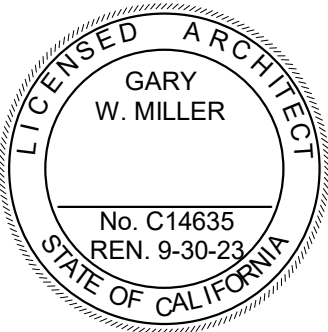

owner approval

initials	date	phase

REVISIONS/ADDENDA

#	Date	Comment
---	------	---------

ANIMAL CARE CENTER

18313 VALLEY BLVD. BLOOMINGTON, CA 92313

SAN BERNARDINO COUNTY

PROJECT INFORMATION

Project Number:	1227
Drawn By:	Author
Checked By:	GWM
Issue Date:	05/08/23

SHEET NAME


CAT AND
OTHER
SECTIONS

SHEET NUMBER


AD301

Sheet Of Sheets

1 E/W WALL SECTION 1
1/2" = 1'-0"

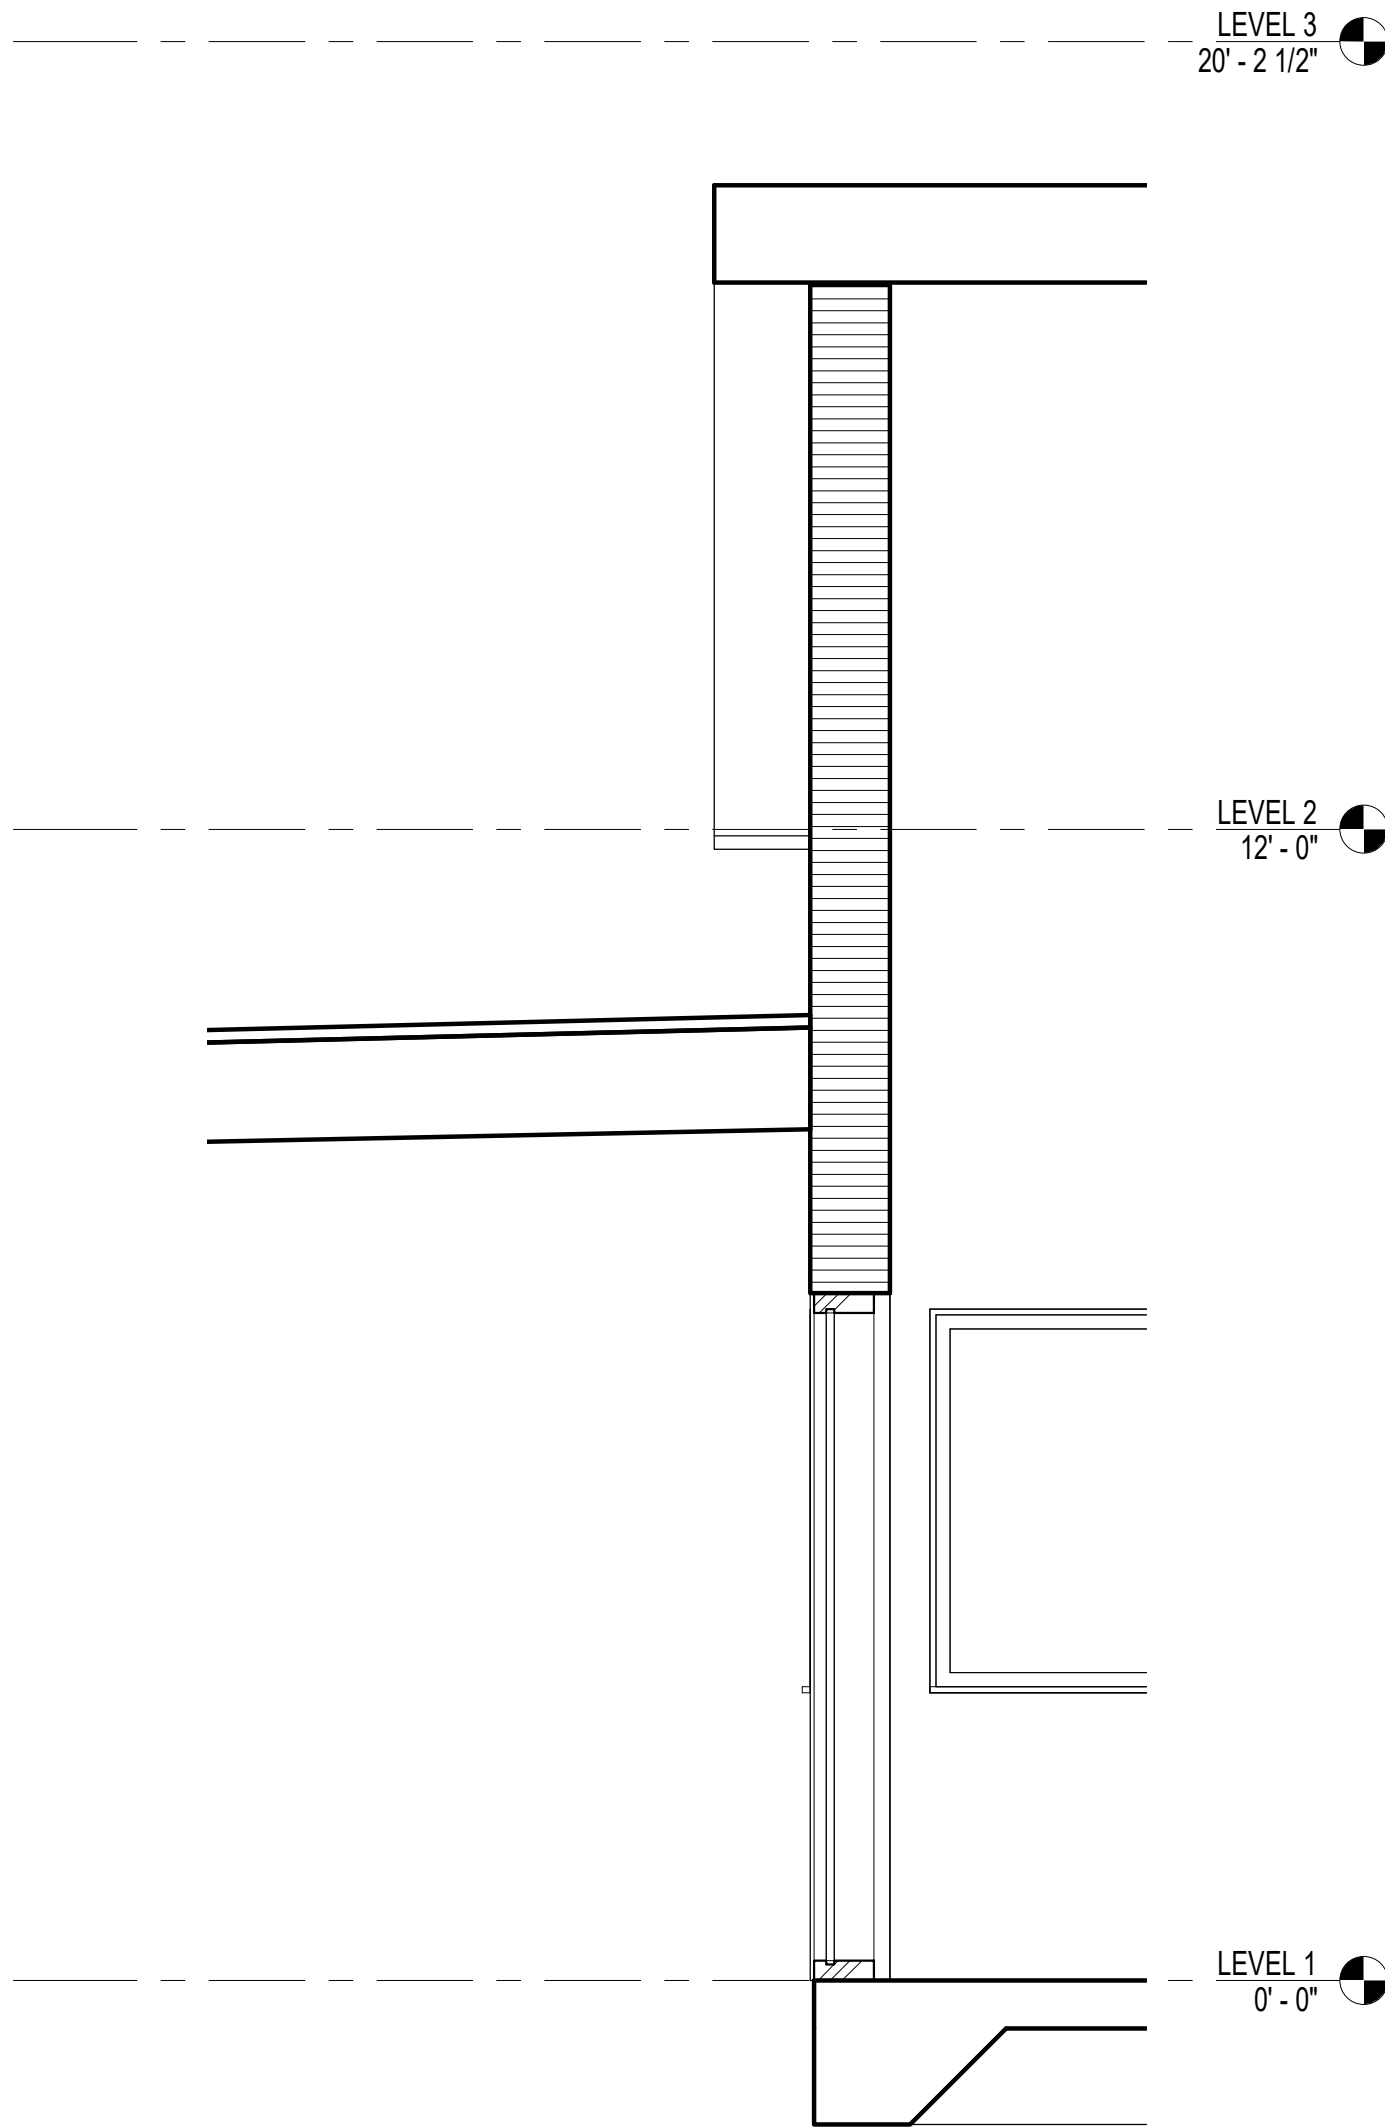

2 E/W WALL SECTION 2
1/2" = 1'-0"

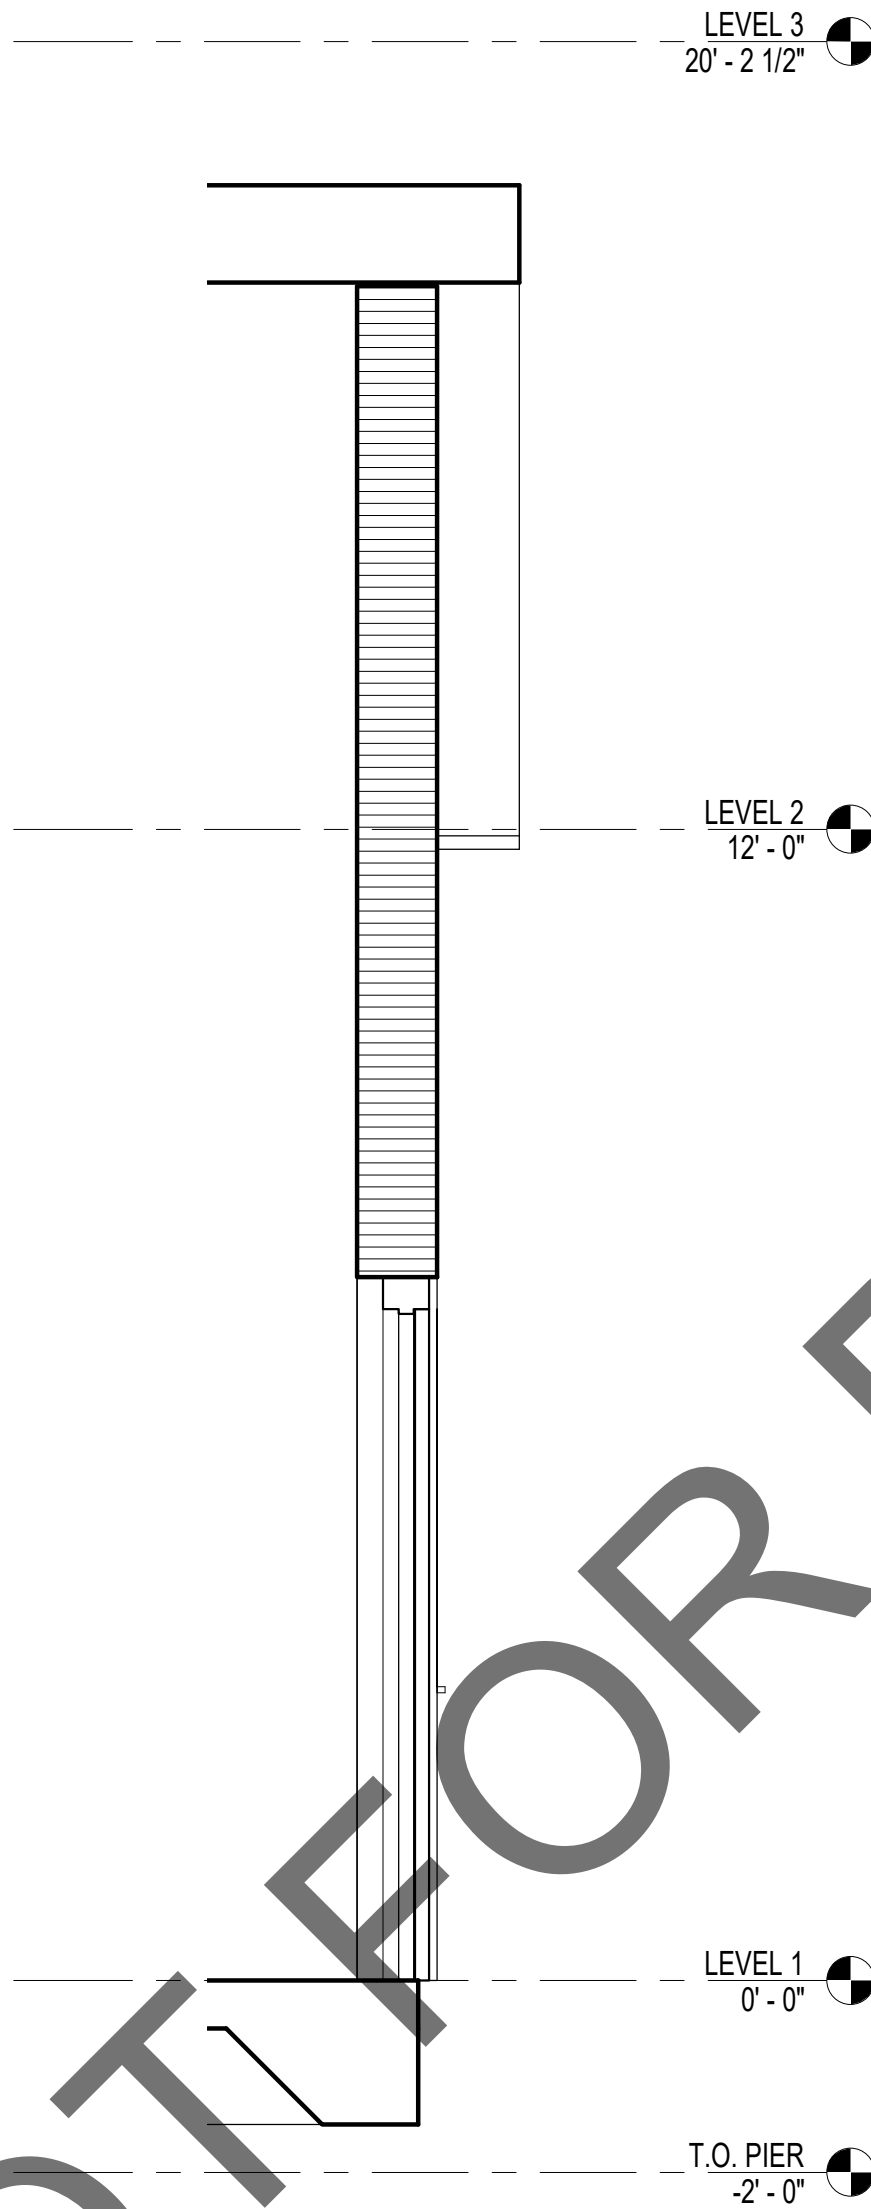

architecture
interiors
planning

1177 Idaho Street, Suite 200
Redlands, CA 92374
Phone: 909-335-7400
Fax: 909-335-7299
info@miller-aip.com



owner approval

initials	date	phase

REVISIONS/ADDENDA

#	Date	Comment
---	------	---------

ANIMAL CARE CENTER

18313 VALLEY BLVD. BLOOMINGTON, CA 92313

SAN BERNARDINO COUNTY

PROJECT INFORMATION

Project Number:	1227
Drawn By:	Author
Checked By:	GWM
Issue Date:	05/08/23



SHEET NAME

CAT AND
OTHER WALL
SECTIONS

SHEET NUMBER

AD303

Sheet Of Sheets

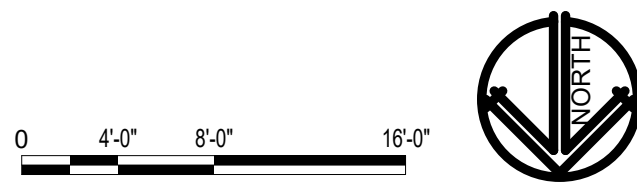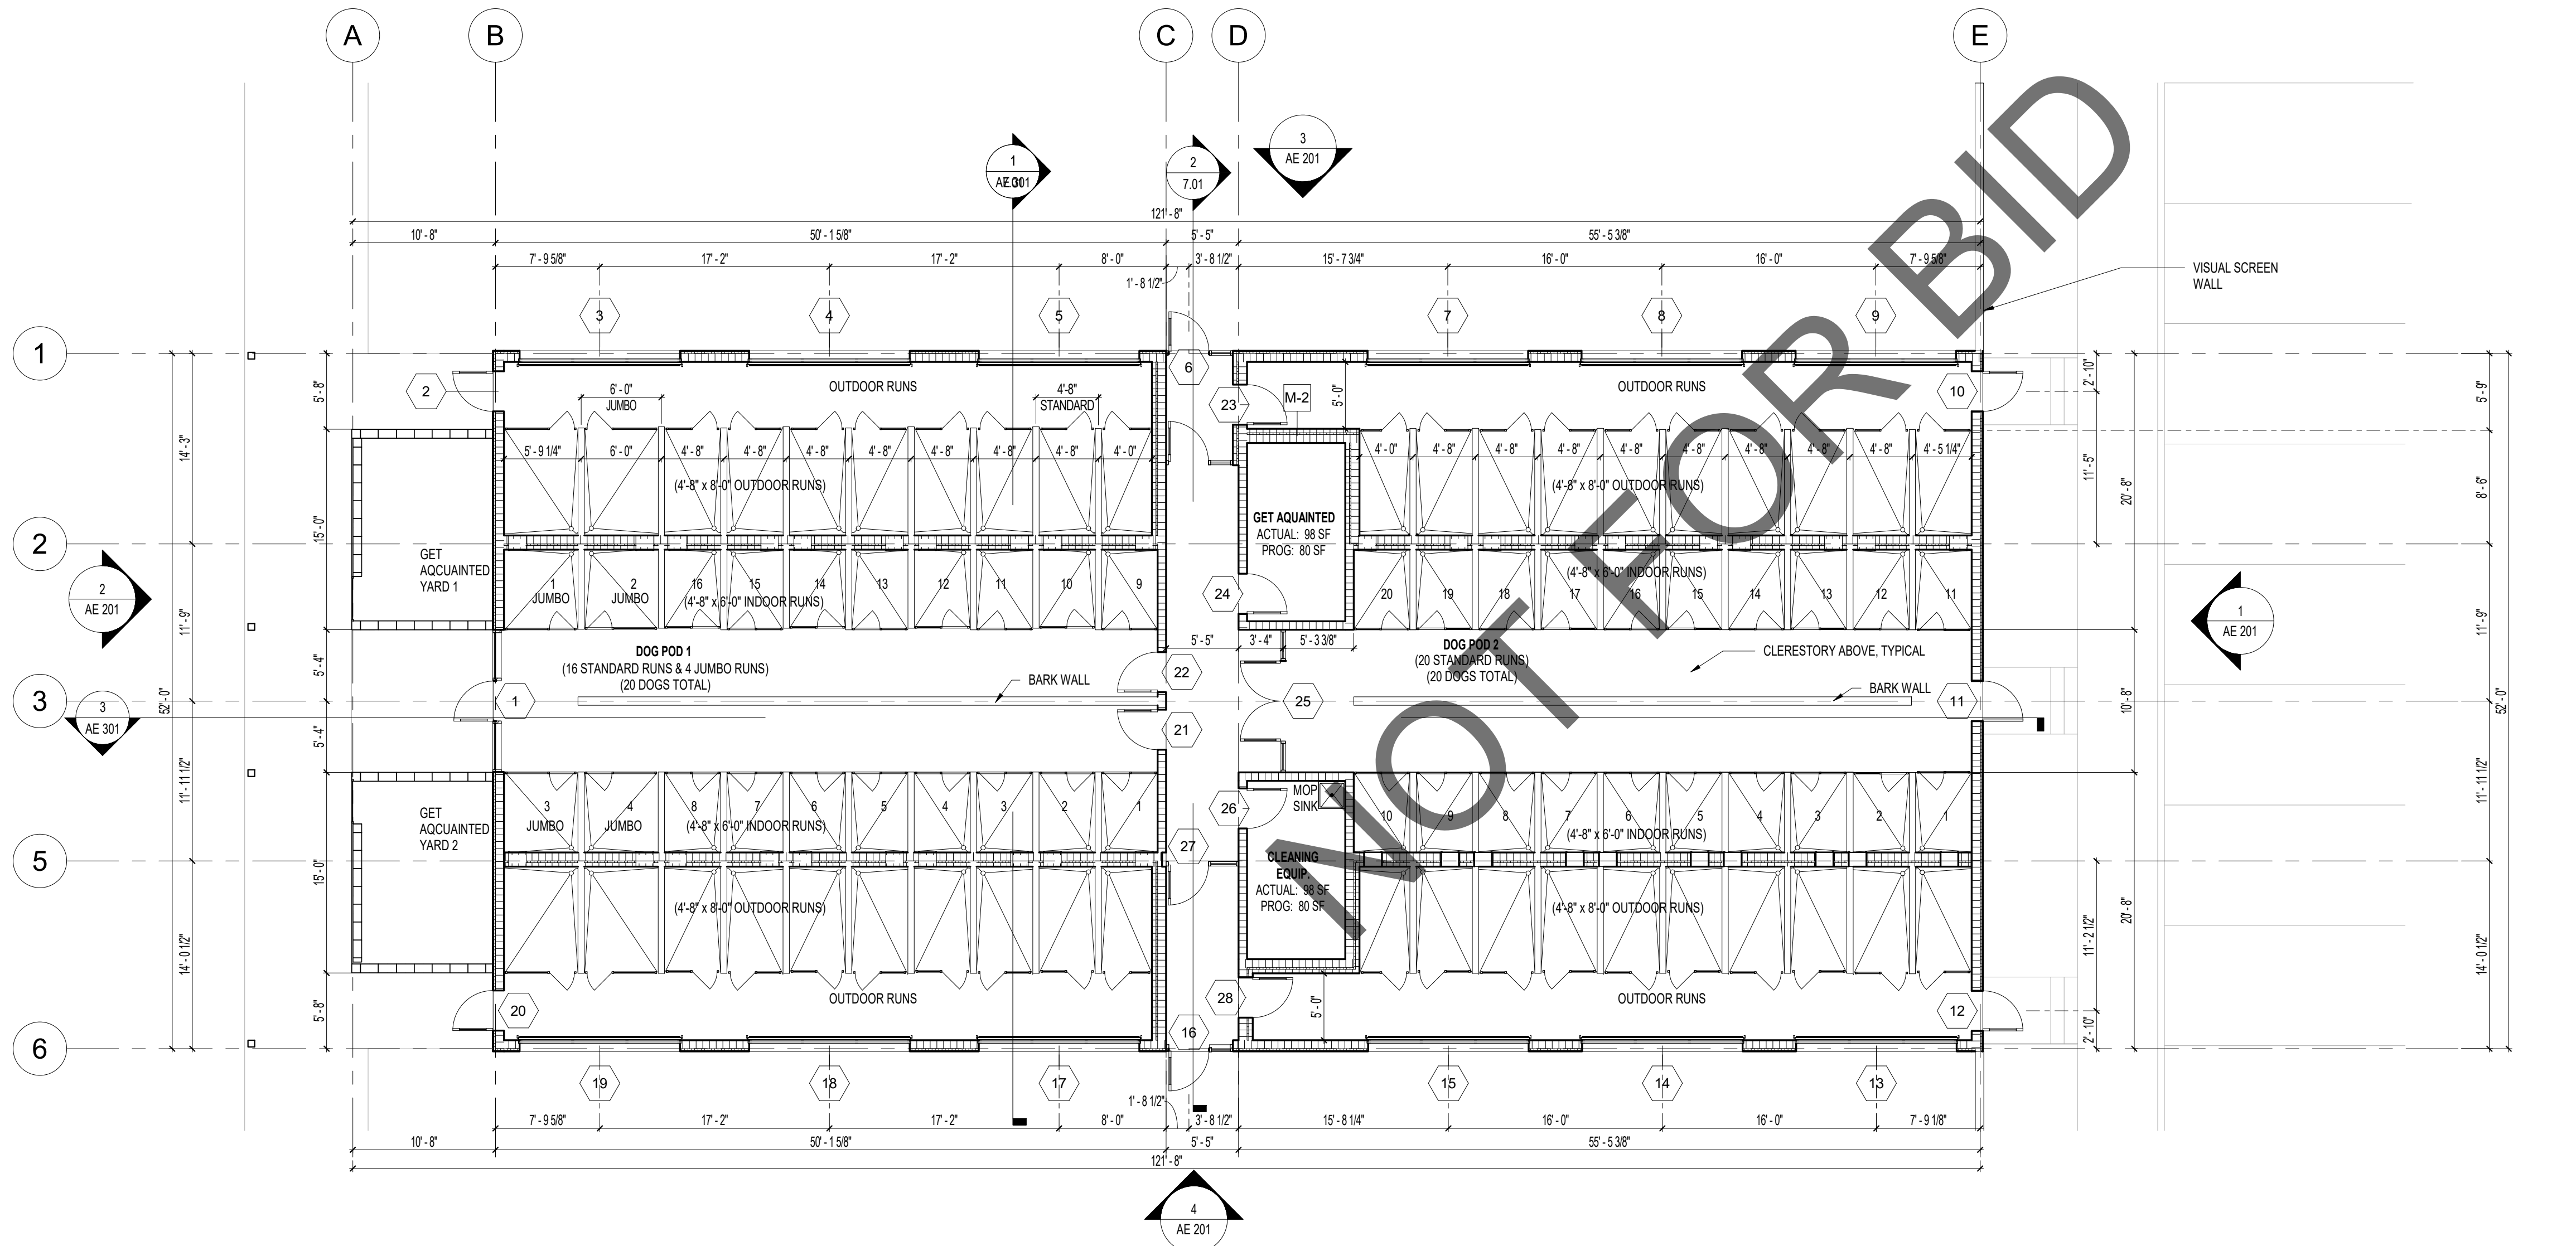


FLOOR PLAN - ADOPTION DOG BUILDING 5, 6, & 7

SCALE
1/8" = 1'-0"

1



1177 Idaho Street, Suite 200
Redlands, CA 92374
Phone: 909-335-7400
Fax: 909-335-7299
info@miller-aip.com

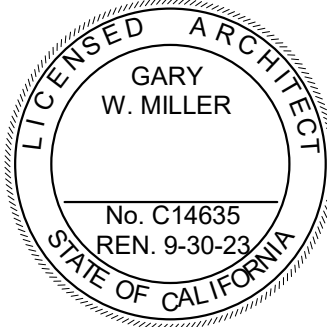

owner approval		
initials	date	phase



REVISIONS/ADDENDA		
#	Date	Comment

ANIMAL CARE CENTER
18313 VALLEY BLVD. BLOOMINGTON, CA 92313
SAN BERNARDINO COUNTY

PROJECT INFORMATION	
Project Number:	1227
Drawn By:	PF
Checked By:	GWM
Issue Date:	05/08/23

SHEET NAME
ADOPTION DOG
BUILDINGS 5, 6,
& 7 FLOOR PLAN

SHEET NUMBER	
AE 101	
Sheet	Of Sheets

 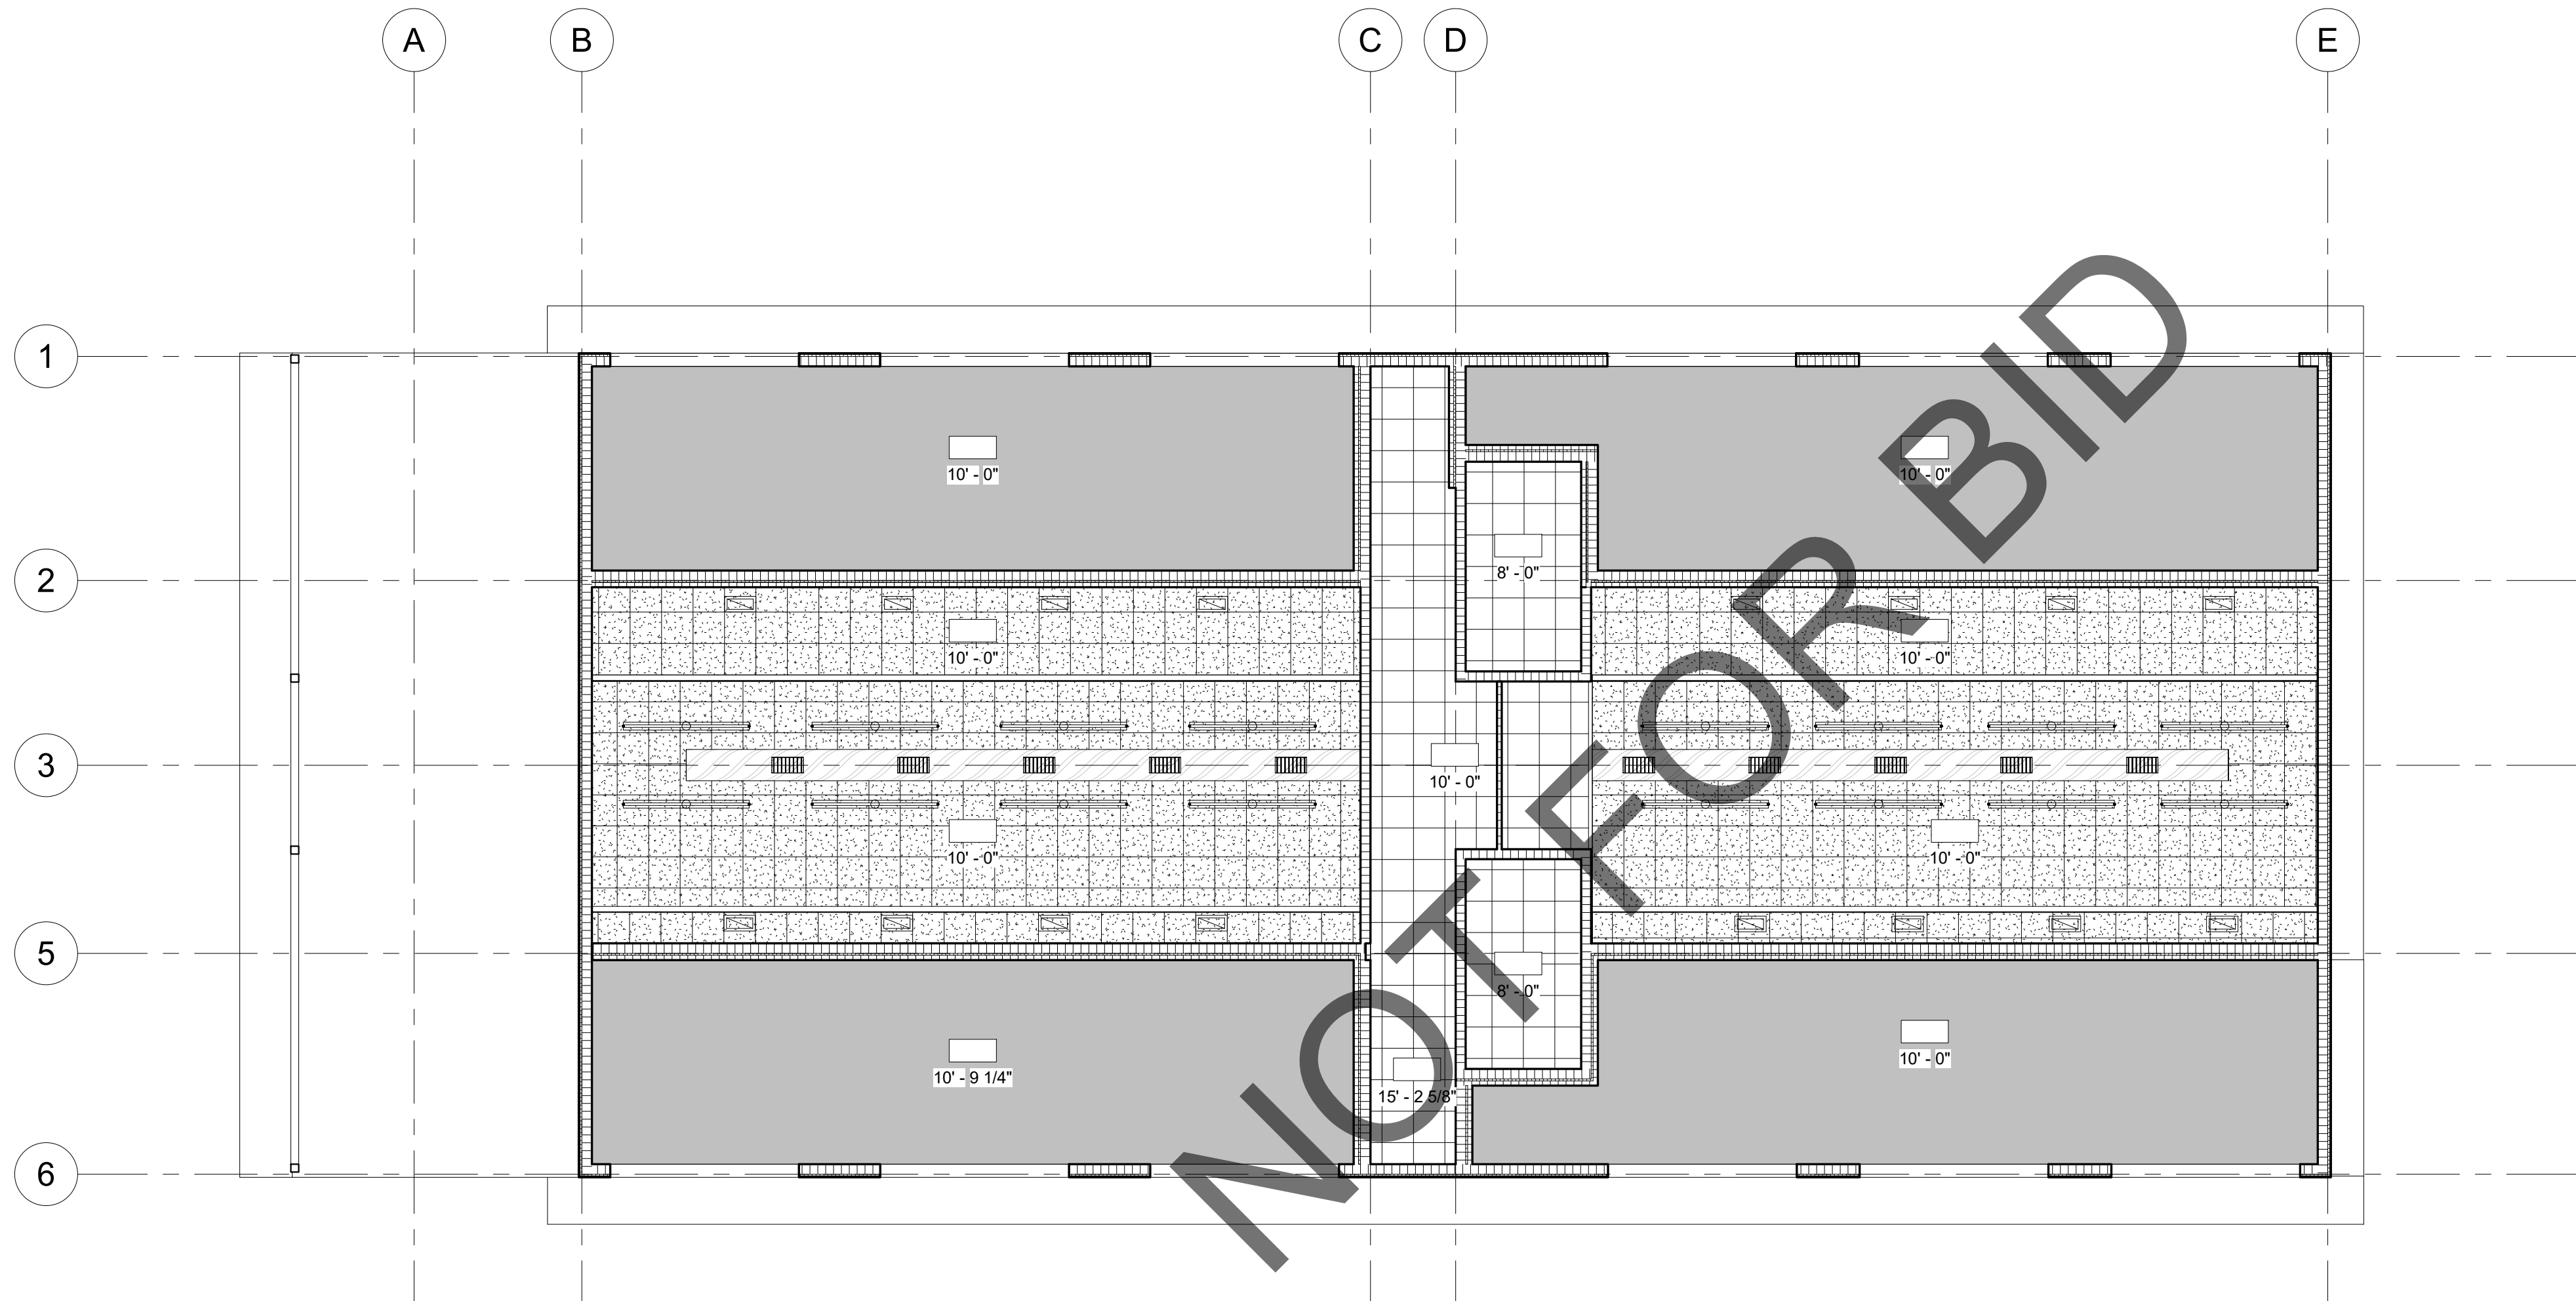

ADOPTION DOG BUILDINGS 5, 6, & 7 REFLECTED CEILING PLAN


SCALE	1
1/8" = 1'-0"	



architecture
interiors
planning

MILLER

1177 Idaho Street, Suite 200
Redlands, CA 92374
Phone: 909-335-7400
Fax: 909-335-7299
info@miller-aip.com

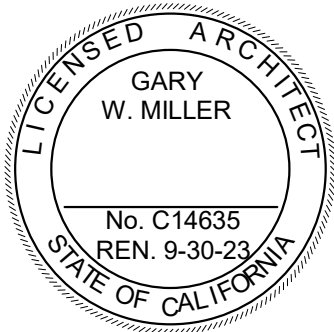

owner approval		
initials	date	phase

REVISIONS/ADDENDA		
#	Date	Comment

ANIMAL CARE CENTER

18313 VALLEY BLVD. BLOOMINGTON, CA 92313

SAN BERNARDINO COUNTY



PROJECT INFORMATION	
Project Number:	1227
Drawn By:	Author
Checked By:	GWM
Issue Date:	05/08/23

SHEET NAME

ADOPTION DOG
BUILDINGS 5, 6,
& 7 RCP

SHEET NUMBER

AE 103

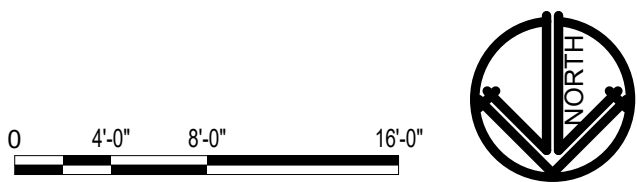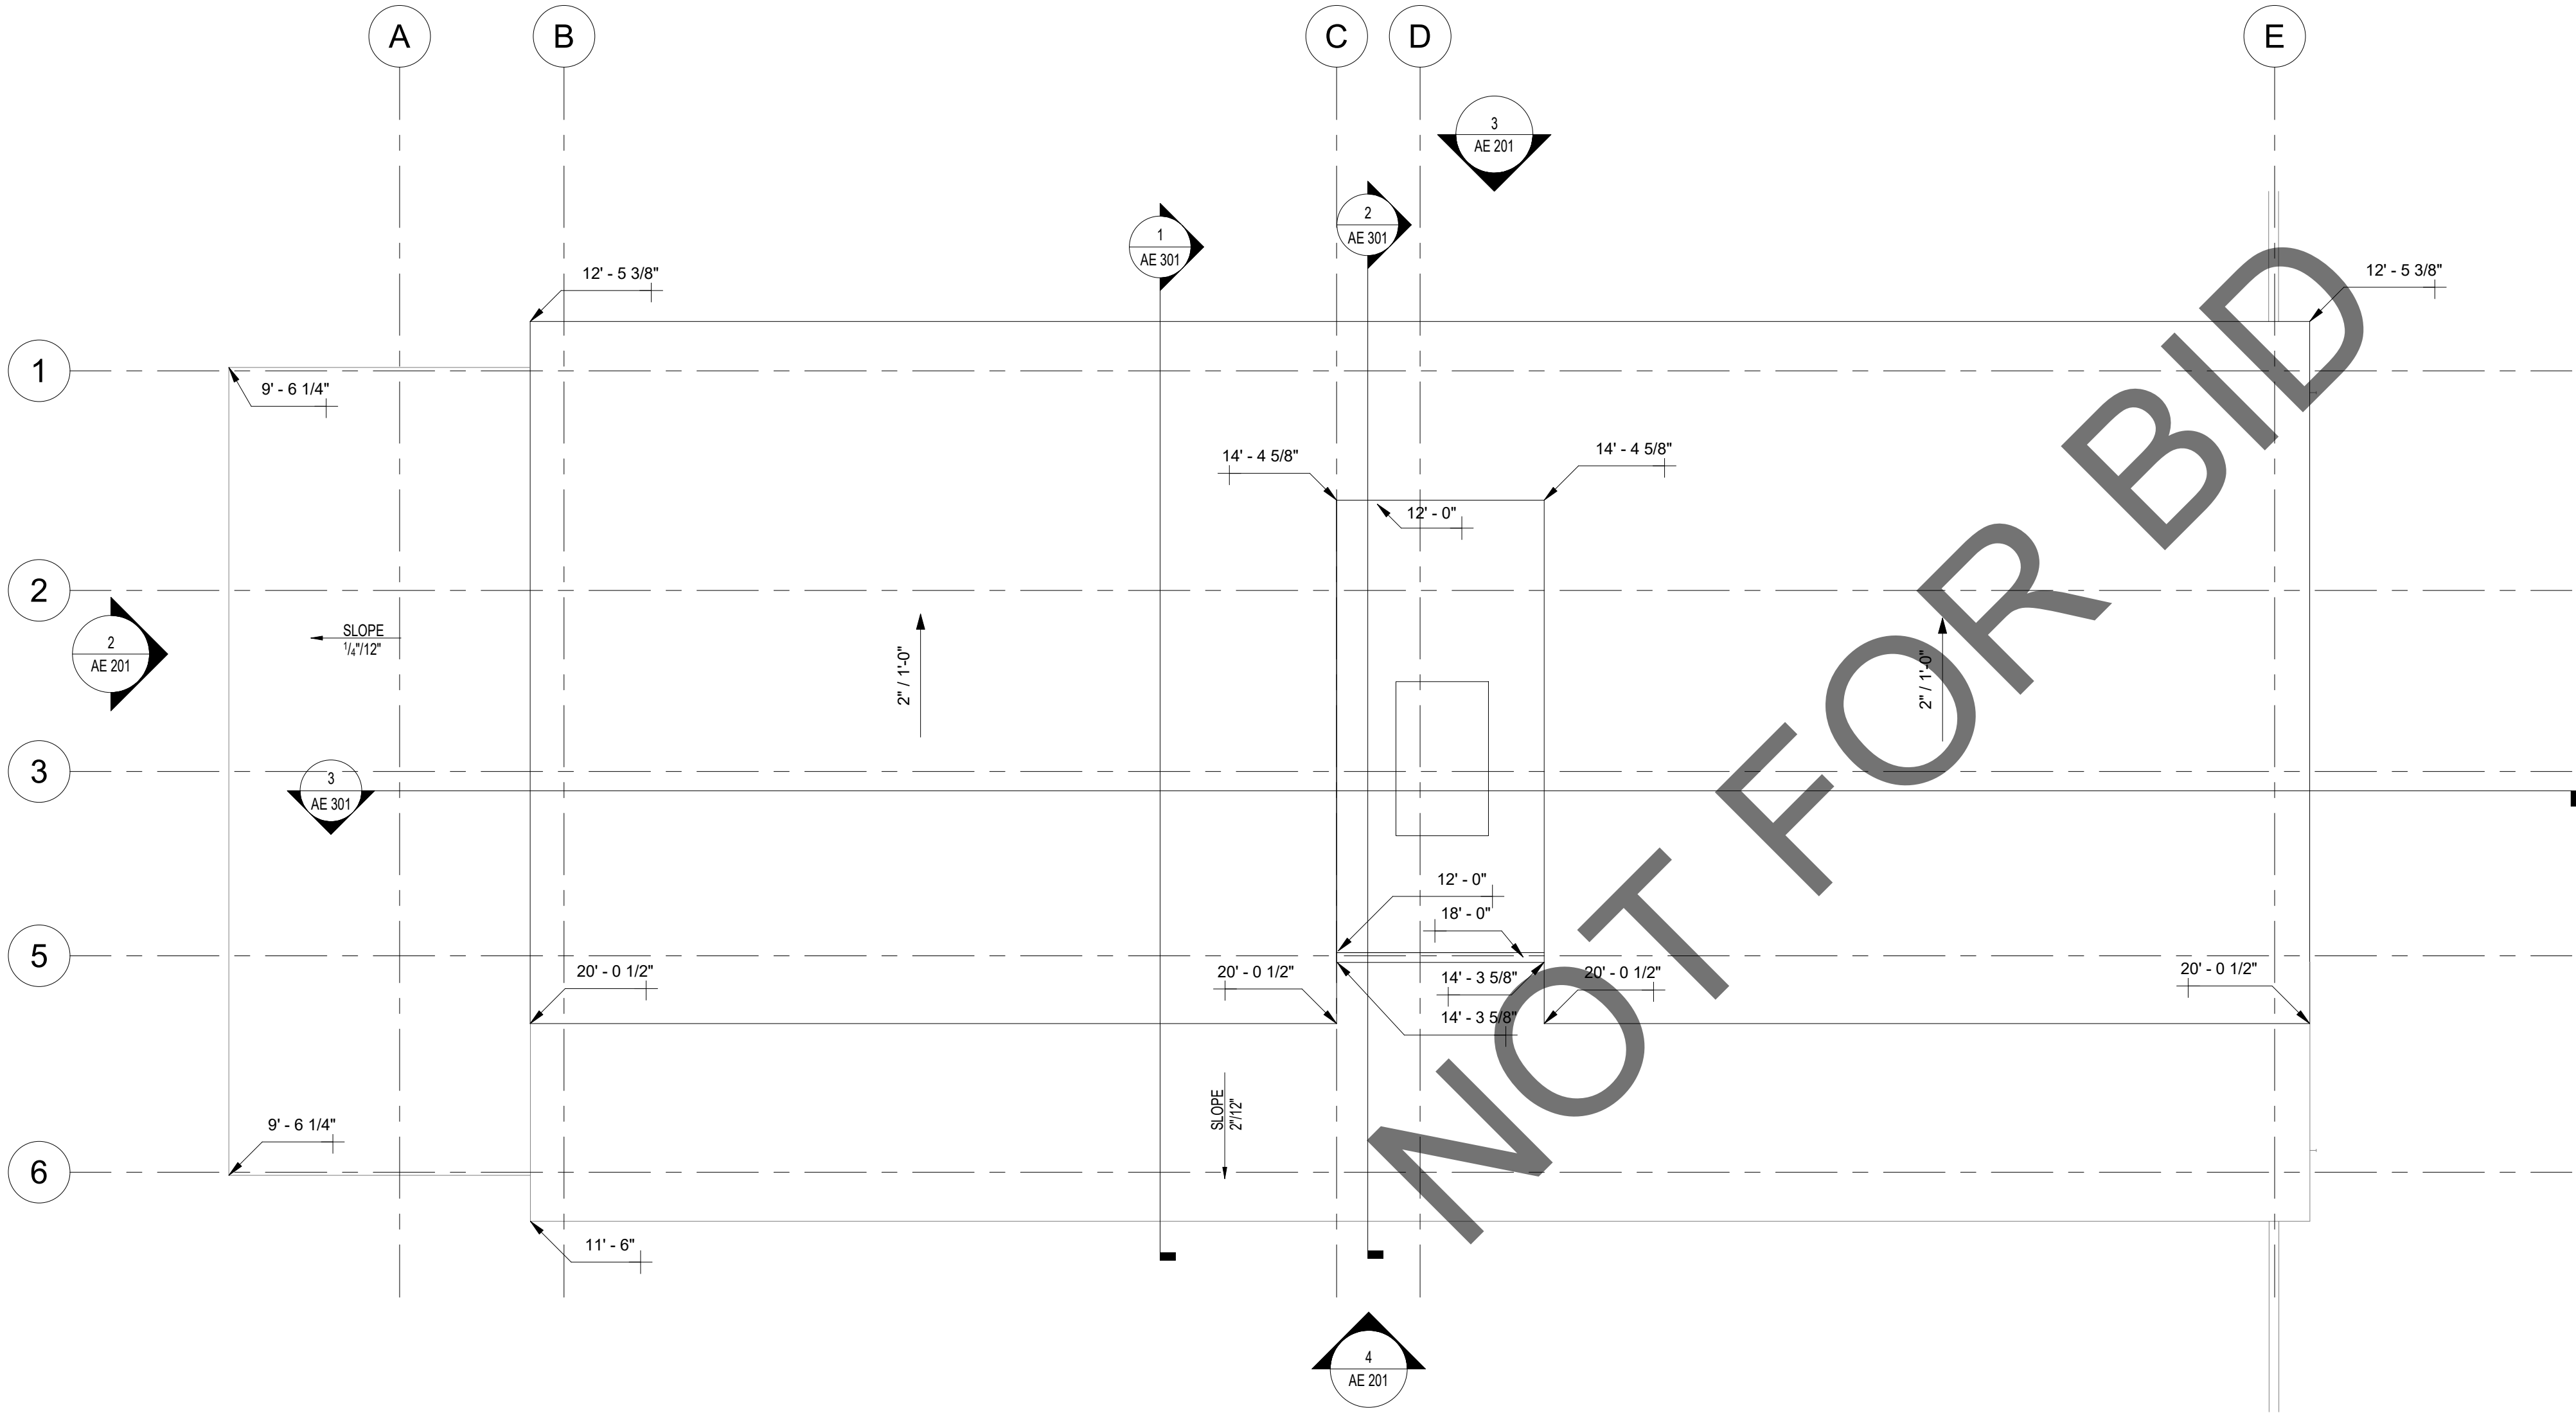

ADOPTION DOG BUILDINGS 5, 6, & 7 ROOF PLAN



1177 Idaho Street, Suite 200
Redlands, CA 92374
Phone: 909-335-7400
Fax: 909-335-7299
info@millar-aip.com



owner approval

initials	date	phase

revisions/addenda

#	Date	Comment
---	------	---------

ANIMAL CARE CENTER

18313 VALLEY BLVD. BLOOMINGTON, CA 92313

SAN BERNARDINO COUNTY

project information


Project Number:	1227
Drawn By:	Author
Checked By:	MB
Issue Date:	05/08/23

sheet name

ADOPTION DOG
BUILDINGS 5, 6,
& 7 ROOF PLAN


sheet number

AE 105

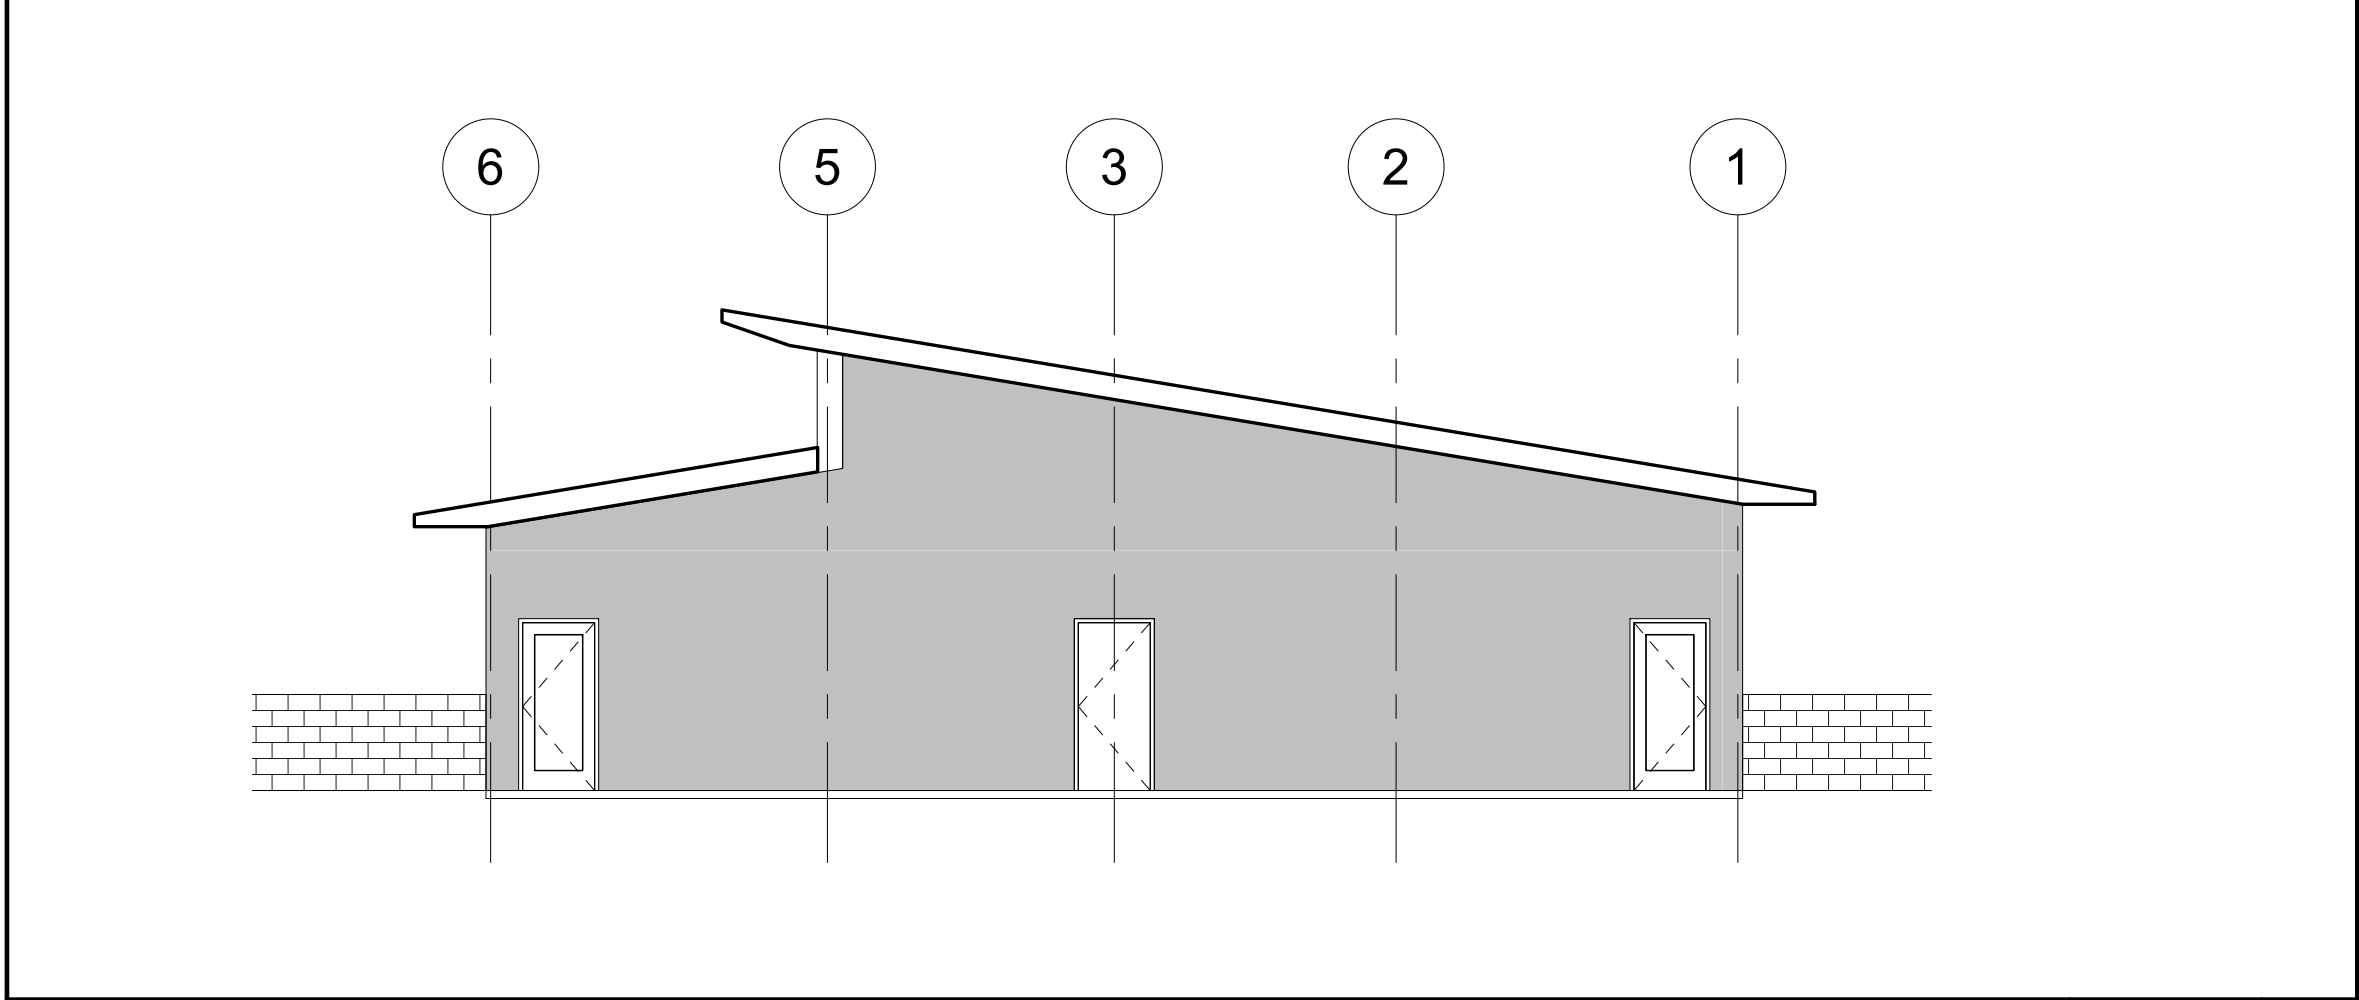


ADOPTION DOG BUILDINGS 5, 6 & 7 EAST ELEVATION

SCALE	1
1/8" = 1'-0"	

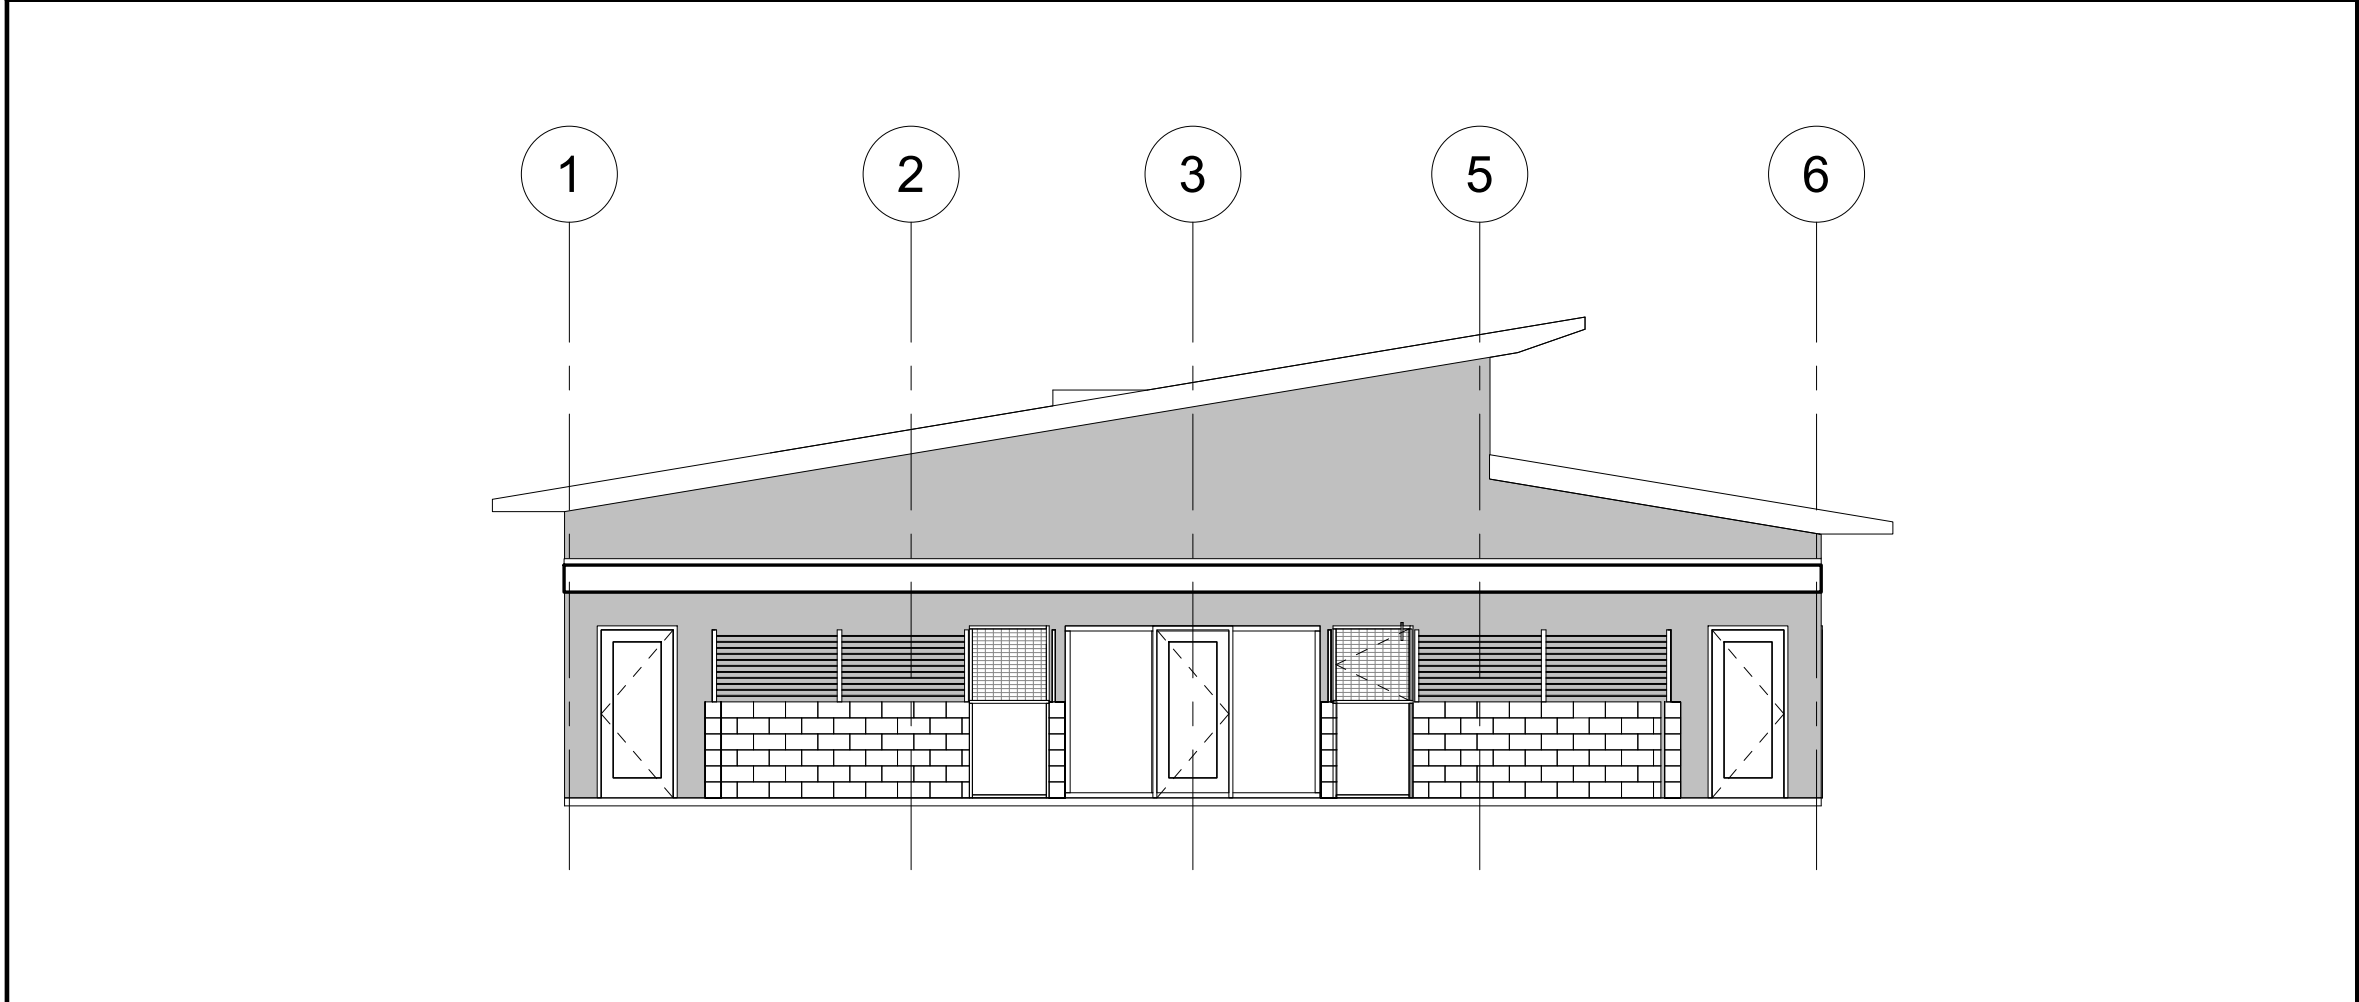


ADOPTION DOG BUILDINGS 5, 6, & 7 WEST ELEVATION

SCALE	2
1/8" = 1'-0"	

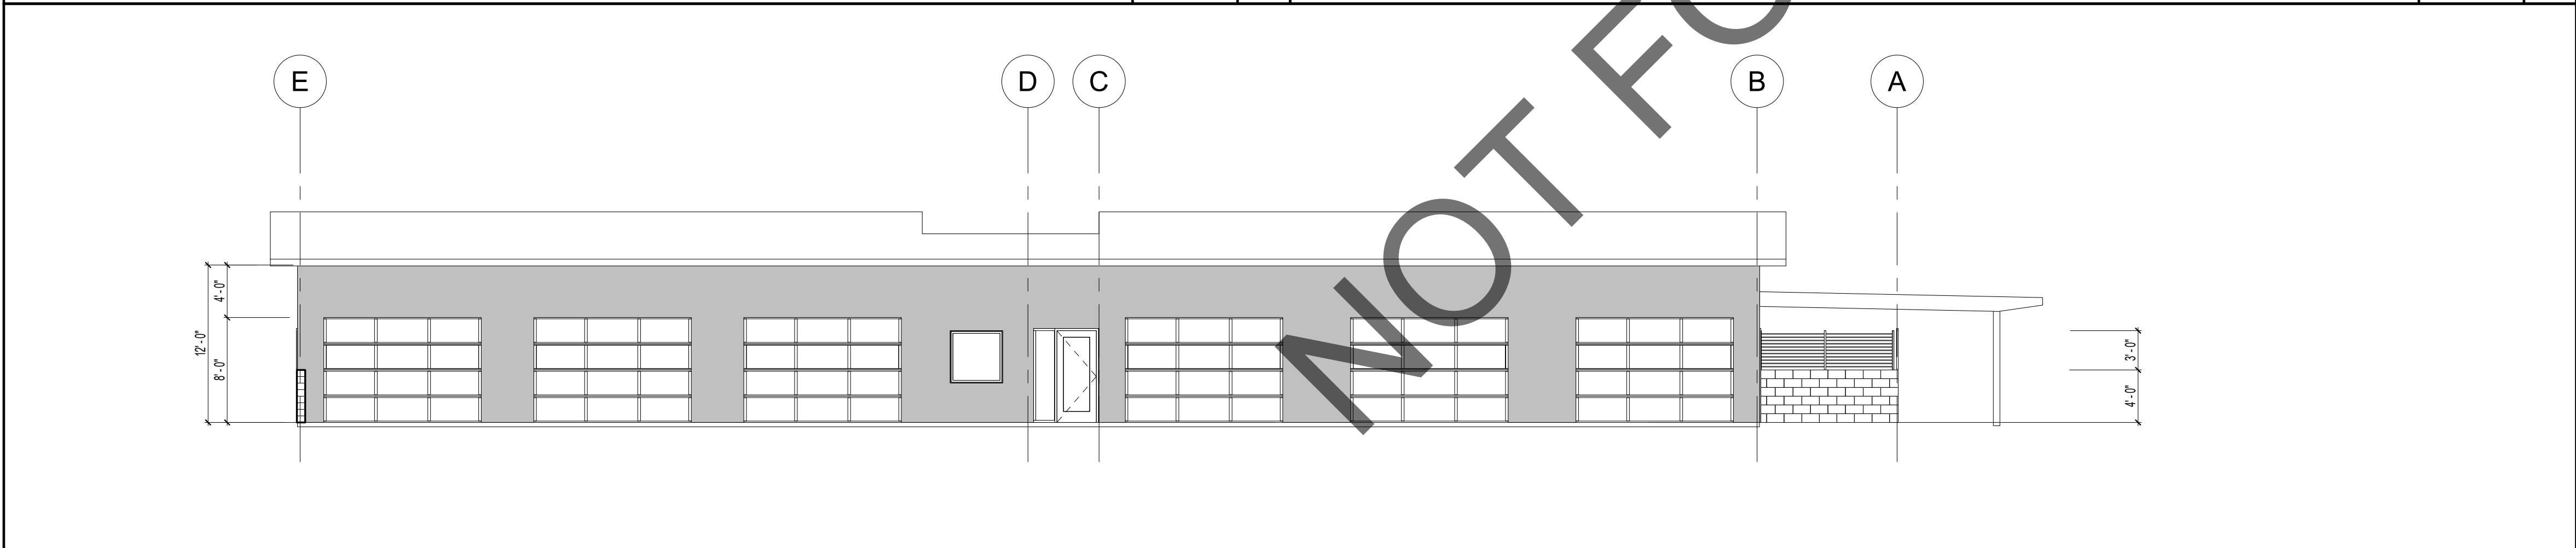

ADOPTION DOG BUILDINGS 5, 6, & 7 NORTH ELEVATION

SCALE	3
1/8" = 1'-0"	

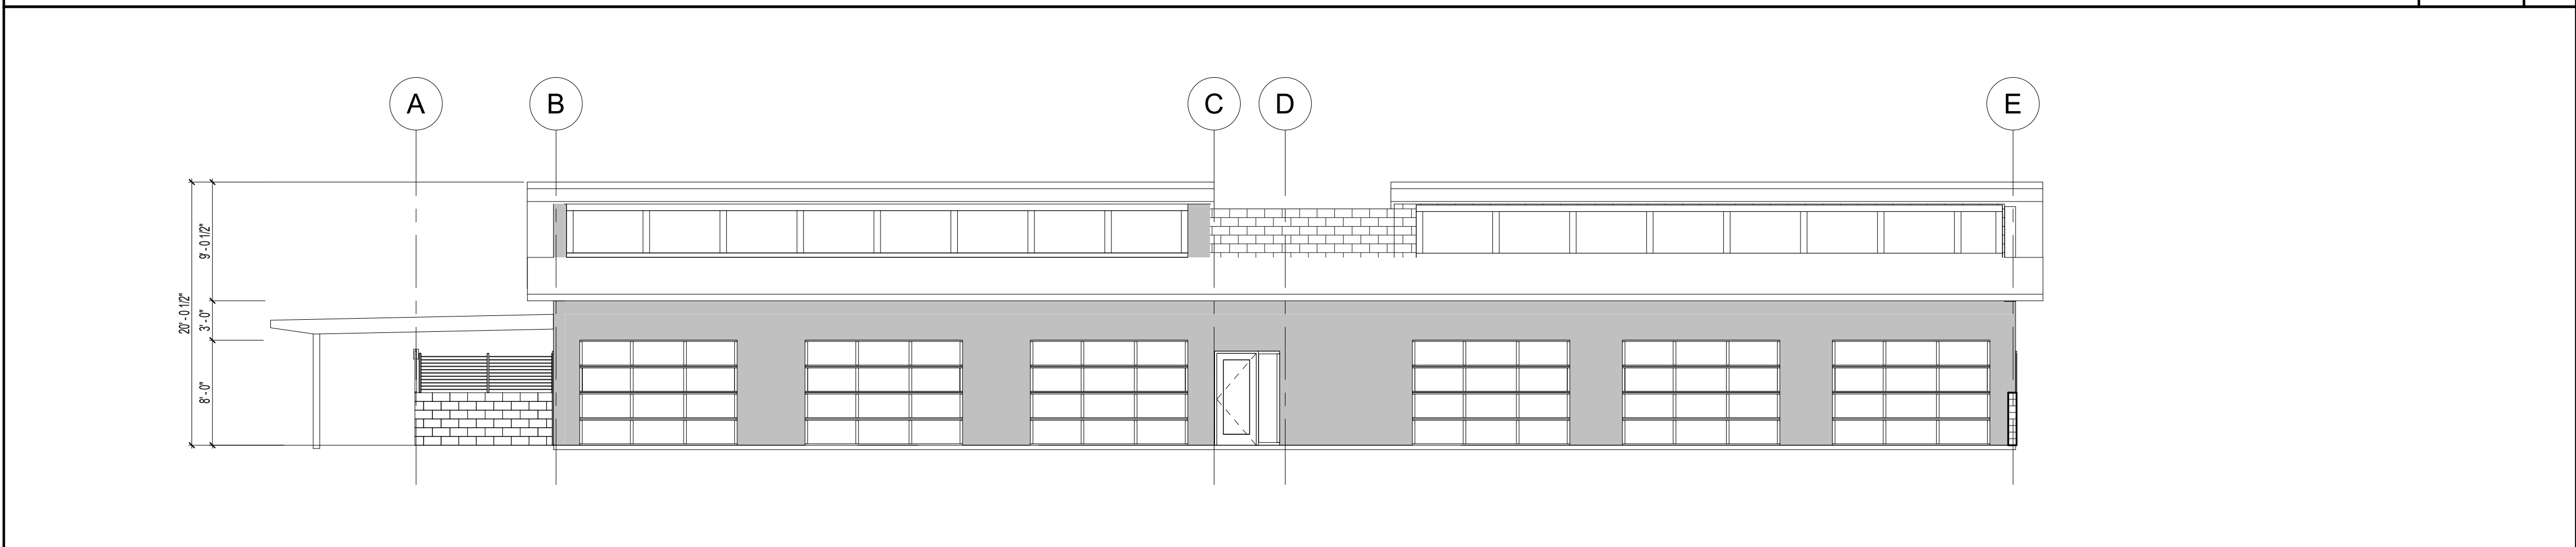


ADOPTION DOG BUILDINGS 5, 6, & 7 SOUTH ELEVATION

SCALE	4
1/8" = 1'-0"	

initials	date	phase

#	Date	Comment
---	------	---------


Project Number:	1227
Drawn By:	Author
Checked By:	GWM
Issue Date:	05/08/23

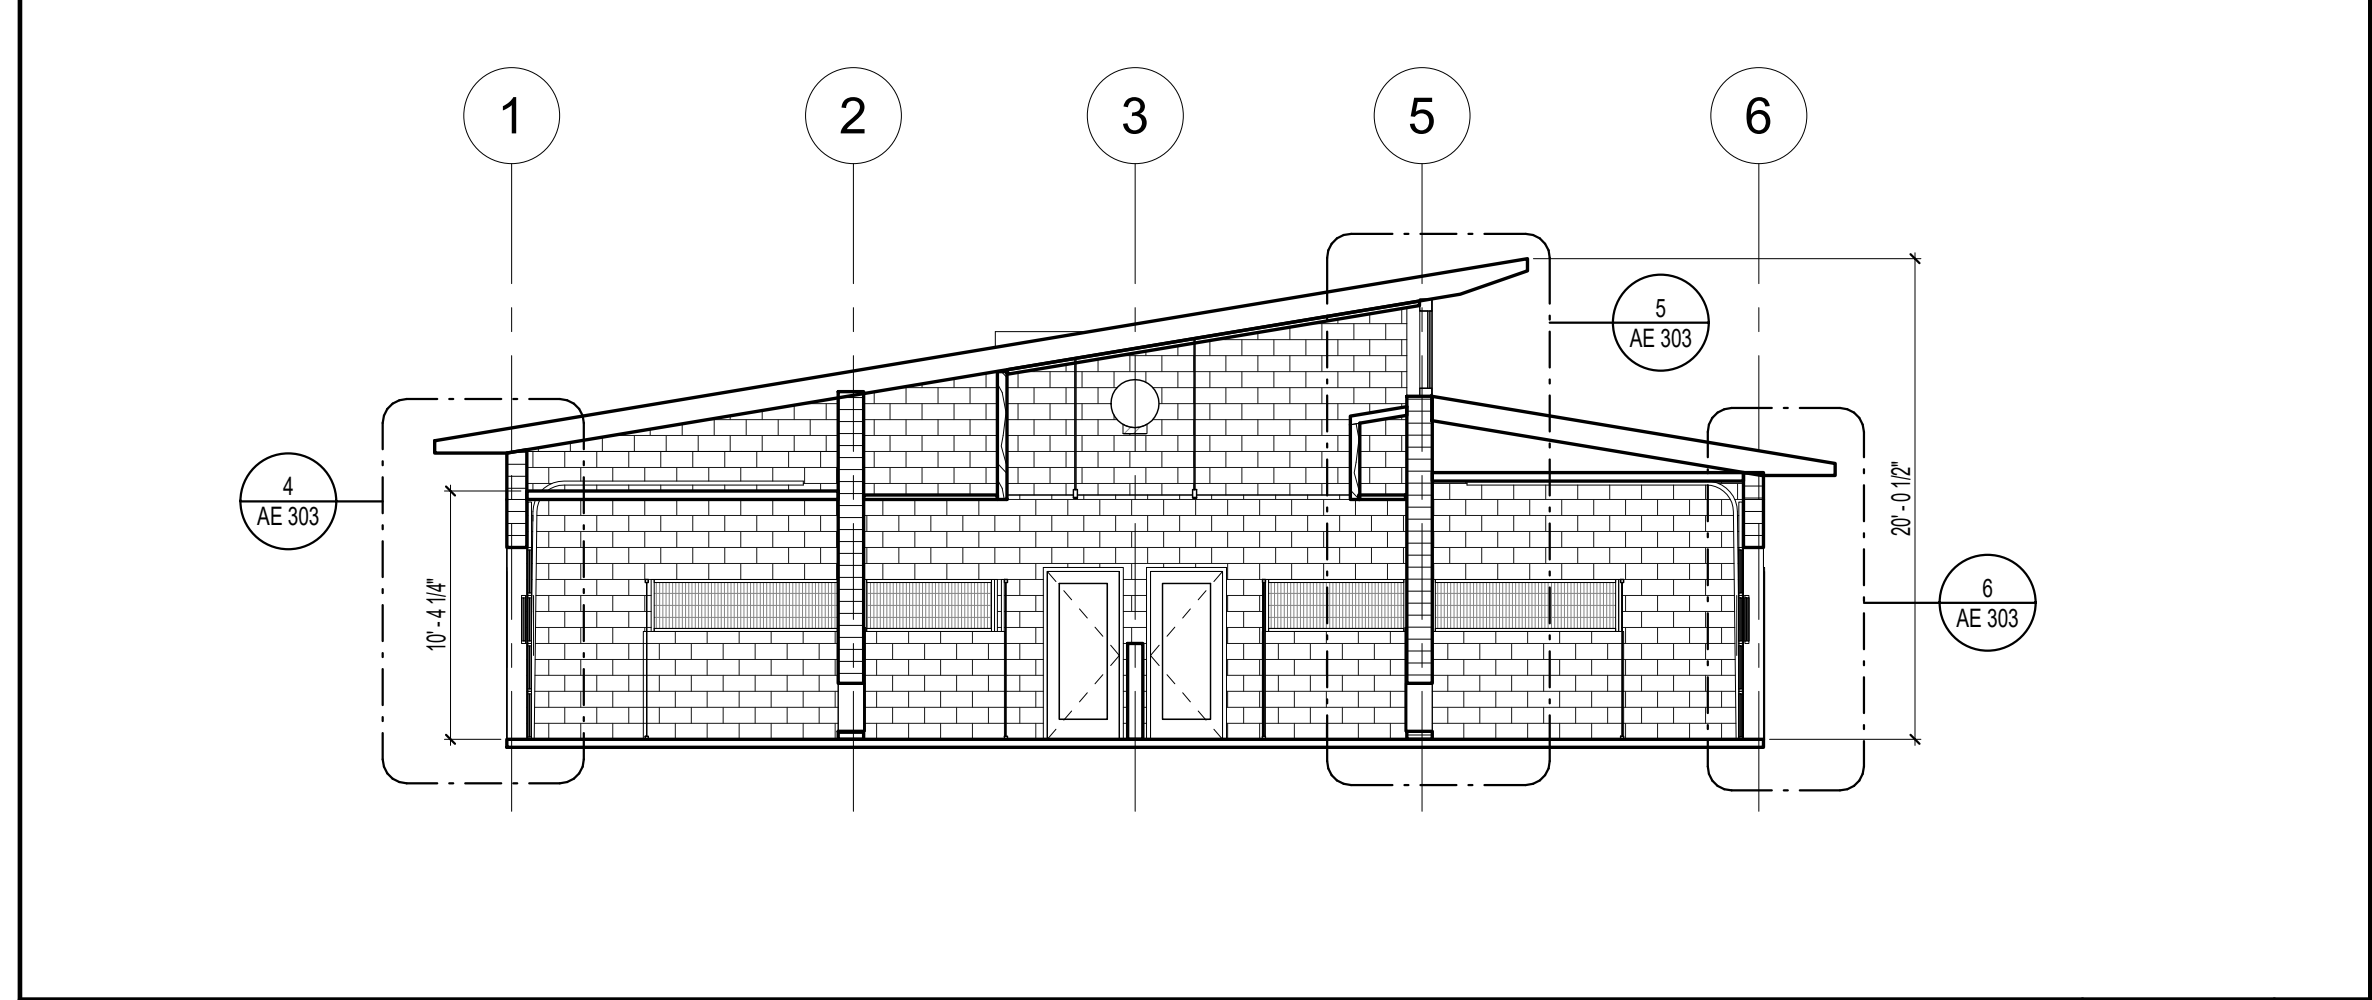

ADOPTION DOG BUILDINGS 5, 6, & 7 E/W SECTION 1

SCALE
1/8" = 1'-0"


1

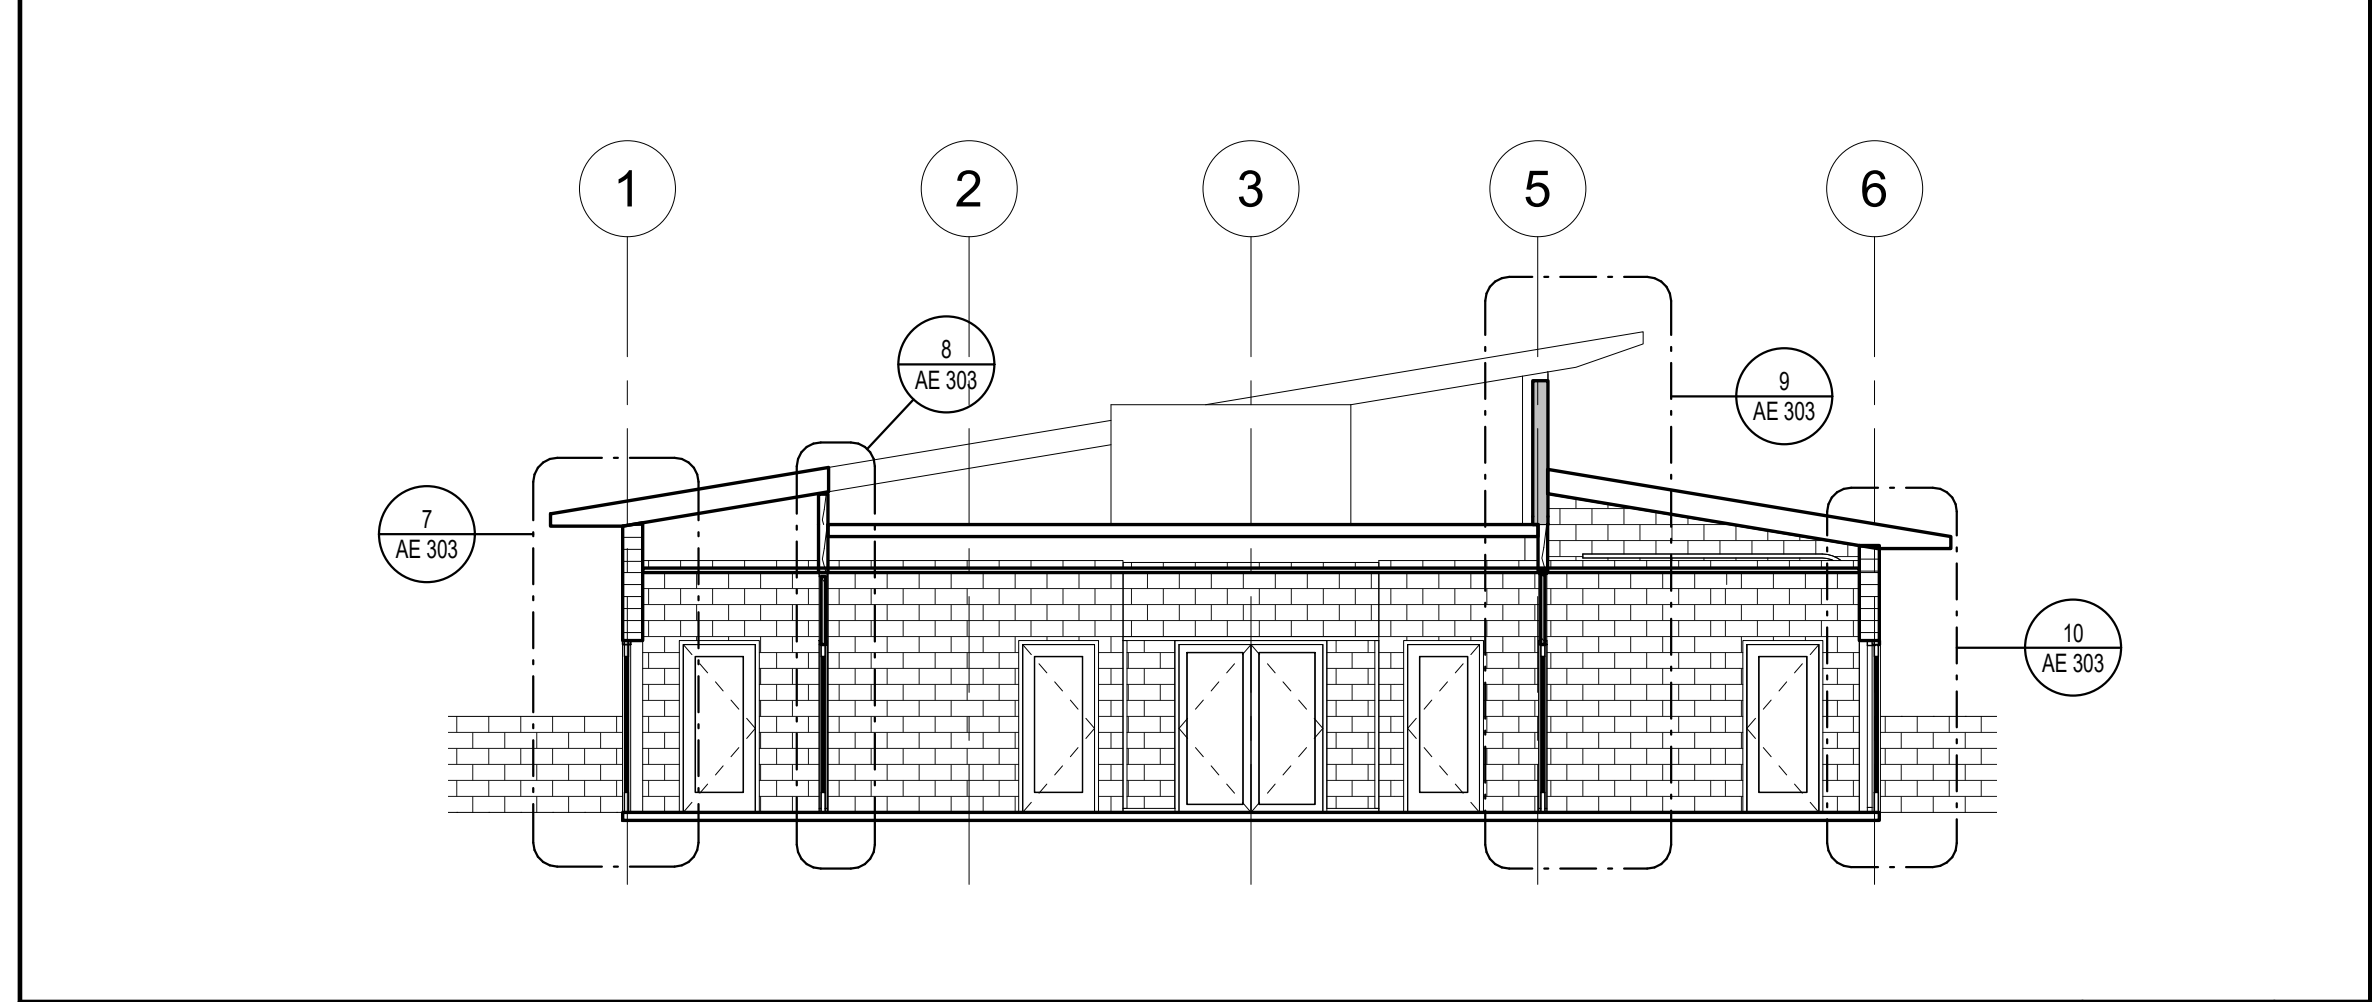

ADOPTION DOG BUILDINGS 5, 6, & 7 E/W SECTION 2

SCALE
1/8" = 1'-0"


2

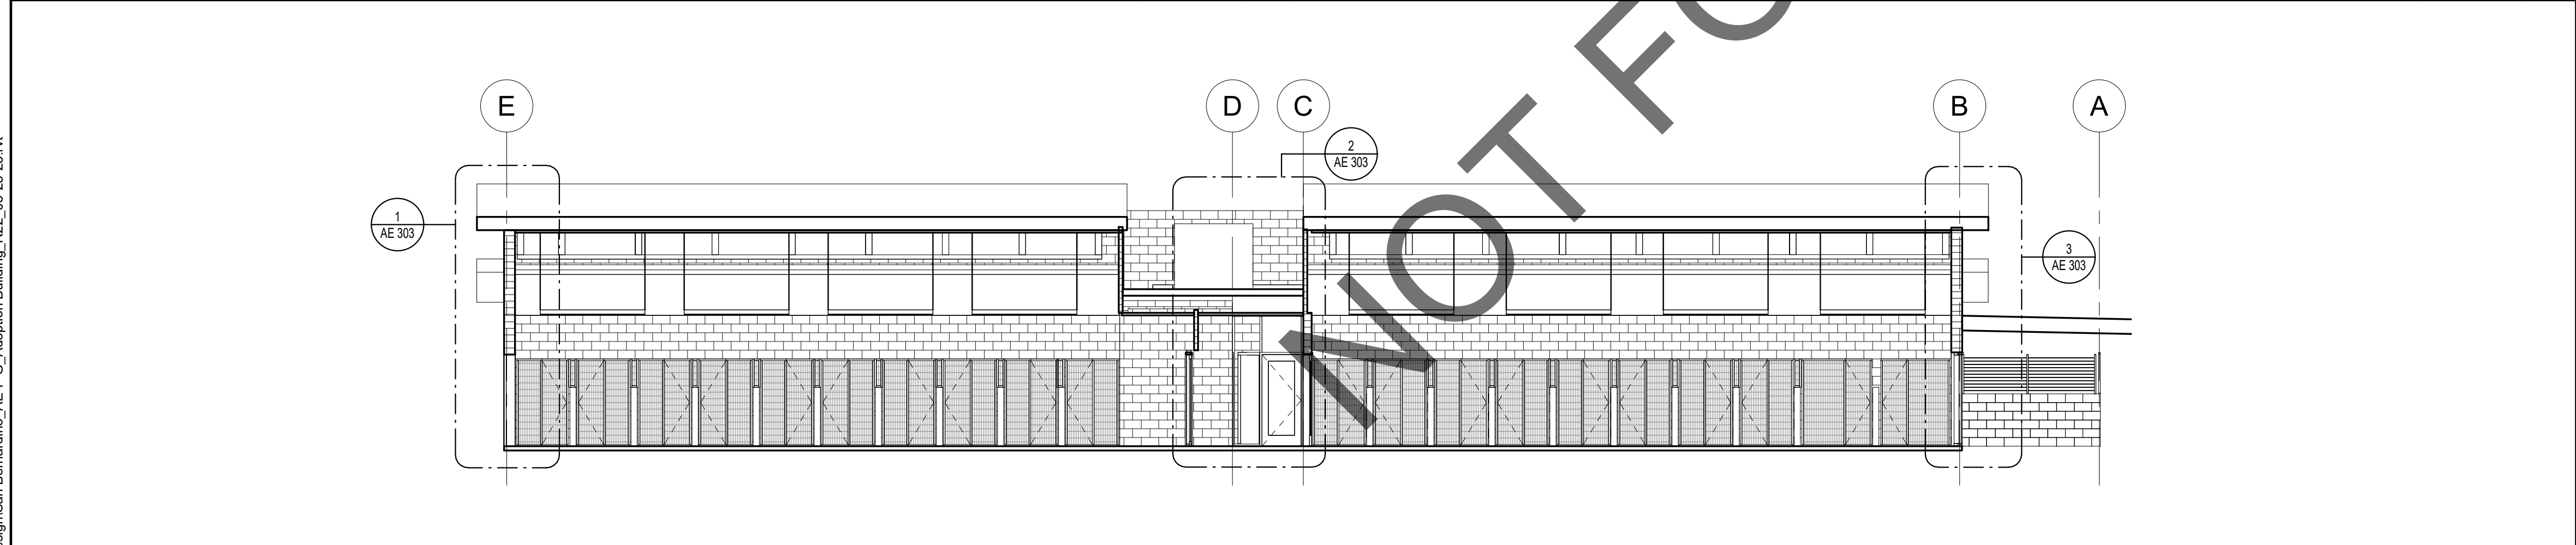

ADOPTION DOG BUILDINGS 5, 6, & 7 N/ S SECTION 3

SCALE
1/8" = 1'-0"

3

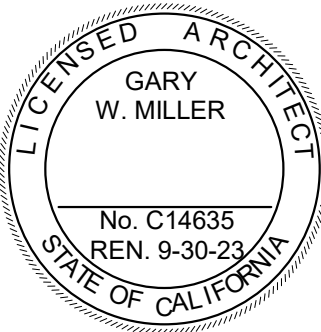

owner approval

initials	date	phase

REVISIONS/ADDENDA

#	Date	Comment
---	------	---------

ANIMAL CARE CENTER

18313 VALLEY BLVD. BLOOMINGTON, CA 92313

SAN BERNARDINO COUNTY

PROJECT INFORMATION


Project Number:	1227
Drawn By:	PF
Checked By:	GWM
Issue Date:	05/08/23

SHEET NAME


ADOPTION DOG
BUILDINGS 5, 6,
& 7 SECTIONS

SHEET NUMBER

AE 301

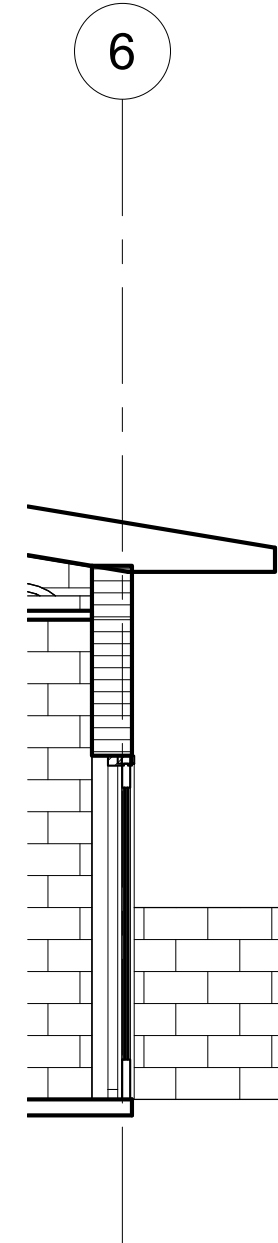


ADOPTION DOG BUILDINGS 5, 6, & 7 E/W WALL SECTION 10	SCALE	10
	1/4" = 1'-0"	

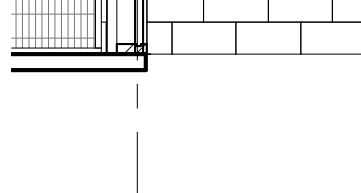				
2 ADOPTION DOG BUILDINGS 5, 6, & 7 N/S WALL SECTION 3	<table border="1"> <tr> <td data-bbox="1583 981 1660 997">SCALE</td> </tr> <tr> <td data-bbox="1583 997 1660 1015">1/4" = 1'-0"</td> </tr> </table>	SCALE	1/4" = 1'-0"	3 ADOPTION DOG BUILD SECTION 4
SCALE				
1/4" = 1'-0"				



1 FLOOR PLAN - STRAY DOG BUILDING
1/8" = 1'-0"

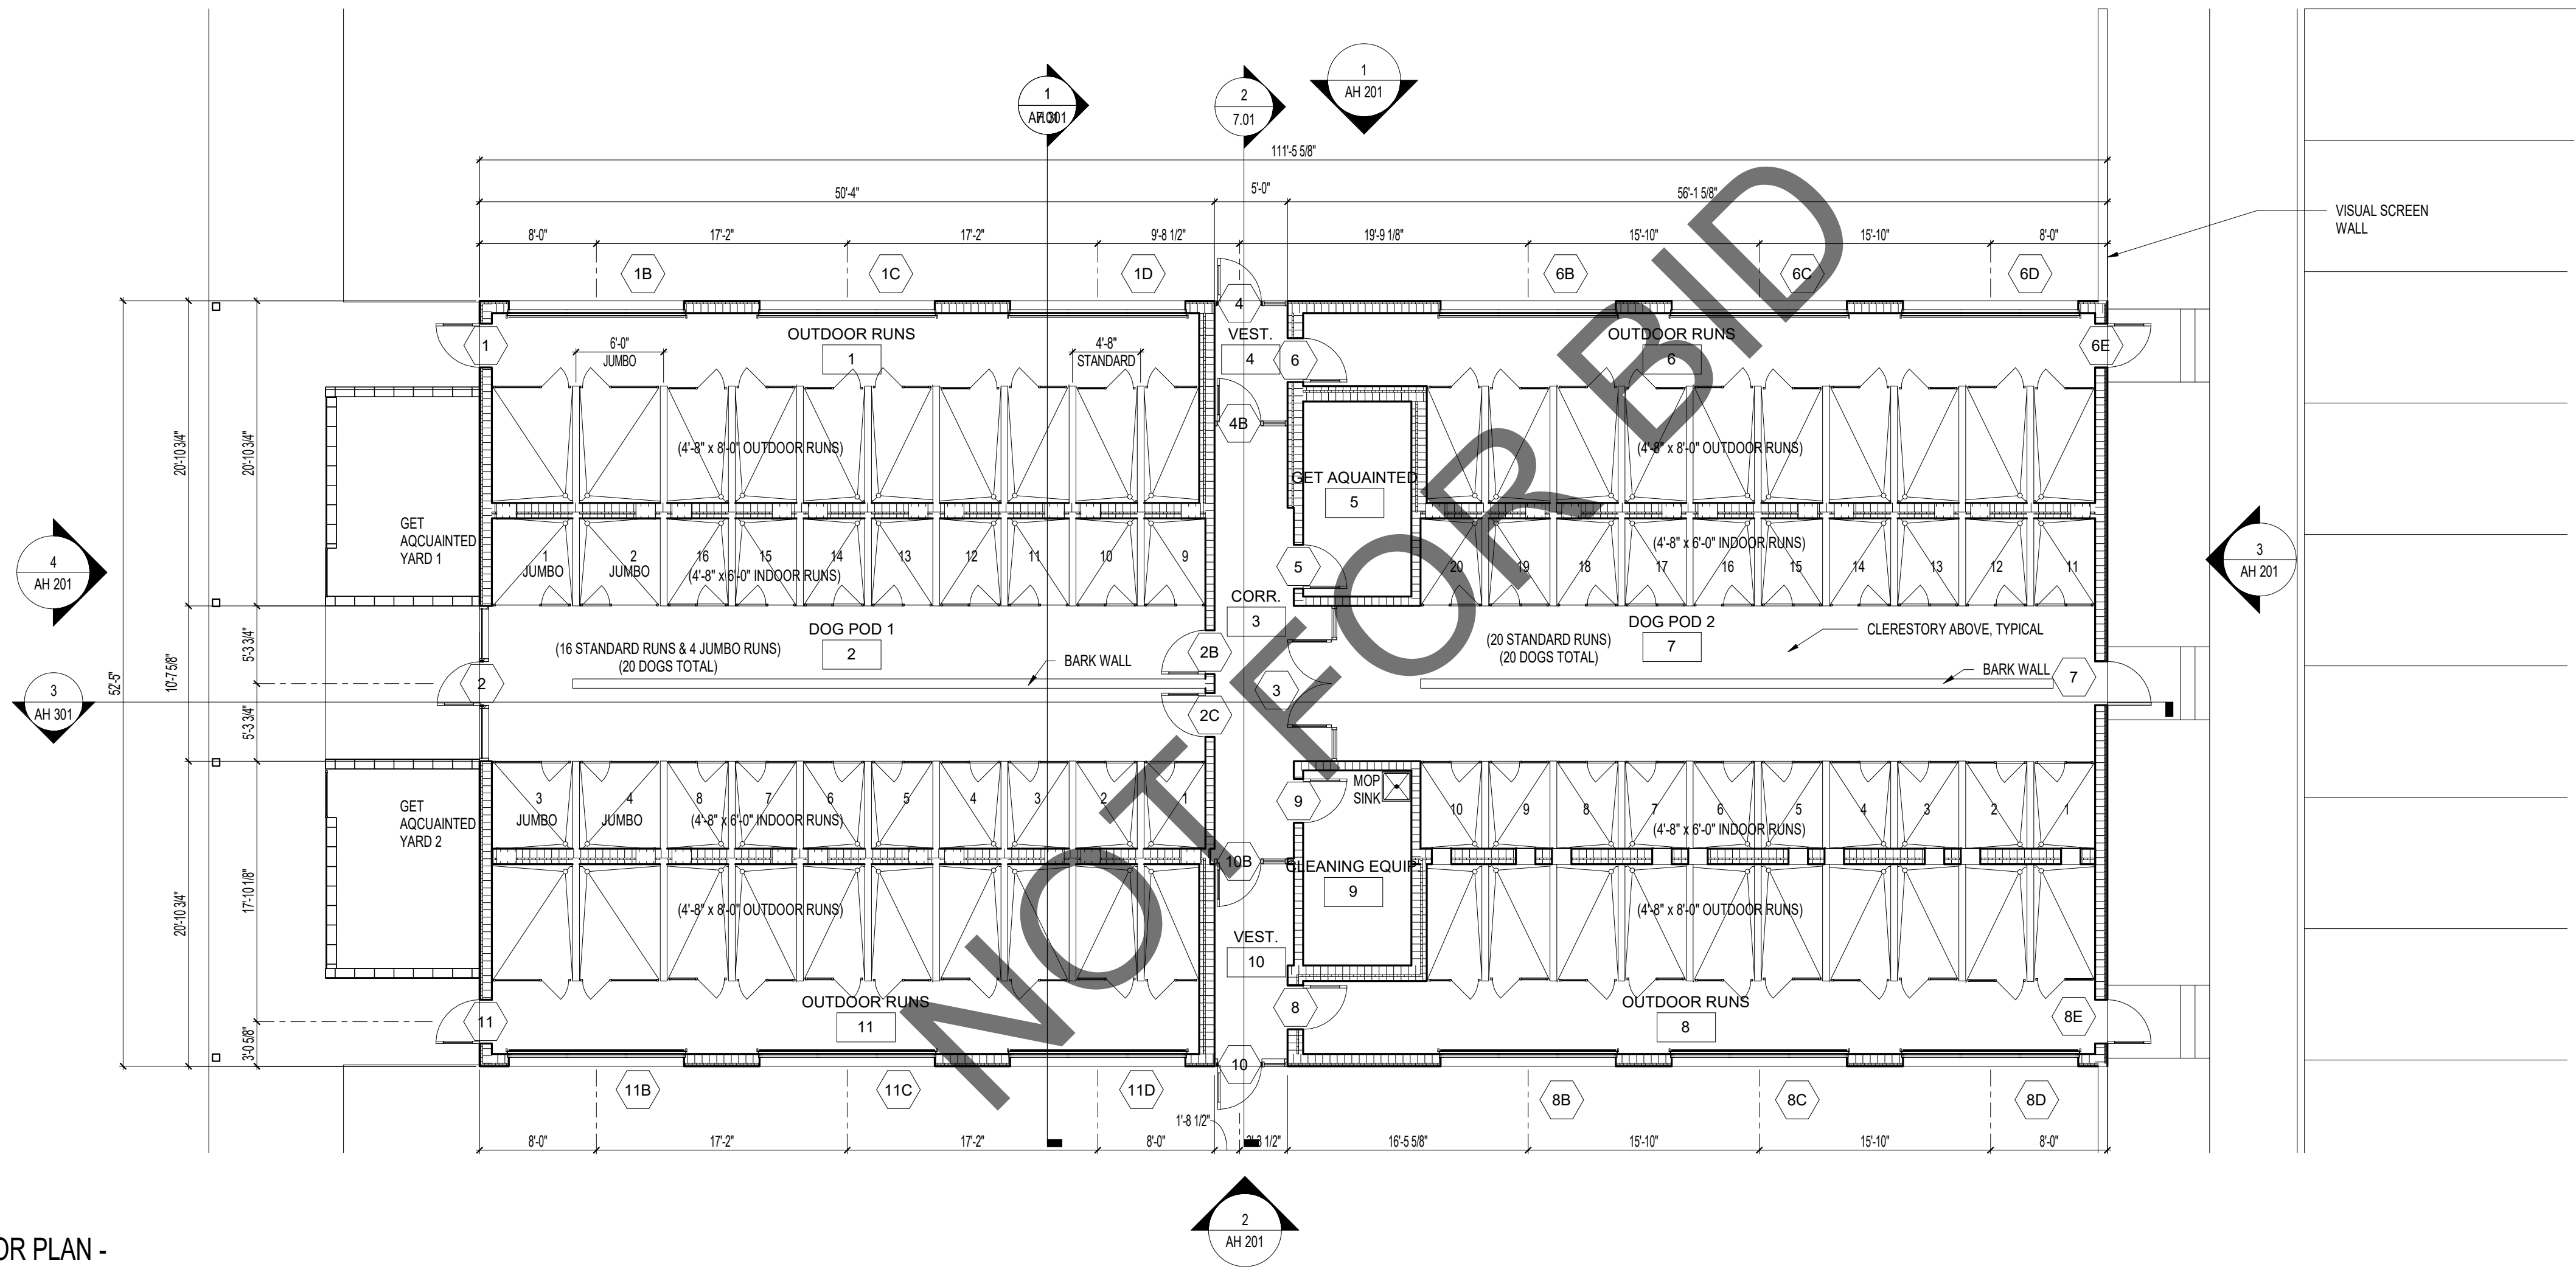

1177 Idaho Street, Suite 200
Redlands, CA 92374
Phone: 909-335-7400
Fax: 909-335-7299
info@miller-aip.com



owner approval		
initials	date	phase
revisions/addenda		
#	Date	Comment

ANIMAL CARE CENTER

18313 VALLEY BLVD. BLOOMINGTON, CA 92313


SAN BERNARDINO COUNTY

project information	
Project Number:	1227
Drawn By:	Author
Checked By:	MB
Issue Date:	05/08/23

sheet name
STRAY DOG BUILDING FLOOR PLAN

sheet number
AH 101
Sheet Of Sheets

1 STRAY DOG BUILDING REFLECTED
CEILING PLAN
1/8" = 1'-0"

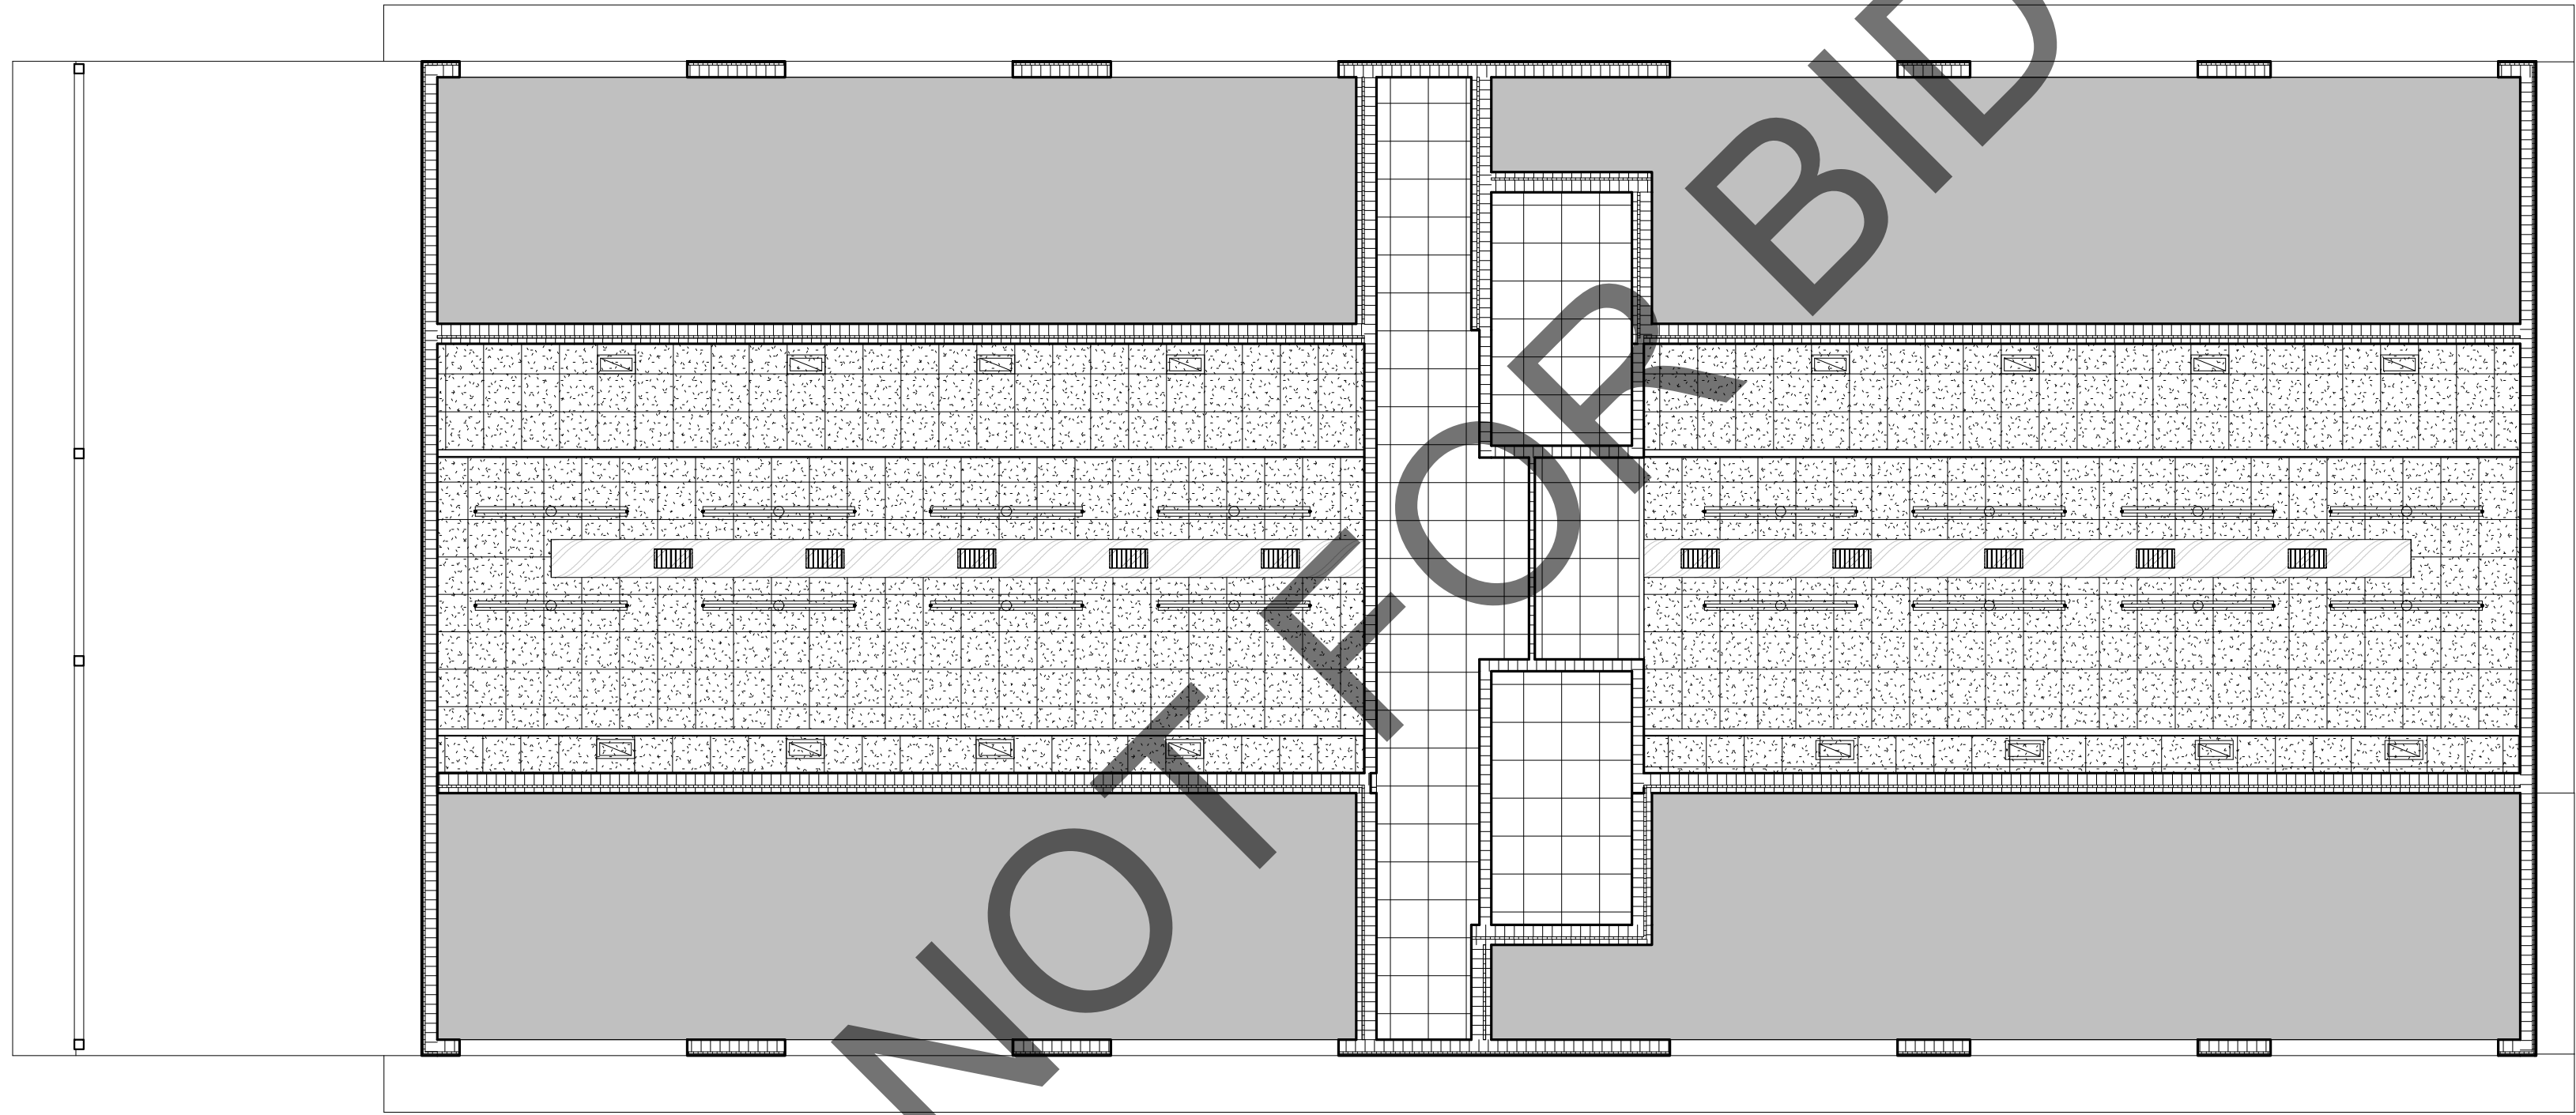

1177 Idaho Street, Suite 200
Redlands, CA 92374
Phone: 909-335-7400
Fax: 909-335-7299
info@miller-aip.com




owner approval		
initials	date	phase
revisions/addenda		
#	Date	Comment

ANIMAL CARE CENTER
18313 VALLEY BLVD. BLOOMINGTON, CA 92313
SAN BERNARDINO COUNTY

project information	
Project Number:	1227
Drawn By:	Author
Checked By:	MB
Issue Date:	05/08/23

sheet name	
STRAY DOG BUILDING RCP	
sheet number	
AH 103	
Sheet	Of Sheets

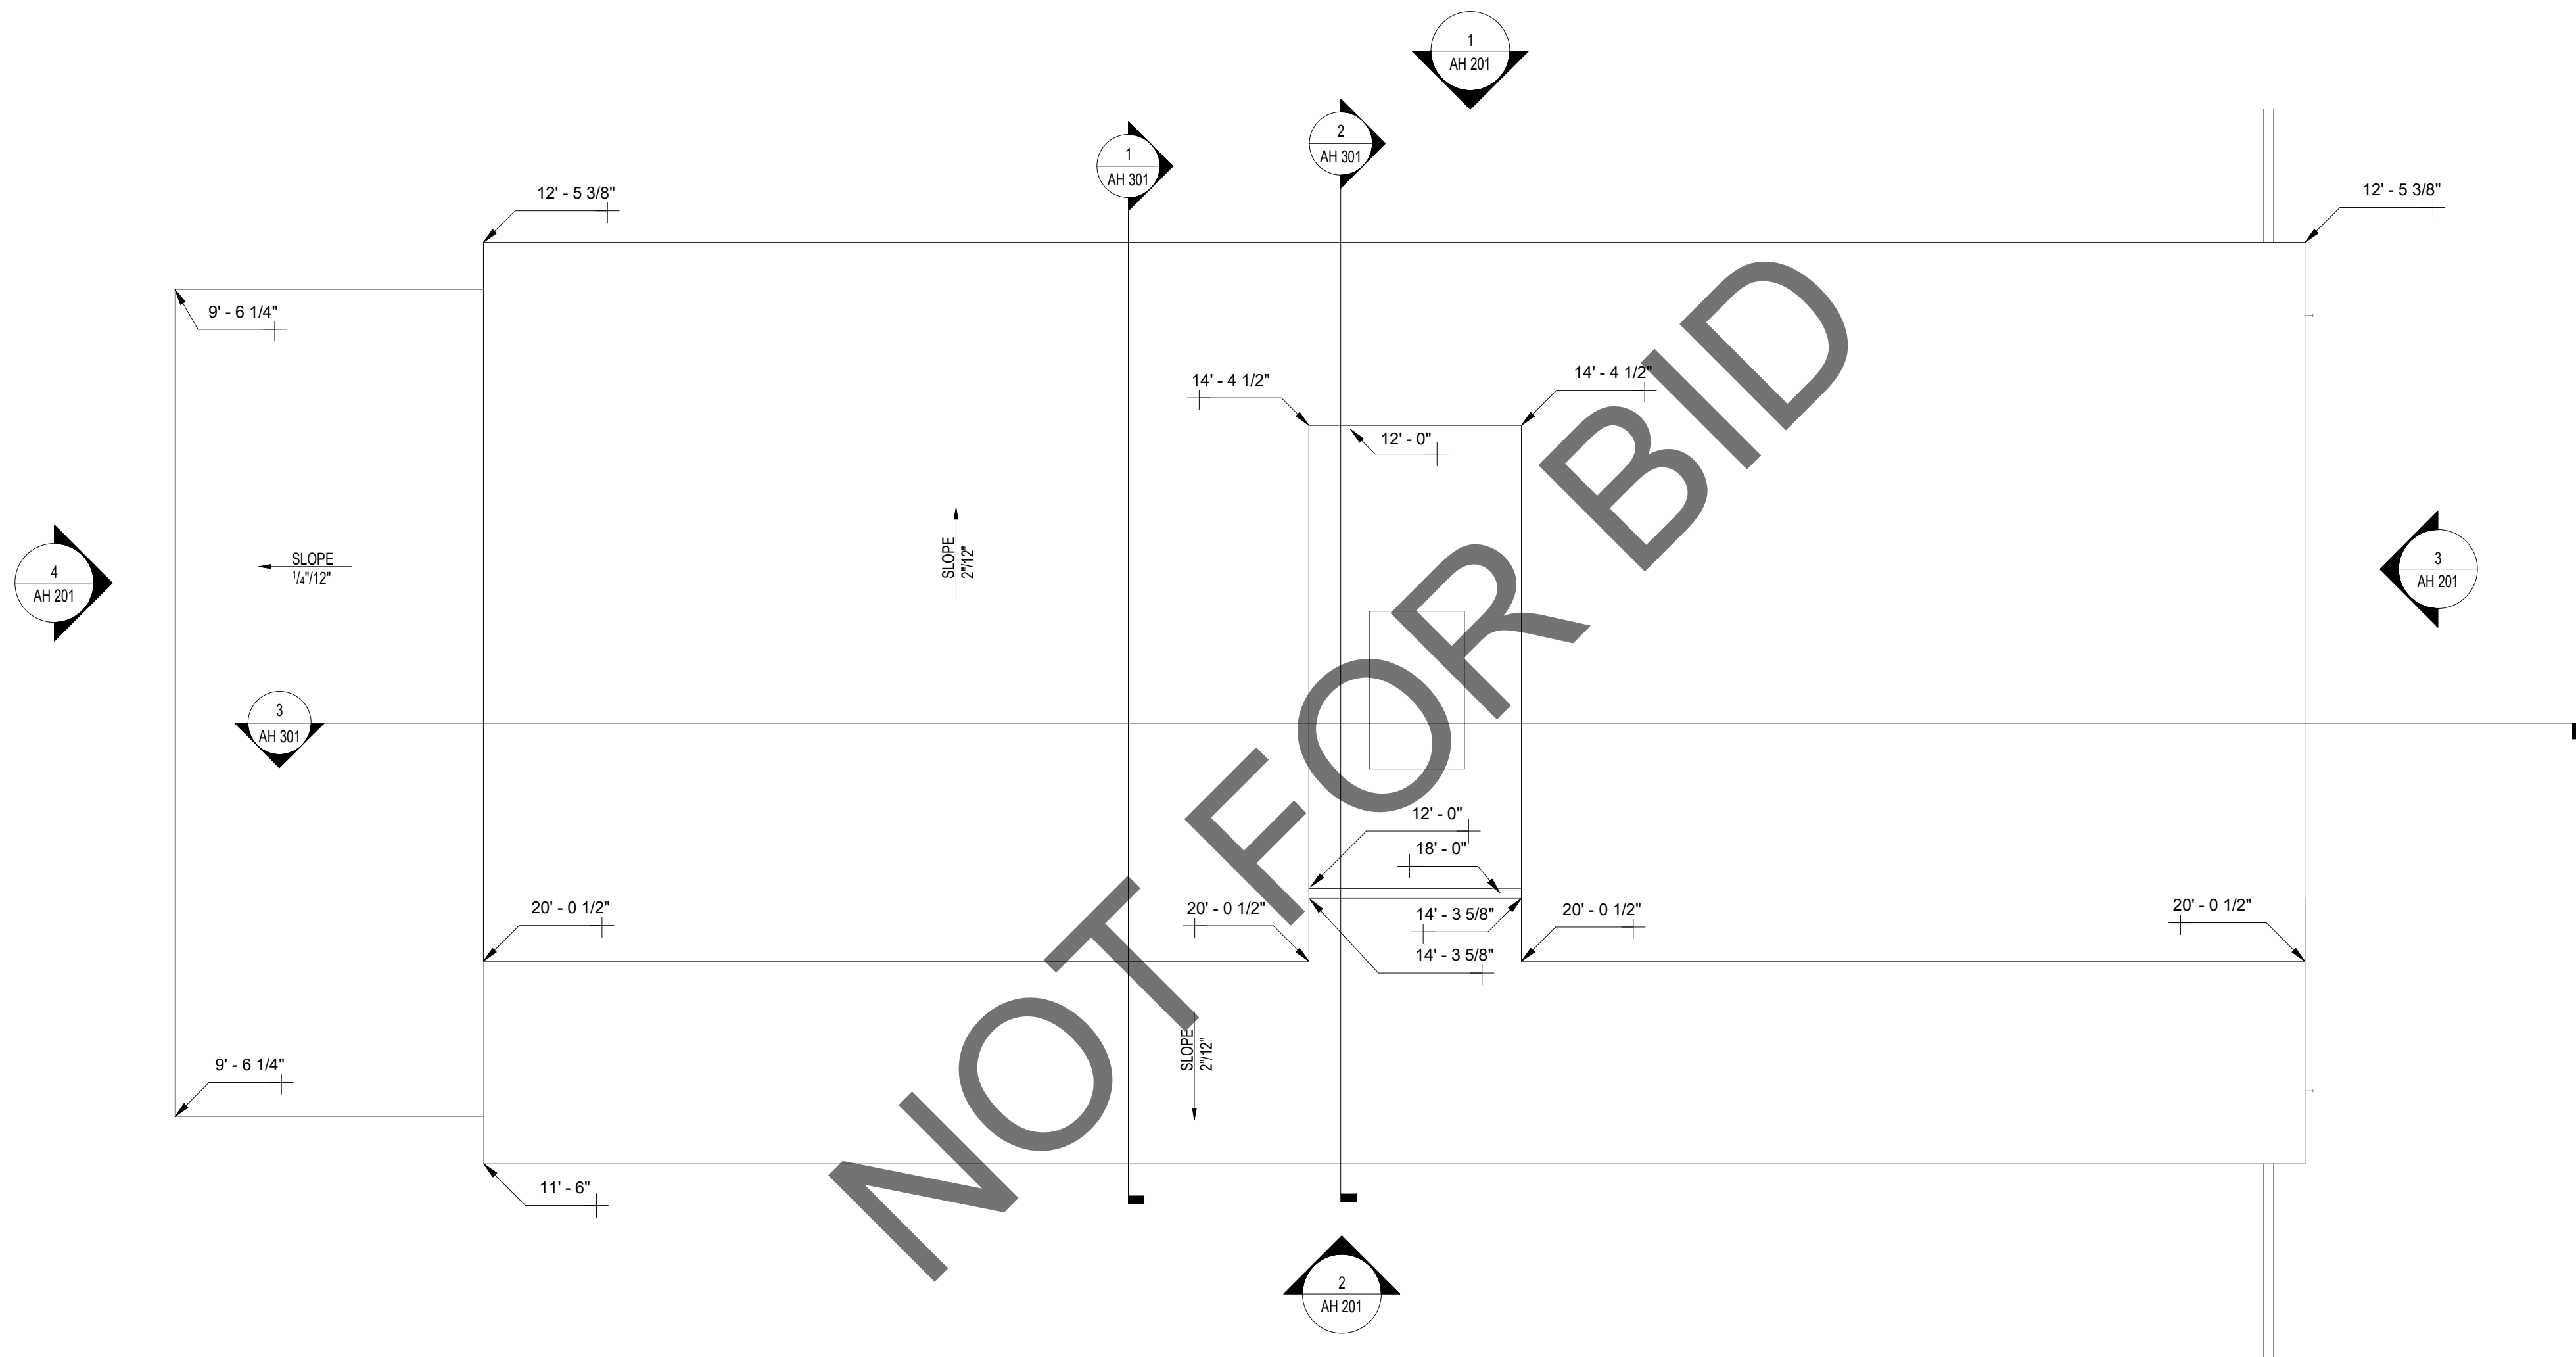

1 STRAY DOG BUILDING 8 ROOF PLAN
1/8" = 1'-0"



1177 Idaho Street, Suite 200
Redlands, CA 92374
Phone: 909-335-7400
Fax: 909-335-7299
info@miller-aip.com



owner approval		
initials	date	phase
revisions/addenda		
#	Date	Comment

ANIMAL CARE CENTER

18313 VALLEY BLVD. BLOOMINGTON, CA 92313

SAN BERNARDINO COUNTY

project information	
Project Number:	1227
Drawn By:	Author
Checked By:	MB
Issue Date:	05/08/23

sheet name
STRAY DOG BUILDING ROOF PLAN

sheet number
AH 105
Sheet Of Sheets


1 STRAY DOG BUILDING NORTH ELEVATION
1/8" = 1'-0"




2 STRAY DOG BUILDING SOUTH ELEVATION
1/8" = 1'-0"




3 STRAY DOG BUILDING EAST ELEVATION
1/8" = 1'-0"

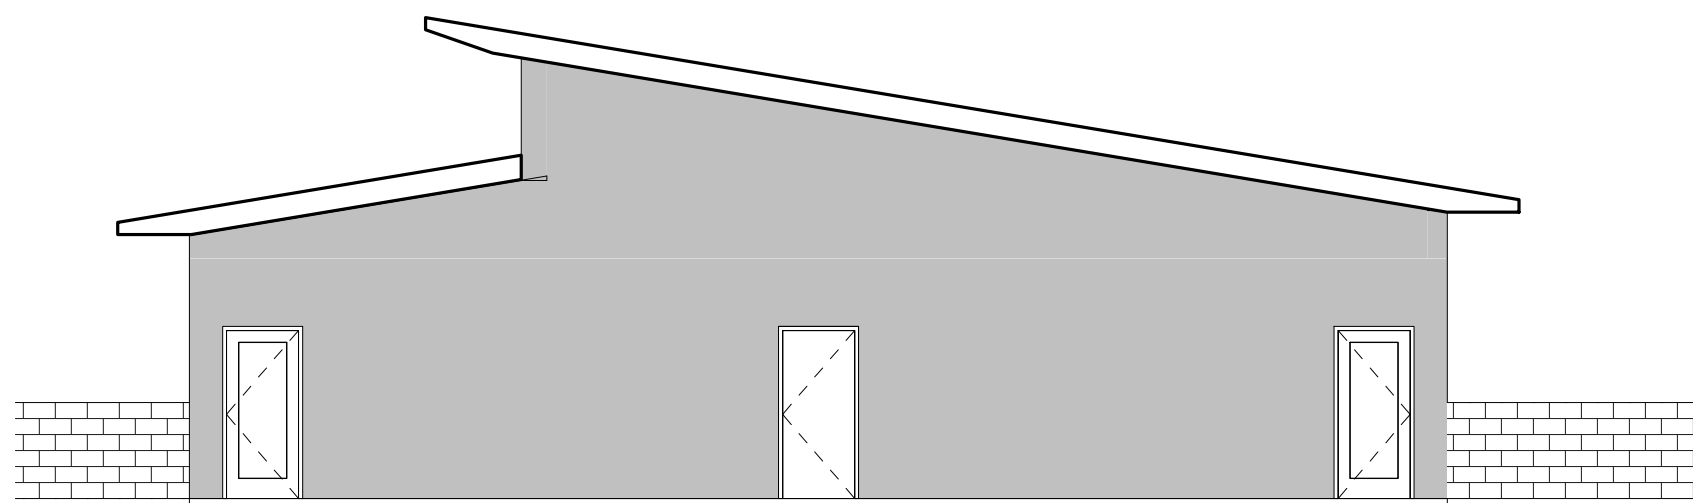

4 STRAY DOG BUILDING WEST ELEVATION
1/8" = 1'-0"

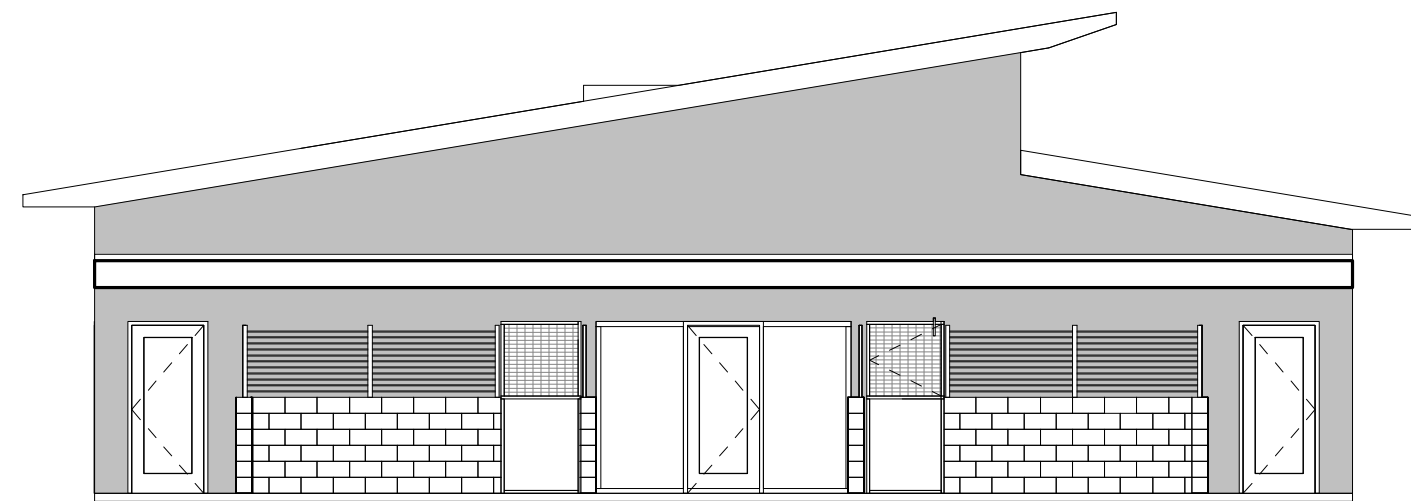

1177 Idaho Street, Suite 200
Redlands, CA 92374
Phone: 909-335-7400
Fax: 909-335-7299
info@miller-aip.com

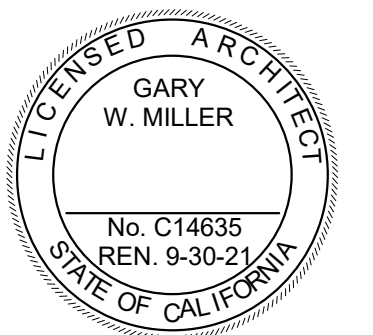

owner approval		
initials	date	phase
revisions/addenda		
#	Date	Comment

ANIMAL CARE CENTER

18313 VALLEY BLVD. BLOOMINGTON, CA 92313

SAN BERNARDINO COUNTY


project information	
Project Number:	1227
Drawn By:	Author
Checked By:	MB
Issue Date:	05/08/23

sheet name
STRAY DOG BUILDING EXT. ELEV.


sheet number
AH 201
Sheet Of Sheets




1
STRAY DOG BUILDING E/W
SECTION 1
1/8" = 1'-0"

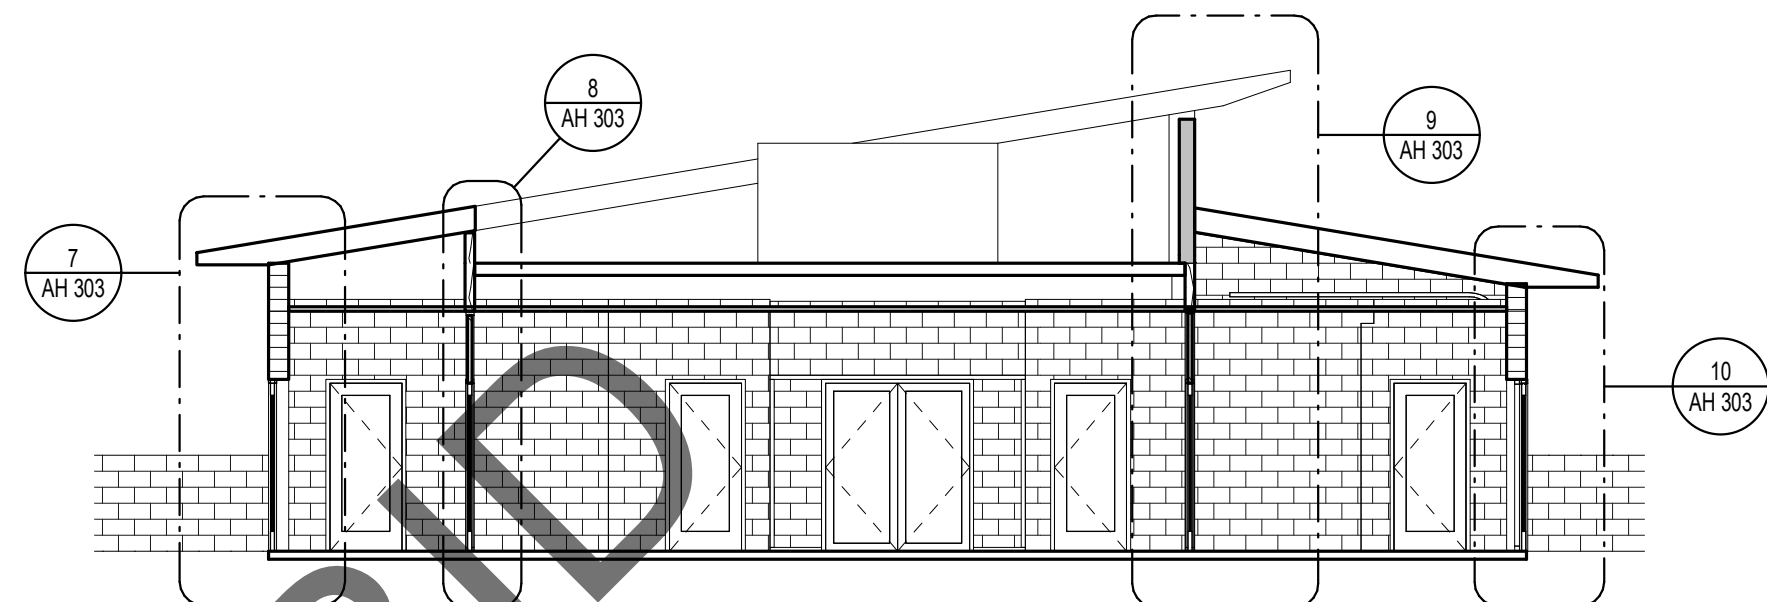

2
STRAY DOG BUILDING E/W
SECTION 2
1/8" = 1'-0"

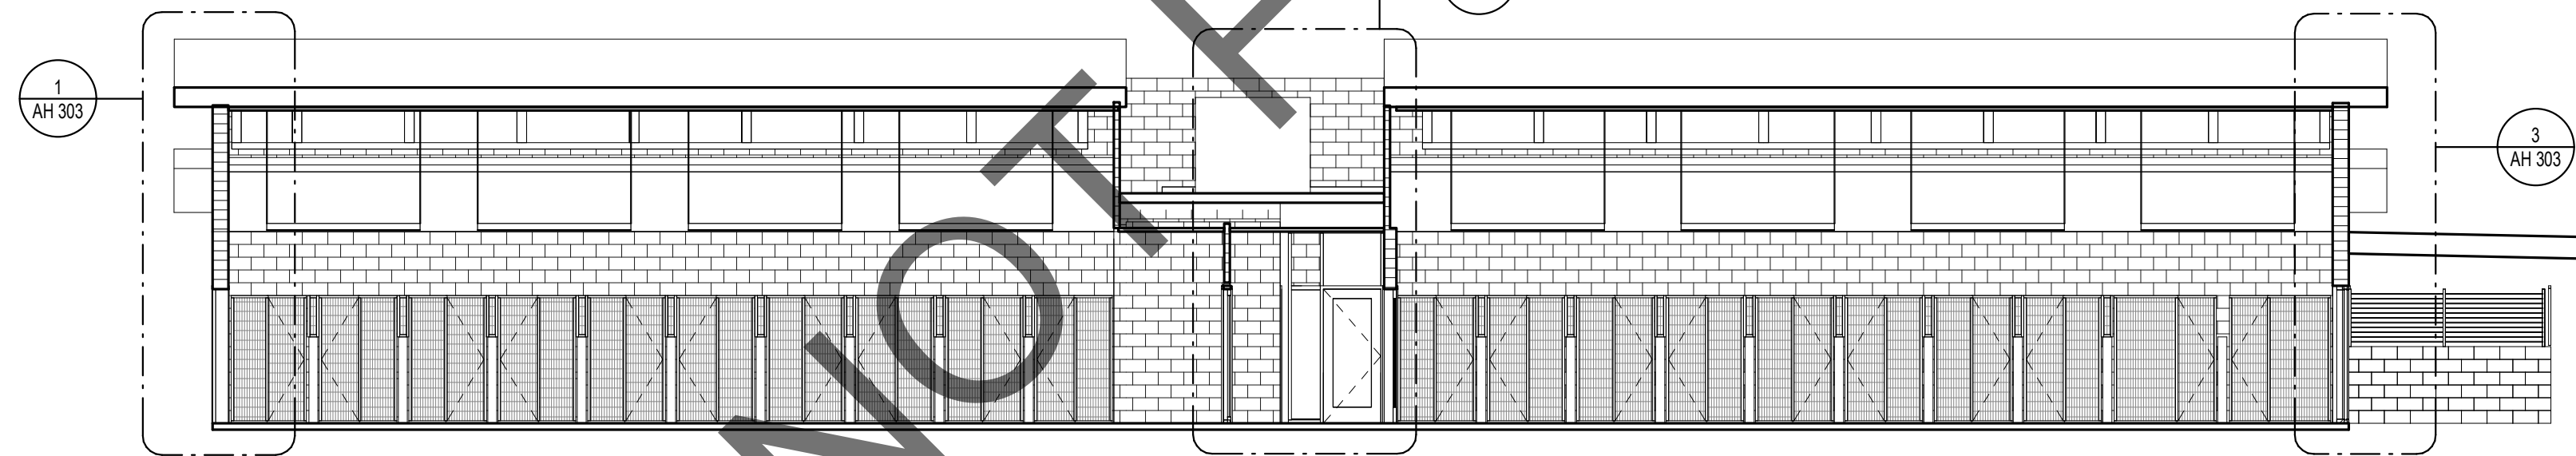

3
STRAY DOG BUILDING N/ S
SECTION 3
1/8" = 1'-0"

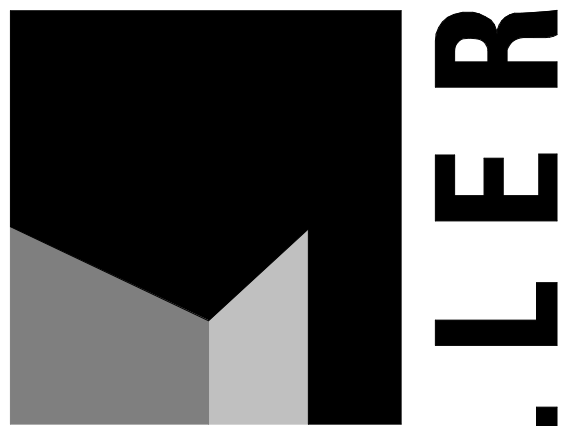

architecture
interiors
planning

MILLER



1177 Idaho Street, Suite 200
Redlands, CA 92374
Phone: 909-335-7400
Fax: 909-335-7299
info@miller-aip.com



owner approval

initials	date	phase

revisions/addenda

#	Date	Comment
---	------	---------

ANIMAL CARE CENTER

18313 VALLEY BLVD. BLOOMINGTON, CA 92313

SAN BERNARDINO COUNTY

project information

Project Number:	1227
Drawn By:	Author
Checked By:	MB
Issue Date:	05/08/23


sheet name

STRAY DOG
BUILDING
SECTIONS


sheet number

AH 301


Sheet Of Sheets

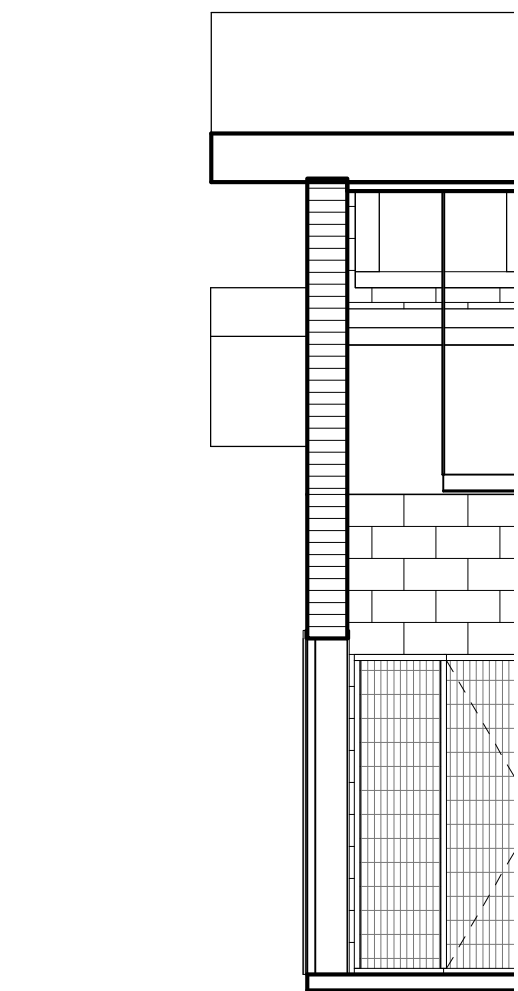


1 STRAY DOG BUILDING N/S WALL
SECTION 1
1/4" = 1'-0"

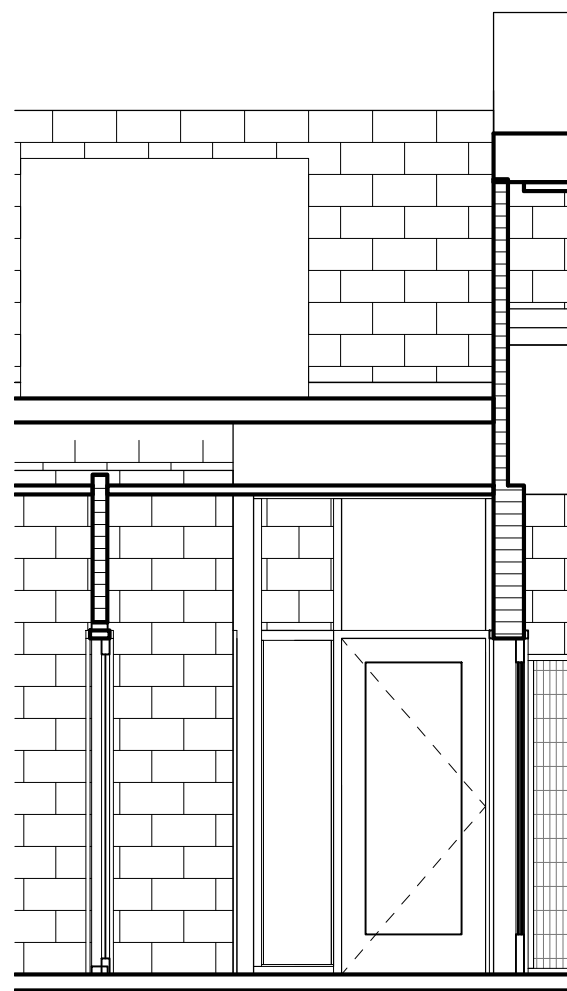


2 STRAY DOG BUILDING N/S WALL
SECTION 2
1/4" = 1'-0"

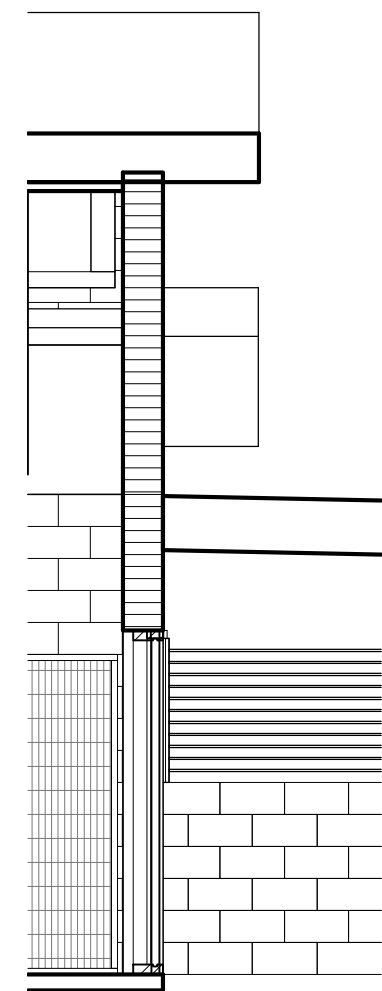


3 STRAY DOG BUILDING N/S WALL
SECTION 3
1/4" = 1'-0"

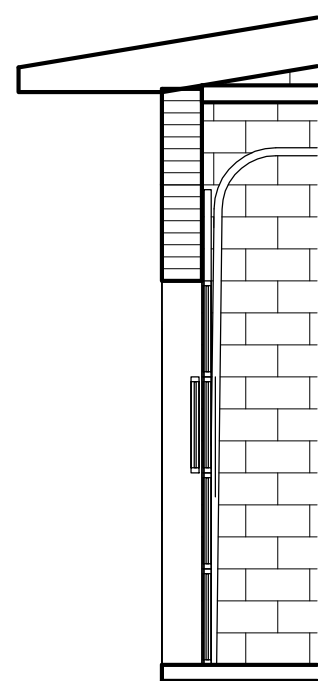


4 STRAY DOG BUILDING E/W WALL
SECTION 4
1/4" = 1'-0"

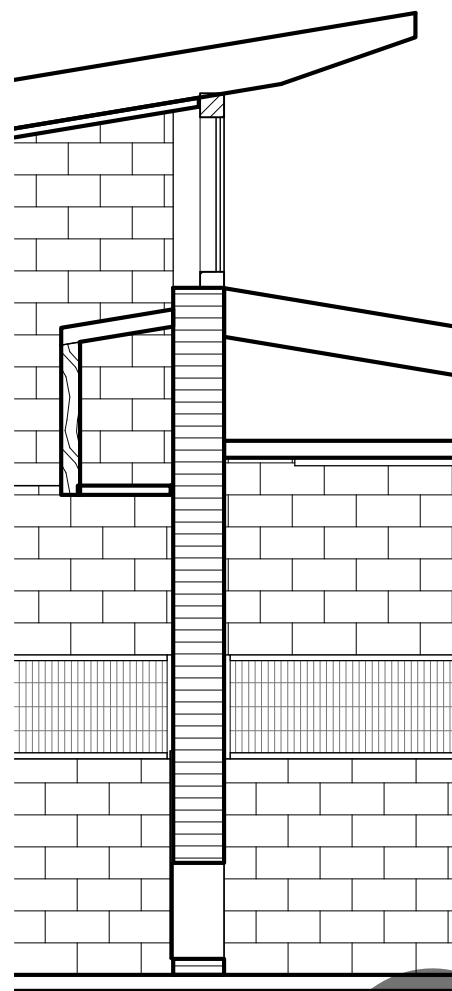


5 STRAY DOG BUILDING E/W WALL
SECTION 5
1/4" = 1'-0"

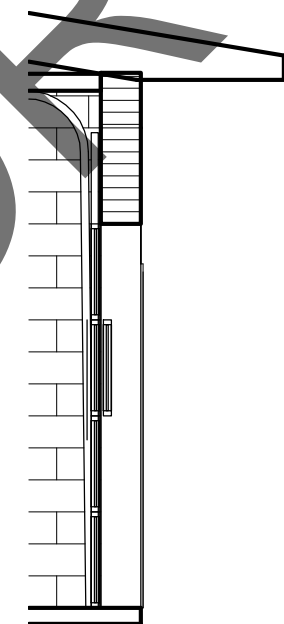


6 STRAY DOG BUILDING E/W WALL
SECTION 6
1/4" = 1'-0"

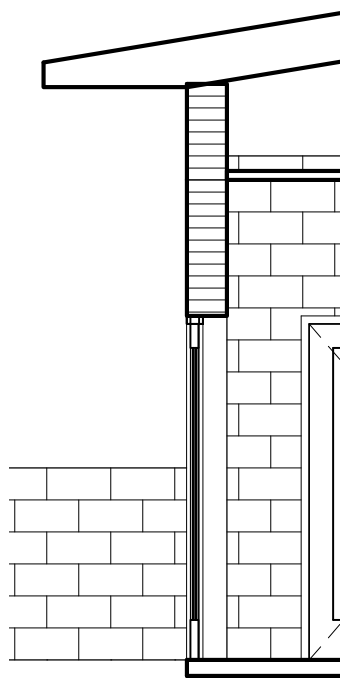


7 STRAY DOG BUILDING E/W WALL
SECTION 7
1/4" = 1'-0"

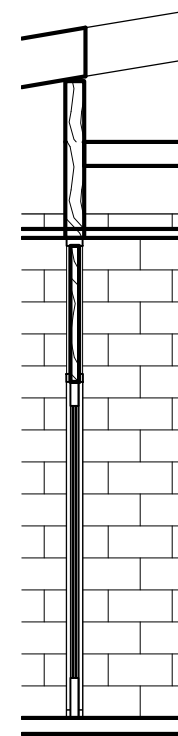

8 STRAY DOG BUILDING E/W WALL
SECTION 8
1/4" = 1'-0"

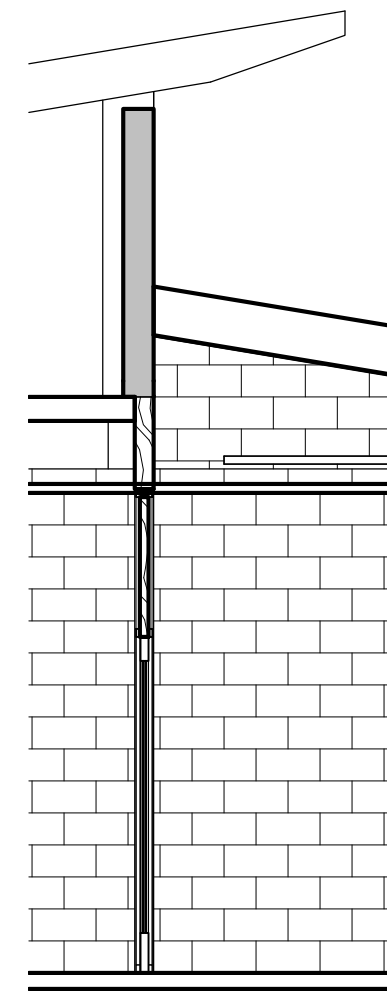


9 STRAY DOG BUILDING E/W WALL
SECTION 9
1/4" = 1'-0"

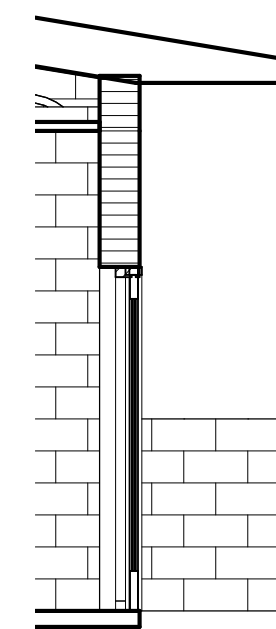

10 STRAY DOG BUILDING E/W WALL
SECTION 10
1/4" = 1'-0"



1177 Idaho Street, Suite 200
Redlands, CA 92374
Phone: 909-335-7400
Fax: 909-335-7299
info@millar-aip.com

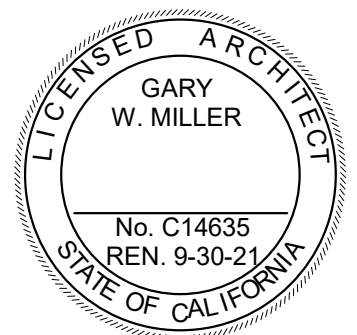

owner approval		
initials	date	phase
revisions/addenda		
#	Date	Comment

ANIMAL CARE CENTER
18313 VALLEY BLVD. BLOOMINGTON, CA 92313
SAN BERNARDINO COUNTY


project information	
Project Number:	1227
Drawn By:	Author
Checked By:	MB
Issue Date:	05/08/23

sheet name
STRAY DOG BUILDING WALL SECTIONS

sheet number
AH 303
Sheet Of Sheets

DOOR SCHEDULE - STANDARD											
DOOR NUMBER	DOOR TYPE	DOORS				FRAME			CARD READER	HARDWA RE SET	REMARKS
		WIDTH	HEIGHT	MATE RIAL	GLASS	ELEV	MATER IAL	GLAS S			
7	F2	3'-0"	7'-0"	STEEL	YES		STEEL				
3	F25	6'-0"	7'-0"	STEEL	NO		STEEL				
11C	F37	12'-0"	8'-0"								
11B	F37	12'-0"	8'-0"								
11D	F37	12'-0"	8'-0"								
1C	F37	12'-0"	8'-0"								
1B	F37	12'-0"	8'-0"								
1D	F37	12'-0"	8'-0"								
8C	F37	12'-0"	8'-0"								
8D	F37	12'-0"	8'-0"								
8B	F37	12'-0"	8'-0"								
6C	F37	12'-0"	8'-0"								
6B	F37	12'-0"	8'-0"								
6D	F37	12'-0"	8'-0"								
5	FG2	3'-0"	7'-0"	STEEL	YES		STEEL				
9	FG2	3'-0"	7'-0"	STEEL	YES		STEEL				
8	FG2	3'-0"	7'-0"	STEEL			STEEL				
6	FG2	3'-0"	7'-0"	STEEL			STEEL				
8E	FG2	3'-0"	7'-0"	STEEL			STEEL				
6E	FG2	3'-0"	7'-0"	STEEL			STEEL				
11	FG2	3'-0"	7'-0"	STEEL			STEEL				
1	FG2	3'-0"	7'-0"	STEEL			STEEL				
2	FG2	3'-0"	7'-0"	STEEL			STEEL				
2B	FG2	3'-0"	7'-0"	STEEL			STEEL				
2C	FG2	3'-0"	7'-0"	STEEL			STEEL				
10	FG4	3'-0"	7'-0"	FBG			FBG				
4	FG4	3'-0"	7'-0"	FBG			FBG				
10B	FG4	3'-0"	7'-0"	FBG			FBG				
4B	FG4	3'-0"	7'-0"	FBG			FBG				

DOOR TYPES SCHEDULE								
DOOR TYPE	DOORS			FRAME			REMARKS	
	WIDTH	HEIGHT	MATERIAL	GLASS	ELEVATION	MATERIAL		
D	<varies>	<varies>						
F2	3'-0"	7'-0"	STEEL	YES		STEEL		
F25	6'-0"	7'-0"	STEEL	NO		STEEL		
F26	3'-0"	3'-0"						
F37	12'-0"	8'-0"						
F02	3'-0"	7'-0"	STEEL	<varies>		STEEL		
F04	3'-0"	7'-0"	FBG			FBG		

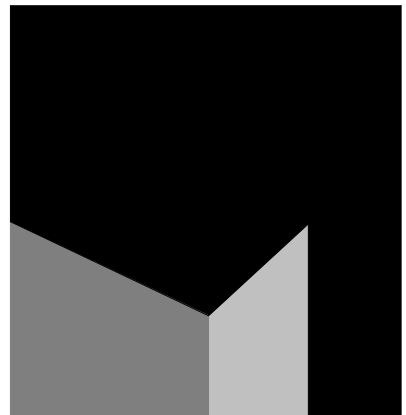

architecture
interiors
planning

MILLER



1177 Idaho Street, Suite 200
Redlands, CA 92374
Phone: 909-335-7400
Fax: 909-335-7299
info@miller-aip.com



owner approval

initials	date	phase

revisions/addenda

#	Date	Comment

ANIMAL CARE CENTER

18313 VALLEY BLVD. BLOOMINGTON, CA 92313

SAN BERNARDINO COUNTY

project information

Project Number:	1227
Drawn By:	Author
Checked By:	MB
Issue Date:	05/08/23

sheet name


STRAY DOG
WIN./ DOOR
SCHEDULES

sheet number

AH 601

Sheet Of Sheets

Keynote Legend	
Key Value	Keynote Text

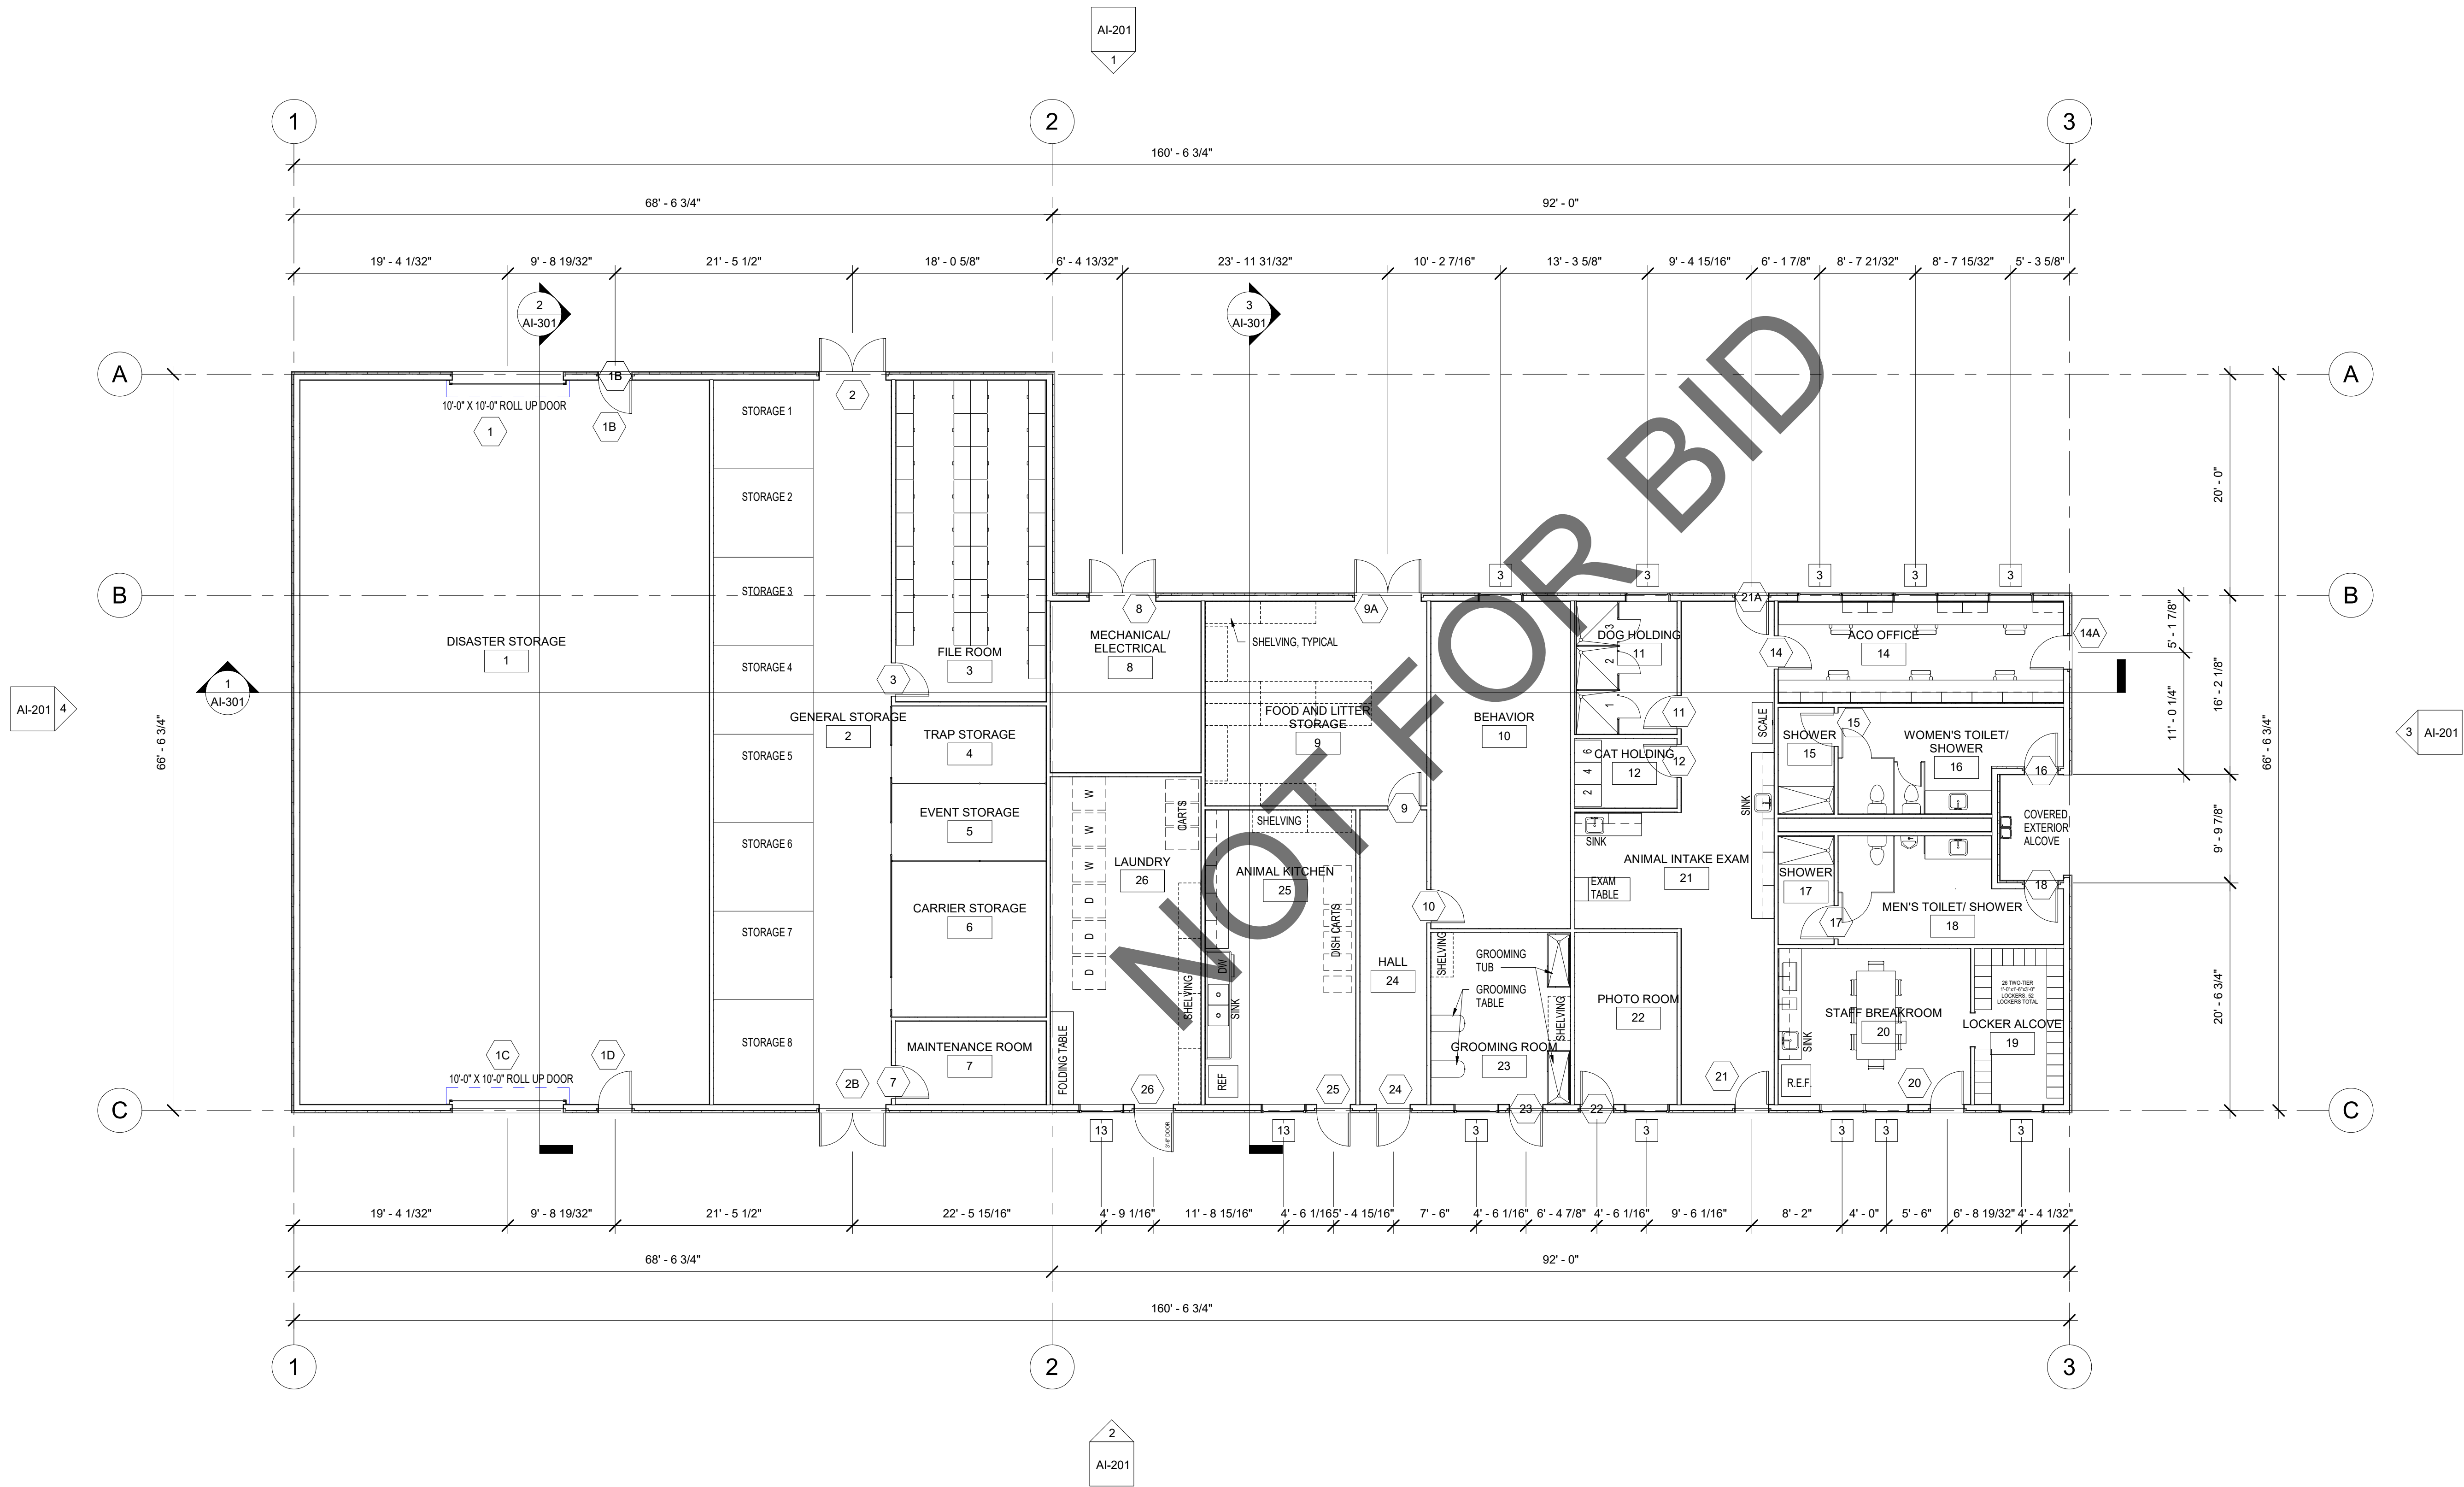

1177 Idaho Street, Suite 200
Redlands, CA 92374
Phone: 909-335-7400
Fax: 909-335-7299
info@miller-aip.com



owner approval		
initials	date	phase
revisions/addenda		
#	Date	Comment

ANIMAL CARE CENTER

18313 VALLEY BLVD.
BLOOMINGTON, CA 92313
SAN BERNARDINO COUNTY

385 N. Arrowhead Ave., 3rd Floor
San Bernardino, CA 92415


project information	
Project Number:	2200065
Drawn By:	Author
Checked By:	MB
Issue Date:	Issue Date

sheet name


FIRST FLOOR
PLAN

sheet number

AI-101
Sheet Of Sheets

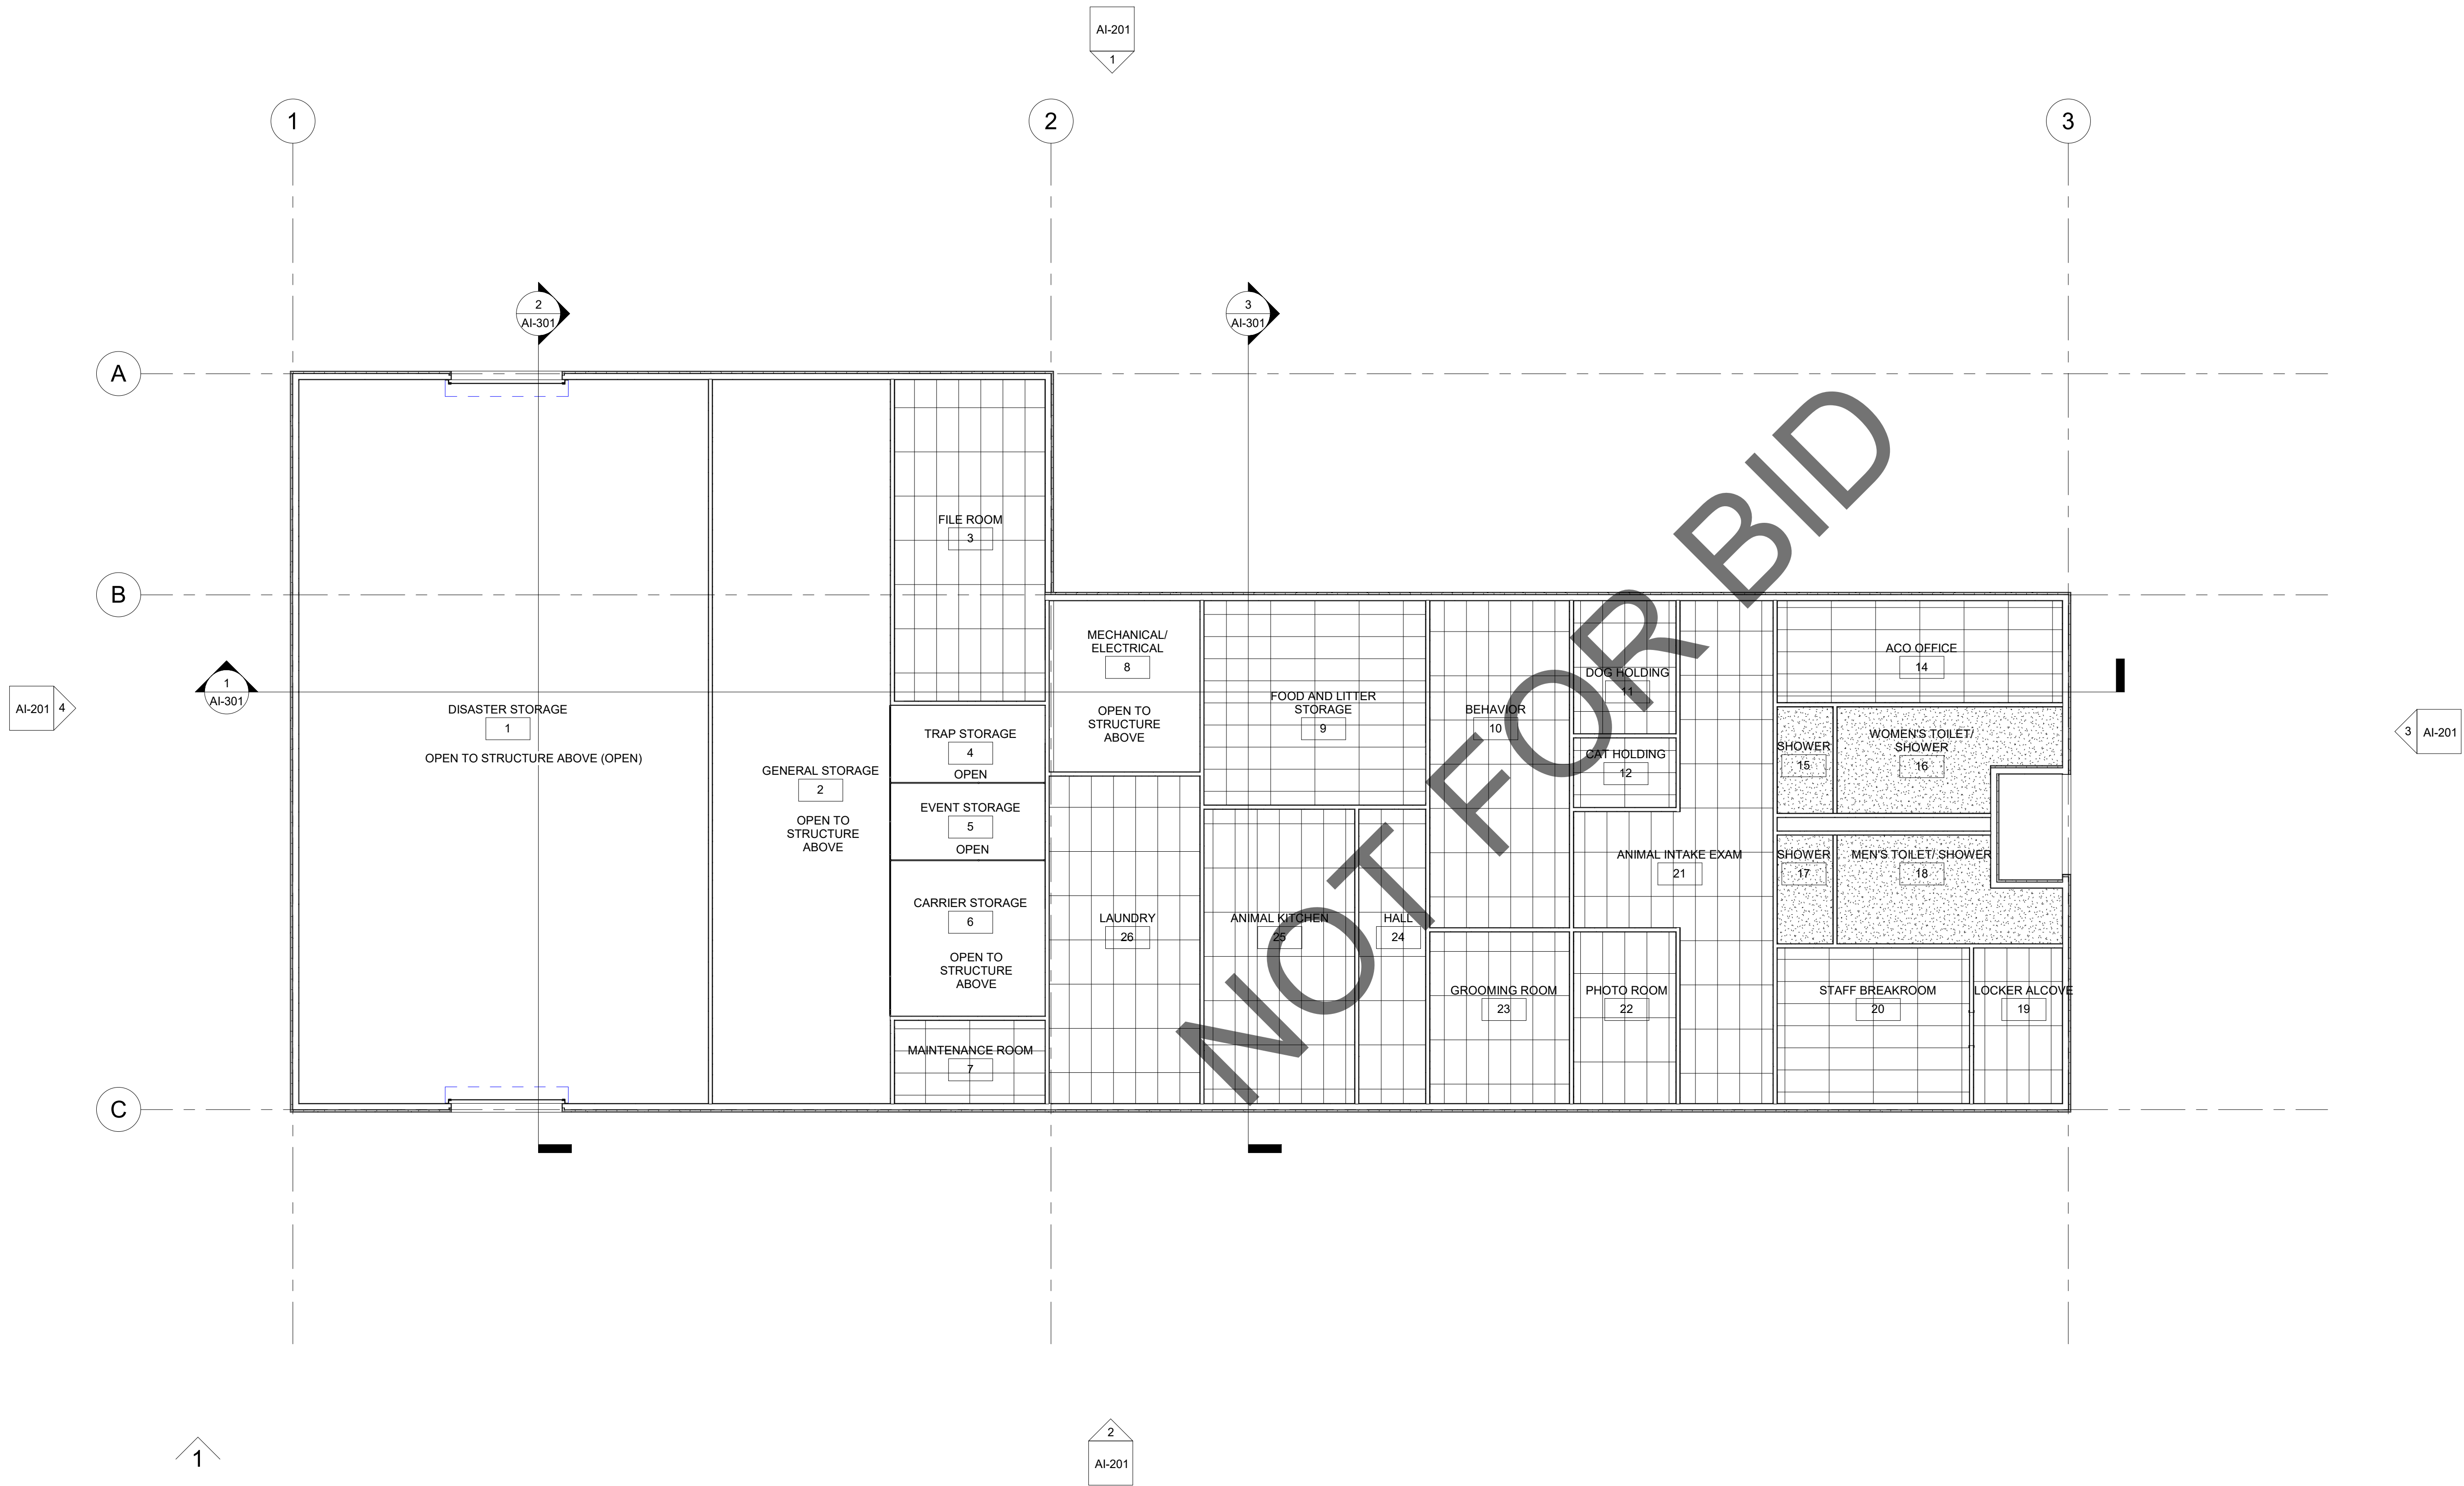

1177 Idaho Street, Suite 200
Redlands, CA 92374
Phone: 909-335-7400
Fax: 909-335-7299
info@miller-aip.com

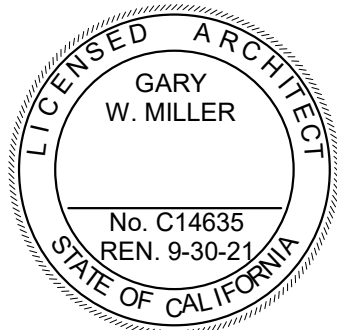

owner approval		
initials	date	phase
revisions/addenda		
#	Date	Comment

ANIMAL CARE CENTER

18313 VALLEY BLVD.
BLOOMINGTON, CA 92313
SAN BERNARDINO COUNTY


385 N. Arrowhead Ave., 3rd Floor
San Bernardino, CA 92415

project information	
Project Number:	2200065
Drawn By:	Author
Checked By:	MB
Issue Date:	Issue Date


sheet name
FIRST FLOOR
REFLECTED
CEILING PLAN

sheet number
AI-103

Sheet Of Sheets

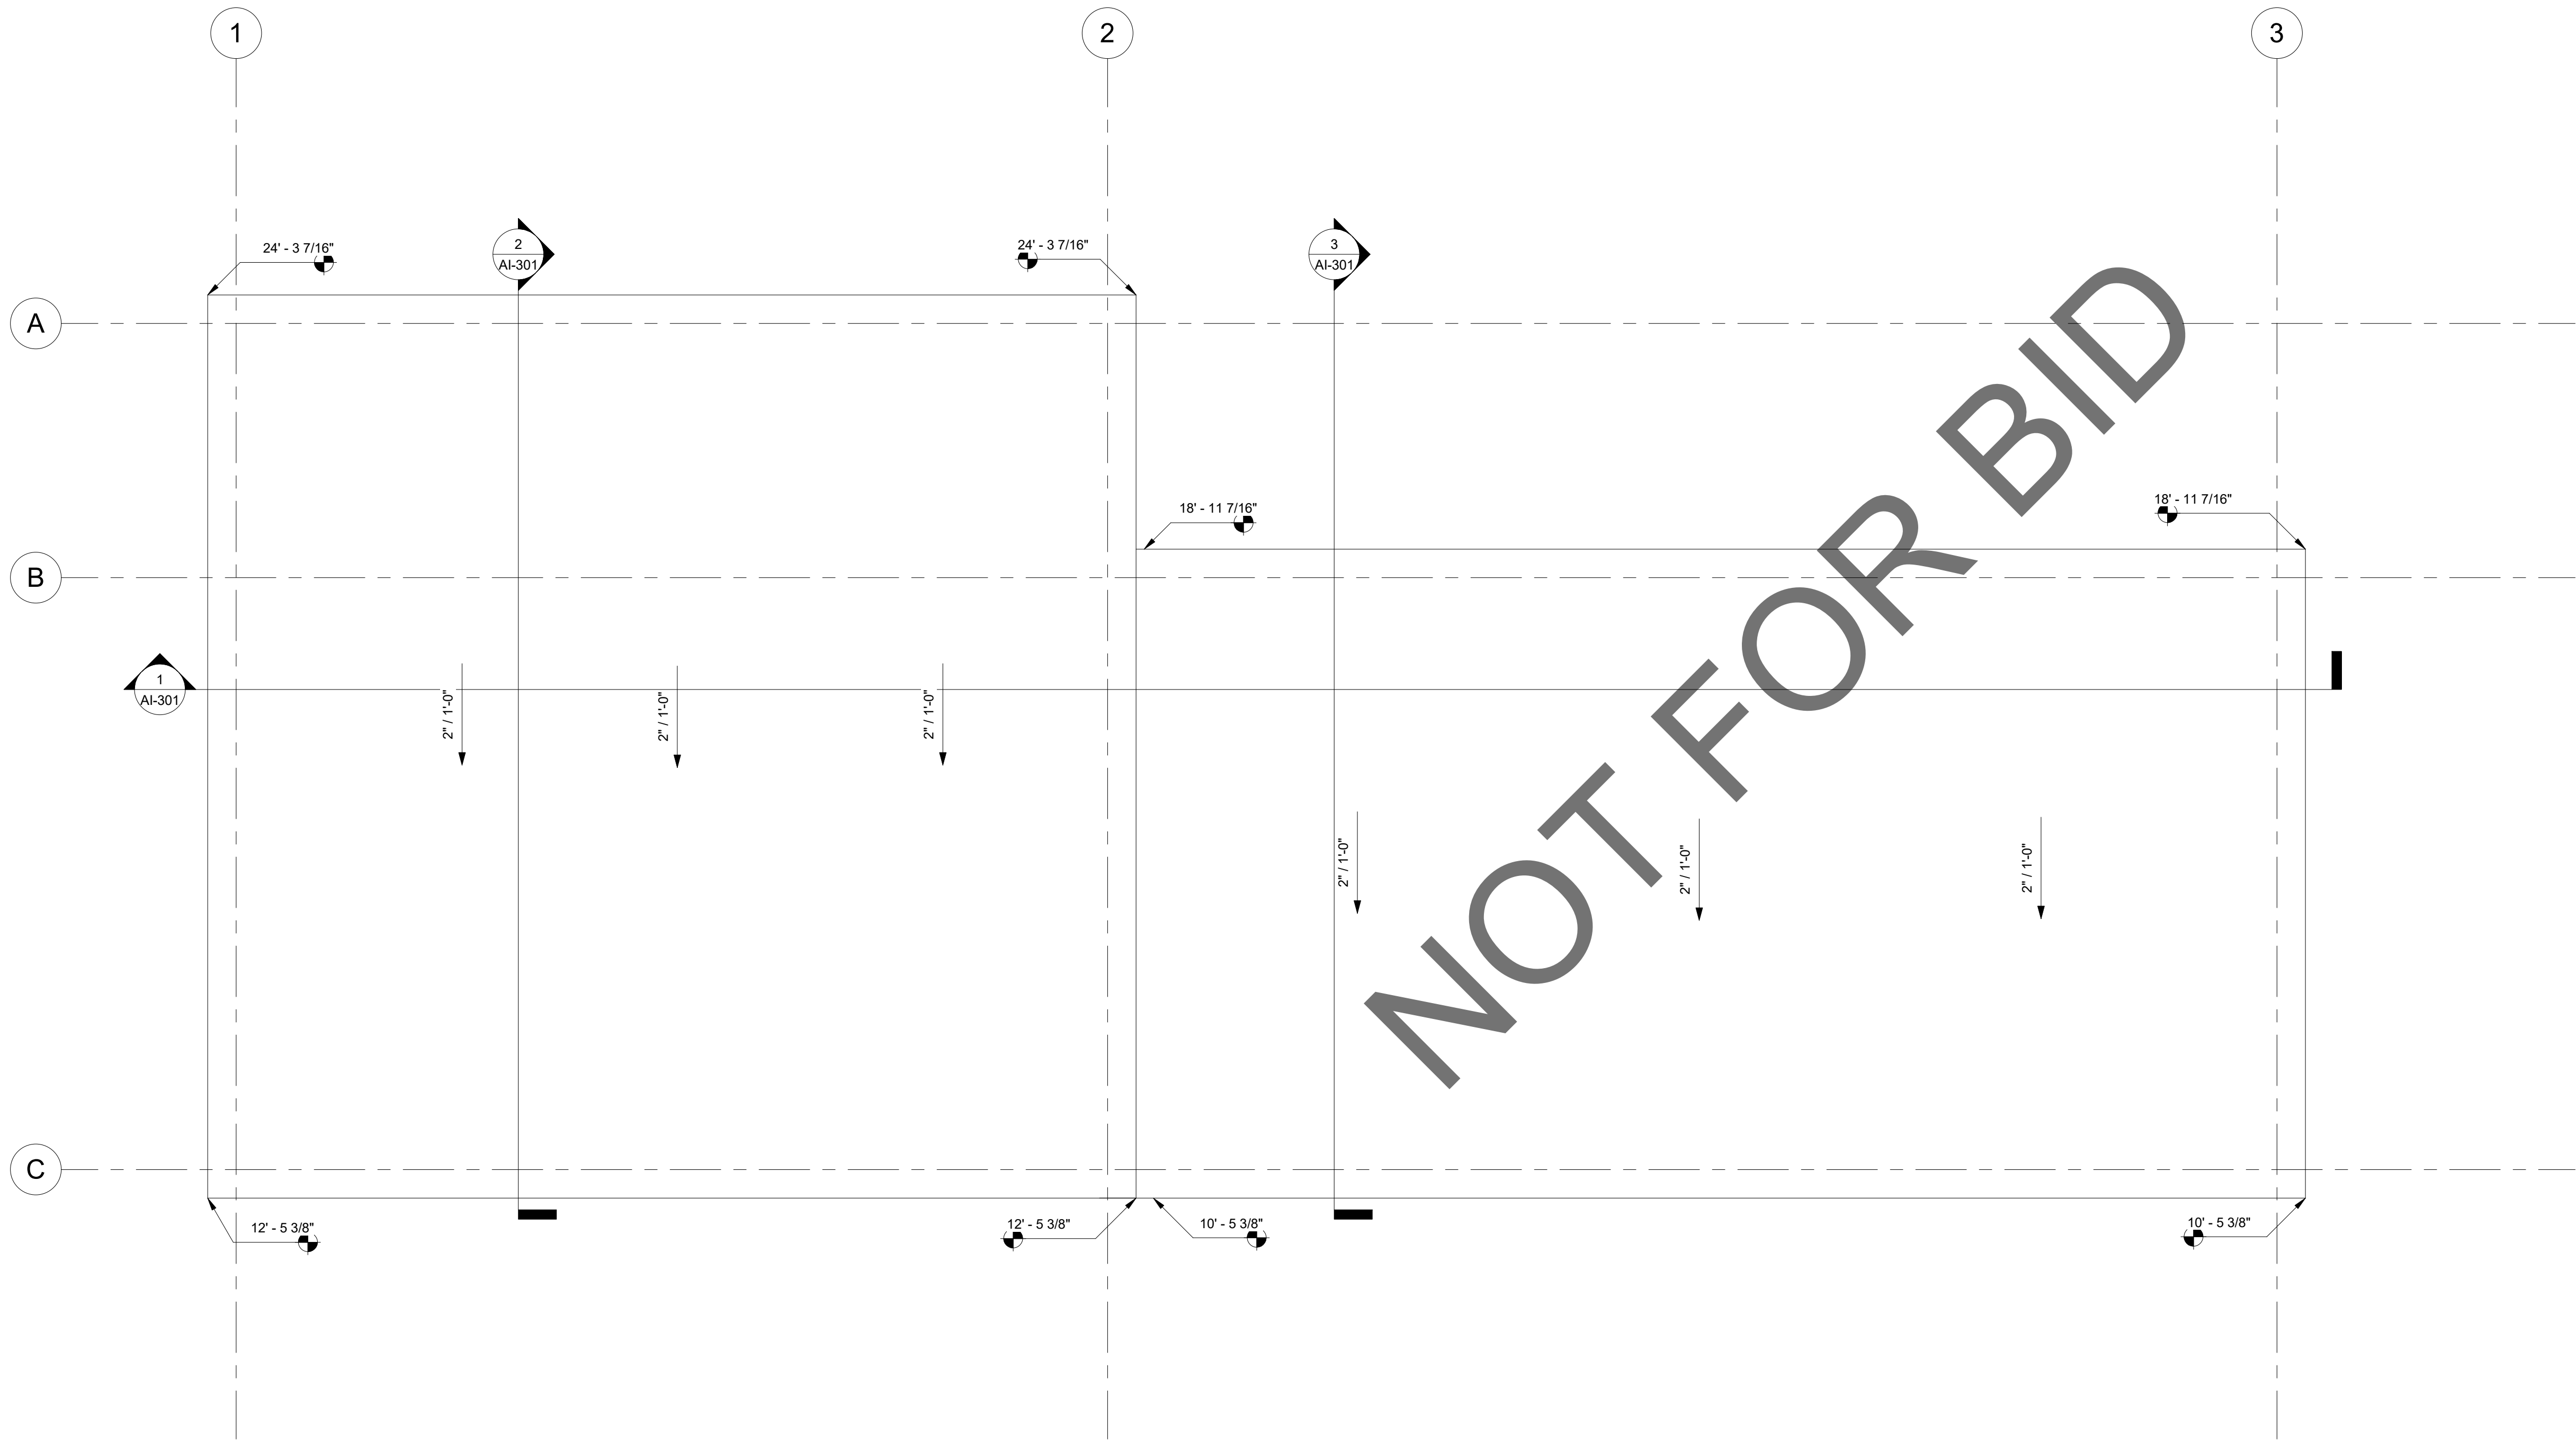

1177 Idaho Street, Suite 200
Redlands, CA 92374
Phone: 909-335-7400
Fax: 909-335-7299
info@miller-aip.com

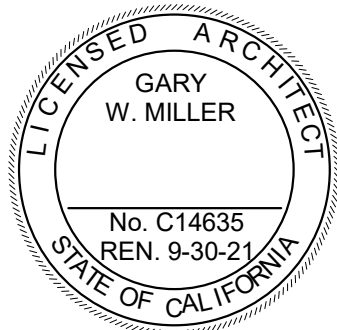

owner approval		
initials	date	phase

revisions/addenda	
#	Date Comment

ANIMAL CARE CENTER

18313 VALLEY BLVD.
BLOOMINGTON, CA 92313

SAN BERNARDINO COUNTY

385 N. Arrowhead Ave., 3rd Floor
San Bernardino, CA 92415


project information	
Project Number:	2200065
Drawn By:	SP
Checked By:	MB
Issue Date:	Issue Date

sheet name

ROOF PLAN

sheet number

AI-105

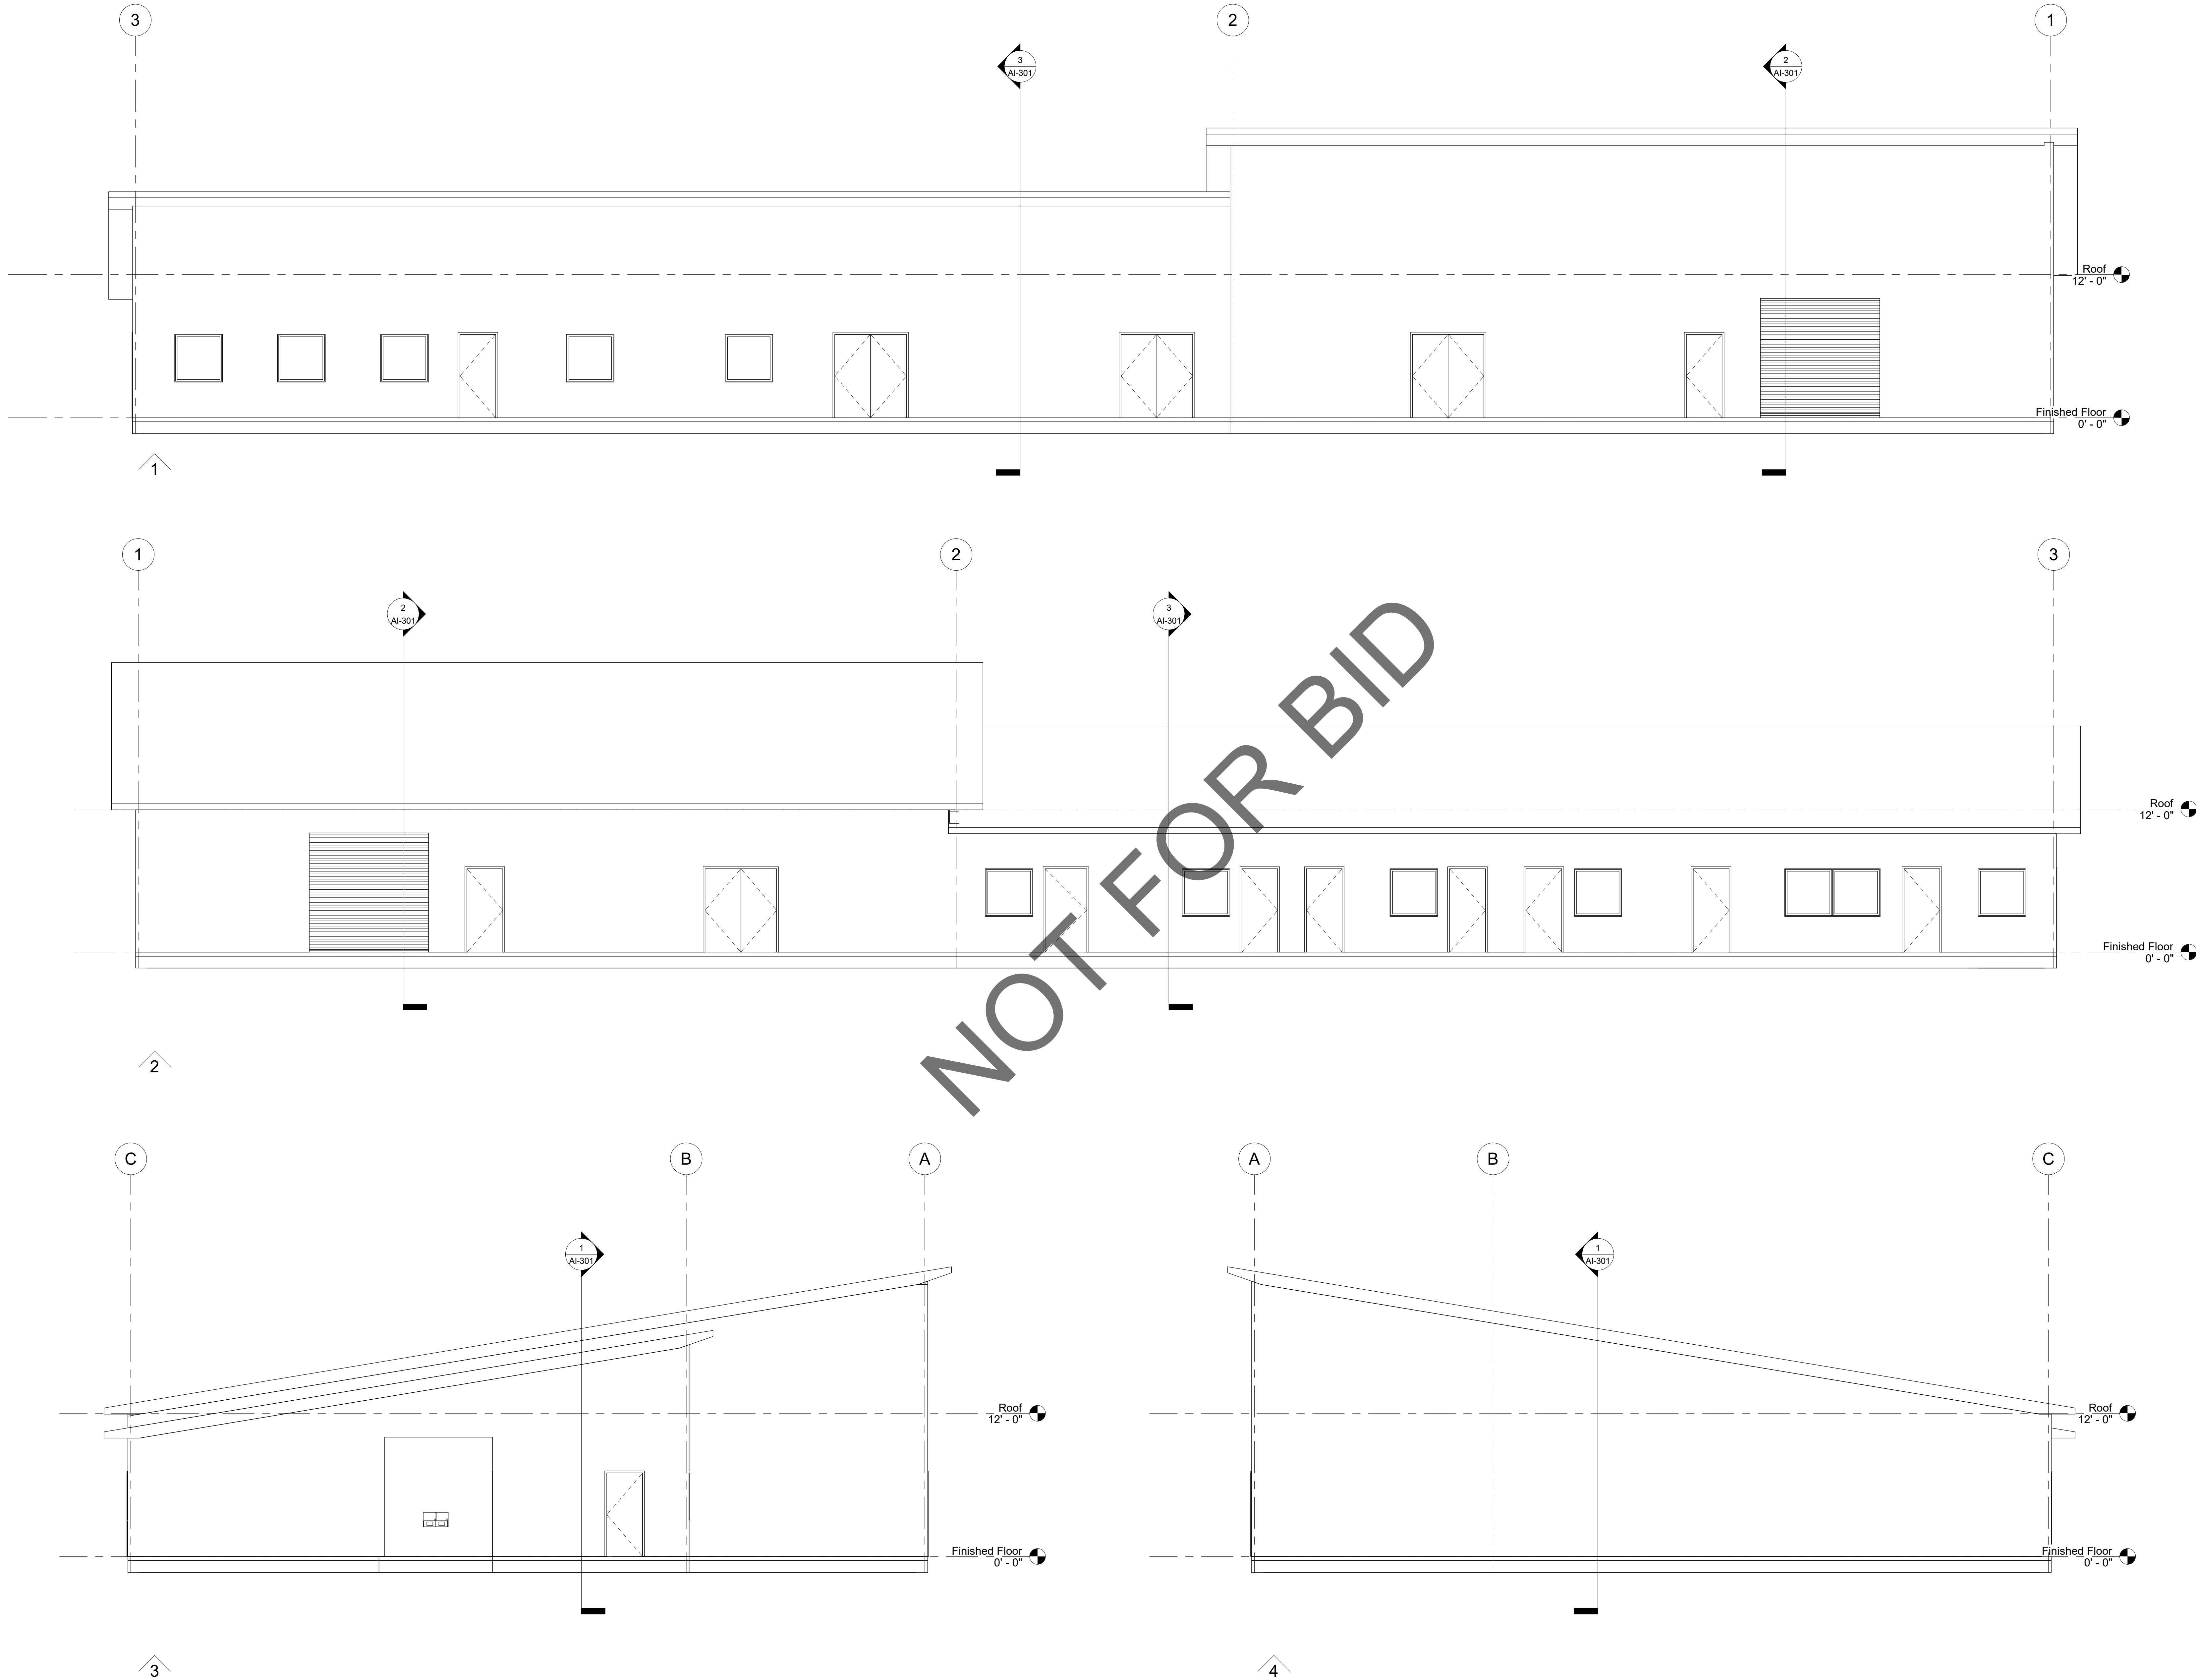

1177 Idaho Street, Suite 200
Redlands, CA 92374
Phone: 909-335-7400
Fax: 909-335-7299
info@miller-aip.com



OWNER APPROVAL		
INITIALS	DATE	PHASE
REVISIONS/ADDENDA		
#	Date	Comment

ANIMAL CARE CENTER

18313 VALLEY BLVD.
BLOOMINGTON, CA 92313

SAN BERNARDINO COUNTY

385 N. Arrowhead Ave., 3rd Floor
San Bernardino, CA 92415

PROJECT INFORMATION	
Project Number:	2200065
Drawn By:	Author
Checked By:	GWM
Issue Date:	Issue Date


SHEET NAME

EXTERIOR
ELEVATIONS

SHEET NUMBER

AI-201

Sheet Of Sheets

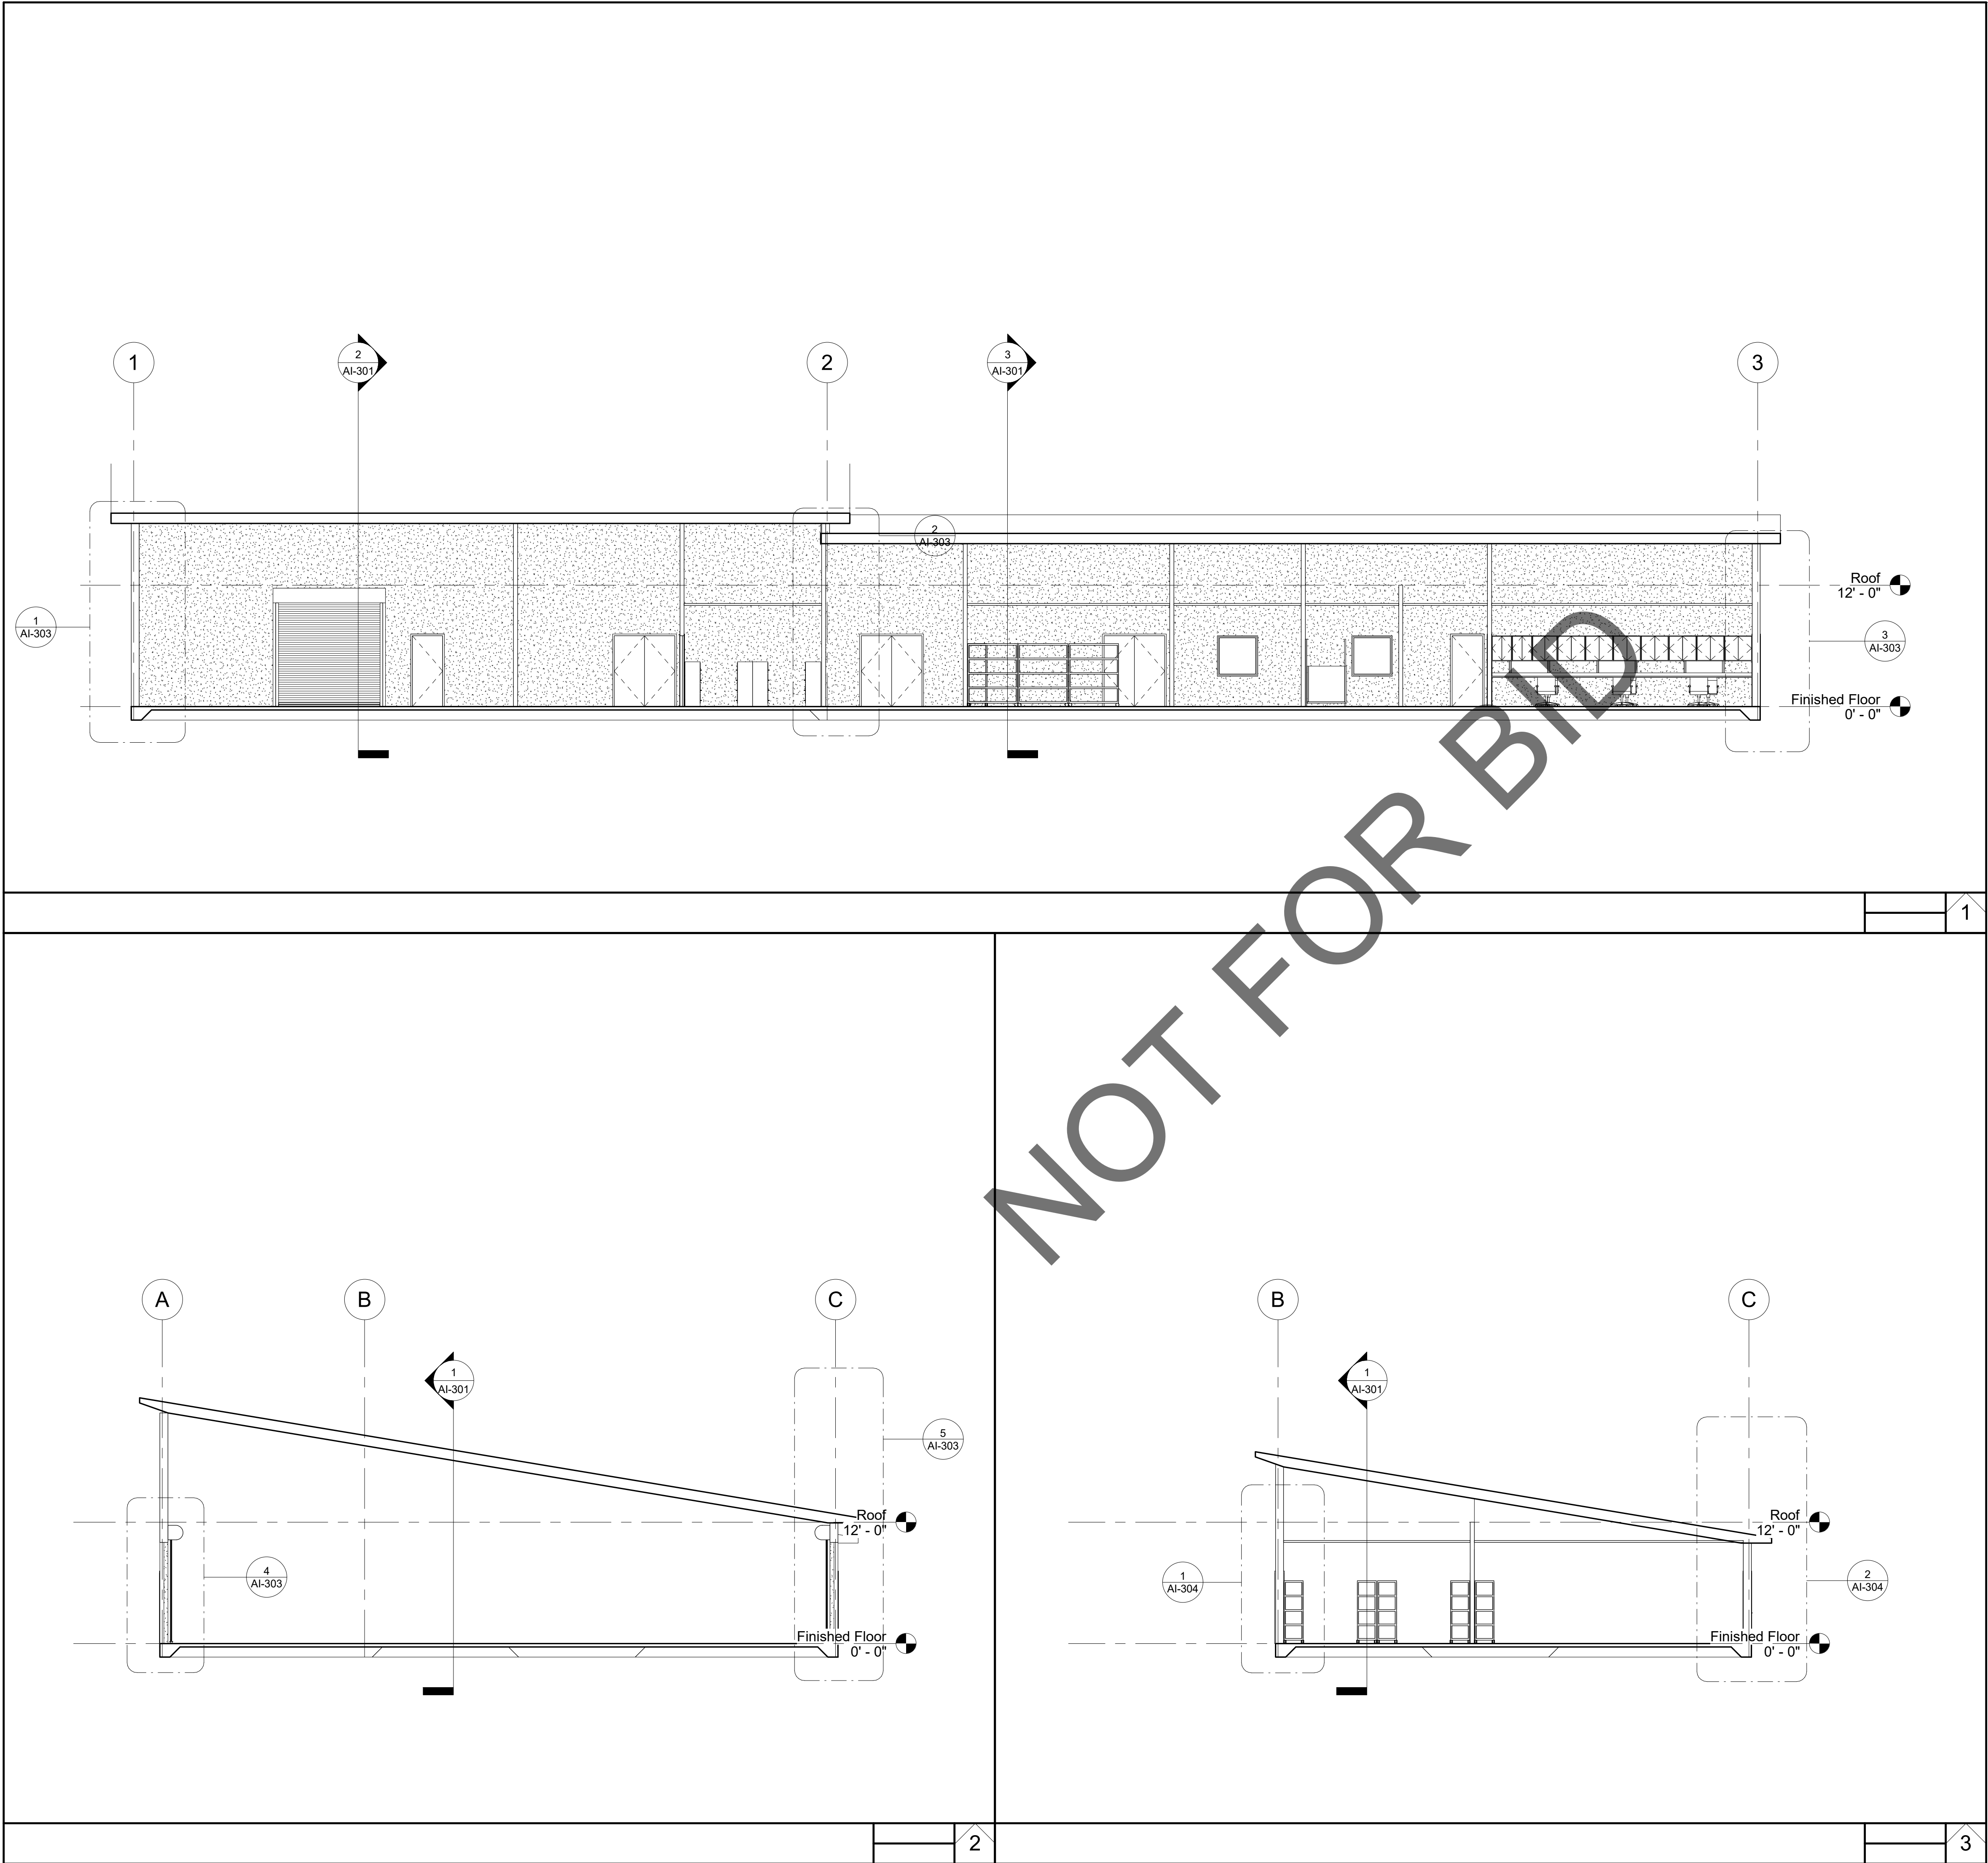

1177 Idaho Street, Suite 200
Redlands, CA 92374
Phone: 909-335-7400
Fax: 909-335-7299
info@miller-aip.com



OWNER APPROVAL

INITIALS	DATE	PHASE

REVISIONS/ADDENDA

#	Date	Comment

ANIMAL CARE CENTER

18313 VALLEY BLVD.
BLOOMINGTON, CA 92313

SAN BERNARDINO COUNTY

385 N. Arrowhead Ave., 3rd Floor
San Bernardino, CA 92415

PROJECT INFORMATION

Project Number:	2200065
Drawn By:	Author
Checked By:	GWM
Issue Date:	Issue Date

SHEET NAME

BUILDING
SECTIONS


SHEET NUMBER

AI-301


Sheet Of Sheets

© 2017 Miller Architectural Corporation

Z:\PROJECTS\2022 Projects\SB CO Bloomington Animal Care Facility - 2200065 RA\Drawings\Schematic Design\San Bernardino_AI_Support Building_R22_5-26-23.rvt

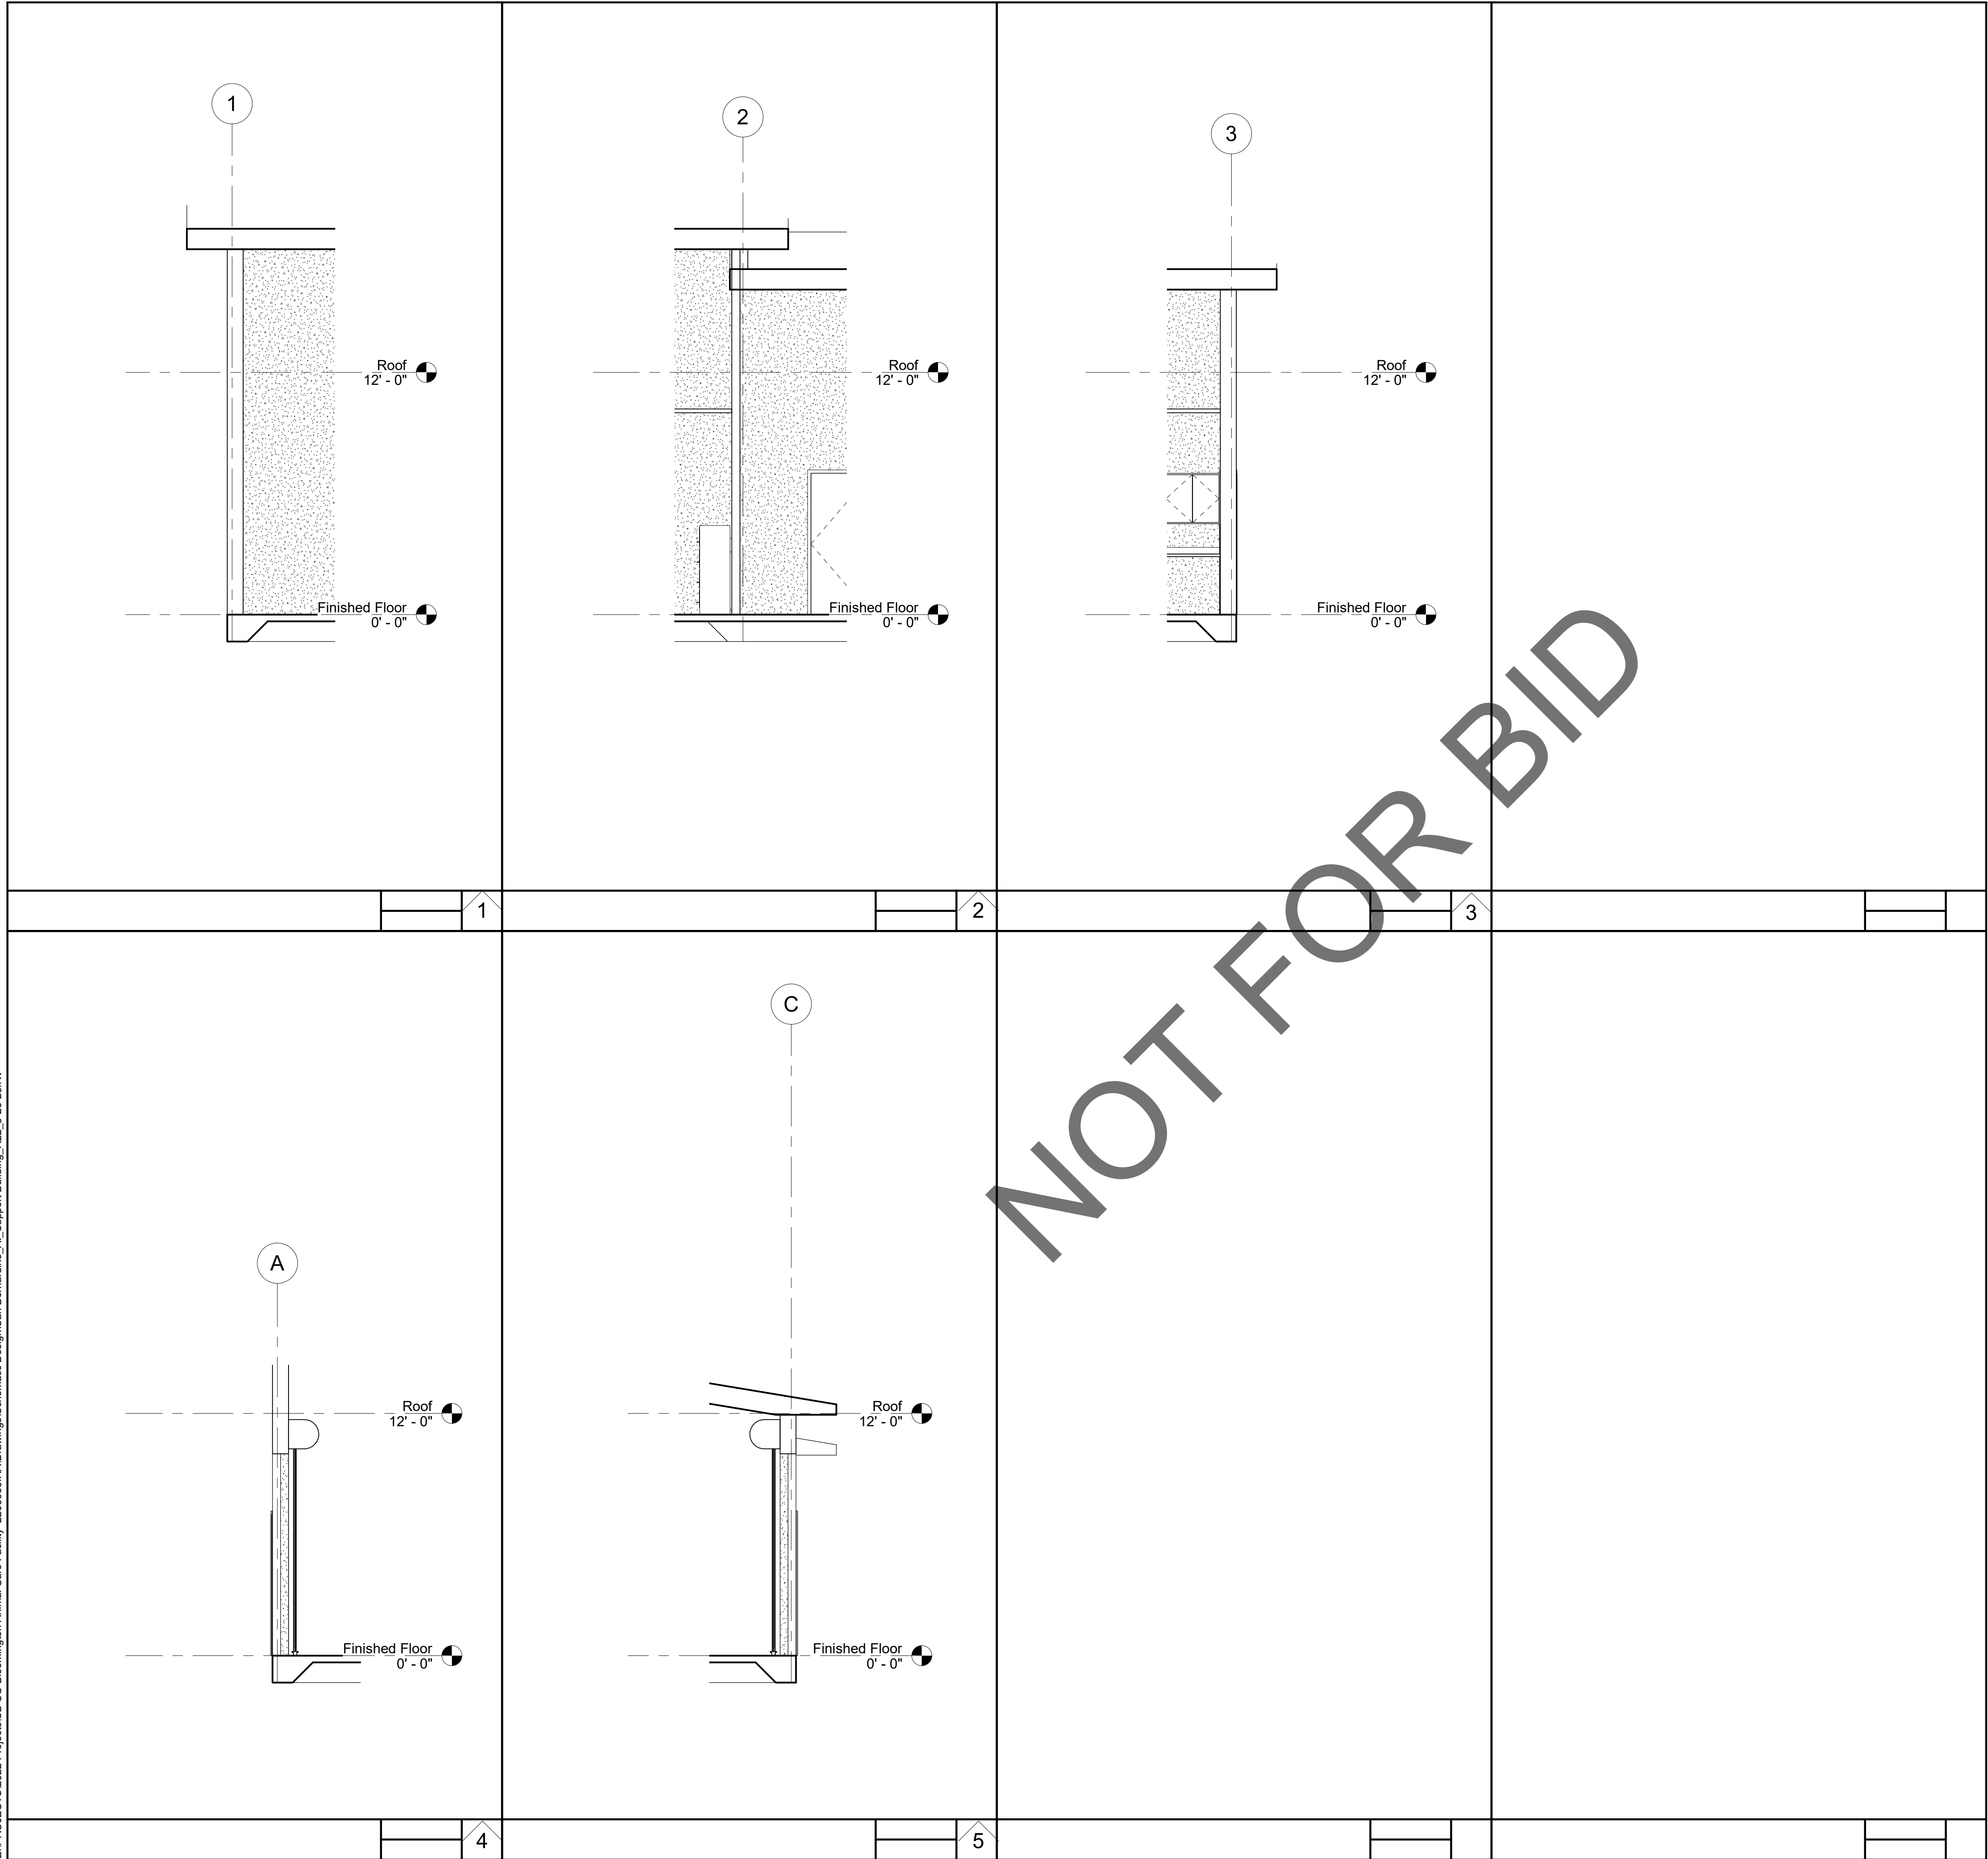

1177 Idaho Street, Suite 200
Redlands, CA 92374
Phone: 909-335-7400
Fax: 909-335-7299
info@miller-aip.com

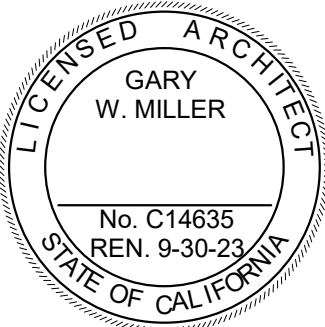

OWNER APPROVAL

INITIALS	DATE	PHASE

REVISIONS/ADDENDA

#	Date	Comment
---	------	---------

ANIMAL CARE CENTER

18313 VALLEY BLVD.
BLOOMINGTON, CA 92313

SAN BERNARDINO COUNTY

385 N. Arrowhead Ave., 3rd Floor
San Bernardino, CA 92415

PROJECT INFORMATION

Project Number:	2200065
Drawn By:	Author
Checked By:	GWM
Issue Date:	Issue Date



SHEET NAME

WALL SECTIONS

SHEET NUMBER


AI-303

Sheet Of Sheets

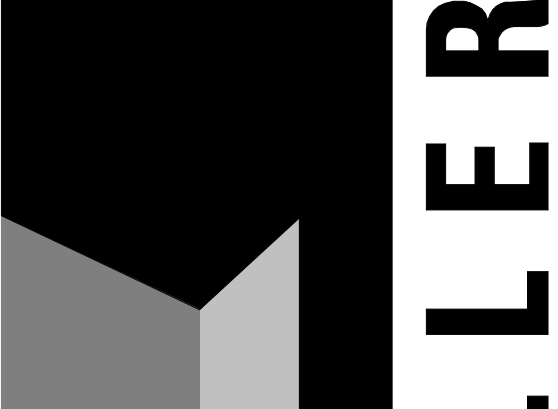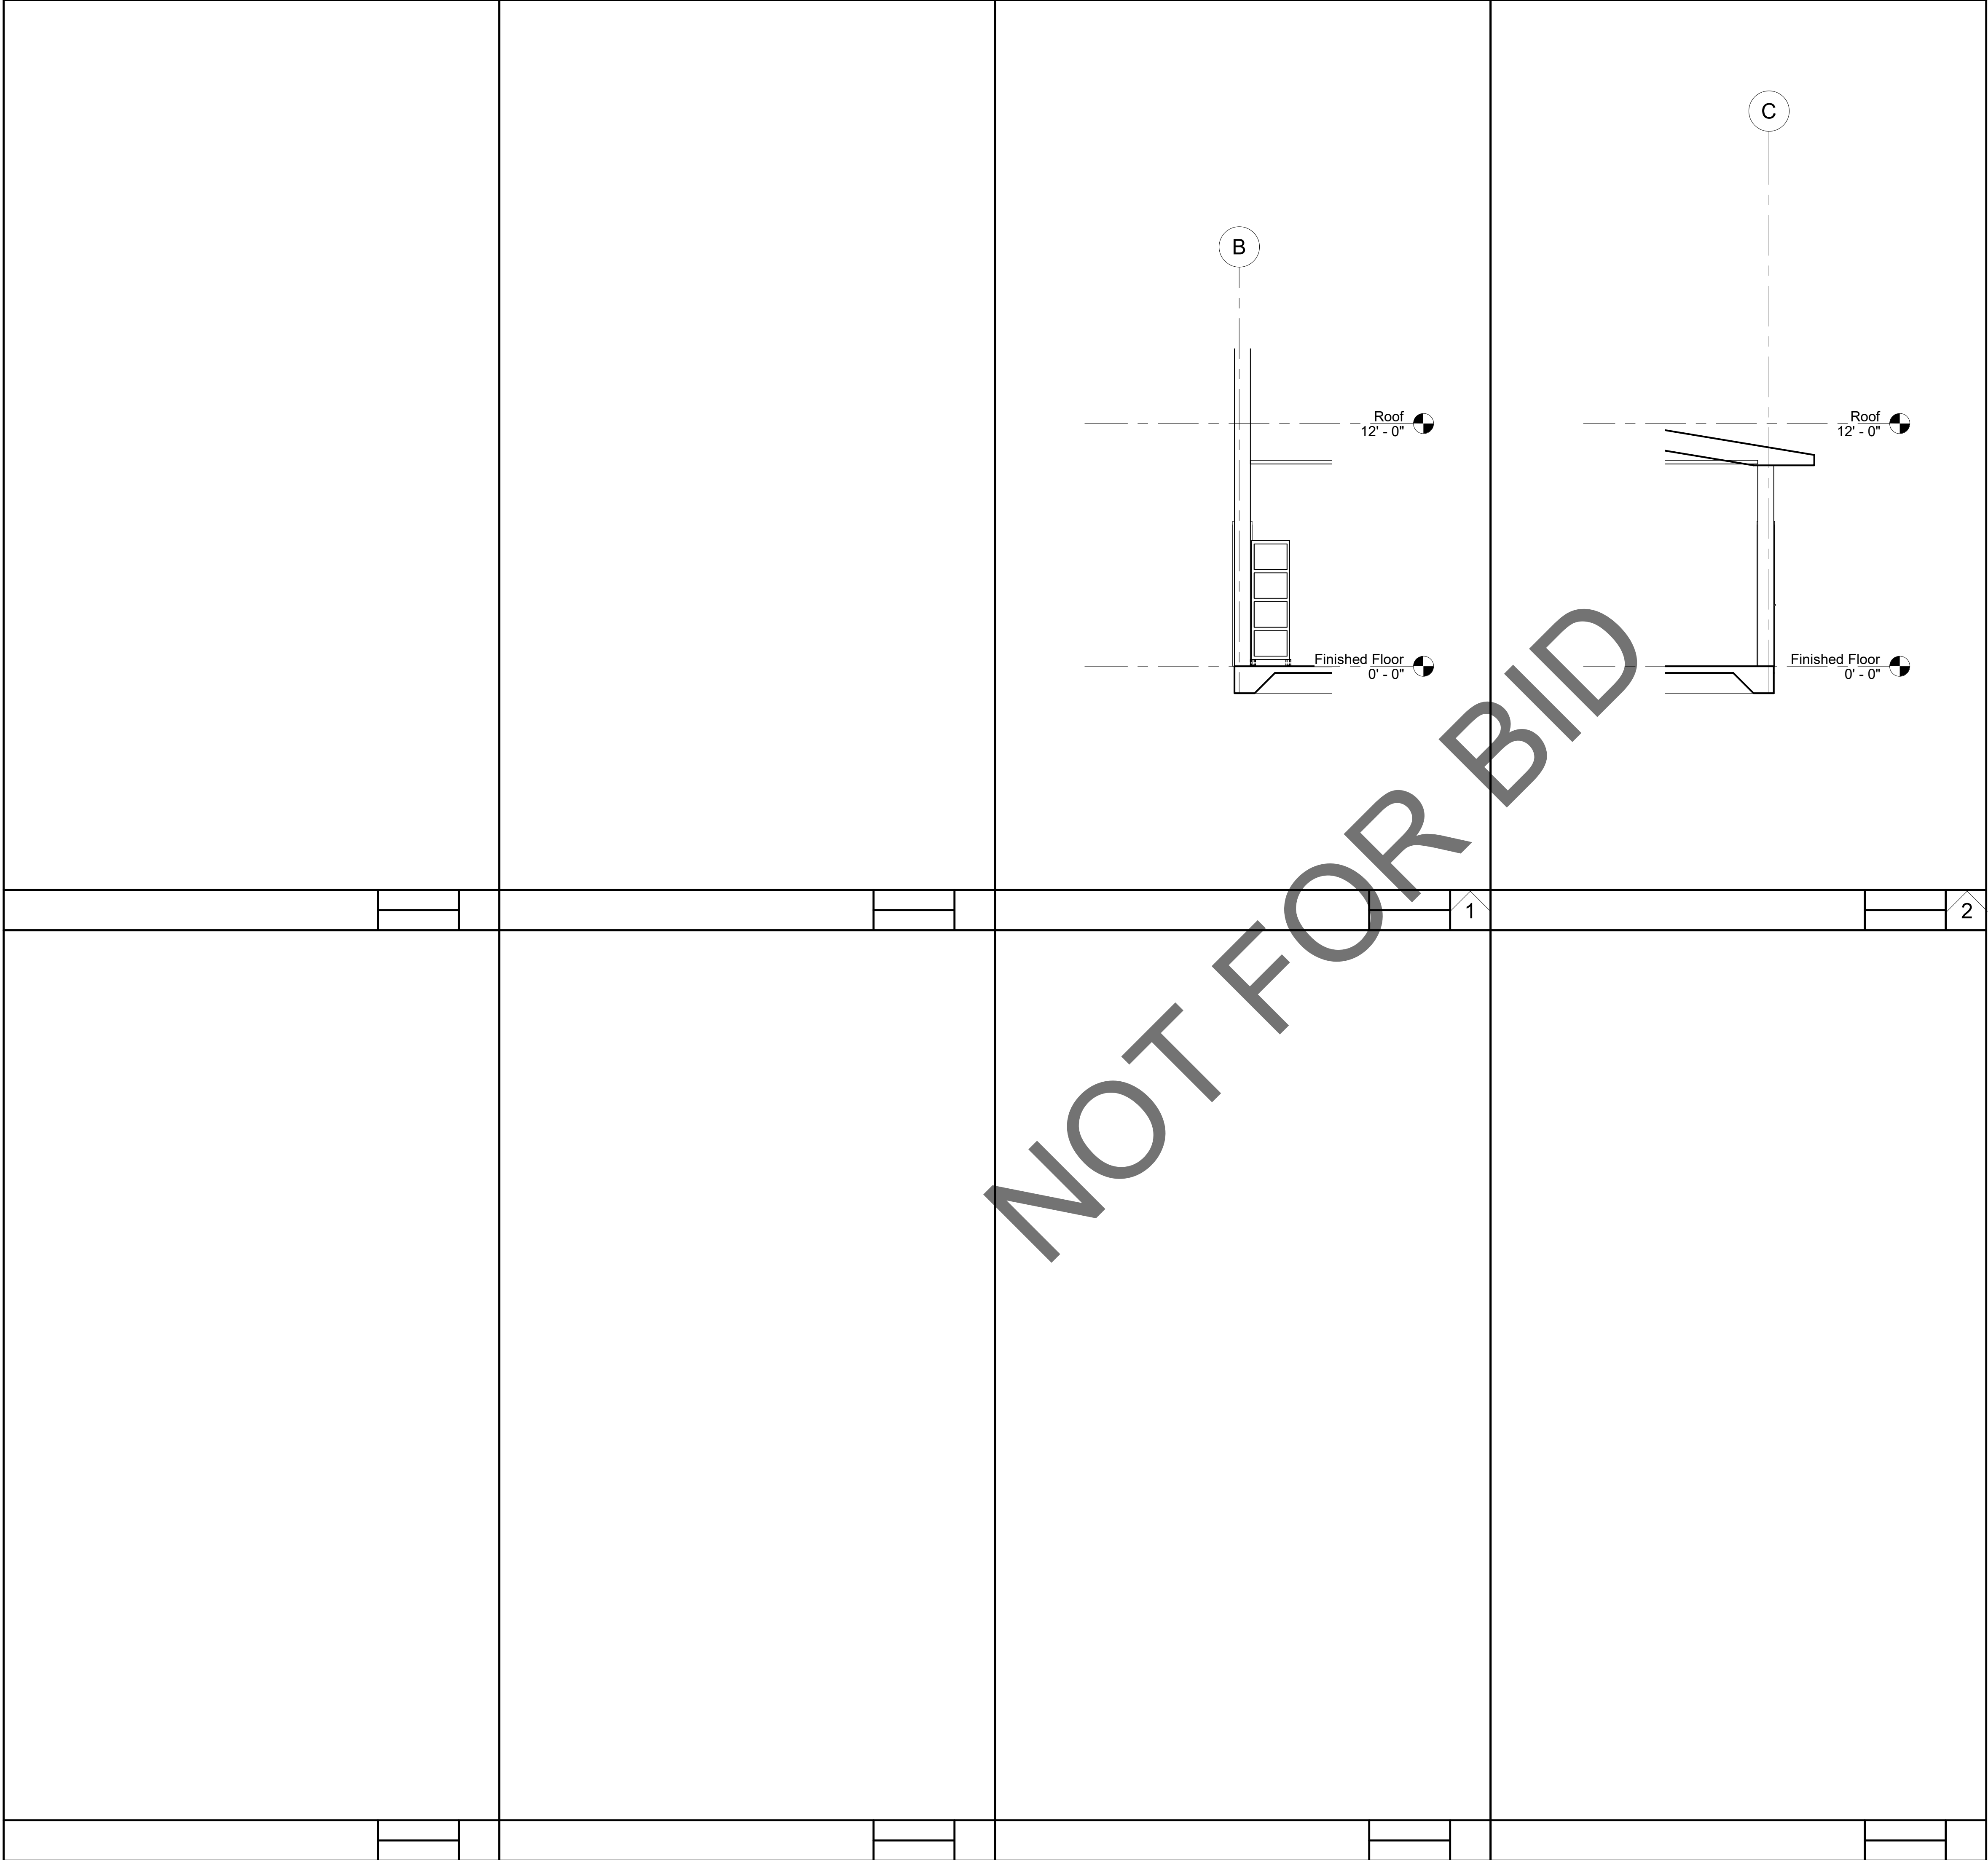

architecture
interiors
planning

1177 Idaho Street, Suite 200
Redlands, CA 92374
Phone: 909-335-7400
Fax: 909-335-7299
info@miller-aip.com

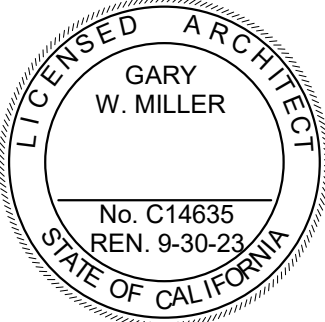

OWNER APPROVAL

INITIALS	DATE	PHASE

REVISIONS/ADDENDA

#	Date	Comment
---	------	---------

ANIMAL CARE CENTER

18313 VALLEY BLVD.
BLOOMINGTON, CA 92313

SAN BERNARDINO COUNTY

385 N. Arrowhead Ave., 3rd Floor
San Bernardino, CA 92415

PROJECT INFORMATION

Project Number:	2200065
Drawn By:	Author
Checked By:	GWM
Issue Date:	Issue Date

SHEET NAME

WALL SECTIONS

SHEET NUMBER

AI-304

Sheet Of Sheets

DOOR SCHEDULE																
MARK	ROOM	DOOR TYPE	PAIR OR SINGLE	SIZE		DOOR		DETAIL				FRAME		FIRE RATING	HW GROUP	REMARKS
				WIDTH	HEIGHT	FINISH	MATERIAL	HEAD	JAMB 1	JAMB 2	SILL	FINISH	MATERIAL			
1				10' - 0"	10' - 0"											
1B				3' - 0"	7' - 0"											
1C				10' - 0"	10' - 0"											
1D				3' - 0"	7' - 0"											
2				6' - 0"	7' - 0"											
2B				6' - 0"	7' - 0"											
3				3' - 0"	7' - 0"											
7				3' - 0"	7' - 0"											
8				6' - 0"	7' - 0"											
9				3' - 0"	7' - 0"											
9A				6' - 0"	7' - 0"											
10				3' - 0"	7' - 0"											
11				3' - 0"	7' - 0"											
12				3' - 0"	7' - 0"											
14				3' - 0"	7' - 0"											
14A				3' - 0"	7' - 0"											
15				3' - 0"	7' - 0"											
16				3' - 0"	7' - 0"											
17				3' - 0"	7' - 0"											
18				3' - 0"	7' - 0"											
20				3' - 0"	7' - 0"											
21				3' - 0"	7' - 0"											
21A				3' - 0"	7' - 0"											
22				3' - 0"	7' - 0"											
23				3' - 0"	7' - 0"											
24				3' - 0"	7' - 0"											
25				3' - 0"	7' - 0"											
26				3' - 6"	7' - 0"											
A183				2' - 0"	6' - 8"											
A184				2' - 0"	6' - 8"											
A185				2' - 0"	6' - 8"											
A186				3' - 0"	7' - 0"											

DOOR GENERAL NOTES:

- EXIT DOORS SHALL BE OPERABLE FROM THE INSIDE WITHOUT THE USE OF A KEY OR SPECIAL KNOWLEDGE OR EFFORT.
- GLASS AND GLAZING SHALL COMPLY WITH CBC CHAPTER 24.
- MAXIMUM EFFORT TO OPERATE DOORS:
EXTERIOR - 5.0 LBS
INTERIOR - 5.0 LBS
- VERIFY ALL DOOR FRAME THROAT SIZES WITH FINISHED WALL THICKNESS PRIOR TO ORDERING FRAMES.
- ALL HAND ACTIVATED DOOR OPENING HARDWARE AT LATCHING OR LOCKING DOORS ON THE ACCESSIBLE PATH OF TRAVEL SHALL BE OPERABLE WITH SINGLE EFFORT LEVER TYPE HARDWARE, PANIC BARS, PUSH/PULL ACTIVATING BARS OR OTHER HARDWARE DESIGNED TO PROVIDE PASSAGE WITHOUT REQUIRING THE ABILITY TO GRASP THE HARDWARE.
- MAIN ENTRY DOOR SHALL BE PROVIDED WITH AN INDICATING FLAG LOCK AND REQUIRED DECAL ON HEADER STATING, THIS DOOR TO REMAIN UNLOCKED WHEN THIS SPACE IS OCCUPIED PER CBC 1010.1.9.3
- FIRE DOORS SHALL BE LATCHED AN SELF OR AUTOMATIC-CLOSING IN ACCORDANCE WITH SECTION 716.2.6.1.
- CHUTE INTAKE DOORS SHALL BE POSITIVE LATCHING, REMAINING LATCHED AND CLOSED IN THE EVENT OF LATCH SPRING FAILURE DURING A FIRE EMERGENCY.
- ALL UNIT NUMBERS TO BE A MIN. OF 4" HIGH INSTALLED ON A CONTRASTING BACKGROUND.

DOOR SCHEDULE LEGEND:

DOOR:

MATERIAL

AL ALUMINUM
WD WOOD
M METAL
G GLASS
V VINYL

FINISH

SCF STAIN & CLEAR FINISH
P PAINT
F FACTORY APPLIED
T TEMPERED GLASS
E EXISTING FINISH

FRAME:

MATERIAL

AL ALUMINUM
HM HOLLOW METAL
M METAL
E EXISTING

FINISH

P PAINT
F FACTORY APPLIED
E EXISTING FINISH

REMARKS:

R1 ACCESSIBILITY SIGN
R2 PANIC DEVICE
R3 CARD READER
R4 METAL KICK PLATES
R5 PANIC DEVICE
R6 SMOKE GASKET
R7 WEATHERSTRIP
R8 CLOSER

WINDOW

GLAZING:

- TEMPERED GLASS
- WIRE GLASS
- DUAL GLAZING
- SINGLE GLAZING
- FIRE PROTECTION RATED GLAZING

FRAME

MATERIAL:

AL ALUMINUM
HM HOLLOW METAL
E EXISTING
VL VINYL FRAME MATERIAL

FINISH:


P PAINTED
F FACTORY APPLIED
E EXISTING FINISH

GLAZING NOTES

- ALL EXTERIOR GLAZING TO COMPLY WITH THE FOLLOWING TITLE 24 REQUIREMENTS:
A. U-FACTOR: 0.00
B. SHGC: 0.00
C. VT: 0.00
- ALL EXTERIOSOLARBAN 70XL SOLEXIA 1-INCH INSULATED LOW-E VITRO OR EQUAL

STOREFRONT NOTES:


- (T) DENOTES TEMPERED GLASS
(10) CUSTOM WINDOW SEE WINDOW SCHEDULE
(1) PRE-MANUFACTURED WINDOWS SEE WINDOW SCHEDULE

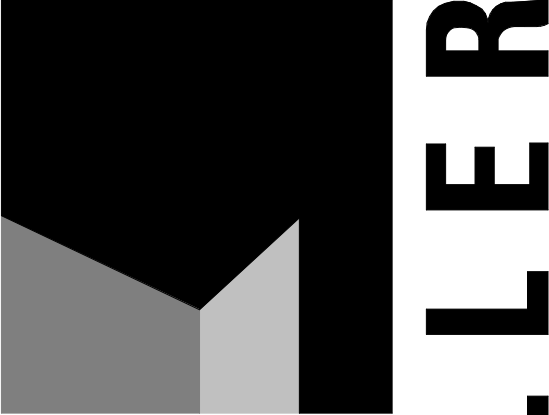

architecture
interiors
planning

MILLER

1177 Idaho Street, Suite 200
Redlands, CA 92374
Phone: 909-335-7400
Fax: 909-335-7299
info@miller-aip.com

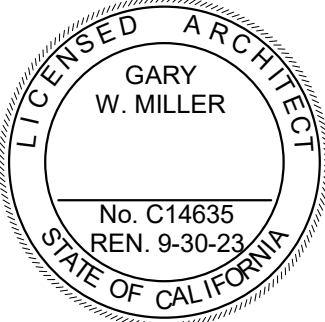

OWNER APPROVAL

INITIALS	DATE	PHASE

REVISIONS/ADDENDA

Date Comment

ANIMAL CARE CENTER

18313 VALLEY BLVD.
BLOOMINGTON, CA 92313

SAN BERNARDINO COUNTY

385 N. Arrowhead Ave., 3rd Floor
San Bernardino, CA 92415

PROJECT INFORMATION

Project Number: 2200065
Drawn By: Author
Checked By: GWM
Issue Date: Issue Date

SHEET NAME

DOOR /
WINDOW
SCHEDULE

SHEET NUMBER


AI-601

Sheet Of Sheets

ROOM FINISH SCHEDULE														
ROOM NUMBER	ROOM	FLOOR MATERIAL	BASE MATERIAL	WALL FINISH				WAINSCOT FINISH				CEILING HEIGHT	CEILING MATERIAL	REMARKS
				A	B	C	D	A	B	C	D			
1	DISASTER STORAGE											8' - 0"		
23	GROOMING ROOM											8' - 0"		
26	LAUNDRY											8' - 0"		
24	HALL											8' - 0"		
3	FILE ROOM											8' - 0"		
22	PHOTO ROOM											8' - 0"		
20	STAFF BREAKROOM											8' - 0"		
18	MEN'S TOILET/ SHOWER											8' - 0"		
16	WOMEN'S TOILET/ SHOWER											8' - 0"		
14	ACO OFFICE											8' - 0"		
11	DOG HOLDING											8' - 0"		
12	CAT HOLDING											8' - 0"		
10	BEHAVIOR											8' - 0"		
9	FOOD AND LITTER STORAGE											8' - 0"		
8	MECHANICAL/ ELECTRICAL											8' - 0"		
25	ANIMAL KITCHEN											8' - 0"		
2	GENERAL STORAGE											8' - 0"		
21	ANIMAL INTAKE EXAM											8' - 0"		
15	SHOWER											8' - 0"		
17	SHOWER											8' - 0"		
19	LOCKER ALCOVE											8' - 0"		
7	MAINTENANCE ROOM											8' - 0"		
4	TRAP STORAGE											8' - 0"		
5	EVENT STORAGE											8' - 0"		
6	CARRIER STORAGE											8' - 0"		
24	Room											0' - 0"		



1177 Idaho Street, Suite 200
Redlands, CA 92374
Phone: 909-335-7400
Fax: 909-335-7299
info@miller-aip.com

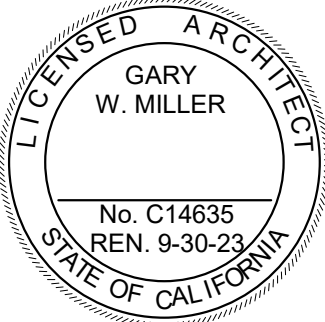

OWNER APPROVAL		
INITIALS	DATE	PHASE
REVISIONS/ADDENDA		
#	Date	Comment


ANIMAL CARE CENTER

18313 VALLEY BLVD.
BLOOMINGTON, CA 92313

SAN BERNARDINO COUNTY

385 N. Arrowhead Ave., 3rd Floor
San Bernardino, CA 92415

PROJECT INFORMATION	
Project Number:	2200065
Drawn By:	Author
Checked By:	GWM
Issue Date:	Issue Date
SHEET NAME	
FINISH SCHEDULE	
SHEET NUMBER	
AI-602	
Sheet	Of Sheets

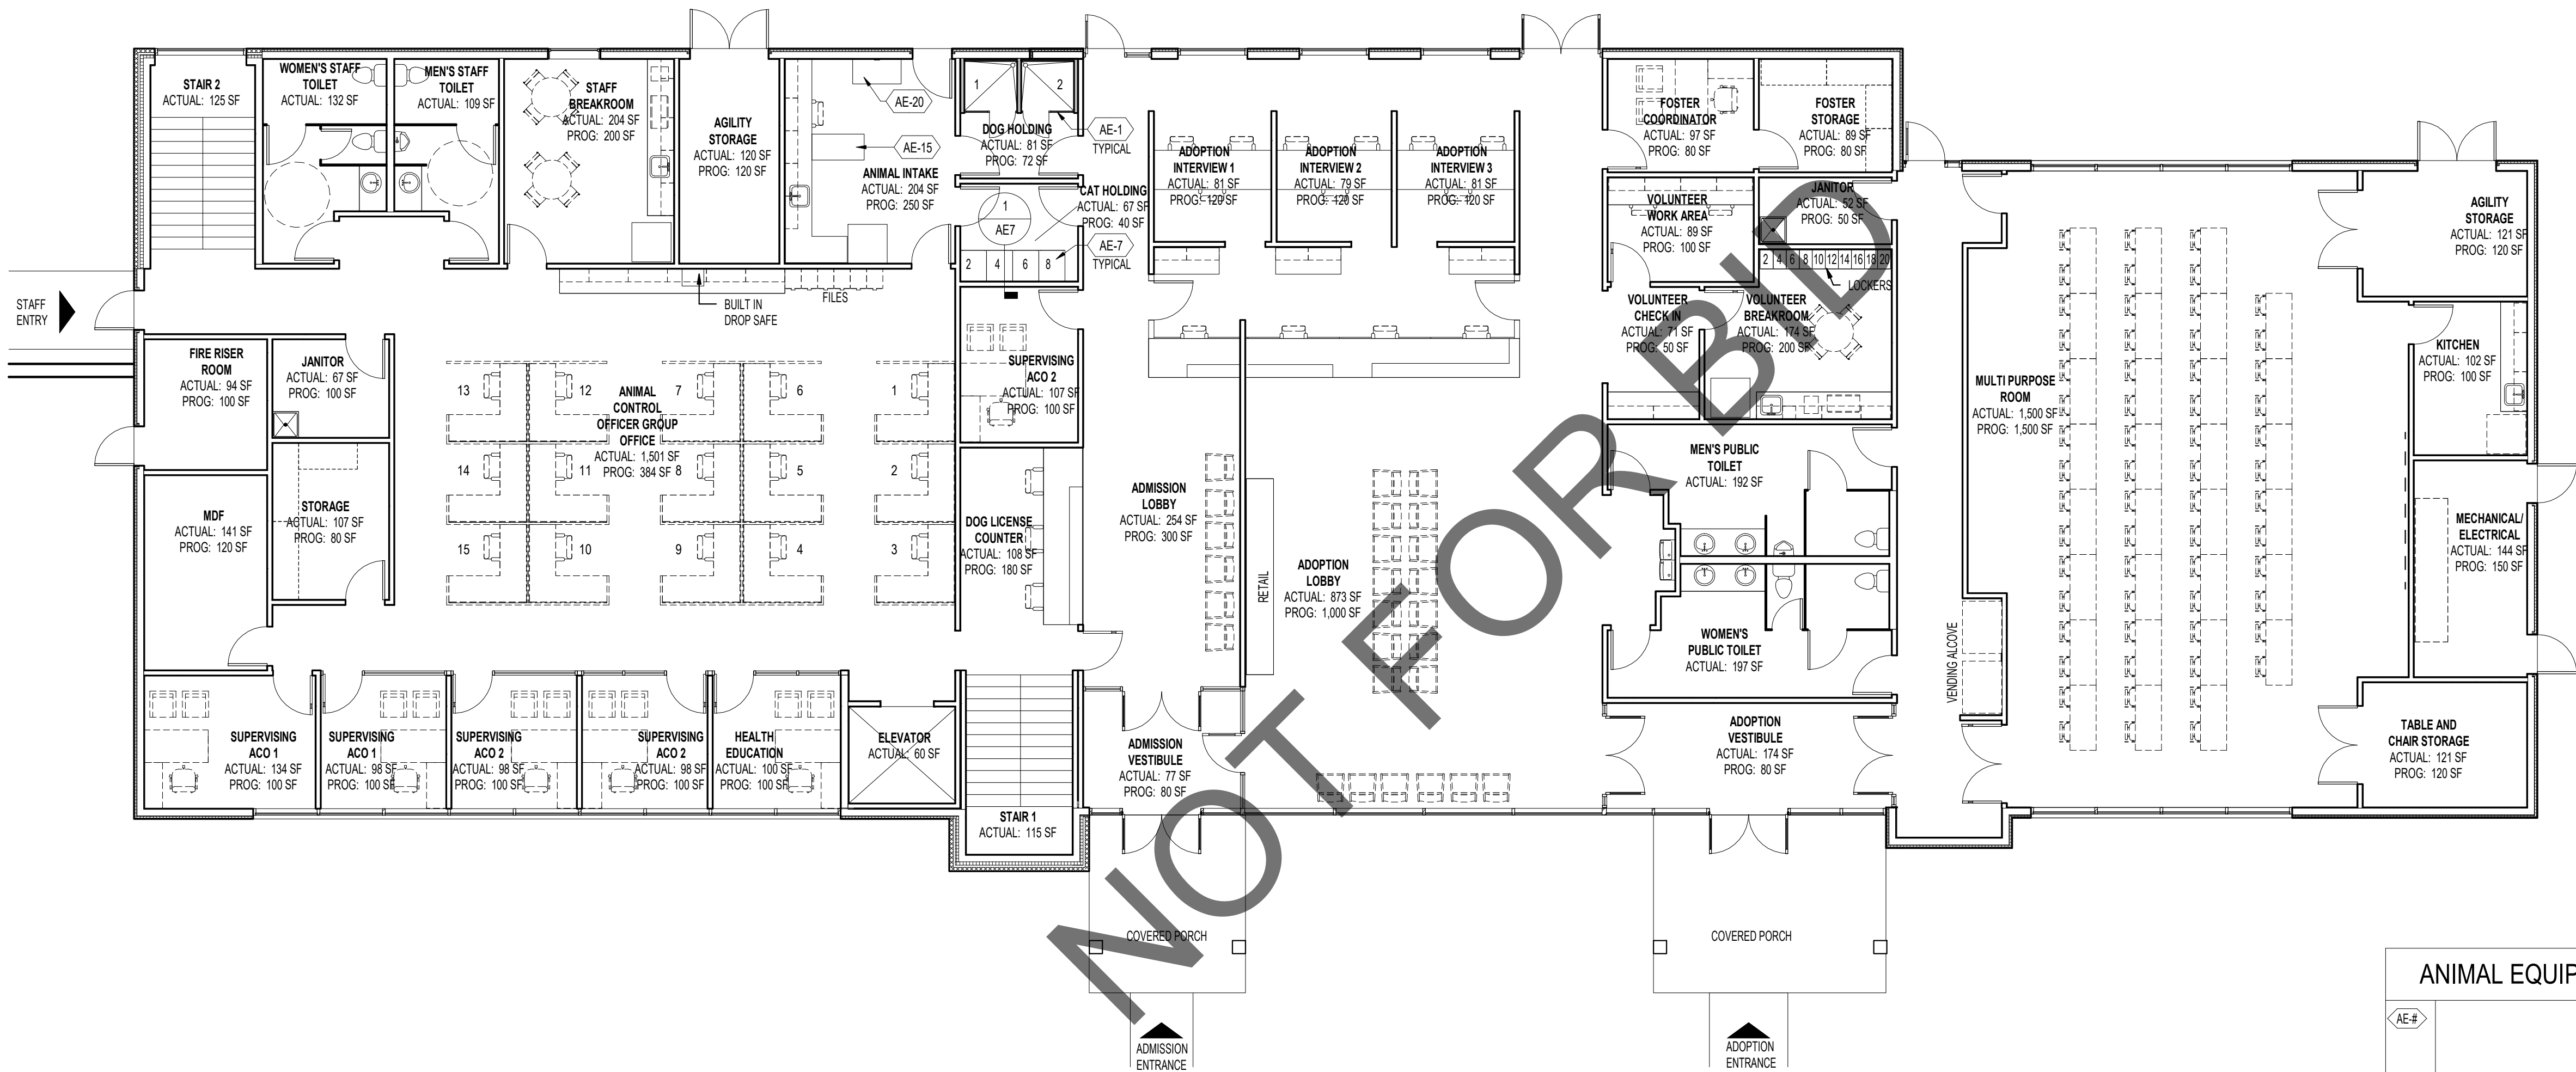


1 ANIMAL EQUIPMENT PLAN - ADMINISTRATION BUILDING FIRST FLOOR
1/8" = 1'-0"

ANIMAL HOUSING TABULATION	
CATEGORY	ACTUAL
ADOPTION DOGS	120
STRAY DOGS	40
MEDICAL ISOLATION DOGS	10
MEDICAL OBSERVATION DOGS	20
FOSTER DOGS	10
DOG SUB-TOTAL	200
ADOPTION CATS	38
FREE ROAM CATS	8
STRAY CATS	32
FRACIOUS CATS	76
MEDICAL ISOLATION CATS	10
STRICT MEDICAL ISOLATION CATS	10
CAT SUB-TOTAL	174
OTHER ANIMALS	42
TOTAL ANIMALS	416

ANIMAL EQUIPMENT LEGEND				
EQUIPMENT NUMBER	EQUIPMENT NAME	CONTRACTOR SUPPLIED, CONTRACTOR INSTALLED	OWNER SUPPLIED, CONTRACTOR INSTALLED	REMARKS
AE-1	DOG KENNELING	•		2
AE-2	DOG KENNEL GUILLotine DOORS	•		
AE-3	INSULATED PET DOOR	•		
AE-4	CAT CAGES	•		
AE-5	DOG MEDICAL HOLDING CAGES	•		
AE-6	CAT MEDICAL HOLDING CAGES	•		
AE-7	INTAKE CAT CAGES	•		
AE-8A	GROOMING TUB (LEFT HAND DRAIN)	•		
AE-8B	GROOMING TUB (RIGHT HAND DRAIN)	•		
AE-9	GROOMING TABLE	•		
AE-10A	OTHER ANIMAL CAGES	•		
AE-10B	OTHER ANIMAL CAGES	•		
AE-11	ANIMAL KITCHEN DISHWASHER - UNDER COUNTER	•		
AE-12	EXAM TABLE	•		
AE-13	SURGERY TABLE	•		1
AE-14	SURGERY LIGHT	•		
AE-15	EXAM TREATMENT TABLE	•		
AE-16A	LEFT HAND TUB TABLE	•		
AE-16B	RIGHT HAND TUB TABLE	•		
AE-17	COUNTERTOP AUTOCLAVE	•		
AE-18	WET DENTAL/TREATMENT LIFT TABLE	•		
AE-19	NARCOTICS SAFE	•		
AE-20	SCALES	•		
AE-21A	ICU CAGES	•		
AE-21B	ICU CAGES	•		
AE-22	CAT PET DOORS	•		
AE-23	CATIO ENCLOSURE PANELS	•		
AE-24	ANESTHESIA MACHINE	•		
NOTES				
1. REFER TO DETAIL 8/AE8 FOR LIGHT MOUNTING SUPPORT DETAIL.				
2. RUNS LABELED WITH 'CT' MEANS THEY ARE TO RECEIVED CAGE TOPS.				



1177 Idaho Street, Suite 200
Redlands, CA 92374
Phone: 909-335-7400
Fax: 909-335-7299
info@millar-aip.com

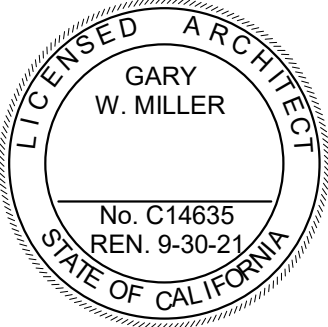


owner approval		
initials	date	phase
revisions/addenda		
#	Date	Comment

ANIMAL CARE CENTER
18313 VALLEY BLVD. BLOOMINGTON, CA 92313
SAN BERNARDINO COUNTY

project information	
Project Number:	1227
Drawn By:	AE
Checked By:	MB
Issue Date:	05/31/23

sheet name
ANIMAL EQUIPMENT PLAN

sheet number
AE1
Sheet Of Sheets

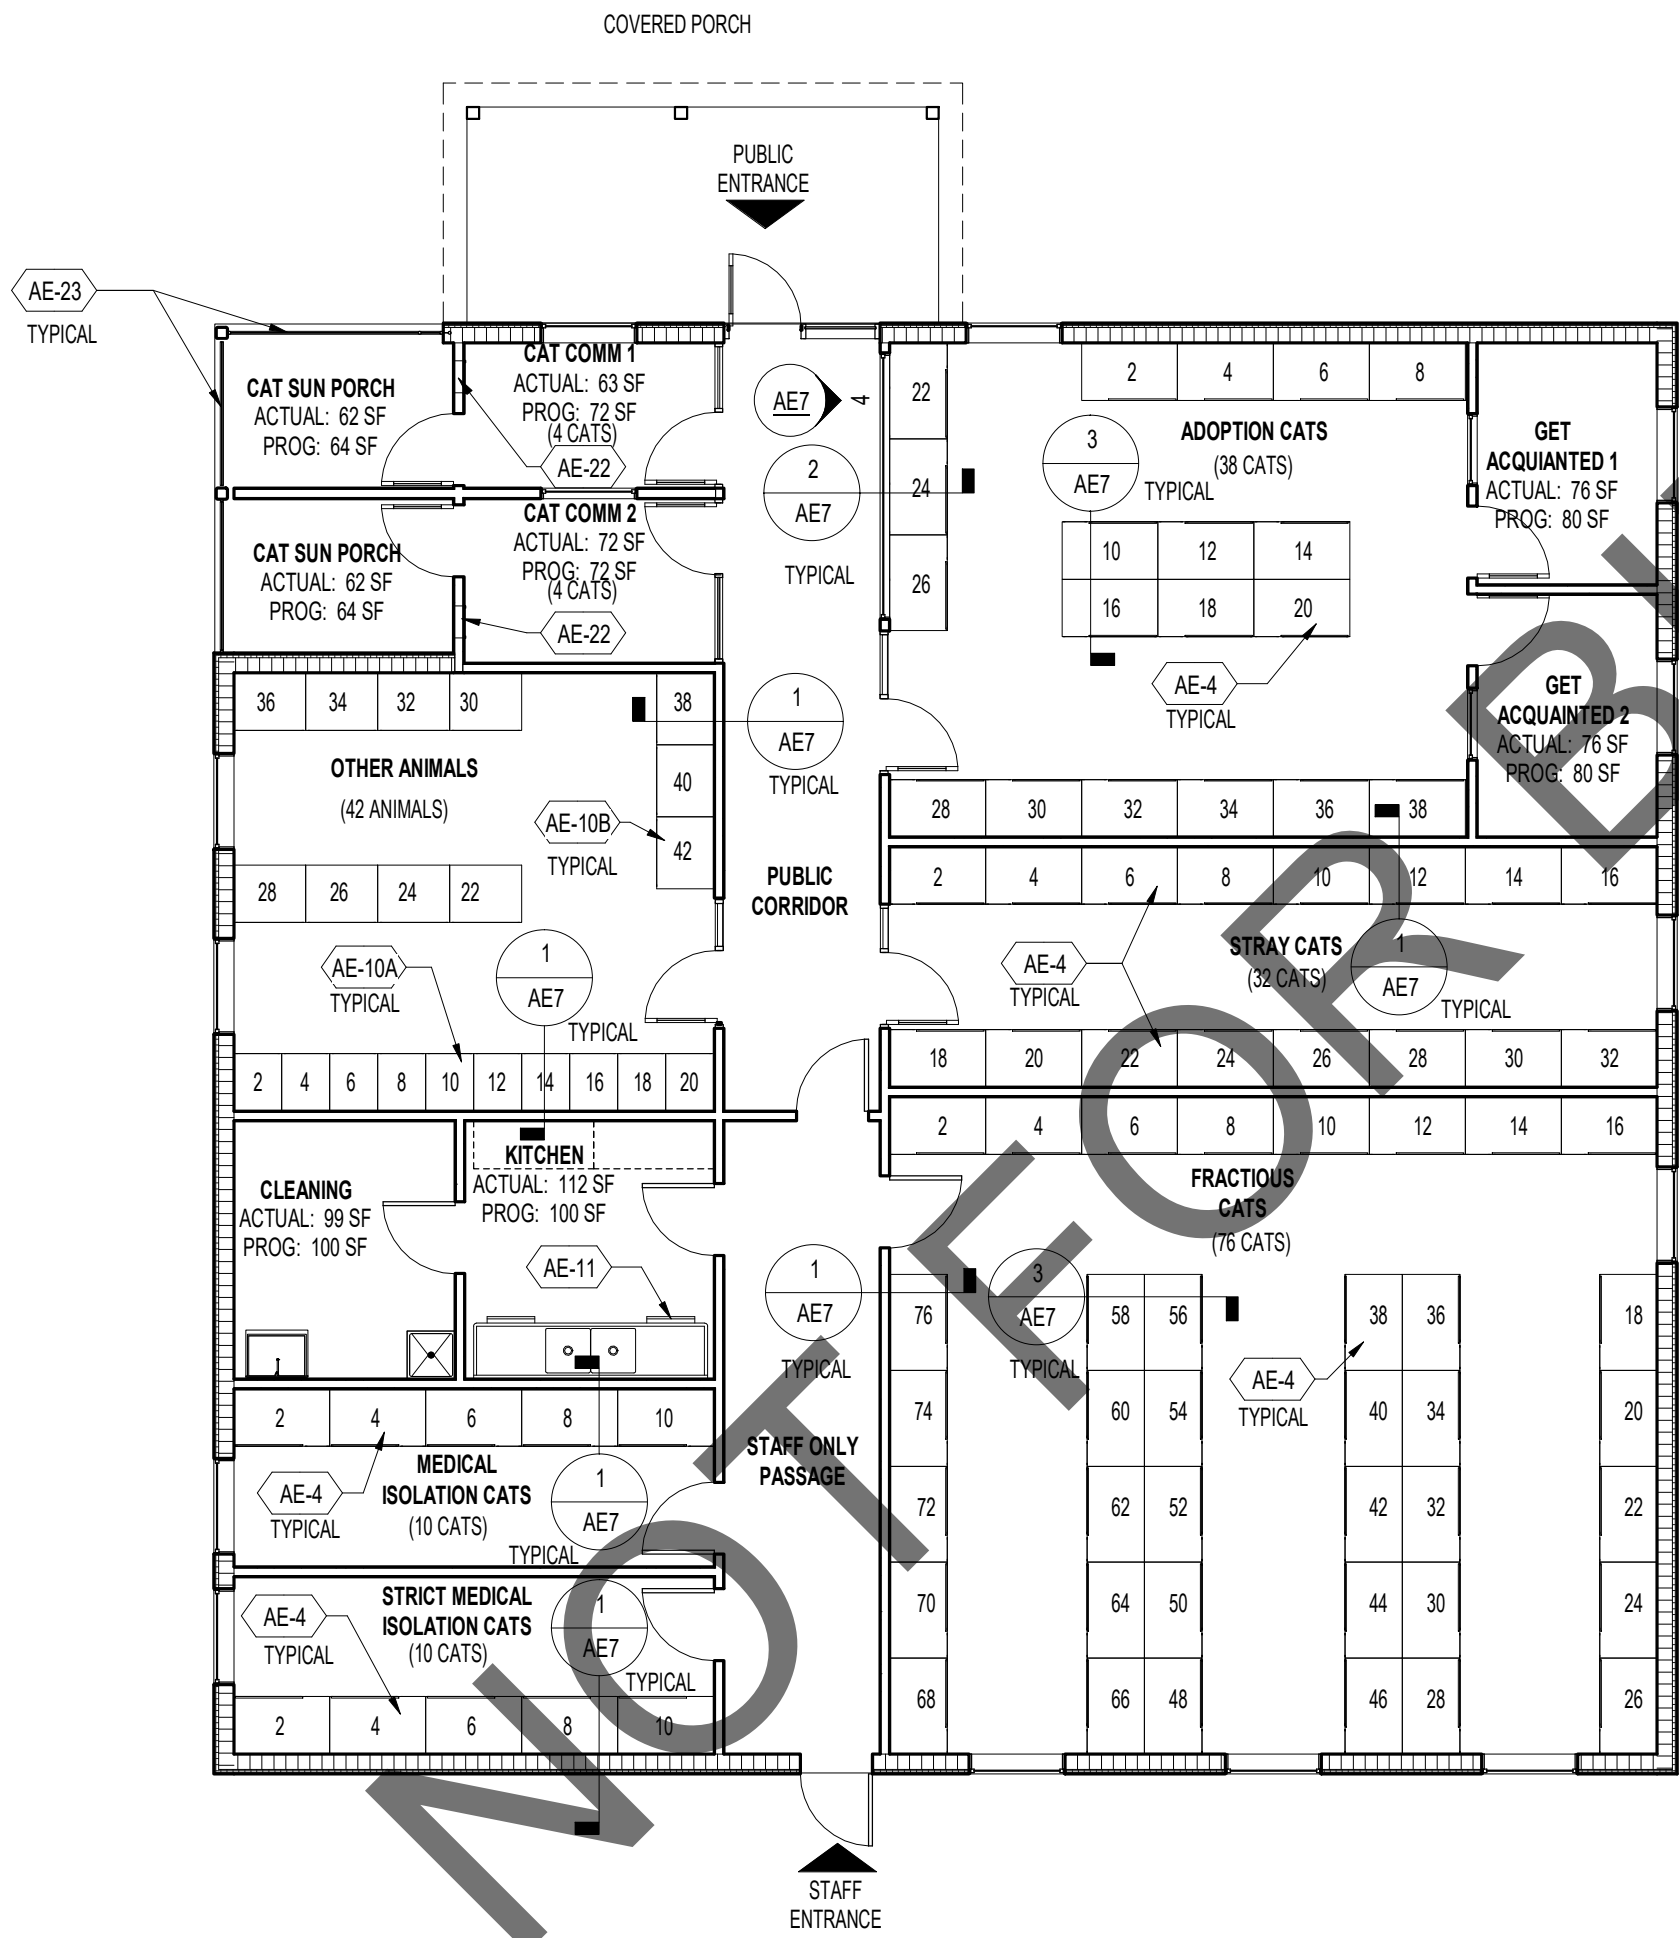


2 ANIMAL EQUIPMENT PLAN - CAT AND OTHER ANIMALS BUILDING
1/8" = 1'-0"

FOR ANIMAL EQUIPMENT LEGEND AND GENERAL NOTES
REFER TO SHEET AE1



1177 Idaho Street, Suite 200
Redlands, CA 92374
Phone: 909-335-7400
Fax: 909-335-7299
info@millar-aip.com

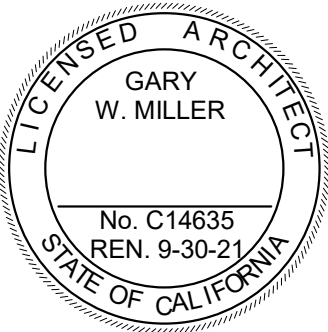

owner approval

initials	date	phase

revisions/addenda

#	Date	Comment
---	------	---------

ANIMAL CARE CENTER

18313 VALLEY BLVD. BLOOMINGTON, CA 92313

SAN BERNARDINO COUNTY

project information


Project Number:	1227
Drawn By:	AE
Checked By:	MB
Issue Date:	05/31/23

sheet name

ANIMAL
EQUIPMENT
PLAN

sheet number

AE2

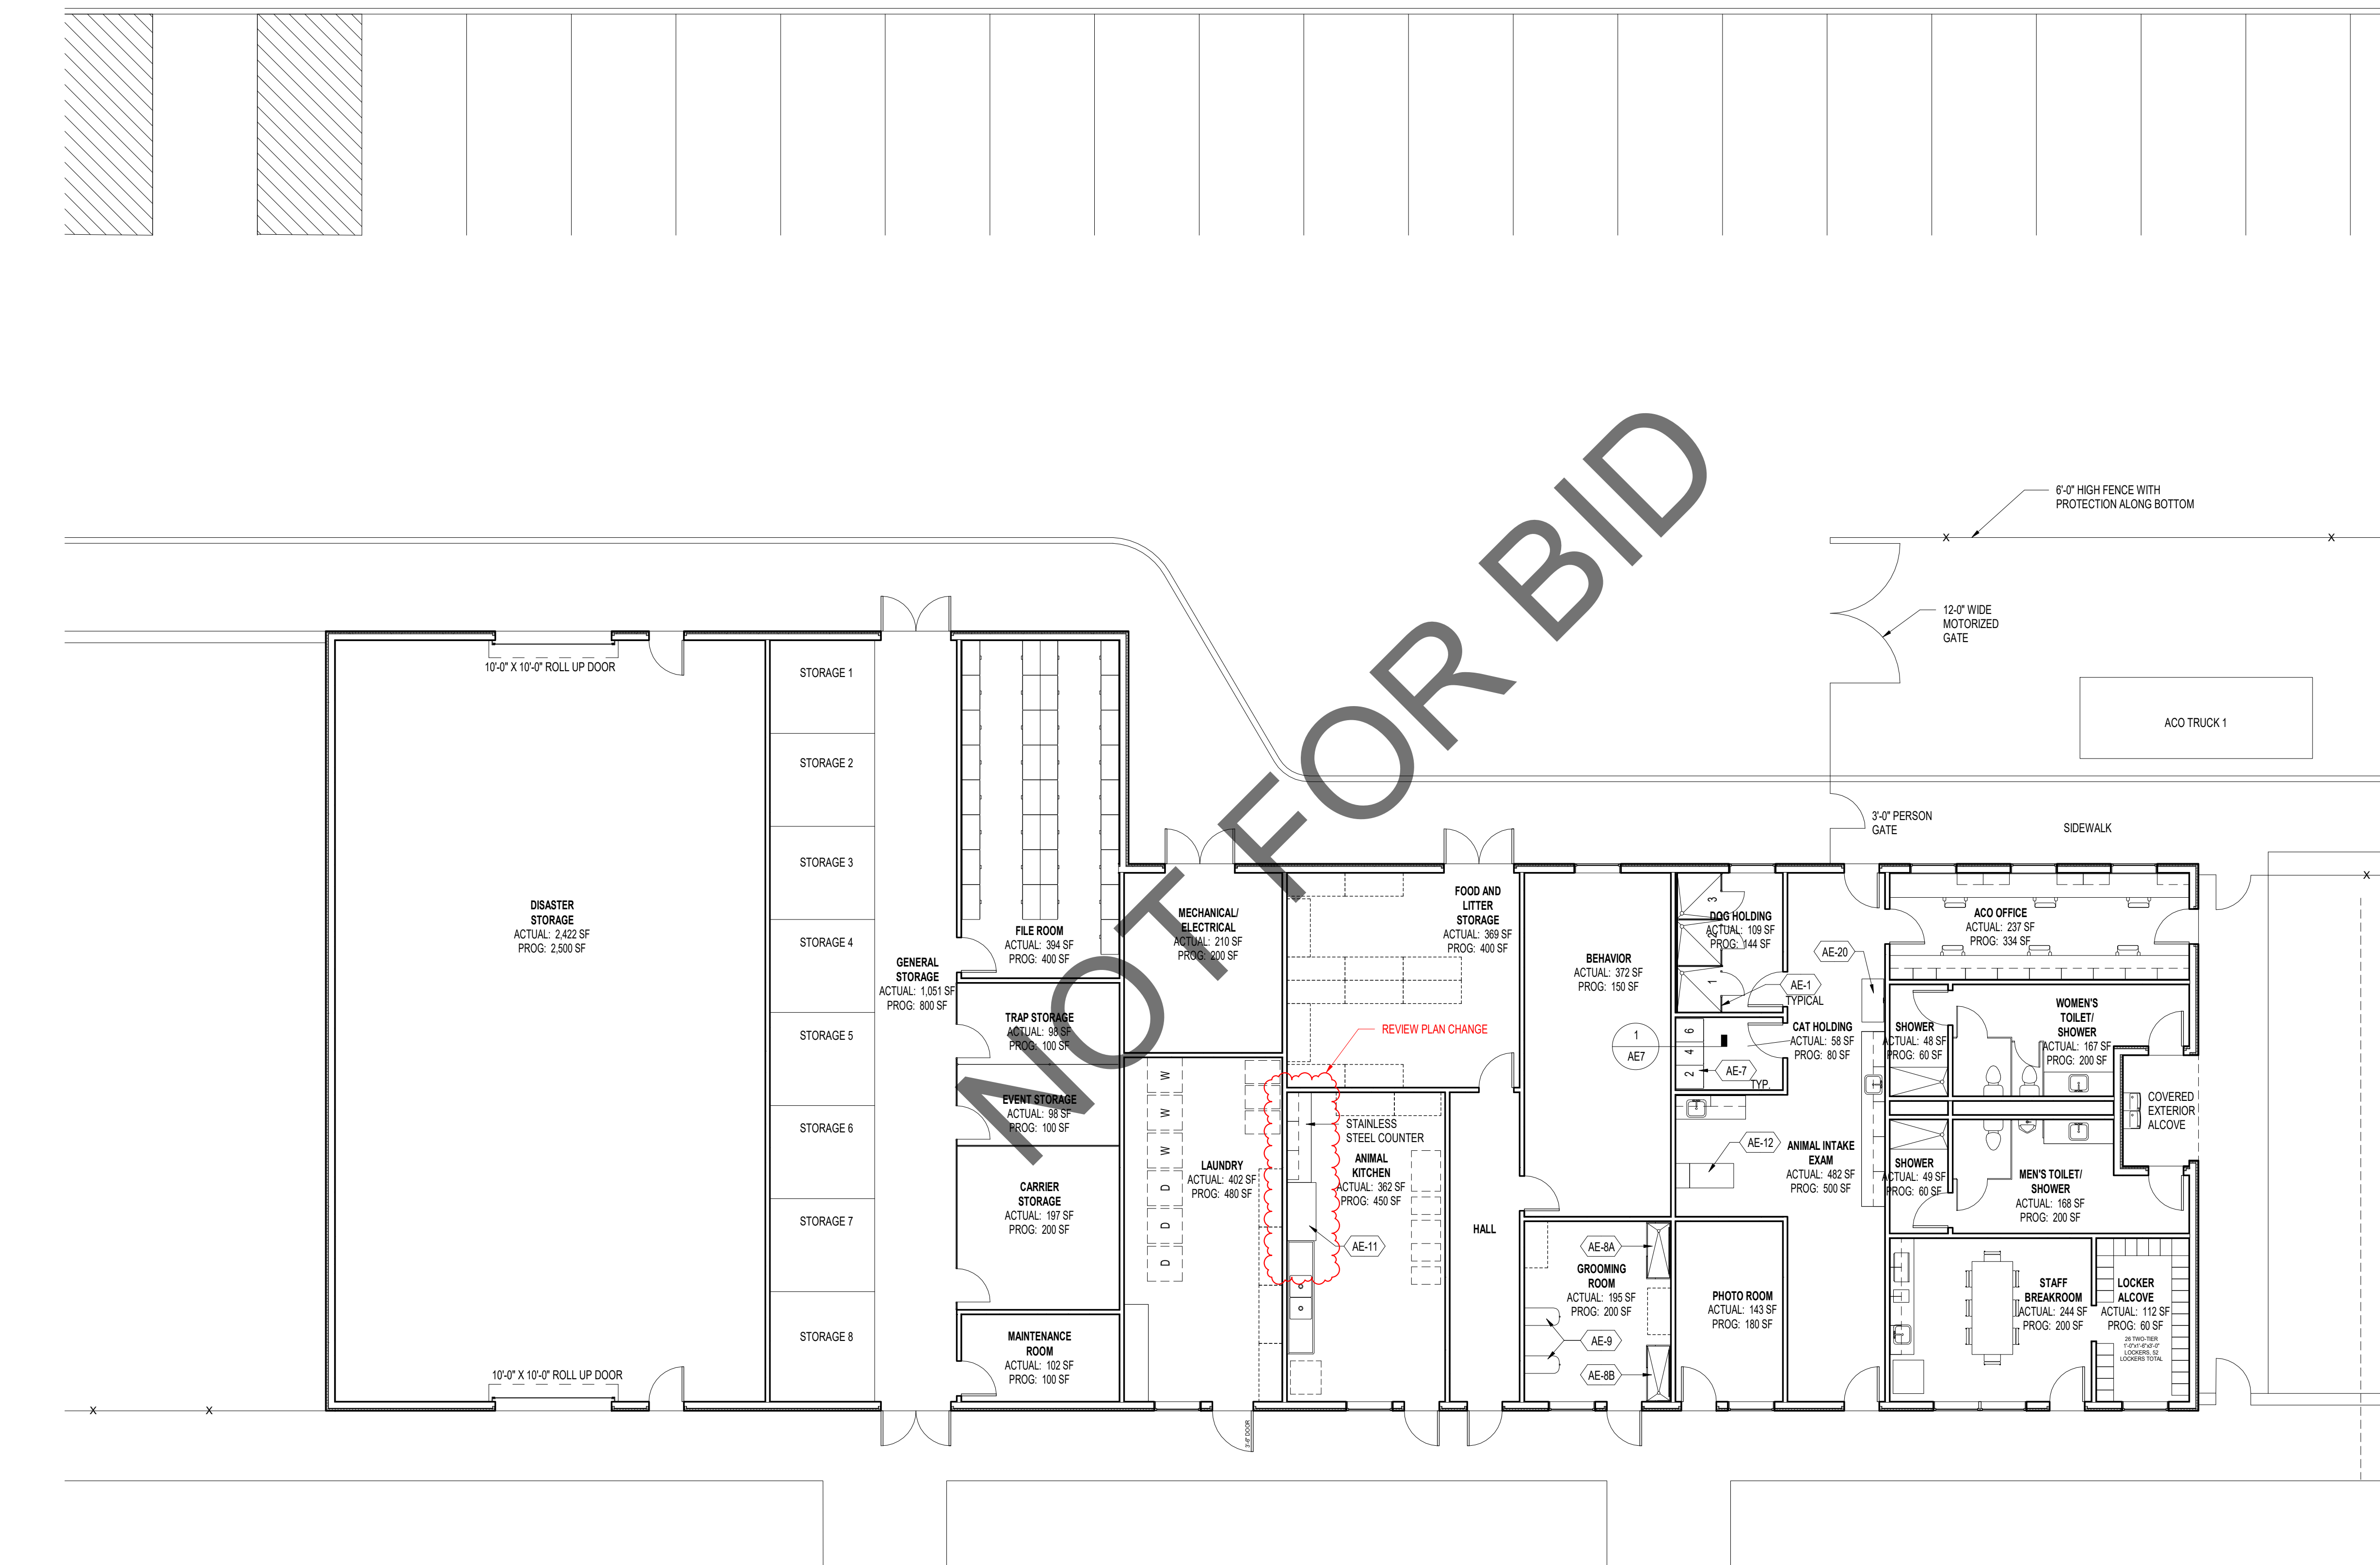

1 ANIMAL EQUIPMENT PLAN - SUPPORT BUILDING
1/8" = 1'-0"

FOR ANIMAL EQUIPMENT LEGEND AND GENERAL NOTES
REFER TO SHEET AE1



architecture
interiors
planning

MILLER



1177 Idaho Street, Suite 200
Redlands, CA 92374
Phone: 909-335-7400
Fax: 909-335-7299
info@miller-aip.com



owner approval

initials	date	phase

revisions/addenda

#	Date	Comment
1	9/13/1	Revision 1
7		

ANIMAL CARE CENTER

18313 VALLEY BLVD. BLOOMINGTON, CA 92313

SAN BERNARDINO COUNTY

project information


Project Number:	1227
Drawn By:	AE
Checked By:	MB
Issue Date:	05/31/23

sheet name

ANIMAL
EQUIPMENT
PLAN

sheet number

AE3

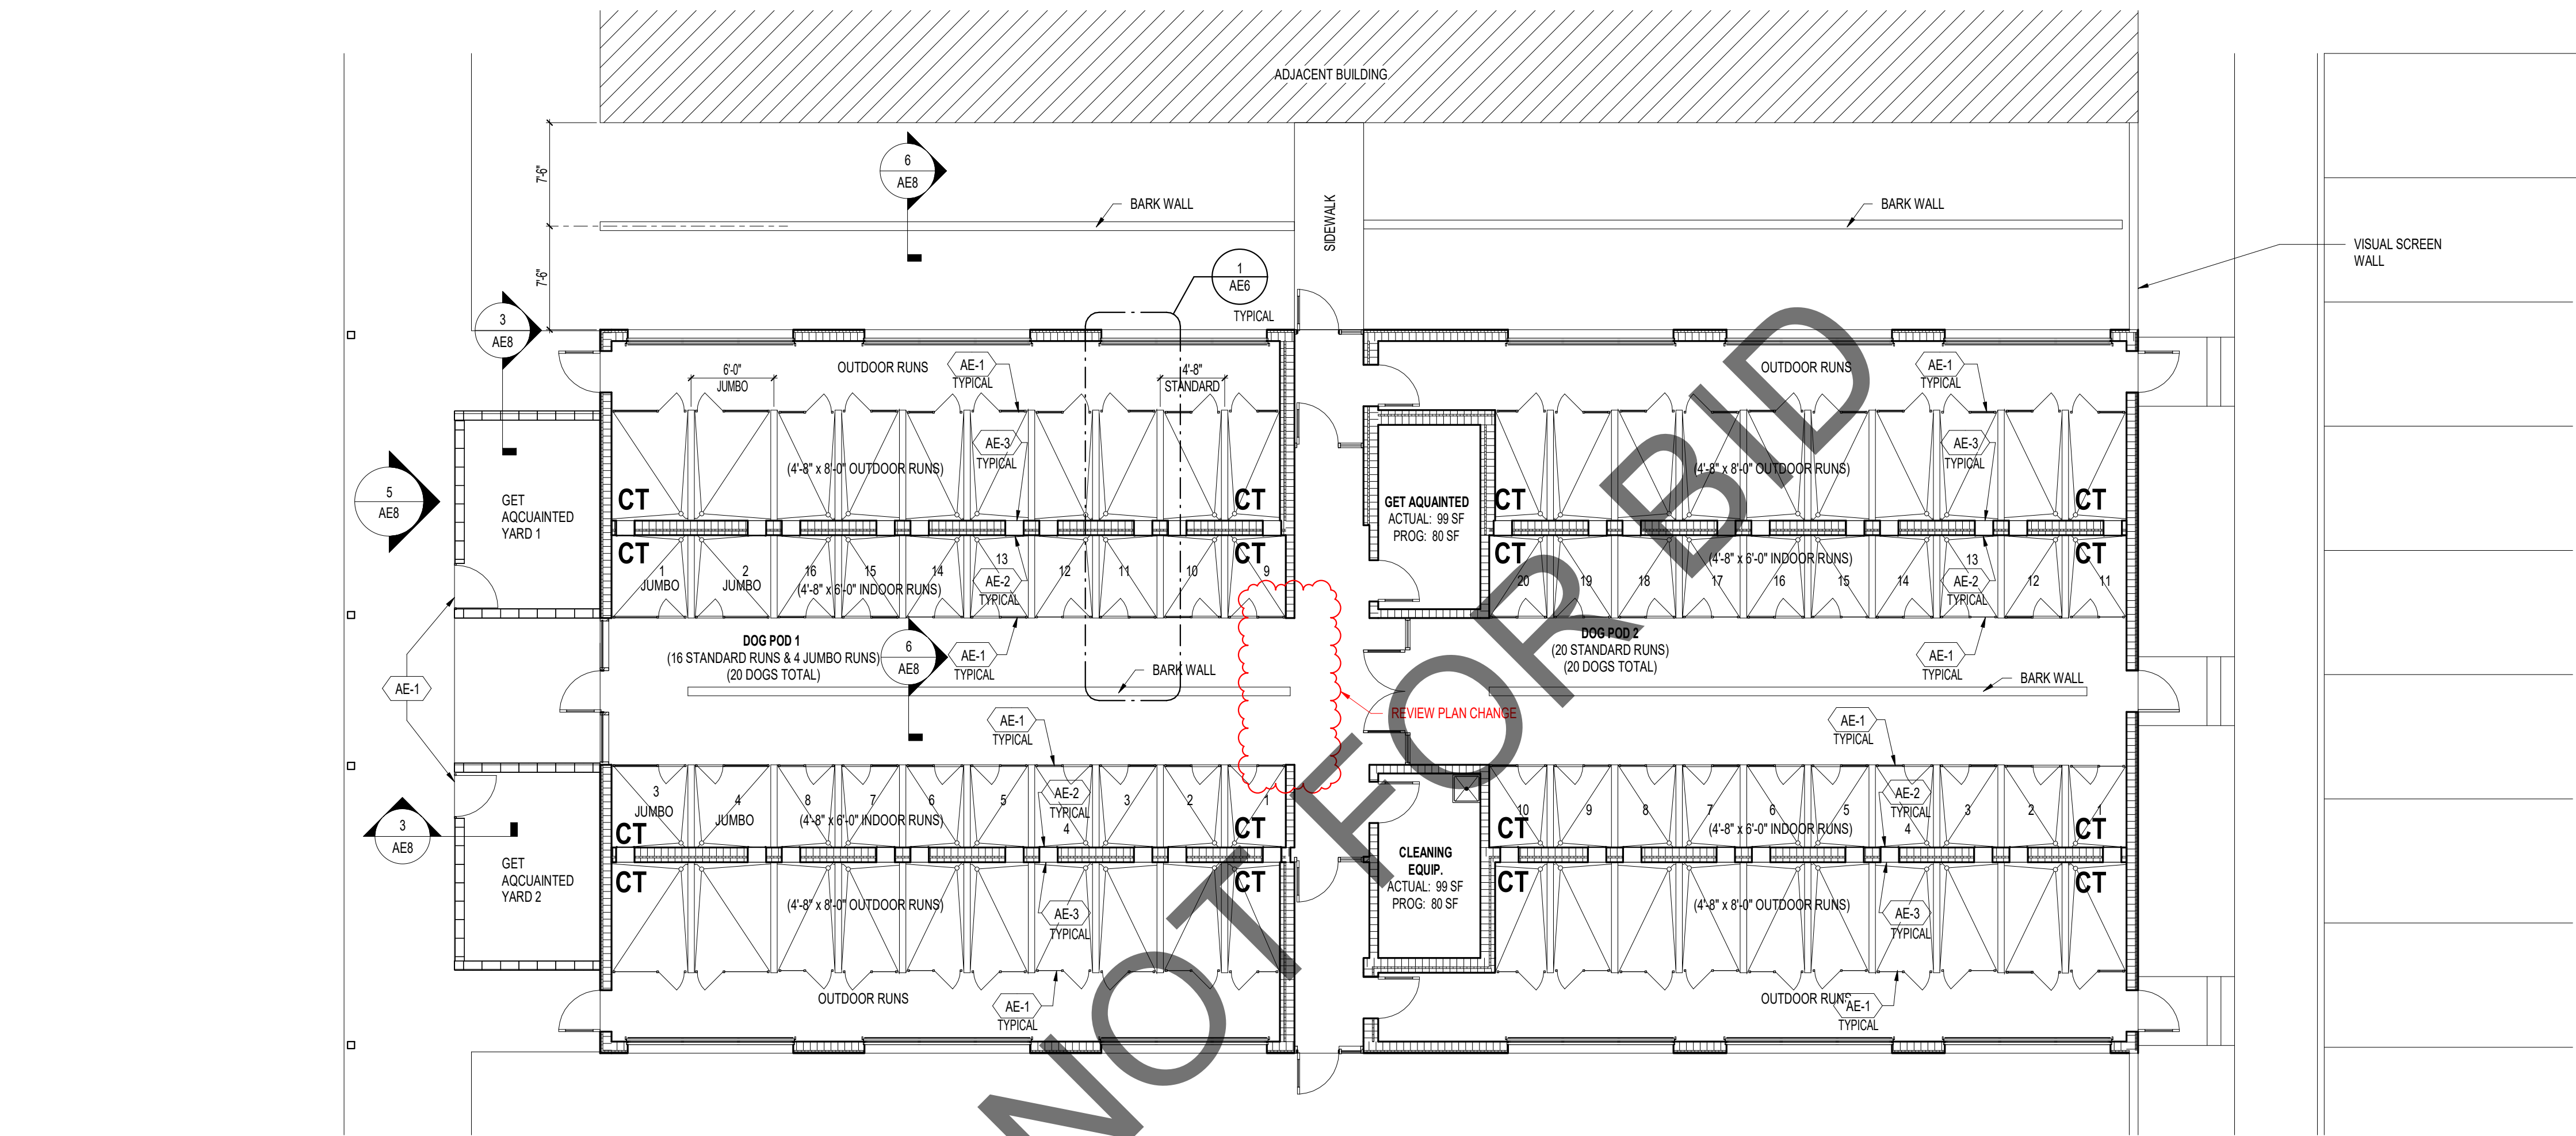

1 ANIMAL EQUIPMENT PLAN - ADOPTION DOG BUILDING 1,2,3 AND STRAY DOG BUILDING
1/8" = 1'-0"


FOR ANIMAL EQUIPMENT LEGEND AND GENERAL NOTES
REFER TO SHEET AE1



architecture
interiors
planning



1177 Idaho Street, Suite 200
Redlands, CA 92374
Phone: 909-335-7400
Fax: 909-335-7299
info@millar-aip.com

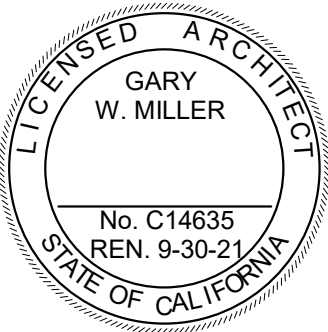

owner approval

initials	date	phase

revisions/addenda

#	Date	Comment
1	9/13/1	Revision 1
7		

ANIMAL CARE CENTER

18313 VALLEY BLVD. BLOOMINGTON, CA 92313

SAN BERNARDINO COUNTY

project information


Project Number:	1227
Drawn By:	AE
Checked By:	MB
Issue Date:	05/31/23

sheet name

ANIMAL
EQUIPMENT
PLAN

sheet number

AE4

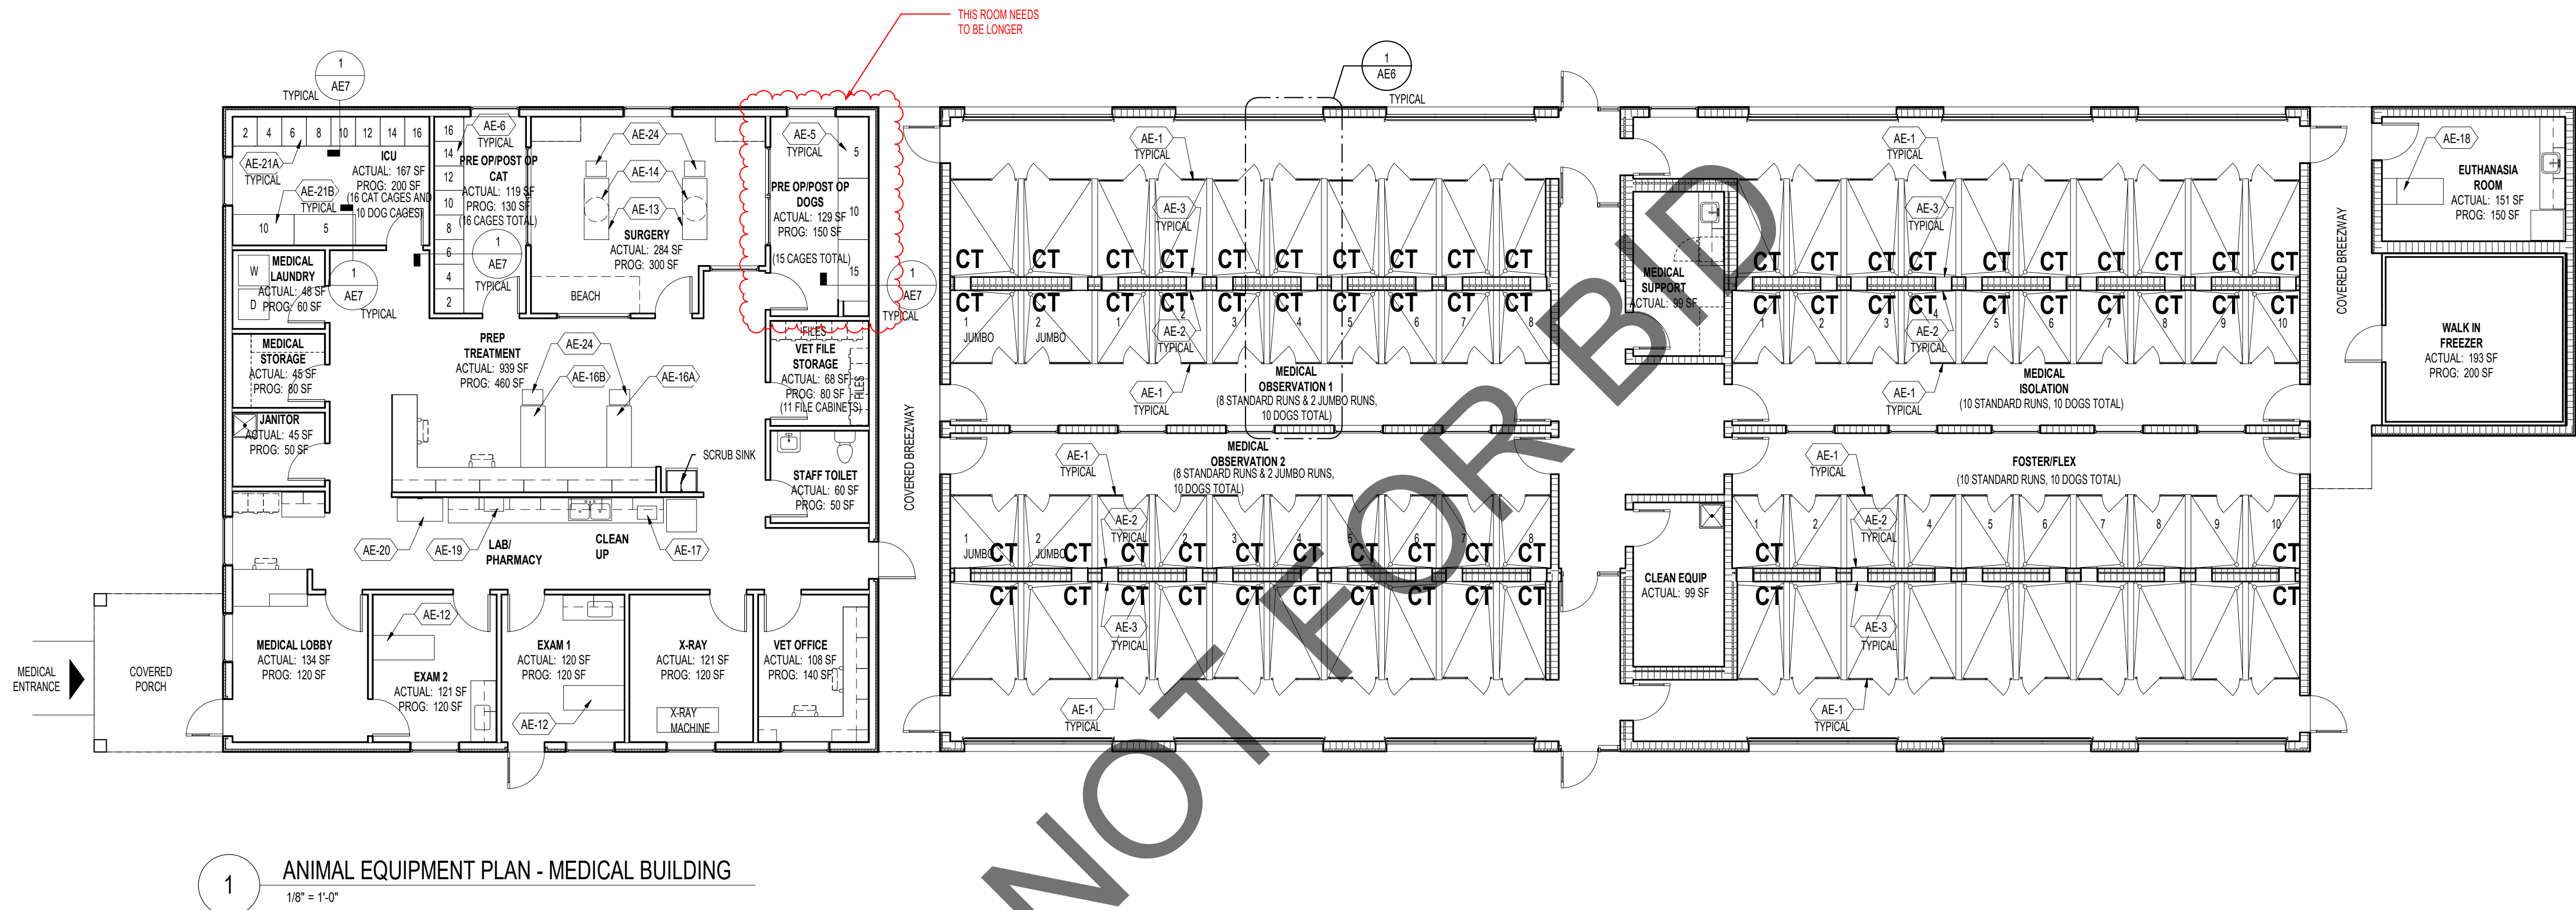

FOR ANIMAL EQUIPMENT LEGEND AND GENERAL NOTES
REFER TO SHEET AE1



1177 Idaho Street, Suite 200
Redlands, CA 92374
Phone: 909-335-7400
Fax: 909-335-7299
info@millar-aip.com



owner approval

initials	date	phase

revisions/addenda

#	Date	Comment
1	9/13/1	Revision 1
7		

ANIMAL CARE CENTER

18313 VALLEY BLVD. BLOOMINGTON, CA 92313

SAN BERNARDINO COUNTY

project information

Project Number:	1227
Drawn By:	AE
Checked By:	MB
Issue Date:	05/31/23



sheet name


ANIMAL
EQUIPMENT
PLAN

sheet number


AE5

  Sheet Of Sheets




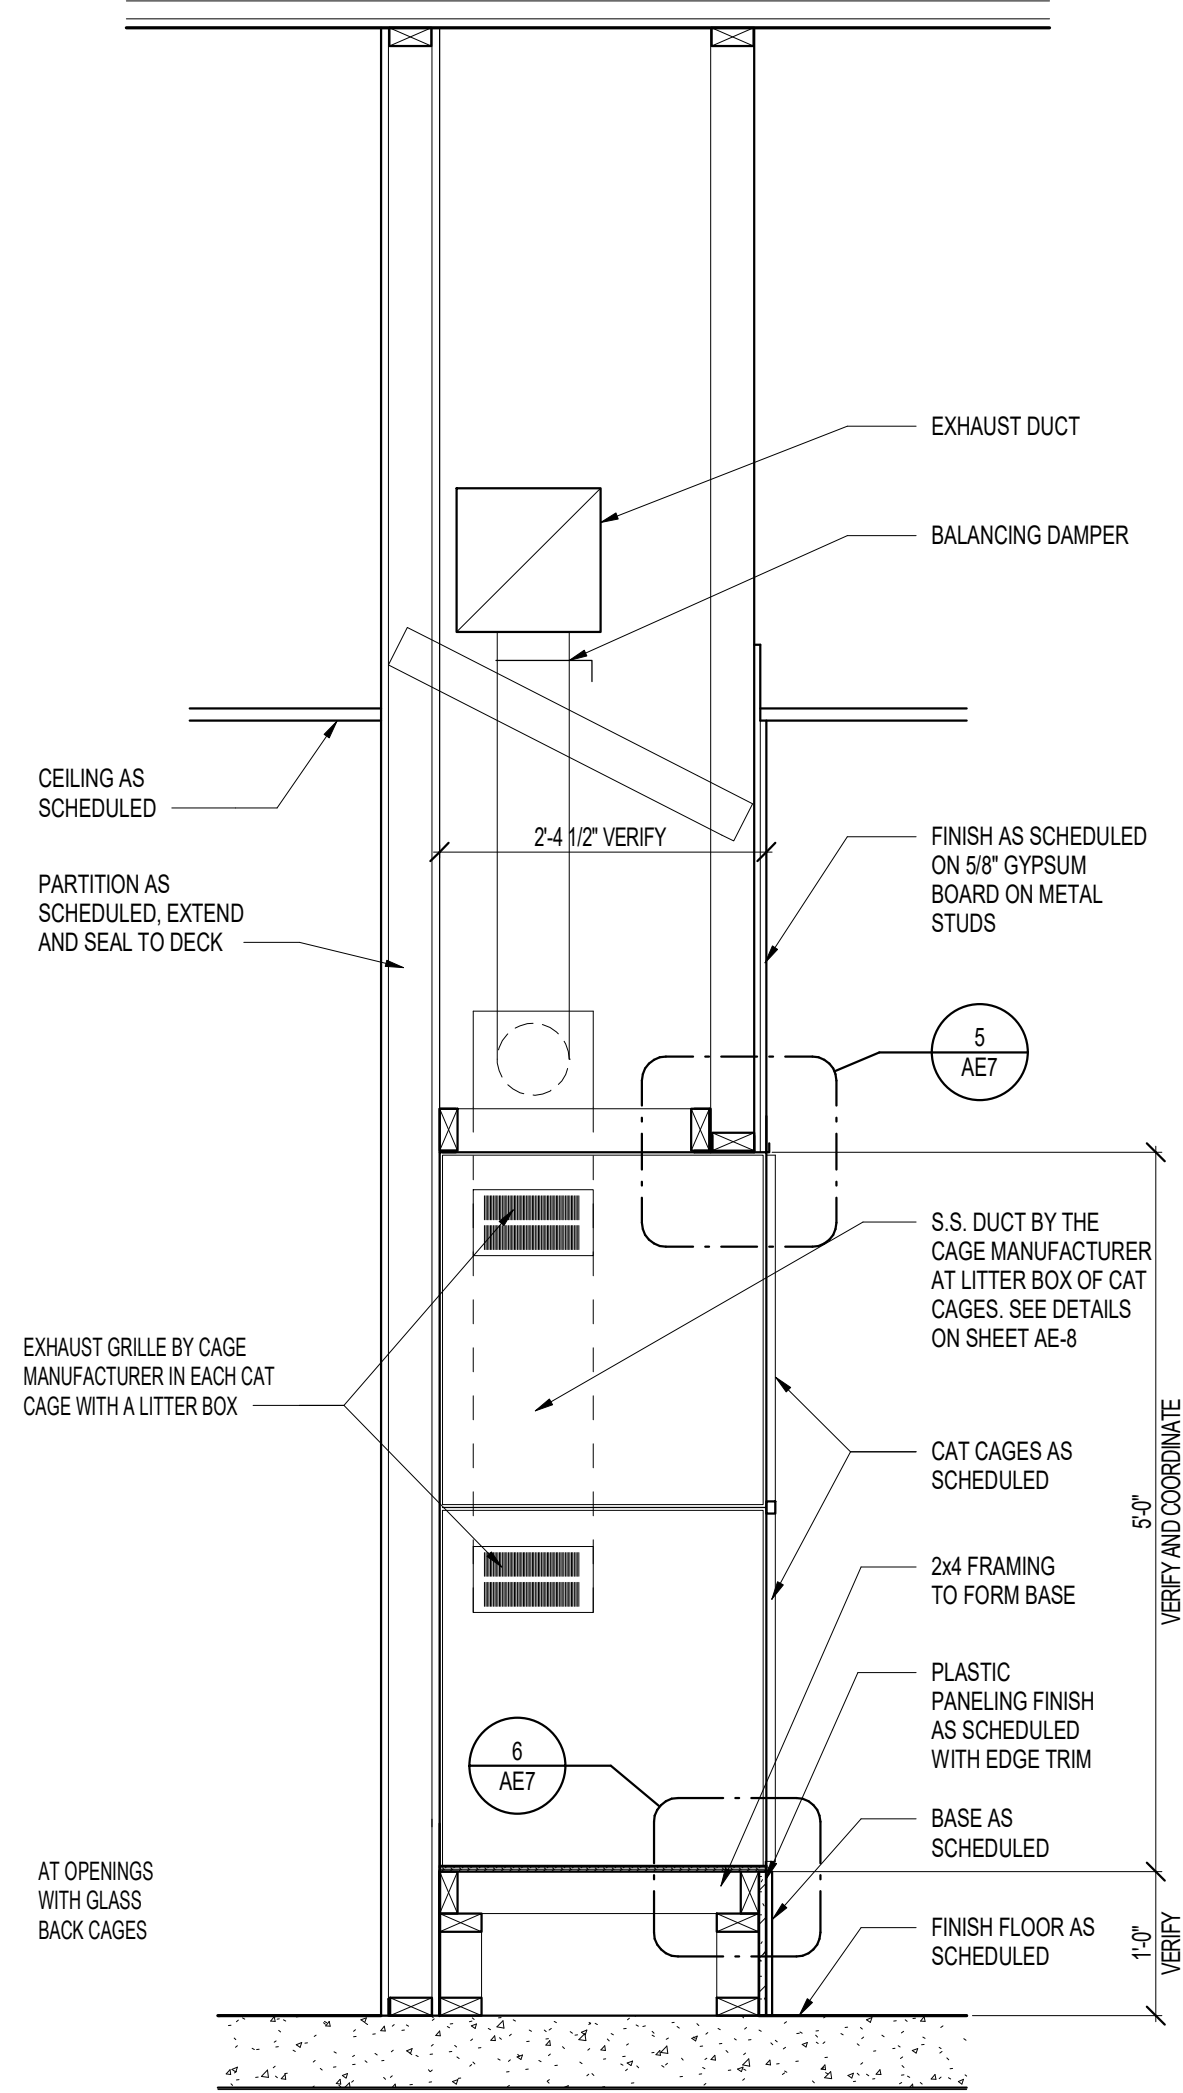


1 SECTION - RECESSED CAGE
3/4" = 1'-0"

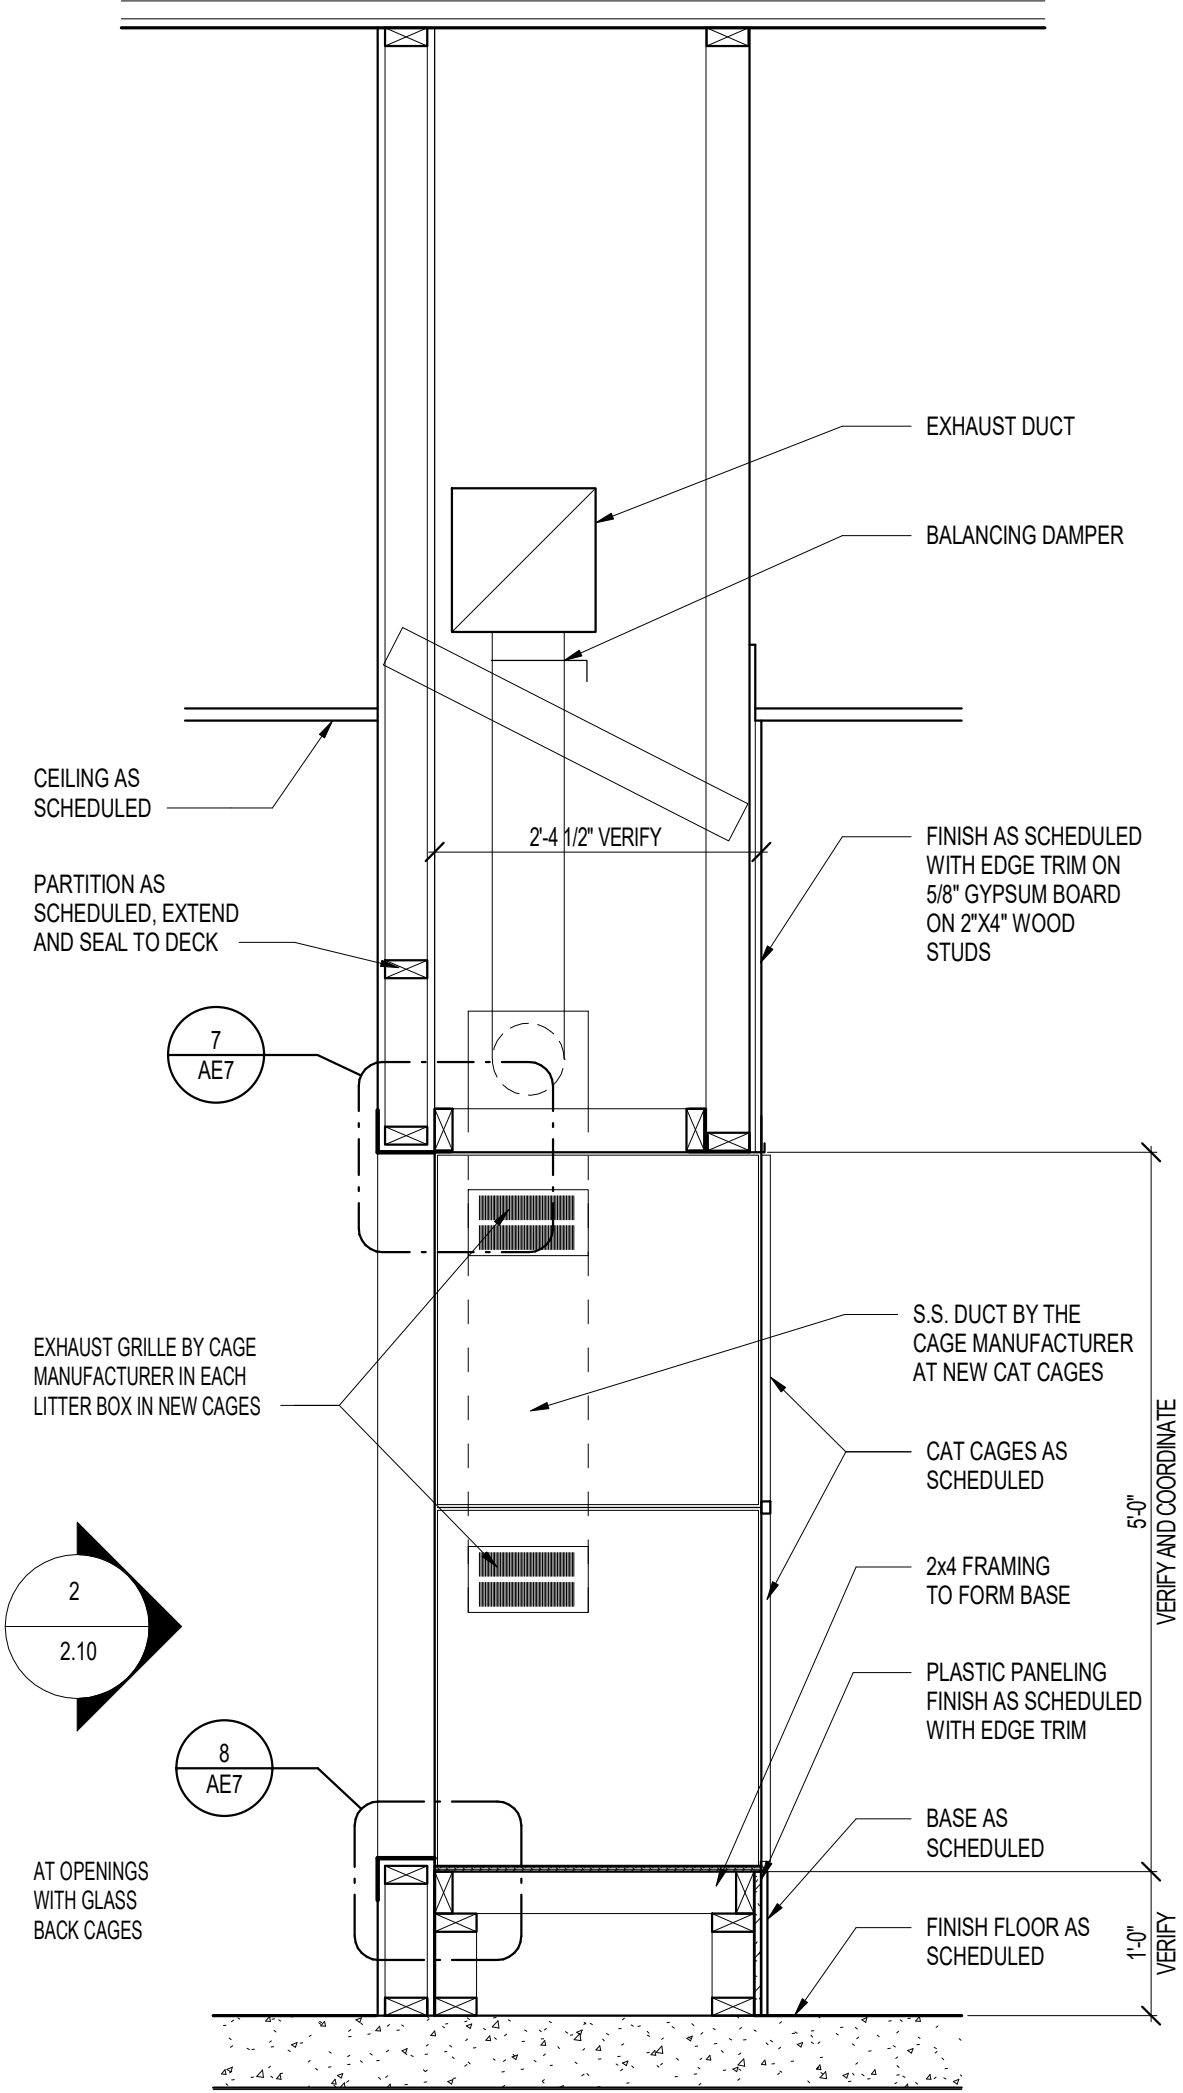


2 SECTION - RECESSED CAGES WITH GLASS BACKS
3/4" = 1'-0"

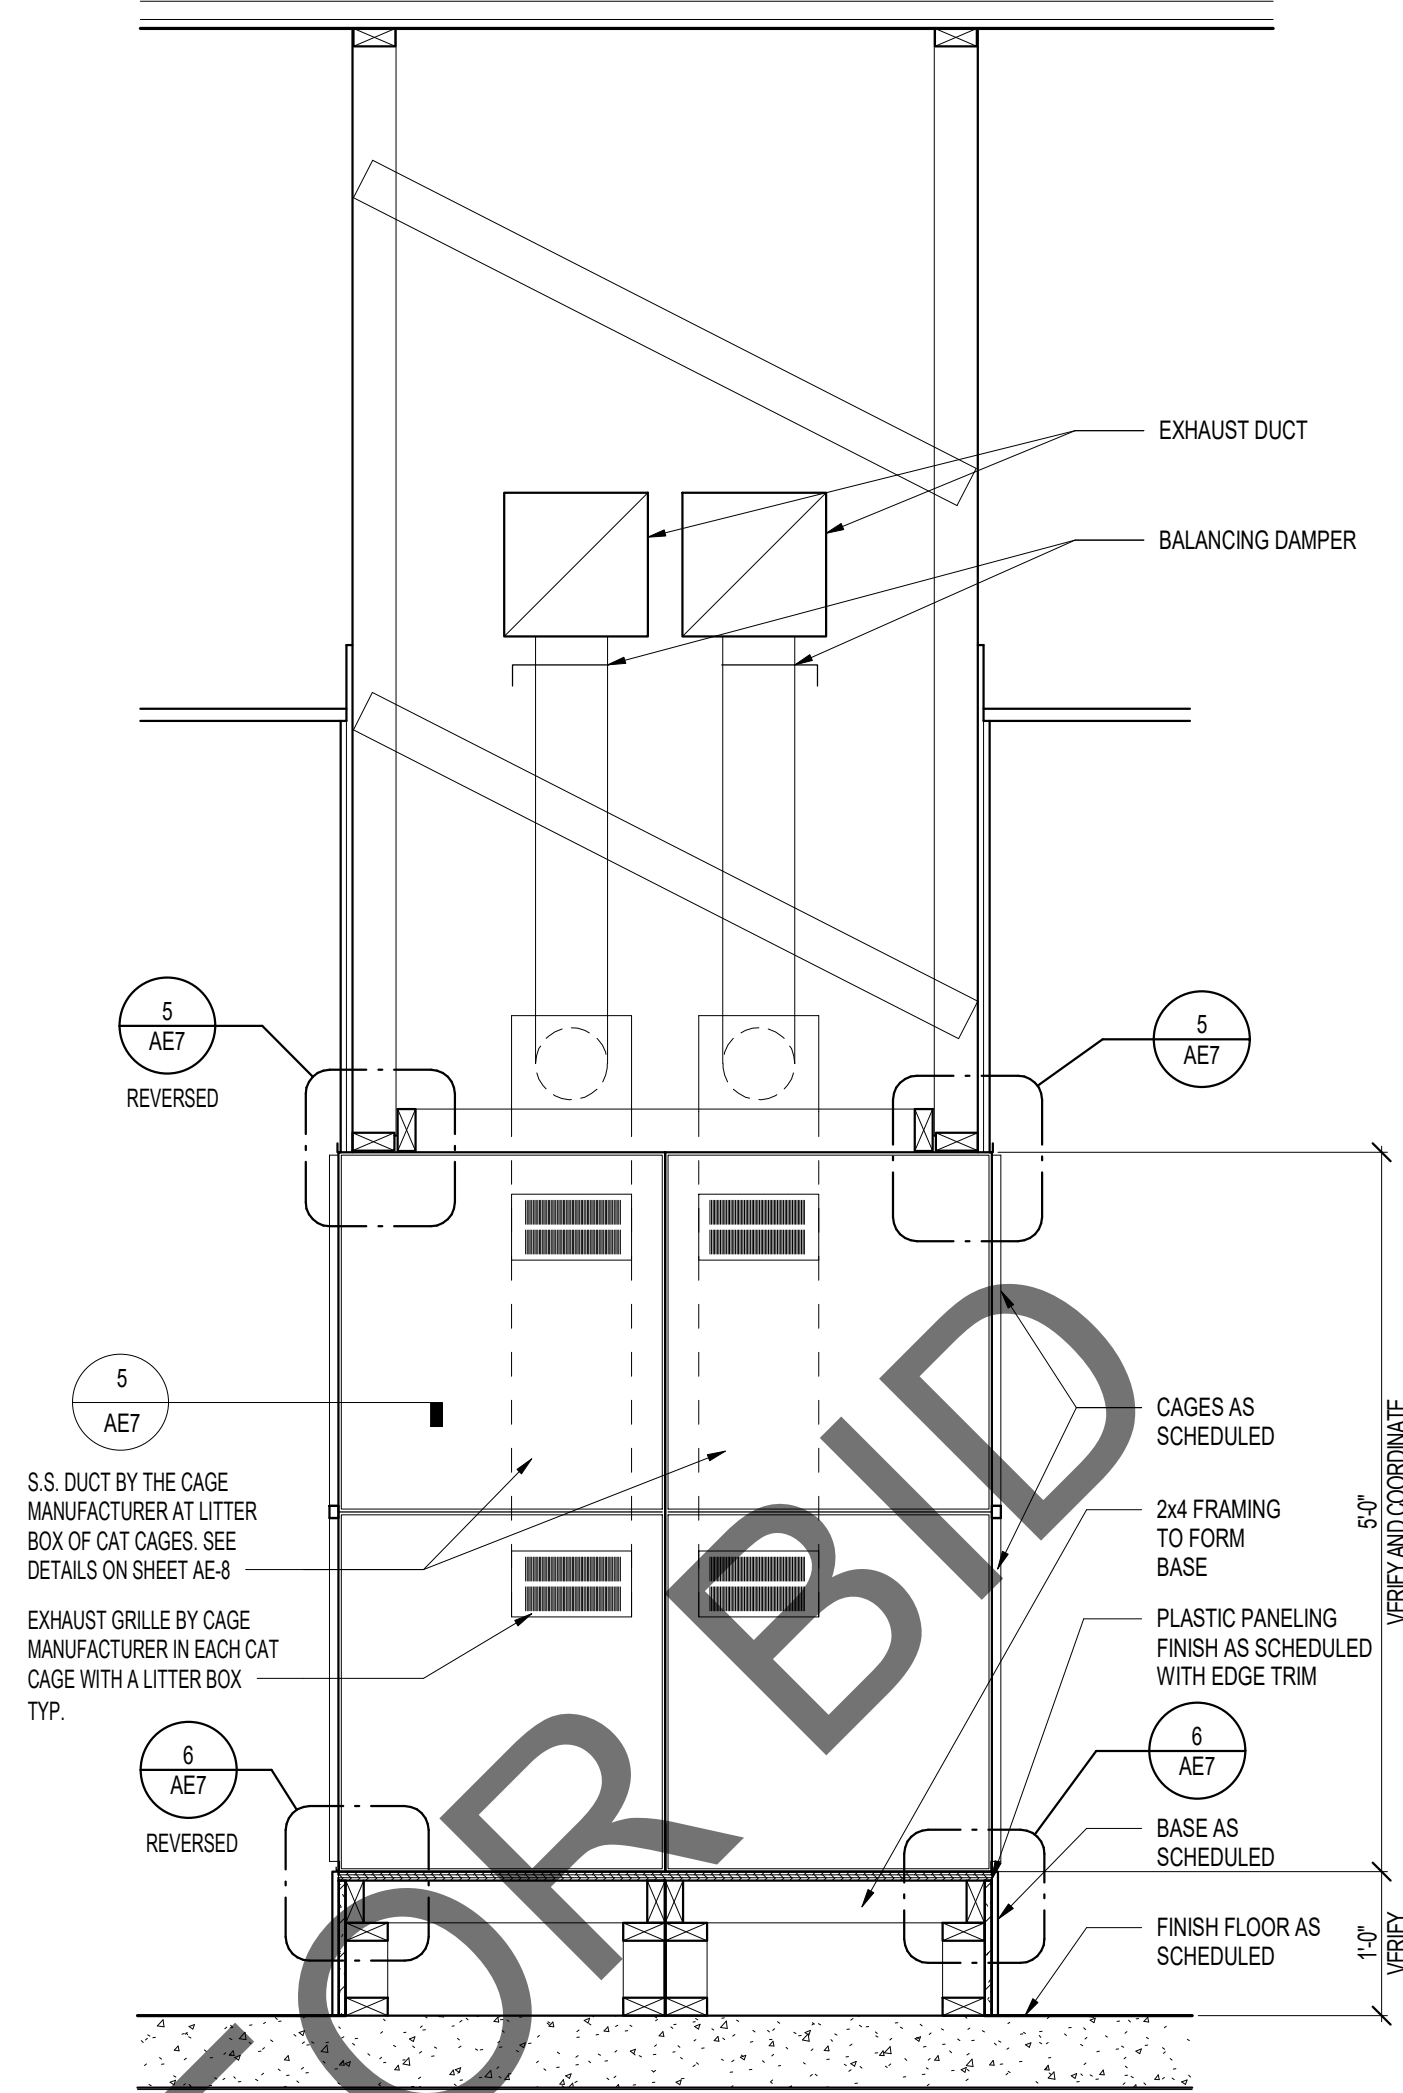


3 SECTION - BACK TO BACK RECESSED CAGES
3/4" = 1'-0"

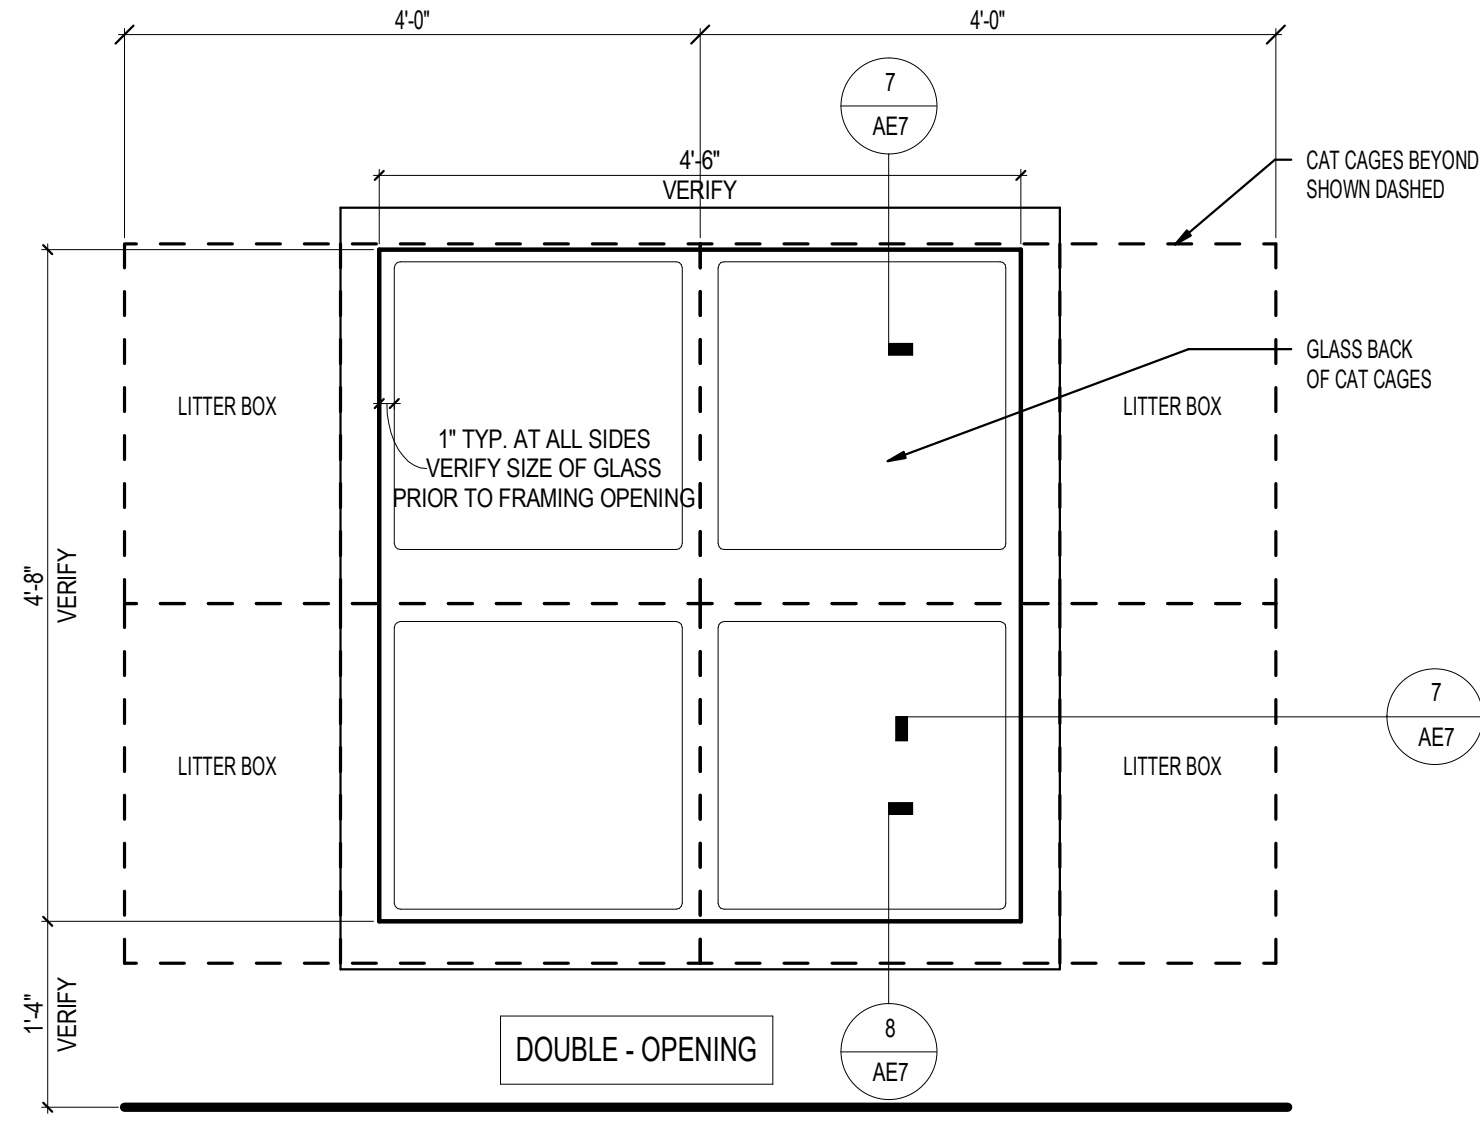


4 ELEVATION - CAT CAGE VIEW WINDOW
3/4" = 1'-0"

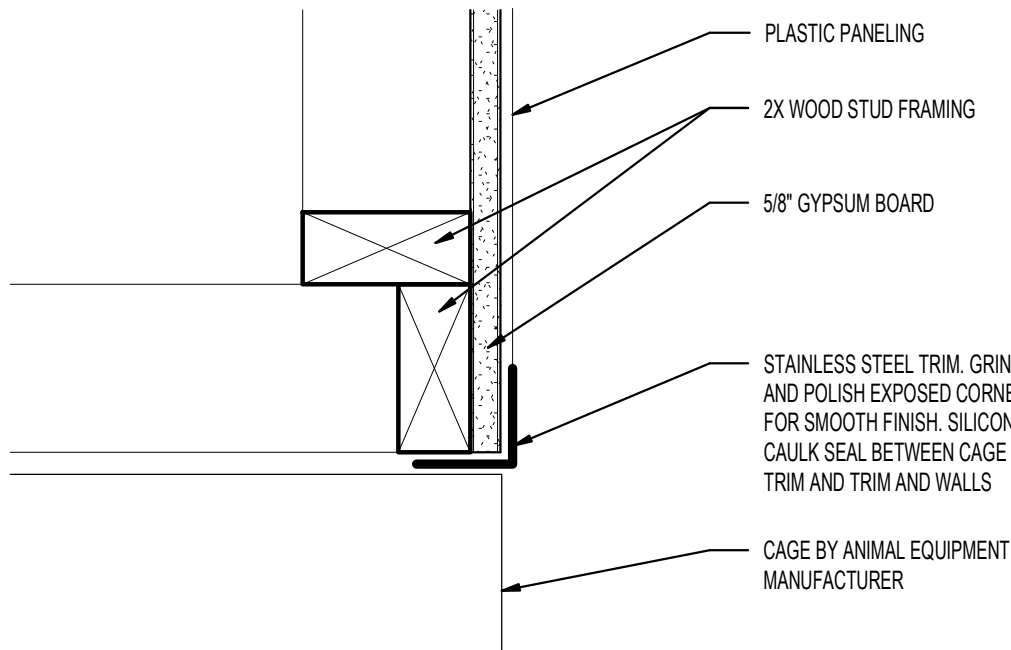


5 CAT CAGE HEAD AND JAMB
3" = 1'-0"

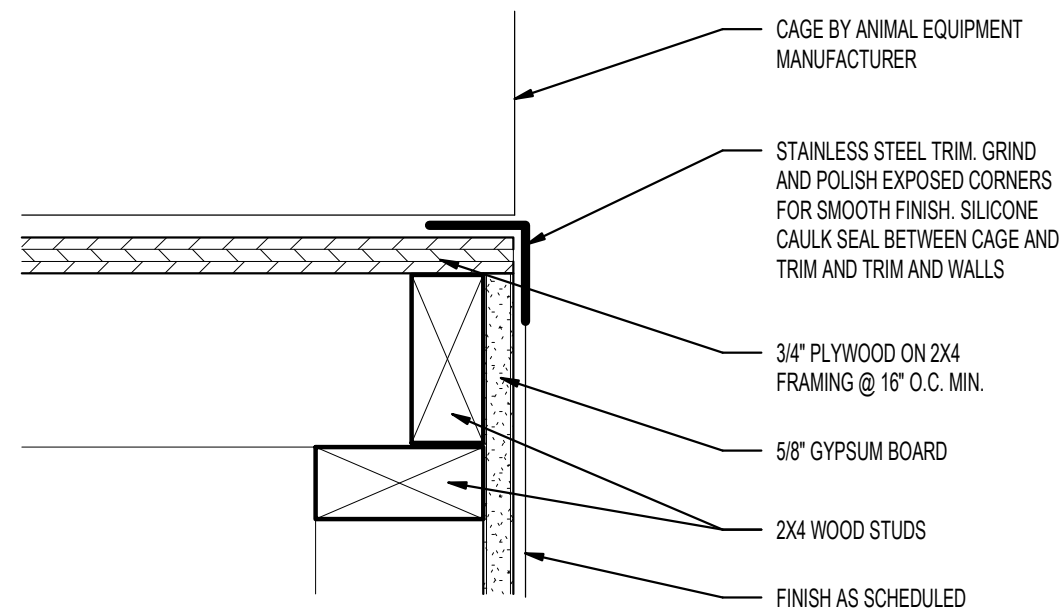

6 CAT CAGE SILL
3" = 1'-0"

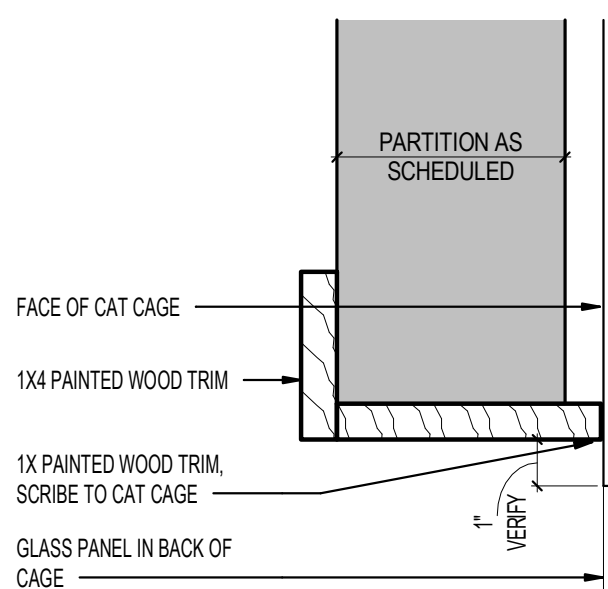

7 CAT CAGE VIEW WINDOW HEAD AND JAMB
3" = 1'-0"

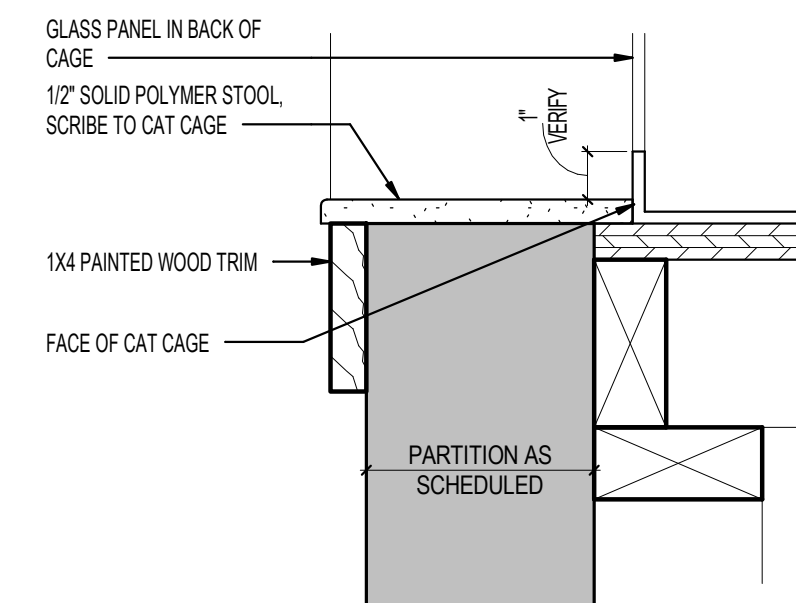

8 CAT CAGE VIEW WINDOW SILL
3" = 1'-0"



architecture
interiors
planning



1177 Idaho Street, Suite 200
Redlands, CA 92374
Phone: 909-335-7400
Fax: 909-335-7299
info@miller-aip.com



owner approval

initials	date	phase

revisions/addenda

#	Date	Comment
---	------	---------

ANIMAL CARE CENTER

18313 VALLEY BLVD. BLOOMINGTON, CA 92313

SAN BERNARDINO COUNTY

project information

Project Number: 1227
Drawn By: AE
Checked By: MB
Issue Date: 05/31/23


sheet name

ANIMAL
EQUIPMENT
DETAILS


sheet number

AE7


Sheet Of Sheets

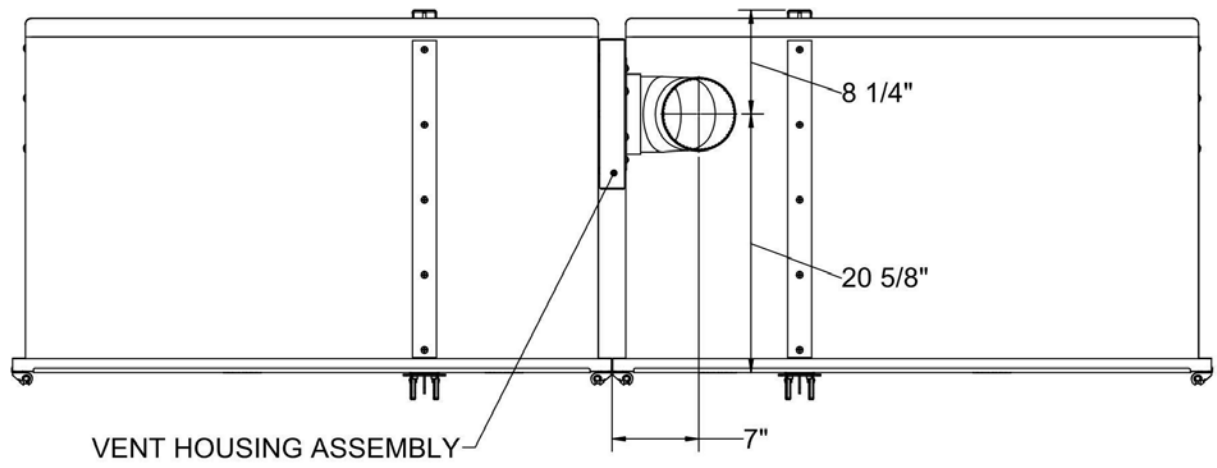


1 SHOR-LINE CAT CAGE VENTILATION DETAIL FOR NEW CAT CAGES
1" = 40'-0"

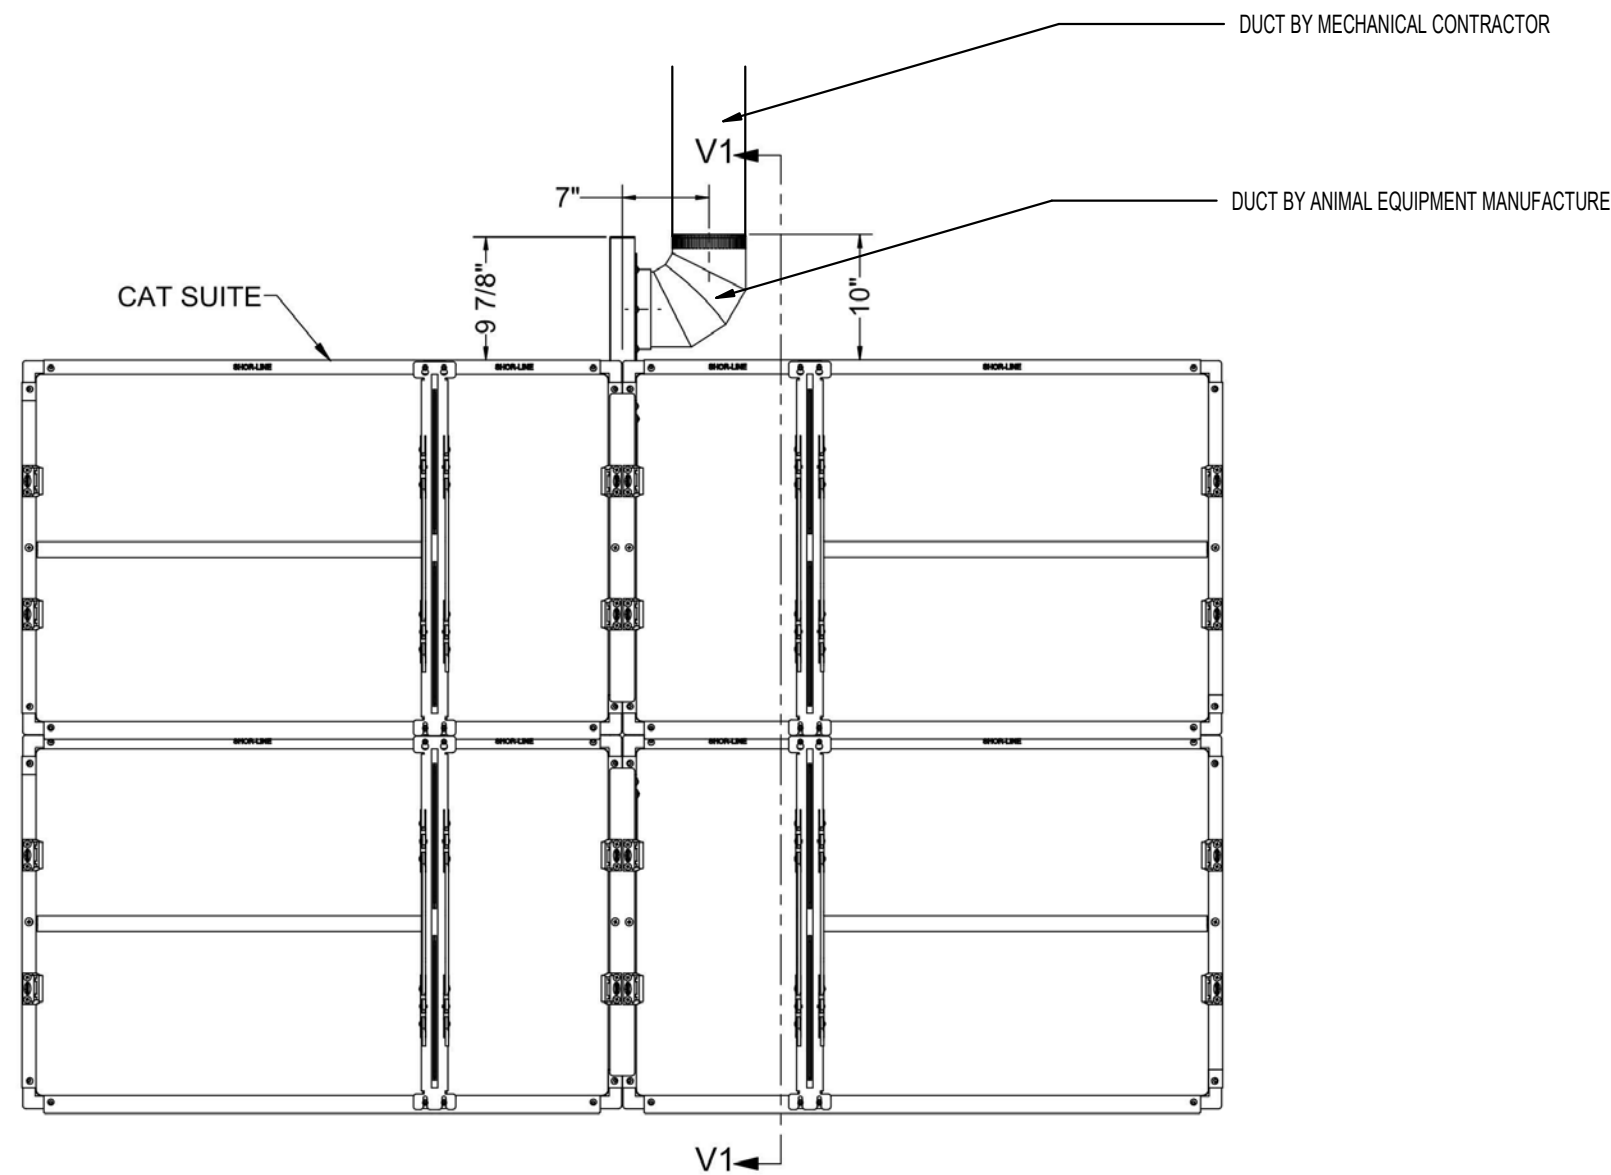


2 SHOR-LINE CAT CAGE VENTILATION DETAIL FOR NEW CAT CAGES
1/8" = 1'-0"

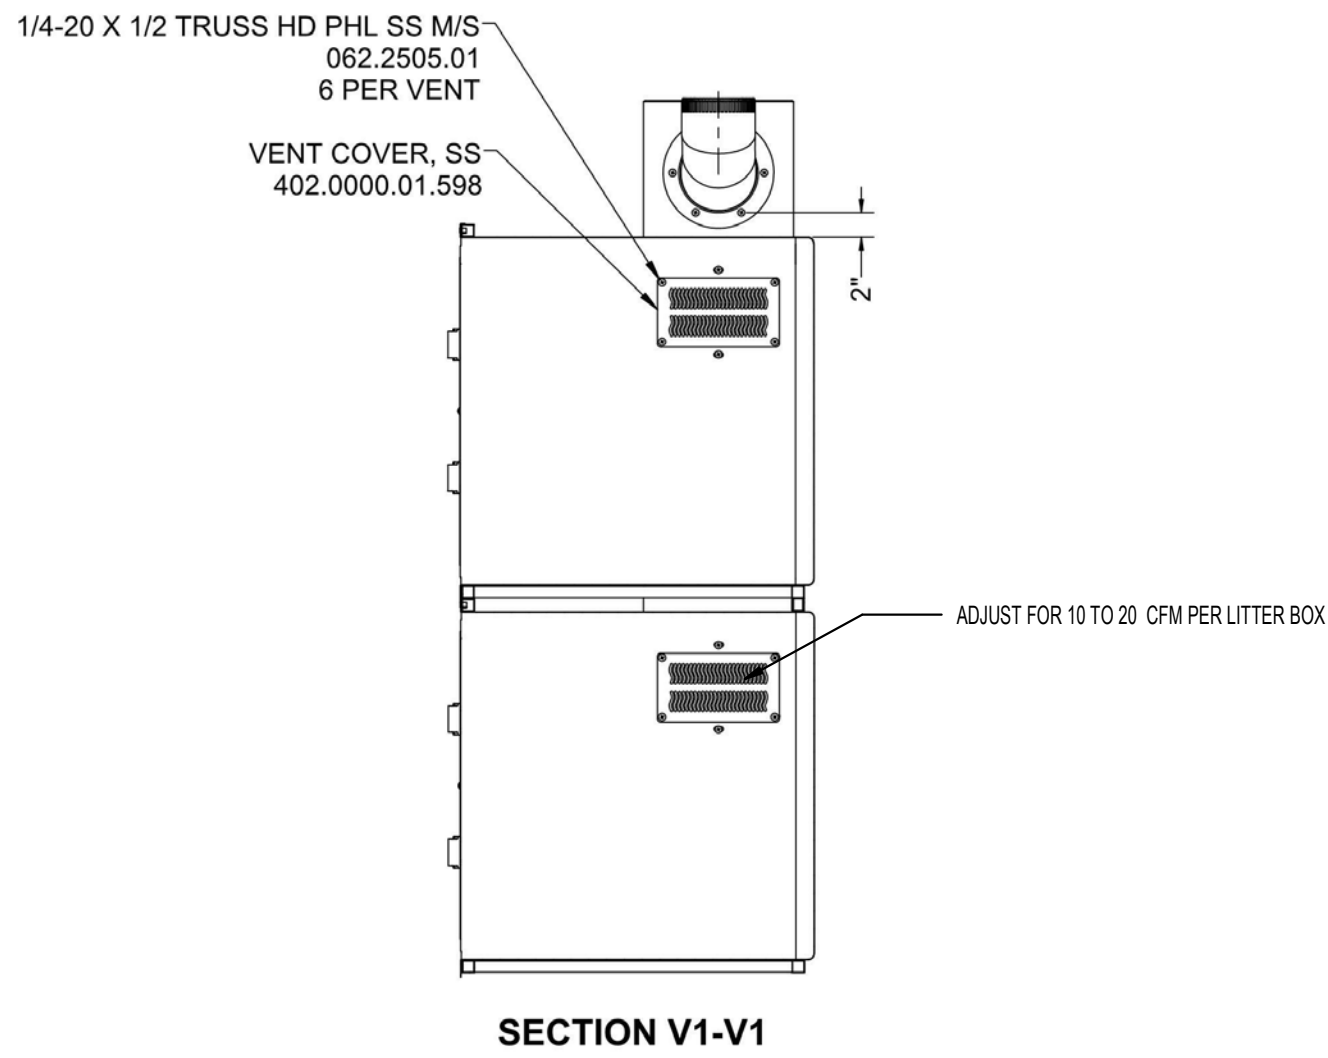


3 SHOR-LINE VENTILATION DETAIL FOR NEW CAT CAGES
1/8" = 1'-0"

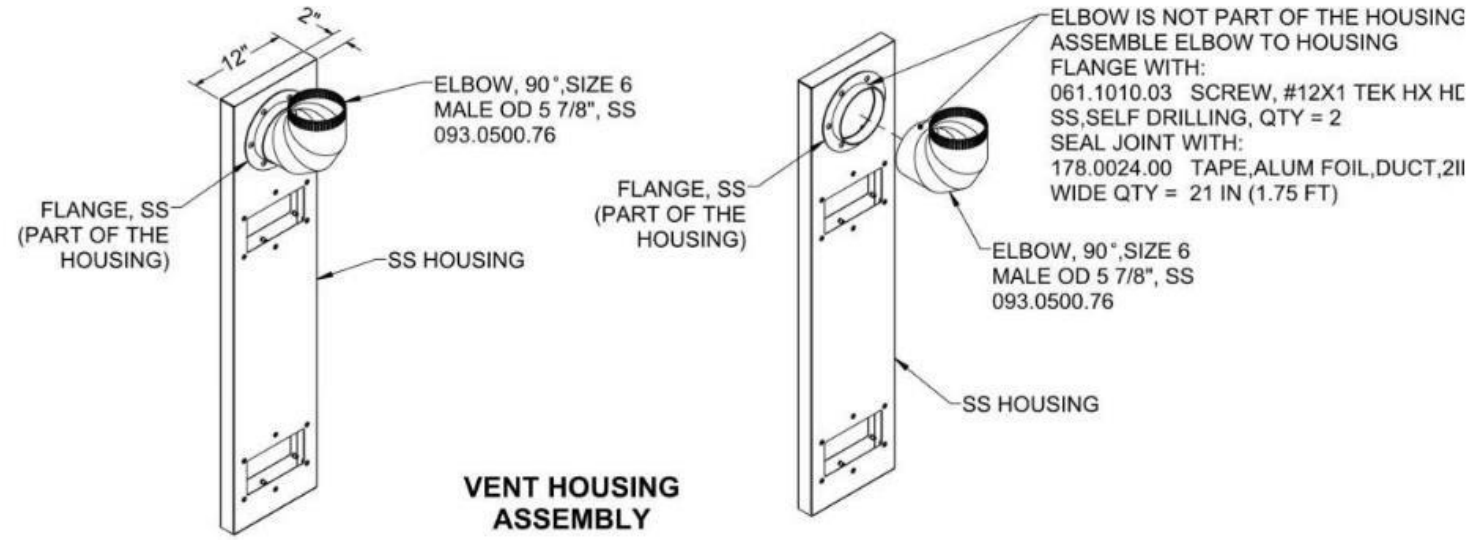


4 SHOR-LINE VENTILATION DETAIL FOR NEW CAT CAGES
1/2" = 1'-0"

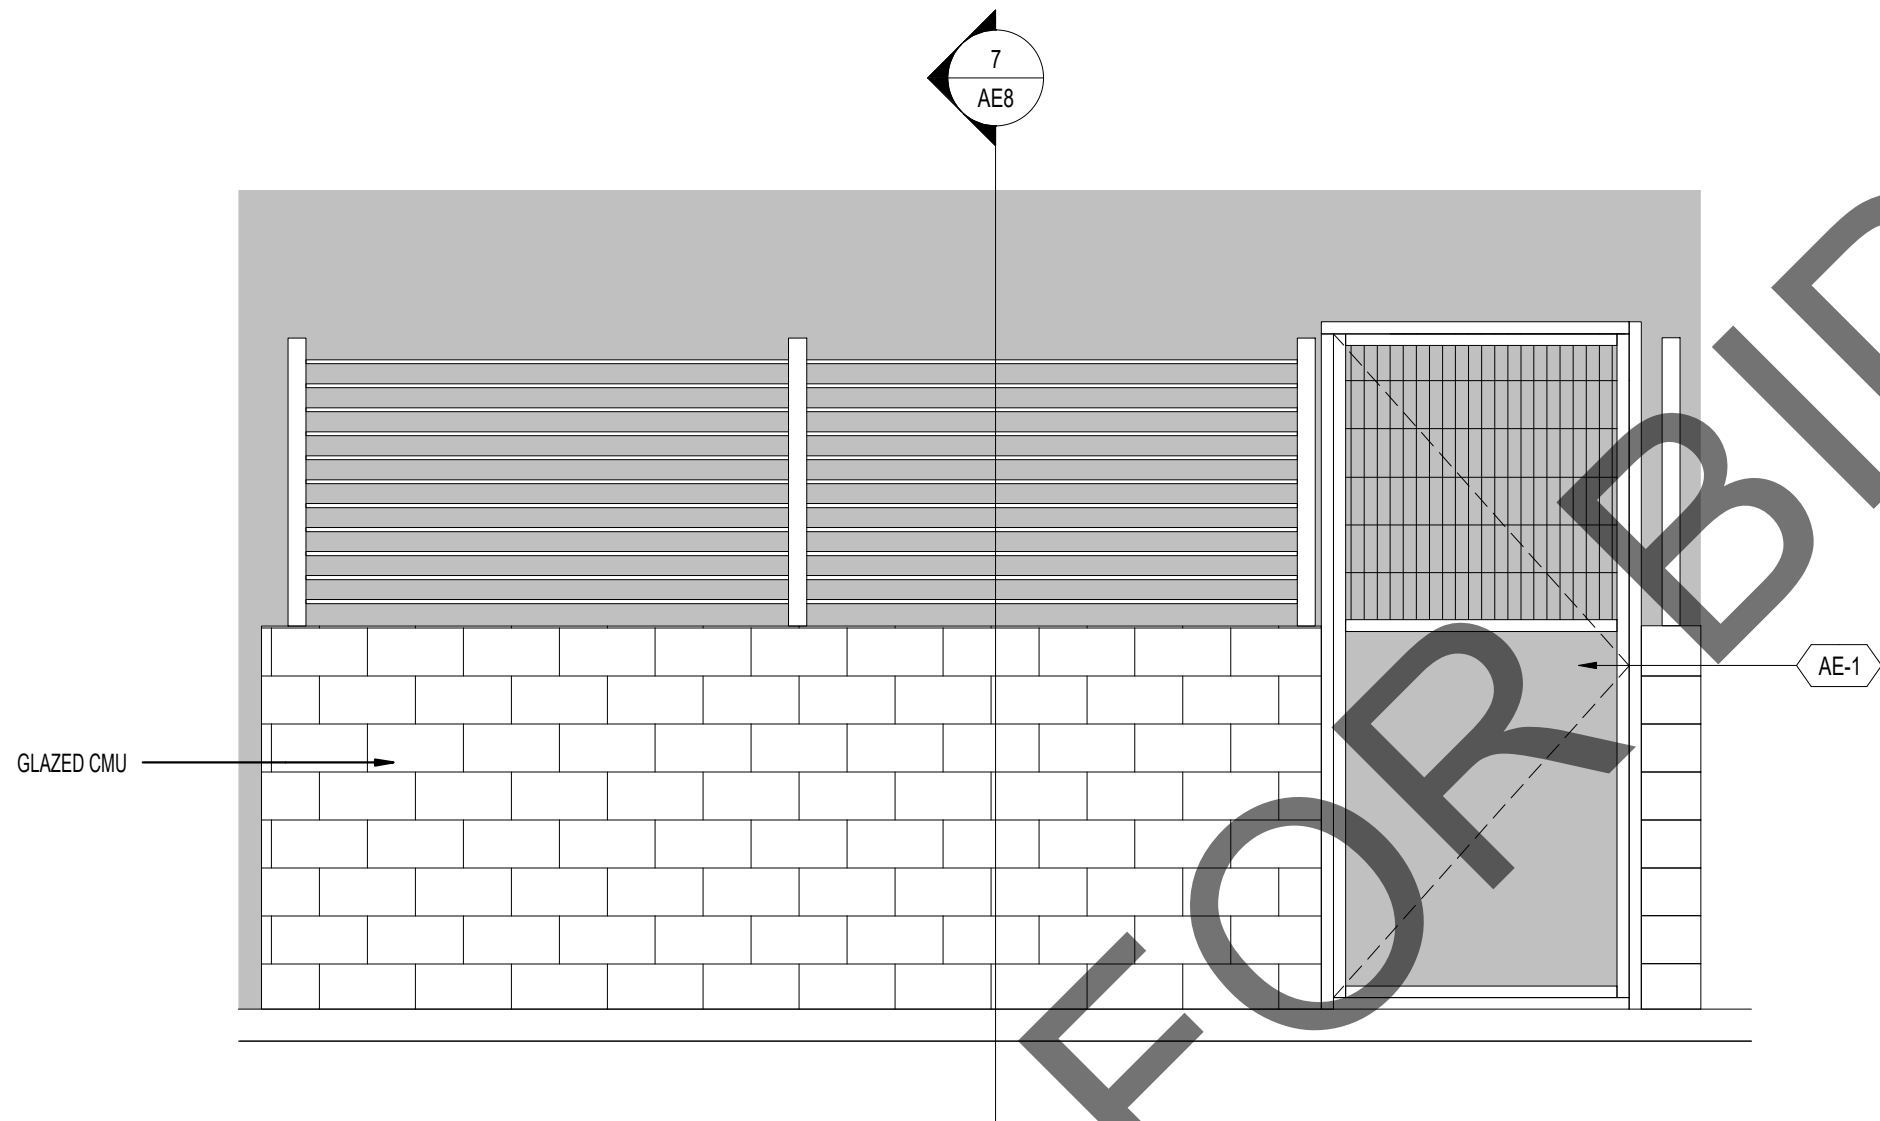


5 ELEVATION
1/2" = 1'-0"

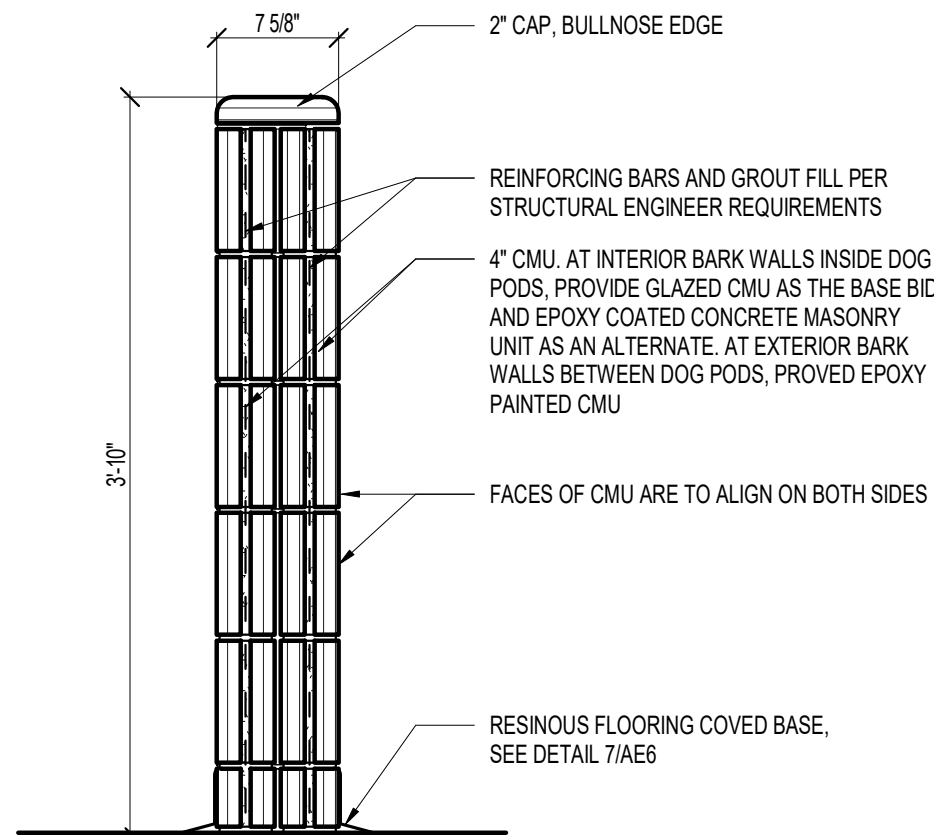

6 DETAIL - BARK WALL
1" = 1'-0"

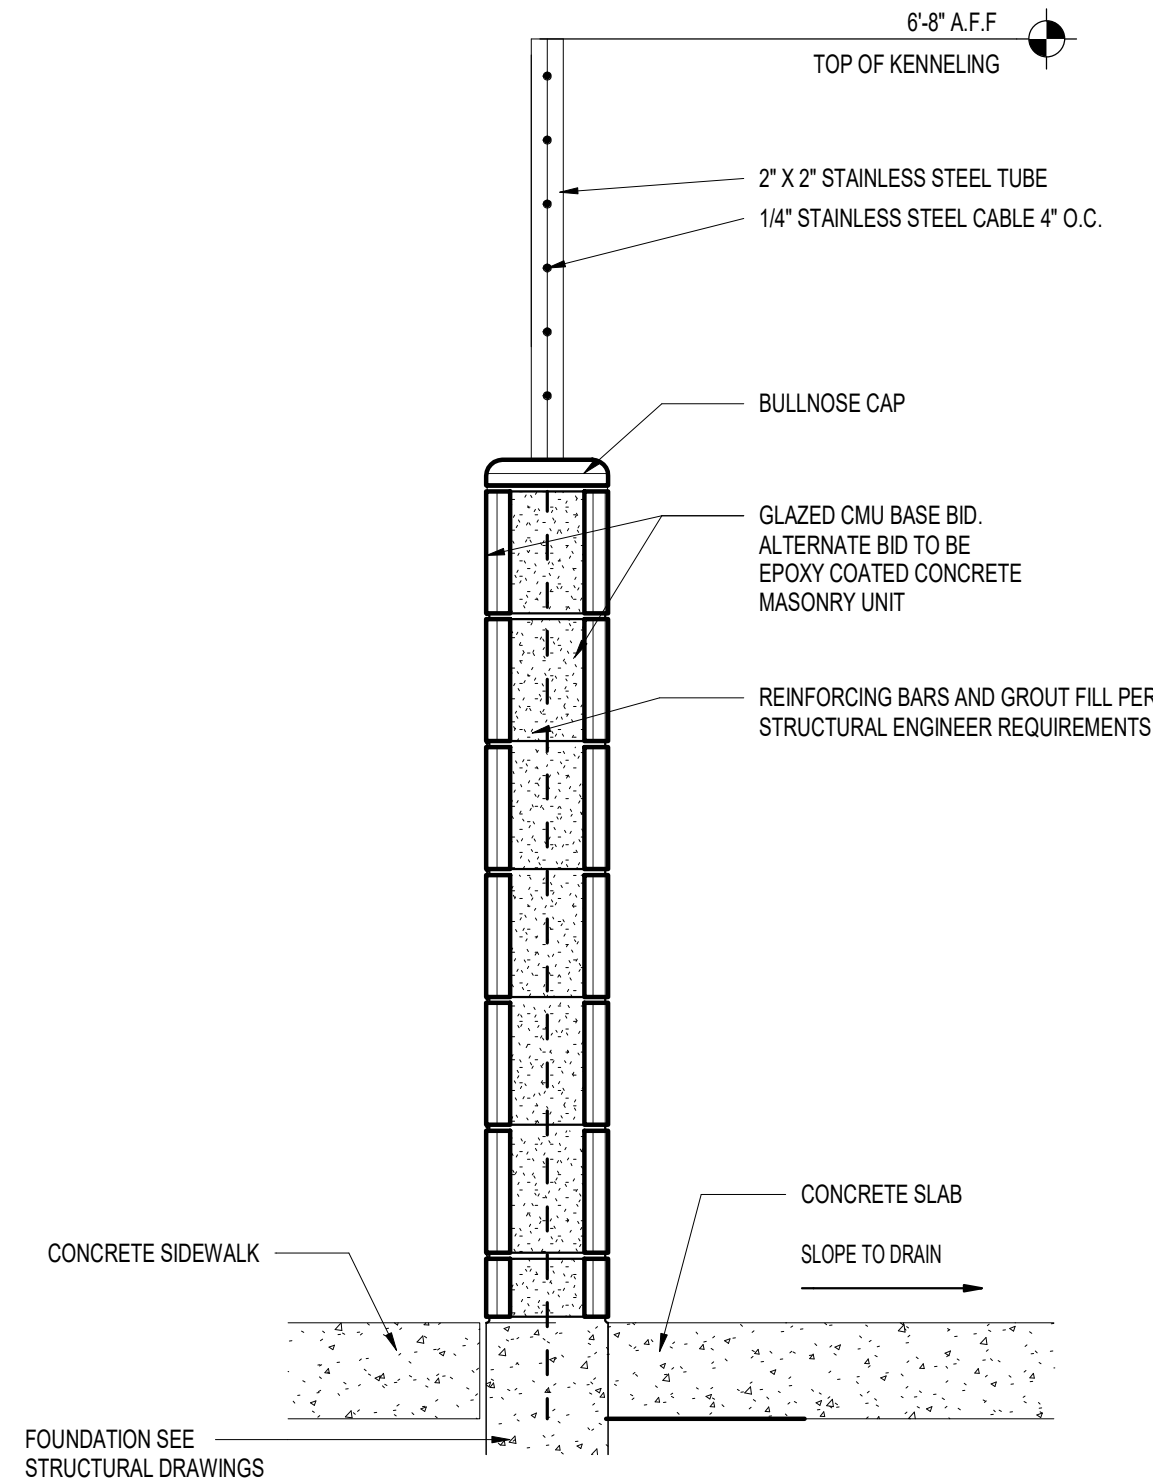

7 DETAIL - GET ACQUAINTED YARD ENCLOSURE
1" = 1'-0"

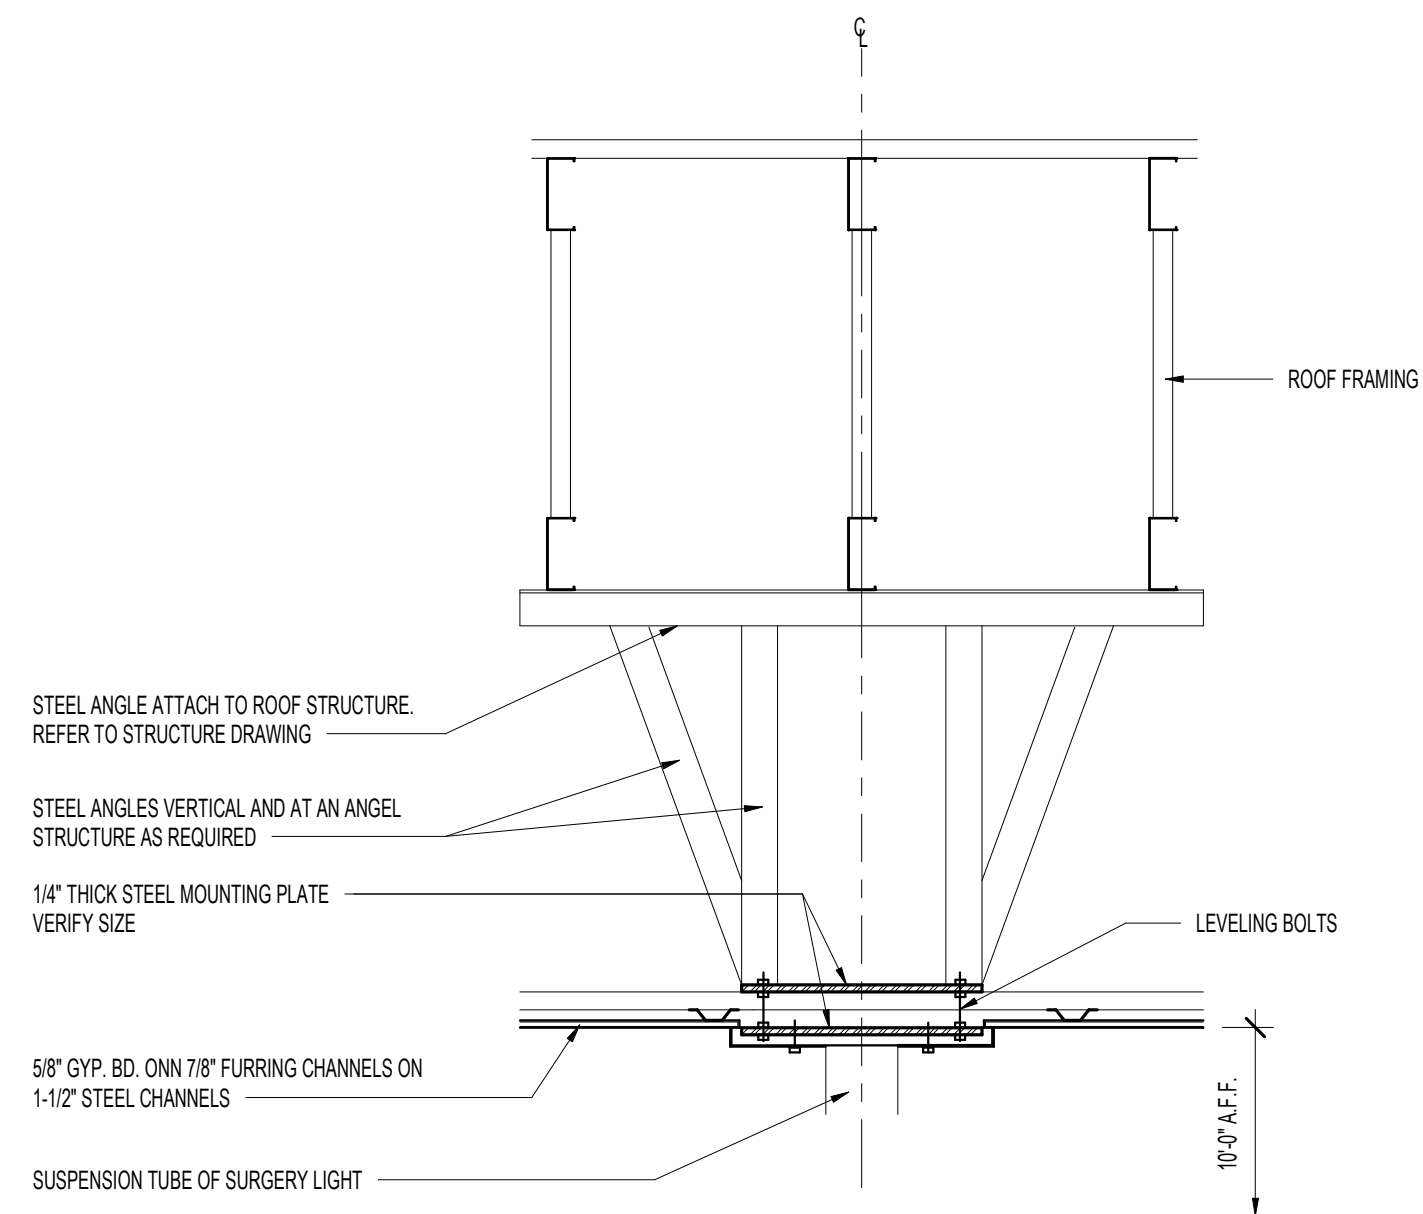

8 SURGERY LIGHT MOUNTING DETAIL
3/4" = 1'-0"



architecture
interiors
planning



1177 Idaho Street, Suite 200
Redlands, CA 92374
Phone: 909-335-7400
Fax: 909-335-7299
info@miller-aip.com



owner approval

initials	date	phase

revisions/addenda

#	Date	Comment
---	------	---------

ANIMAL CARE CENTER

18313 VALLEY BLVD. BLOOMINGTON, CA 92313

SAN BERNARDINO COUNTY

project information

Project Number: 1227
Drawn By: AE
Checked By: MB
Issue Date: 05/31/23



sheet name

ANIMAL
EQUIPMENT
DETAILS

sheet number

AE8

Sheet Of Sheets

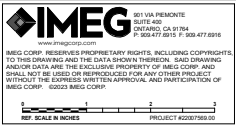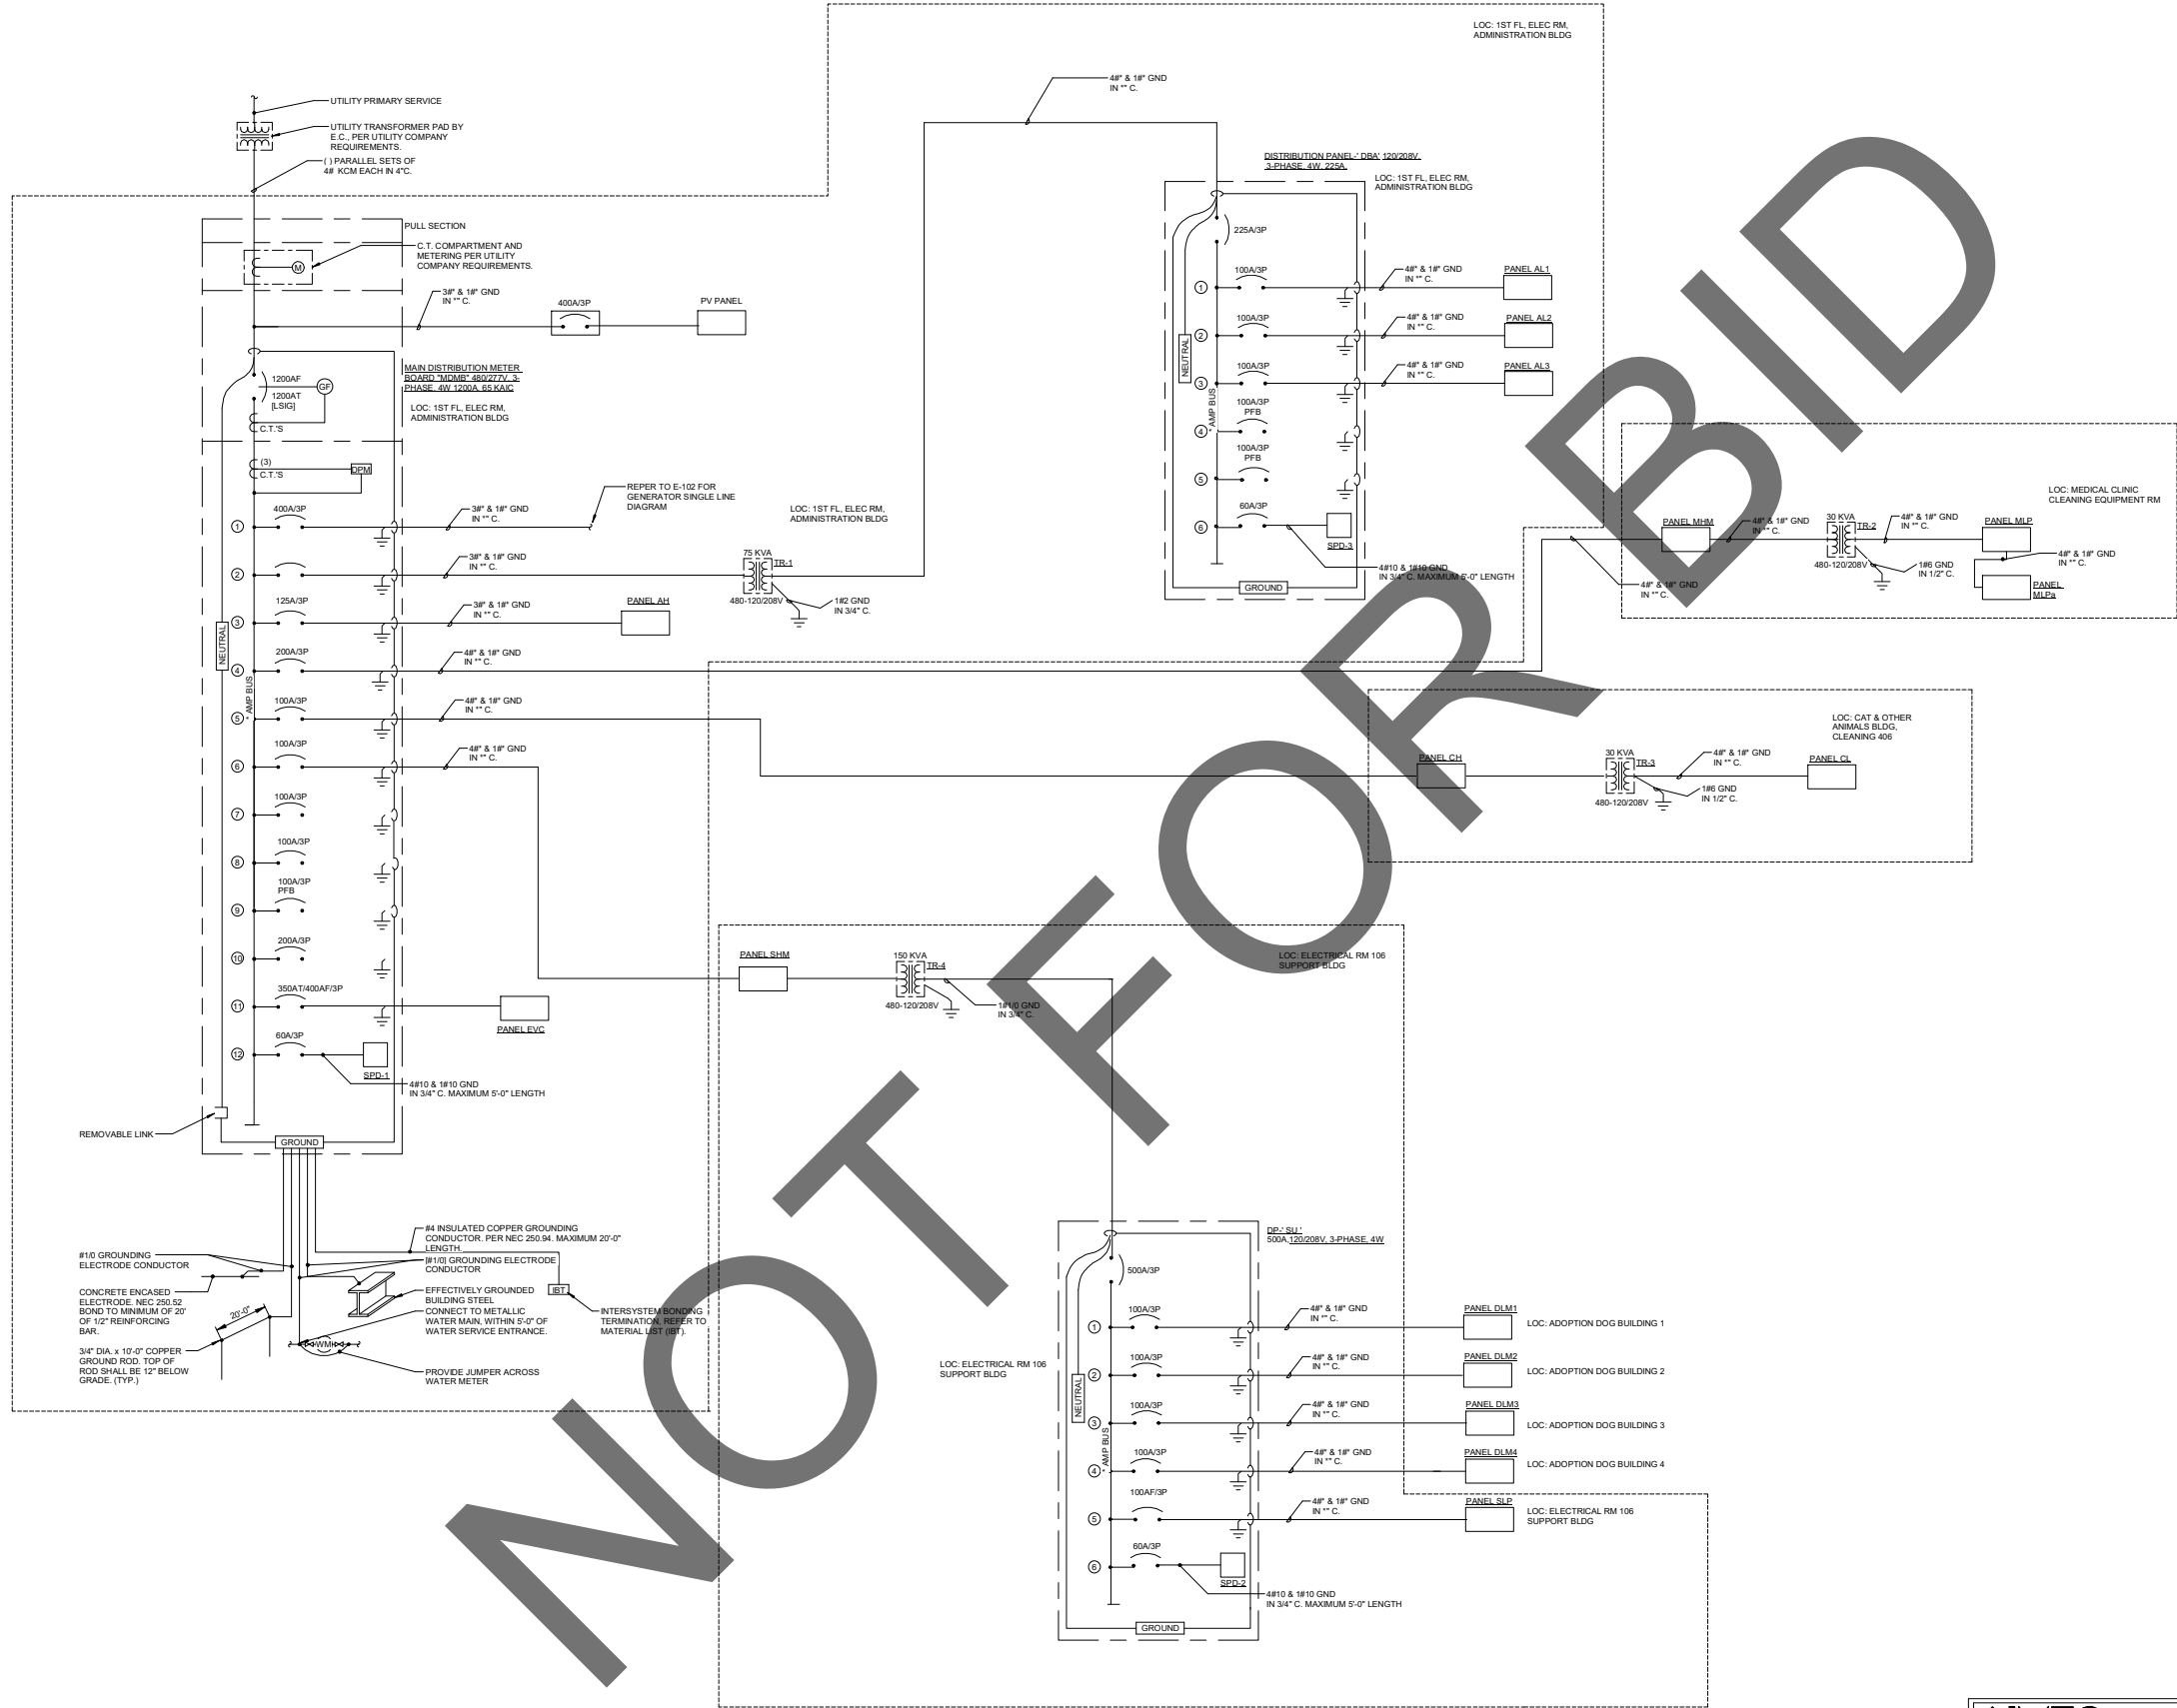

architecture
interiors
planning



1177 Idaho Street, Suite 200
Redlands, CA 92374
Phone: 909-335-7400
Fax: 909-335-7299
info@miller-alp.com



owner approval

initials	date	phase

revisions/addenda

#	Date	Comment

ANIMAL CARE CENTER

18313 VALLEY BLVD, BLOOMINGTON, CA 92313

SAN BERNARDINO COUNTY

project information

Project Number:	1227
Drawn By:	Author
Checked By:	MB
Issue Date:	06/01/23


sheet name

SINGLE LINE
DIAGRAM

sheet number

E-101

Sheet Of Sheets

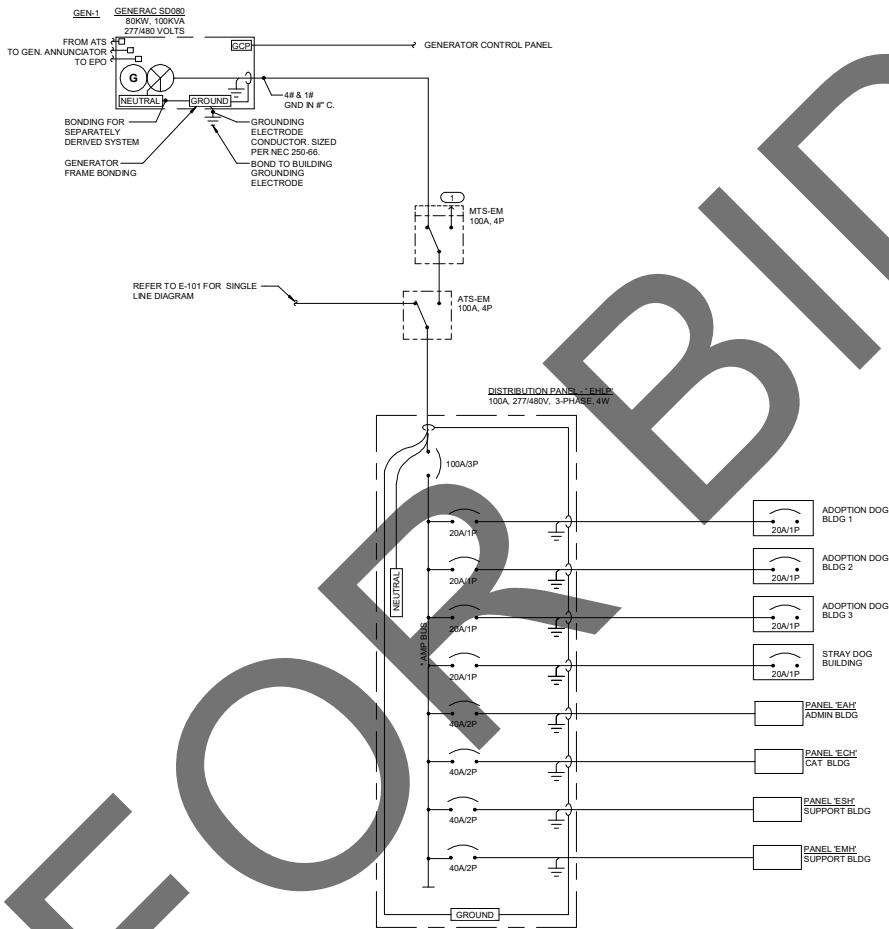

1 EMERGENCY SYSTEM SINGLE LINE DIAGRAM

KEYNOTES: 1

1. INDICATES MANUAL TRANSFER SWITCH WITH CAM CONNECTION TO PORTABLE GENERATOR.



architecture
interiors
planning



1177 Idaho Street, Suite 200
Redlands, CA 92374
Phone: 909-335-7400
Fax: 909-335-7299
info@millier-alp.com



owner approval

Initials	date	phase

revisions/addenda

#	Date	Comment
---	------	---------

ANIMAL CARE CENTER

18313 VALLEY BLVD. BLOOMINGTON, CA 92313

SAN BERNARDINO COUNTY

project information

Project Number:	1227
Drawn By:	Author
Checked By:	MB
Issue Date:	06/01/23


sheet name

SINGLE LINE
DIAGRAM

sheet number

E-102

Sheet Of Sheets

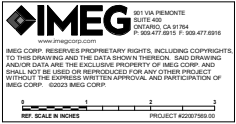

PRELIMINARY
NOT FOR
CONSTRUCTION

LED LUMINAIRE SCHEDULE

(DESC) BODY:	FA - FLAT ALUMINUM	DISTRIBUTION: II - ANSI/IES TYPE 2 DISTRIBUTION IV - ANSI/IES TYPE 4 DISTRIBUTION V - ANSI/IES TYPE 5 DISTRIBUTION	BEAMWIDTH: NSP - VERY NARROW SPOT SP - SPOT MD - MEDIUM WD - WIDE VWD - VERY WIDE WW - WALL WASH	(ILL) LENS/COVER: A - 125" ACRYLIC B - BAFFLE/COVER C - CLEAR ALZAK P - FROSTED ACRYLIC G - TEMPERED GLASS K - KSH12 125" ACRYLIC	K19 - KSH19 150" ACRYLIC M - MATTE DIFFUSE CLEAR N - NONE P - POLYCARBONATE R - HIGH IMPACT DR ACRYLIC SS - SEMI-SPECULAR CLEAR O - OTHER (SEE DESCRIPTION) (DESIGN SPECIFIC BLANKS)
	FS - FLAT STEEL				
	RA - REGRESSED ALUMINUM				
	RS - REGRESSED STEEL				
(MTO) MOUNTING:	PAF - PAINT AFTER FABRICATION	RE - RECESSED SP - SUSPENDED SU - SURFACE UC - UNDER CABINET WL - WALL O - OTHER (SEE DESCRIPTION)		(WATT) PER:	FIX - FIXTURE, FT - FOOT, LAMP
	CFA - COLOR FINISH SELECTION BY ARCHITECT				
	CL - CEILING SURFACE				
	CV - COVE				
(TYPE) DRIVER:	FR - FLANGED RECESSED			(TYPE) LED:	RGB - COLOR CHANGING LED RGBW - COLOR CHANGING + WHITE RGBA - COLOR CHANGING + AMBER RLED - RETROFIT LED WLED - WARM DIM LED
	P - PERIMETER				
	FL - POLE				
	O - OTHER (SEE DESCRIPTION)				
CATALOG NUMBER SHALL NOT BE CONSIDERED COMPLETE AND MATERIAL SHALL NOT BE ORDERED BY MANUFACTURER AND CATALOG NUMBER ONLY. THE COMPLETE DESCRIPTION AND THE SPECIFICATION SHALL BE COORDINATED WITH THE CATALOG NUMBER TO DETERMINE THE EXACT MATERIAL AND ACCESSORIES TO BE ORDERED. THE FIRST MANUFACTURER LISTED IS THE BASIS OF DESIGN.	0-10V - 0-10V DIMMING	EB - ELECTRONIC ELV - ELECTRONIC LOW VOLTAGE EM - EMERGENCY BATTERY ML - MULTI-LEVEL SWITCHING	HL - HIGH/LOW (100%/50%) STEP DIM LINE - LINE VOLTAGE DIMMING	MV - MULTI-VOLTAGE ELECTRONIC REM - REMOTE O - OTHER (SEE DESCRIPTION)	
	DALI - DIGITAL ADDRESSABLE				
	DMX - DIGITAL MULTIPLEX				

VERIFY AND COORDINATE ALL CEILING TYPES WITH LUMINAIRE MOUNTING AND TRIM REQUIREMENTS PRIOR TO THE RELEASE OF THE LUMINAIRE ORDER.
CONFIRM ALL COLORS AND FINISHES OF ALL LUMINAIRE COMPONENTS WITH ARCHITECT AND INTERIOR DESIGNER PRIOR TO THE RELEASE OF THE LUMINAIRE ORDER.
UNLESS INDICATED ON LIGHTING PLANS OR BELOW, REFER TO ARCHITECTURAL AND INTERIOR DESIGN ELEVATIONS, SECTIONS AND DETAILS FOR ALL SUSPENDED AND WALL MOUNTED LUMINAIRE MOUNTING HEIGHTS.

REFER TO SPECIFICATION SECTIONS [LED LIGHTING 28.51.19] FOR ADDITIONAL INFORMATION AND REQUIREMENTS.
INTERIOR CORRELATED COLOR TEMPERATURE 3500, 4000/4100 K, COLOR RENDERING INDEX (CRI) AT OR ABOVE [80, 85, 90], UNLESS NOTED OTHERWISE.
EXTERIOR CORRELATED COLOR TEMPERATURE 3500, 4000/4100 K, COLOR RENDERING INDEX (CRI) AT OR ABOVE [80, 85, 90], UNLESS NOTED OTHERWISE.

ITEM	DESCRIPTION	ILL	MTO	DIMENSIONS				WATT			LED				DRIVER		MANUFACTURER AND MODEL
				L	W	H	DIA.	ANSI WATTS	PER	TYPE	QTY	DELIVERED LUMENS (MIN)	VOLTS	TYPE			
	ENCLOSED INDUSTRIAL WITH FIBERGLASS HOUSING, STAINLESS STEEL LATCHES, MOLDED IN PLACE GASKET, PEBBLED LENS, ILL LISTED WET LOCATION.	A	CL	4'-0"	7"	5"		0 W	FIX	FL	2	F32T8RS	120 V	LED			GUTH DC4 LITHONIA DMW232 I.H.E. WILLIAMS 92-4-232OC-A-WET PRICEDENTIAL P-2382 METALLUX VT2232
A	2x4 STATIC GRID TROFFER			4'-0"	2'-0"	5 7/16"		0 W	FIX		0		277 V	LED			
B	2x2 STATIC GRID TROFFER			2'-0"	2'-0"	5 7/16"		0 W	FIX		0		120 V	LED			
C	4" LINEAR WALL MOUNTED LED			4'-0"	3"	3"		0 W	FIX		0		120 V	LED			
D	4" LINEAR SUSPENSION LED SYSTEM			<varies >	2"	2"		0 W	FT	LED	1		120 V	LED			
EX#	EXIT LIGHT	O	<varies >	1'-11"	2"	9"		0 W	FIX	LED	1	<varies>	120 V	LED	<varies>		
F	2" LINEAR WALL MOUNTED LED			2'-0"	6"	6"		0 W	FIX		0		120 V	LED			
G	2" LINEAR CABINET UNIT WITH SOLID FRONT & PRISMATIC LENS, PAINTED STEEL HOUSING, [POCKER SWITCH]	UC		2'-0"	6"	1 1/2"		0 W	FIX		1		120 V	LED			
I	15x4 PENDANT MOUNTED LED			4'-0"	1'-0"	6"		0 W	FIX		0		120 V	LED			
J	2x4 SURFACE MOUNTED LED		<varies >	<varies >	<varies >	<varies >		0 W	FIX		0		120 V	LED			
K	4" LINEAR SUSPENSION LED SYSTEM		<varies >	<varies >	<varies >	<varies >		<varies >	<varies >	<varies >	<varies >		120 V	LED			
L	10" SQUARE DOWN LIGHT	CL	RE	10"	10"	10"		0 W	FIX	FL	1	CF1R26W/GK2 40-3	120 V	EB MV			
W	WALL PACK LUMINAIRE, PRISMATIC GLASS LENS, ALUMINUM HOUSING, POWDER COAT FINISH, GASKETED, [CUSTOM] COLOR SELECTION BY ARCHITECT FROM STANDARD COLORS, LISTED WET LOCATION.	G	WL	1'-4"	10"	10 1/2"		0 W	FIX	MH	1	MH70E17	120 V	LED			LUMARK MHWL-70W-277V LITHONIA DAY-BRITE



architecture
interiors
planning



1177 Idaho Street, Suite 200
Redlands, CA 92374
Phone: 909-335-7400
Fax: 909-335-7299
info@miller-alp.com



owner approval

initials	date	phase

revisions/addenda

#	Date	Comment
---	------	---------

ANIMAL CARE CENTER

18313 VALLEY BLVD. BLOOMINGTON, CA 92313

SAN BERNARDINO COUNTY

project information

Project Number:	1227
Drawn By:	Author
Checked By:	MB
Issue Date:	06/01/23


sheet name


LUMINAIRE
SCHEDULE

sheet number

E-104

Sheet Of Sheets

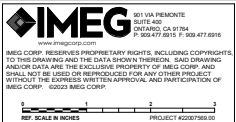


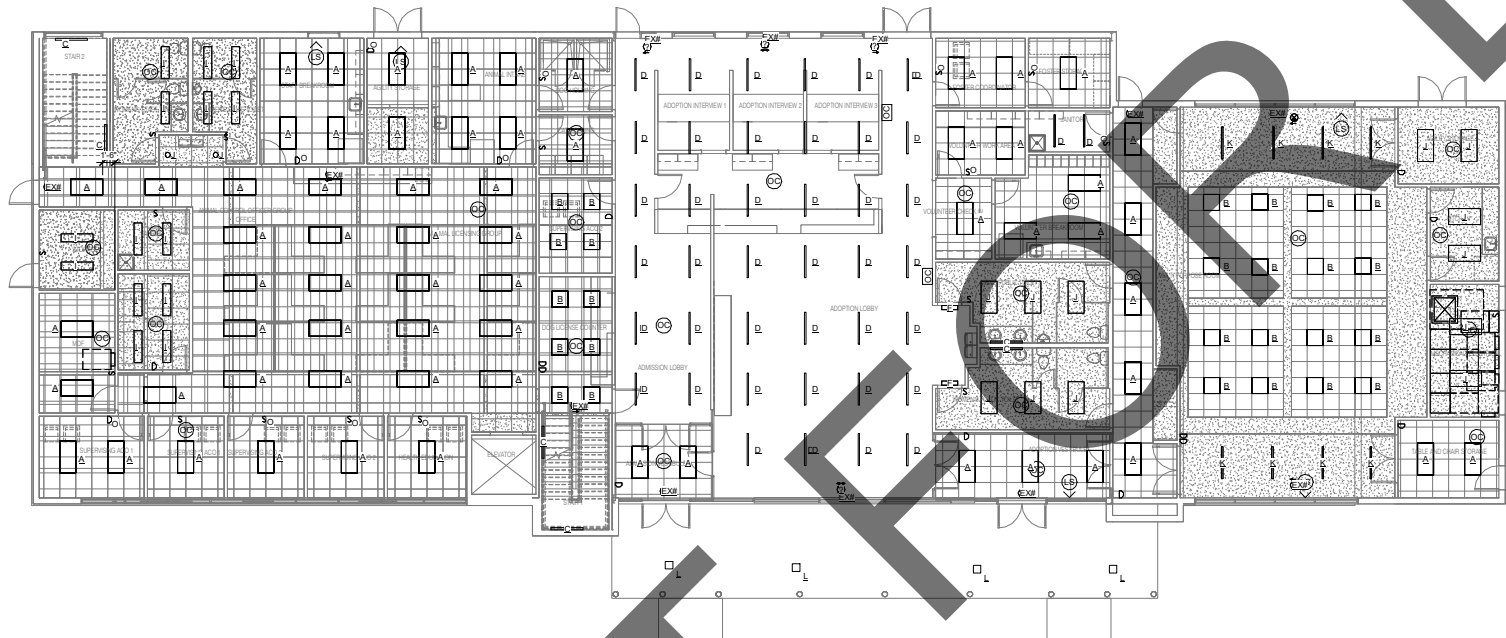

1

ADMINISTRATION BUILDING LIGHTING FIRST FLOOR PLAN

1/8" = 1'-0"

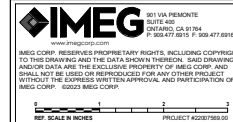

PRELIMINARY
NOT FOR
CONSTRUCTION

ANIMAL CARE CENTER
18313 VALLEY BLVD. BLOOMINGTON, CA 92313
SAN BERNARDINO COUNTY

project information

Project Number: 1227
Drawn By: Author
Checked By: MB
Issue Date: 06/01/23

sheet name
ADMINISTRATION
BUILDING
LIGHTING FIRST
FLOOR PLAN

sheet number

EA-101

Sheet Of Sheets



architecture
interiors
planning

MILLER



1177 Idaho Street, Suite 200
Redlands, CA 92374
Phone: 909-335-7400
Fax: 909-335-7299
info@miller-alp.com





owner approval

initials	date	phase

revisions/addenda

#	Date	Comment

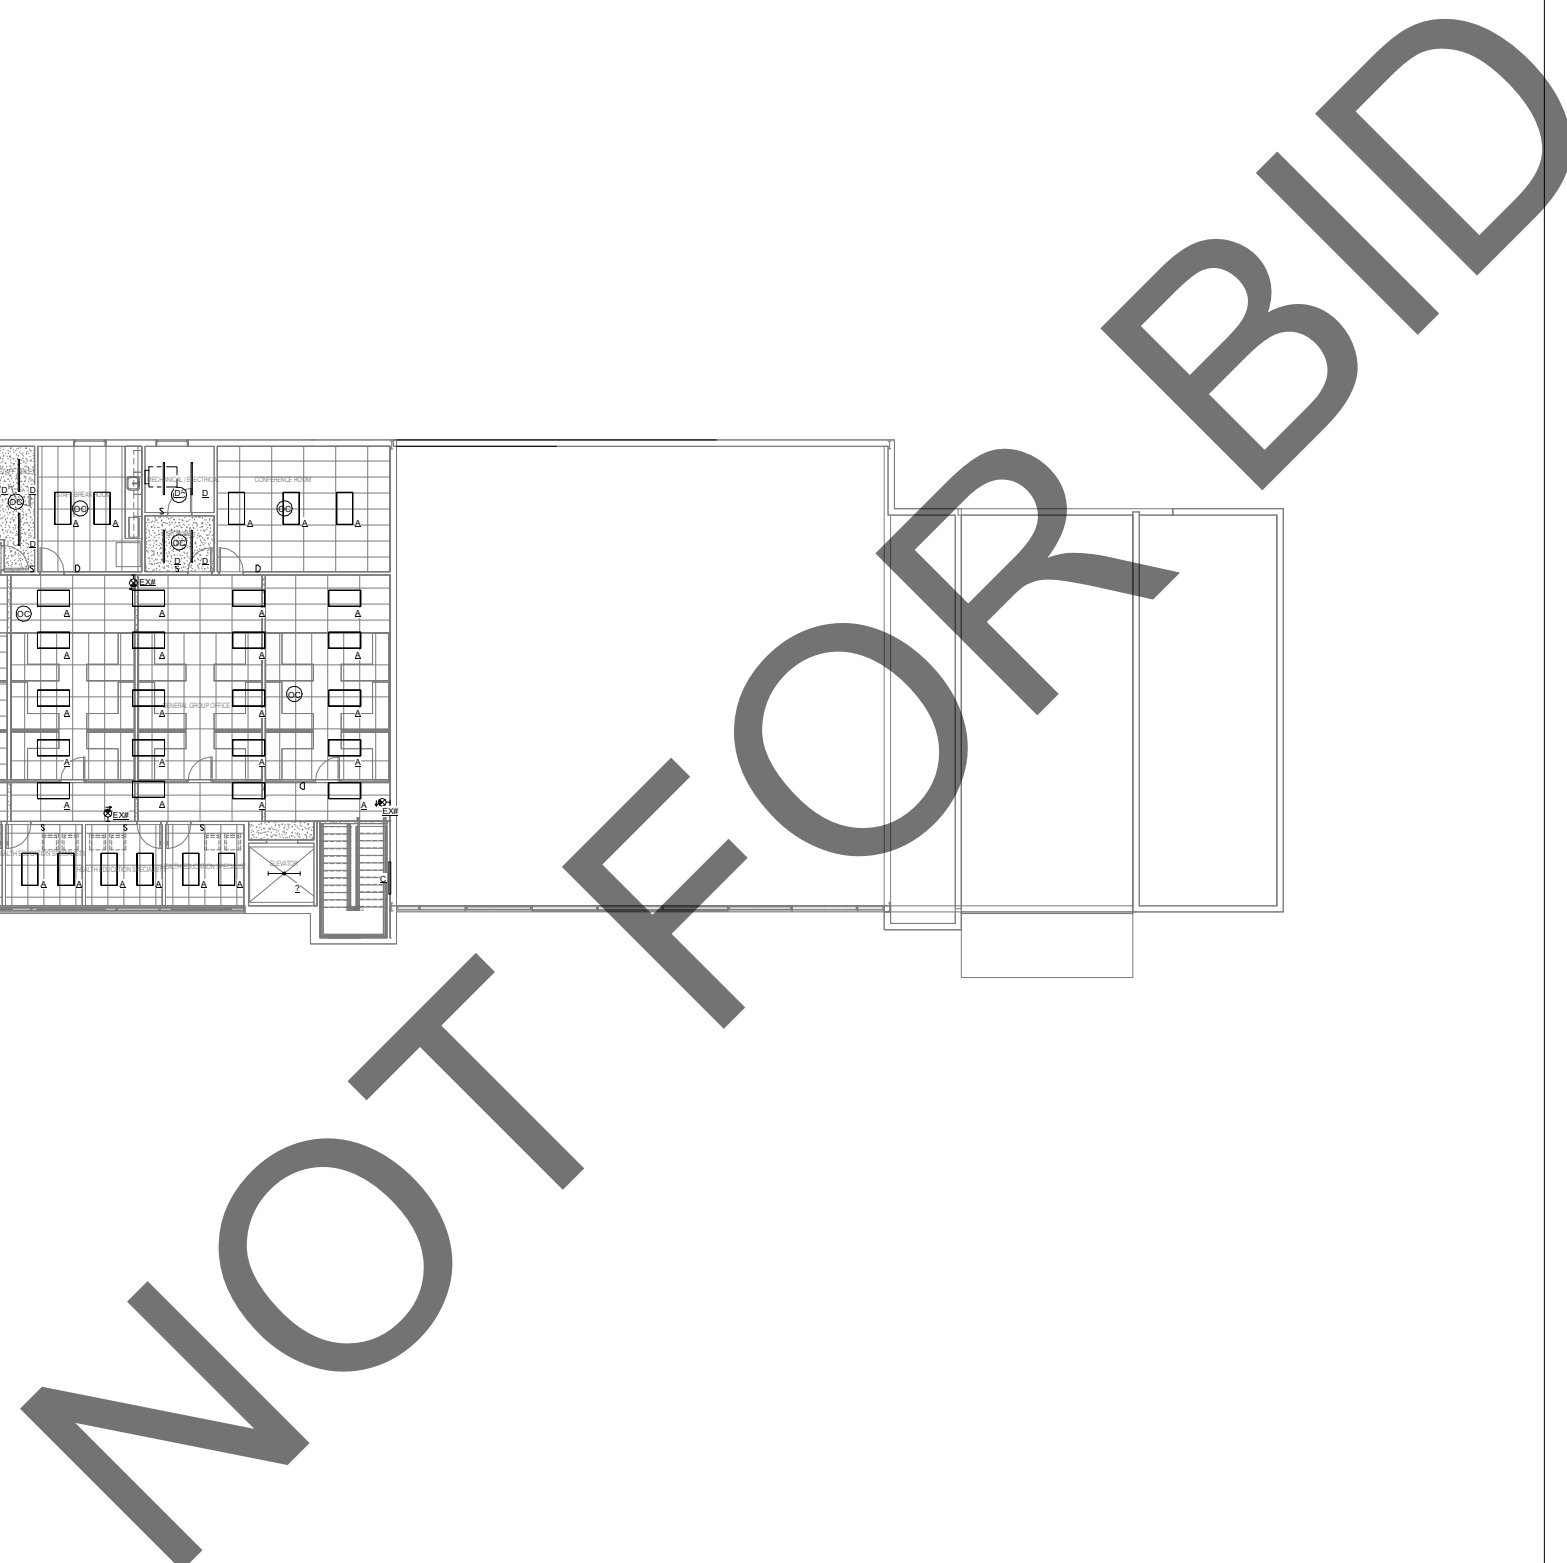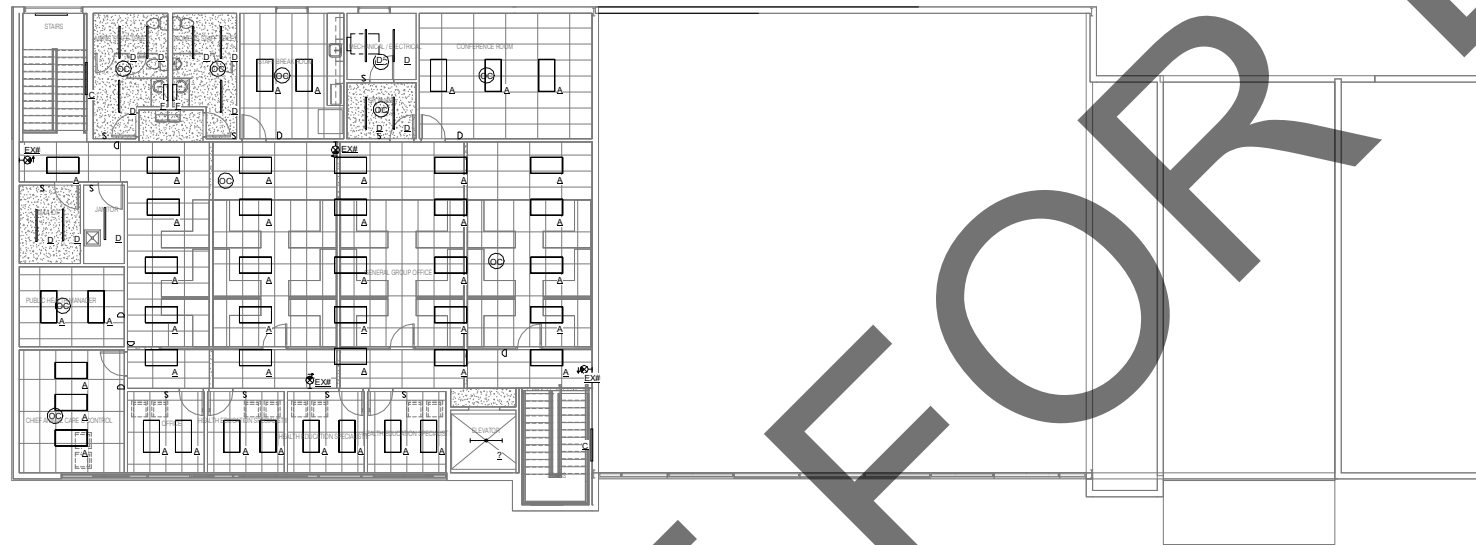

1

100' = 1'-00"



**PRELIMINARY
NOT FOR
CONSTRUCTION**


ANIMAL CARE CENTER
18313 VALLEY BLVD. BLOOMINGTON, CA 92313
SAN BERNARDINO COUNTY

Project Number:	1227
Drawn By:	Author
Checked By:	MB
Issue Date:	06/01/23

ADMINISTRATION
BUILDING
LIGHTING
SECOND FLOOR
PLAN

EA-102

Sheet Of Sheets

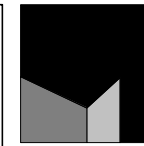

**architecture
interiors
planning**




1177 Idaho Street, Suite 200
Redlands, CA 92374
Phone: 909-335-7400
Fax: 909-335-7299
info@milller-aip.com



owner approval		
initials	date	phase


#	Date	Comment
---	------	---------

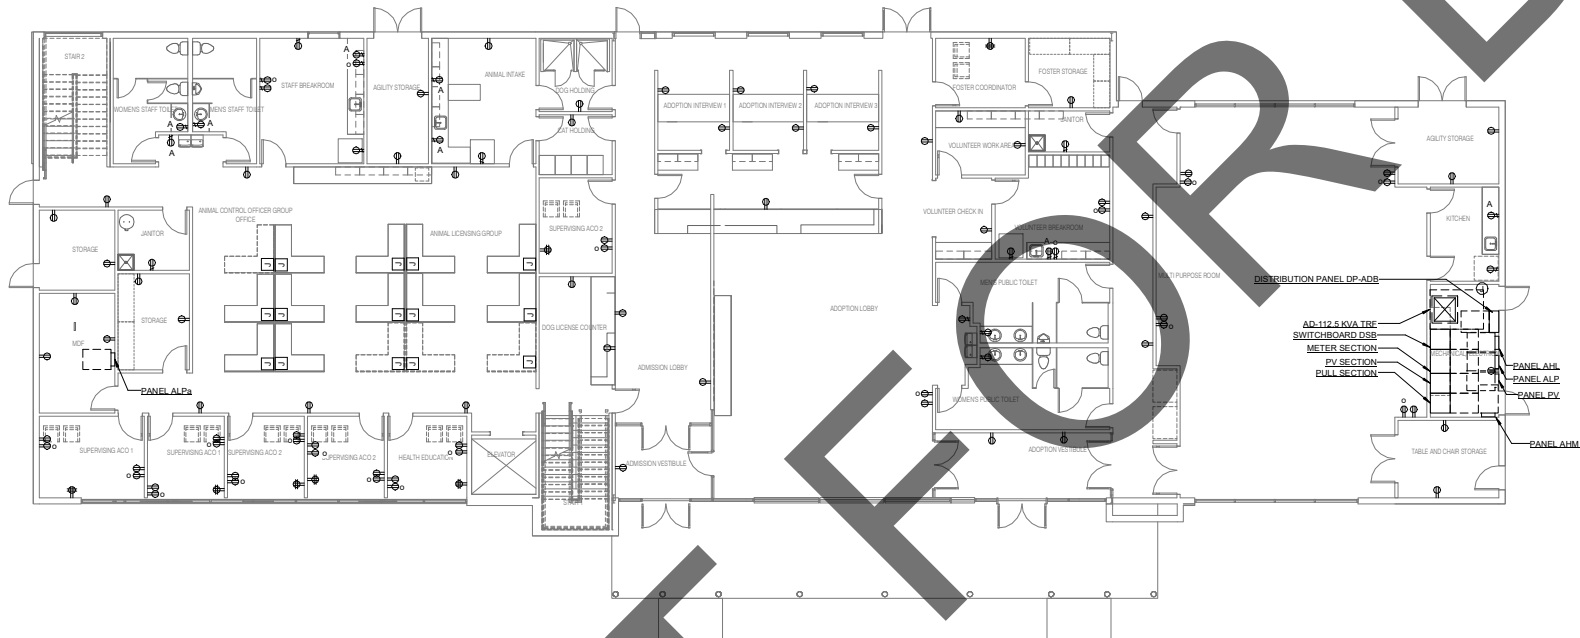

1

ADMINISTRATION BUILDING POWER FIRST FLOOR PLAN

1/8" = 1'-0"

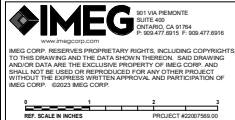

PRELIMINARY
NOT FOR
CONSTRUCTION

ANIMAL CARE CENTER
18313 VALLEY BLVD. BLOOMINGTON, CA 92313
SAN BERNARDINO COUNTY

project information

Project Number: 1227
Drawn By: Author
Checked By: MB
Issue Date: 06/01/23

sheet name
ADMINISTRATION
BUILDING
POWER FIRST
FLOOR PLAN

sheet number

EA-201

Sheet Of Sheets



architecture
interiors
planning

MILLER



1177 Idaho Street, Suite 200
Redlands, CA 92374
Phone: 909-335-7400
Fax: 909-335-7299
info@miller-alp.com




owner approval

Initials	Date	Phase

revisions/addenda


#	Date	Comment

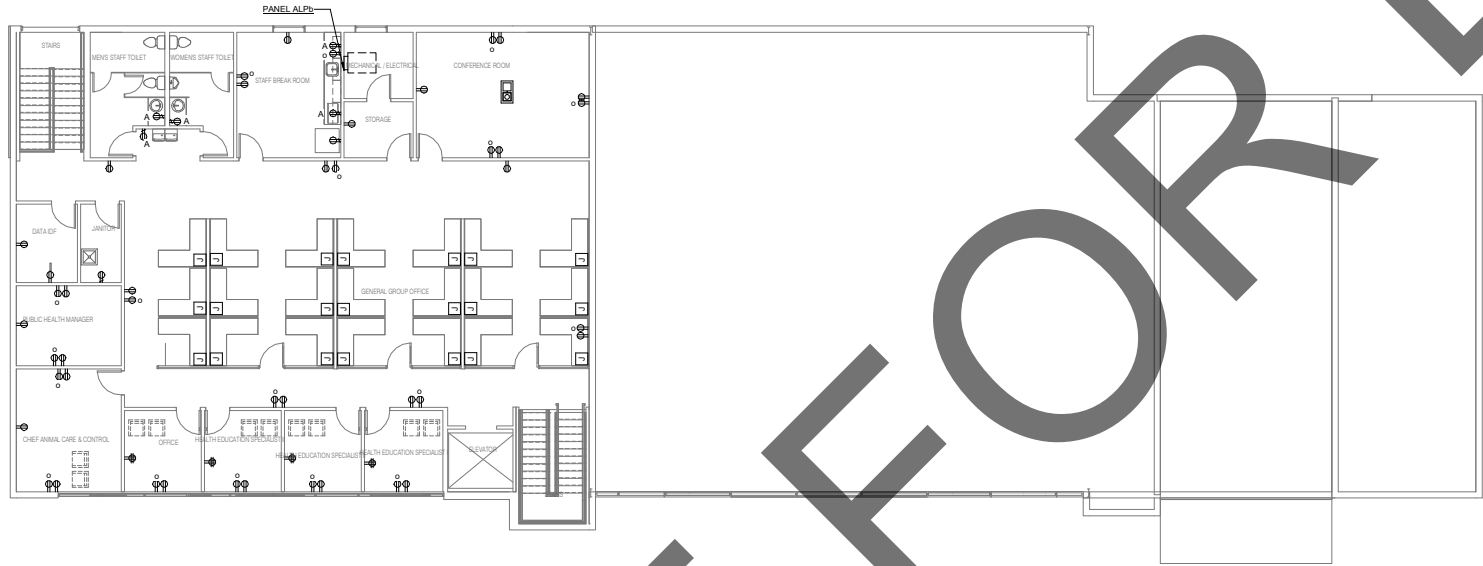

1

ADMINISTRATION BUILDING POWER SECOND FLOOR PLAN

1/8" = 1'-0"

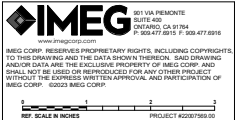

PRELIMINARY
NOT FOR
CONSTRUCTION

ANIMAL CARE CENTER
18313 VALLEY BLVD. BLOOMINGTON, CA 92313
SAN BERNARDINO COUNTY


project information

Project Number: 1227
Drawn By: Author
Checked By: MB
Issue Date: 06/01/23

ADMINISTRATION
BUILDING
POWER
SECOND FLOOR
PLAN
sheet number

EA-202

Sheet Of Sheets

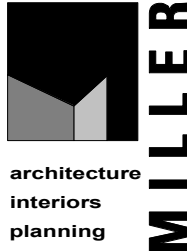

1177 Idaho Street, Suite 200
Redlands, CA 92374
Phone: 909-335-7400
Fax: 909-335-7299
info@miller-alp.com




owner approval

Initials	date	phase

revisions/addenda


#	Date	Comment

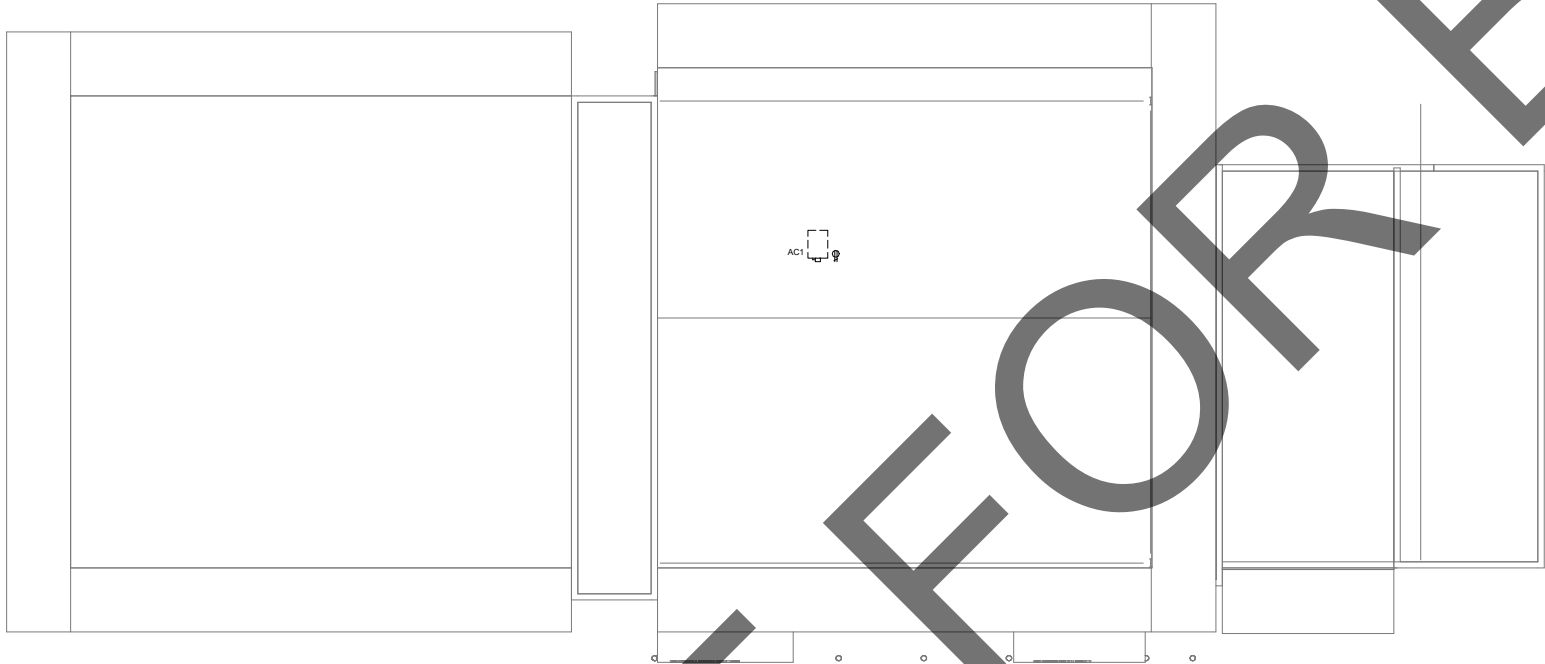

1

ADMINISTRATION BUILDING POWER ROOF PLAN

1/8" = 1'-0"

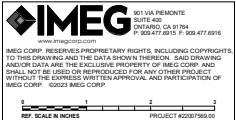

PRELIMINARY
NOT FOR
CONSTRUCTION



architecture
interiors
planning

MILLER



1177 Idaho Street, Suite 200
Redlands, CA 92374
Phone: 909-335-7400
Fax: 909-335-7299
info@millier-alp.com



owner approval

initials	date	phase

revisions/addenda

#	Date	Comment
---	------	---------

ANIMAL CARE CENTER

18313 VALLEY BLVD. BLOOMINGTON, CA 92313

SAN BERNARDINO COUNTY

project information


Project Number:	1227
Drawn By:	Author
Checked By:	MB
Issue Date:	06/01/23

sheet name
ADMINISTRATION
BUILDING
POWER ROOF
PLAN

sheet number

EA-203


Sheet Of Sheets

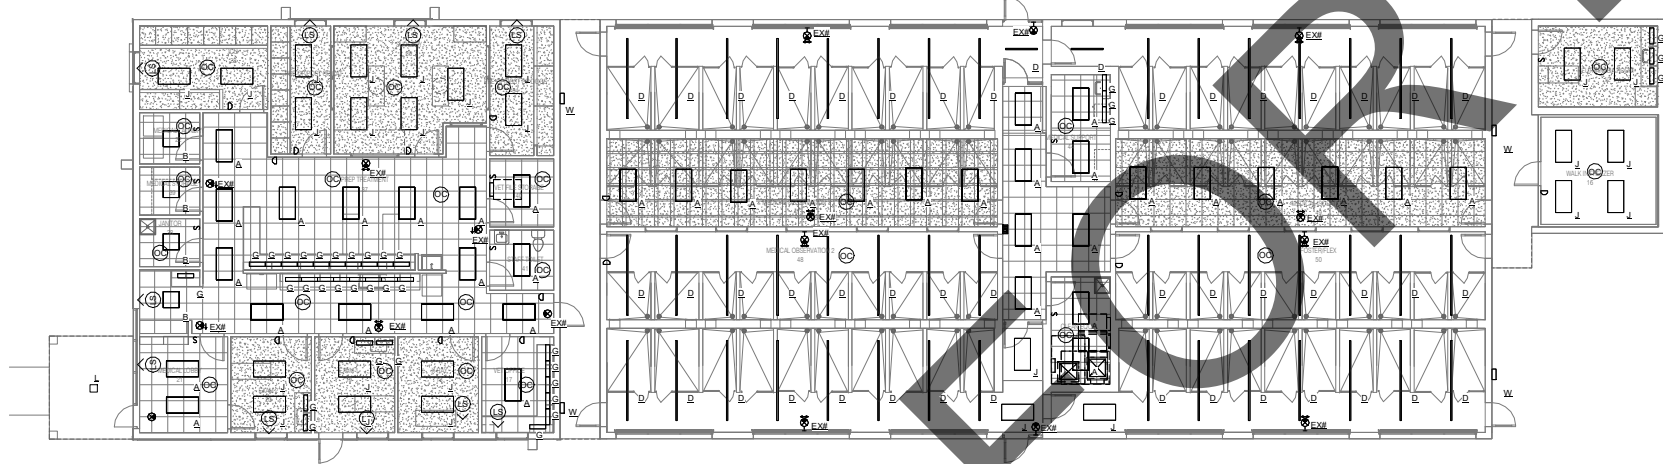

1

MEDICAL CLINIC LIGHTING FLOOR PLAN

1/8" = 1'-0"

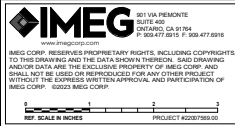

**PRELIMINARY
NOT FOR
CONSTRUCTION**

ANIMAL CARE CENTER
18313 VALLEY BLVD. BLOOMINGTON, CA 92313
SAN BERNARDINO COUNTY

project information

Project Number: 1227
Drawn By: Author
Checked By: MB
Issue Date: 06/01/23

sheet name

**MEDICAL CLINIC
LIGHTING
FLOOR PLAN**

sheet number

EB-C-101

Sheet Of Sheets



**architecture
interiors
planning**



1177 Idaho Street, Suite 200
Redlands, CA 92374
Phone: 909-335-7400
Fax: 909-335-7299
info@miller-alp.com




owner approval

Initials	date	phase

revisions/addenda

#	Date	Comment

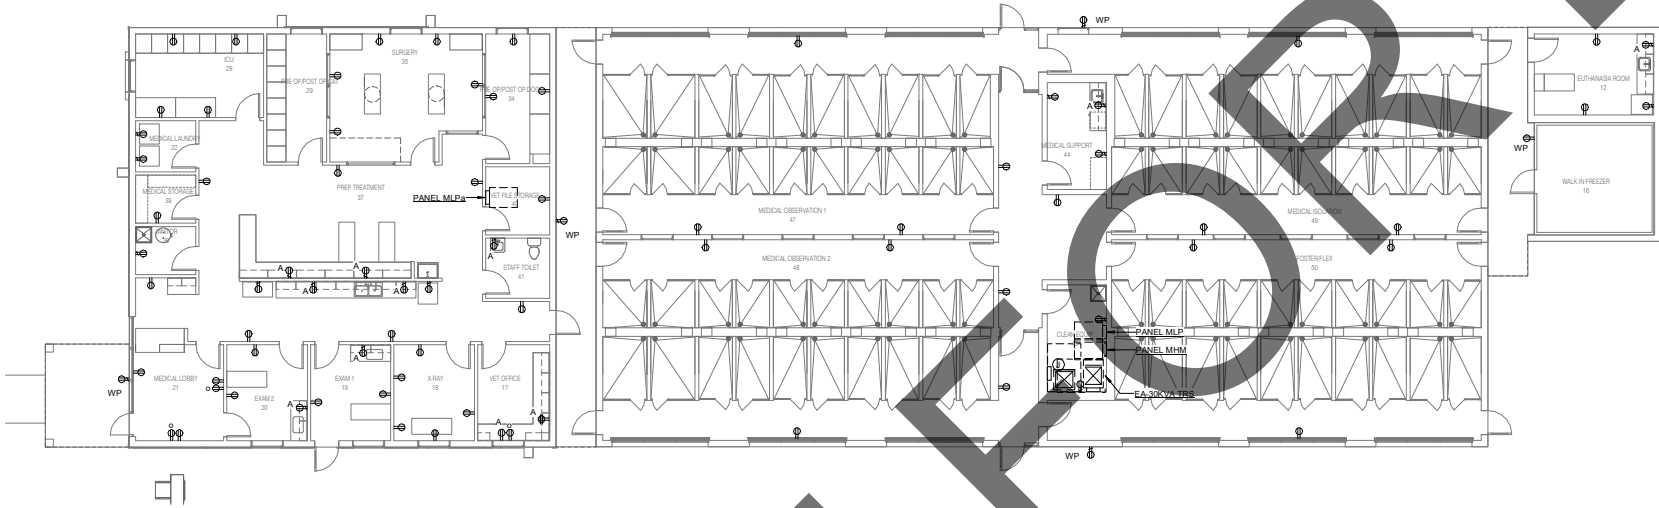

1

MEDICAL CLINIC POWER FLOOR PLAN

1/8" = 1'-0"

IMEG
551 VIA PIEDMONT
SUITE 100
DANFORTH, CA 91914
P: 619-477-8811 F: 619-477-8816
www.imegcorp.com

IMEG CORP. RESERVES PROPRIETARY RIGHTS, INCLUDING COPYRIGHTS, TO THIS DRAWING AND THE DATA SHOWN THEREON. SAID DRAWING AND/OR DATA ARE THE EXCLUSIVE PROPERTY OF IMEG CORP. AND SHALL NOT BE USED OR REPRODUCED FOR ANY OTHER PROJECT WITHOUT THE EXPRESS WRITTEN APPROVAL AND PARTICIPATION OF IMEG CORP. ©2003 IMEG CORP.

1" = 12" SCALE IN INCHES PROJECT #20070901-01

**PRELIMINARY
NOT FOR
CONSTRUCTION**

ANIMAL CARE CENTER
18313 VALLEY BLVD. BLOOMINGTON, CA 92313
SAN BERNARDINO COUNTY

project information

Project Number: 1227
Drawn By: Author
Checked By: MB
Issue Date: 06/01/23

sheet name

MEDICAL CLINIC
POWER FLOOR
PLAN

sheet number

EBC-201

Sheet Of Sheets

MILLER
architecture
interiors
planning



1177 Idaho Street, Suite 200
Redlands, CA 92374
Phone: 909-335-7400
Fax: 909-335-7299
info@millier-alp.com




owner approval

Initials	date	phase

revisions/addenda


#	Date	Comment
---	------	---------

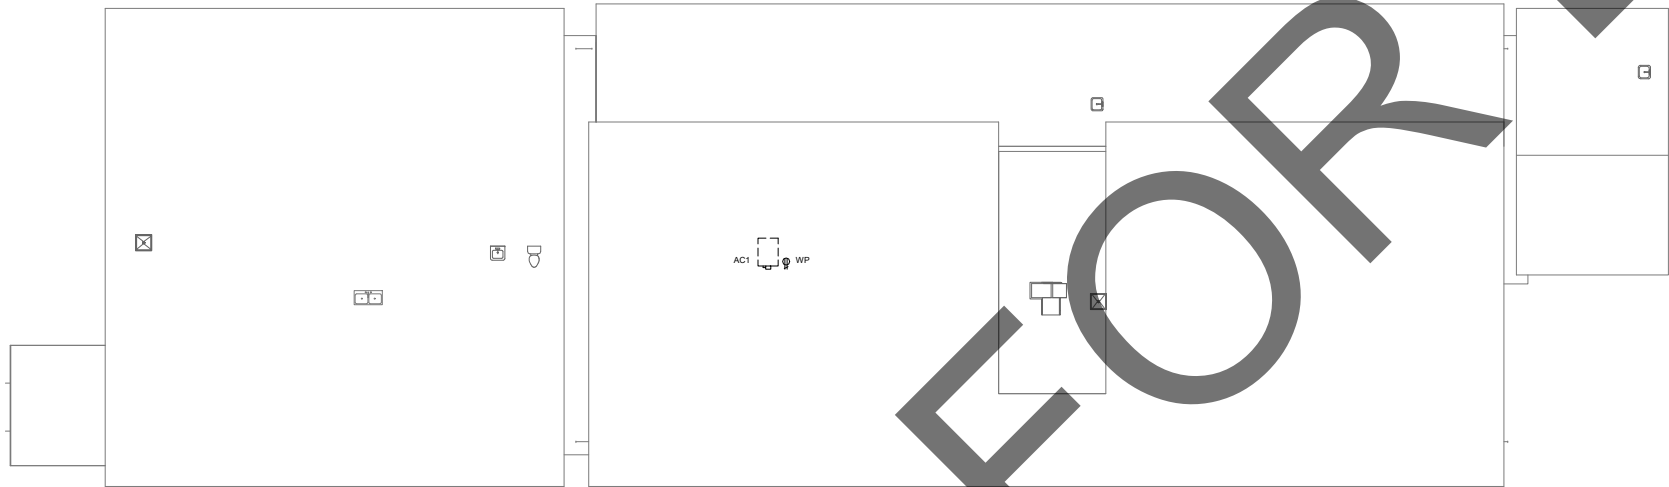

1

MEDICAL CLINIC POWER ROOF PLAN

1/8" = 1'-0"

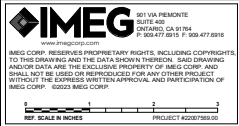

1177 Idaho Street, Suite 200
Redlands, CA 92374
Phone: 909-335-7400
Fax: 909-335-7299
info@millier-alp.com



owner approval

Initials	date	phase

revisions/addenda

#	Date	Comment
---	------	---------

ANIMAL CARE CENTER

18313 VALLEY BLVD. BLOOMINGTON, CA 92313

SAN BERNARDINO COUNTY

project information

Project Number: 1227
Drawn By: Author
Checked By: MB
Issue Date: 06/01/23


sheet name

MEDICAL CLINIC
POWER ROOF
PLAN

sheet number

EBC-202

Sheet Of Sheets

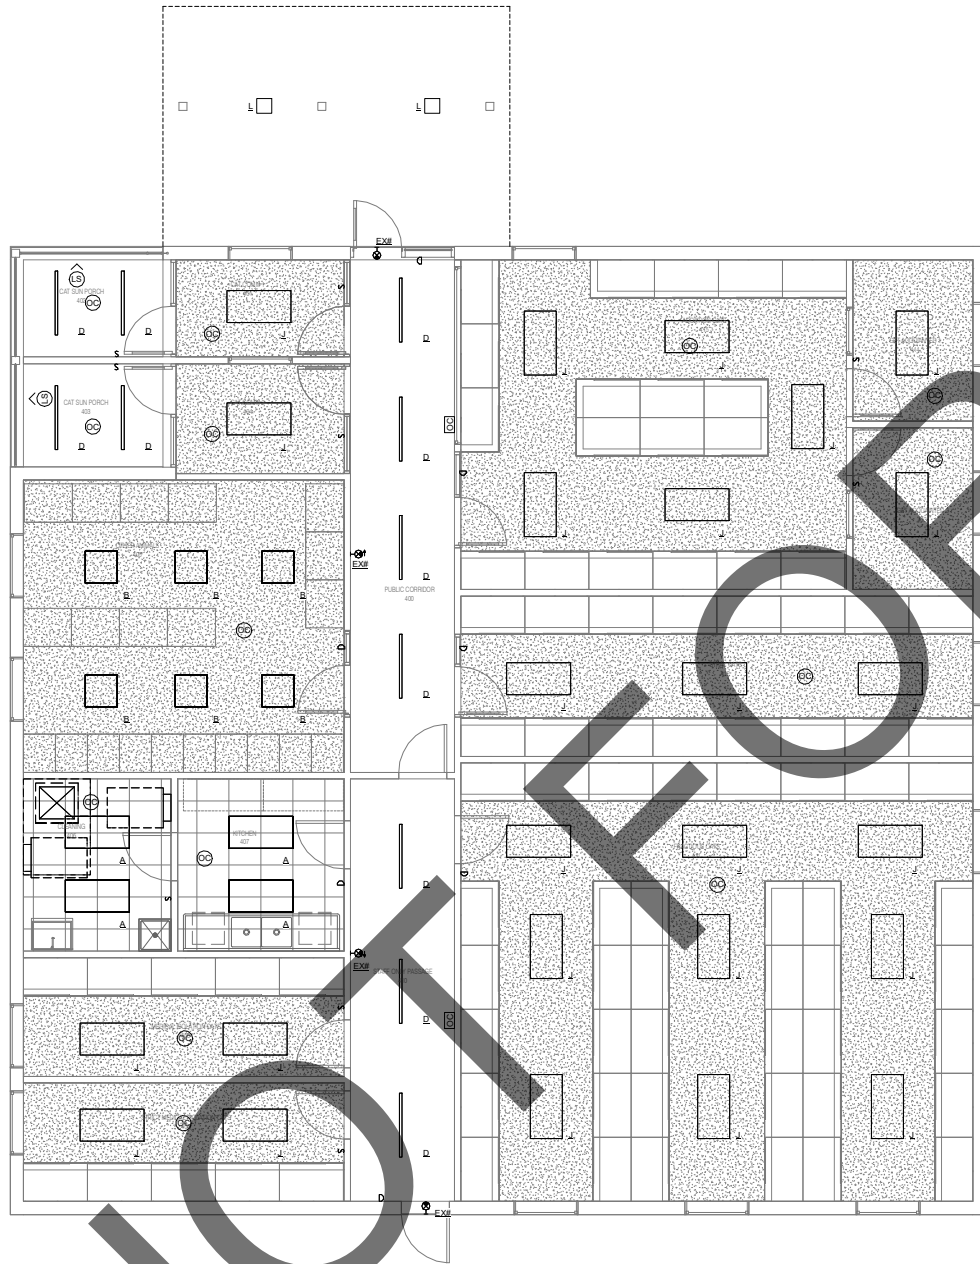

①

CAT & OTHER ANIMALS BUILDING LIGHTING FLOOR PLAN

1/4" = 1'-0"



PRELIMINARY
NOT FOR
CONSTRUCTION



**architecture
interiors
planning**



**1177 Idaho Street, Suite 200
Redlands, CA 92374
Phone: 909-335-7400
Fax: 909-335-7299
info@milller-aip.com**



owner approval

initials	date	phase

revisions/addenda

#	Date	Comment
---	------	---------

ANIMAL CARE CENTER

18313 VALLEY BLVD. BLOOMINGTON, CA 92313

SAN BERNARDINO COUNTY

project information

Project Number:	1227
Drawn By:	Author
Checked By:	MB
Issue Date:	06/01/23


sheet name

ANIMALS
BUILDING
LIGHTING
FLOOR PLAN
sheet number

sheet number



ED-101

Sheet Of Sheets

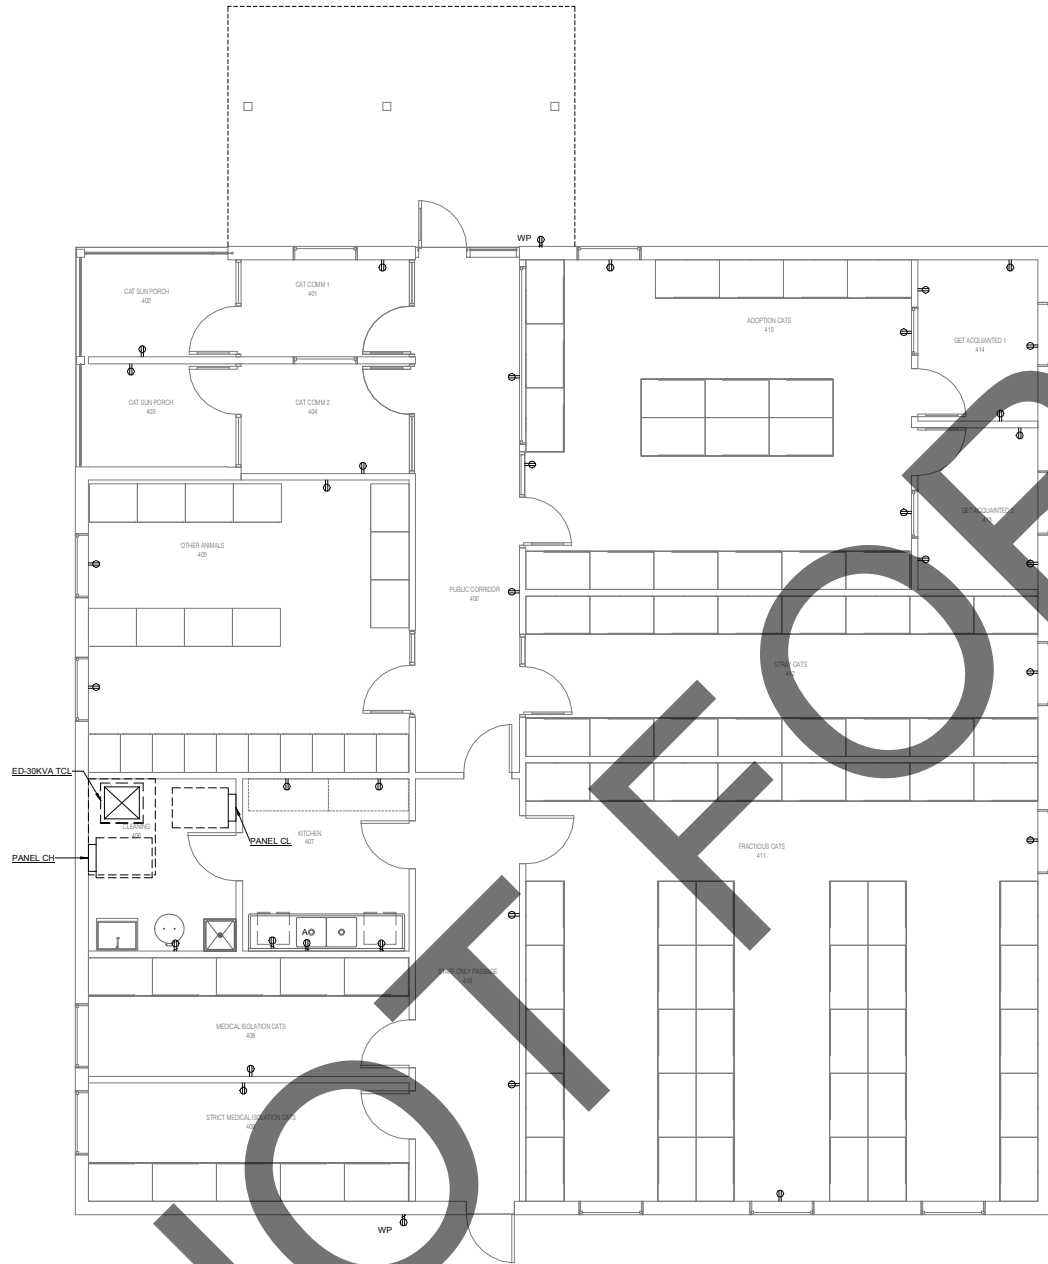

CAT & OTHER ANIMALS BUILDING POWER FLOOR PLAN

1/4" = 1'-0"

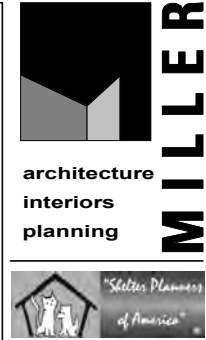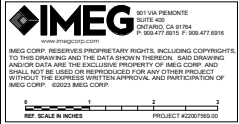

1177 Idaho Street, Suite 200
Redlands, CA 92374
Phone: 909-335-7400
Fax: 909-335-7299
info@miller-alp.com




owner approval		
Initials	date	phase
revisions/addenda		
#	Date	Comment

ANIMAL CARE CENTER
18313 VALLEY BLVD. BLOOMINGTON, CA 92313
SAN BERNARDINO COUNTY

project information
Project Number: 1227
Drawn By: Author
Checked By: MB
Issue Date: 06/01/23

sheet name
CAT & OTHER ANIMALS BUILDING POWER FLOOR PLAN
sheet number


ED-201
Sheet Of Sheets

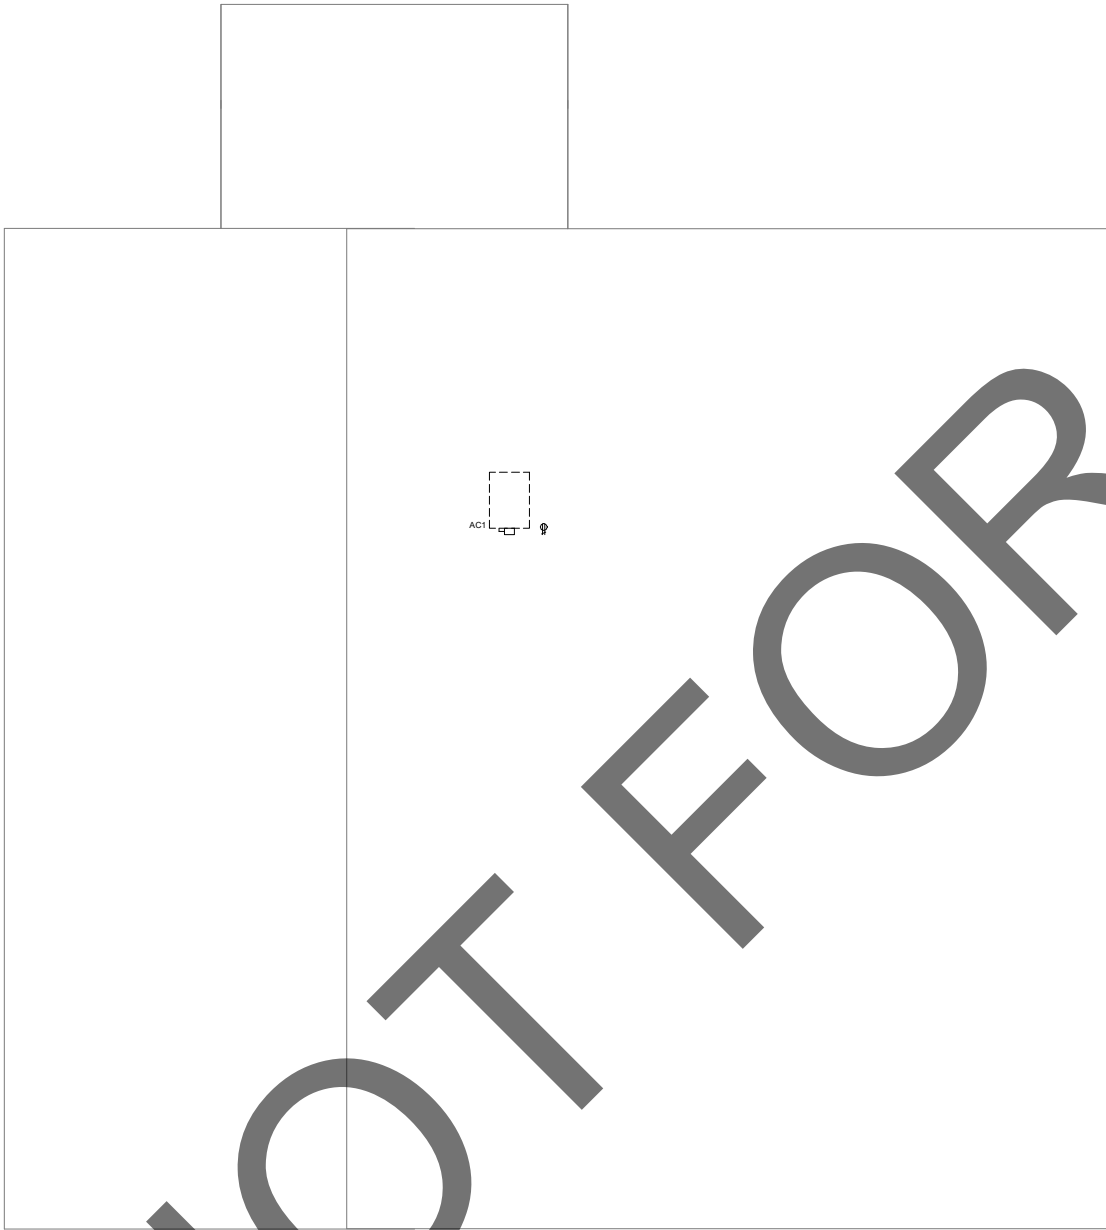

1

CAT & OTHER ANIMALS BUILDING POWER ROOF PLAN

1/4" = 1'-0"

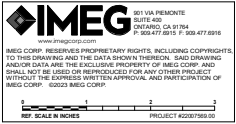

ANIMAL CARE CENTER
18313 VALLEY BLVD. BLOOMINGTON, CA 92313
SAN BERNARDINO COUNTY

project information
Project Number: 1227
Drawn By: Author
Checked By: MB
Issue Date: 06/01/23

sheet name
CAT & OTHER ANIMALS BUILDING POWER ROOF PLAN
sheet number

ED-202

Sheet Of Sheets



architecture
interiors
planning



1177 Idaho Street, Suite 200
Redlands, CA 92374
Phone: 909-335-7400
Fax: 909-335-7299
info@millier-alp.com




owner approval

initials	date	phase

revisions/addenda


#	Date	Comment
---	------	---------

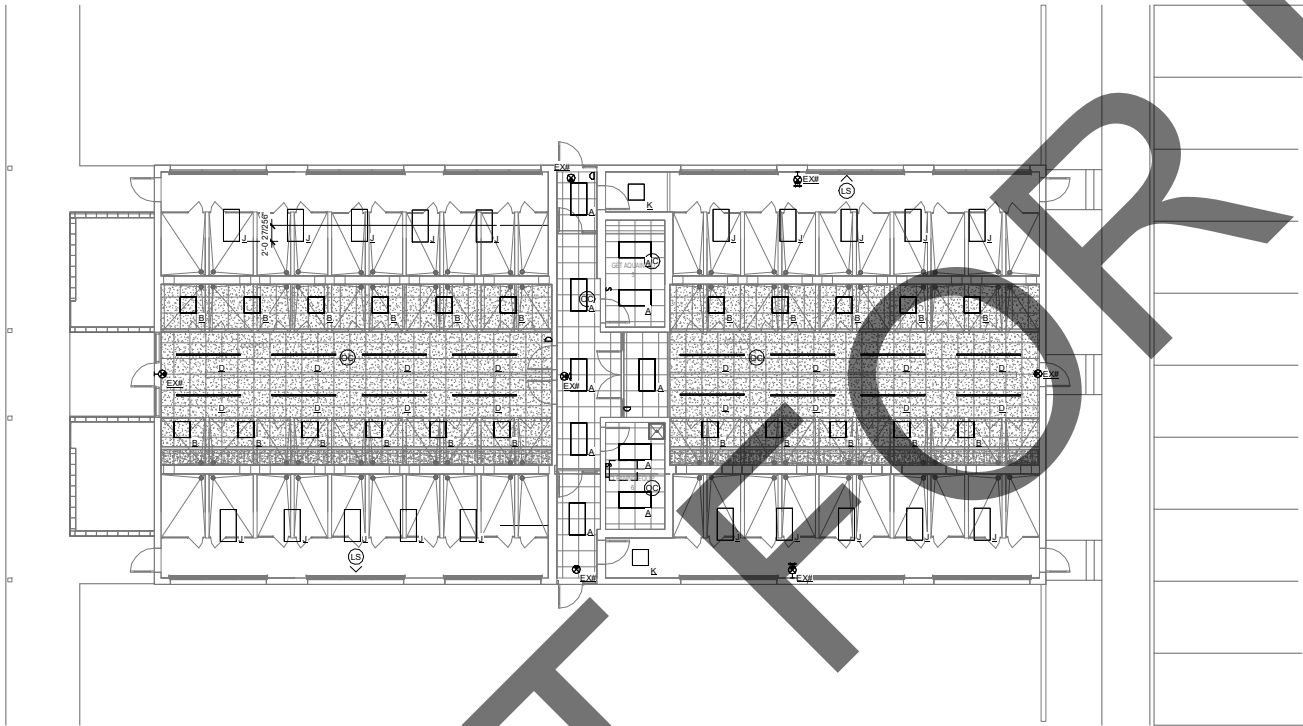

1

ADOPTION DOG BUILDING 1 LIGHTING FLOOR PLAN

1/8" = 1'-0"

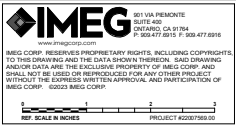

ANIMAL CARE CENTER
18313 VALLEY BLVD. BLOOMINGTON, CA 92313
SAN BERNARDINO COUNTY

project information

Project Number: 1227
Drawn By: Author
Checked By: MB
Issue Date: 06/01/23

sheet name

ADOPTION DOG
BUILDING 1
LIGHTING
FLOOR PLAN

sheet number

EE-101

Sheet Of Sheets



architecture
interiors
planning



1177 Idaho Street, Suite 200
Redlands, CA 92374
Phone: 909-335-7400
Fax: 909-335-7299
info@miller-alp.com




owner approval

initials	date	phase

revisions/addenda


#	Date	Comment
---	------	---------

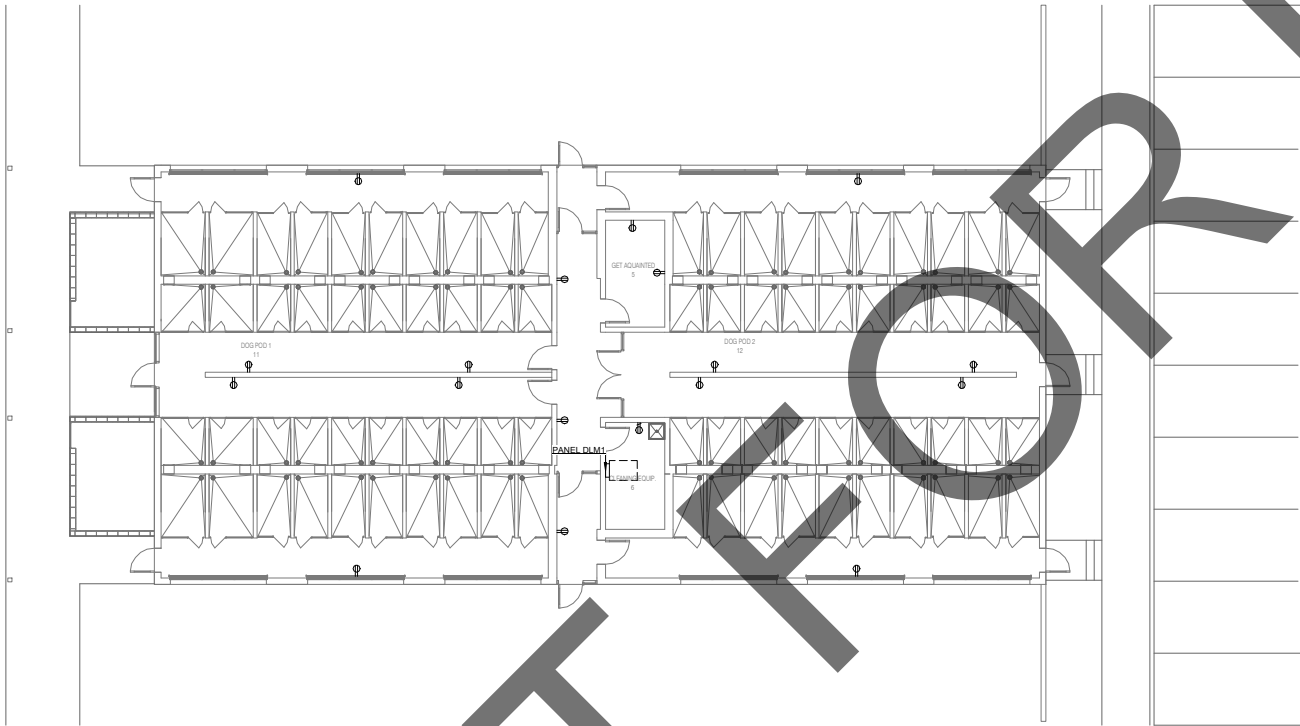

1

ADOPTION DOG BUILDING 1 POWER FLOOR PLAN

1/8" = 1'-0"

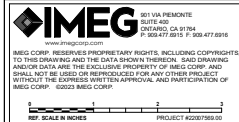

ANIMAL CARE CENTER
18313 VALLEY BLVD. BLOOMINGTON, CA 92313
SAN BERNARDINO COUNTY

project information

Project Number: 1227
Drawn By: Author
Checked By: MB
Issue Date: 06/01/23

sheet name

ADOPTION DOG
BUILDING 1
POWER FLOOR
PLAN

sheet number

EE-201

Sheet Of Sheets



architecture
interiors
planning

MILLER



1177 Idaho Street, Suite 200
Redlands, CA 92374
Phone: 909-335-7400
Fax: 909-335-7299
info@millier-alp.com




owner approval

initials	date	phase

revisions/addenda


#	Date	Comment
---	------	---------

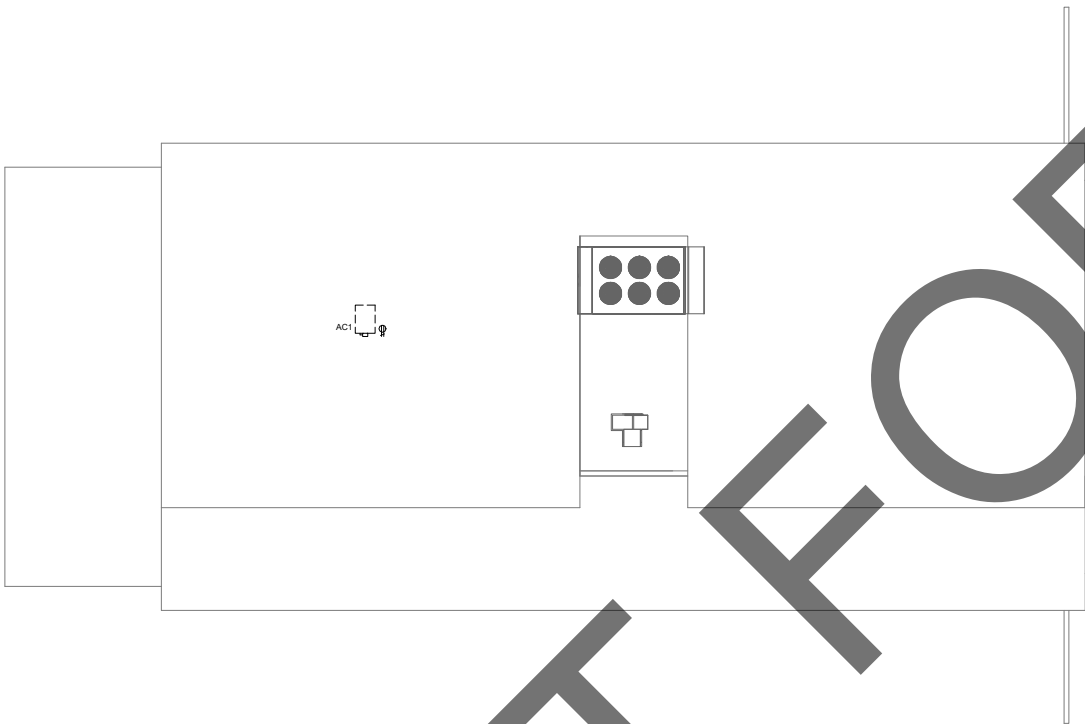

1

ADOPTION DOG BUILDING 1 POWER ROOF PLAN

1/8" = 1'-0"

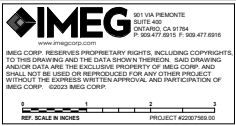

ANIMAL CARE CENTER
18313 VALLEY BLVD. BLOOMINGTON, CA 92313
SAN BERNARDINO COUNTY

project information

Project Number: 1227
Drawn By: Author
Checked By: MB
Issue Date: 06/01/23


sheet name

ADOPTION DOG
BUILDING 1
POWER ROOF
PLAN

sheet number

EE-202

Sheet Of Sheets

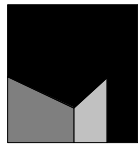

architecture
interiors
planning

MILLER



1177 Idaho Street, Suite 200
Redlands, CA 92374
Phone: 909-335-7400
Fax: 909-335-7299
info@millier-alp.com




owner approval

initials	date	phase

revisions/addenda


#	Date	Comment
---	------	---------

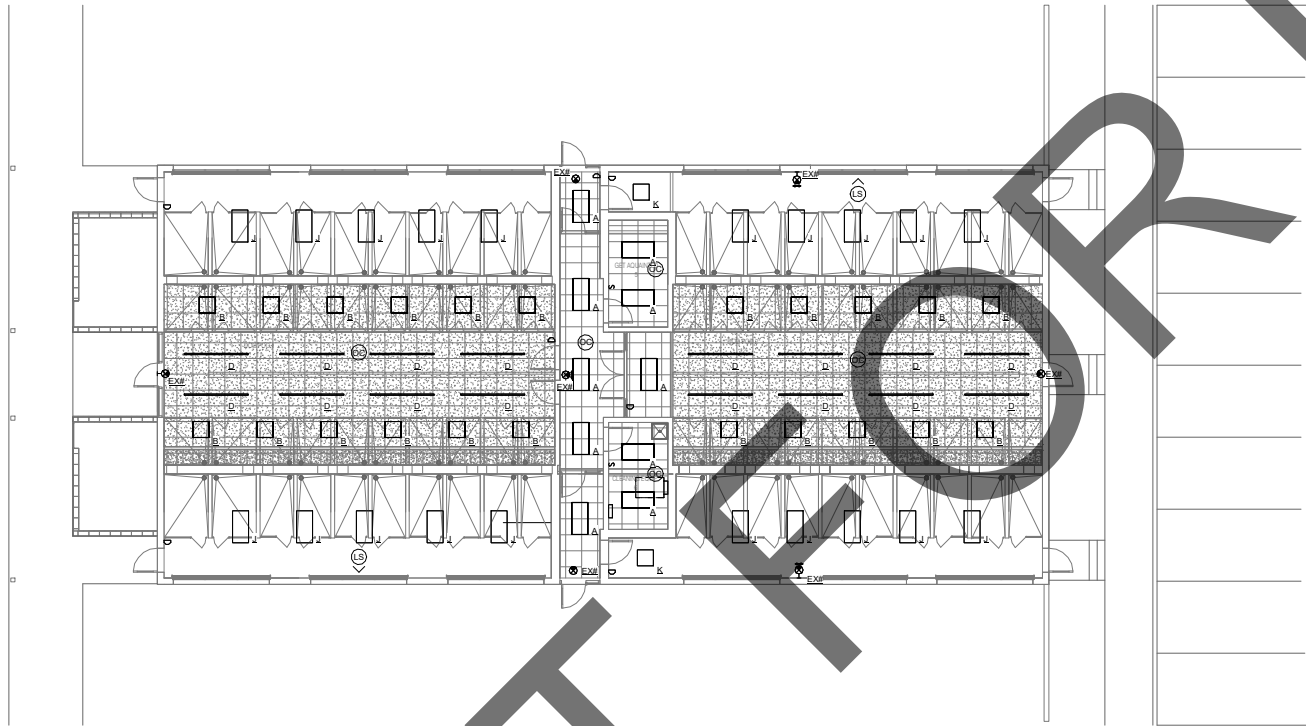

1

ADOPTION DOG BUILDING 2 LIGHTING FLOOR PLAN

1/8" = 1'-0"

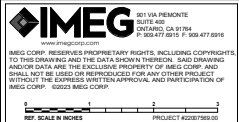

PRELIMINARY
NOT FOR
CONSTRUCTION

ANIMAL CARE CENTER
18313 VALLEY BLVD. BLOOMINGTON, CA 92313
SAN BERNARDINO COUNTY

project information

Project Number: 1227
Drawn By: Author
Checked By: MB
Issue Date: 06/01/23

sheet name

ADOPTION DOG
BUILDING 2
LIGHTING
FLOOR PLAN

sheet number

EF-101

Sheet Of Sheets



architecture
interiors
planning

MILLER



1177 Idaho Street, Suite 200
Redlands, CA 92374
Phone: 909-335-7400
Fax: 909-335-7299
info@miller-alp.com




owner approval

initials	date	phase

revisions/addenda


#	Date	Comment

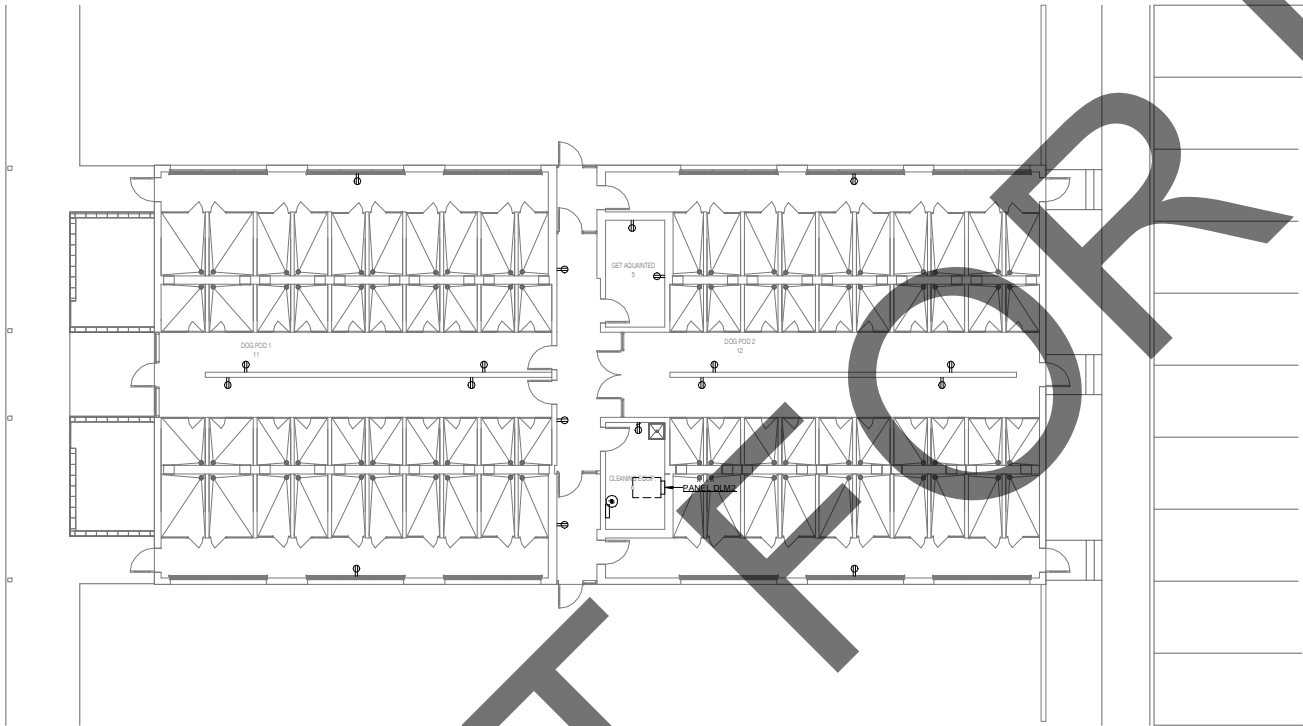

1

ADOPTION DOG BUILDING 2 POWER FLOOR PLAN

1/8" = 1'-0"

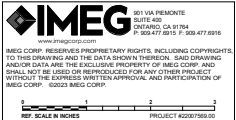

ANIMAL CARE CENTER
18313 VALLEY BLVD. BLOOMINGTON, CA 92313
SAN BERNARDINO COUNTY

project information

Project Number: 1227
Drawn By: Author
Checked By: MB
Issue Date: 06/01/23

sheet name

ADOPTION DOG
BUILDING 2
POWER FLOOR
PLAN

sheet number

EF-201

Sheet Of Sheets



architecture
interiors
planning

MILLER



1177 Idaho Street, Suite 200
Redlands, CA 92374
Phone: 909-335-7400
Fax: 909-335-7299
info@millier-alp.com




owner approval

initials	date	phase

revisions/addenda


#	Date	Comment
---	------	---------

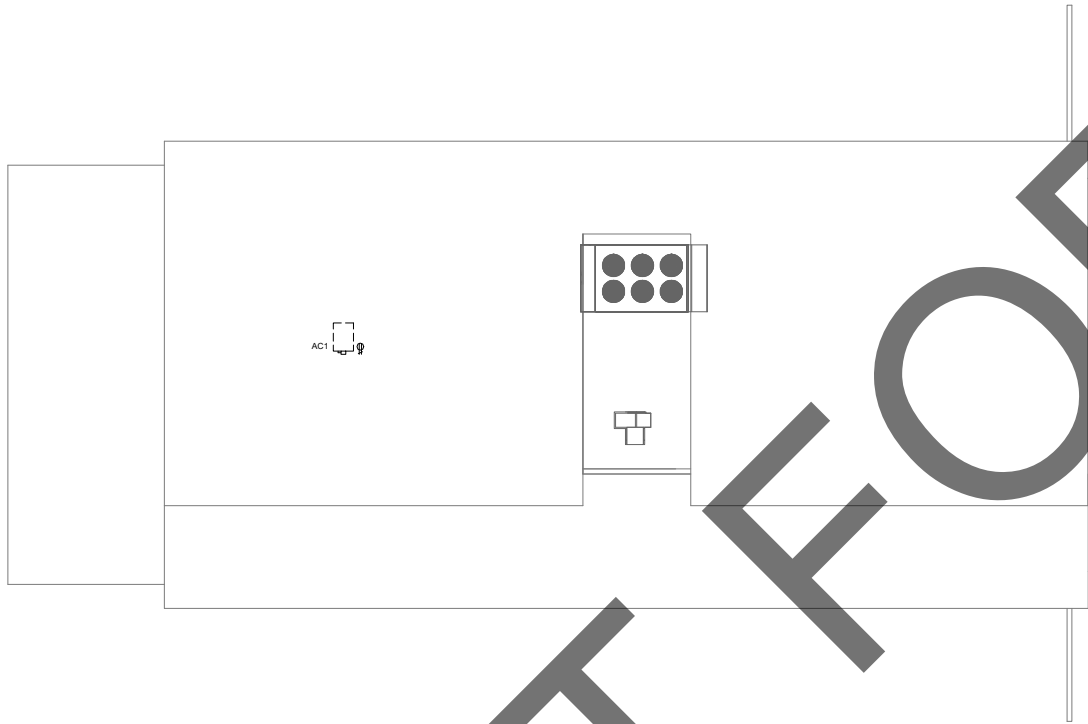

1

ADOPTION DOG BUILDING 2 POWER ROOF PLAN

1/8" = 1'-0"

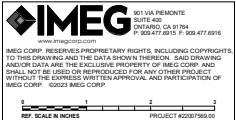

ANIMAL CARE CENTER
18313 VALLEY BLVD. BLOOMINGTON, CA 92313
SAN BERNARDINO COUNTY

project information

Project Number: 1227
Drawn By: Author
Checked By: MB
Issue Date: 06/01/23

sheet name

ADOPTION DOG
BUILDING 2
POWER ROOF
PLAN

sheet number

EF-202

Sheet Of Sheets



architecture
interiors
planning



1177 Idaho Street, Suite 200
Redlands, CA 92374
Phone: 909-335-7400
Fax: 909-335-7299
info@millar-alp.com




owner approval

initials	date	phase

revisions/addenda


#	Date	Comment
---	------	---------

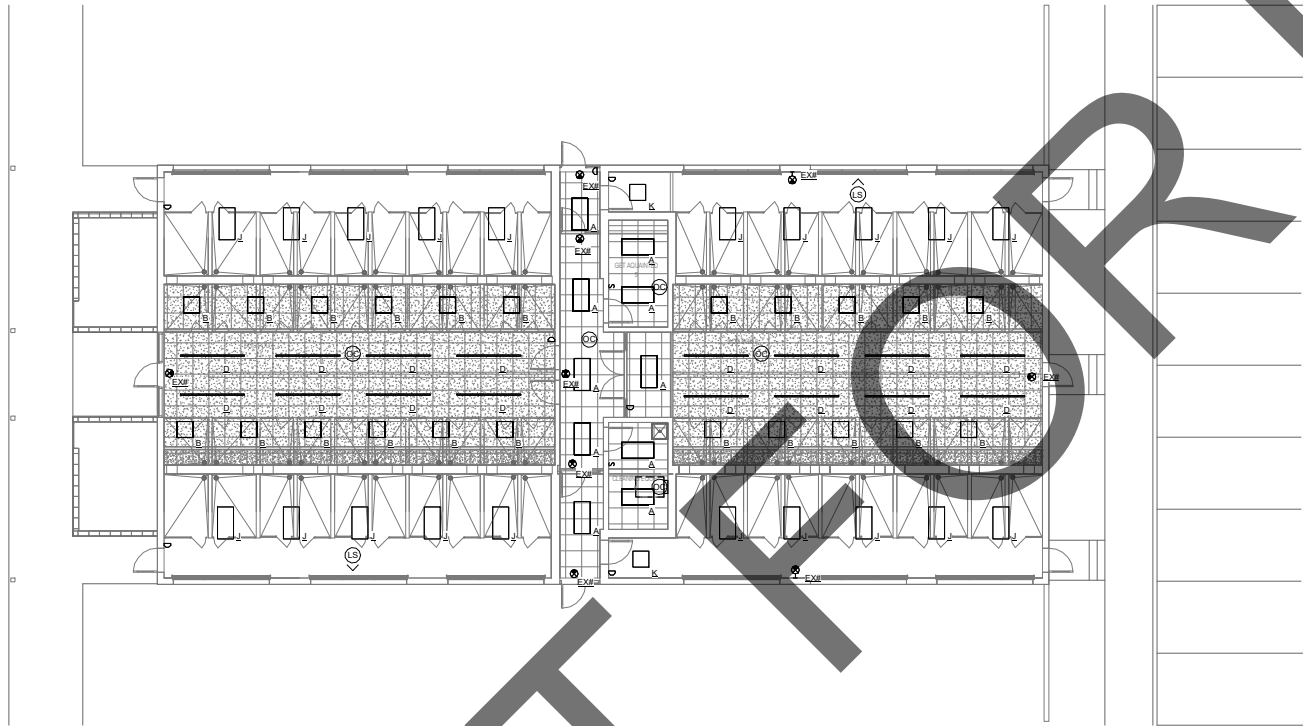

1

ADOPTION DOG BUILDING 3 LIGHTING FLOOR PLAN

1/8" = 1'-0"

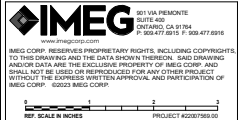

PRELIMINARY
NOT FOR
CONSTRUCTION

ANIMAL CARE CENTER
18313 VALLEY BLVD. BLOOMINGTON, CA 92313
SAN BERNARDINO COUNTY

project information

Project Number: 1227
Drawn By: Author
Checked By: MB
Issue Date: 06/01/23

sheet name

ADOPTION DOG
BUILDING 3
LIGHTING
FLOOR PLAN

sheet number

EG-101

Sheet Of Sheets



architecture
interiors
planning

MILLER



1177 Idaho Street, Suite 200
Redlands, CA 92374
Phone: 909-335-7400
Fax: 909-335-7299
info@miller-alp.com



owner approval

Initials	date	phase

revisions/addenda

#	Date	Comment
---	------	---------