
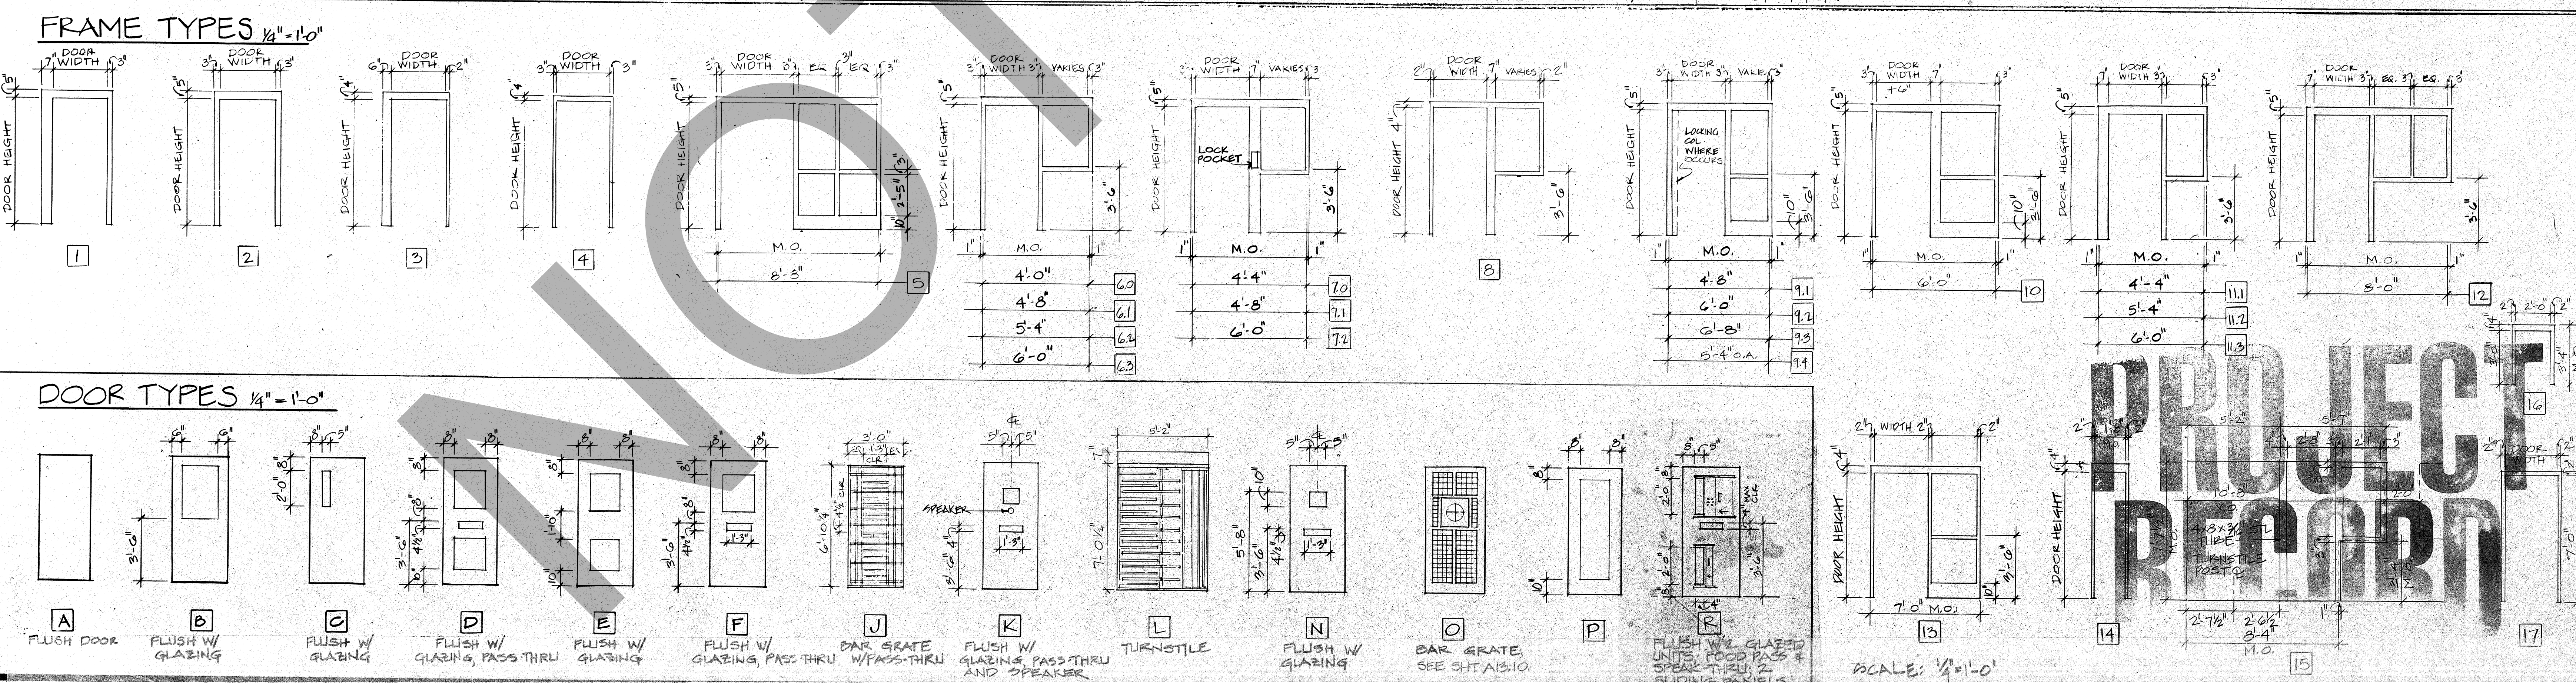


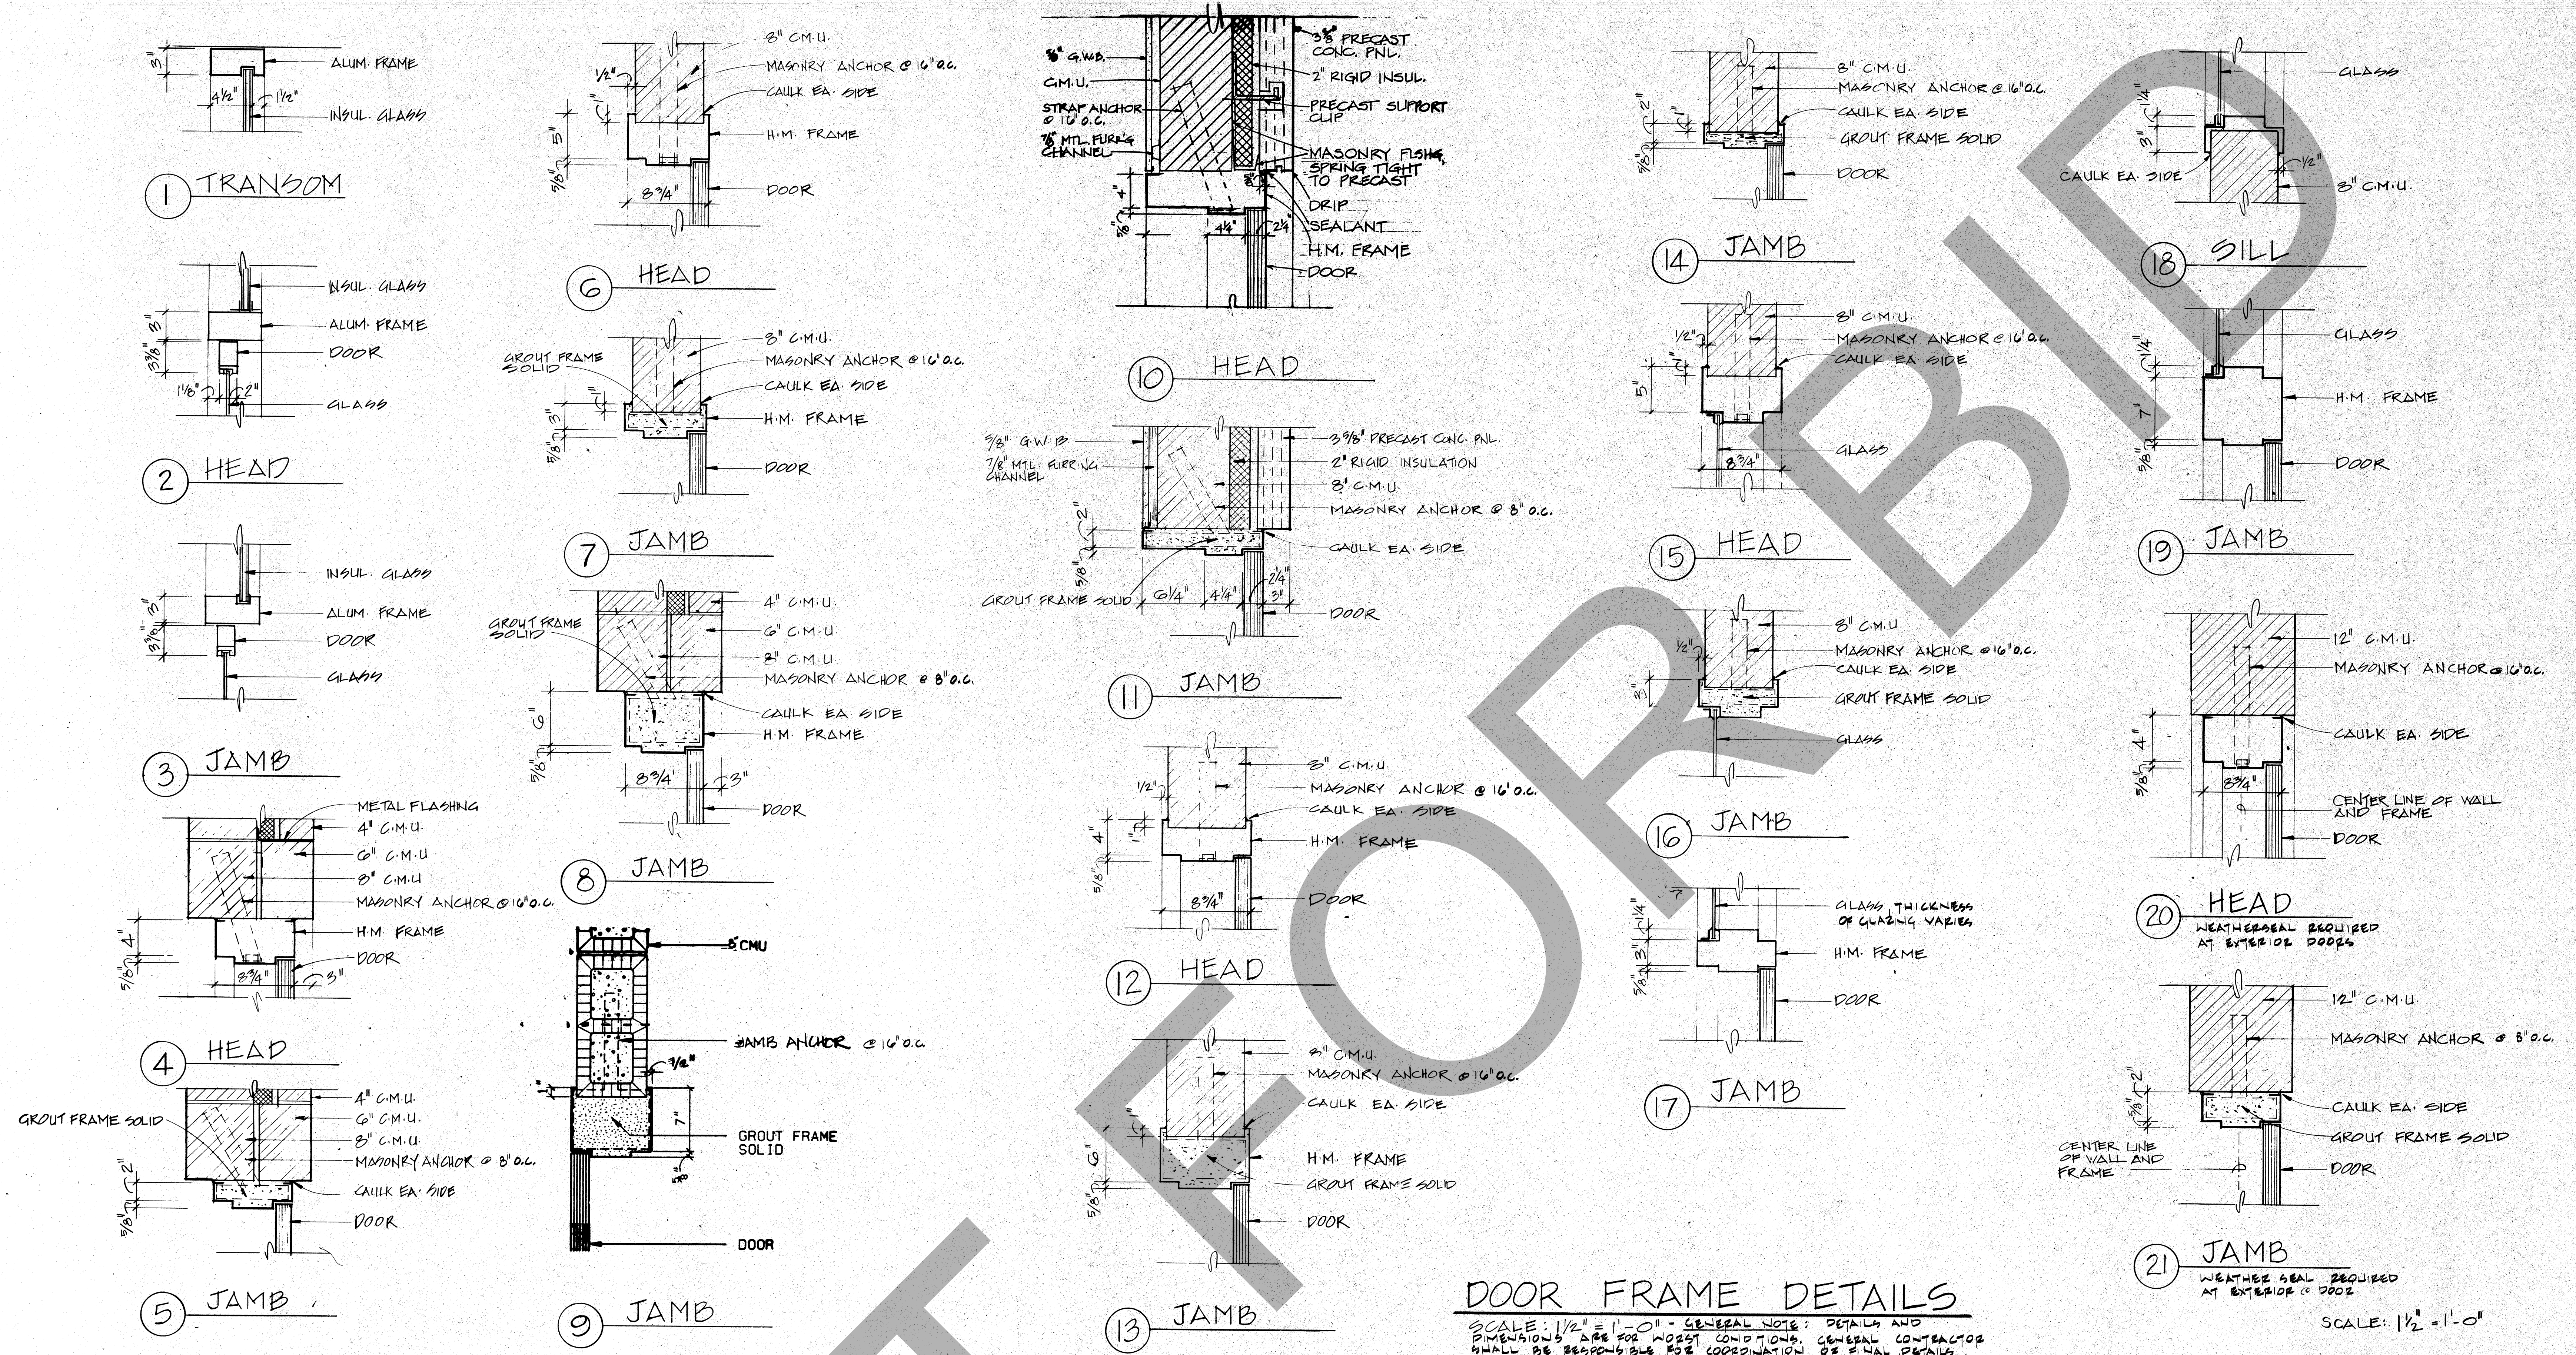

ROSSER FABRAP INTERNATIONAL
 Comprehensive Services to Building Design and Technology
 Atlanta Savannah Tampa

ROSSER FABRAP INTERNATIONAL
 Criminal Justice Architecture, Technology Planning, Interiors
 Mechanical, Electrical, Plumbing, Security, & Civil Engineering

JUSTICE SYSTEMS INCORPORATED
 Criminal Justice Operations, Programming
JOHNSON & NIELSEN
 Structural Engineering

WEST - VALLEY - DETENTION - CENTER
 FOR THE COUNTY OF SAN BERNARDINO, CALIFORNIA

HARRY MAYS, COUNTY ADMINISTRATION OFFICER
FLOYD TIDWELL, SHERIFF
BOARD OF SUPERVISORS
 San Mateo, Second District
 Larry Williams, Board President
 Larry Williams, Board President


PROJECT REPORT

TYPICAL ELEVATIONS - DOORS & FRAMES


Job No. 22055-21
 Date 12-17-20

A136


33

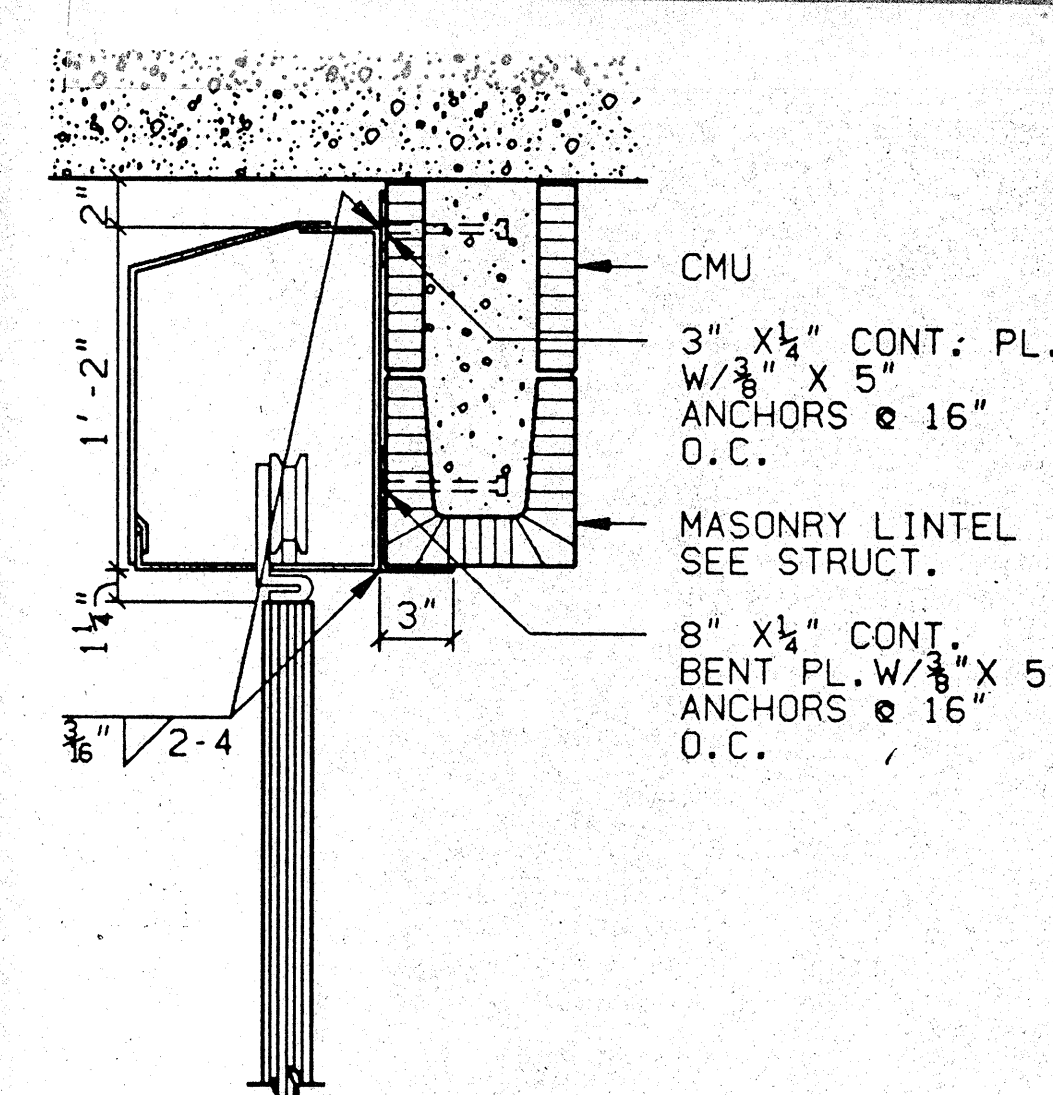


55 HEAD
SCALE: 1 1/2" = 1'-0"

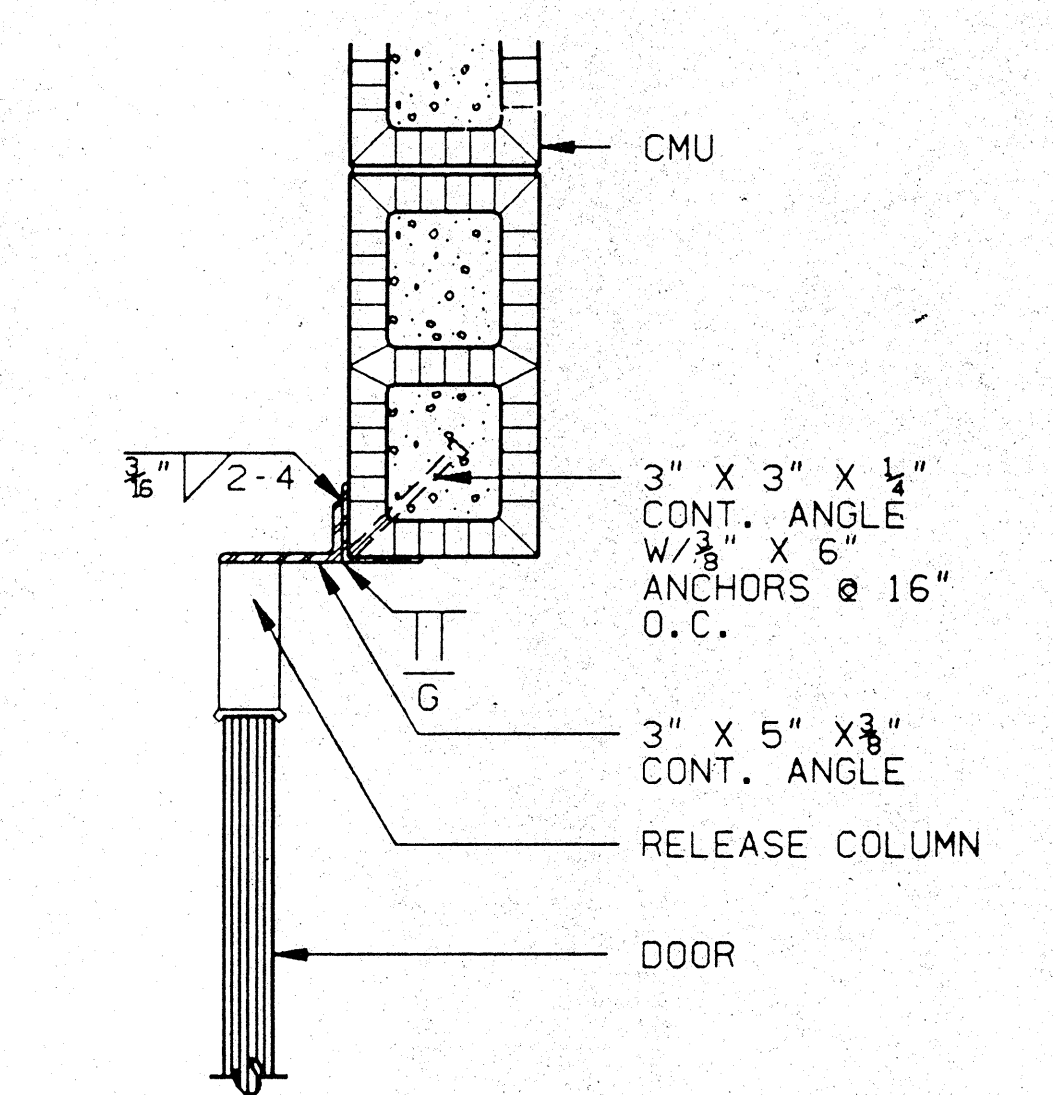


56 JAMB
SCALE: 1 1/2" = 1'-0"

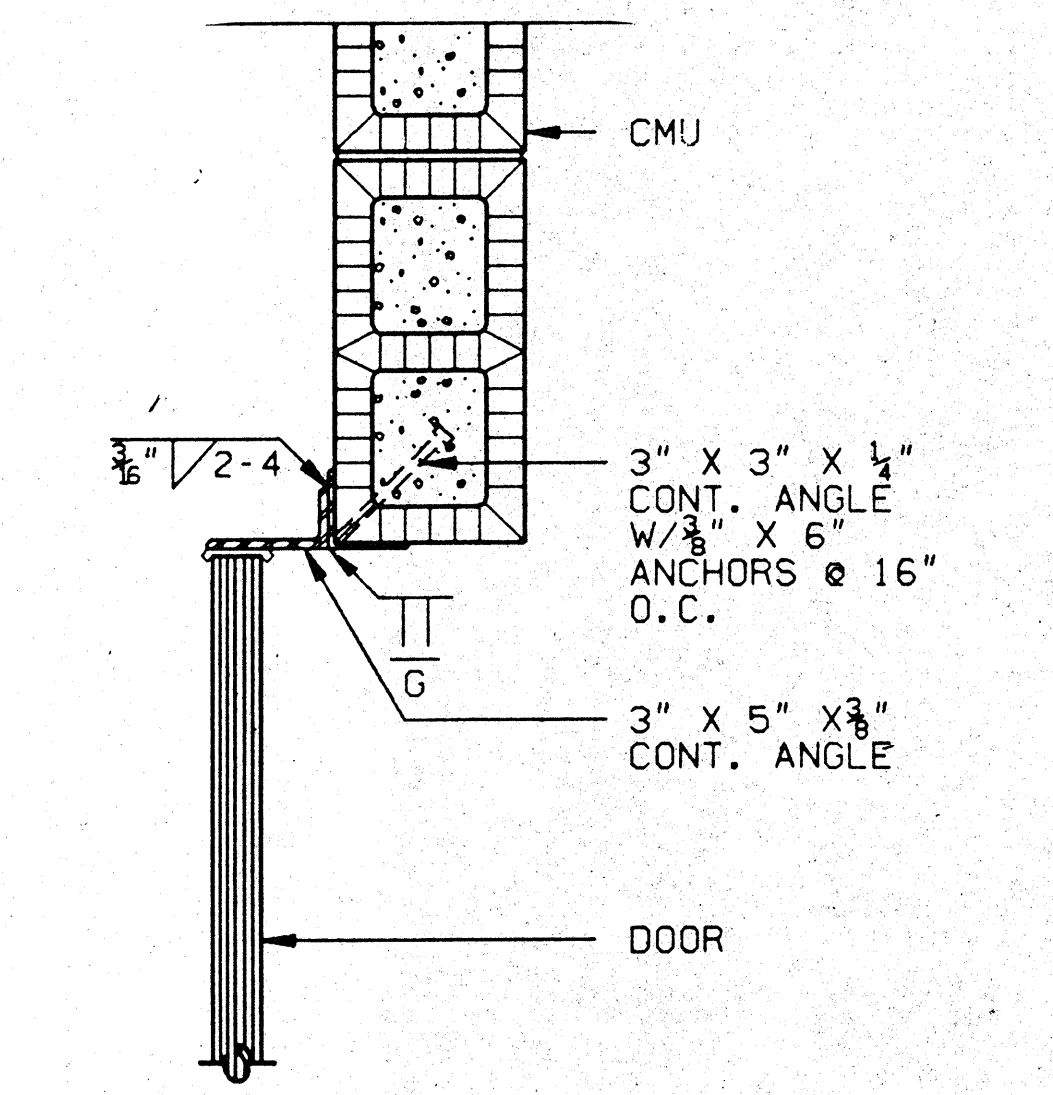


57 JAMB
SCALE: 1 1/2" = 1'-0"

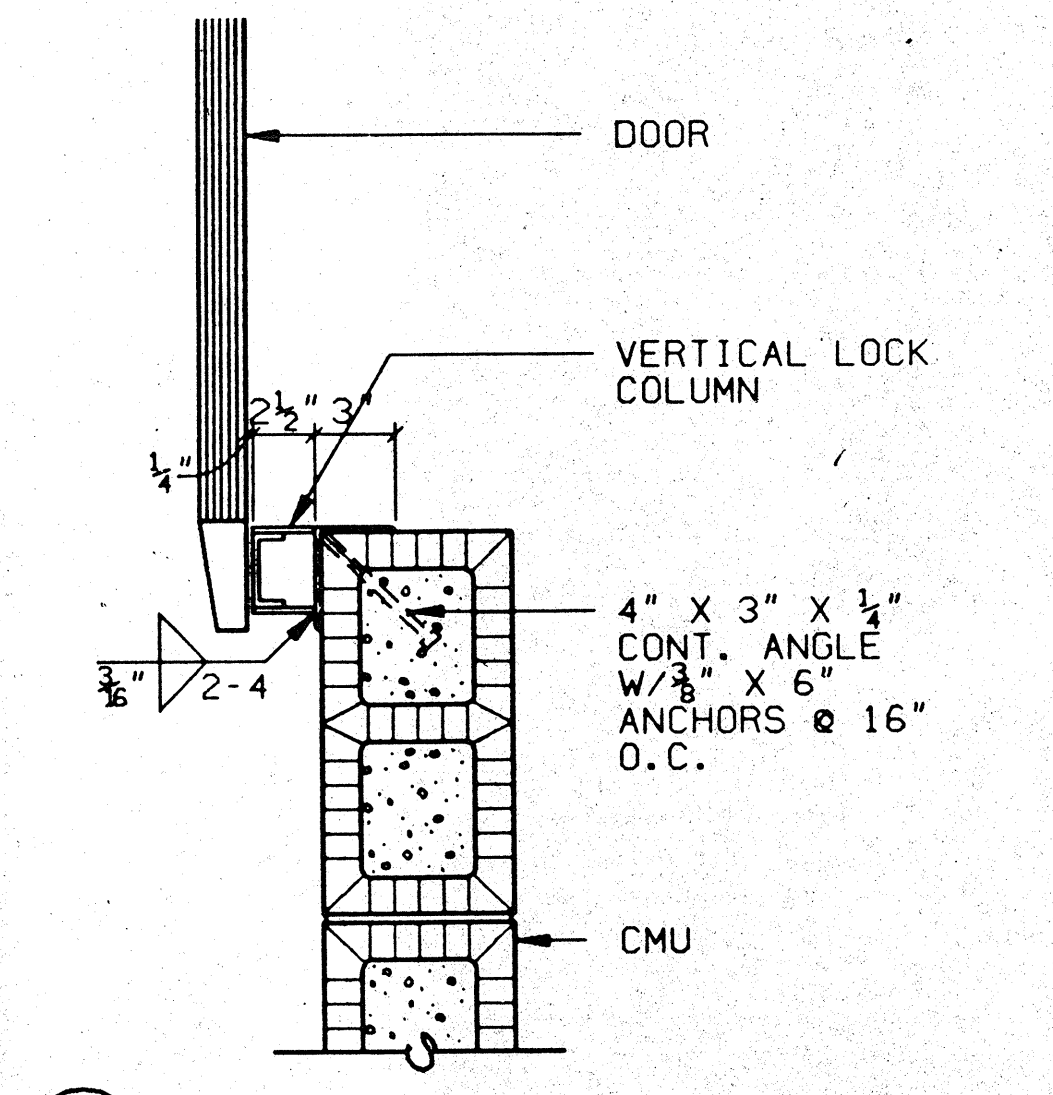


58 JAMB
SCALE: 1 1/2" = 1'-0"

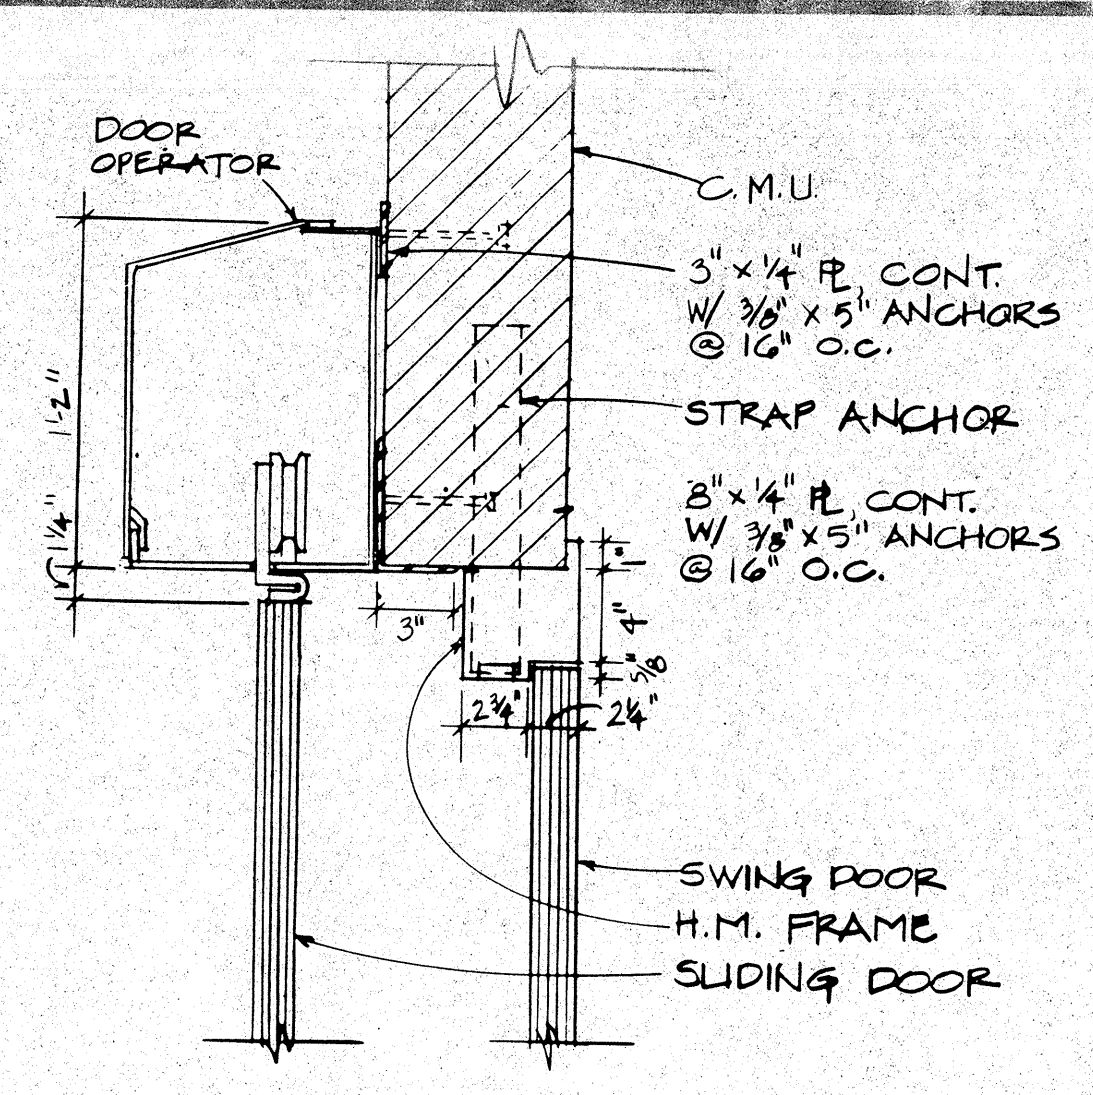


59A HEAD
59B

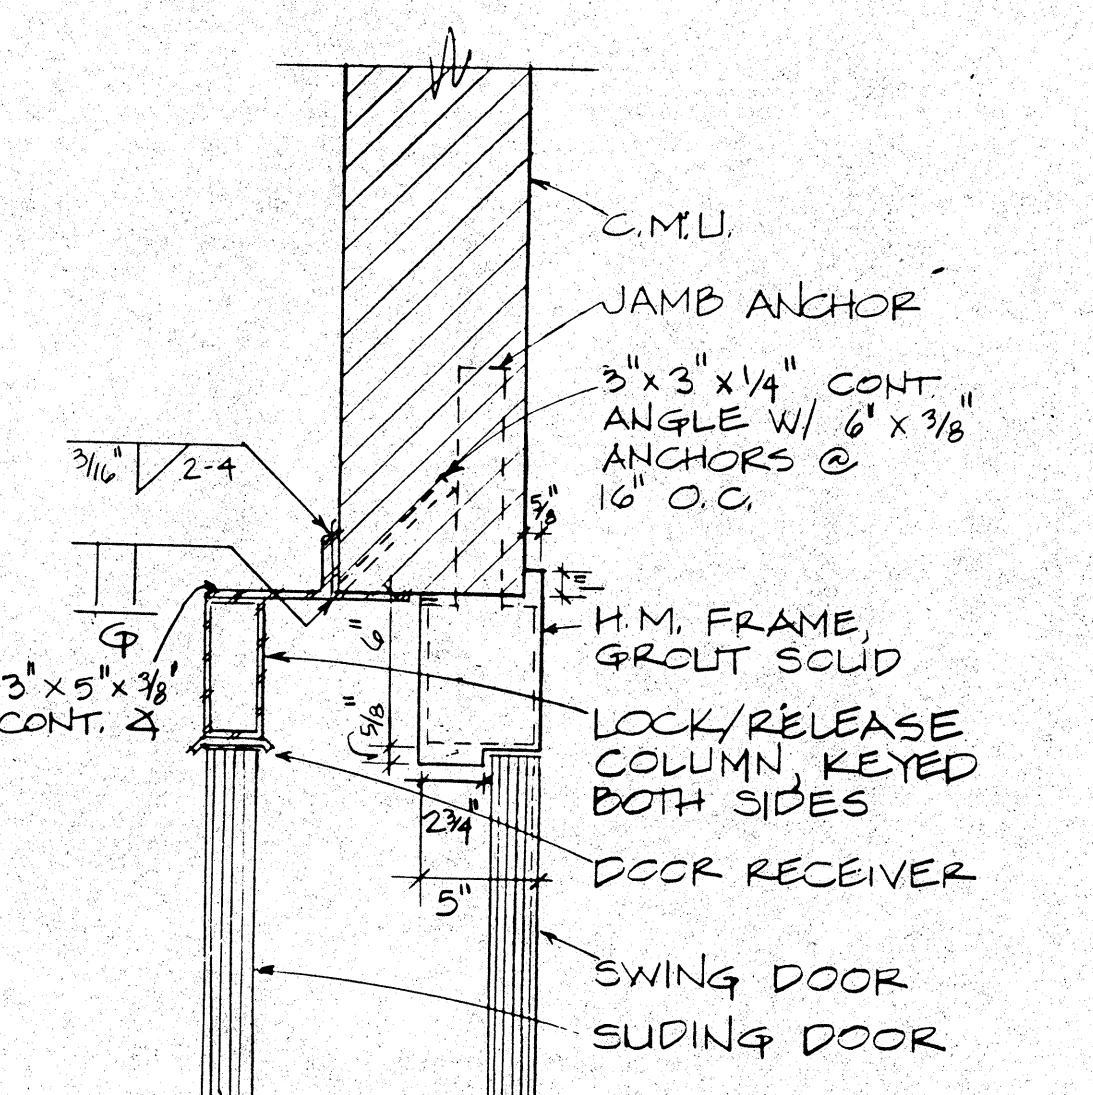


60A JAMB
M.O. = DOOR WIDTH + 8"

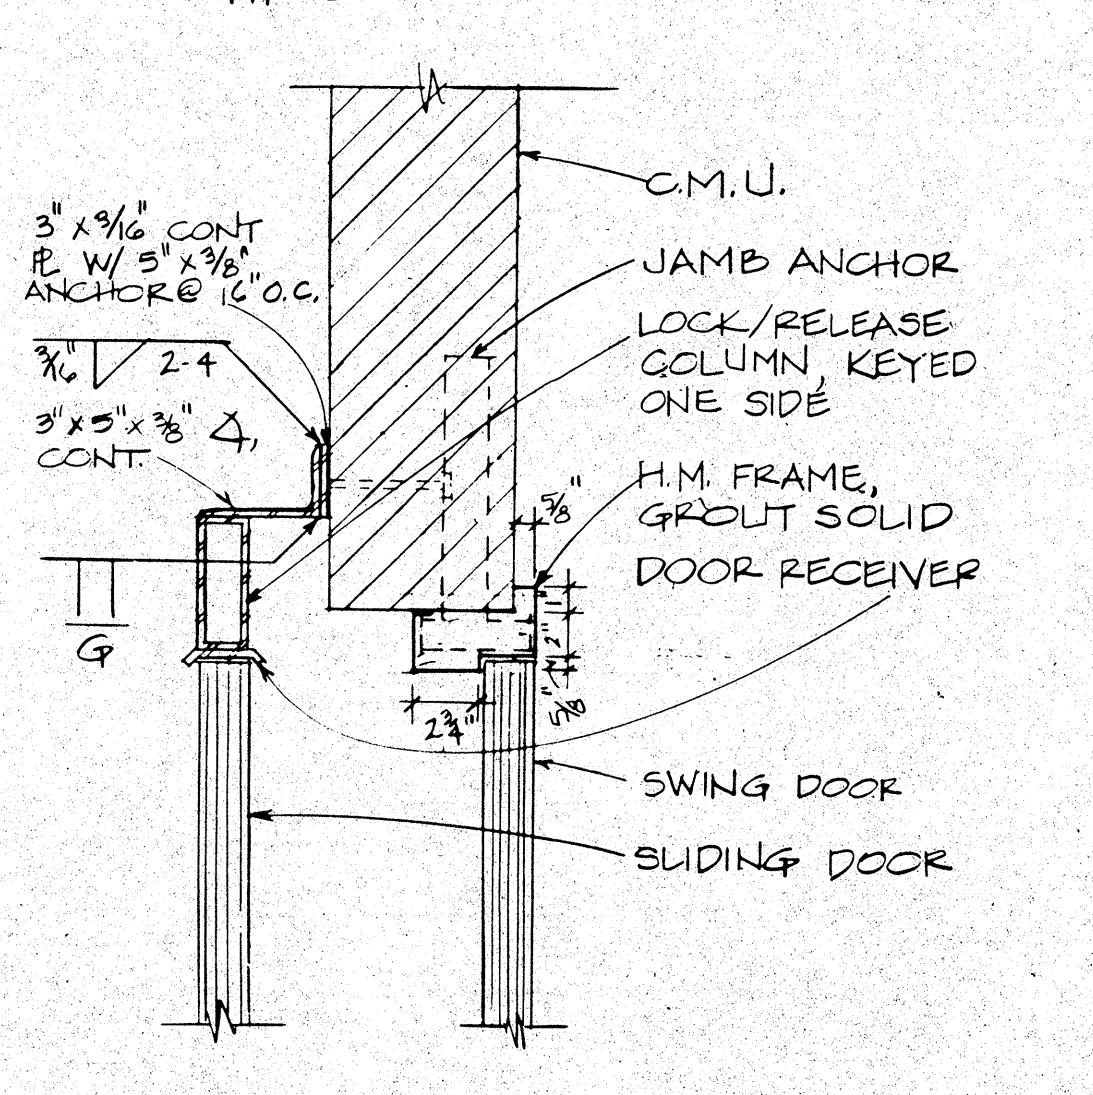


61A JAMB
M.O. = DOOR WIDTH + 4"

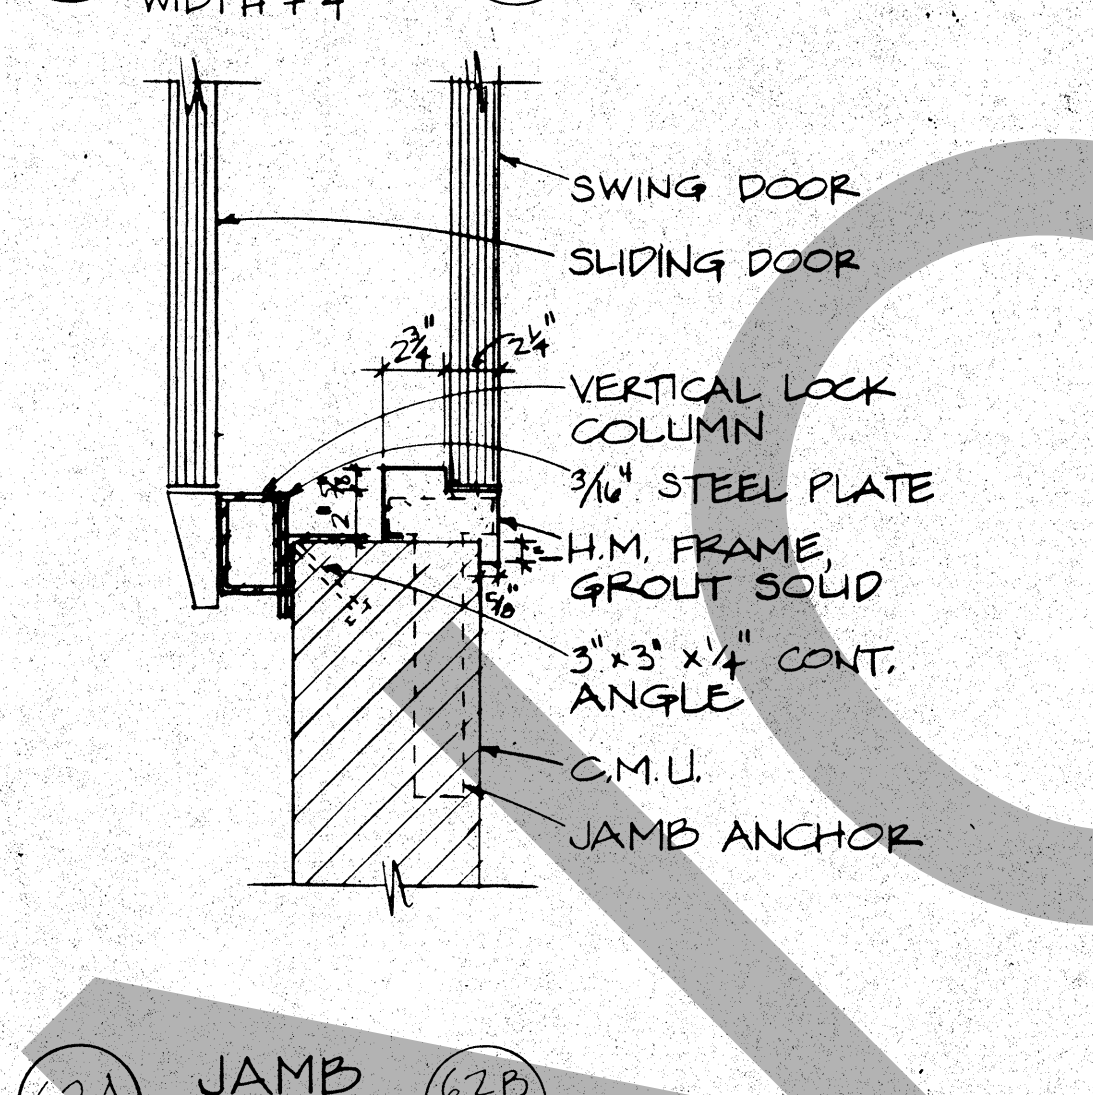


62A JAMB
62B

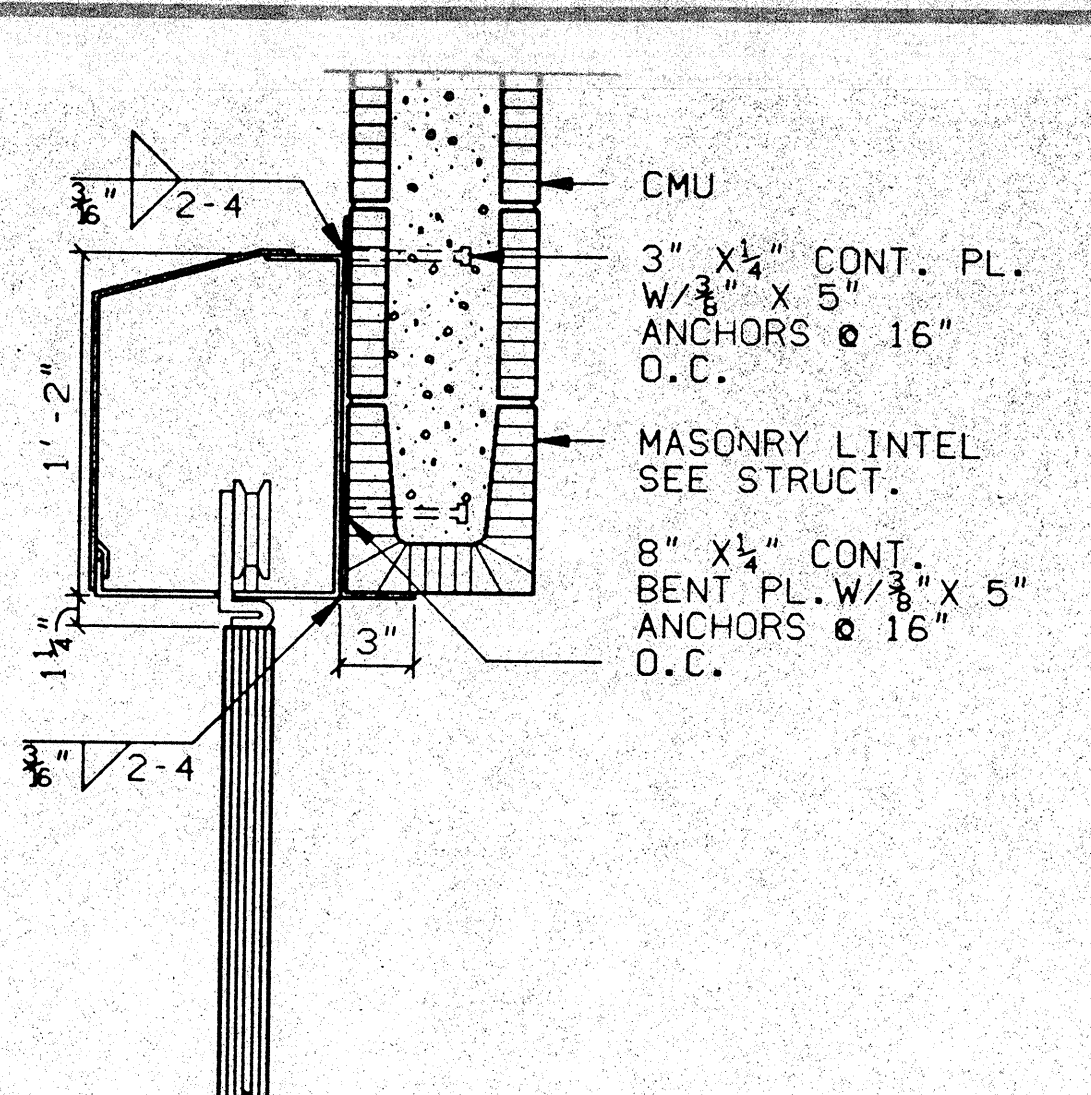


63 HEAD
SCALE: 1 1/2" = 1'-0"

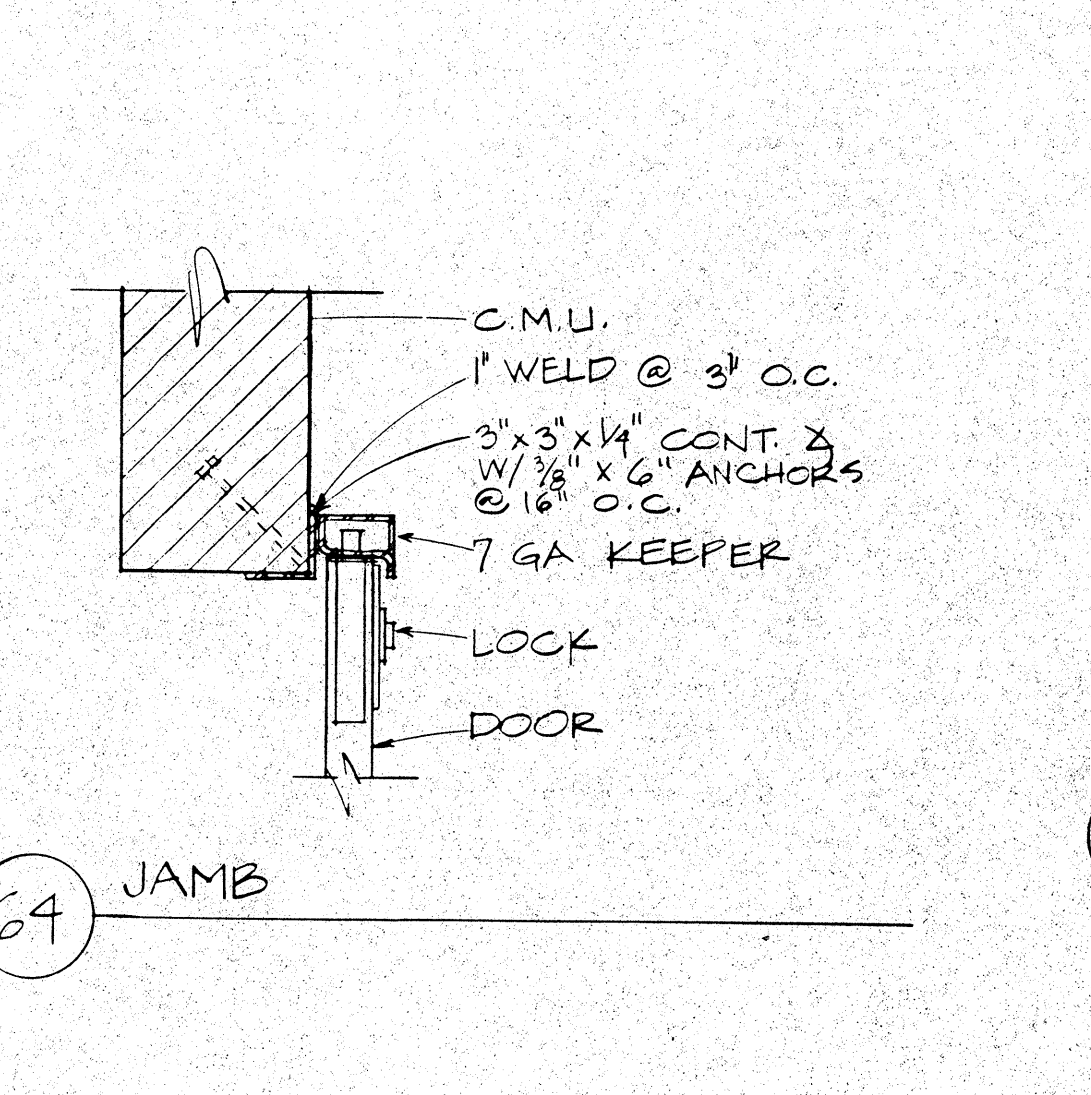


64 JAMB

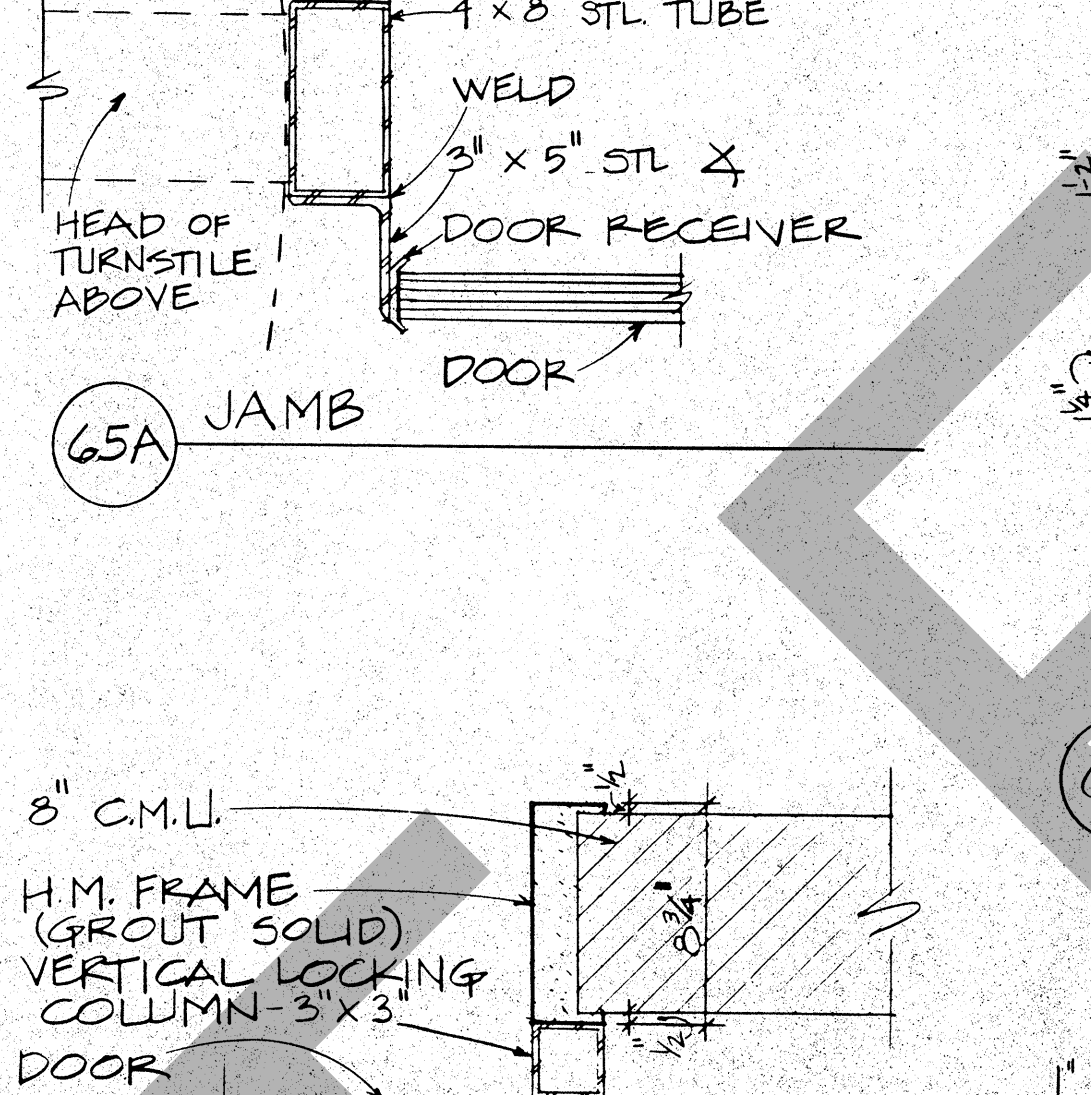


65A JAMB

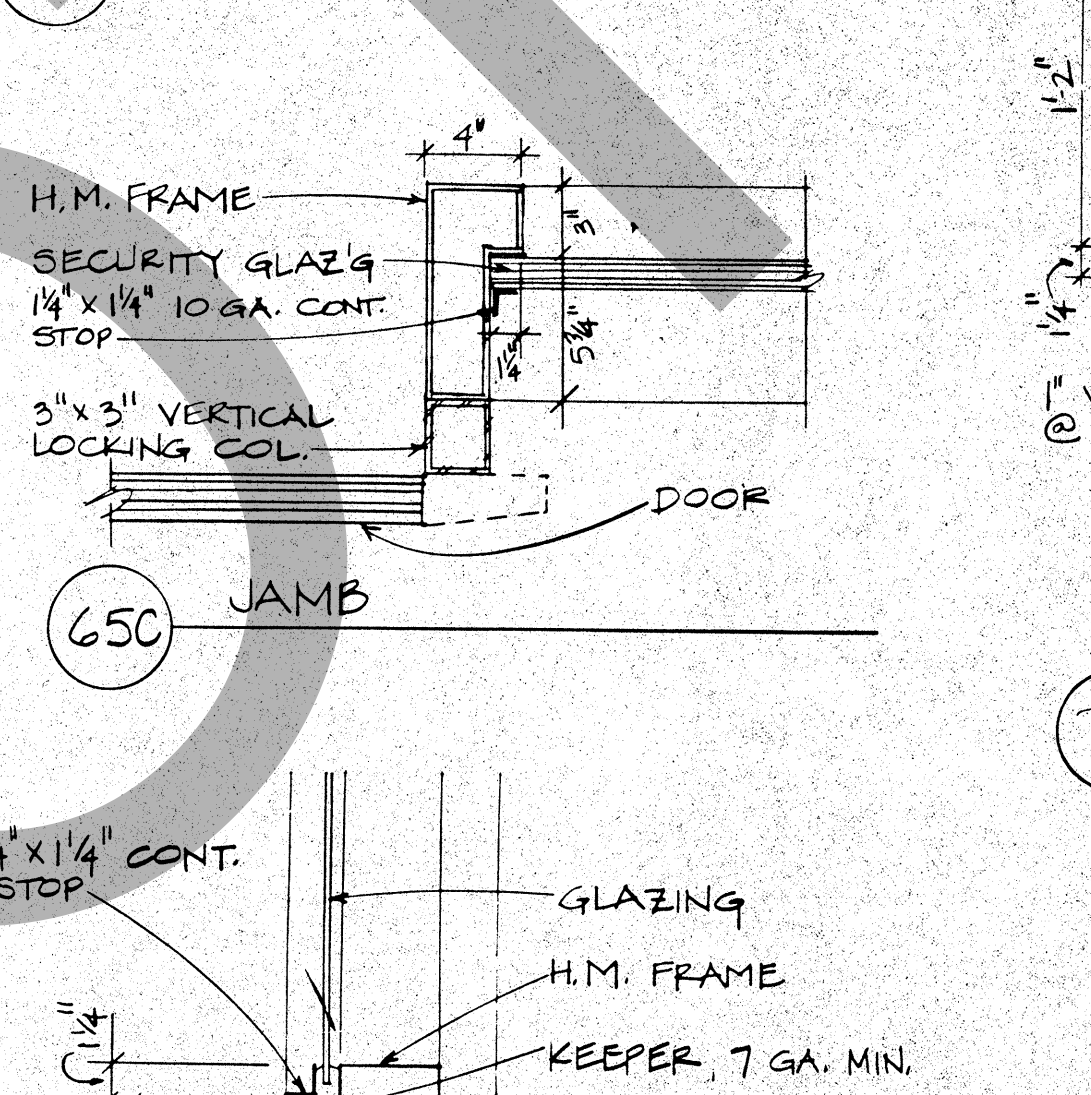


65B JAMB

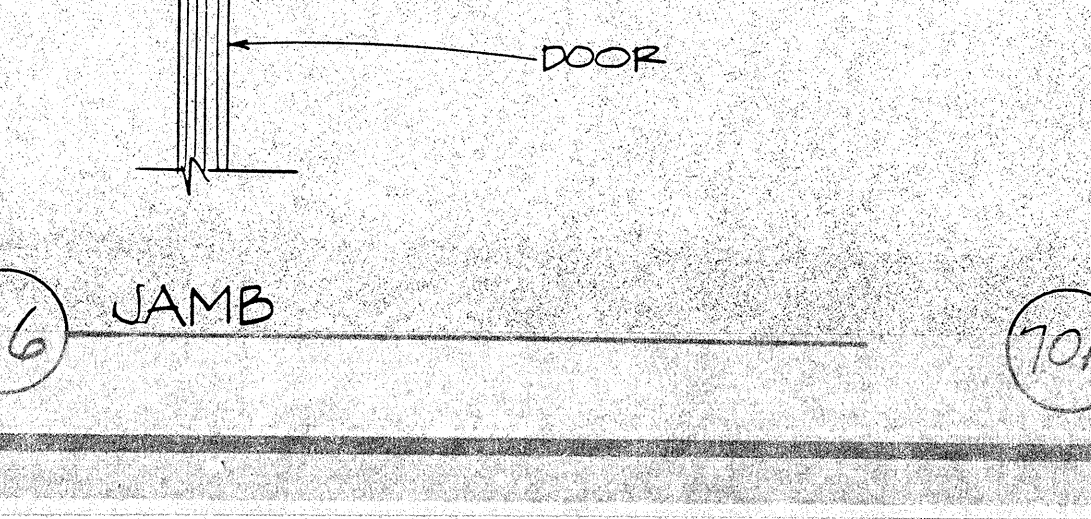


66 JAMB

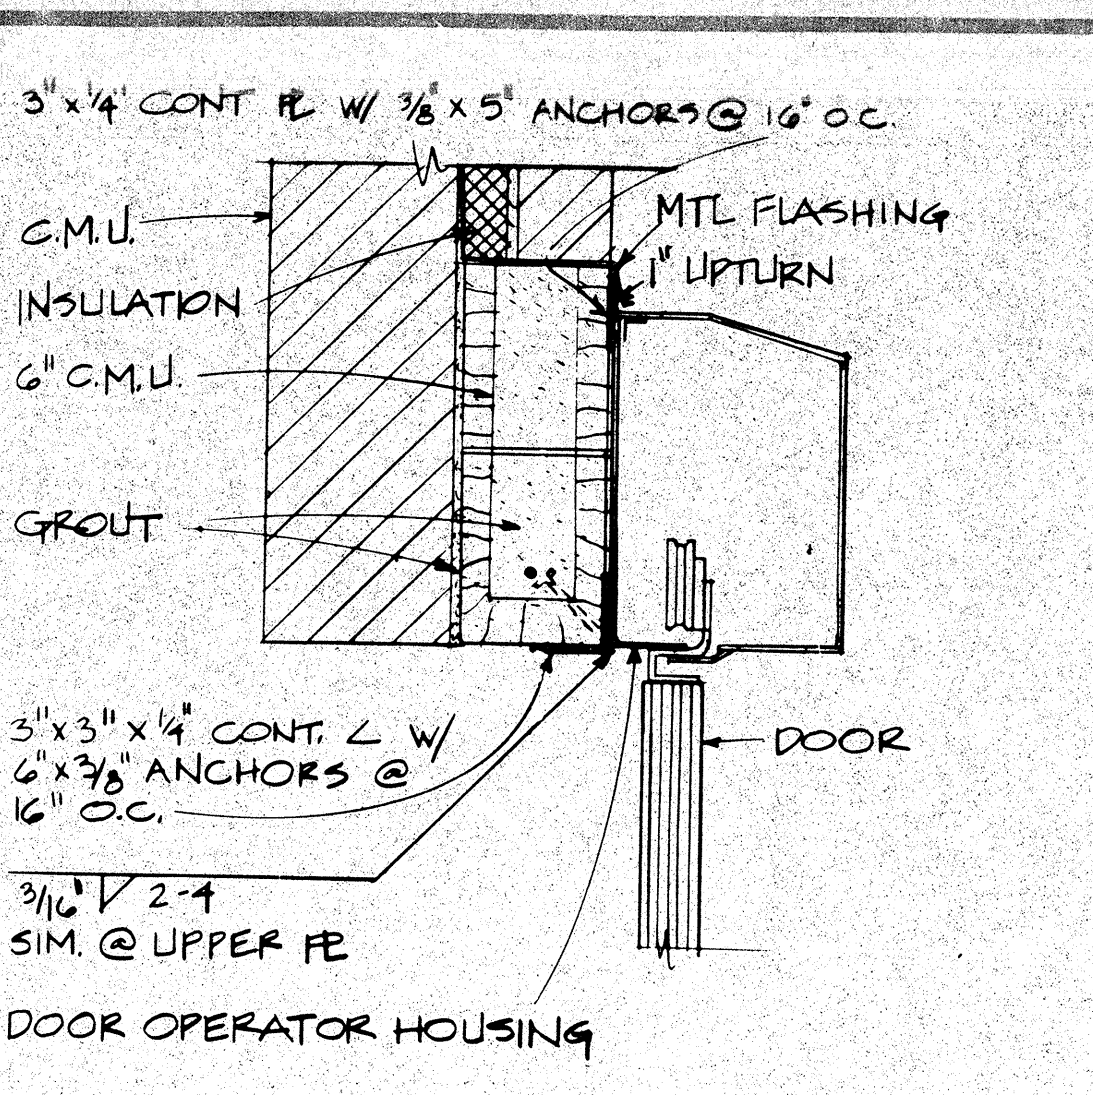


67 HEAD

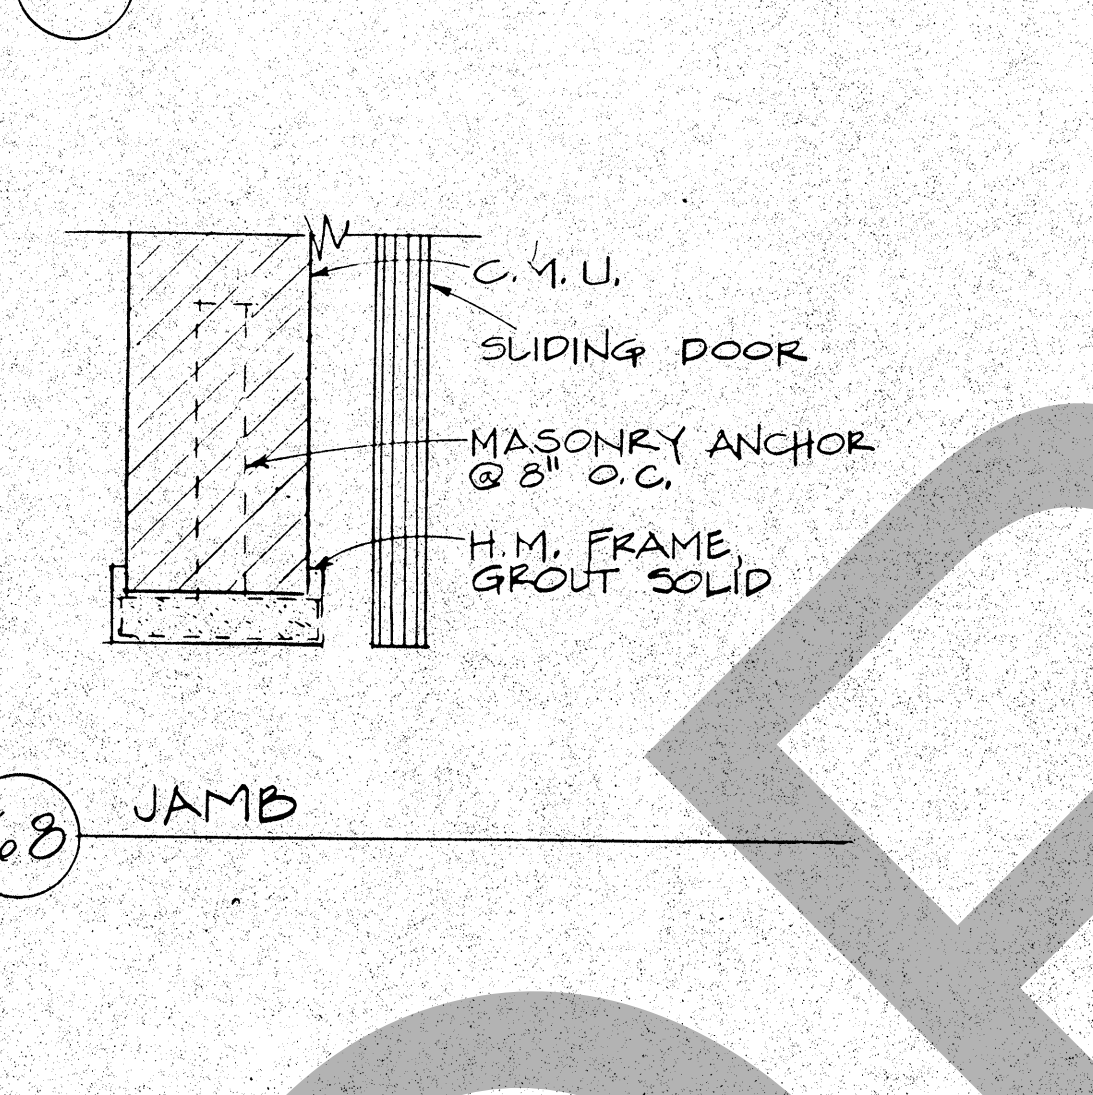


68 JAMB

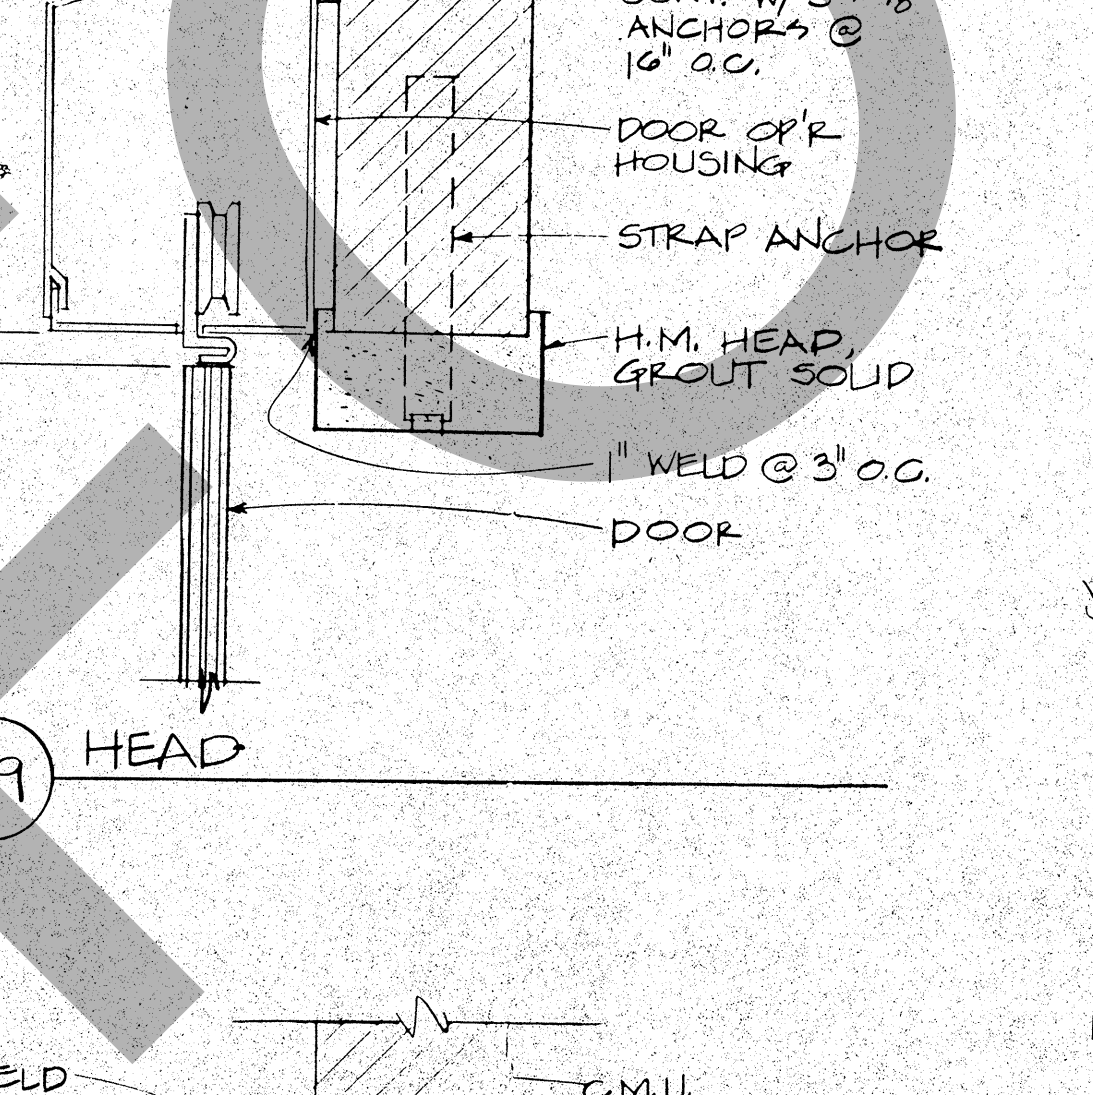


69 HEAD

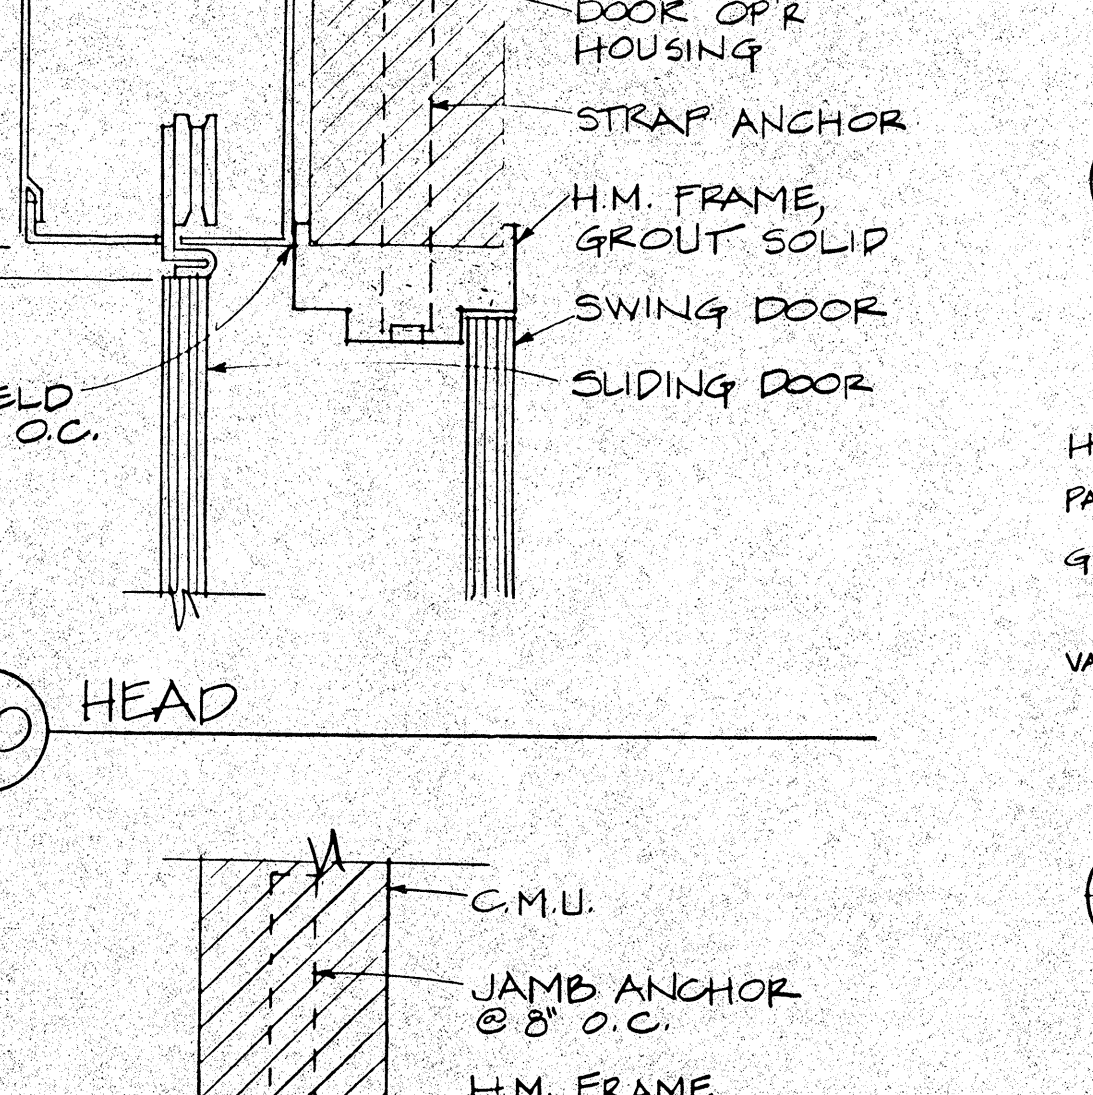


70 HEAD

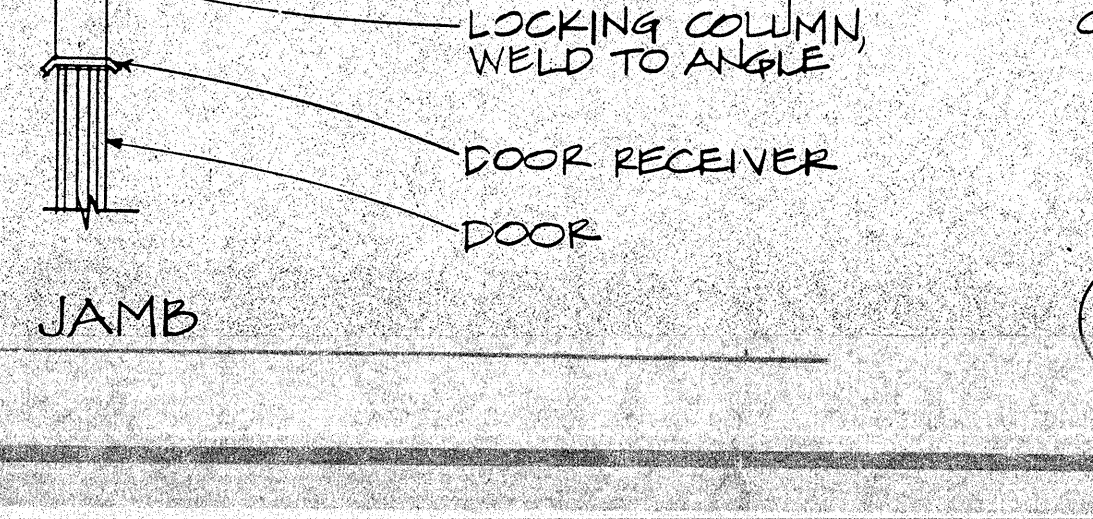


71A JAMB

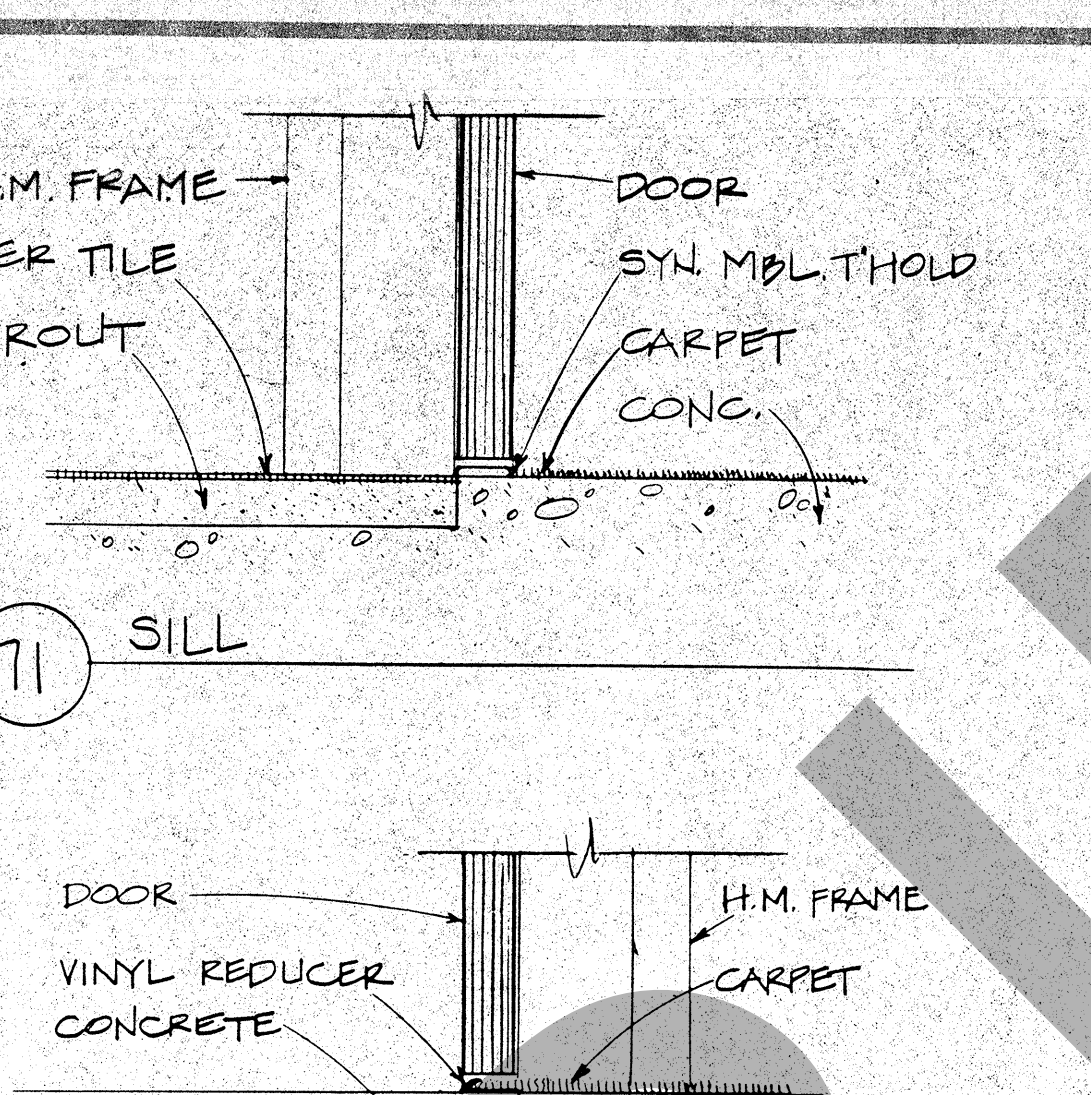


72 SILL

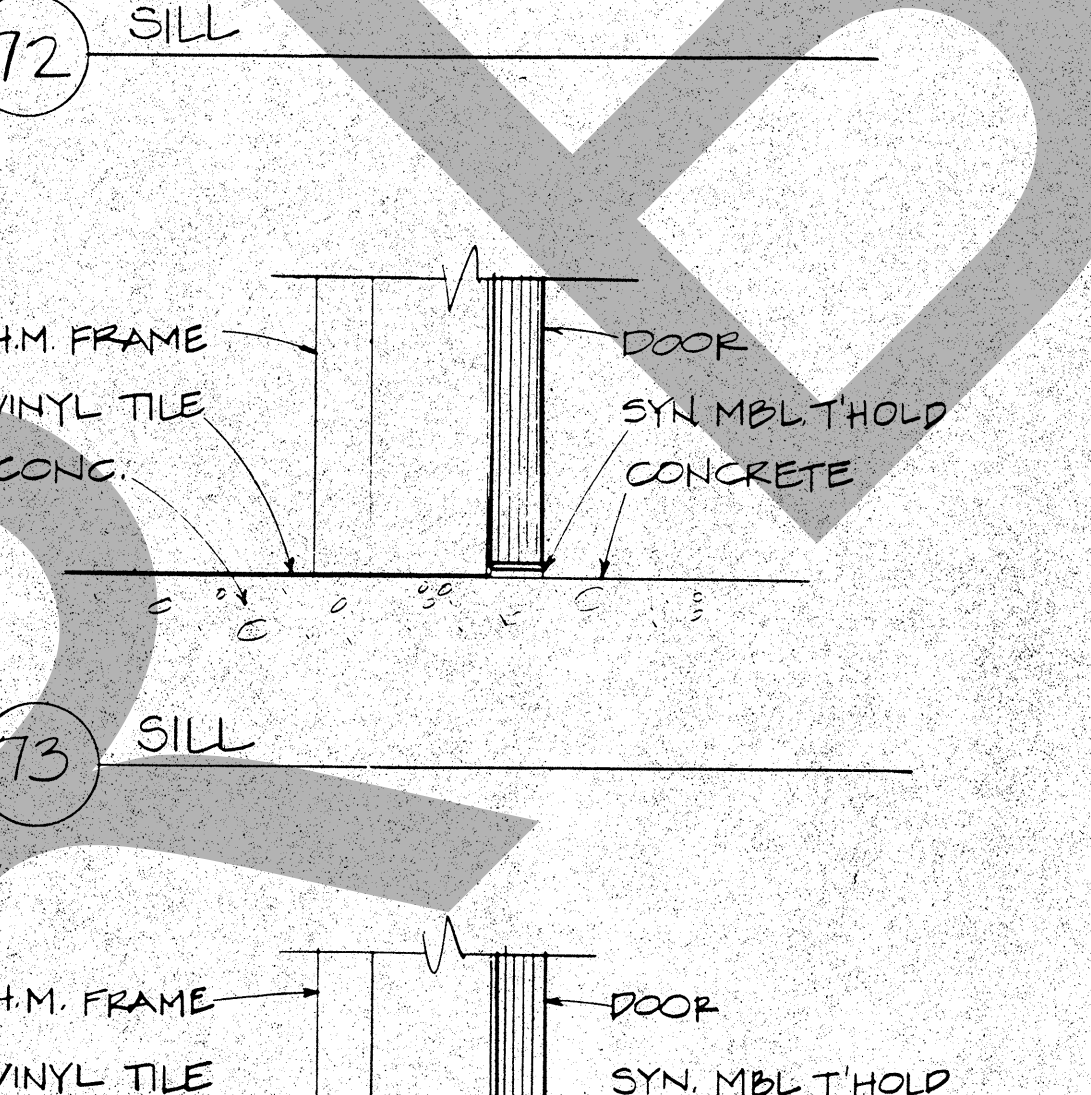


73 SILL

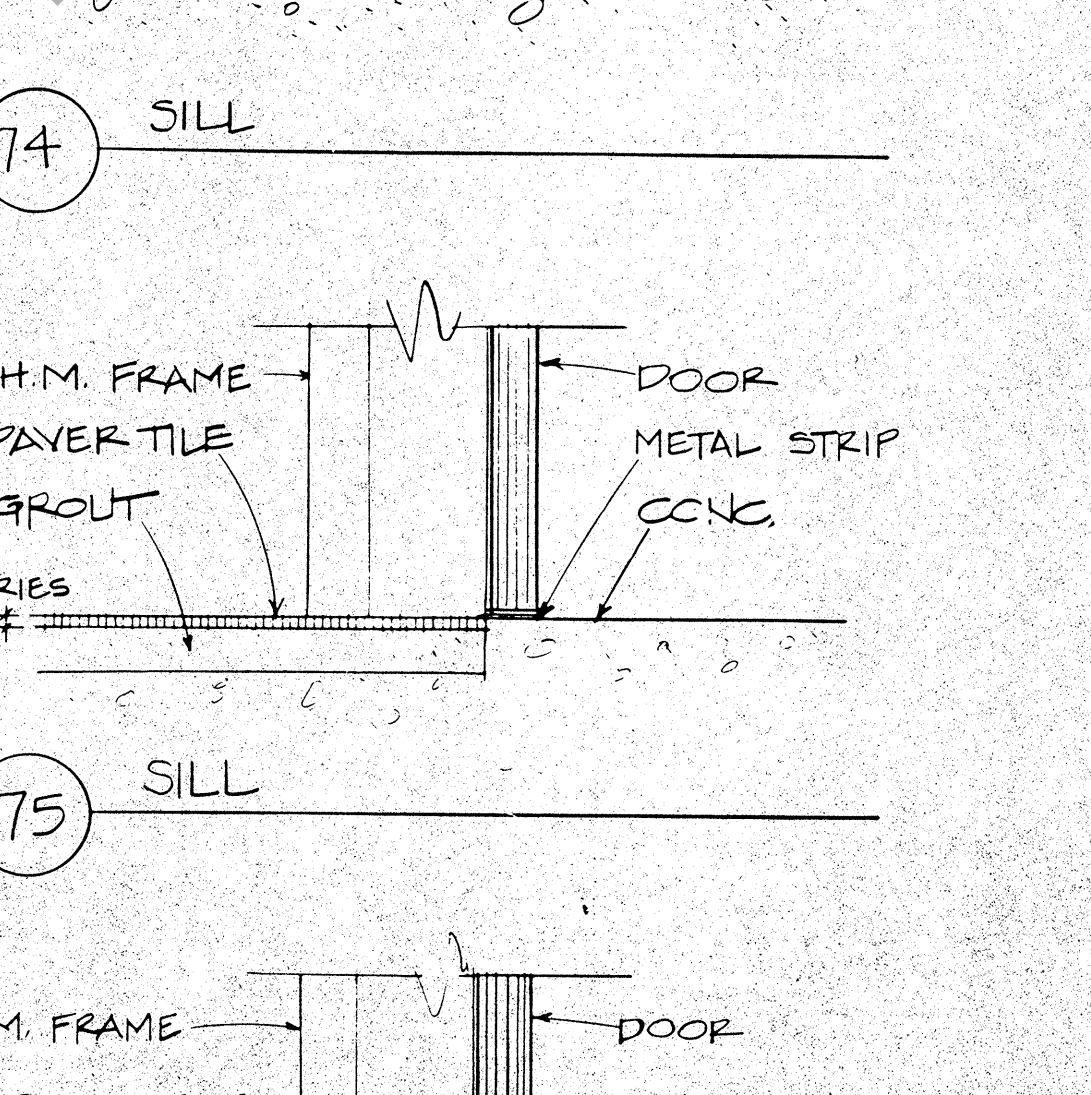


74 SILL

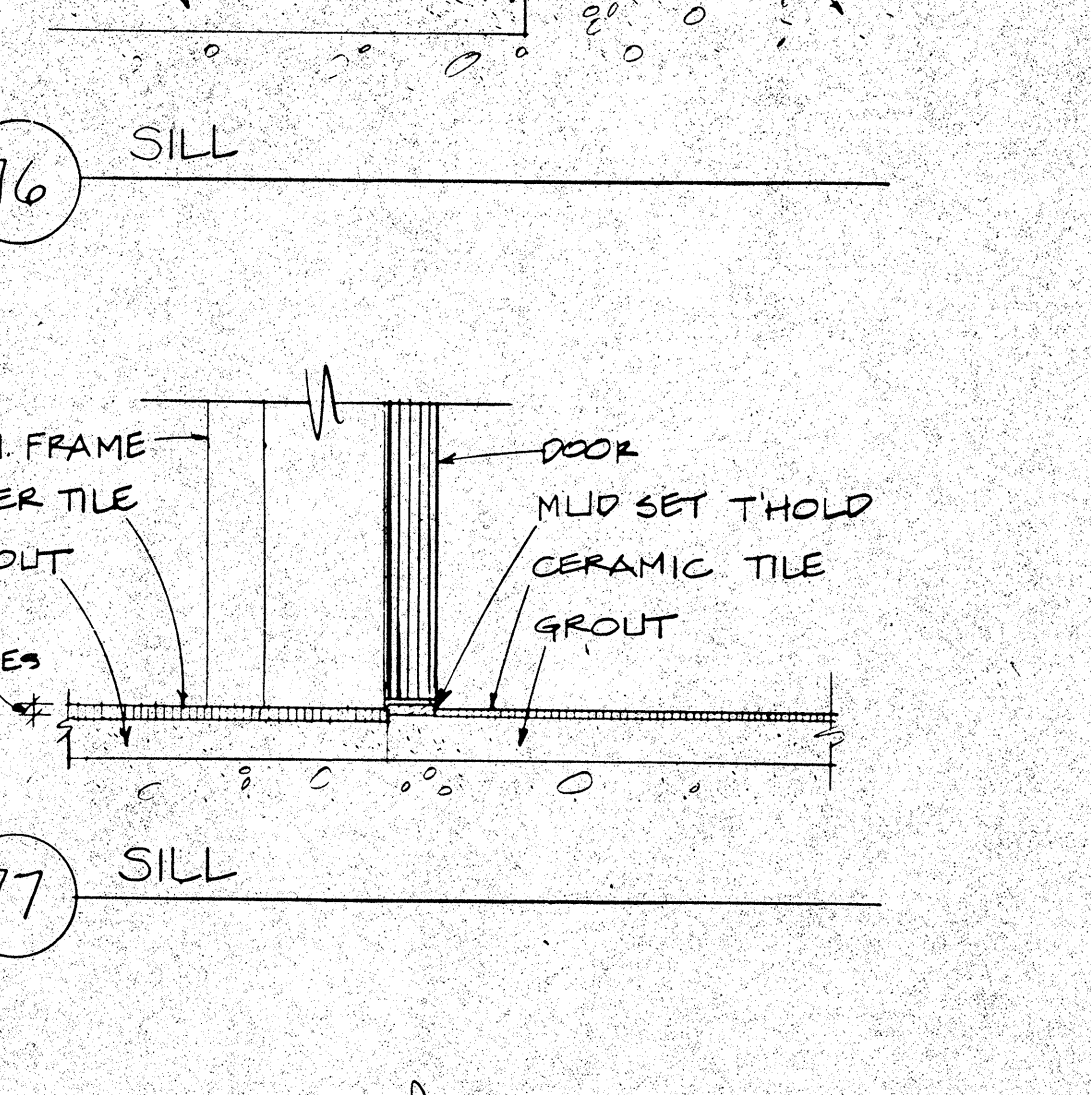


75 SILL

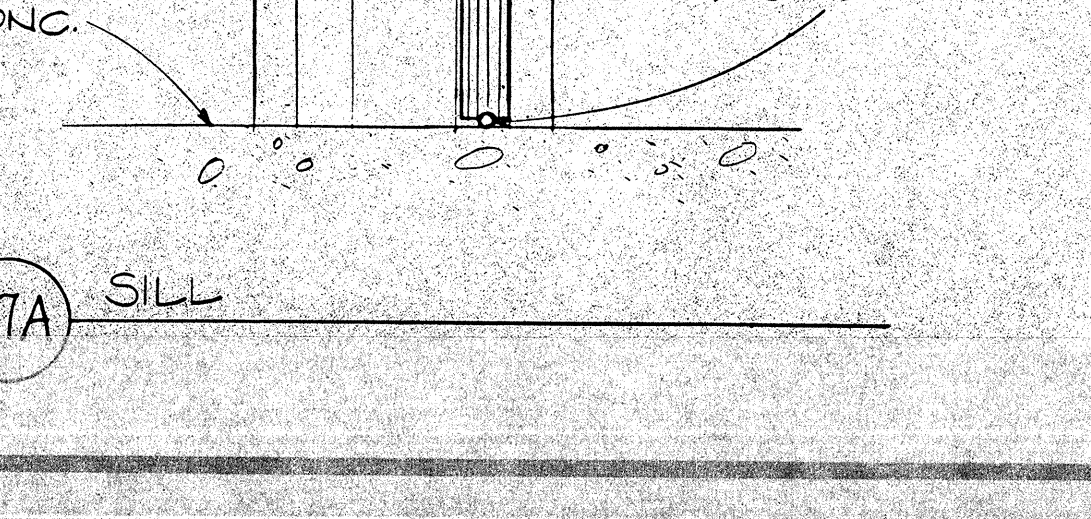


76 SILL

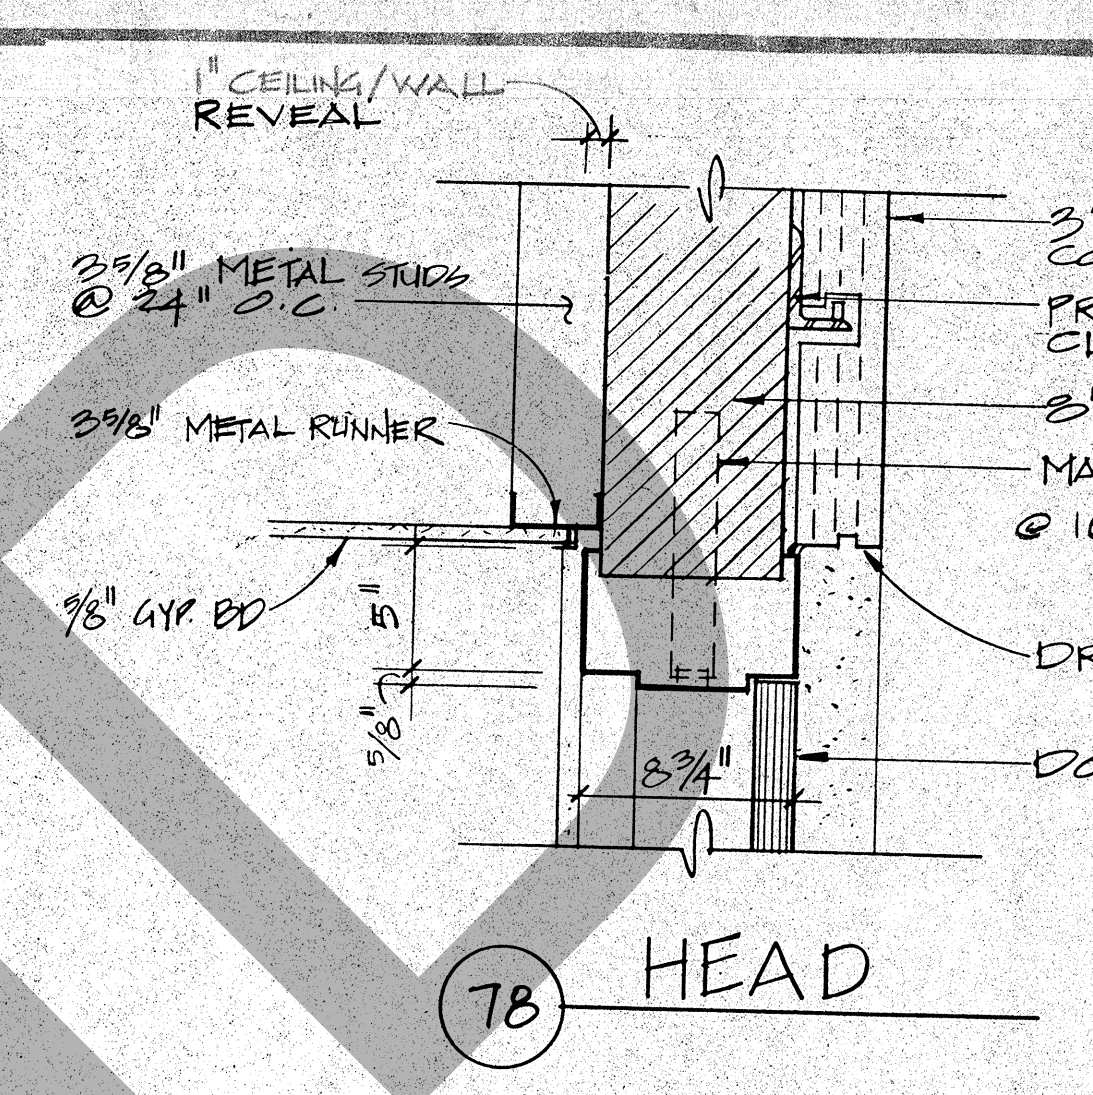


78 HEAD

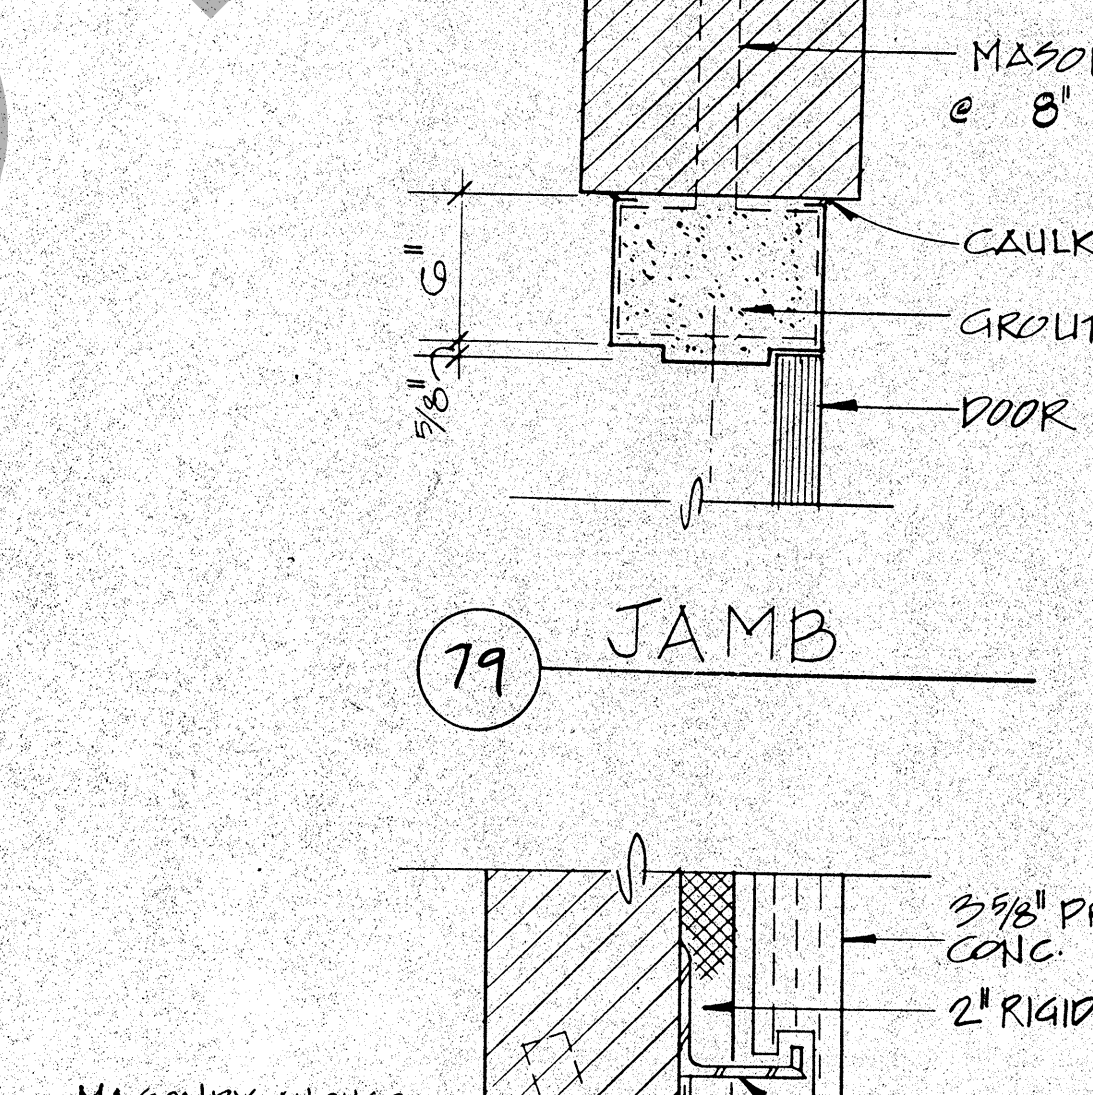


79 JAMB

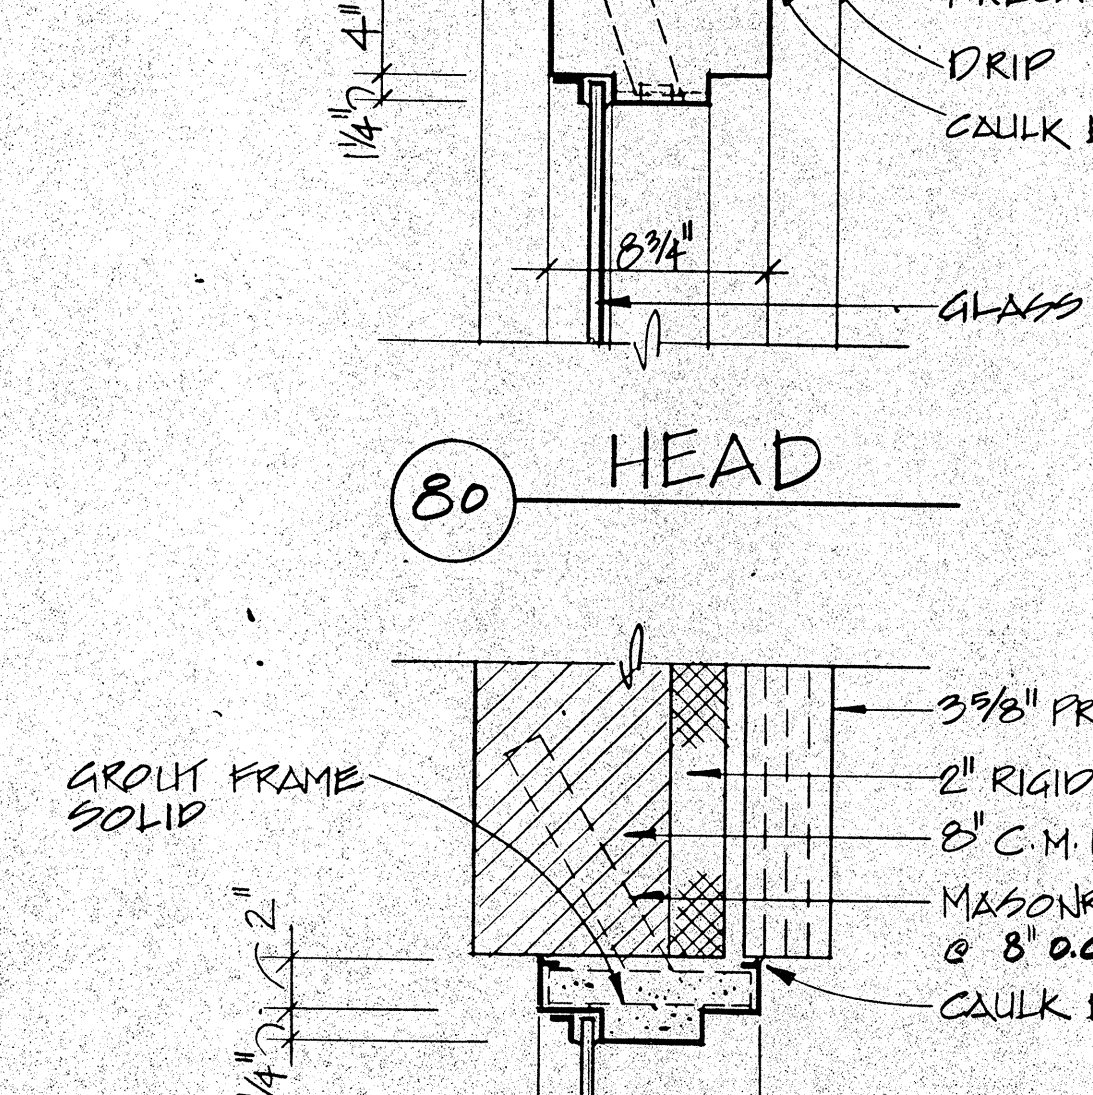

80 HEAD

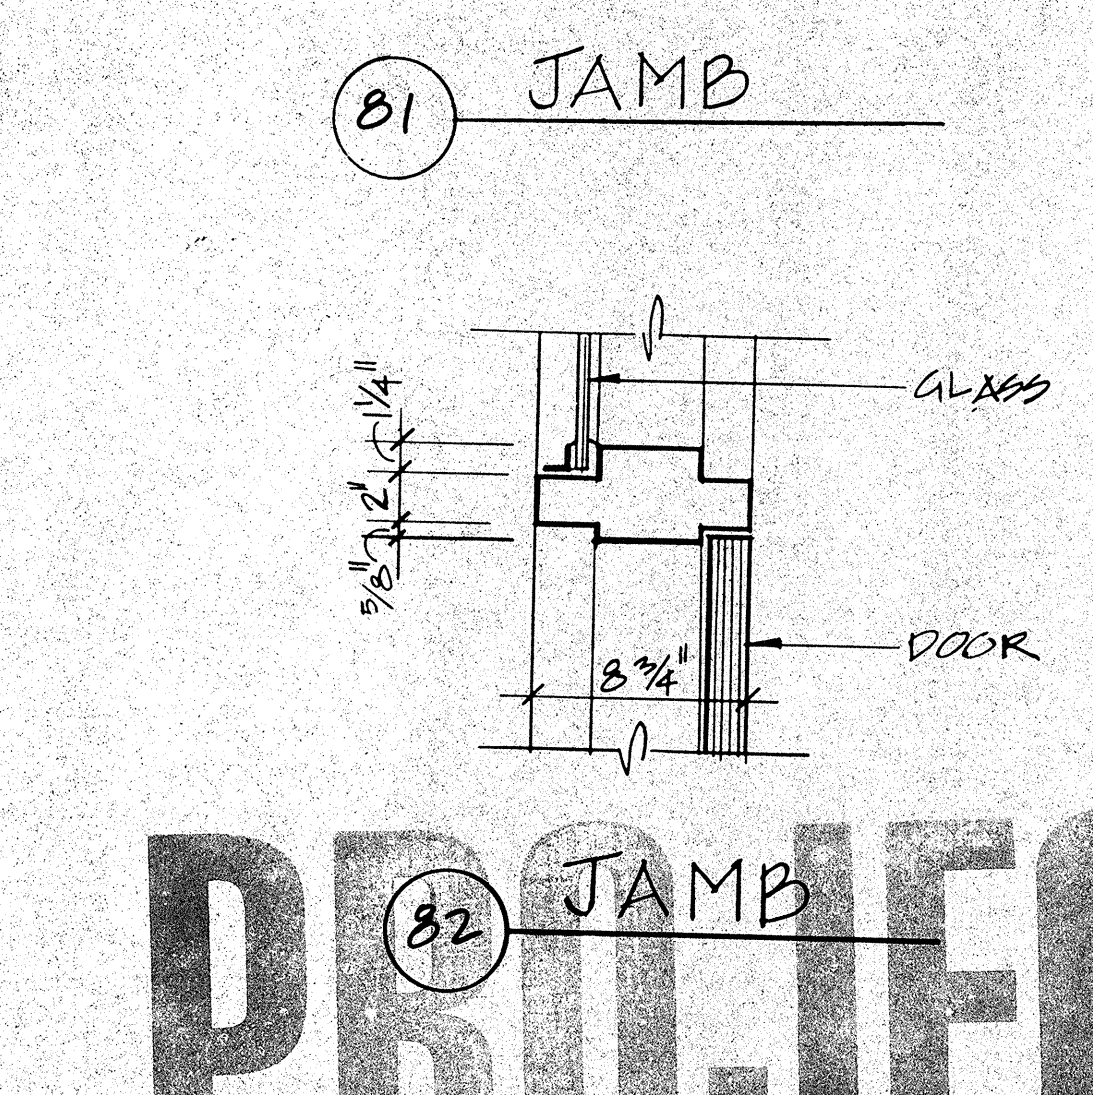

81 JAMB

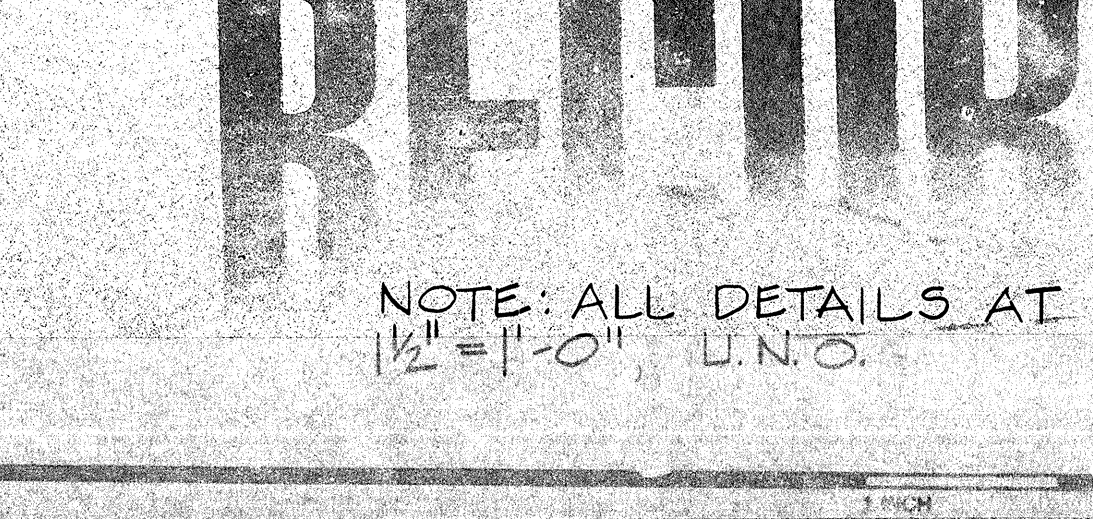

82 JAMB

PROJECT RECORD

NOTE: ALL DETAILS AT 1/2" = 1'-0" U.N.O.

ROSSER FABRAP INTERNATIONAL
Rosser Fabrap International, Inc.
Comprehensive Services for Building
Design and Technology
Atlanta Savannah

ROSSER FABRAP INTERNATIONAL
Criminal Justice Architecture, Technology, Planning, Interiors,
Mechanical, Electrical, Plumbing, Security, & Civil Engineering.

JUSTICE SYSTEMS INCORPORATED
Criminal Justice Operations, Programming
JOHNSON & NIELSEN
Structural Engineering

WEST - VALLEY - DETENTION - CENTER
FOR THE COUNTY OF SAN BERNARDINO, CALIFORNIA

HARRY WANS, COUNTY ADMINISTRATION OFFICER
FLOYD TIDWELL, SHERIFF
BOARD OF SUPERVISORS
John Wilson, Second District
Larry Walker, Fourth District
Doreen Williams, Fifth District

STATE OF CALIFORNIA
DAVID A. CLARK
REGISTERED ARCHITECT
No. C 01587

**HEAD/JAMB/SILL
DETAILS -
DOORS AND FRAMES**

Job No. 03099-04
Date 10-17-66
A 13.8