



MILLER

revisions/addenda

#	Date	Comment
---	------	---------

18313 VALLEY BLVD. BLOOMINGTON, CA 92313

SAN BERNARDINO COUNTY

project information

Project Number:	2200065
Drawn By:	Author
Checked By:	MB
Issue Date:	2/29/24


sheet name

CAT AND OTHER ENLARGED PLANS

sheet number

AD401

Sheet Of Sheets

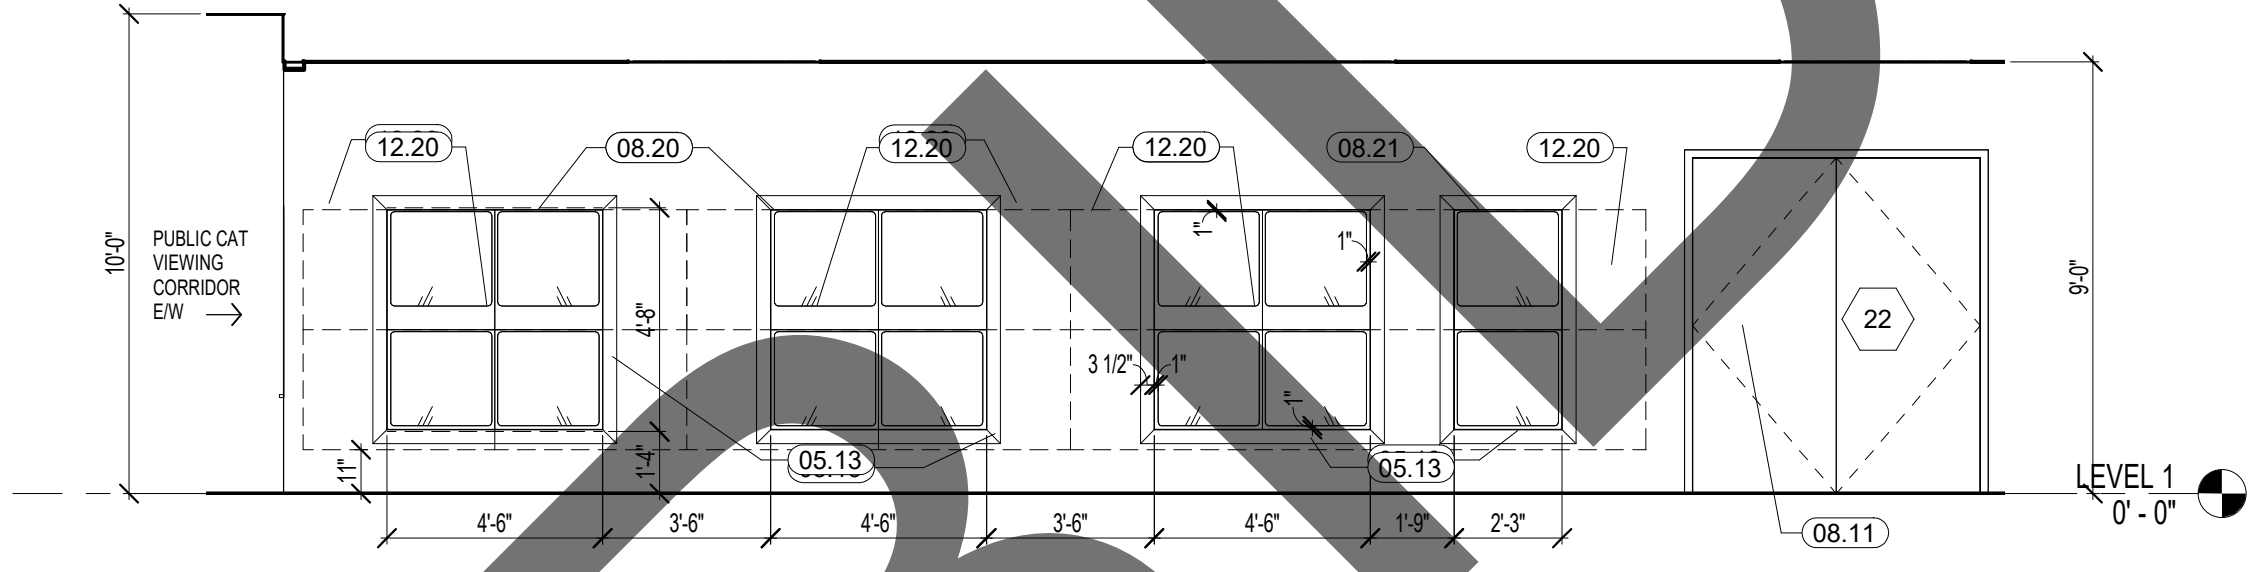

CAT VIEW WINDOW - PUBLIC VIEWING CORRIDOR E/W


SCALE
1/4" = 1'-0"

5

CAT VIEW WINDOW - PUBLIC VIEWING CORRIDOR N/S

SCALE
1/4" = 1'-0"

1

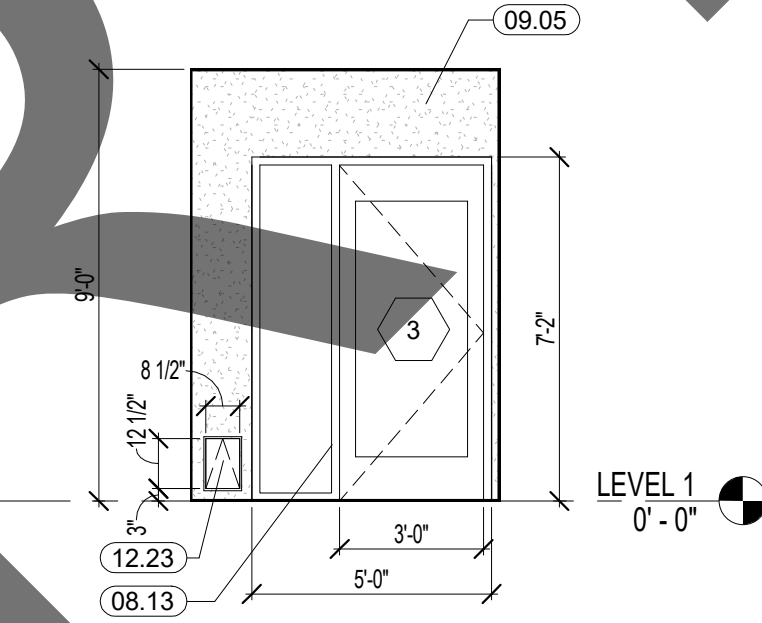

PREP COUNTER ANTE ROOM


SCALE
1/4" = 1'-0"

6

CAT SUN PORCH ELEVATION

SCALE
1/4" = 1'-0"


4

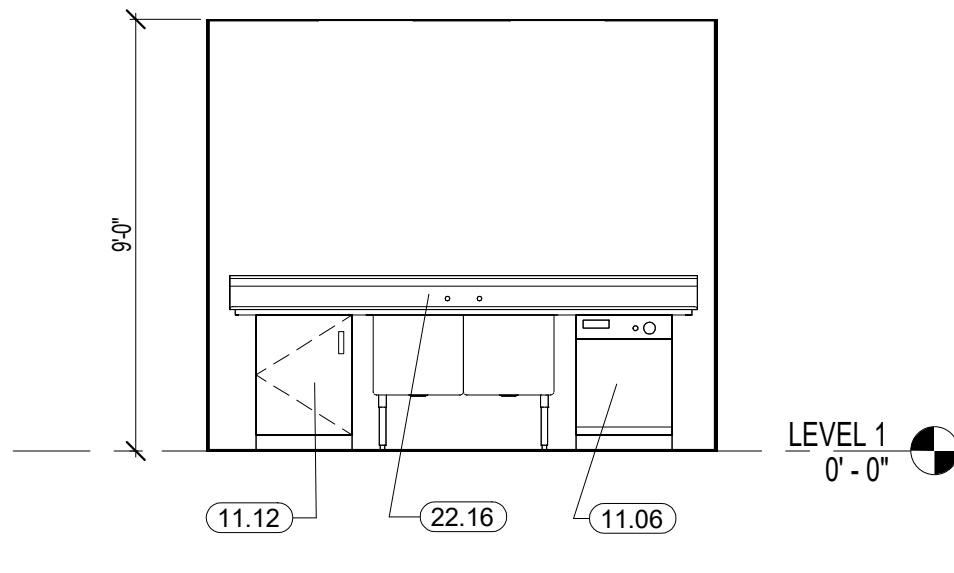

CAT KITCHEN

SCALE
1/4" = 1'-0"

2

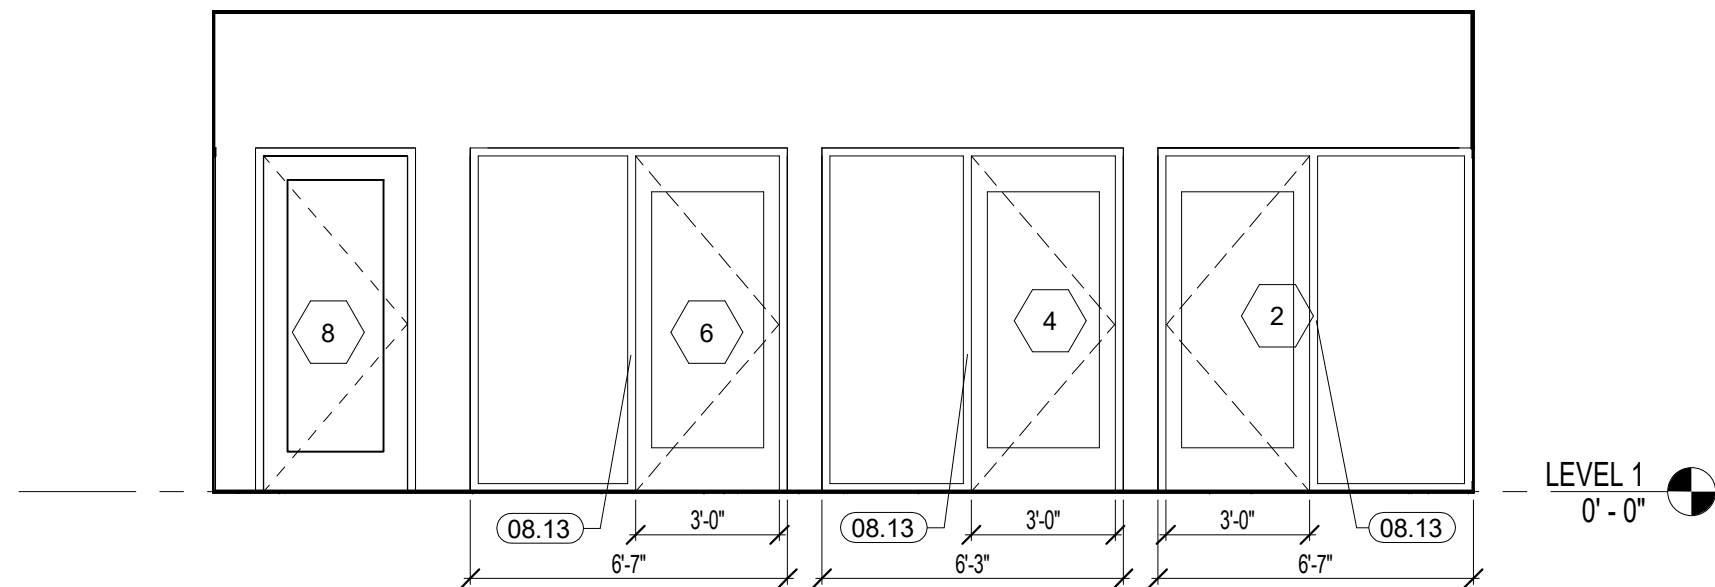

CAT COMMUNITY ROOMS ENTRANCE DOORS

SCALE
1/4" = 1'-0"

3

<u>KEYNOTE LEGEND</u>	
CSI #	KEYNOTE TEXT
05.13	1X4 Wood Trim per 4/AE7
08.11	Door
08.12	Window
08.13	Aluminum Storefront
08.20	4'-6" x 4'-8" Wall Opening. Coordinate with 4/AE7
08.21	2'-3" x 4'-8" Wall Opening. Coordinate with 4/AE7
09.05	7/8" Stucco
11.06	Dishwasher - See Animal Equipment Drawings
11.12	Undercounter Refrigerator
12.20	Cat Cage with View Window beyond wall opening
12.23	Cat Pet Door - See Animal Equipment Drawings
22.16	2 Compartment S.S. Sink - Tabco Model



1177 Idaho Street, Suite 200
Redlands, CA 92374
Phone: 909-335-7400
Fax: 909-335-7299
info@miller-aip.com



owner approval

initials	date	phase

REVISIONS/ADDENDA

#	Date	Comment
---	------	---------

ANIMAL CARE CENTER

18313 VALLEY BLVD. BLOOMINGTON, CA 92313

SAN BERNARDINO COUNTY

385 N. ARROWHEAD AVENUE
SAN BERNARDINO, CA 92415
PHONE: 1-888-818-8988

PROJECT INFORMATION

Project Number:	2200065
Drawn By:	Author
Checked By:	GWM
Issue Date:	2/29/24

SHEET NAME


CANOPY DETAILS

SHEET NUMBER

AD 402

Sheet Of Sheets

DOOR SCHEDULE															
DOOR NUMBER	TYPE	PAIR OR SINGL E	SIZE		DOOR		FRAME		DETAIL				HW GROUP	REMARKS	
			WIDTH	HEIGHT	FINISH	MATERIAL	FINISH	MATERIAL	HEAD	JAMB 1	JAMB 2	SILL			
1	A	S	3' - 0"	7' - 0"	F	AL/GL	F	AL	9/A-501	10/A-501					
2	A	S	3' - 0"	7' - 0"	F	AL/GL	F	AL	5/A-502	6/A-502	3/A-502				
3	A	S	3' - 0"	7' - 0"	F	AL/GL	F	AL	5/A-502	6/A-502	3/A-502				
4	A	S	3' - 0"	7' - 0"	F	AL/GL	F	AL	5/A-502	6/A-502	3/A-502				
5	A	S	3' - 0"	7' - 0"	F	AL/GL	F	AL	5/A-502	6/A-502	3/A-502				
6	A	S	3' - 0"	7' - 0"	F	AL/GL	F	AL	5/A-502	6/A-502	3/A-502				
7	A	S	3' - 0"	7' - 0"	F	AL/GL	F	AL	5/A-502	6/A-502	3/A-502				
8	A	S	3' - 0"	7' - 0"	F	AL/GL	F	AL	5/A-502	6/A-502	3/A-502				
9A	A	S	3' - 6"	7' - 0"	F	M	F	M	1/A-502	2/A-502	3/A-502				
9B	E	S	3' - 0"	7' - 0"	F	M	F	M	17/A-501	18/A-501					
10	D	S	3' - 0"	7' - 0"	SCF	WD	F	M	1/A-502	2/A-502					
11	B	S	3' - 0"	7' - 0"	F	M	F	M	17/A-501	18/A-501					
12	D	S	3' - 0"	7' - 0"	SCF	WD	F	M	1/A-502	2/A-502					
13	D	S	3' - 0"	7' - 0"	SCF	WD	F	M	1/A-502	2/A-502					
14	A	S	3' - 0"	7' - 0"	F	M	F	M	1/A-502	3/A-502					
15	A	S	3' - 0"	7' - 0"	SCF	WD	F	M	1/A-502	2/A-502					
16	A	S	3' - 0"	7' - 0"	SCF	WD	F	M	1/A-502	2/A-502					
17A	A	S	3' - 0"	7' - 0"	F	M	F	M	1/A-502	2/A-502					
17B	A	S	3' - 0"	7' - 0"	F	M	F	M	1/A-502	2/A-502					
18A	A	S	3' - 0"	7' - 0"	F	AL/GL	F	AL	5/A-502	6/A-502					
18B	B	S	3' - 0"	7' - 0"	F	AL/GL	F	AL	17/A-501	18/A-501					
19	A	S	3' - 0"	7' - 0"	F	AL/GL	F	AL	1/A-502	6/A-502	3/A-502				
20	A	S	3' - 0"	7' - 0"	F	AL/GL	F	AL	5/A-502	6/A-502	3/A-502				
21	A	S	3' - 0"	7' - 0"	F	AL/GL	F	AL	5/A-502	6/A-502	3/A-502				
22	C	P	6' - 0"	7' - 0"	F	M	F	M	1/A-502	3/A-502					
23	B	S	3' - 0"	7' - 0"	F	M	F	M	1/A-502	3/A-502					

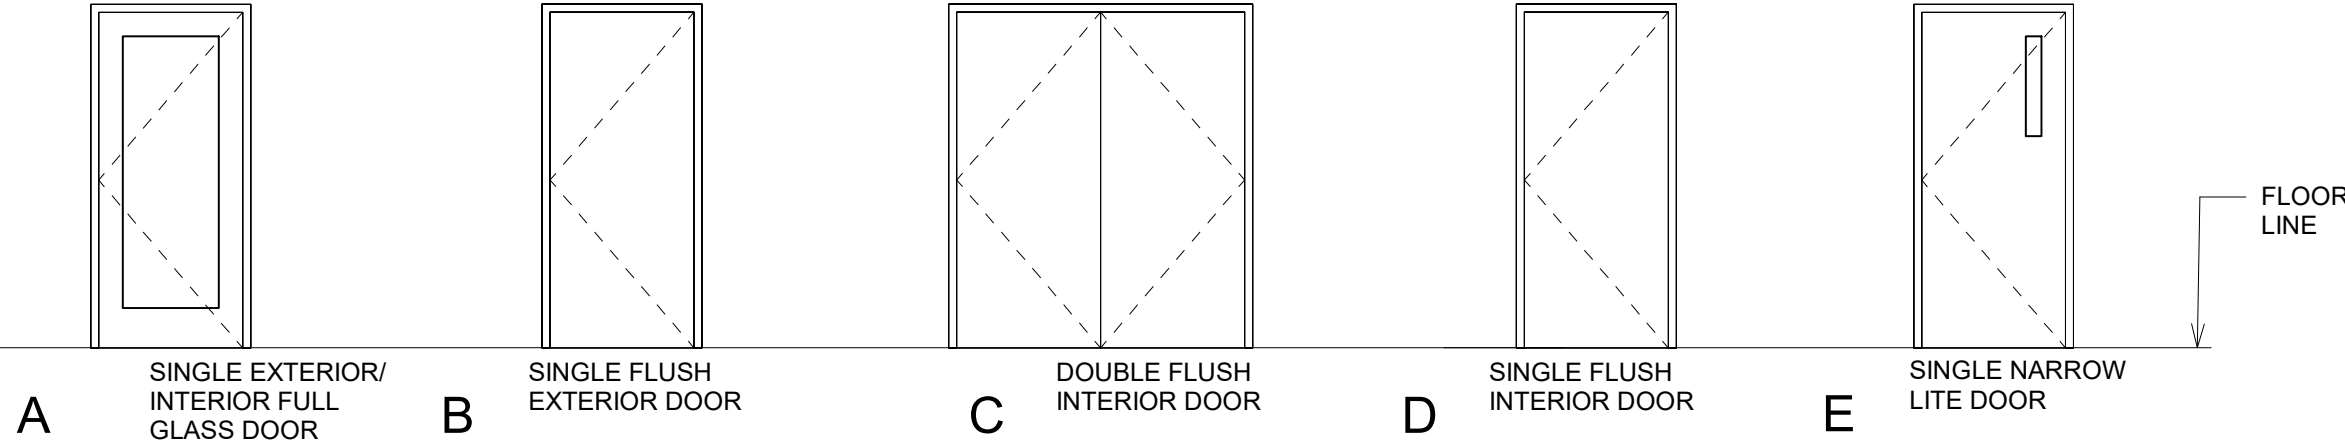

DOOR TYPES

Ⓣ TEMPERED GLAZING

DOOR GENERAL NOTES:

- EXIT DOORS SHALL BE OPERABLE FROM THE INSIDE WITHOUT THE USE OF A KEY OR SPECIAL KNOWLEDGE OR EFFORT.
- GLASS AND GLAZING SHALL COMPLY WITH CBC CHAPTER 24.
- MAXIMUM EFFORT TO OPERATE DOORS:
EXTERIOR - 5.0 LBS
INTERIOR - 5.0 LBS
- VERIFY ALL DOOR FRAME THROAT SIZES WITH FINISHED WALL THICKNESS PRIOR TO ORDERING FRAMES.
- ALL HAND ACTIVATED DOOR OPENING HARDWARE AT LATCHING OR LOCKING DOORS ON THE ACCESSIBLE PATH OF TRAVEL SHALL BE OPERABLE WITH SINGLE EFFORT LEVER TYPE HARDWARE, PANIC BARS, PUSH/PULL ACTIVATING BARS OR OTHER HARDWARE DESIGNED TO PROVIDE PASSAGE WITHOUT REQUIRING THE ABILITY TO GRASP THE HARDWARE.
- MAIN ENTRY DOOR SHALL BE PROVIDED WITH AN INDICATING FLAG LOCK AND REQUIRED DECAL ON HEADER STATING, "THIS DOOR TO REMAIN UNLOCKED WHEN THIS SPACE IS OCCUPIED PER CBC 1010.1.9.3
- FIRE DOORS SHALL BE LATCHED AN SELF OR AUTOMATIC-CLOSING IN ACCORDANCE WITH SECTION 716.2.6.1.
- CHUTE INTAKE DOORS SHALL BE POSITIVE LATCHING, REMAINING LATCHED AND CLOSED IN THE EVENT OF LATCH SPRING FAILURE DURING A FIRE EMERGENCY.
- ALL UNIT NUMBERS TO BE A MIN. OF 4" HIGH INSTALLED ON A CONTRASTING BACKGROUND.

DOOR SCHEDULE LEGEND:

DOOR:

MATERIAL
AL ALUMINUM
WD WOOD
M METAL
G GLASS

FINISH
SCF STAIN & CLEAR FINISH
P PAINT
F FACTORY APPLIED
T TEMPERED GLASS
E EXISTING FINISH

FRAME:

MATERIAL
AL ALUMINUM
HM HOLLOW METAL
M METAL
E EXISTING

FINISH
P PAINT
F FACTORY APPLIED
E EXISTING FINISH

REMARKS:

R1 ACCESSIBILITY SIGN
R2 PANIC DEVICE
R3 CARD READER
R4 METAL KICK PLATES
R5 PANIC DEVICE
R6 SMOKE GASKET
R7 WEATHERSTRIP
R8 CLOSER

FINISH SCHEDULE														
ROOM NUMBER	ROOM NAME	FLOOR	BASE	WALL FINISH				WAINSCOT FINISH				CEILING MATERIAL	CEILING HEIGHT	REMARKS
				A	B	C	D	A	B	C	D			
1	PUBLIC VIEWING CORRIDOR	F5	B4	W5	W5	W5	W5					C1	9' - 0"	
2	CAT COMM	F5	B3	W2	W2	W2	W2					C2	9' - 0"	
3	CAT SUN PORCH	F5	B4	W5	W5	W5	W5					C1	8' - 0"	
4	CAT COMM	F5	B3	W2	W2	W2	W2					C2	9' - 0"	
5	CAT SUN PORCH	F5	B4	W5	W5	W5	W5					C1	8' - 0"	
6	CAT COMM	F5	B3	W2	W2	W2	W2					C2	9' - 0"	
7	CAT SUN PORCH	F5	B4	W5	W5	W5	W5					C1	8' - 0"	
8	OTHER ANIMALS	F5	B4	W5	W5	W5	W5					C4	9' - 0"	
9	STAFF CORRIDOR	F5	B4	W5	W5	W5	W5					C1	9' - 0"	
10	KITCHEN	F5	B4	W5	W5	W5	W5					C1	9' - 0"	
11	ELECTRICAL	F4	B1	W5	W5	W5	W5					-	9' - 0"	
12	CLEANING EQUIP.	F4	B1	W5	W5	W5	W5					C2	9' - 0"	
13	FOOD & LITTER STORAGE	F4	B1	W5	W5	W5	W5					C2	9' - 0"	
14	ANTE ROOM	F5	B4	W5	W5	W5	W5					C2	9' - 0"	
15	STRICT MEDICAL ISOLATION	F5	B4	W5	W5	W5	W5					C2	9' - 0"	
16	MEDICAL ISOLATION	F5	B4	W5	W5	W5	W5					C2	9' - 0"	
17	FRACTIOUS CATS	F5	B4	W5	W5	W5	W5					C4	9' - 0"	
18	STRAY CATS	F5	B4	W5	W5	W5	W5					C4	9' - 0"	
19	GET ACQUAIANTED	F5	B4	W5	W5	W5	W5					C2	9' - 0"	
20	GET ACQUAIANTED	F5	B4	W5	W5	W5	W5					C2	9' - 0"	
21	ADOPTION CATS	F5	B4	W5	W5	W5	W5					C4	9' - 0"	
22	MDF	F3	B1	W5	W5	W5	W5					C2	11' - 0"	
23	FIRE RISER	F4	B1	W5	W5	W5	W5					-		

FLOOR MATERIAL:

F1 CARPET
F2 CERAMIC TILE
F3 VINYL TILE
F4 SEALED CONCRETE
F5 EPOXY

BASE MATERIAL:

B1 RUBBER COVE BASE
B2 CARPET
B3 CERAMIC TILE
B4 EPOXY RESIN COVED 4"
B5 PORCELAIN TIL

WALL MATERIAL:

W1 GYPSUM BOARD - TEXTURED AND PAINTED
W2 CERAMIC TILE
W3 EXPOSED FRAMING
W4 FRP
W5 2 LAYERS BLOCK FILLER AND EPOXY

CEILING:

C1 SUSPENDED ACOUSTICAL CEILING
C2 GYPSUM BOARD - TEXTURED AND PAINTED
C3 EXPOSED FRAMING
C4 CERAMIC GUARD ACOUSTICAL CEILING


REMARKS:

R1 X
R2 X
R3 X
R4 X
R5 X
R6 X

GENERAL NOTES:

- INTERIOR FINISH MATERIALS SHALL COMPLY WITH 2022 CBC CHAPTER 12
- WATER RESISTANT GYPSUM BOARD COMPLYING WITH 2022 CBC SECTION 2509 TO BE USED IN TOILET ROOMS.
- GYPSUM BOARD TO BE 5/8" TYPE "X" UNLESS NOTED OTHERWISE.

WINDOW SCHEDULE													
MARK	WINDOW TYPE	SIZE		GLAZING	FRAME		FIRE RATING	DETAILS				REMARKS	
		WIDTH	HEIGHT		MATERIAL	FINISH		HEAD	JAMB 1	JAMB 2	SILL		
D1	A	4' - 0"	4' - 0"	3	AL	F		9/A-502	10/A-502				
D2	B	3' - 0"	4' - 0"	3	AL	F		9/A-502	10/A-502				
D2	C	2' - 6"	4' - 0"	3	AL	F		9/A-502	10/A-502				
D4	D	2' - 0"	4' - 0"	3	AL	F		9/A-502	10/A-502				
D5	E	2' - 0"	4' - 0"	1,3	AL	F		9/A-502	10/A-502				

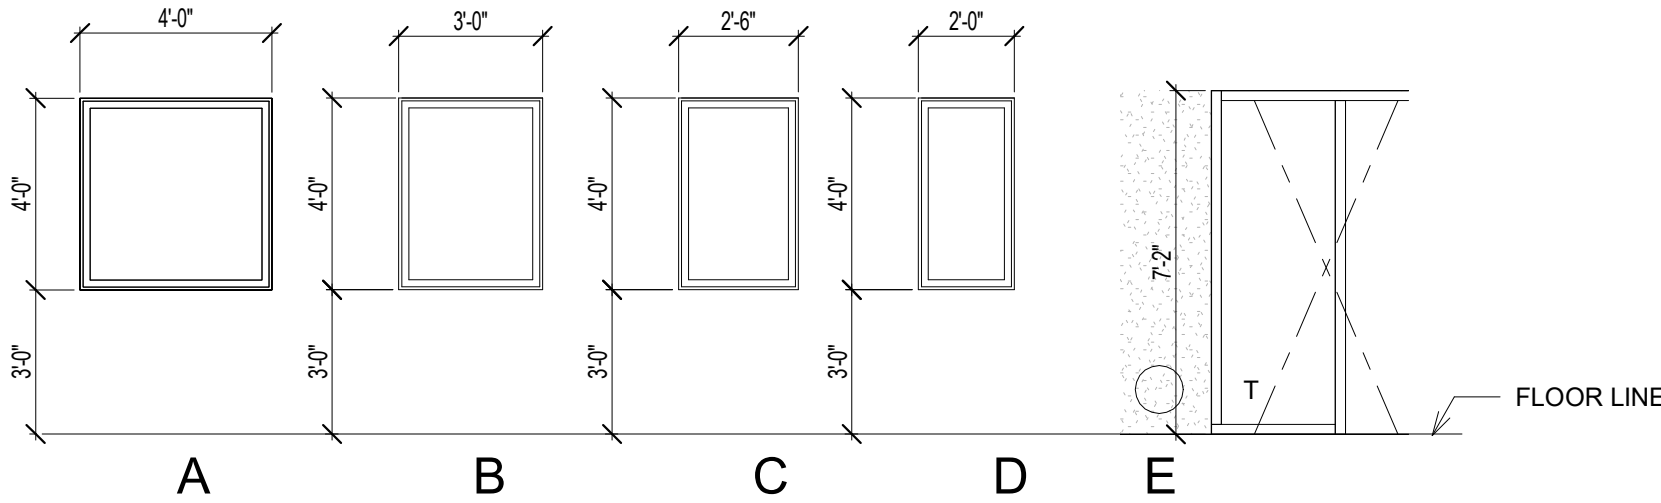

WINDOW TYPES

Ⓣ TEMPERED GLAZING

1/4" = 1'-0"

WINDOW

GLAZING:

- TEMPERED GLASS
- WIRE GLASS
- DUAL GLAZING
- SINGLE GLAZING
- FIRE PROTECTION RATED GLAZING

FRAME

MATERIAL:
AL ALUMINUM
HM HOLLOW METAL
E EXISTING
VL VINYL FRAME MATERIAL


FINISH:
P PAINTED
F FACTORY APPLIED
E EXISTING FINISH

STOREFRONT NOTES:

- Ⓣ DENOTES TEMPERED GLASS
- Ⓣ10 CUSTOM WINDOW SEE WINDOW SCHEDULE
- 1 PRE-MANUFACTURED WINDOWS SEE WINDOW SCHEDULE


GLAZING NOTES

- ALL EXTERIOR GLAZING TO COMPLY WITH THE FOLLOWING TITLE 24 REQUIREMENTS:
A. U-FACTOR: 0.00
B. SHGC: 0.00
C. VT: 0.00
- ALL EXTERIOSOLARBAN 70XL SOLEXIA 1-INCH INSULATED LOW-E VITRO OR EQUAL

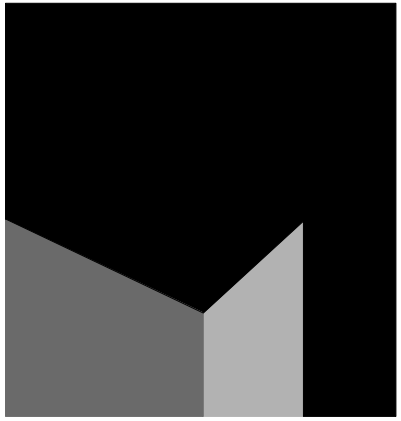

architecture
interiors
planning

1177 Idaho Street, Suite 200
Redlands, CA 92374
Phone: 909-335-7400
Fax: 909-335-7299
info@miller-aip.com

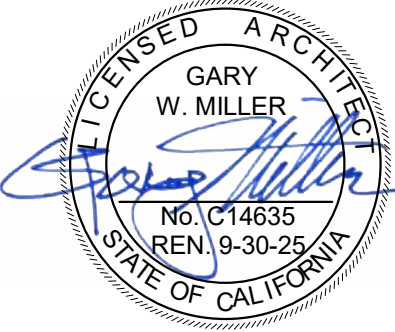

owner approval

initials	date	phase

REVISIONS/ADDENDA

Date Comment

ANIMAL CARE CENTER

18313 VALLEY BLVD. BLOOMINGTON, CA 92313

SAN BERNARDINO COUNTY

385 N. ARROWHEAD AVENUE
SAN BERNARDINO, CA 92415
PHONE: 1-888-818-8968

PROJECT INFORMATION

Project Number: 2200065
Drawn By: Author
Checked By: GWM
Issue Date: 2/29/24

SHEET NAME



DOOR &
WINDOW
SCHEDULE

SHEET NUMBER

AD 601

Sheet Of Sheets

ADOPTION DOG BUILDINGS AE - AH.1 LAYOUT PLAN

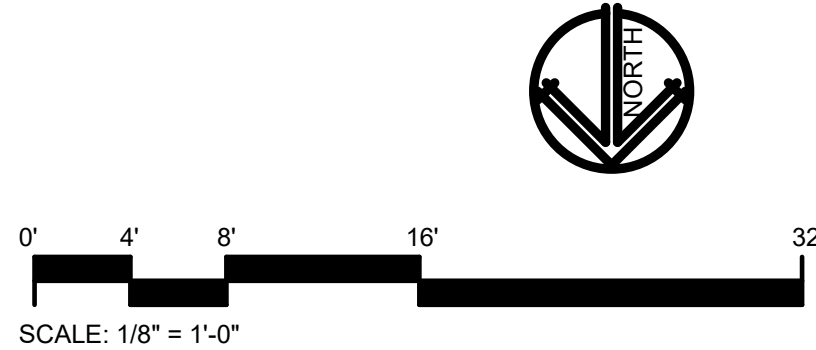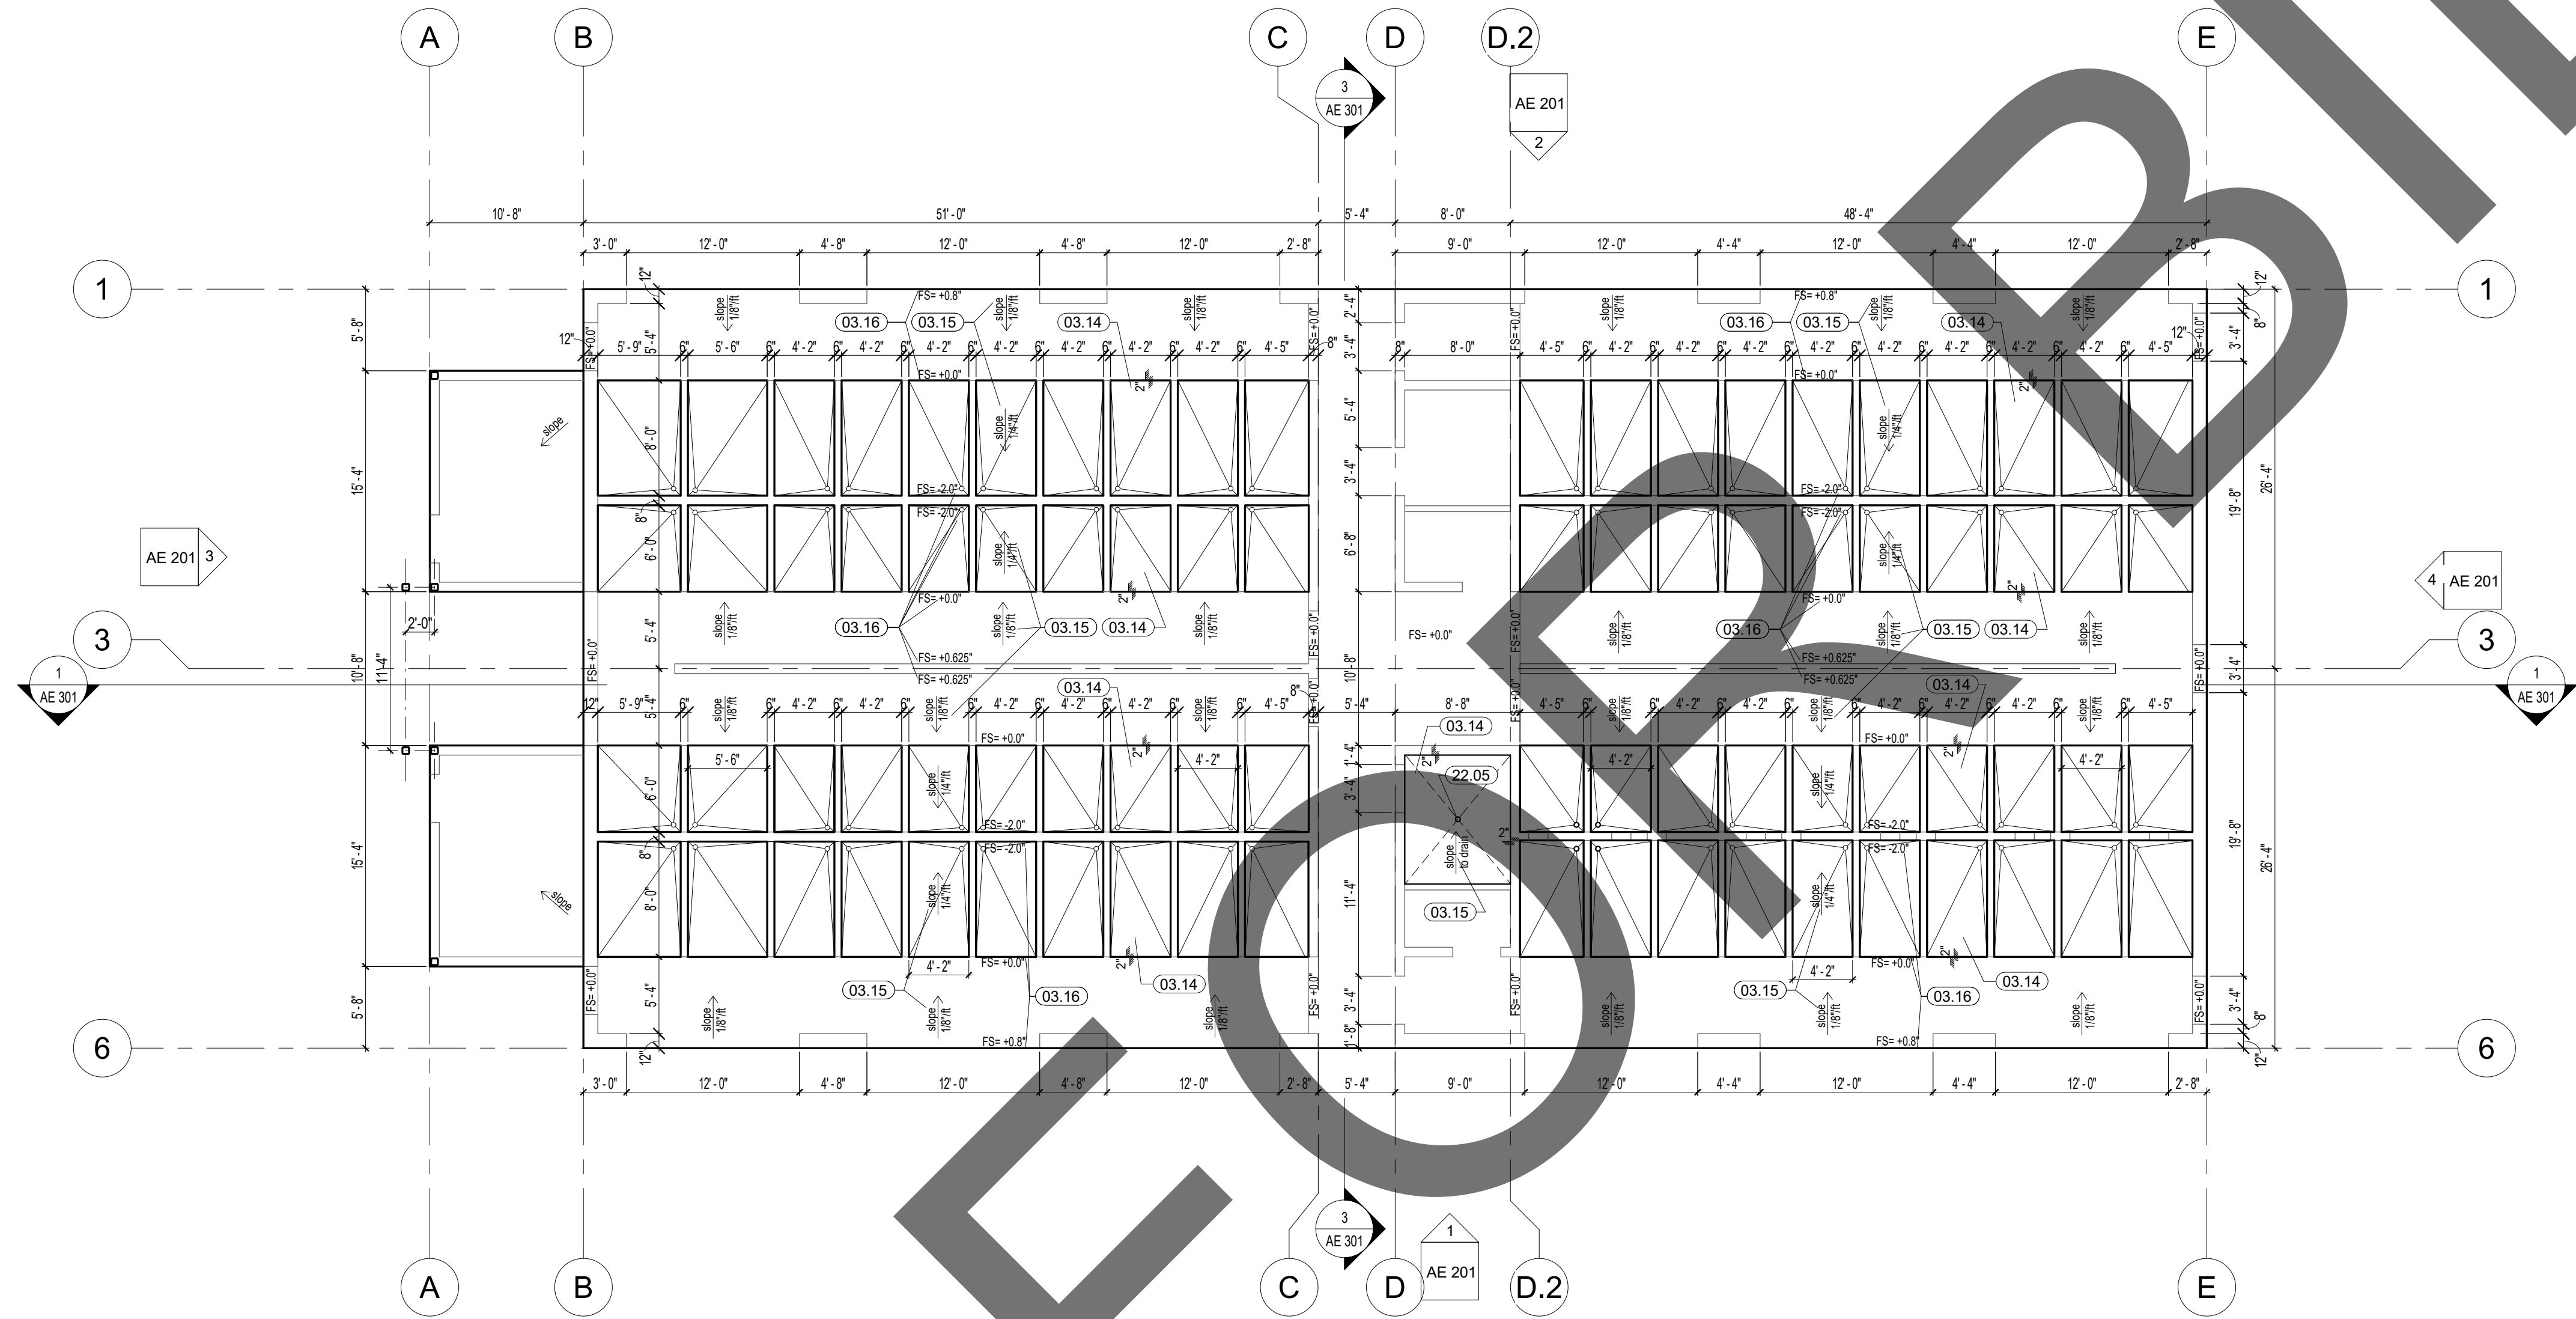

GENERAL LAYOUT PLAN NOTES:

- COORDINATE UNDERSLAB WASTE LINE DRAINS WITH PLUMBING DRAWINGS.
- COORDINATE FOUNDATION PLAN AND FOOTING DETAILS WITH STRUCTURAL DRAWINGS.
- COORDINATE UNDERSLAB POWER AND DATA REQUIREMENTS, CONDUIT ETC. WITH ELECTRICAL DRAWINGS.
- PROVIDE DEPRESSED SLAB AND SLOPES AS INDICATED ON DRAWING.

KEYNOTE LEGEND


CSI #	KEYNOTE TEXT
03.14	Depress Slab as Shown
03.15	Slope Indicates Final Slab Finish
03.16	Finish Surface Spot Elevation
22.05	Floor Drain - See Plumbing Drawings

GENERAL - LAYOUT PLAN NOTES

SCALE
12" = 1'-0"



1177 Idaho Street, Suite 200
Redlands, CA 92374
Phone: 909-335-7400
Fax: 909-335-7299
info@miller-aip.com

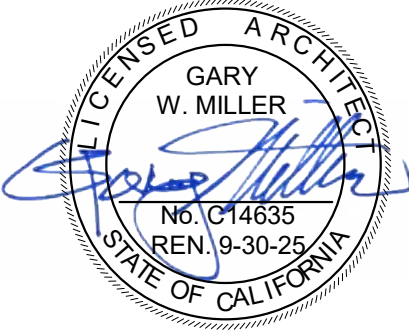

owner approval

initials	date	phase

REVISIONS/ADDENDA

#	Date	Comment
---	------	---------

ANIMAL CARE CENTER

18313 VALLEY BLVD. BLOOMINGTON, CA 92313

SAN BERNARDINO COUNTY

385 N. ARROWHEAD AVENUE
SAN BERNARDINO, CA 92415
PHONE: 1-888-818-8988

PROJECT INFORMATION

Project Number:	2200065
Drawn By:	Author
Checked By:	GWM
Issue Date:	2/29/24

SHEET NAME

AE - AH.1
LAYOUT PLAN

SHEET NUMBER

AE100

Sheet Of Sheets



**1177 Idaho Street, Suite 200
Redlands, CA 92374
Phone: 909-335-7400
Fax: 909-335-7299
info@miller-aip.com**



initials	date	phase

#	Date	Comment
---	------	---------


385 N. ARROWHEAD AVENUE
SAN BERNARDINO, CA 92415
PHONE: 1-888-818-8988

Project Number:	2200065
Drawn By:	PF
Checked By:	GWM
Issue Date:	2/29/24

ADOPTION DOG
BUILD. DIM.
FLOOR PLAN

AE101

Sheet Of Sheets

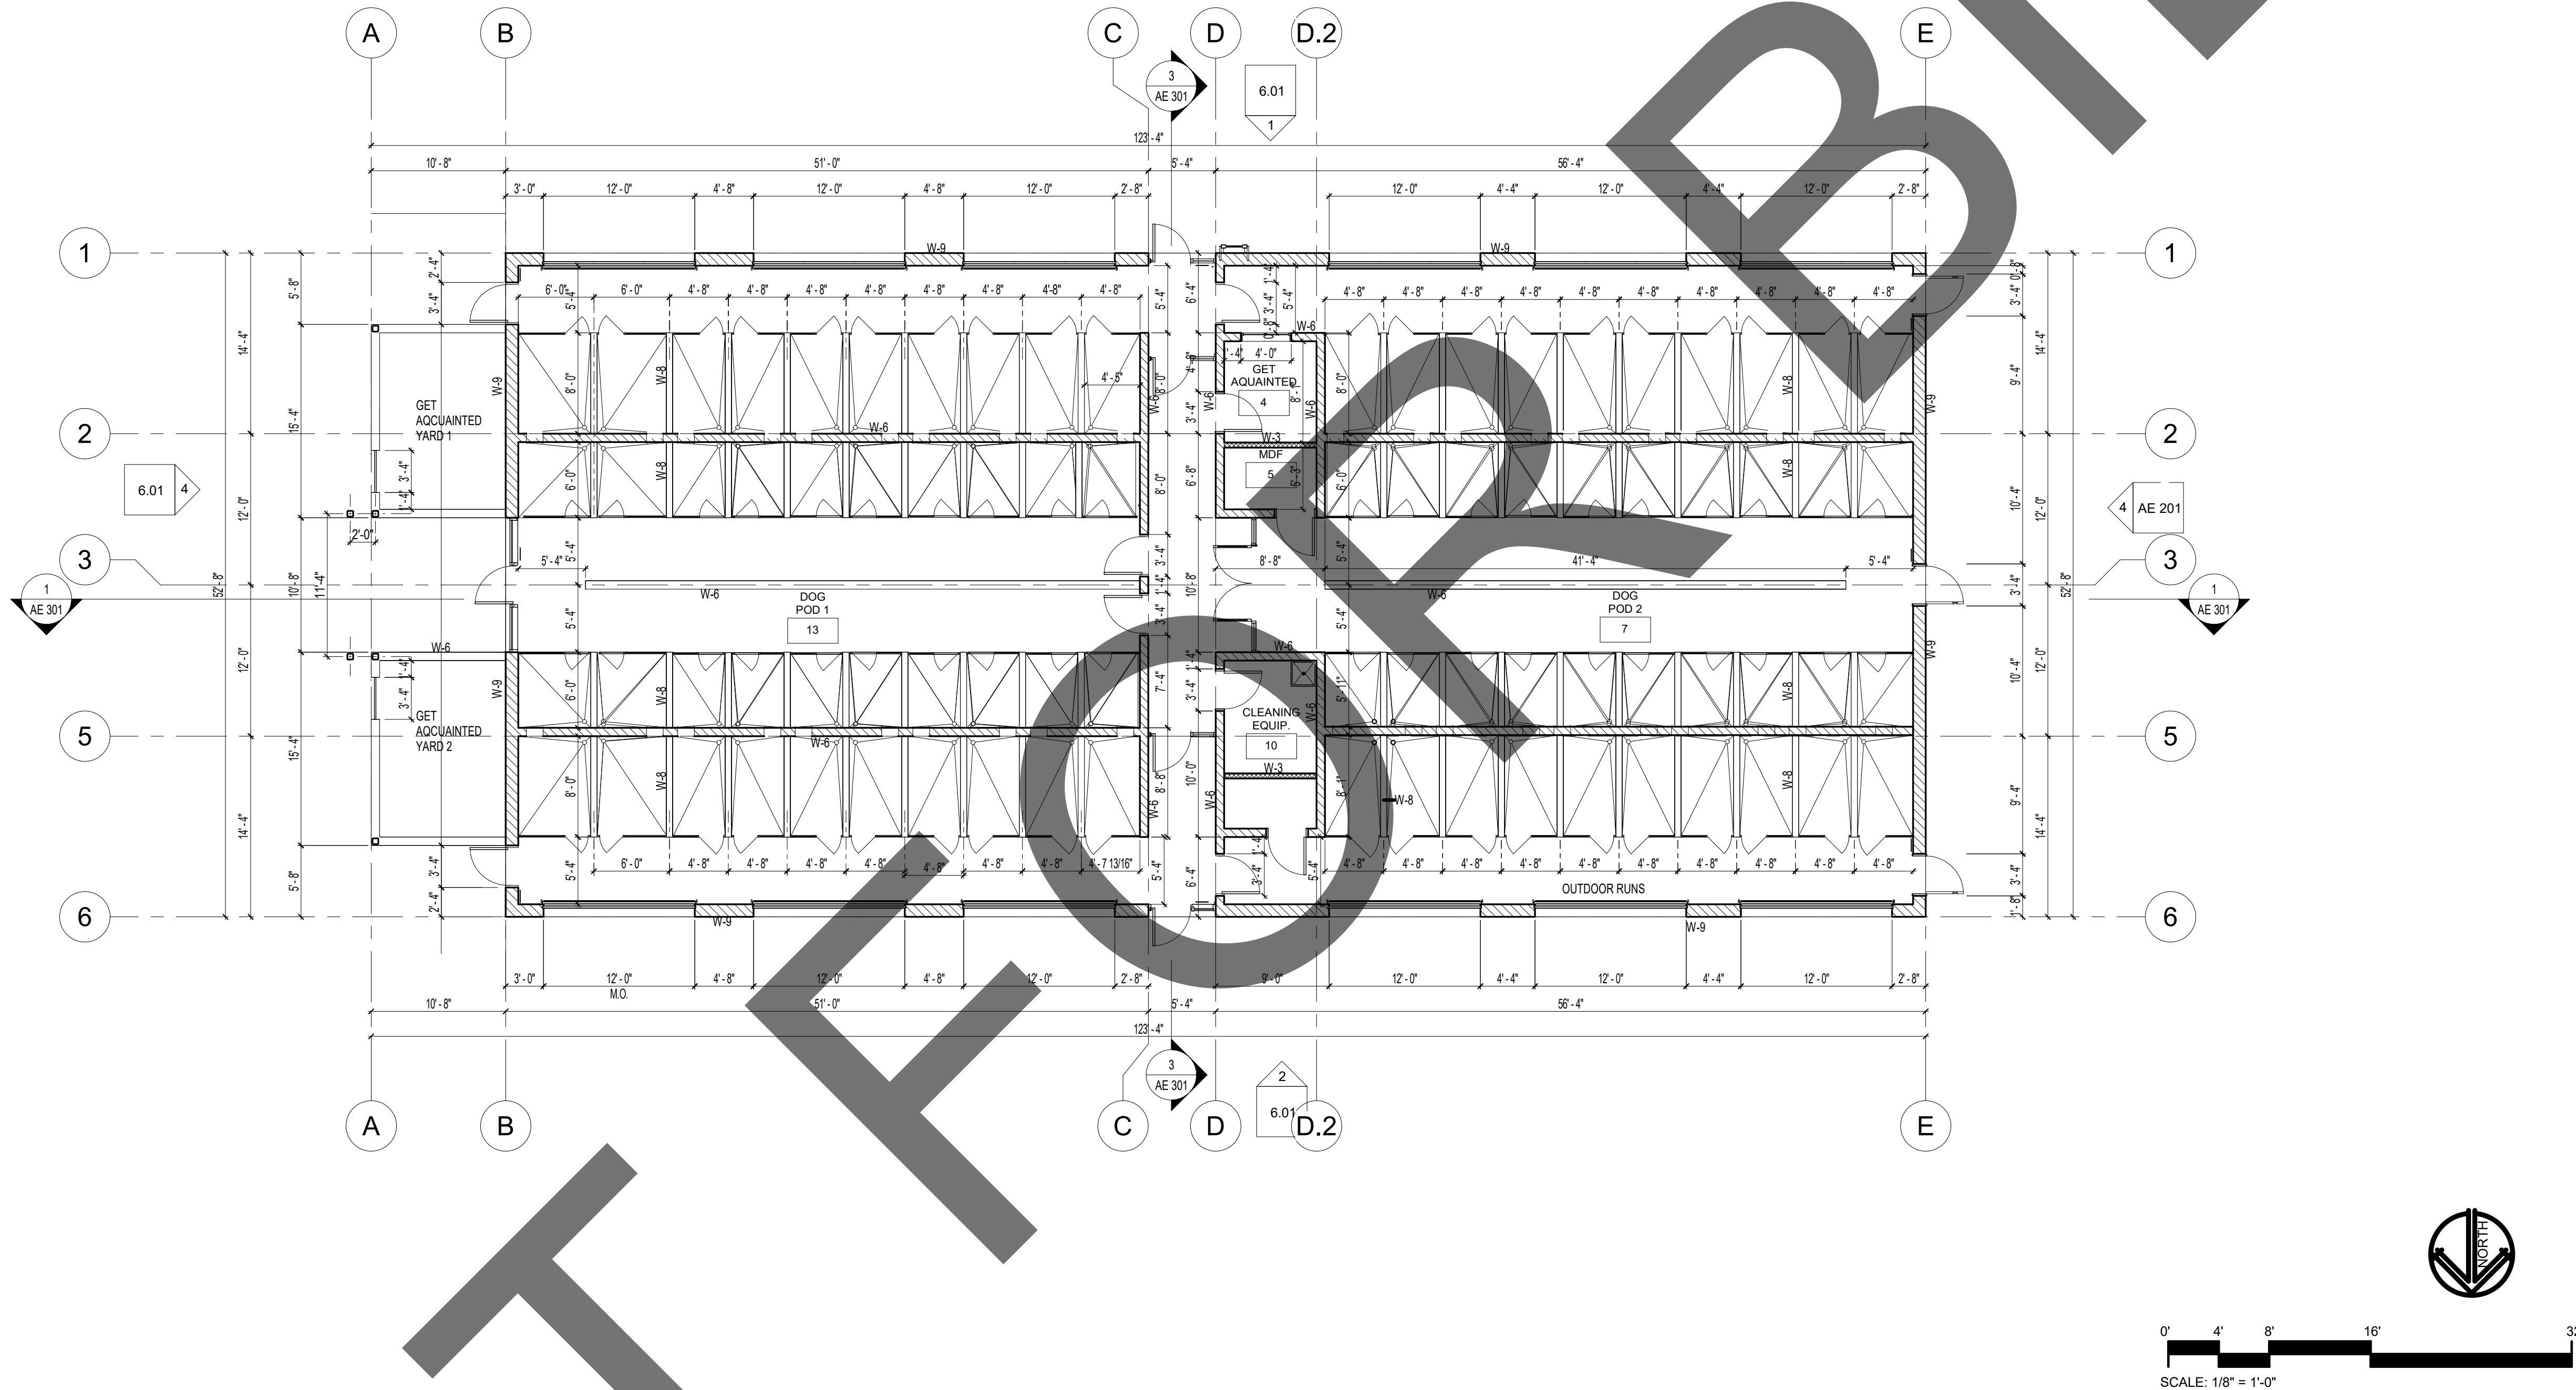

FLOOR PLAN - ADOPTION DOG BUILDING 5, 6, & 7

1. QUANTITIES LISTED ON THESE DOCUMENTS ARE FOR AGENCY APPROVAL. ONLY THE CONTRACTOR IS RESPONSIBLE FOR VERIFYING ALL QUANTITIES FOR BIDDING PURPOSES.
2. FINISH: PREPARE SUB-FLOOR AND LEAVE IN BROOM CLEAN CONDITION TO RECEIVE NEW FINISH AS REQUIRED. FLOOR SHALL BE LEVEL AND FREE OF DIPS, DIMPLES AND JOINTS.
3. REFER TO MECHANICAL, ELECTRICAL, AND PLUMBING DRAWINGS FOR ADDITIONAL SCOPE.

 STEEL STUDS PER SCHEDULE
 CMU MASONRY UNIT
 LOW CMU WALL

W-1 6" STEEL STUDS @ 16" O.C. W/ R-19 BATT, R-14 RIGID INSULATION & TRESPA EXT.

W-2 6" STEEL STUDS @ 16" O.C. W/ R-19 BATT, R-14 RIGID INSULATION & STUCCO EXT.

W-3 4" STEEL STUDS @ 24" O.C. GYP. BD. BOTH SIDES

W-4 4" STEEL STUDS @ 16" O.C. GYP. BD. BOTH SIDES

W-5 6" STEEL STUDS @ 16" O.C. w/ 5/8" GYP. BD. BOTH SIDES

W-6 8" MASONRY CMU BLOCK

W-7 6" STEEL STUDS, SPACING PER STRUCTURAL, FINISH PER ELEVATIONS

W-8 6" MASONRY CMU BLOCK

W-9 12" MASONRY CMU BLOCK

GENERAL - FLOOR PLAN NOTES

SCALE


12" = 1'-0"

WALL TYPE SCHEDULE

SCALE

1/4" = 1'-0"

FLOOR PLAN - ADOPTION DOG BUILDING 5, 6, & 7

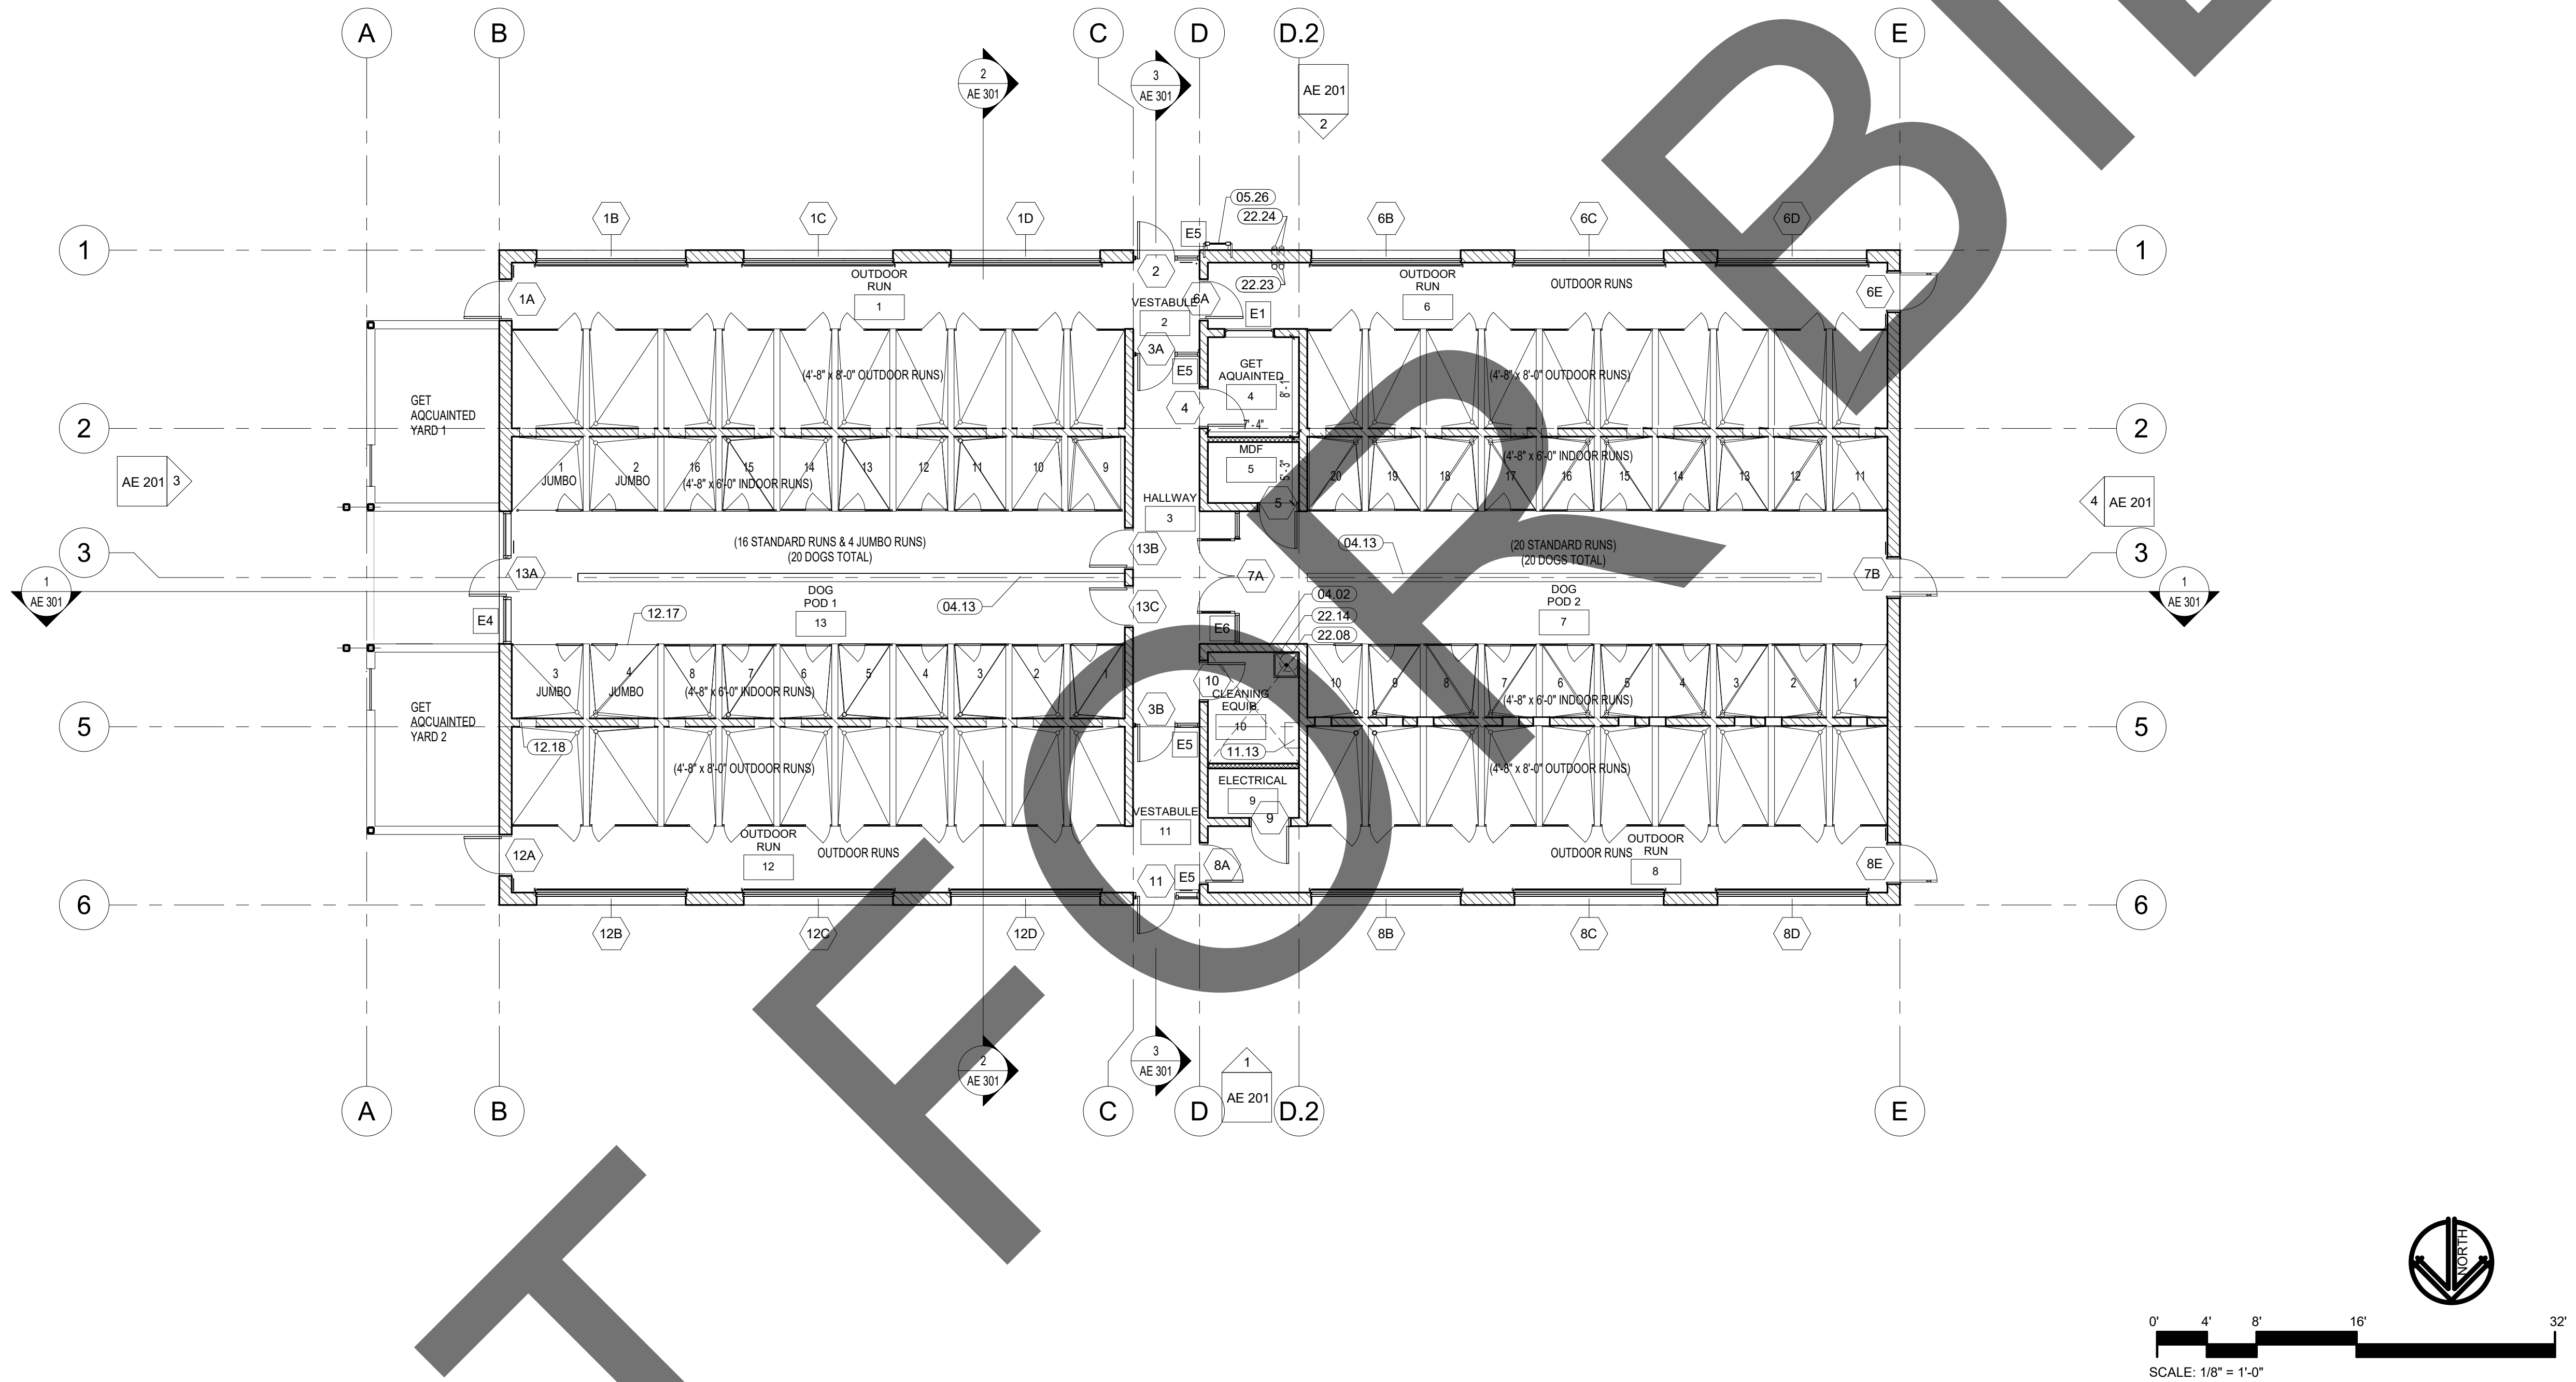

GENERAL FLOOR PLAN NOTES:

- QUANTITIES LISTED ON THESE DOCUMENTS ARE FOR AGENCY APPROVAL ONLY. THE CONTRACTOR IS RESPONSIBLE FOR VERIFYING ALL QUANTITIES FOR BIDDING PURPOSES.
- FINISH: PREPARE SUB-FLOOR AND LEAVE IN BROOM CLEAN CONDITION TO RECEIVE NEW FINISH AS REQUIRED. FLOOR SHALL BE LEVEL AND FREE OF DIPS, DIMPLES AND JOINTS.
- REFER TO MECHANICAL, ELECTRICAL, AND PLUMBING DRAWINGS FOR ADDITIONAL SCOPE.

WALL TYPE LEGEND

- STEEL STUDS PER SCHEDULE
- CMU MASONRY UNIT
- LOW CMU WALL

WALL TYPE SCHEDULE

- W-1 6" STEEL STUDS @ 16" O.C. W/ R-19 BATT, R-14 RIGID INSULATION & TRESPA EXT.
- W-2 6" STEEL STUDS @ 16" O.C. W/ R-19 BATT, R-14 RIGID INSULATION & STUCCO EXT.
- W-3 4" STEEL STUDS @ 24" O.C. GYP. BD. BOTH SIDES
- W-4 4" STEEL STUDS @ 16" O.C. GYP. BD. BOTH SIDES
- W-5 6" STEEL STUDS @ 16" O.C. w/ 5/8" GYP. BD. BOTH SIDES
- W-6 8" MASONRY CMU BLOCK
- W-7 6" STEEL STUDS, SPACING PER STRUCTURAL, FINISH PER ELVATIONS
- W-8 6" MASONRY CMU BLOCK
- W-9 12" MASONRY CMU BLOCK

KEYNOTE LEGEND

CSI #	KEYNOTE TEXT
04.02	CMU Wall
04.13	Bark Wall Per 7/AE8
05.26	Steel Roof Ladder
11.13	Pressure Wash Sytem - See Animal Equipment Drawings
12.17	Dog Kenneling - See Animal Equipment Drawings
12.18	Transfer Guillotine Door - See Animal Equipment Drawings
22.08	Water Heater Mounted on Shelf 6'-6" Above Finished Floor
22.14	Mop Sink
22.23	Roof Drain Leader
22.24	Roof Drain Outlet

GENERAL - FLOOR PLAN NOTES

SCALE
1/2" = 1'-0"

WALL TYPE SCHEDULE

SCALE
1/4" = 1'-0"



owner approval

initials	date	phase

REVISIONS/ADDENDA

#	Date	Comment
---	------	---------

ANIMAL CARE CENTER

18313 VALLEY BLVD. BLOOMINGTON, CA 92313

SAN BERNARDINO COUNTY

385 N. ARROWHEAD AVENUE
SAN BERNARDINO, CA 92415
PHONE: 1-888-818-8988

PROJECT INFORMATION

Project Number:	2200065
Drawn By:	Author
Checked By:	GWM
Issue Date:	2/29/24

SHEET NAME

ADOPTION DOG
BUILD. ANNOT.
FLOOR PLAN

SHEET NUMBER

AE102

Sheet Of Sheets



**1177 Idaho Street, Suite 200
Redlands, CA 92374
Phone: 909-335-7400
Fax: 909-335-7299
info@miller-aip.com**



owner approval

initials	date	phase

REVISIONS/ADDENDA

#	Date	Comment
---	------	---------

ANIMAL CARE CENTER

18313 VALLEY BLVD. BLOOMINGTON, CA 92313

SAN BERNARDINO COUNTY

385 N. ARROWHEAD AVENUE
SAN BERNARDINO, CA 92415
PHONE: 1-888-818-8988

PROJECT INFORMATION

Project Number:	2200065
Drawn By:	Author
Checked By:	GWM
Issue Date:	2/29/24


SHEET NAME

ADOPTION DOG
BUILDING RCP

SHEET NUMBER

AE 103

Sheet Of Sheets

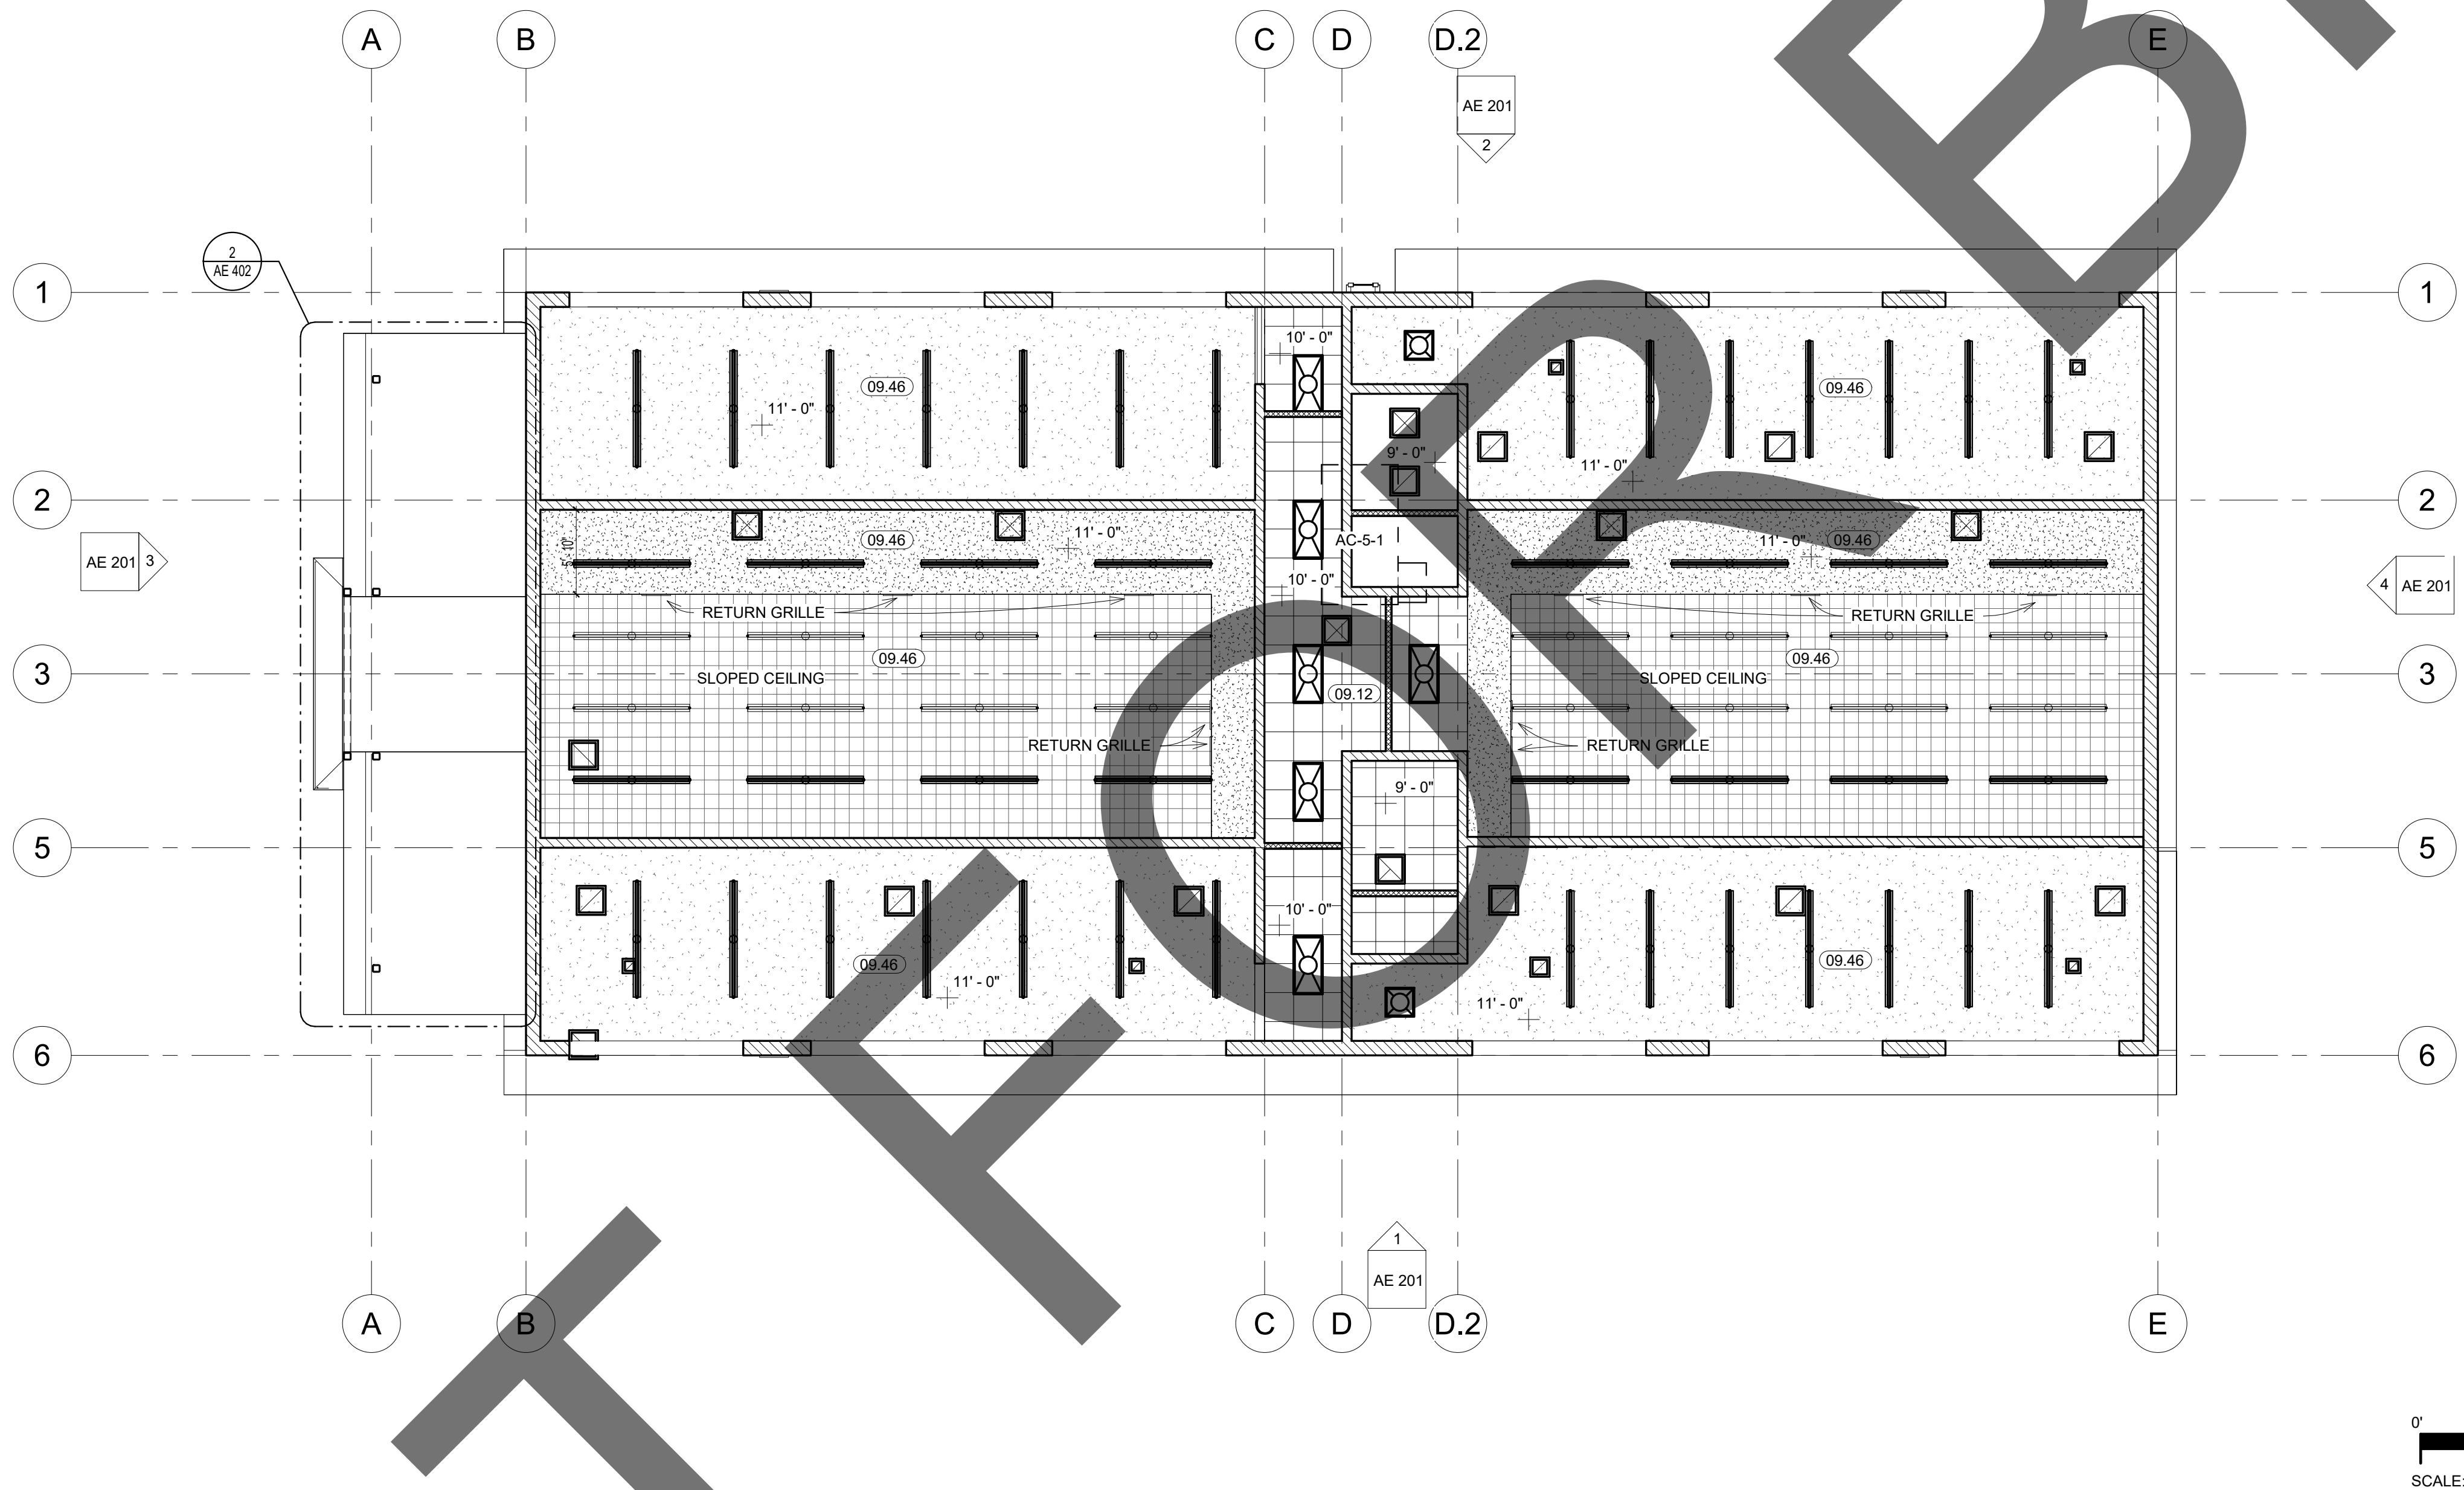

1ST RCF

SCALE	1
1/8" = 1'-0"	

REFLECTED CEILING PLAN LEGEND:

	2x2 ACT SUSPENDED CEILING
	GYPSUM BOARD CEILING
	ARMSTRONG CERAMAGARD W/ ALUM. GRID
	CEMENT BOARD CEILING PAINTED
	PENDANT LIGHT FIXTURE. SEE ELECTRICAL
	RECESSED LIGHT FIXTURE. SEE ELECTRICAL
	SURFACE MOUNTED LIGHT FIXTURE. SEE ELECTRICAL
	EXIT SIGN. SEE ELECTRICAL DRAWINGS.
	EXHAUST. SEE ELECTRICAL DRAWINGS.
	SUPPLY / RETURN GRILLE. SEE MECHANICAL
0'-0" +	CEILING HEIGHT


REFLECTED CEILING PLAN NOTES:

1. QUANTITIES LISTED ON THESE DOCUMENTS ARE FOR AGENCY APPROVAL ONLY. THE CONTRACTOR IS RESPONSIBLE FOR VERIFYING ALL QUANTITIES FOR BIDDING PURPOSES.
2. ALL NEW WORK SHALL CONFORM TO CURRENT BUILDING STANDARDS, UNLESS NOTED OTHERWISE.
3. CONTRACTOR TO VERIFY EXISTING CONSTRUCTION WITHIN THE SCOPE OF WORK TO ENSURE CONFORMANCE WITH ALL NOTED RATINGS AND LOCAL CODES. RETROFIT NON-CONFORMING CONSTRUCTION AS REQUIRED.
4. SUSPENSION SYSTEM TO BE "PRELUDE XL" AS MANUFACTURED BY ARMSTRONG WORLD INDUSTRIES, INC. OR EQUAL AS APPROVED BY ARCHITECT.
5. PERIODIC INSPECTION OF THE CEILING SUSPENSION SYSTEM SHALL BE PROVIDED IN ACCORDANCE WITH MANUFACTURER'S REQUIREMENTS FOR SPECIFIED COMPONENTS AND CEILING ANCHORAGE SYSTEM.
6. REFER TO MECHANICAL, ELECTRICAL, AND PLUMBING DRAWINGS FOR ADDITIONAL SCOPE.

KEYNOTE LEGEND


CSI #	KEYNOTE TEXT
09.12	Suspended Ceiling w/ Acoustical Panels
09.46	Cement Board Ceiling

CEILING LEGEND	SCALE	GENERAL - RCP NOTES	SCALE				
	1/8" = 1'-0"		12" = 1'-0"				

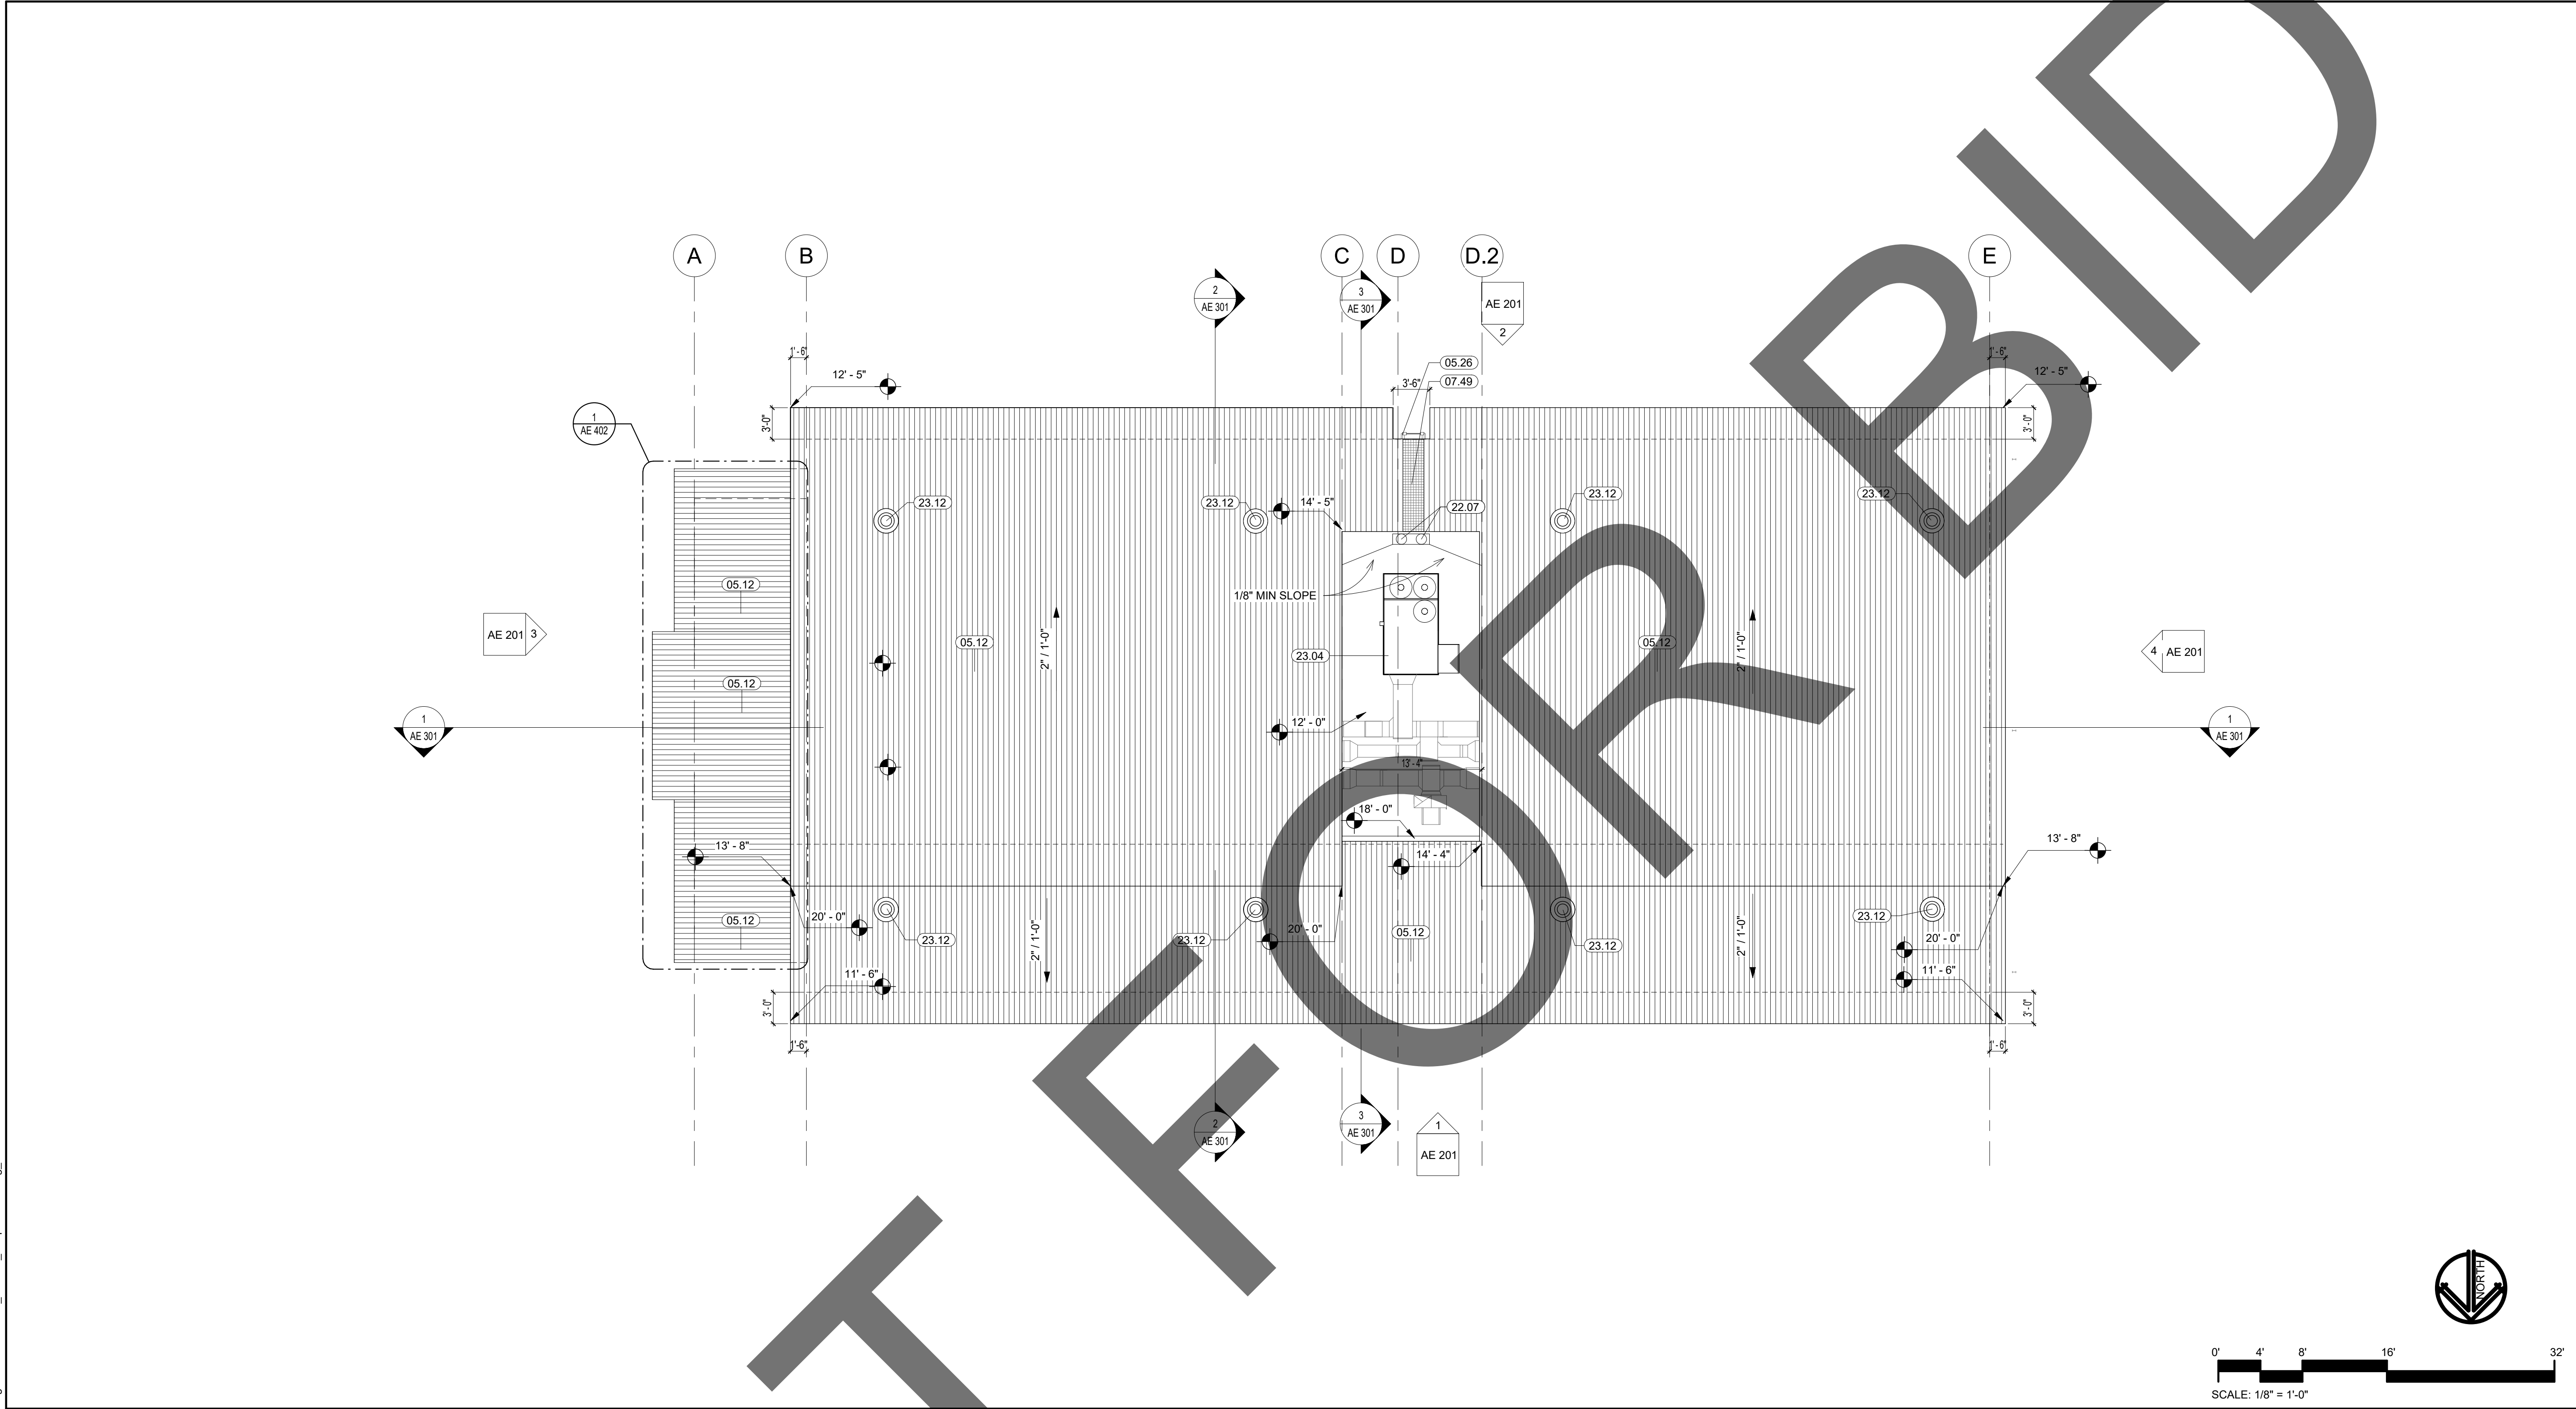

ADOPTION DOG BUILDINGS 5, 6, & 7 ROOF PLAN


KEYNOTE LEGEND	
CSI #	KEYNOTE TEXT
05.12	Standing Seam Metal Roof
22.07	Roof Drain & Overflow
23.04	A/C Condensing Unit
23.12	Exhaust Fan, Per Mechanical Plans

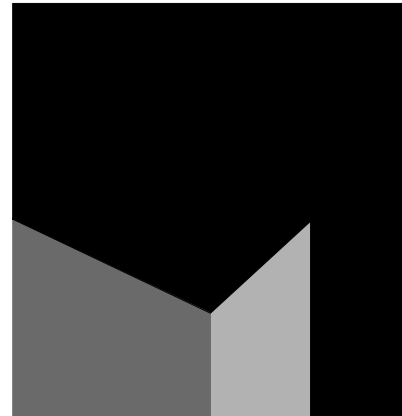

architecture
interiors
planning

MILLER

1177 Idaho Street, Suite 200
Redlands, CA 92374
Phone: 909-335-7400
Fax: 909-335-7299
info@miller-aip.com

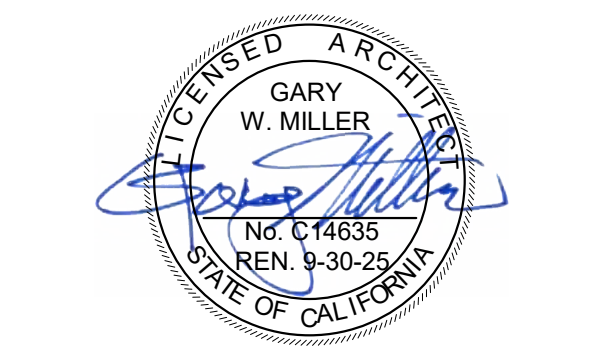

owner approval		
initials	date	phase

REVISIONS/ADDENDA		
#	Date	Comment

ANIMAL CARE CENTER
18313 VALLEY BLVD. BLOOMINGTON, CA 92313

SAN BERNARDINO COUNTY
385 N. ARROWHEAD AVENUE
SAN BERNARDINO, CA 92415
PHONE: 1-888-818-8988

PROJECT INFORMATION	
Project Number:	2200065
Drawn By:	Author
Checked By:	GWM
Issue Date:	2/29/24

SHEET NAME
ADOPTION DOG
BUILDINGS
ROOF PLAN

SHEET NUMBER
AE 105



**1177 Idaho Street, Suite 200
Redlands, CA 92374
Phone: 909-335-7400
Fax: 909-335-7299
info@miller-aip.com**



owner approval

initials	date	phase

REVISIONS/ADDENDA

#	Date	Comment
---	------	---------

ANIMAL CARE CENTER

18313 VALLEY BLVD. BLOOMINGTON, CA 92313

SAN BERNARDINO COUNTY

385 N. ARROWHEAD AVENUE
SAN BERNARDINO, CA 92415
PHONE: 1-888-818-8988

PROJECT INFORMATION

Project Number:	2200065
Drawn By:	Author
Checked By:	GWM
Issue Date:	2/29/24


SHEET NAME

ADOPTION DOG BUILDING ELEVATIONS

SHEET NUMBER

AE 201

Sheet Of Sheets

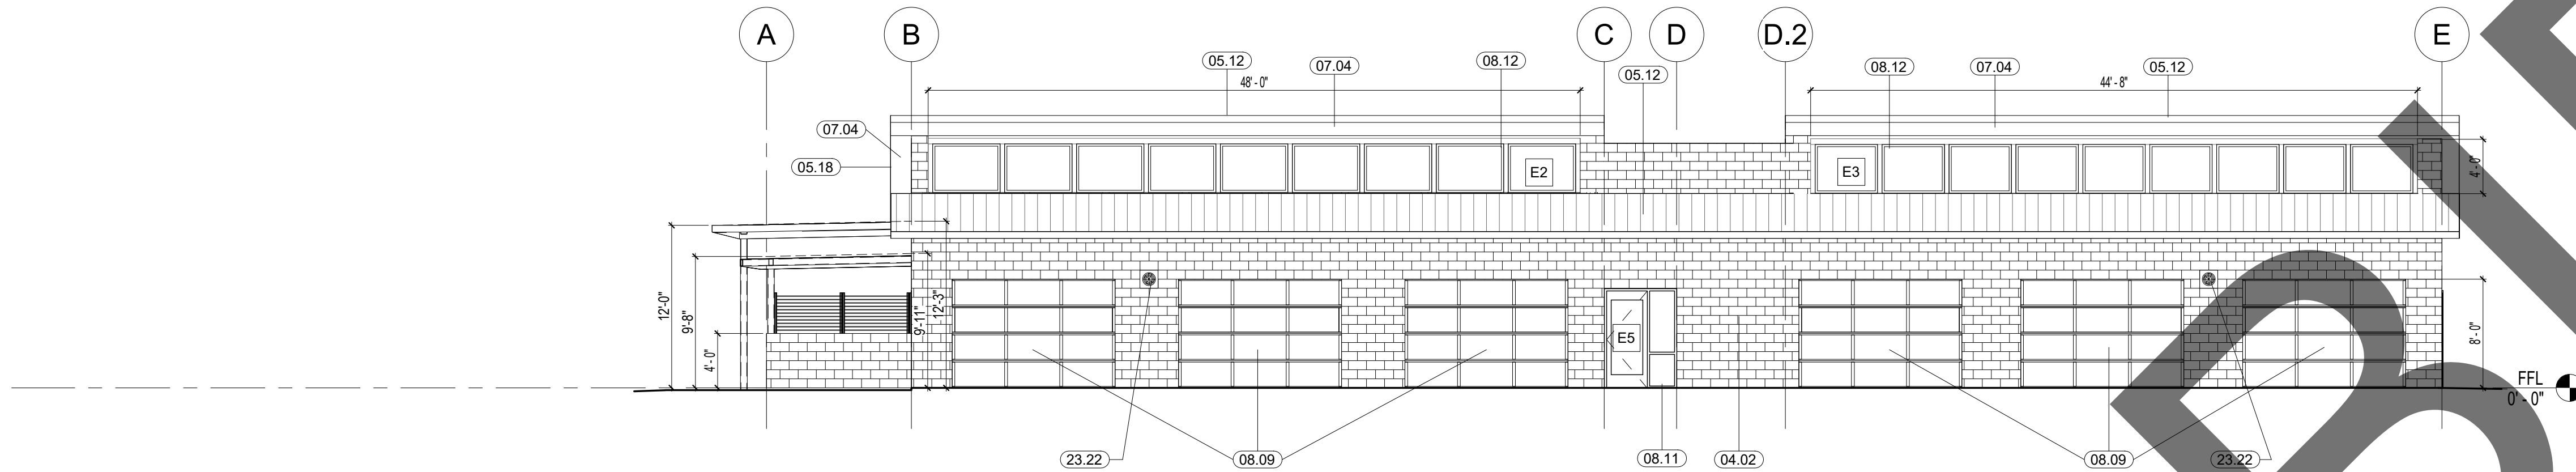


SOUTH ELEVATION

SCALE

$$1/8'' = 1'-0''$$

1

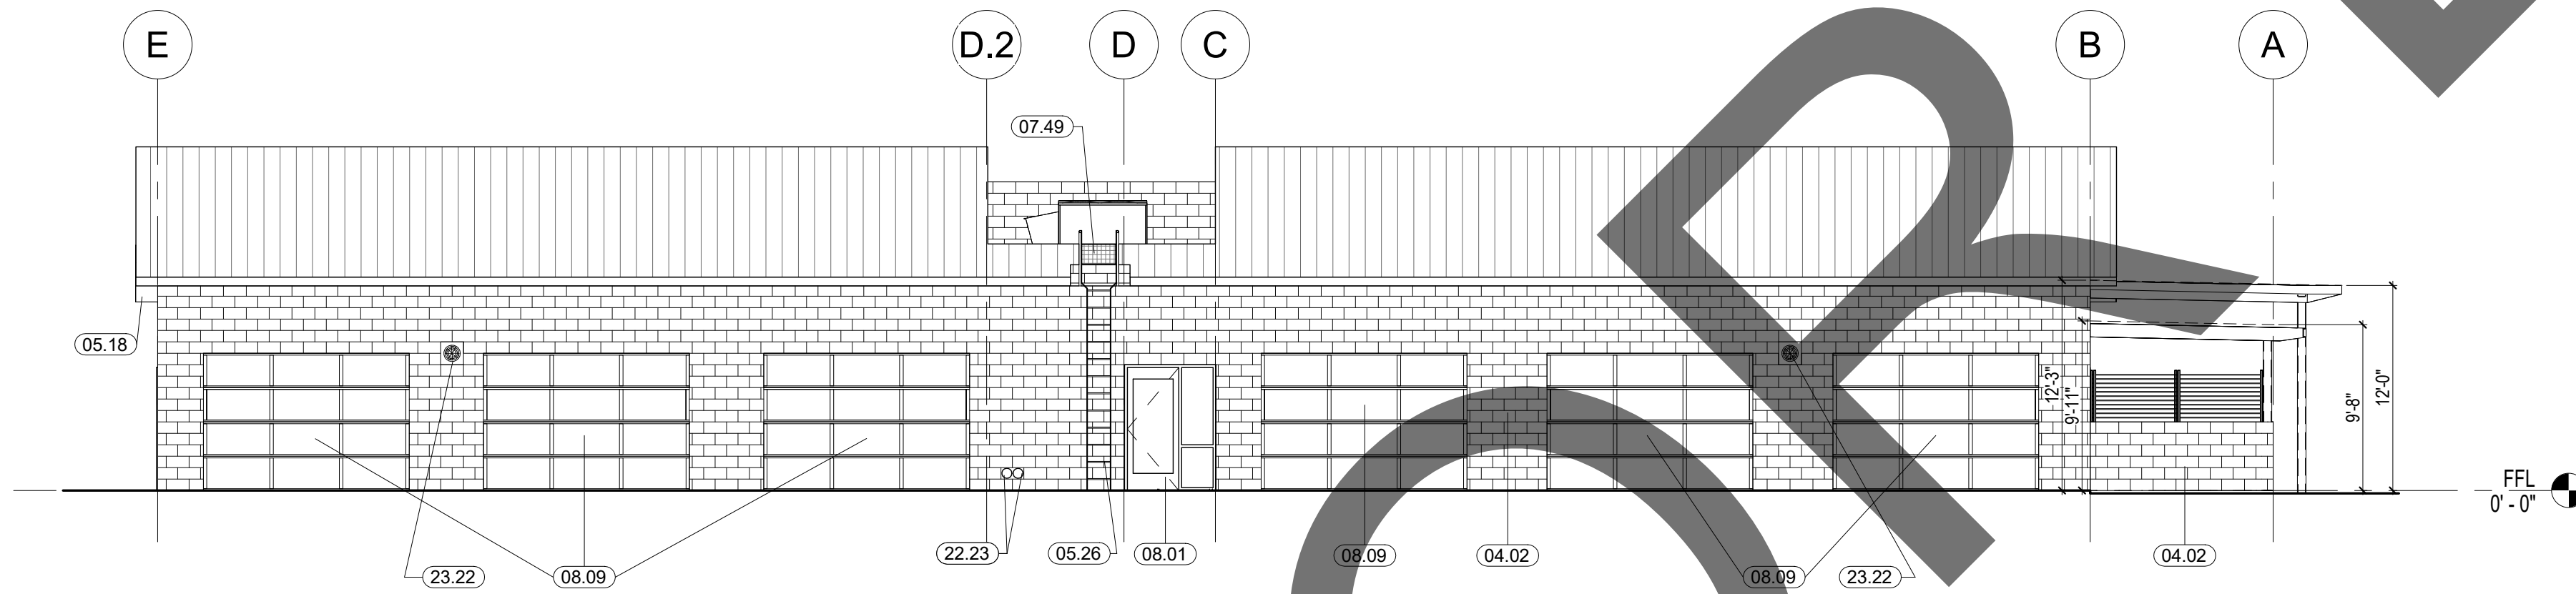


NORTH ELEVATION

SCALE

$$1/8'' = 1'-0''$$

2

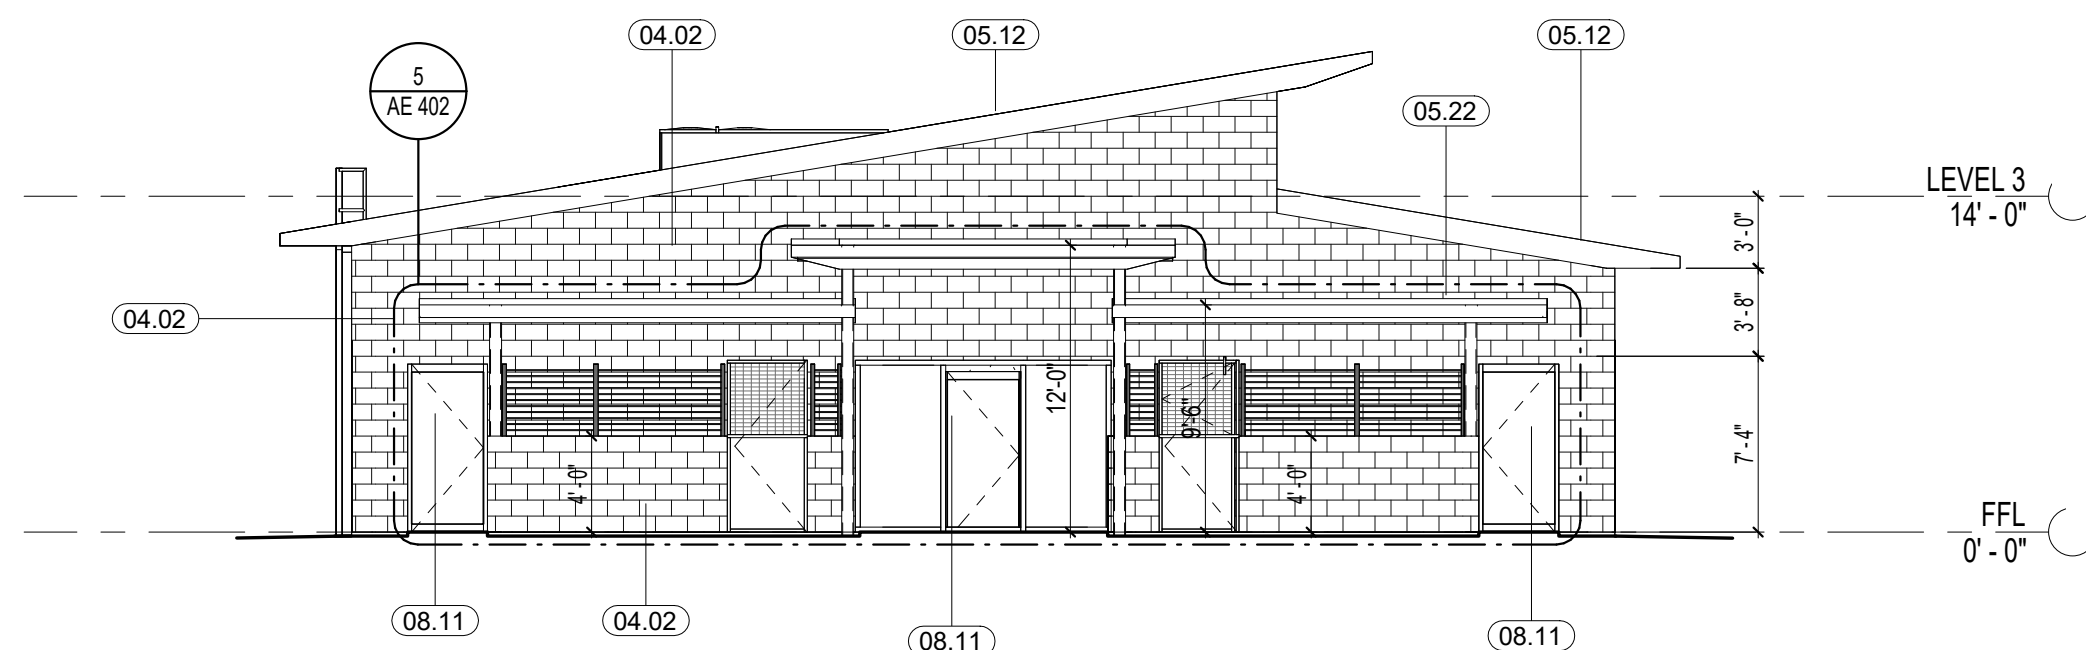


WEST ELEVATION

SCALE

$$1/8'' = 1'-0''$$

3

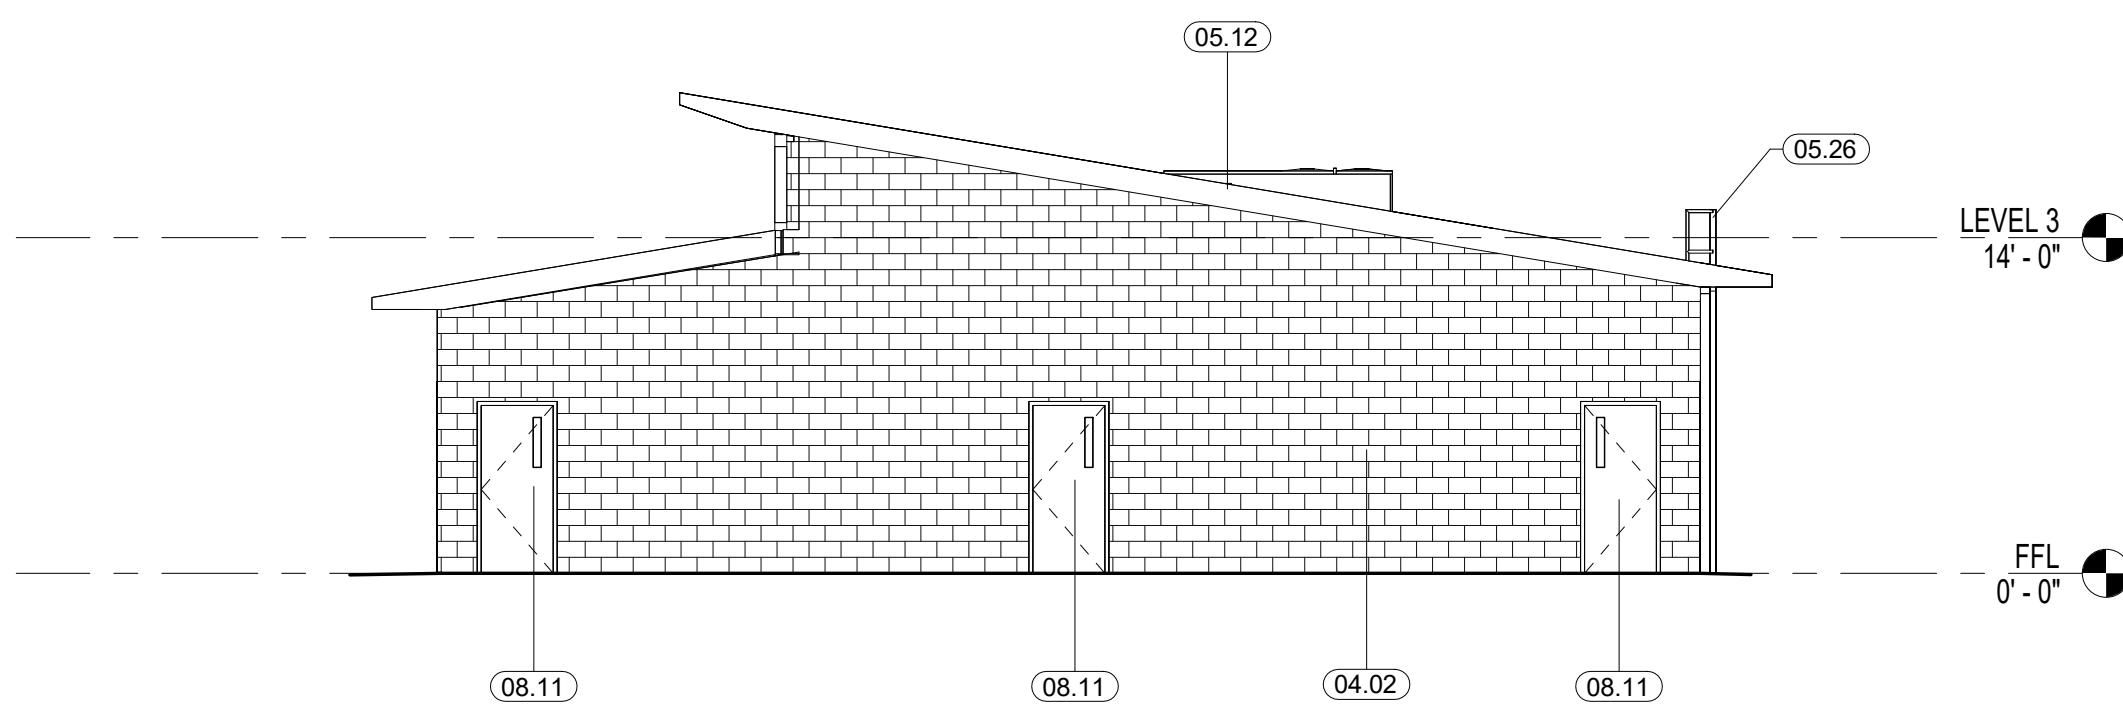

EAST ELEVATION


SCALE

$$1/8" = 1'-0"$$

4

KEYNOTE LEGEND

CSI #	KEYNOTE TEXT
04.02	CMU Wall
05.12	Standing Seam Metal Roof
05.18	6" V-Groove Aluminum Plank 'Longboard'
05.22	Steel Canopy Structure
05.26	Steel Roof Ladder
07.04	'Trespa' 'Meteon' Wall Planks
07.49	Roof Walkway System
08.01	Hollow Metal Door & Metal Frame
08.09	Overhead Door with Rail Support per Schedule
08.11	Door
08.12	Window
22.23	Roof Drain Leader
23.22	Mechanical Fan per Mechanical Drawings

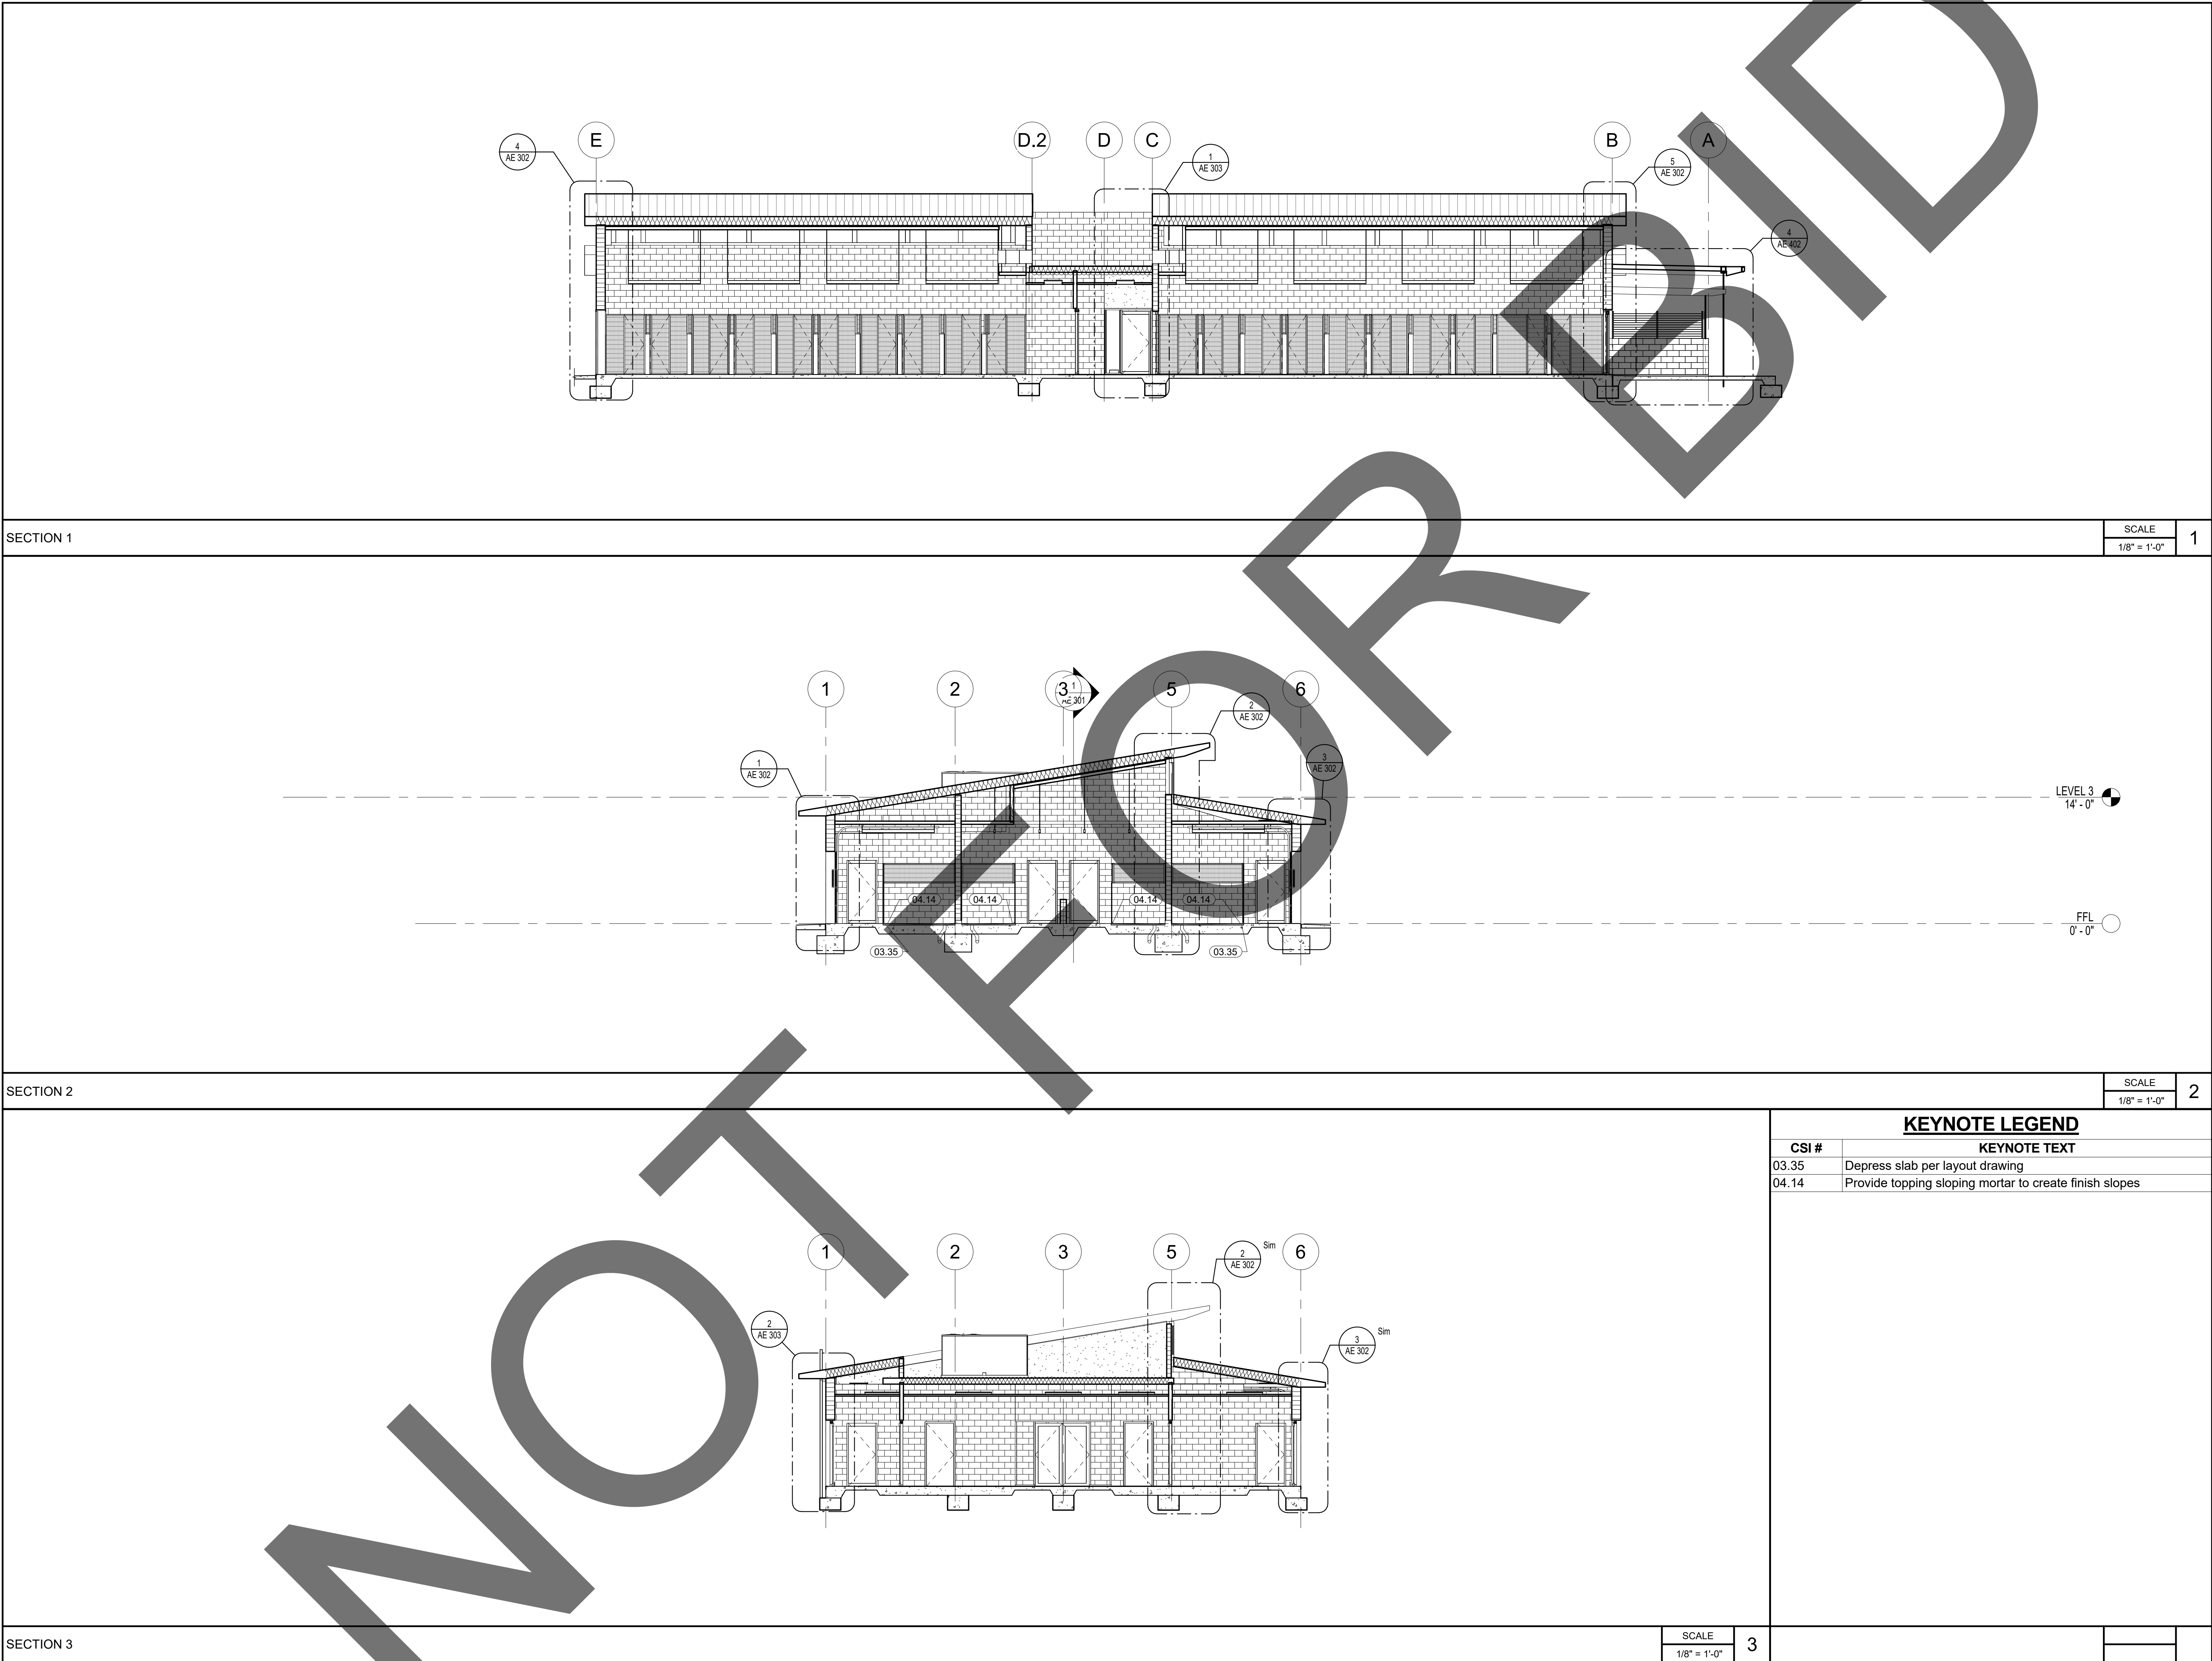



architecture
interiors
planning

MILLER

1177 Idaho Street, Suite 200
Redlands, CA 92374
Phone: 909-335-7400
Fax: 909-335-7299
info@miller-aip.com



owner approval

initials	date	phase

REVISIONS/ADDENDA		
#	Date	Comment

ANIMAL CARE CENTER
18313 VALLEY BLVD. BLOOMINGTON, CA 92313

SAN BERNARDINO COUNTY
385 N. ARROWHEAD AVENUE
SAN BERNARDINO, CA 92415
PHONE: 1-888-818-8988

PROJECT INFORMATION	
Project Number:	2200065
Drawn By:	PF
Checked By:	GWM
Issue Date:	2/29/24

SHEET NAME

ADOPTION DOG
BUILDINGS
SECTIONS

SHEET NUMBER	
AE 301	
Sheet	Of Sheets



initials	date	phase

REVISIONS/ADDENDA

#	Date	Comment
---	------	---------

ANIMAL CARE CENTER

18313 VALLEY BLVD. BLOOMINGTON, CA 92313

SAN BERNARDINO COUNTY

385 N. ARROWHEAD AVENUE
SAN BERNARDINO, CA 92415
PHONE: 1-888-818-8988

PROJECT INFORMATION

Project Number:	2200065
Drawn By:	Author
Checked By:	GWM
Issue Date:	2/29/24


SHEET NAME

WALL SECTIONS

SHEET NUMBER

AE 302


Sheet Of Sheets

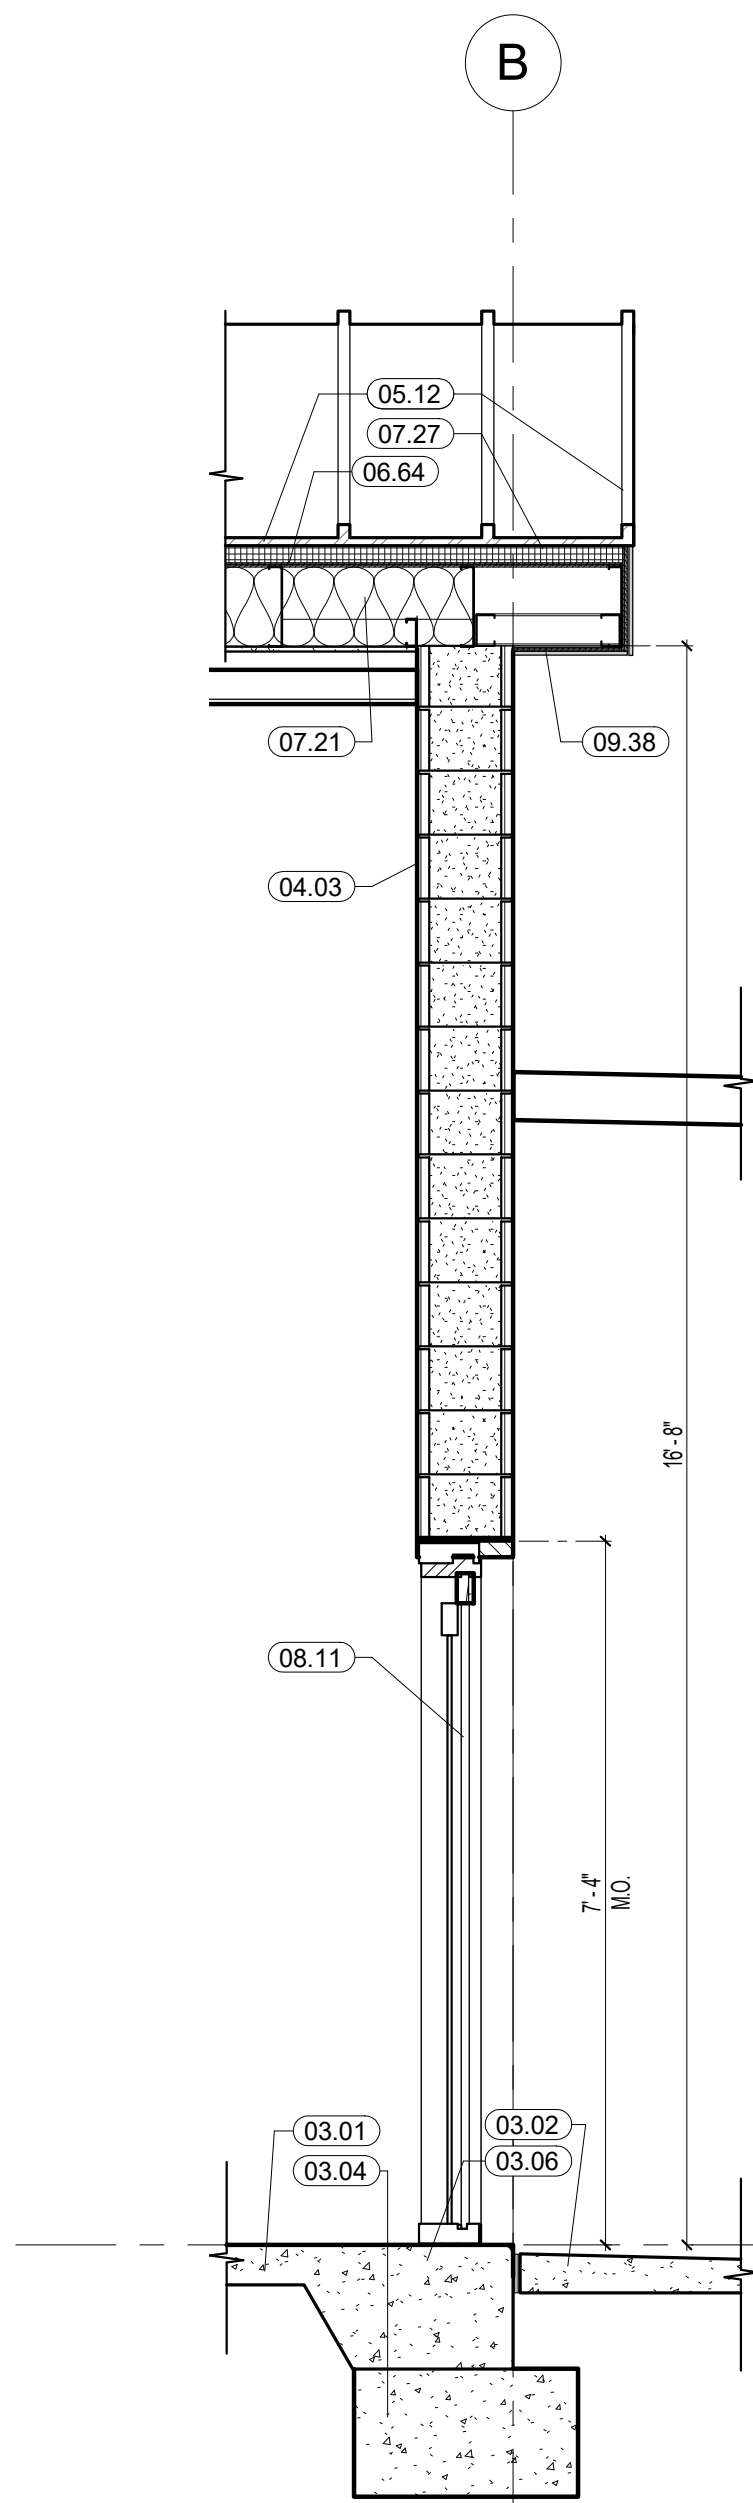

WALL SECTION 3

SCALE
1/2" = 1'-0"


5

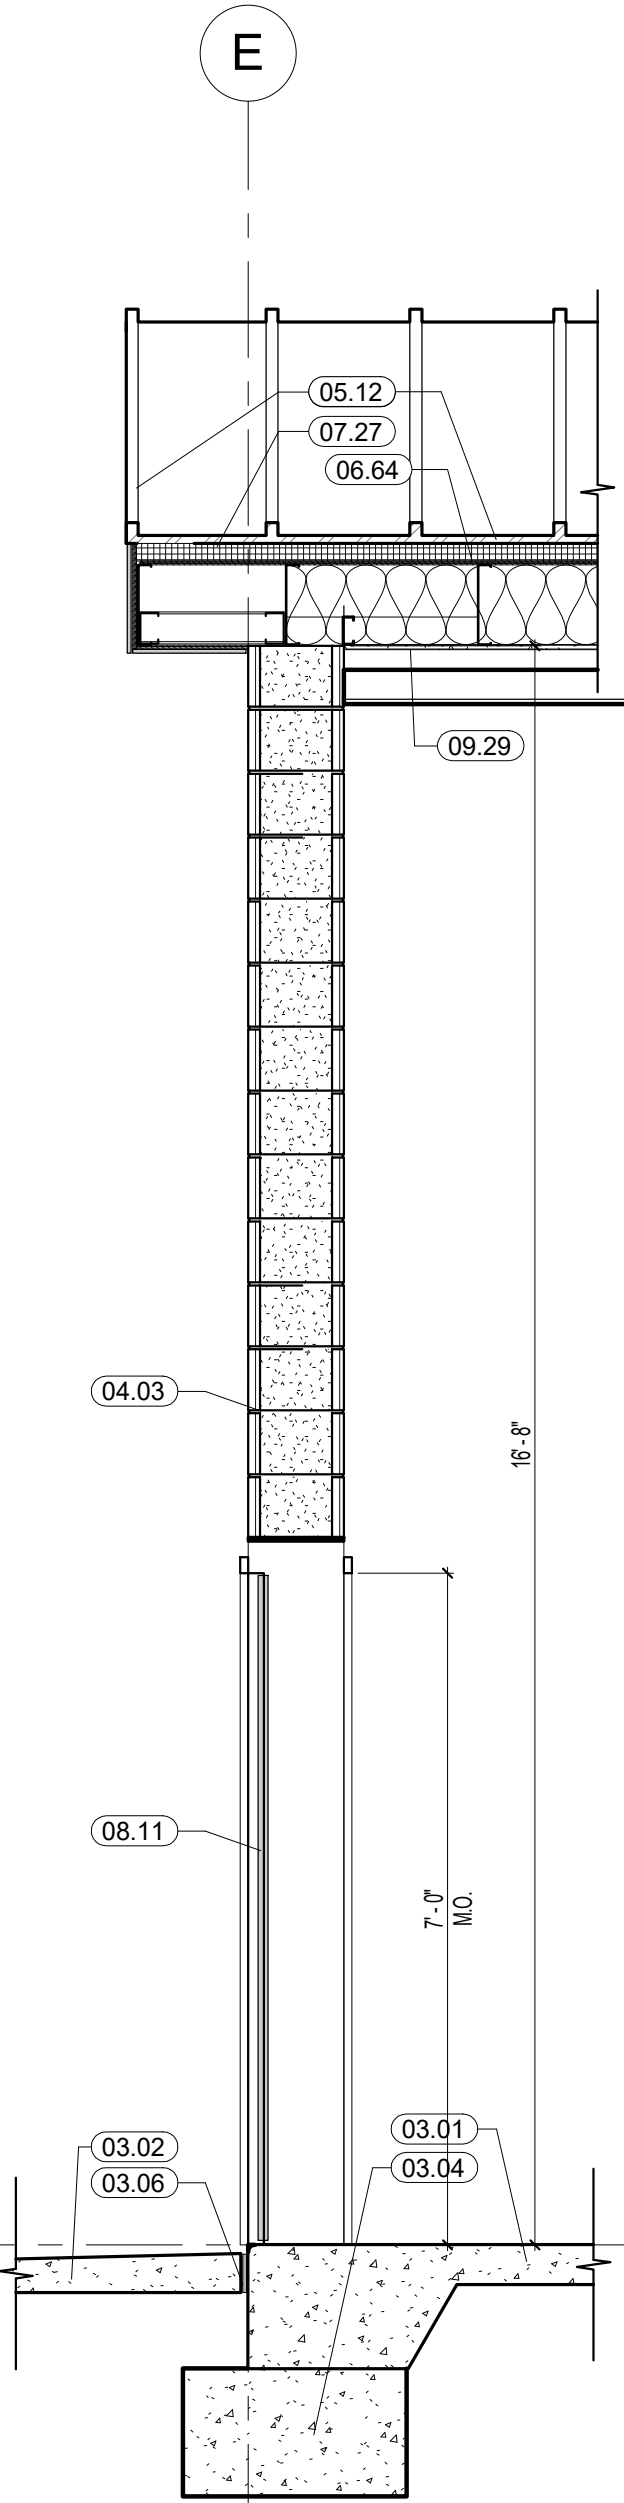

WALL SECTION 1

SCALE
1/2" = 1'-0"


4

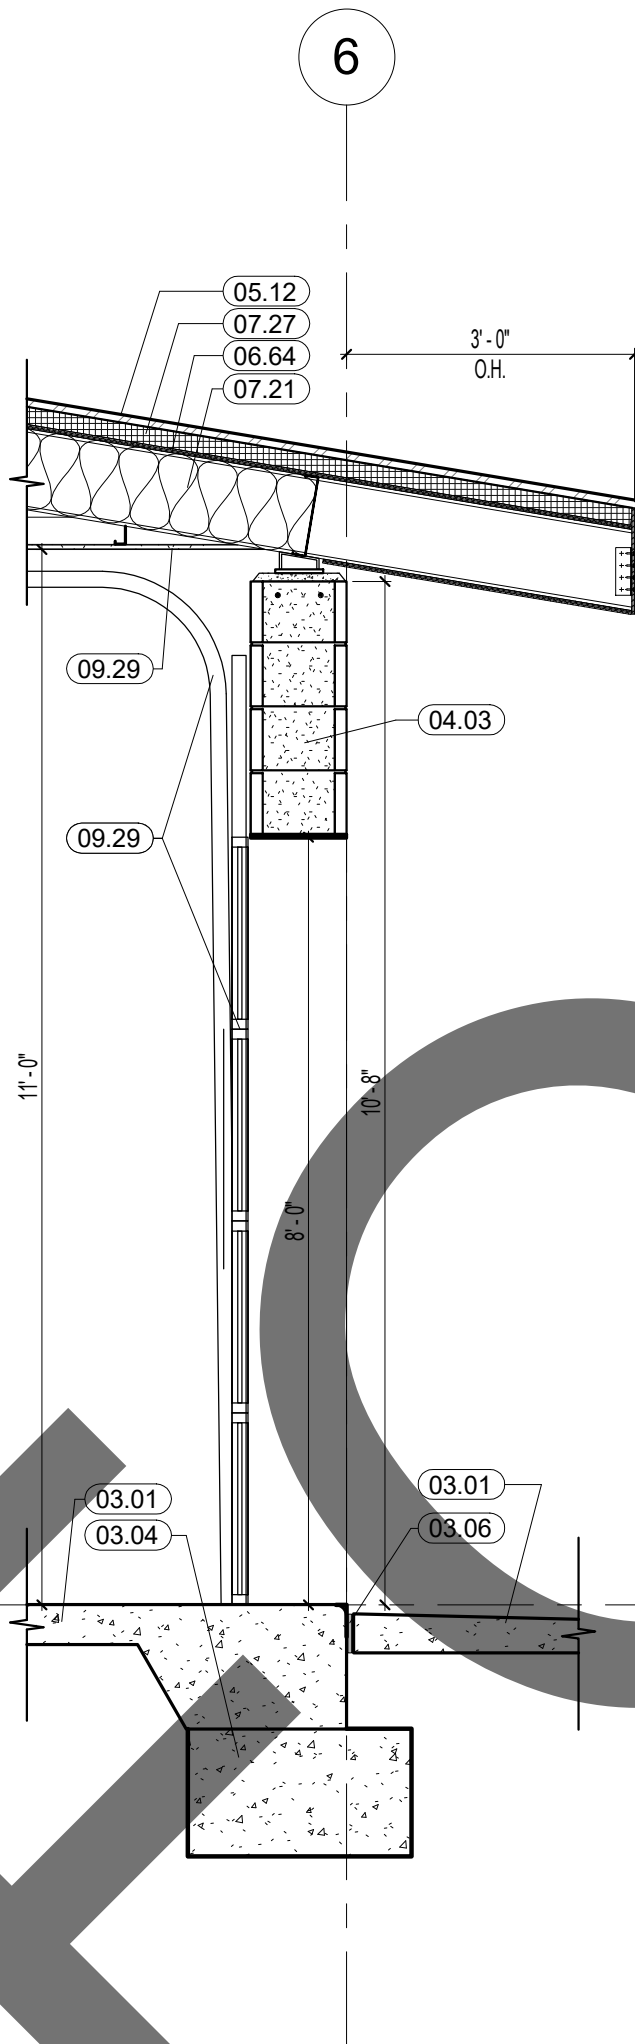

WALL SECTION 6

SCALE
1/2" = 1'-0"


3

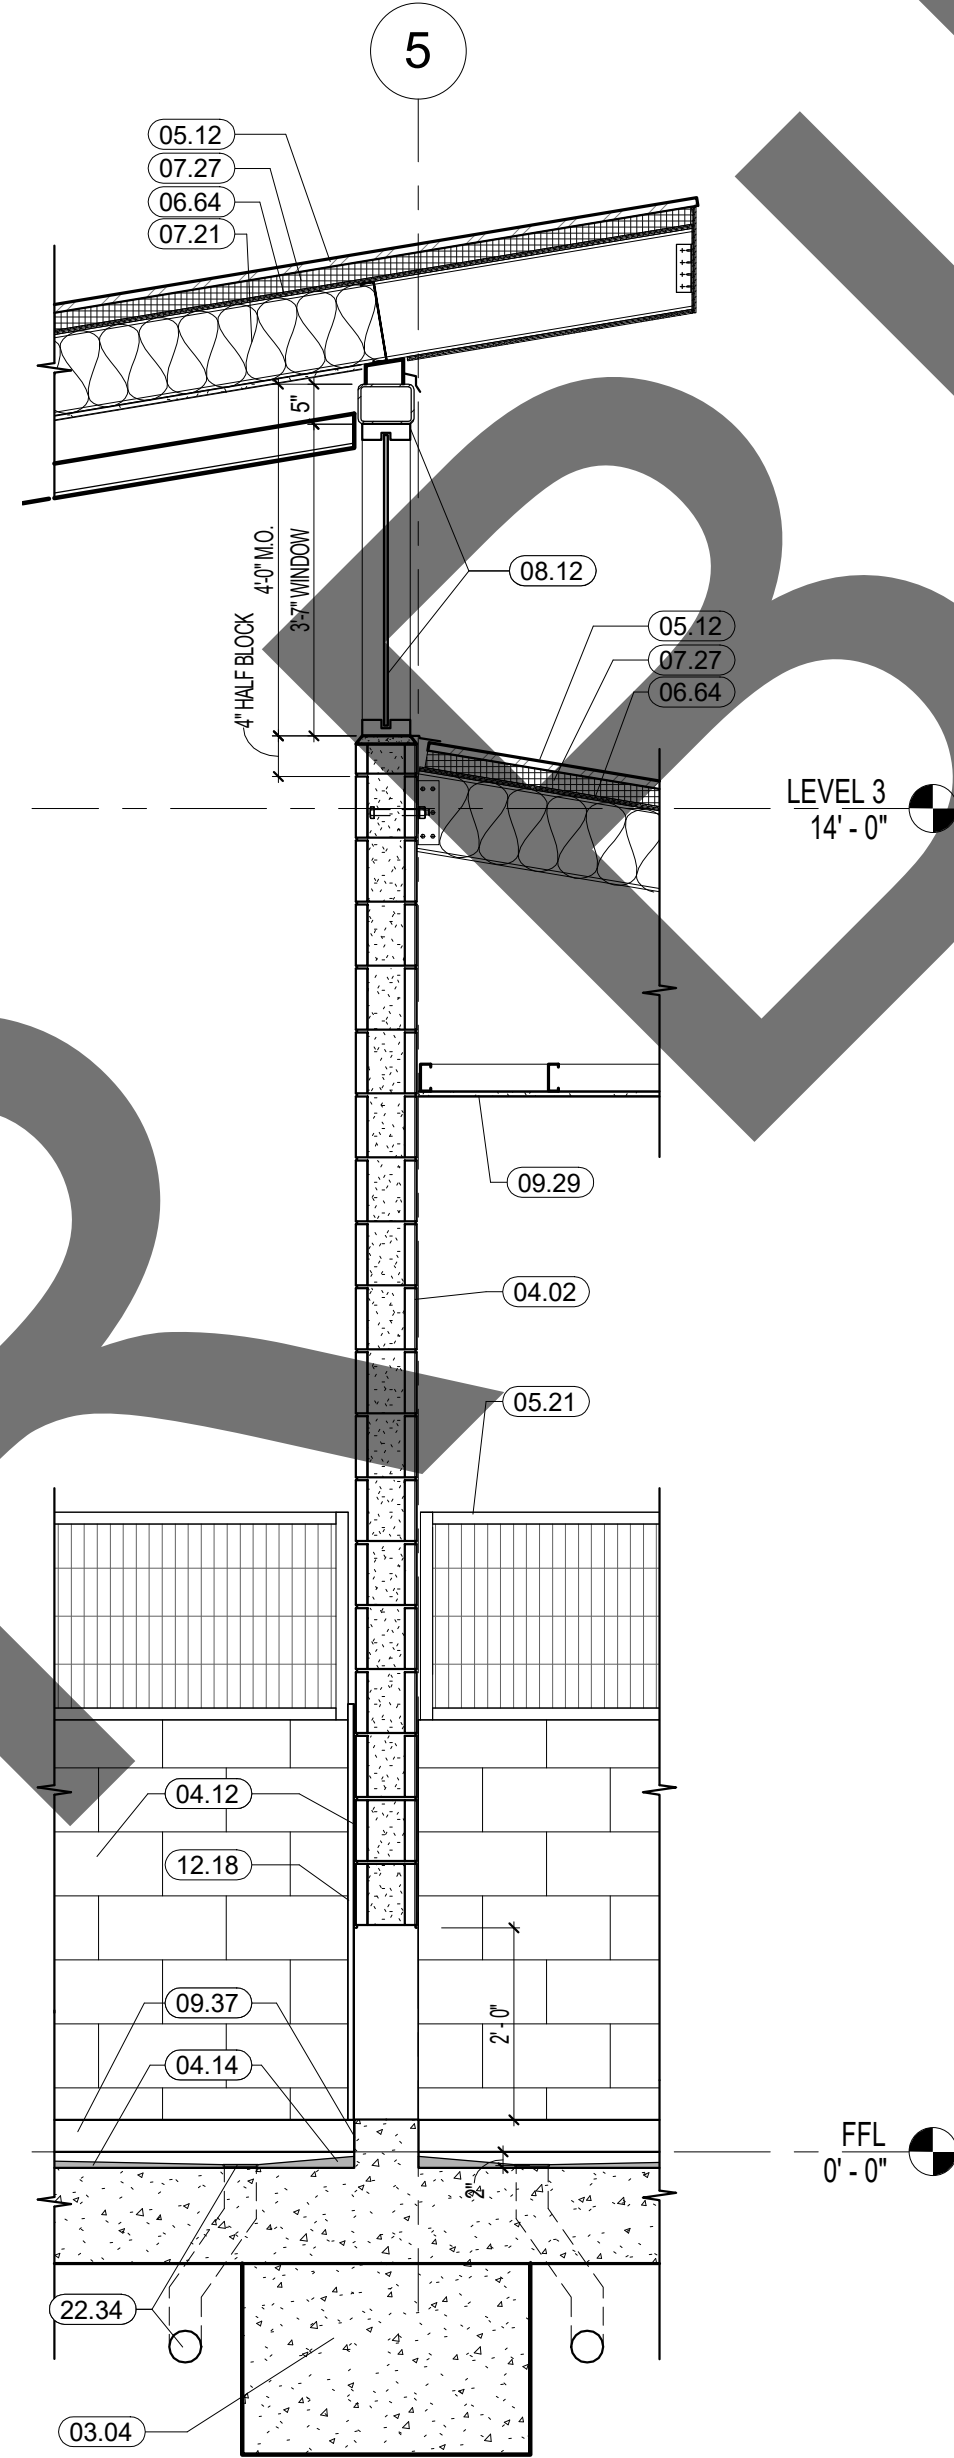

WALL SECTION 5

SCALE
1/2" = 1'-0"

2

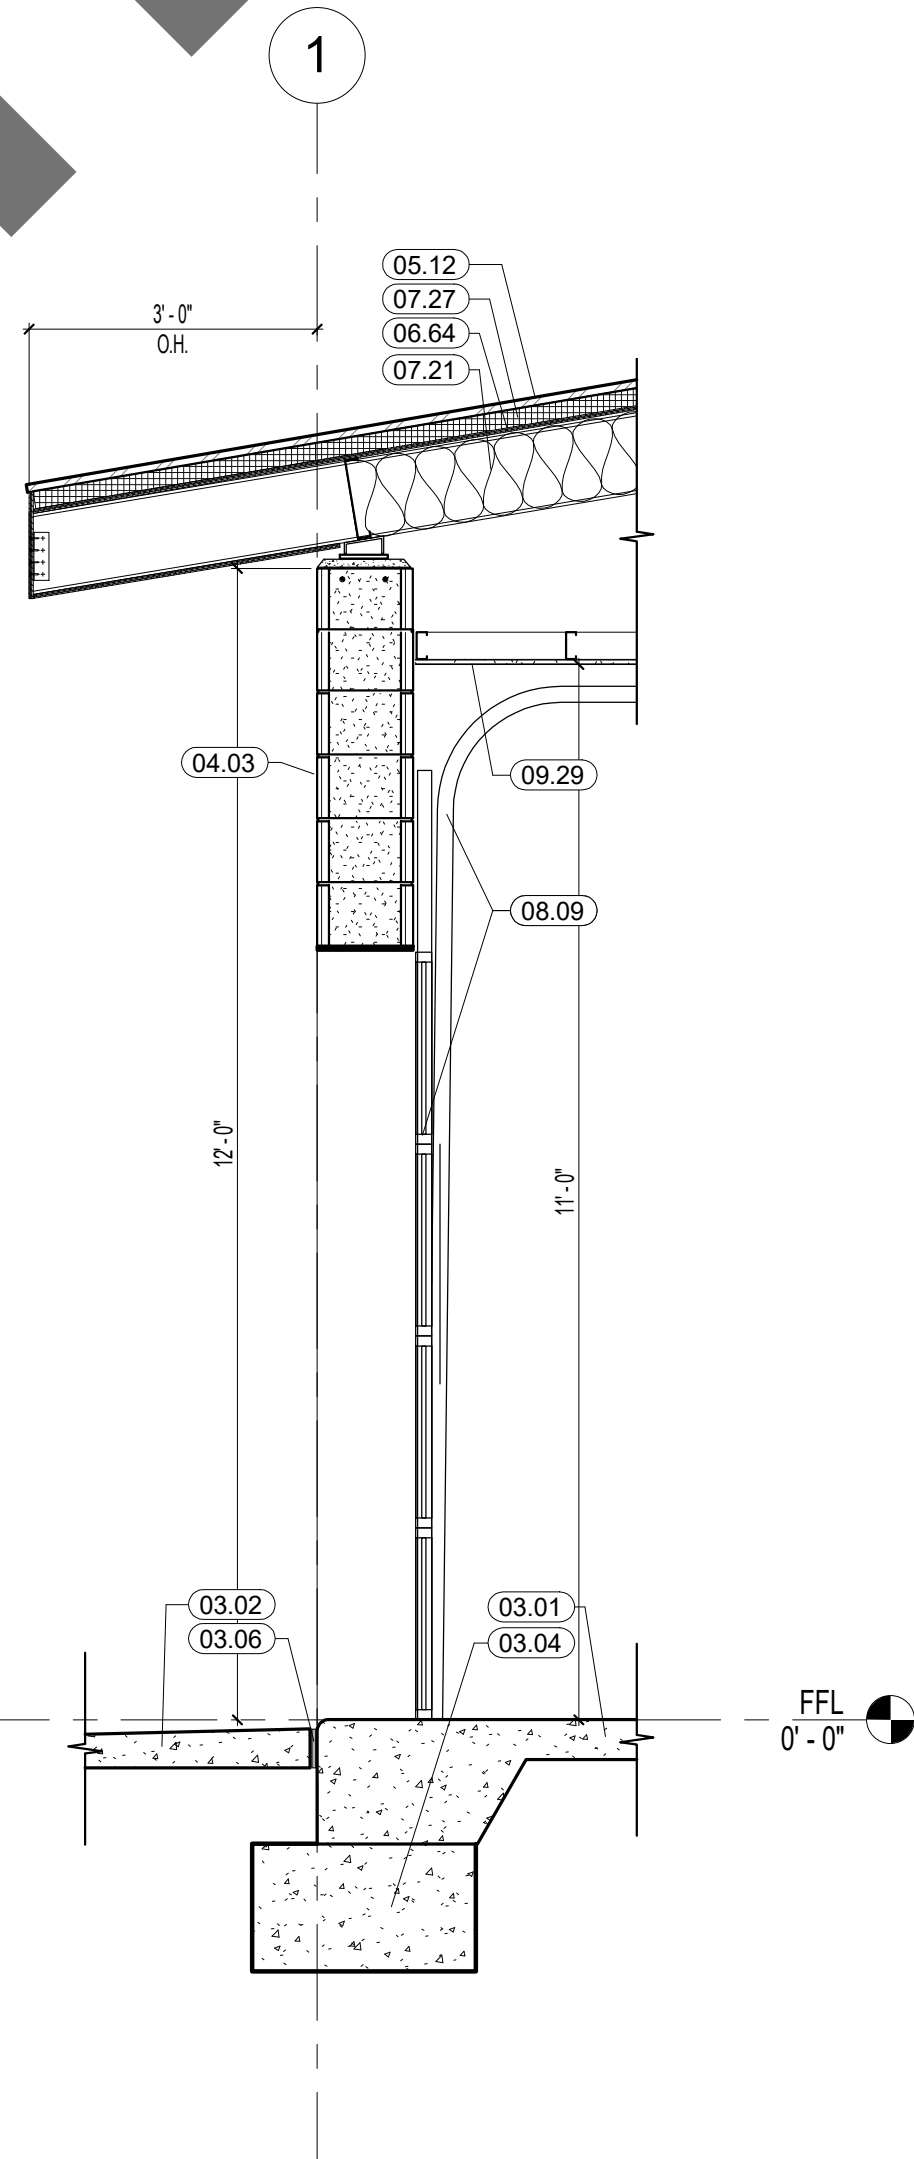

WALL SECTION 4

SCALE
1/2" = 1'-0"

1

KEYNOTE LEGEND

CSI #	KEYNOTE TEXT
03.01	Concrete Slab
03.02	Exterior Concrete
03.04	Concrete Footing
03.06	Expansion Joint
04.02	CMU Wall
04.03	12x8x16 CMU Wall
04.12	Epoxy Coated CMU Block
04.14	Provide topping sloping mortar to create finish slopes
05.12	Standing Seam Metal Roof
05.21	Kenneling Material
06.64	Plywood Sheathing
07.21	Batt Insulation
07.27	Rigid Insulation
08.09	Overhead Door with Rail Support per Schedule
08.11	Door
08.12	Window
09.29	'Armstrong Ceramaguard' w/ Aluminum Grid
09.37	Concrete/Masonry Epoxy Resin
09.38	Hardie Soffit Board
12.18	Transfer Guillotine Door - See Animal Equipment Drawings
22.34	Coordinate drain & waste line with plumbing drawings



**1177 Idaho Street, Suite 200
Redlands, CA 92374
Phone: 909-335-7400
Fax: 909-335-7299
info@millers-aip.com**




owner approval

initials	date	phase

REVISIONS/ADDENDA

#	Date	Comment
---	------	---------

 

ANIMAL CARE CENTER

18313 VALLEY BLVD. BLOOMINGTON, CA 92313

SAN BERNARDINO COUNTY

3385 N. ARROWHEAD AVENUE
SAN BERNARDINO, CA 92415
PHONE: 1-888-818-8988

PROJECT INFORMATION

Project Number:	2200065
Drawn By:	Author
Checked By:	GWM
Issue Date:	2/29/24


SHEET NAME

ADOPTION DOG
BUILDINGS
WALL SEC.

SHEET NUMBER

AE 303

Sheet Of Sheets


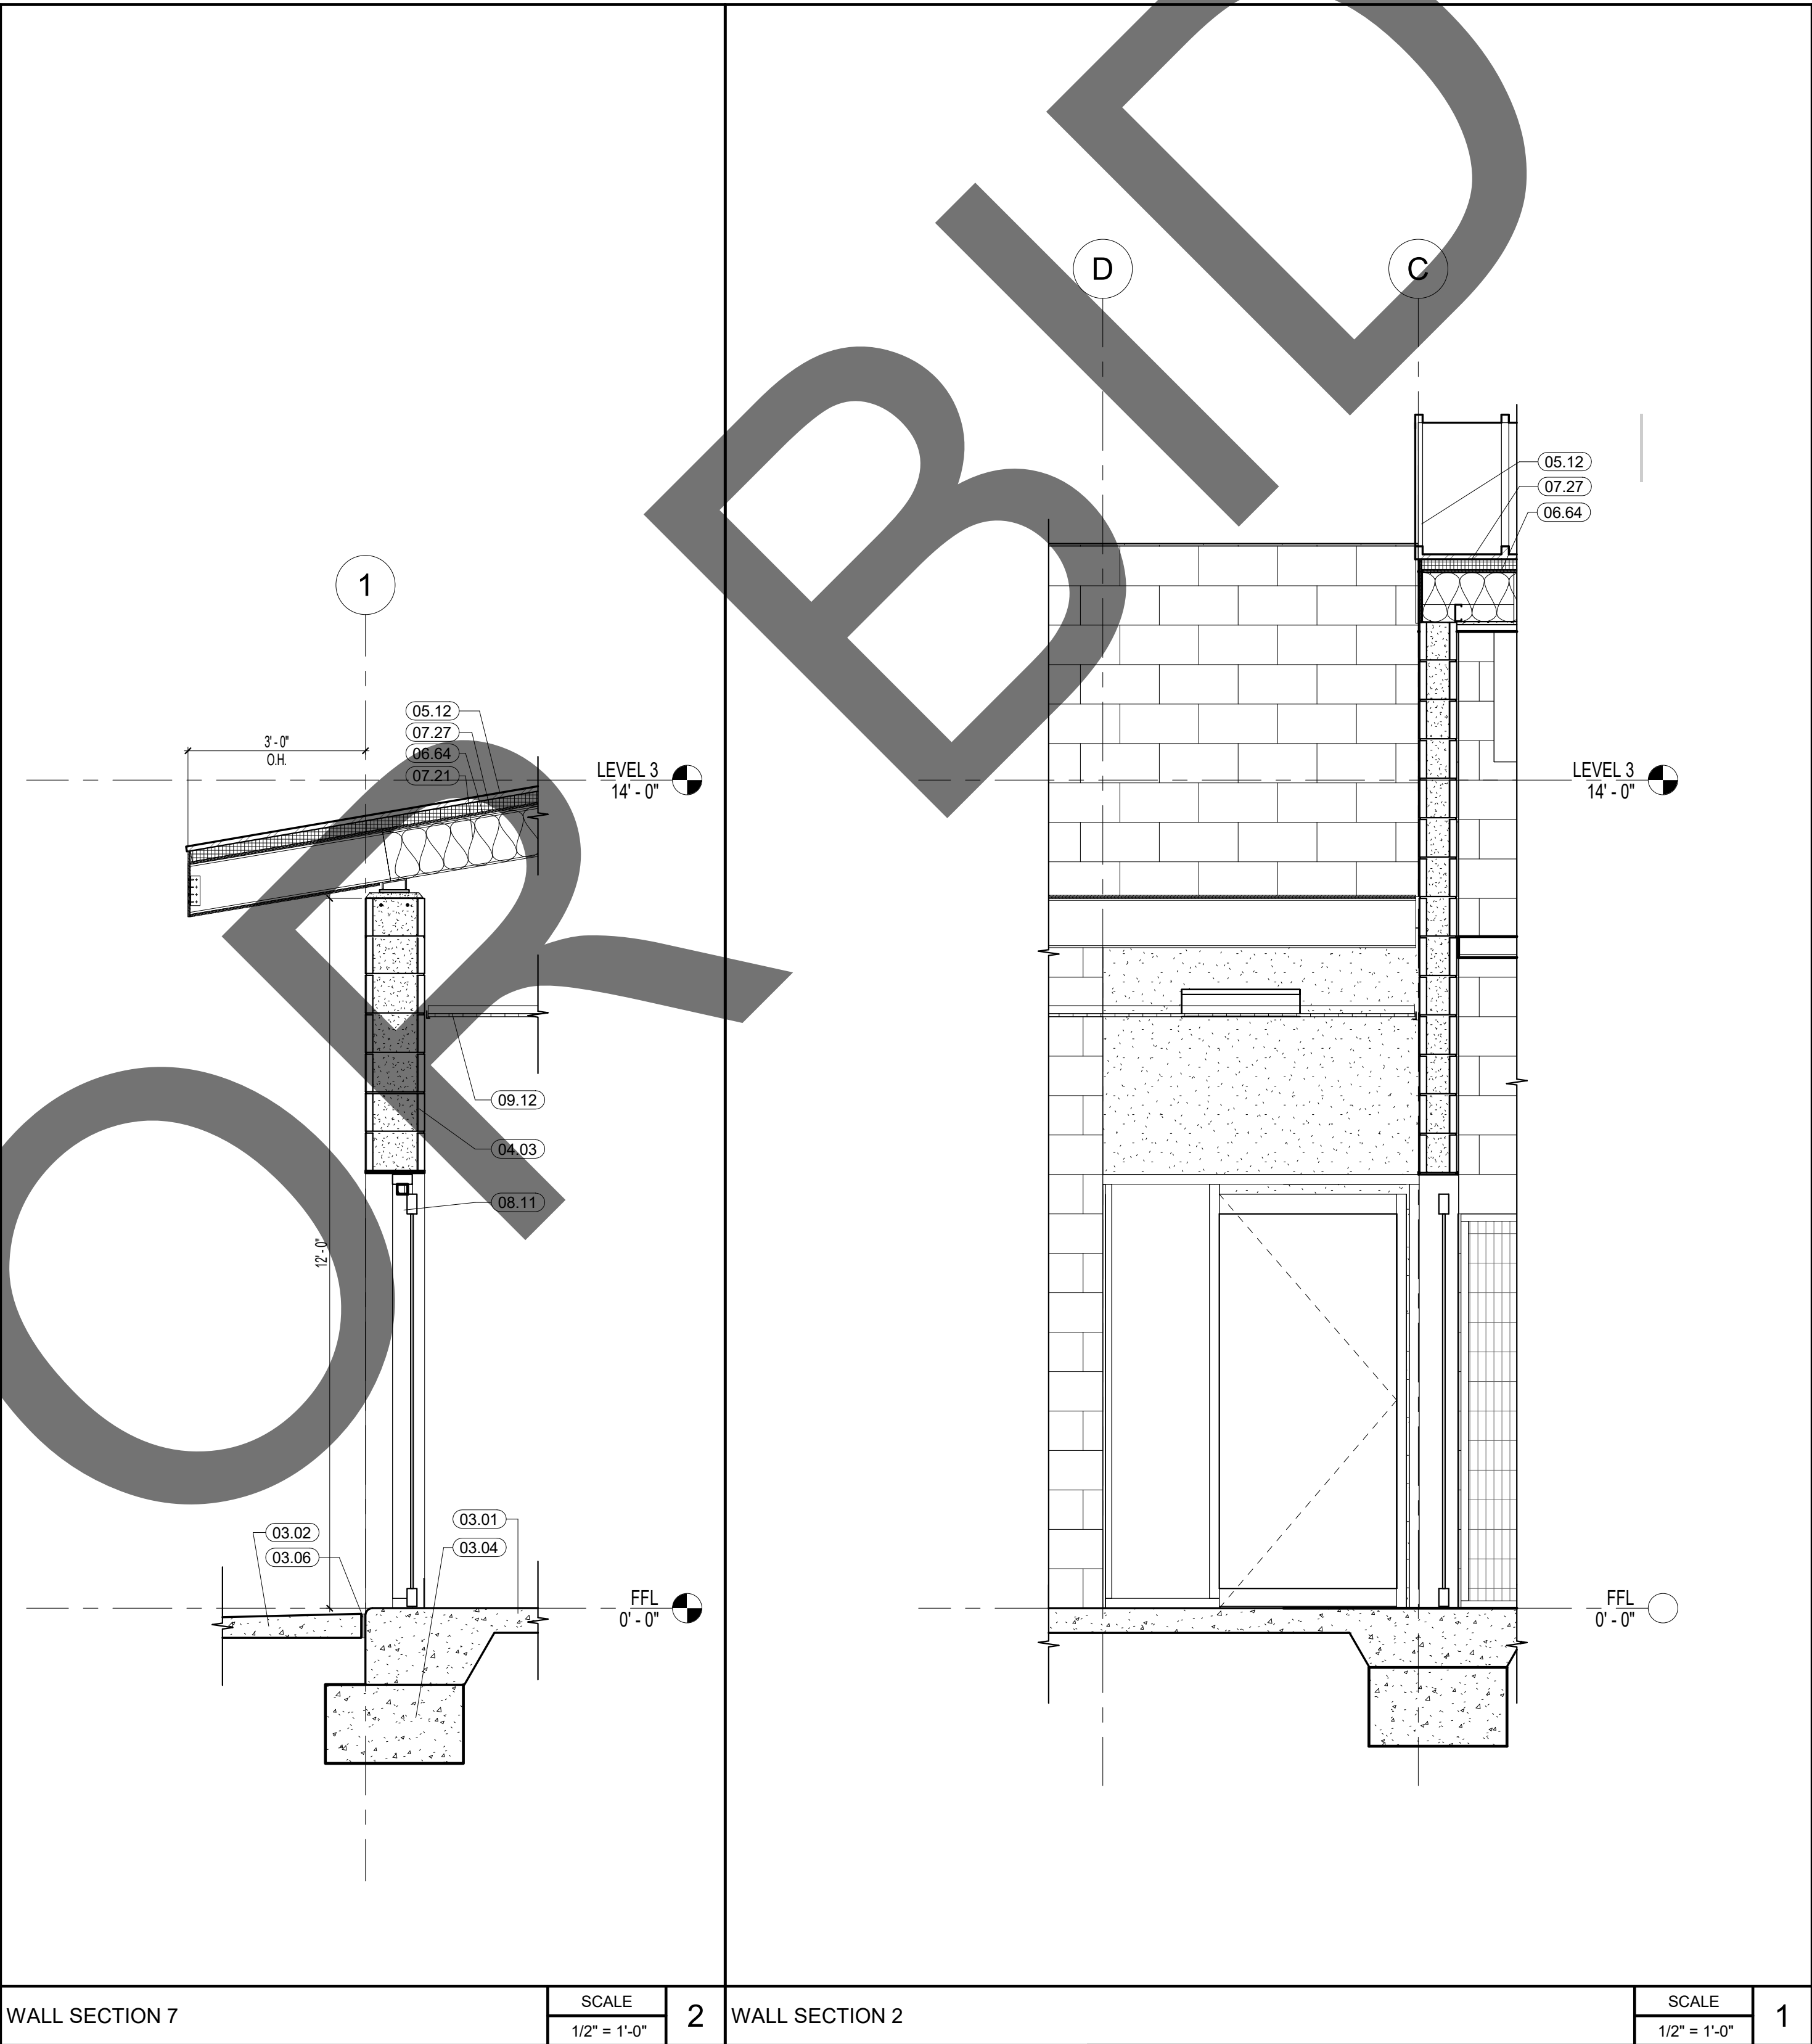


KEYNOTE LEGEND		
CSI #	KEYNOTE TEXT	
03.01	Concrete Slab	
03.02	Exterior Concrete	
03.04	Concrete Footing	
03.06	Expansion Joint	
04.03	12x8x16 CMU Wall	
05.12	Standing Seam Metal Roof	
06.64	Plywood Sheathing	
07.21	Batt Insulation	
07.27	Rigid Insulation	
08.11	Door	
09.12	Suspended Ceiling w/ Acoustical Panels	



385 N. ARROWHEAD AVENUE
SAN BERNARDINO, CA 92415
PHONE: 1-888-818-8988

Sheet Of Sheets

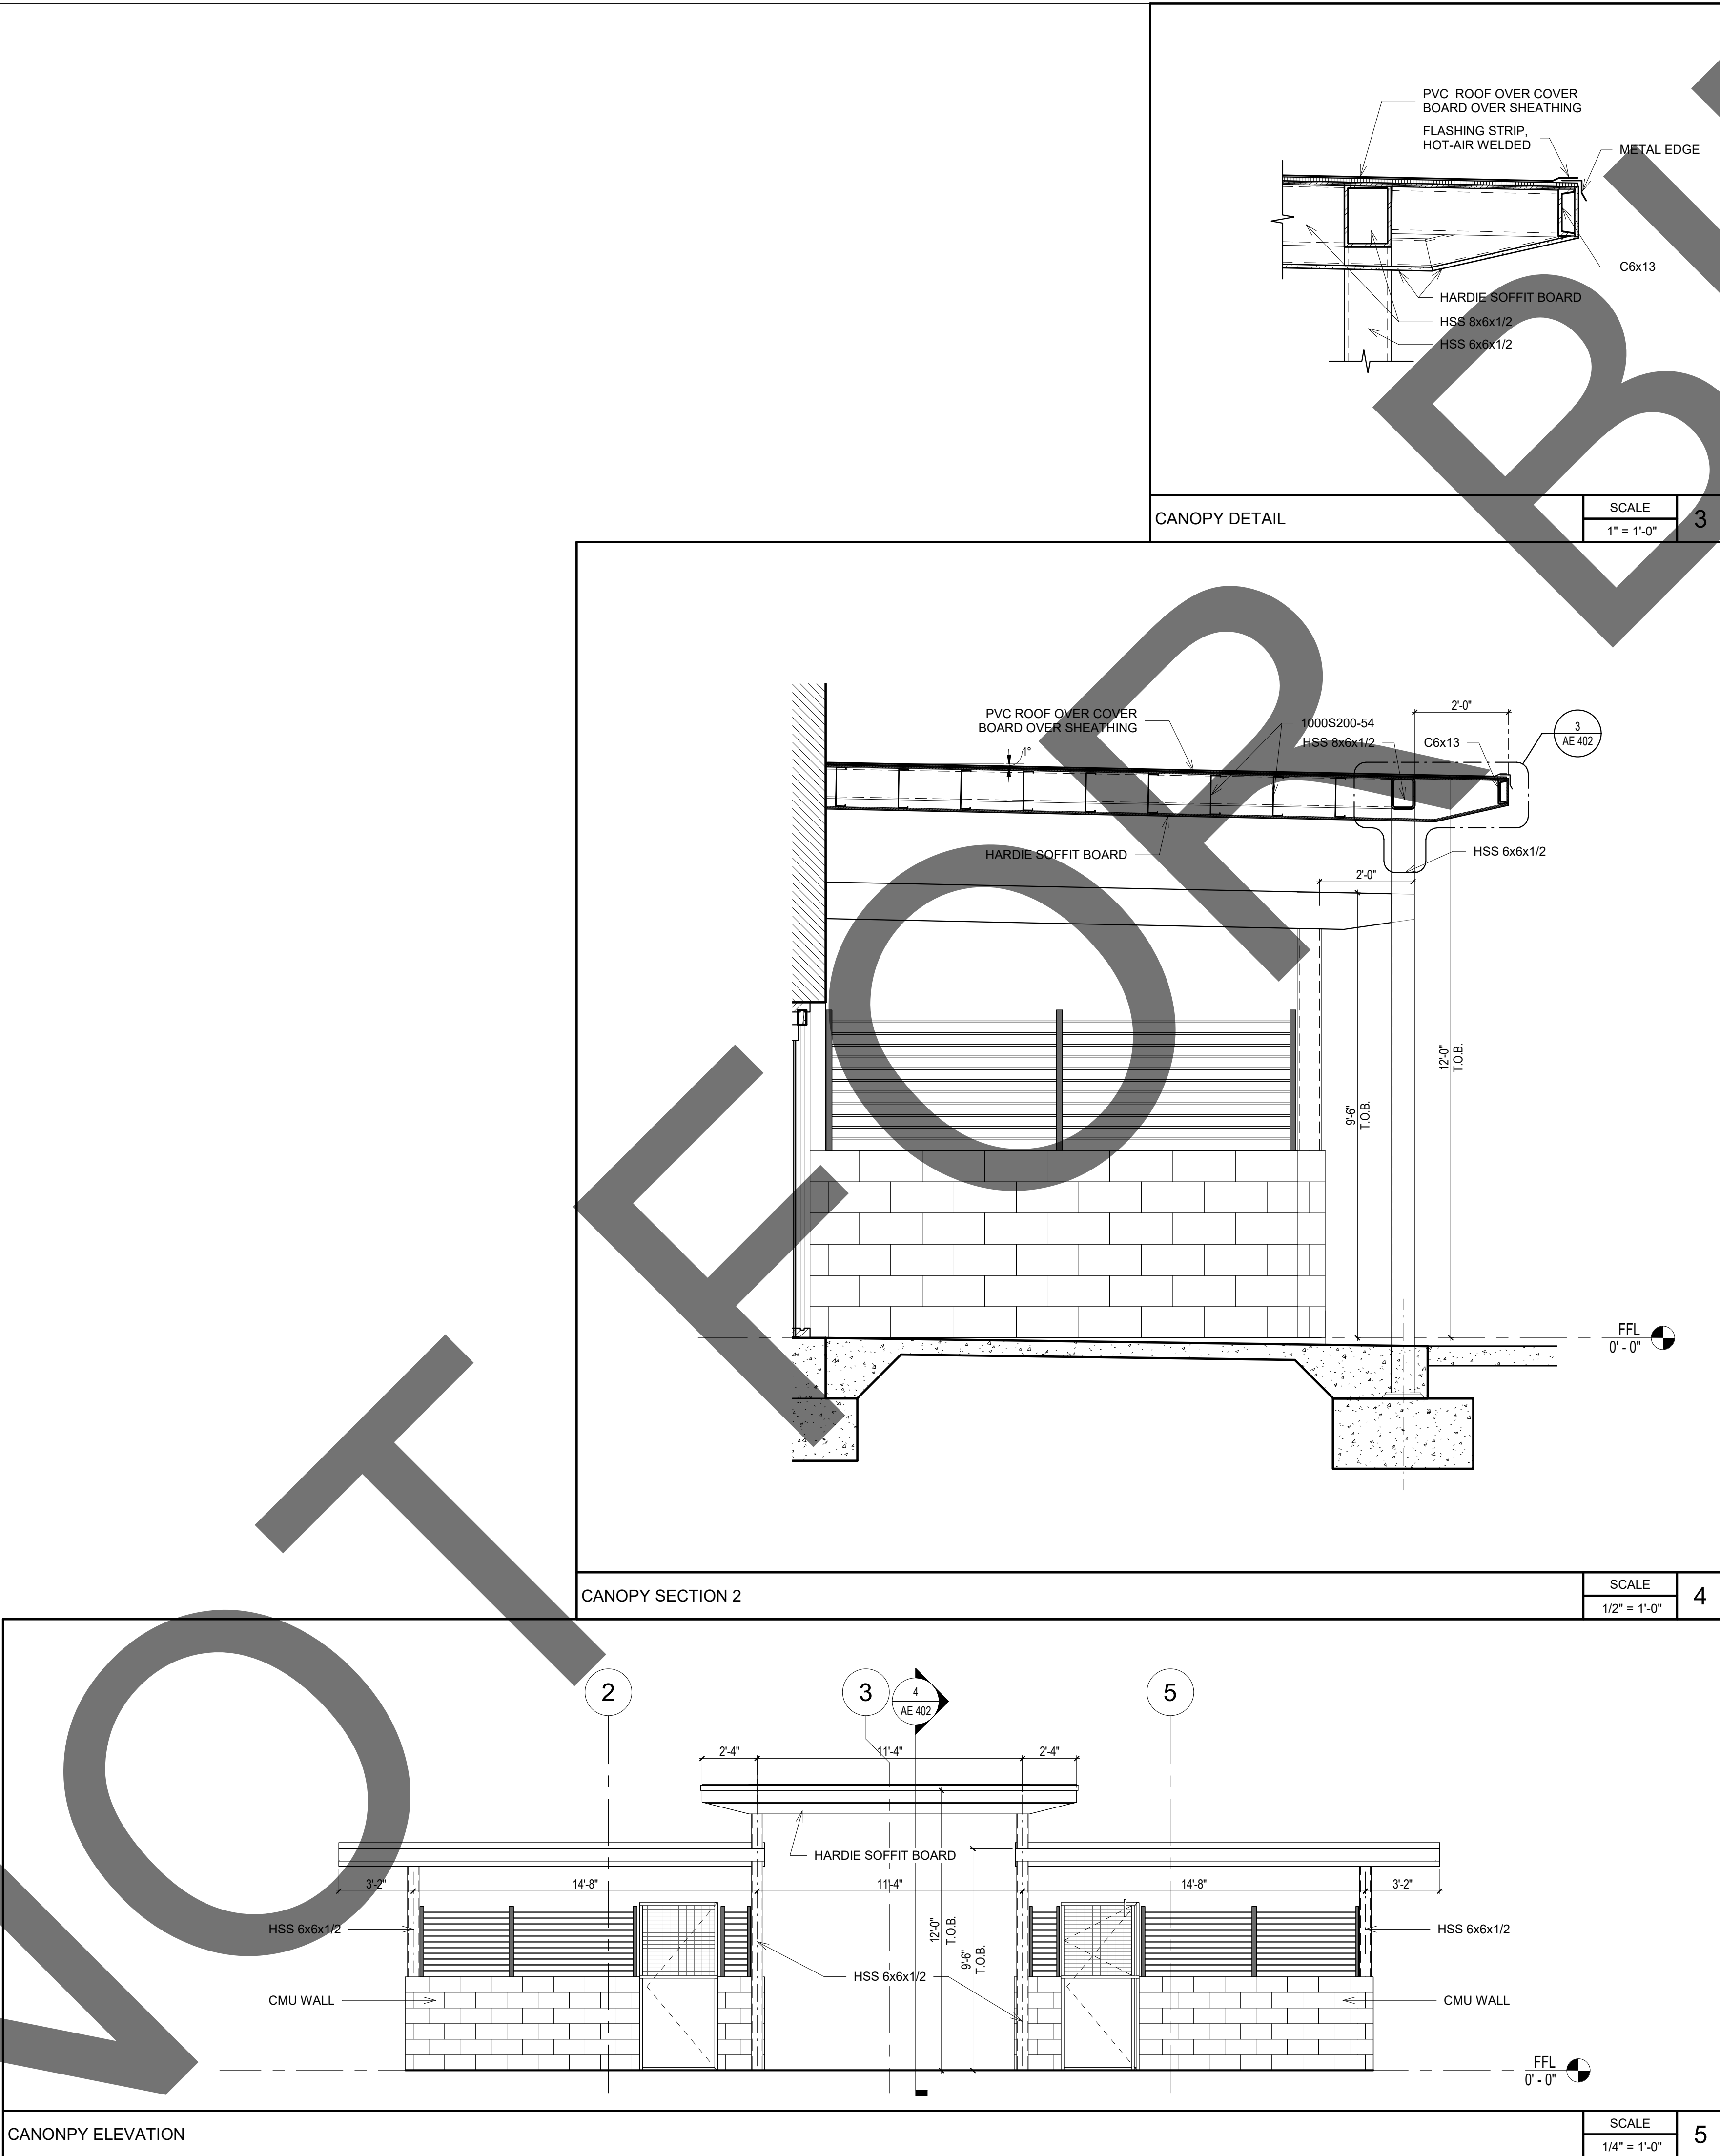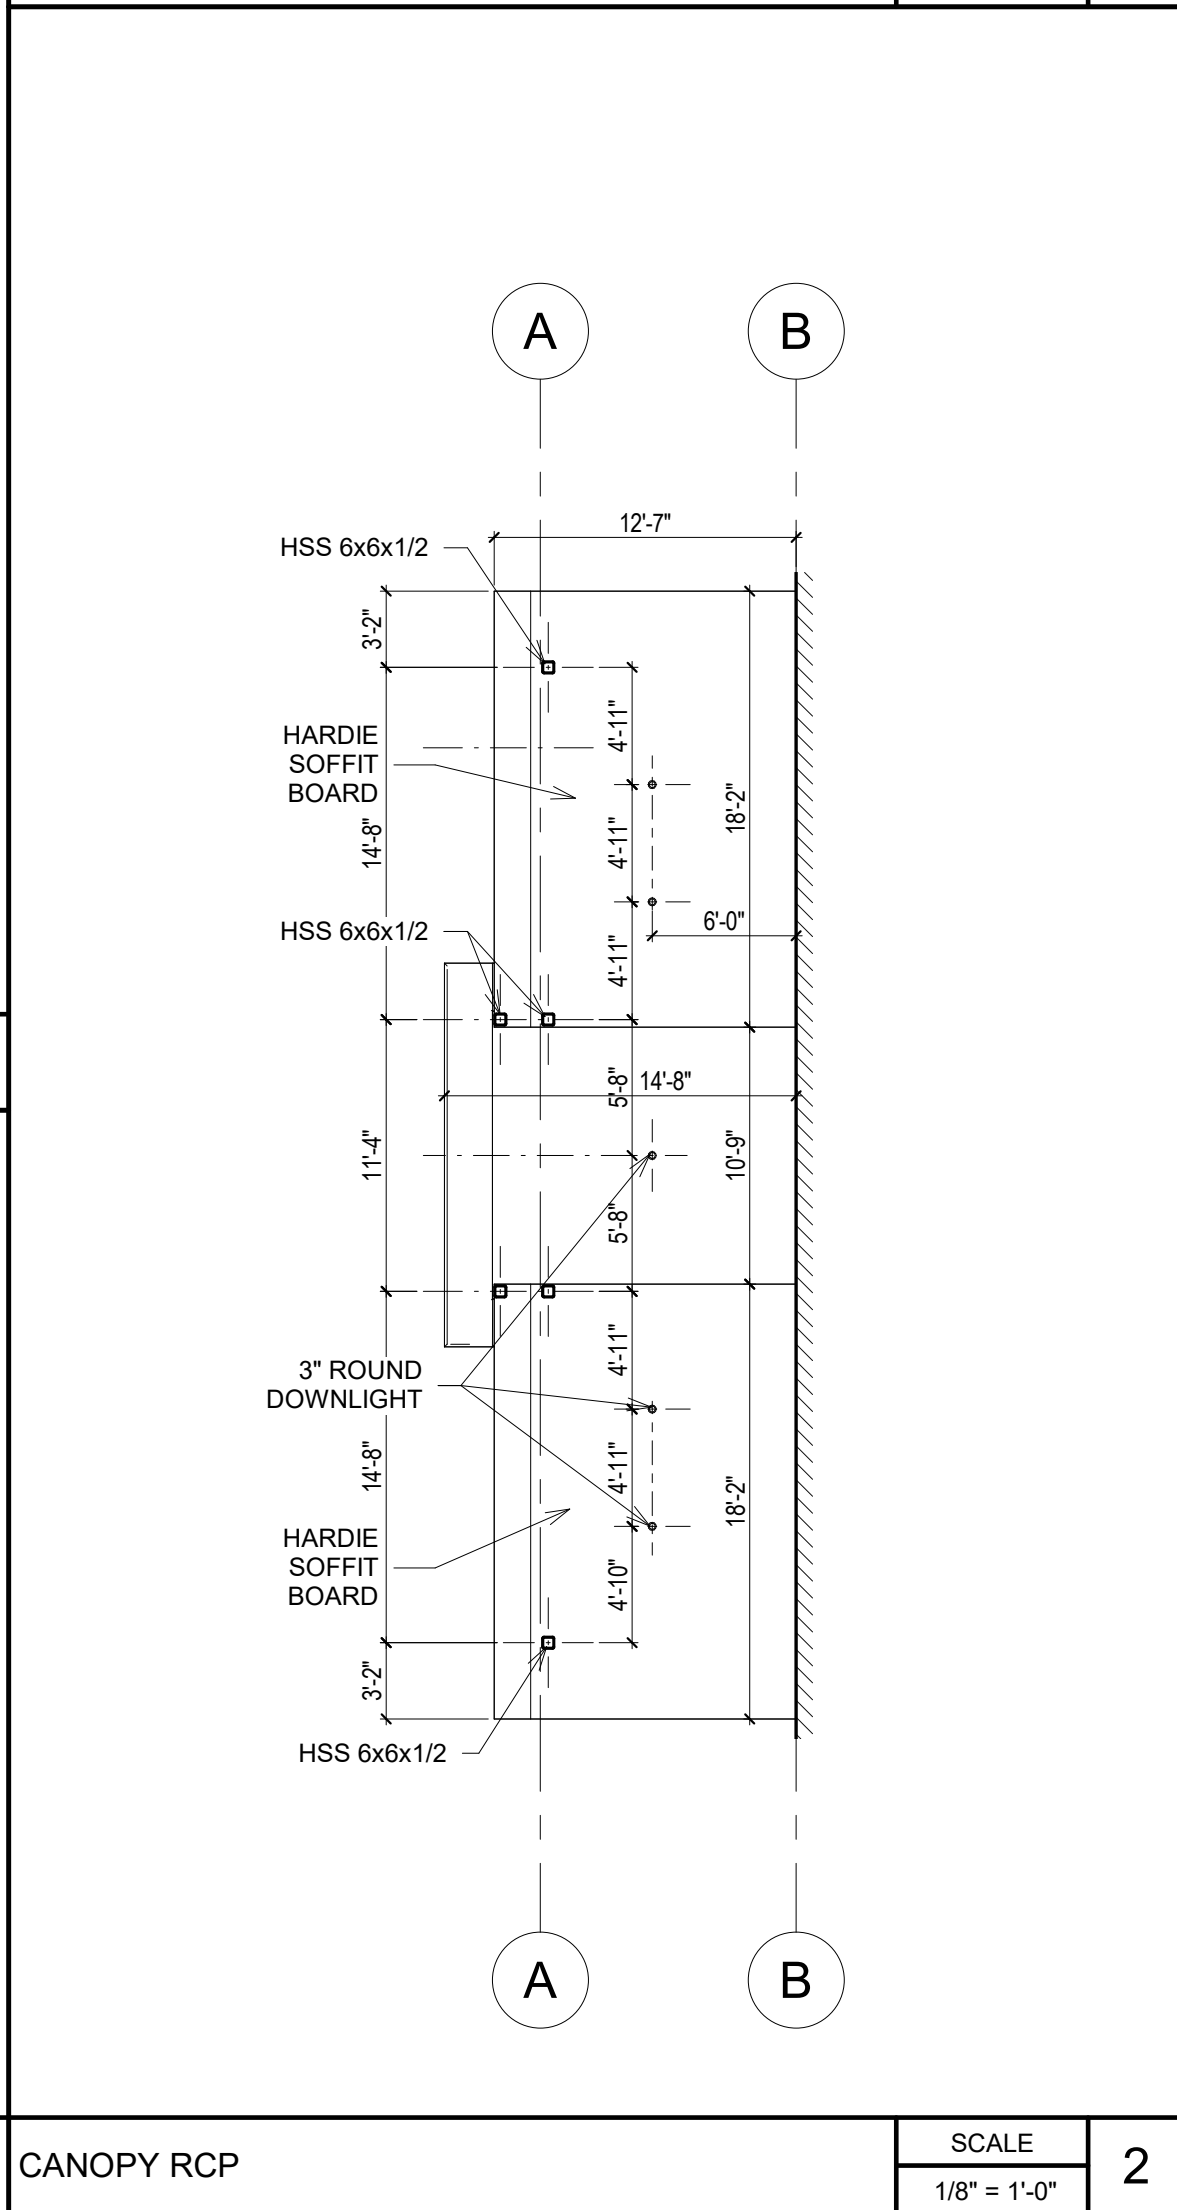

WINDOW SCHEDULE												
MARK	WINDOW TYPE	SIZE		GLAZING	FRAME		FIRE RATING	DETAILS				REMARKS
		WIDTH	HEIGHT		MATERIAL	FINISH		HEAD	JAMB 1	JAMB 2	SILL	
E1	A	4' - 0"	4' - 0"	3	AL	F		9/A-502	10/A-502			
E2	B	4' - 7 1/8"	3' - 7"	3	AL	F		9/A-502	10/A-502			9 Windows - See Elevation
E3	C	4' - 11 5/8"	3' - 7"	3	AL	F		9/A-502	10/A-502			9 Windows - See Elevation
E4	D	10' - 8"	7' - 4"	1,3	AL	F		9/A-502	10/A-502			
E5	E	5' - 4"	7' - 4"	1,3	AL	F		9/A-502	10/A-502			
E6	F	10' - 8"	7' - 4"	1,3	AL	F		9/A-502	10/A-502			

WINDOW

- GLAZING:
1. TEMPERED GLASS
 2. WIRE GLASS
 3. DUAL GLAZING
 4. SINGLE GLAZING
 5. FIRE PROTECTION RATED GLAZING

FRAME

- MATERIAL:
- AL ALUMINUM
 - HM HOLLOW METAL
 - E EXISTING
 - VL VINYL FRAME MATERIAL


- FINISH:
- P PAINTED
 - F FACTORY APPLIED
 - E EXISTING FINISH

STOREFRONT NOTES:


- T DENOTES TEMPERED GLASS
- 10 CUSTOM WINDOW SEE WINDOW SCHEDULE
- 1 PRE-MANUFACTURED WINDOWS SEE WINDOW SCHEDULE

GLAZING NOTES


1. ALL EXTERIOR GLAZING TO COMPLY WITH THE FOLLOWING TITLE 24 REQUIREMENTS:
 - A. U-FACTOR: 0.00
 - B. SHGC: 0.00
 - C. VT: 0.00
2. ALL EXTERIOSOLARBAN 70XL SOLEXIA 1-INCH INSULATED LOW-E VITRO OR EQUAL

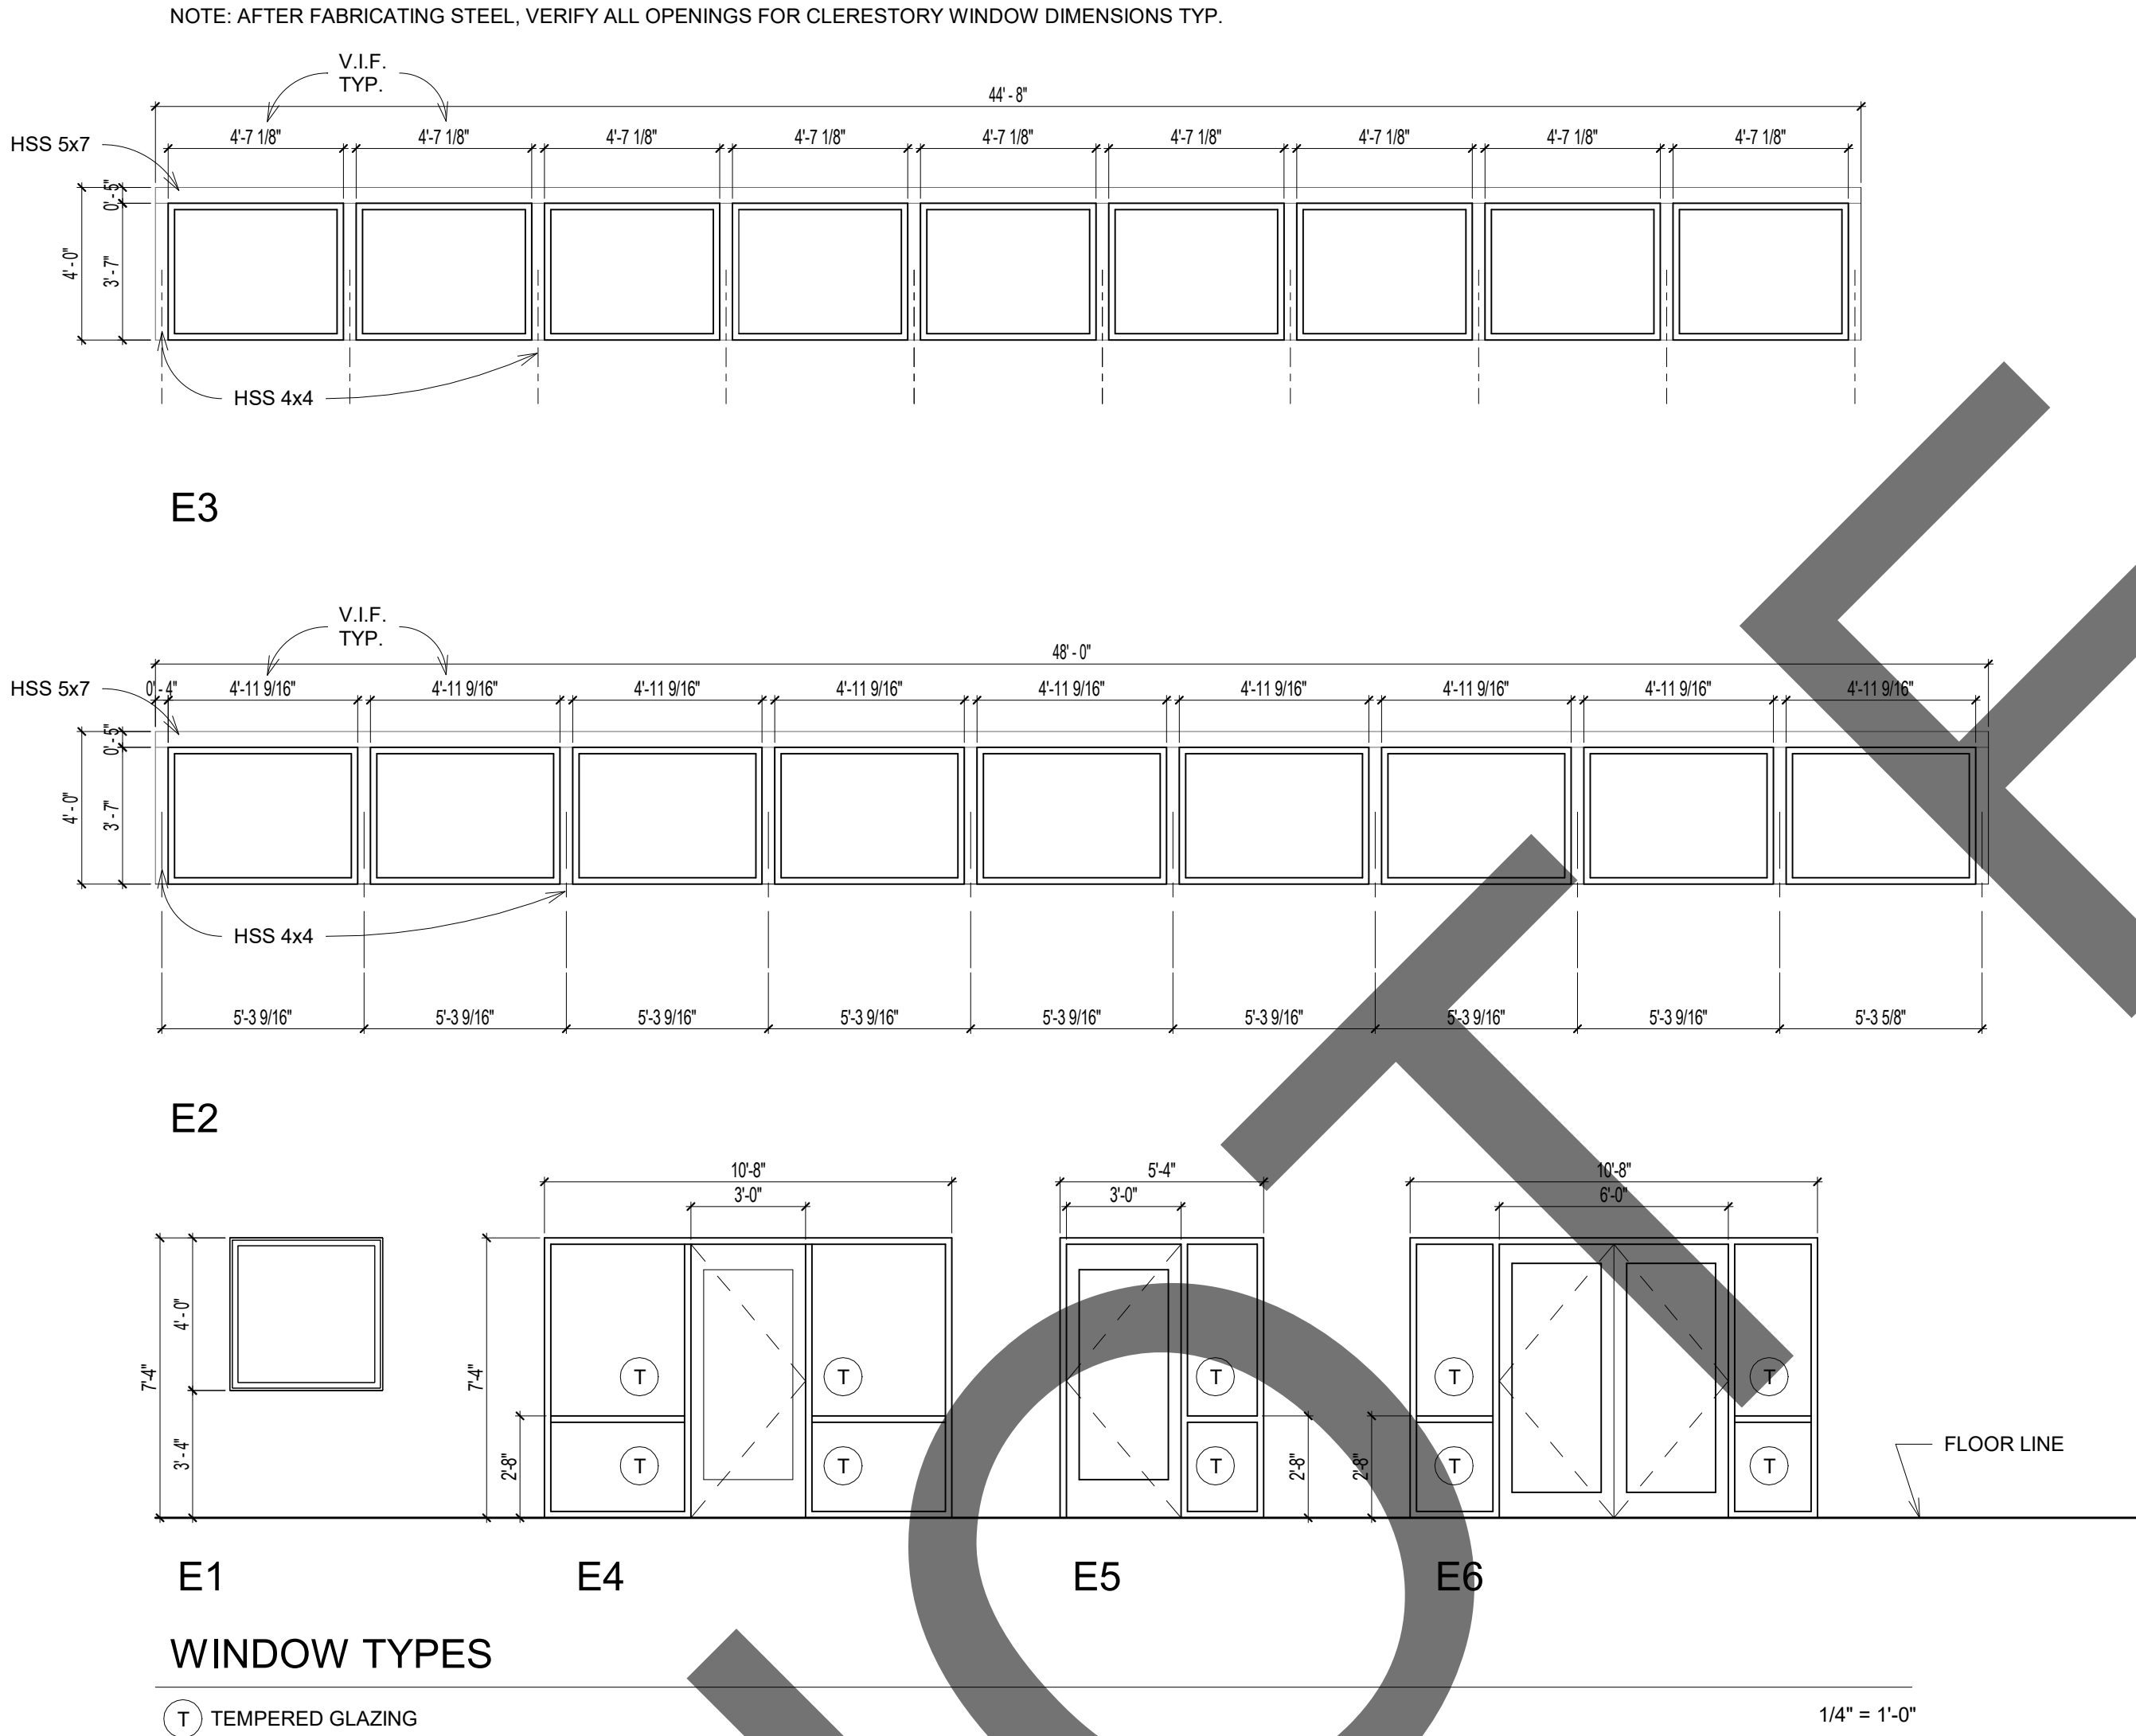


DOOR SCHEDULE														
DOOR NUMBER	TYPE	PAIR OR SINGLE	SIZE		DOOR		FRAME		DETAIL				REMARKS	
			WIDTH	HEIGHT	FINISH	MATERIAL	FINISH	MATERIAL	HEAD	JAMB 1	JAMB 2	SILL		
1A	A	S	3' - 0"	7' - 0"	F	AL/G	F	AL	5/A-502	4/A-502			R7,R8	
1B	C	S	12' - 0"	8' - 0"	F	AL/G	F	AL	18/A-502	19/A-502		20/A-502	R7	
1C	C	S	12' - 0"	8' - 0"	F	AL/G	F	AL	18/A-502	19/A-502		20/A-502	R7	
1D	C	S	12' - 0"	8' - 0"	F	AL/G	F	AL	18/A-502	19/A-502		20/A-502	R7	
2	A	S	3' - 0"	7' - 0"	F	AL/G	F	AL	5/A-502	4/A-502	11/A-501	4/A-501	R7,R8	
3A	A	S	3' - 0"	7' - 0"	F	AL/G	F	AL	5/A-502	4/A-502	3/A-502		R8	
3B	A	S	3' - 0"	7' - 0"	F	AL/G	F	AL	5/A-502	4/A-502	3/A-502		R8	
4	B	S	3' - 0"	7' - 0"	F	F	F	F	14/A-501	15/A-501			Lower Half Opaque to Remove Outside Distractions	
5	B	S	3' - 0"	7' - 0"	F	F	F	F	14/A-501	15/A-501				
6A	A	S	3' - 0"	7' - 0"	F	AL/G	F	AL	5/A-502	4/A-502			R8	
6B	C	S	12' - 0"	8' - 0"	F	AL/G	F	AL	18/A-502	19/A-502		20/A-502	R7	
6C	C	S	12' - 0"	8' - 0"	F	AL/G	F	AL	18/A-502	19/A-502		20/A-502	R7	
6D	C	S	12' - 0"	8' - 0"	F	AL/G	F	AL	18/A-502	19/A-502		20/A-502	R7	
6E	G	S	3' - 0"	7' - 0"	F	F	F	F	14/A-501	15/A-501		4/A-501	R7,R8	
7A	D	P	6' - 0"	7' - 0"	F	AL/G	F	AL	5/A-502	3/A-502			R8	
7B	G	S	3' - 0"	7' - 0"	F	F	F	F	14/A-501	15/A-501		4/A-501	R7,R8	
8A	A	S	3' - 0"	7' - 0"	F	AL/G	F	AL	5/A-502	4/A-502	3/A-502		R8	
8B	C	S	12' - 0"	8' - 0"	F	AL/G	F	AL	18/A-502	19/A-502		20/A-502	R7	
8C	C	S	12' - 0"	8' - 0"	F	AL/G	F	AL	18/A-502	19/A-502		20/A-502	R7	
8D	C	S	12' - 0"	8' - 0"	F	AL/G	F	AL	18/A-502	19/A-502		20/A-502	R7	
8E	G	S	3' - 0"	7' - 0"	F	F	F	F	14/A-501	15/A-501		20/A-502	R7,R8	
9	B	S	3' - 0"	7' - 0"	F	F	F	F	14/A-501	15/A-501		20/A-502	R8	
10	B	S	3' - 0"	7' - 0"	F	F	F	F	14/A-501	15/A-501		20/A-502	R8	
11	A	S	3' - 0"	7' - 0"	F	AL/G	F	AL	5/A-502	4/A-502	3/A-502		R7,R8	
12A	A	S	3' - 0"	7' - 0"	F	AL/G	F	AL	5/A-502	4/A-502	3/A-502		R7,R8	
12B	C	S	12' - 0"	8' - 0"	F	AL/G	F	AL	18/A-502	19/A-502		20/A-502	R7	
12C	C	S	12' - 0"	8' - 0"	F	AL/G	F	AL	18/A-502	19/A-502		20/A-502	R7	
12D	C	S	12' - 0"	8' - 0"	F	AL/G	F	AL	18/A-502	19/A-502		20/A-502	R7	
13A	A	S	3' - 0"	7' - 0"	F	AL/G	F	AL	5/A-502	3/A-502		4/A-501	R7,R8	
13B	A	S	3' - 0"	7' - 0"	F	AL/G	F	AL	5/A-502	4/A-502			R8	
13C	A	S	3' - 0"	7' - 0"	F	AL/G	F	AL	5/A-502	4/A-502			R8	

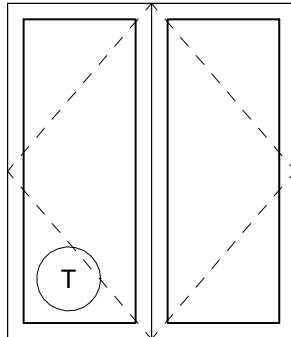


D DOUBLE FULL GLASS DOOR

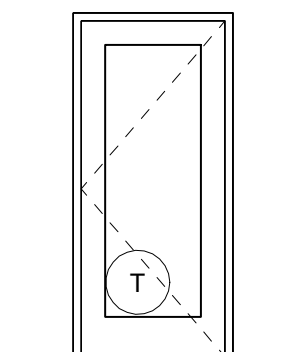

A SINGLE EXTERIOR/ INTERIOR GLASS DOOR

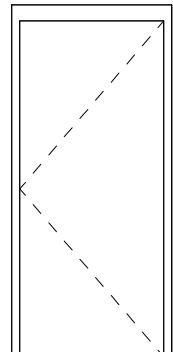

B SINGLE FLUSH EXTERIOR DOOR

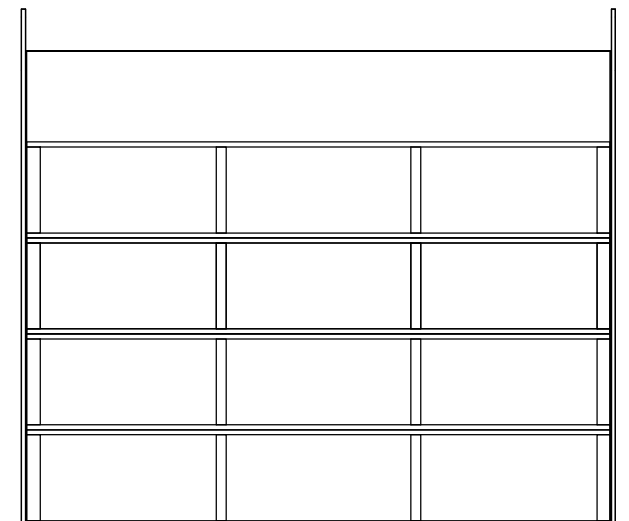

C SECTIONAL DOOR WITH GLASS PANELS

DOOR TYPES

T TEMPERED GLAZING

1/4" = 1'-0"

DOOR GENERAL NOTES:

1. EXIT DOORS SHALL BE OPERABLE FROM THE INSIDE WITHOUT THE USE OF A KEY OR SPECIAL KNOWLEDGE OR EFFORT.
2. GLASS AND GLAZING SHALL COMPLY WITH CBC CHAPTER 24.
3. MAXIMUM EFFORT TO OPERATE DOORS:
 - EXTERIOR - 5.0 LBS
 - INTERIOR - 5.0 LBS
4. VERIFY ALL DOOR FRAME THROAT SIZES WITH FINISHED WALL THICKNESS PRIOR TO ORDERING FRAMES.
5. ALL HAND ACTIVATED DOOR OPENING HARDWARE AT LATCHING OR LOCKING DOORS ON THE ACCESSIBLE PATH OF TRAVEL SHALL BE OPERABLE WITH SINGLE EFFORT LEVER TYPE HARDWARE, PANIC BARS, PUSH/PULL ACTIVATING BARS OR OTHER HARDWARE DESIGNED TO PROVIDE PASSAGE WITHOUT REQUIRING THE ABILITY TO GRASP THE HARDWARE.
6. MAIN ENTRY DOOR SHALL BE PROVIDED WITH AN INDICATING FLAG LOCK AND REQUIRED DECAL ON HEADER STATING, "THIS DOOR TO REMAIN UNLOCKED WHEN THIS SPACE IS OCCUPIED PER CBC 1010.1.9.3
7. FIRE DOORS SHALL BE LATCHED AN SELF OR AUTOMATIC-CLOSING IN ACCORDANCE WITH SECTION 716.2.6.1.
8. CHUTE INTAKE DOORS SHALL BE POSITIVE LATCHING, REMAINING LATCHED AND CLOSED IN THE EVENT OF LATCH SPRING FAILURE DURING A FIRE EMERGENCY.
9. ALL UNIT NUMBERS TO BE A MIN. OF 4" HIGH INSTALLED ON A CONTRASTING BACKGROUND.

DOOR SCHEDULE LEGEND:

DOOR:

- MATERIAL
- AL ALUMINUM
 - WD WOOD
 - M METAL
 - G GLASS
 - V VINYL

FINISH

- SCF STAIN & CLEAR FINISH
- P PAINT
- F FACTORY APPLIED
- T TEMPERED GLASS
- E EXISTING FINISH

FRAME:

- MATERIAL
- AL ALUMINUM
 - HM HOLLOW METAL
 - M METAL
 - E EXISTING
 - F FIBERGLASS

FINISH

- P PAINT
- F FACTORY APPLIED
- E EXISTING FINISH

REMARKS:

- R1 ACCESSIBILITY SIGN
- R2 PANIC DEVICE
- R3 CARD READER
- R4 METAL KICK PLATES
- R5 PANIC DEVICE
- R6 SMOKE GASKET
- R7 WEATHERSTRIP
- R8 CLOSER



architecture
interiors
planning

1177 Idaho Street, Suite 200
Redlands, CA 92374
Phone: 909-335-7400
Fax: 909-335-7299
info@miller-aip.com



owner approval

initials	date	phase

REVISIONS/ADDENDA

Date Comment

ANIMAL CARE CENTER

18313 VALLEY BLVD. BLOOMINGTON, CA 92313

SAN BERNARDINO COUNTY

385 N. ARROWHEAD AVENUE
SAN BERNARDINO, CA 92415
PHONE: 1-888-818-8968

PROJECT INFORMATION

Project Number: 2200065
Drawn By: Author
Checked By: GWM
Issue Date: 2/29/24

SHEET NAME

WINDOW/DOOR
SHCHEDULE

SHEET NUMBER

AE 601

Sheet Of Sheets

ROOM FINISH SCHEDULE														
ROOM NUMBER	ROOM	FLOOR MATERIAL	BASE MATERIAL	WALL FINISH				WAINSCOT FINISH				CEILING HEIGHT	CEILING MATERIAL	REMARKS
				A	B	C	D	A	B	C	D			
1	OUTDOOR RUN	F5	B4	W5	W5	W5	W5					8' - 0"	C4	
2	VESTABULE	F5	B4	W5	W5	W5	W5					8' - 0"	C4	
3	HALLWAY	F5	B4	W5	W5	W5	W5					8' - 0"	C4	
4	GET AQUAINTED	F5	B4	W5	W5	W5	W5					8' - 0"	C4	
5	MDF	F3	B1	W5	W5	W5	W5					8' - 0"	C4	
6	OUTDOOR RUN	F5	B4	W5	W5	W5	W5					8' - 0"	C4	
7	DOG POD 2	F5	B4	W5	W5	W5	W5					8' - 0"	C4	
8	OUTDOOR RUN	F5	B4	W5	W5	W5	W5					8' - 0"	C4	
9	ELECTRICAL	F4	B1	W5	W5	W5	W5					8' - 0"	C4	
10	CLEANING EQUIP.	F4	B1	W5	W5	W5	W5					8' - 0"	C4	
11	VESTABULE	F5	B4	W5	W5	W5	W5					8' - 0"	C4	
12	OUTDOOR RUN	F5	B4	W5	W5	W5	W5					8' - 0"	C4	
13	DOG POD 1	F5	B4	W5	W5	W5	W5					8' - 0"	C4	
14	GET AQUAINTED	F5	B4	W5	W5	W5	W5					8' - 0"	C4	
15	GET AQUAINTED	F5	B4	W5	W5	W5	W5					8' - 0"	C4	
FLOOR MATERIAL: F1 CARPET F2 CERAMIC TILE F3 VINYL TILE F4 SEALED CONCRETE F5 EPOXY BASE MATERIAL: B1 RUBBER COVE BASE B2 CARPET B3 CERAMIC TILE B4 EPOXY RESIN COVED 4" WALL MATERIAL: W1 GYPSUM BOARD - TEXTURED AND PAINTED W2 CERAMIC TILE W3 EXPOSED FRAMING W4 FRP W5 2 LAYERS OF BLOCK FILLER + EPOXY PAINT CEILING: C1 SUSPENDED ACOUSTICAL CEILING C2 GYPSUM BOARD - TEXTURED AND PAINTED C3 EXPOSED FRAMING C4 CERAMAGUARD WITH SOUND ABSORPTION REMARKS: R1 W-2 WAINSCOTING TO BE 8'-0" R2 W-4 WAINSCOTING TO BE 4'-0" R3 X R4 X R5 X R6 X GENERAL NOTES: 1. INTERIOR FINISH MATERIALS SHALL COMPLY WITH 2022 CBC CHAPTER 12. 2. WATER RESISTANT GYPSUM BOARD COMPLYING WITH 2022 CBC SECTION 2509 TO BE USED IN TOILET ROOMS. 3. GYPSUM BOARD TO BE 5/8" TYPE "X" UNLESS NOTED OTHERWISE.														



architecture
interiors
planning

1177 Idaho Street, Suite 200
Redlands, CA 92374
Phone: 909-335-7400
Fax: 909-335-7299
info@miller-aip.com



owner approval		
initials	date	phase

REVISIONS/ADDENDA		
#	Date	Comment

ANIMAL CARE CENTER

18313 VALLEY BLVD. BLOOMINGTON, CA 92313

SAN BERNARDINO COUNTY

385 N. ARROWHEAD AVENUE
SAN BERNARDINO, CA 92415
PHONE: 1-888-818-8868


PROJECT INFORMATION	
Project Number:	2200065
Drawn By:	Author
Checked By:	GWM
Issue Date:	2/29/24

SHEET NAME

FINISH
SCHEDULE


SHEET NUMBER

AE 602

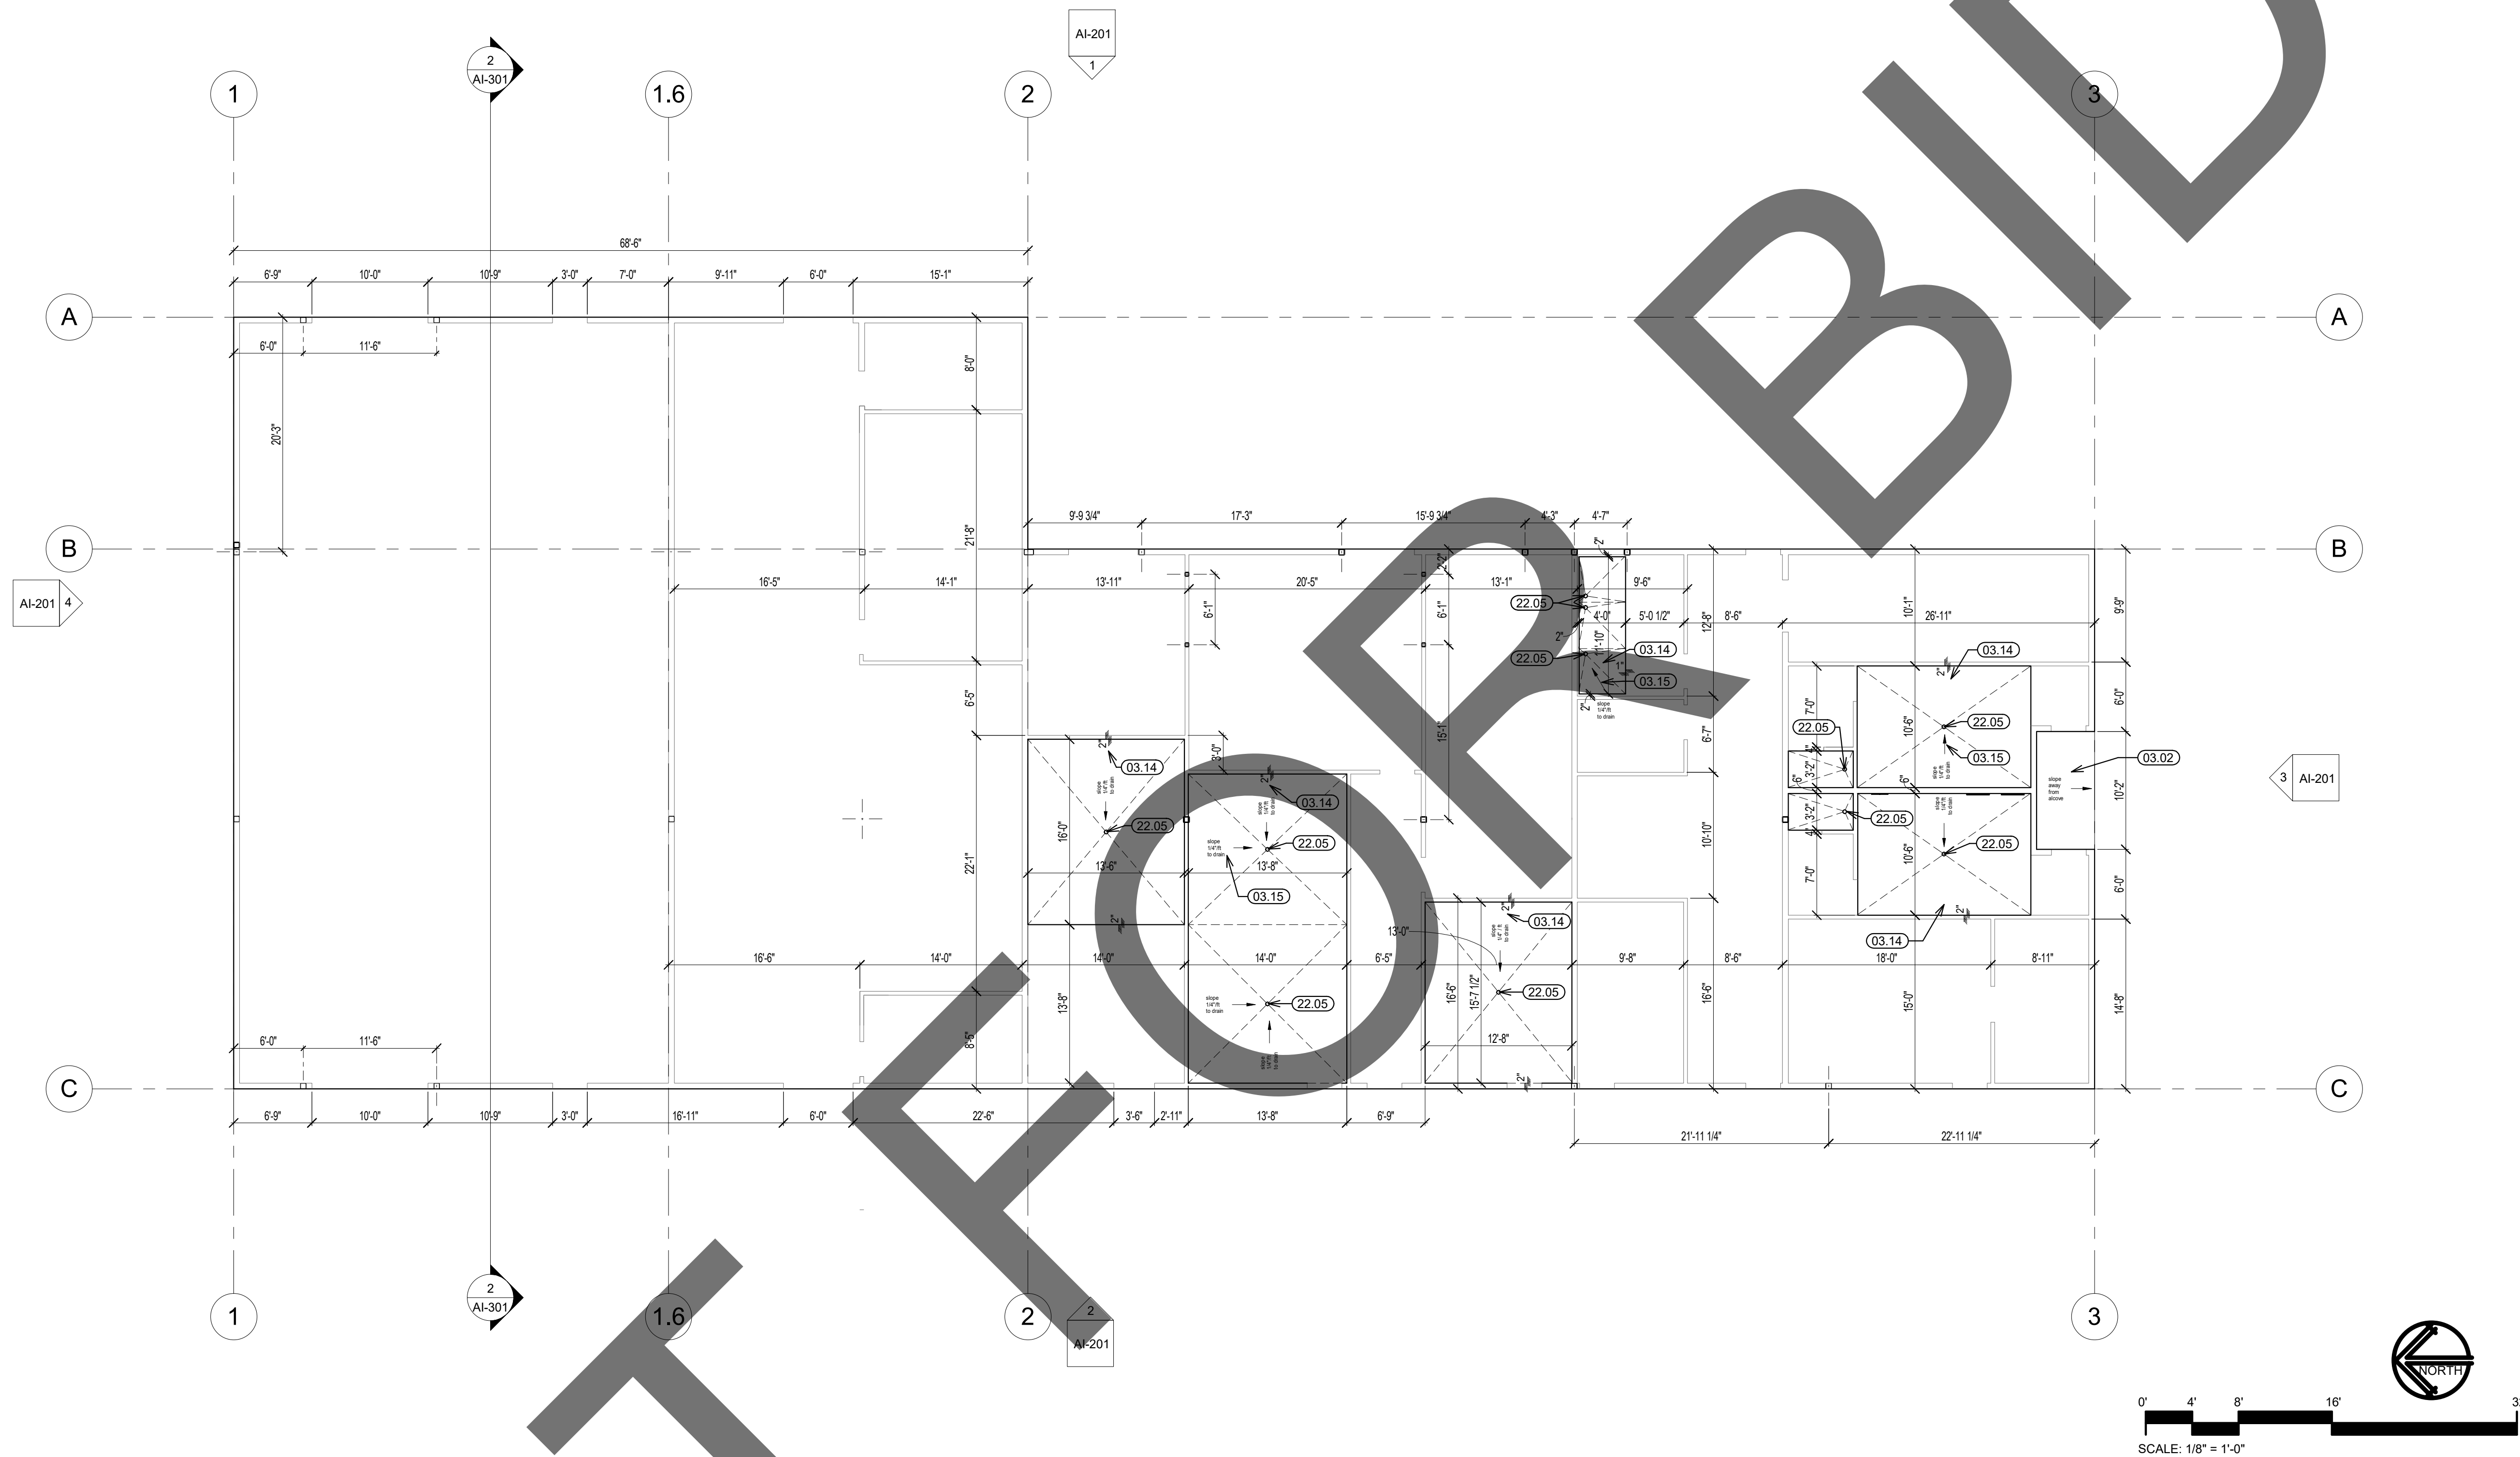

SUPPORT LAYOUT FLOOR PLAN

<u>KEYNOTE LEGEND</u>	
CSI#	KEYNOTE TEXT
03.02	Exterior Concrete
03.14	Depress Slab as Shown
03.15	Slope Indicates Final Slab Finish
22.05	Floor Drain - See Plumbing Drawings

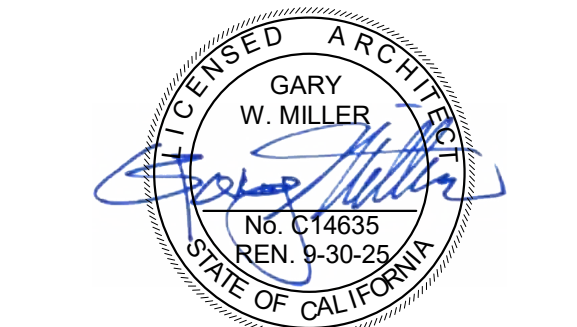

owner approval

initials	date	phase

REVISIONS/ADDENDA

#	Date	Comment
---	------	---------

ANIMAL CARE CENTER
18313 VALLEY BLVD.
BLOOMINGTON, CA 92313

SAN BERNARDINO COUNTY
365 N. ARROWHEAD AVENUE
SAN BERNARDINO, CA 92415
PHONE: 1-888-818-4988

PROJECT INFORMATION	PROJECT NO.	DATE	SHEET NO.	SHEET TOTAL	PROJECT TITLE	PROJECT LOCATION	PROJECT DESCRIPTION	PROJECT STATUS
---------------------	-------------	------	-----------	-------------	---------------	------------------	---------------------	----------------

Project Number:	2200065
Drawn By:	Author
Checked By:	GWM
Issue Date:	2/29/24


SHEET NAME

SUPPORT LAYOUT PLAN

SHEET NUMBER

AI100

Sheet	Of	Sheets
-------	----	--------

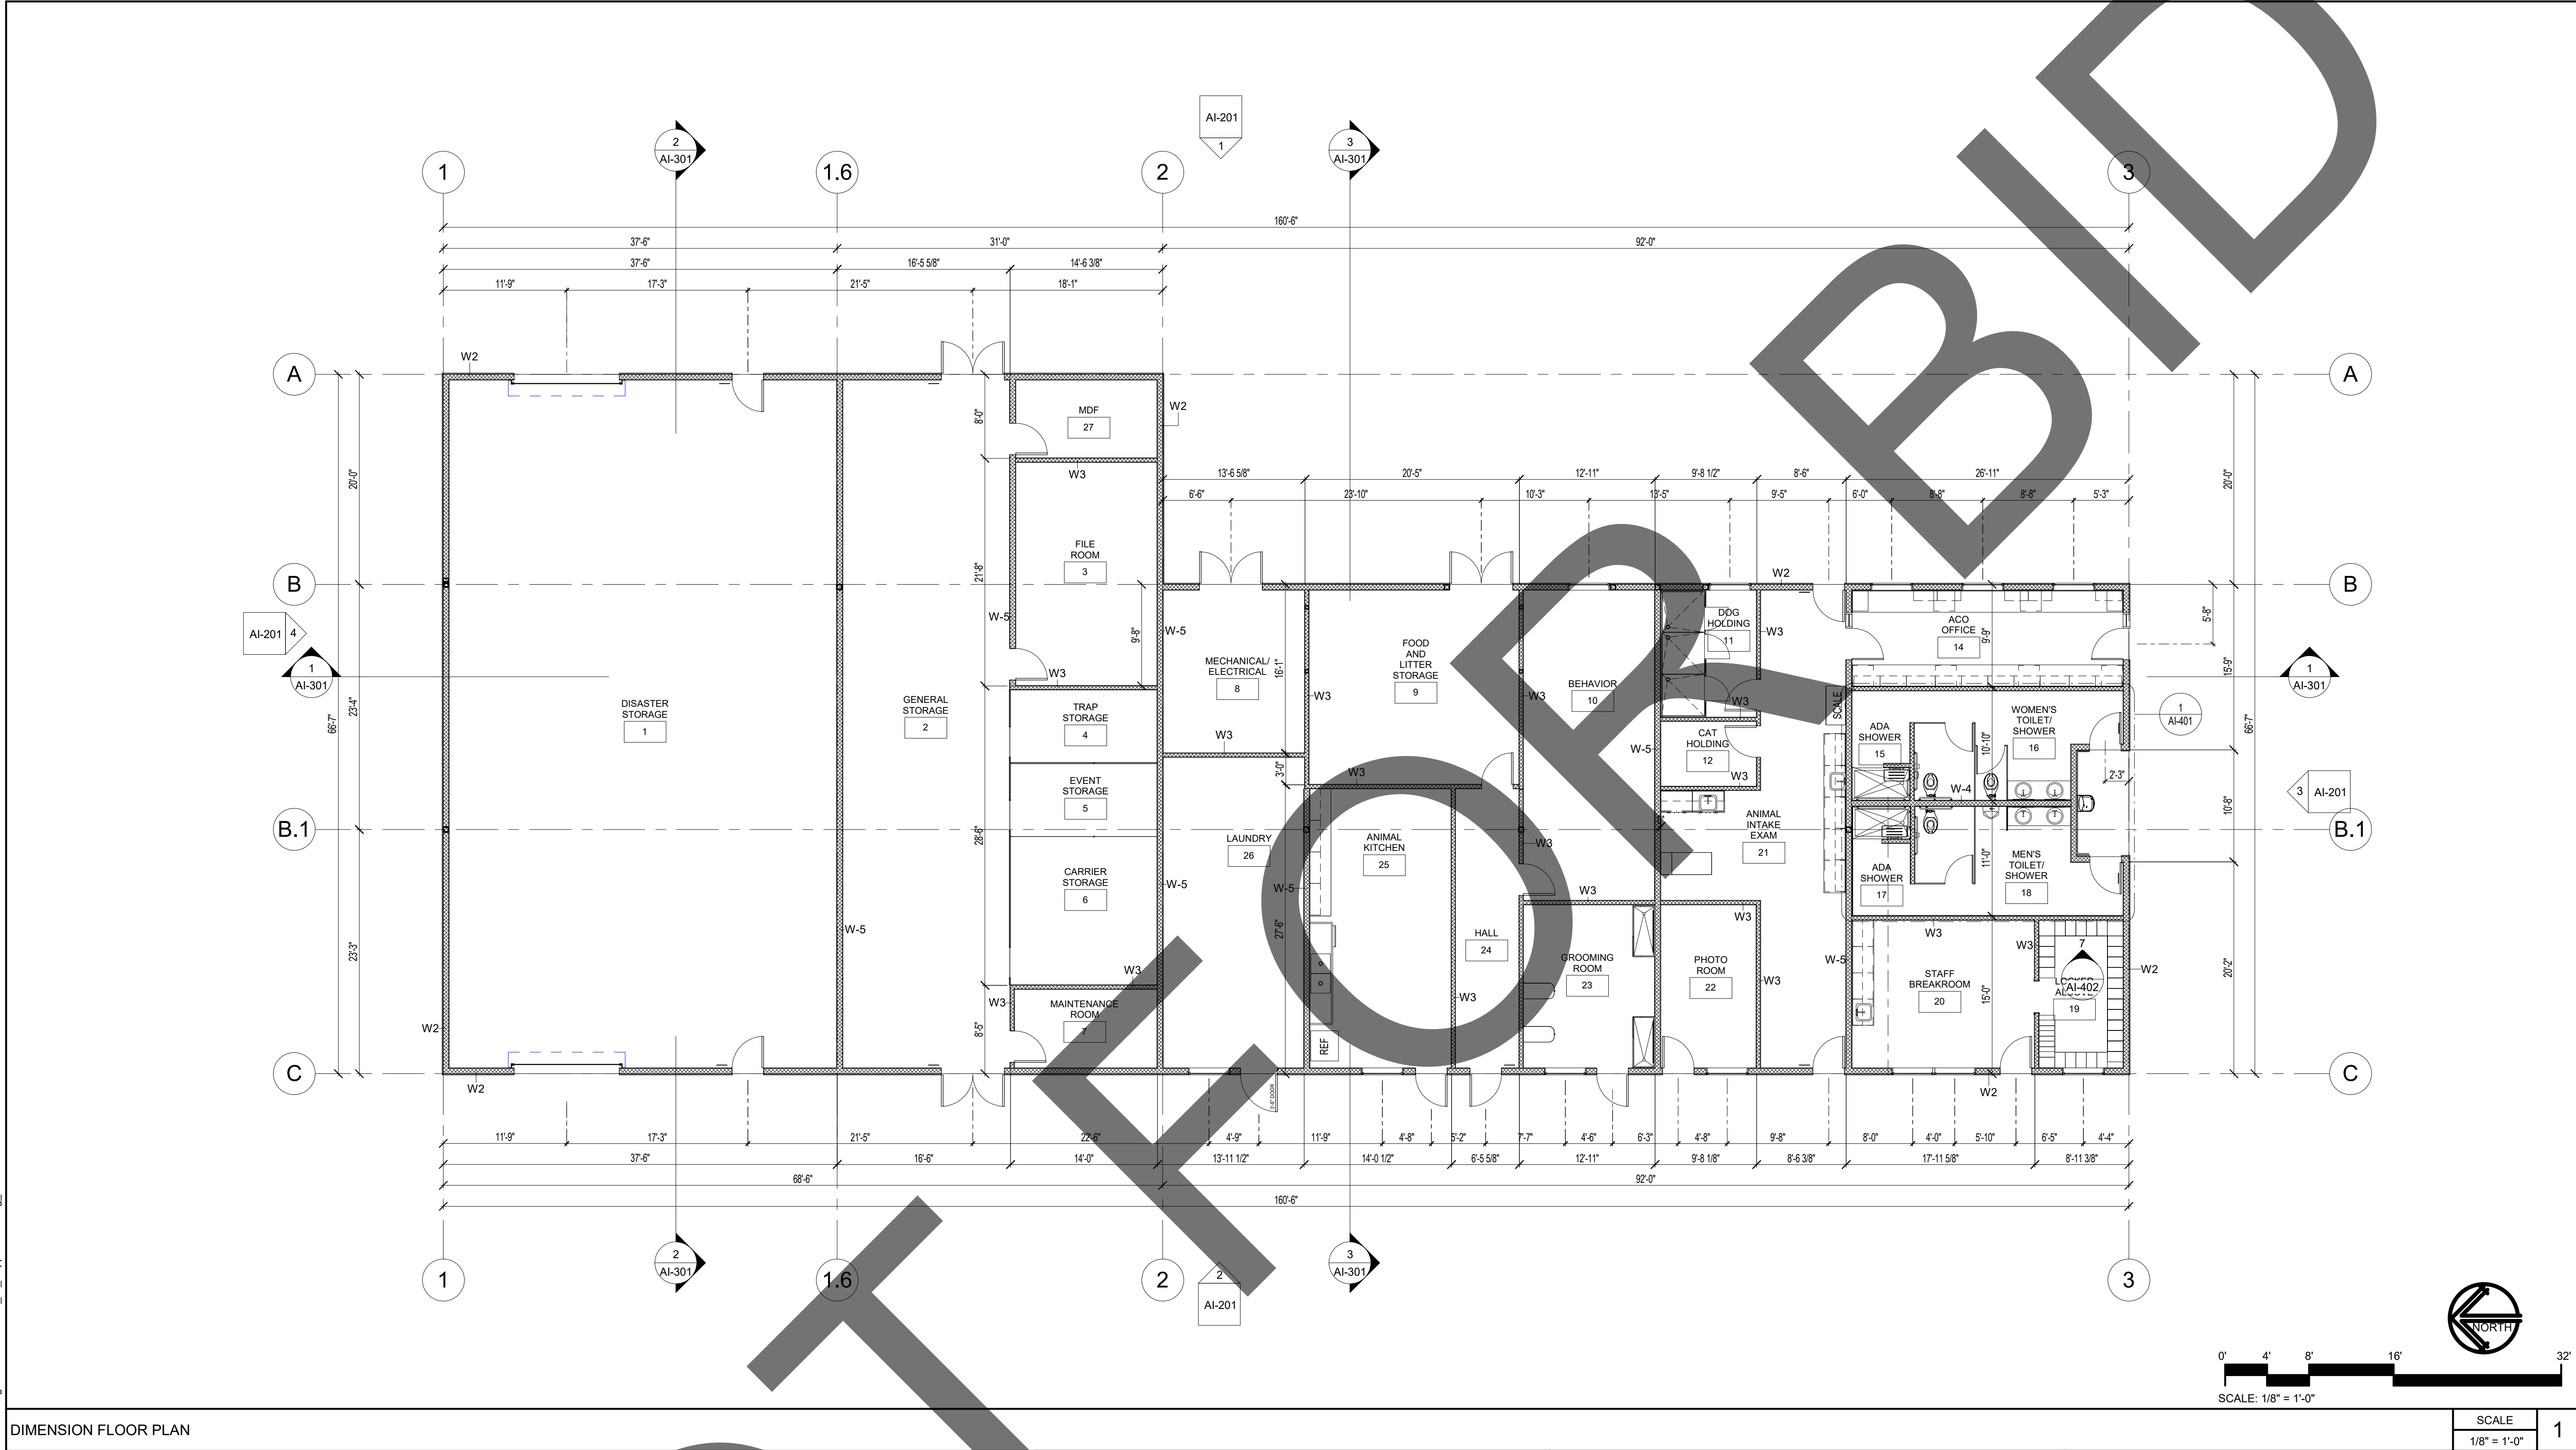

DIMENSION FLOOR PLAN

GENERAL FLOOR PLAN NOTES:

1. QUANTITIES LISTED ON THESE DOCUMENTS ARE FOR AGENCY APPROVAL ONLY. THE CONTRACTOR IS RESPONSIBLE FOR VERIFYING ALL QUANTITIES FOR BIDDING PURPOSES.
2. FINISH: PREPARE SUB-FLOOR AND LEAVE IN BROOM CLEAN CONDITION TO RECEIVE NEW FINISH AS REQUIRED. FLOOR SHALL BE LEVEL AND FREE OF DIPS, DIMPLES AND JOINTS.
3. REFER TO MECHANICAL, ELECTRICAL, AND PLUMBING DRAWINGS FOR ADDITIONAL SCOPE.
4. REFER TO ANIMAL EQUIPMENT DRAWINGS, SHEETS AE1 - AE8 FOR ADDITIONAL SCOPE. ALL EQUIPMENT AND FRNISHINGS ARE CONTRACTOR SUPPLIED AND CONTRACTOR INSTALLED.

WALL TYPE LEGEND

- STEEL STUDS PER SCHEDULE
- CMU MASONRY UNIT

WALL TYPE SCHEDULE

- W-1 6" STEEL STUDS @ 16" O.C. W/ R-19 BATT, R-14 RIGID INSULATION & TRESPA EXT.
- W-2 6" STEEL STUDS @ 16" O.C. W/ R-19 BATT, R-14 RIGID INSULATION & STUCCO EXT.
- W-3 4" STEEL STUDS @ 24" O.C. GYP. BD. BOTH SIDES
- W-4 4" STEEL STUDS @16" O.C. GYP. BD. BOTH SIDES
- W-5 6" STEEL STUDS @ 16" O.C. w/ 5/8" GYP. BD. BOTH SIDES
- W-6 8" MASONRY CMU BLOCK
- W-7 6" STEEL STUDS, SPACING PER STRUCTURAL, FINISH PER ELVATIONS
- W-8 6" MASONRY CMU BLOCK
- W-9 12" MASONRY CMU BLOCK

GENERAL - FLOOR PLAN NOTES


SCALE
12" = 1'-0"

WALL TYPE SCHEDULE

SCALE
1/4" = 1'-0"



1177 Idaho Street, Suite 200
Redlands, CA 92374
Phone: 909-335-7400
Fax: 909-335-7299
info@miller-aip.com

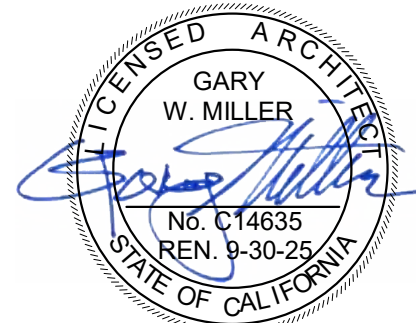

owner approval

initials	date	phase

REVISIONS/ADDENDA

#	Date	Comment
---	------	---------

ANIMAL CARE CENTER

18313 VALLEY BLVD.
BLOOMINGTON, CA 92313

SAN BERNARDINO COUNTY

385 N. ARROWHEAD AVENUE
SAN BERNARDINO, CA 92415
PHONE: 1-888-818-8968

PROJECT INFORMATION

Project Number:	2200065
Drawn By:	Author
Checked By:	GWM
Issue Date:	2/29/24


SHEET NAME

SUPPORT
BUILDING
DIMENSION
PLAN

SHEET NUMBER

AI101

Sheet Of Sheets

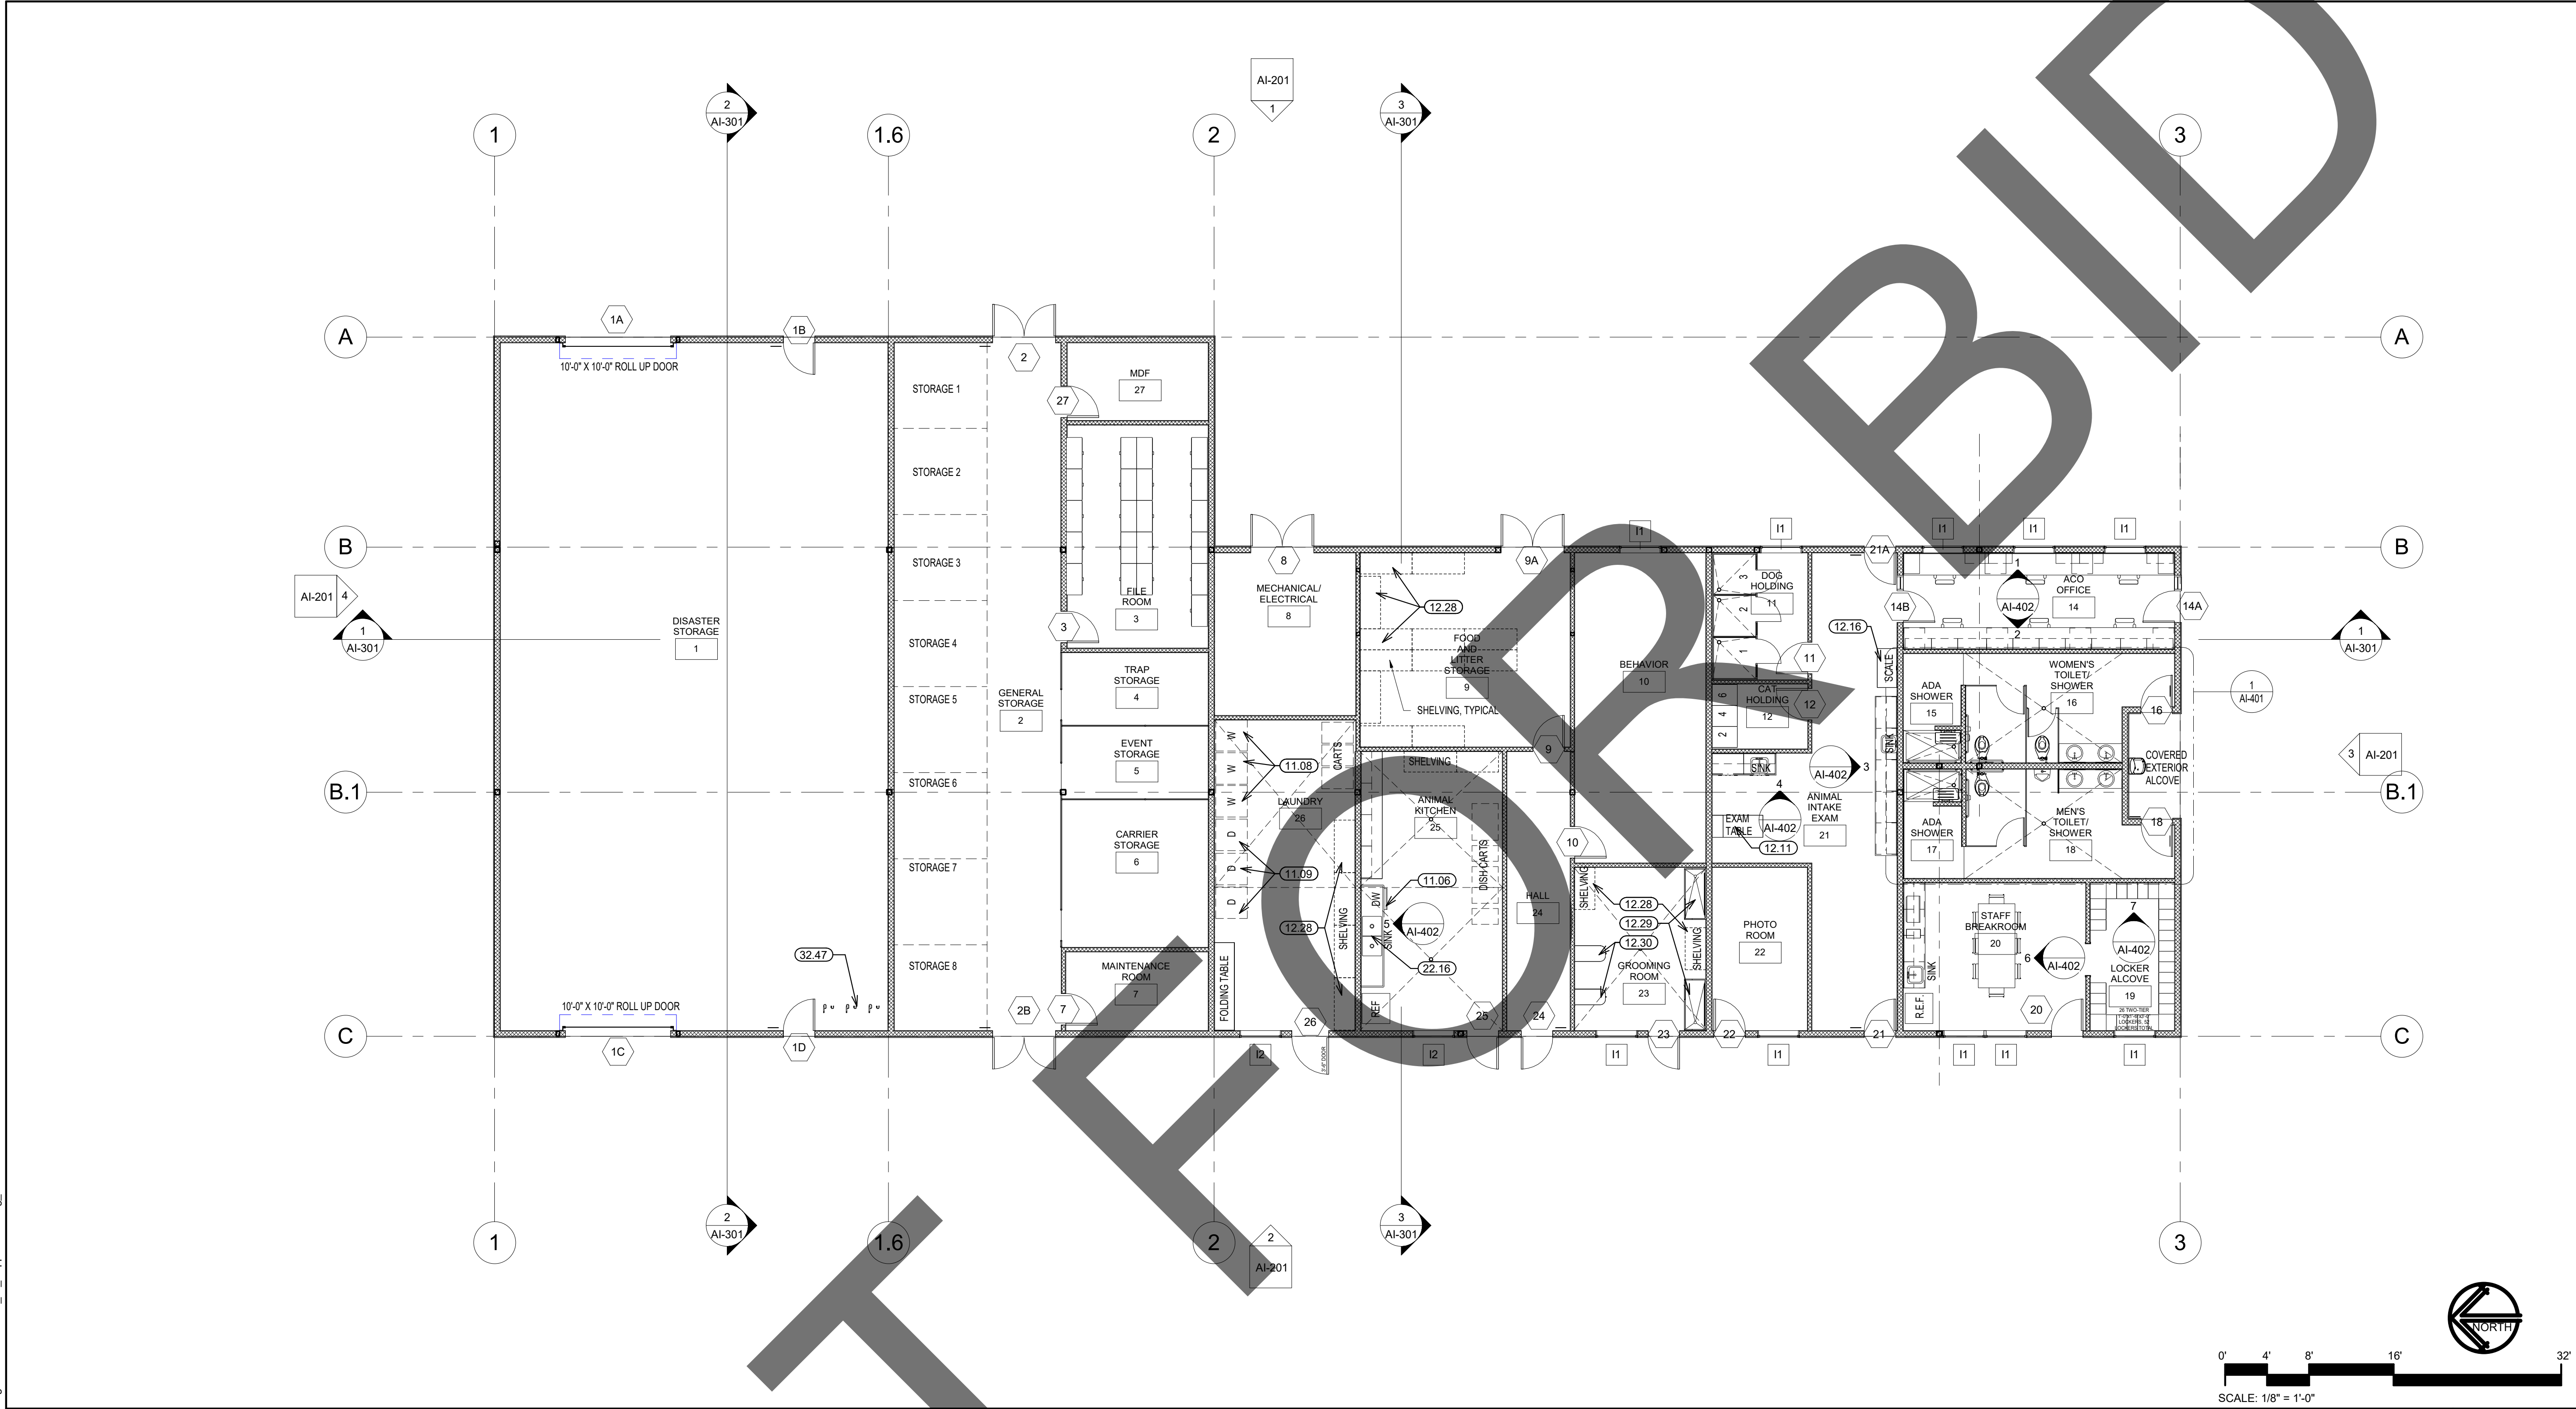

ANNOTATION FLOOR PLAN

GENERAL FLOOR PLAN NOTES:

1. QUANTITIES LISTED ON THESE DOCUMENTS ARE FOR AGENCY APPROVAL ONLY. THE CONTRACTOR IS RESPONSIBLE FOR VERIFYING ALL QUANTITIES FOR BIDDING PURPOSES.
2. FINISH: PREPARE SUB-FLOOR AND LEAVE IN BROOM CLEAN CONDITION TO RECEIVE NEW FINISH AS REQUIRED. FLOOR SHALL BE LEVEL AND FREE OF DIPS, DIMPLES AND JOINTS.
3. REFER TO MECHANICAL, ELECTRICAL, AND PLUMBING DRAWINGS FOR ADDITIONAL SCOPE.
4. REFER TO ANIMAL EQUIPMENT DRAWINGS, SHEETS AE1 - AE8 FOR ADDITIONAL SCOPE. ALL EQUIPMENT AND FRNISHINGS ARE CONTRACTOR SUPPLIED AND CONTRACTOR INSTALLED.

GENERAL - FLOOR PLAN NOTES

SCALE
12" = 1'-0"

KEYNOTE LEGEND

CSI #	KEYNOTE TEXT
11.06	Dishwasher - See Animal Equipment Drawings
11.08	Washer
11.09	Dryer
12.11	Exam + Treatment Table - See Animal Equipment Drawings
12.16	Scale - See Animal Equipment Drawings
12.28	Wire Shelving - See Animal Equipment Drawings
12.29	Grooming Tub - See Animal Equipment Drawings
12.30	Grooming Table - See Animal Equipment Drawings
22.16	2 Compartment S.S. Sink - Tabco Model
32.47	Five (5) Wall-Hung Long-Term Bicycle Parking in Support



1177 Idaho Street, Suite 200
Redlands, CA 92374
Phone: 909-335-7400
Fax: 909-335-7299
info@miller-aip.com



owner approval

initials	date	phase

REVISIONS/ADDENDA

#	Date	Comment
---	------	---------

ANIMAL CARE CENTER

18313 VALLEY BLVD.
BLOOMINGTON, CA 92313

SAN BERNARDINO COUNTY

385 N. ARROWHEAD AVENUE
SAN BERNARDINO, CA 92415
PHONE: 1-888-818-8988

PROJECT INFORMATION

Project Number:	2200065
Drawn By:	Author
Checked By:	GWM
Issue Date:	2/29/24


SHEET NAME

SUPPORT
BUILDING
ANNOTATION
PLAN

SHEET NUMBER

AI-102

Sheet Of Sheets

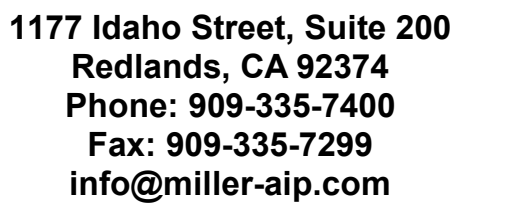


#	Date	Comment
---	------	---------

385 N. ARROWHEAD AVENUE
SAN BERNARDINO, CA 92415
PHONE: 1-888-818-8988

Project Number:	2200065
Drawn By:	Author
Checked By:	GWM
Issue Date:	2/29/24

SUPPORT
BUILDING
REFLECTED
CEILING PLAN

Sheet Of Sheets

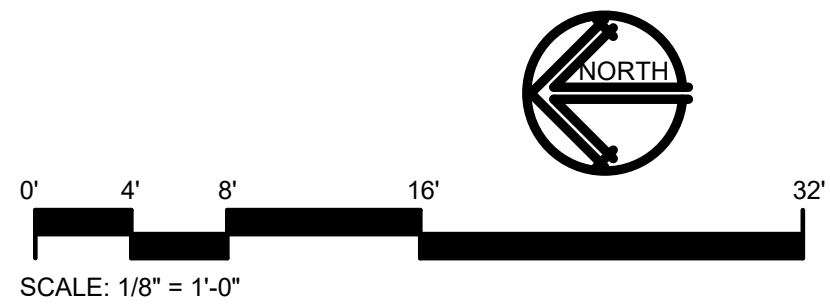

REFLECTED CEILING PLAN

SCALE	1
1/8" = 1'-0"	

	2x4 ACT SUSPENDED CEILING
	GYPSUM BOARD CEILING
	CEMENT PLASTER CEILING
	RECESSED LIGHT FIXTURE. SEE ELECTRICAL
	PENDANT LIGHT FIXTURE. SEE ELECTRICAL
	RECESSED LIGHT FIXTURE. SEE ELECTRICAL
	SURFACE MOUNTED LIGHT FIXTURE. SEE ELECTRICAL
	EXIT SIGN. SEE ELECTRICAL DRAWINGS.
	EXHAUST. SEE ELECTRICAL DRAWINGS.
	SUPPLY / RETURN GRILLE. SEE MECHANICAL
0'-0" +	CEILING HEIGHT



CEILING LEGEND	SCALE
	1/8" = 1'-0"

1. QUANTITIES LISTED ON THESE DOCUMENTS ARE FOR AGENCY APPROVAL ONLY. THE CONTRACTOR IS RESPONSIBLE FOR VERIFYING ALL QUANTITIES FOR BIDDING PURPOSES.
2. ALL NEW WORK SHALL CONFORM TO CURRENT BUILDING STANDARDS, UNLESS NOTED OTHERWISE.
3. CONTRACTOR TO VERIFY EXISTING CONSTRUCTION WITHIN THE SCOPE OF WORK TO ENSURE CONFORMANCE WITH NOTED RATINGS AND LOCAL CODES. RETROFIT NON-CONFORMING CONSTRUCTION AS REQUIRED.
4. SUSPENSION SYSTEM TO BE "PRELUDE XL" AS MANUFACTURED BY ARMSTRONG WORLD INDUSTRIES, INC. OR EQUAL AS APPROVED BY ARCHITECT.
5. PERIODIC INSPECTION OF THE CEILING SUSPENSION SYSTEM SHALL BE PROVIDED IN ACCORDANCE WITH MANUFACTURER'S REQUIREMENTS FOR SPECIFIED COMPONENTS AND CEILING ANCHORAGE SYSTEM.
6. REFER TO MECHANICAL, ELECTRICAL, AND PLUMBING DRAWINGS FOR ADDITIONAL SCOPE.

GENERAL - RCP NOTES	SCALE
	12" = 1'-0"

CSI #	KEYNOTE TEXT
09.03	5/8" Gypsum Board
09.12	Suspended Ceiling w/ Acoustical Panels


Roof Plan

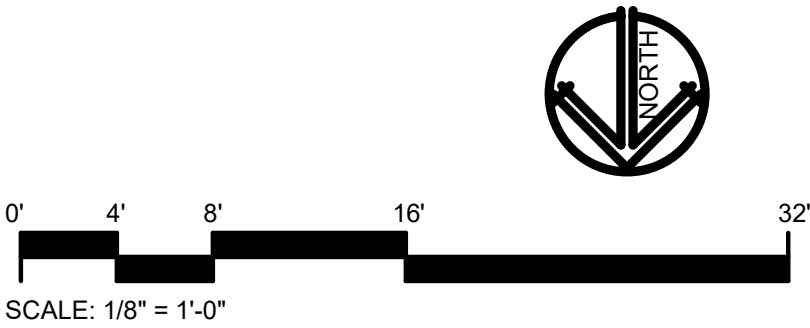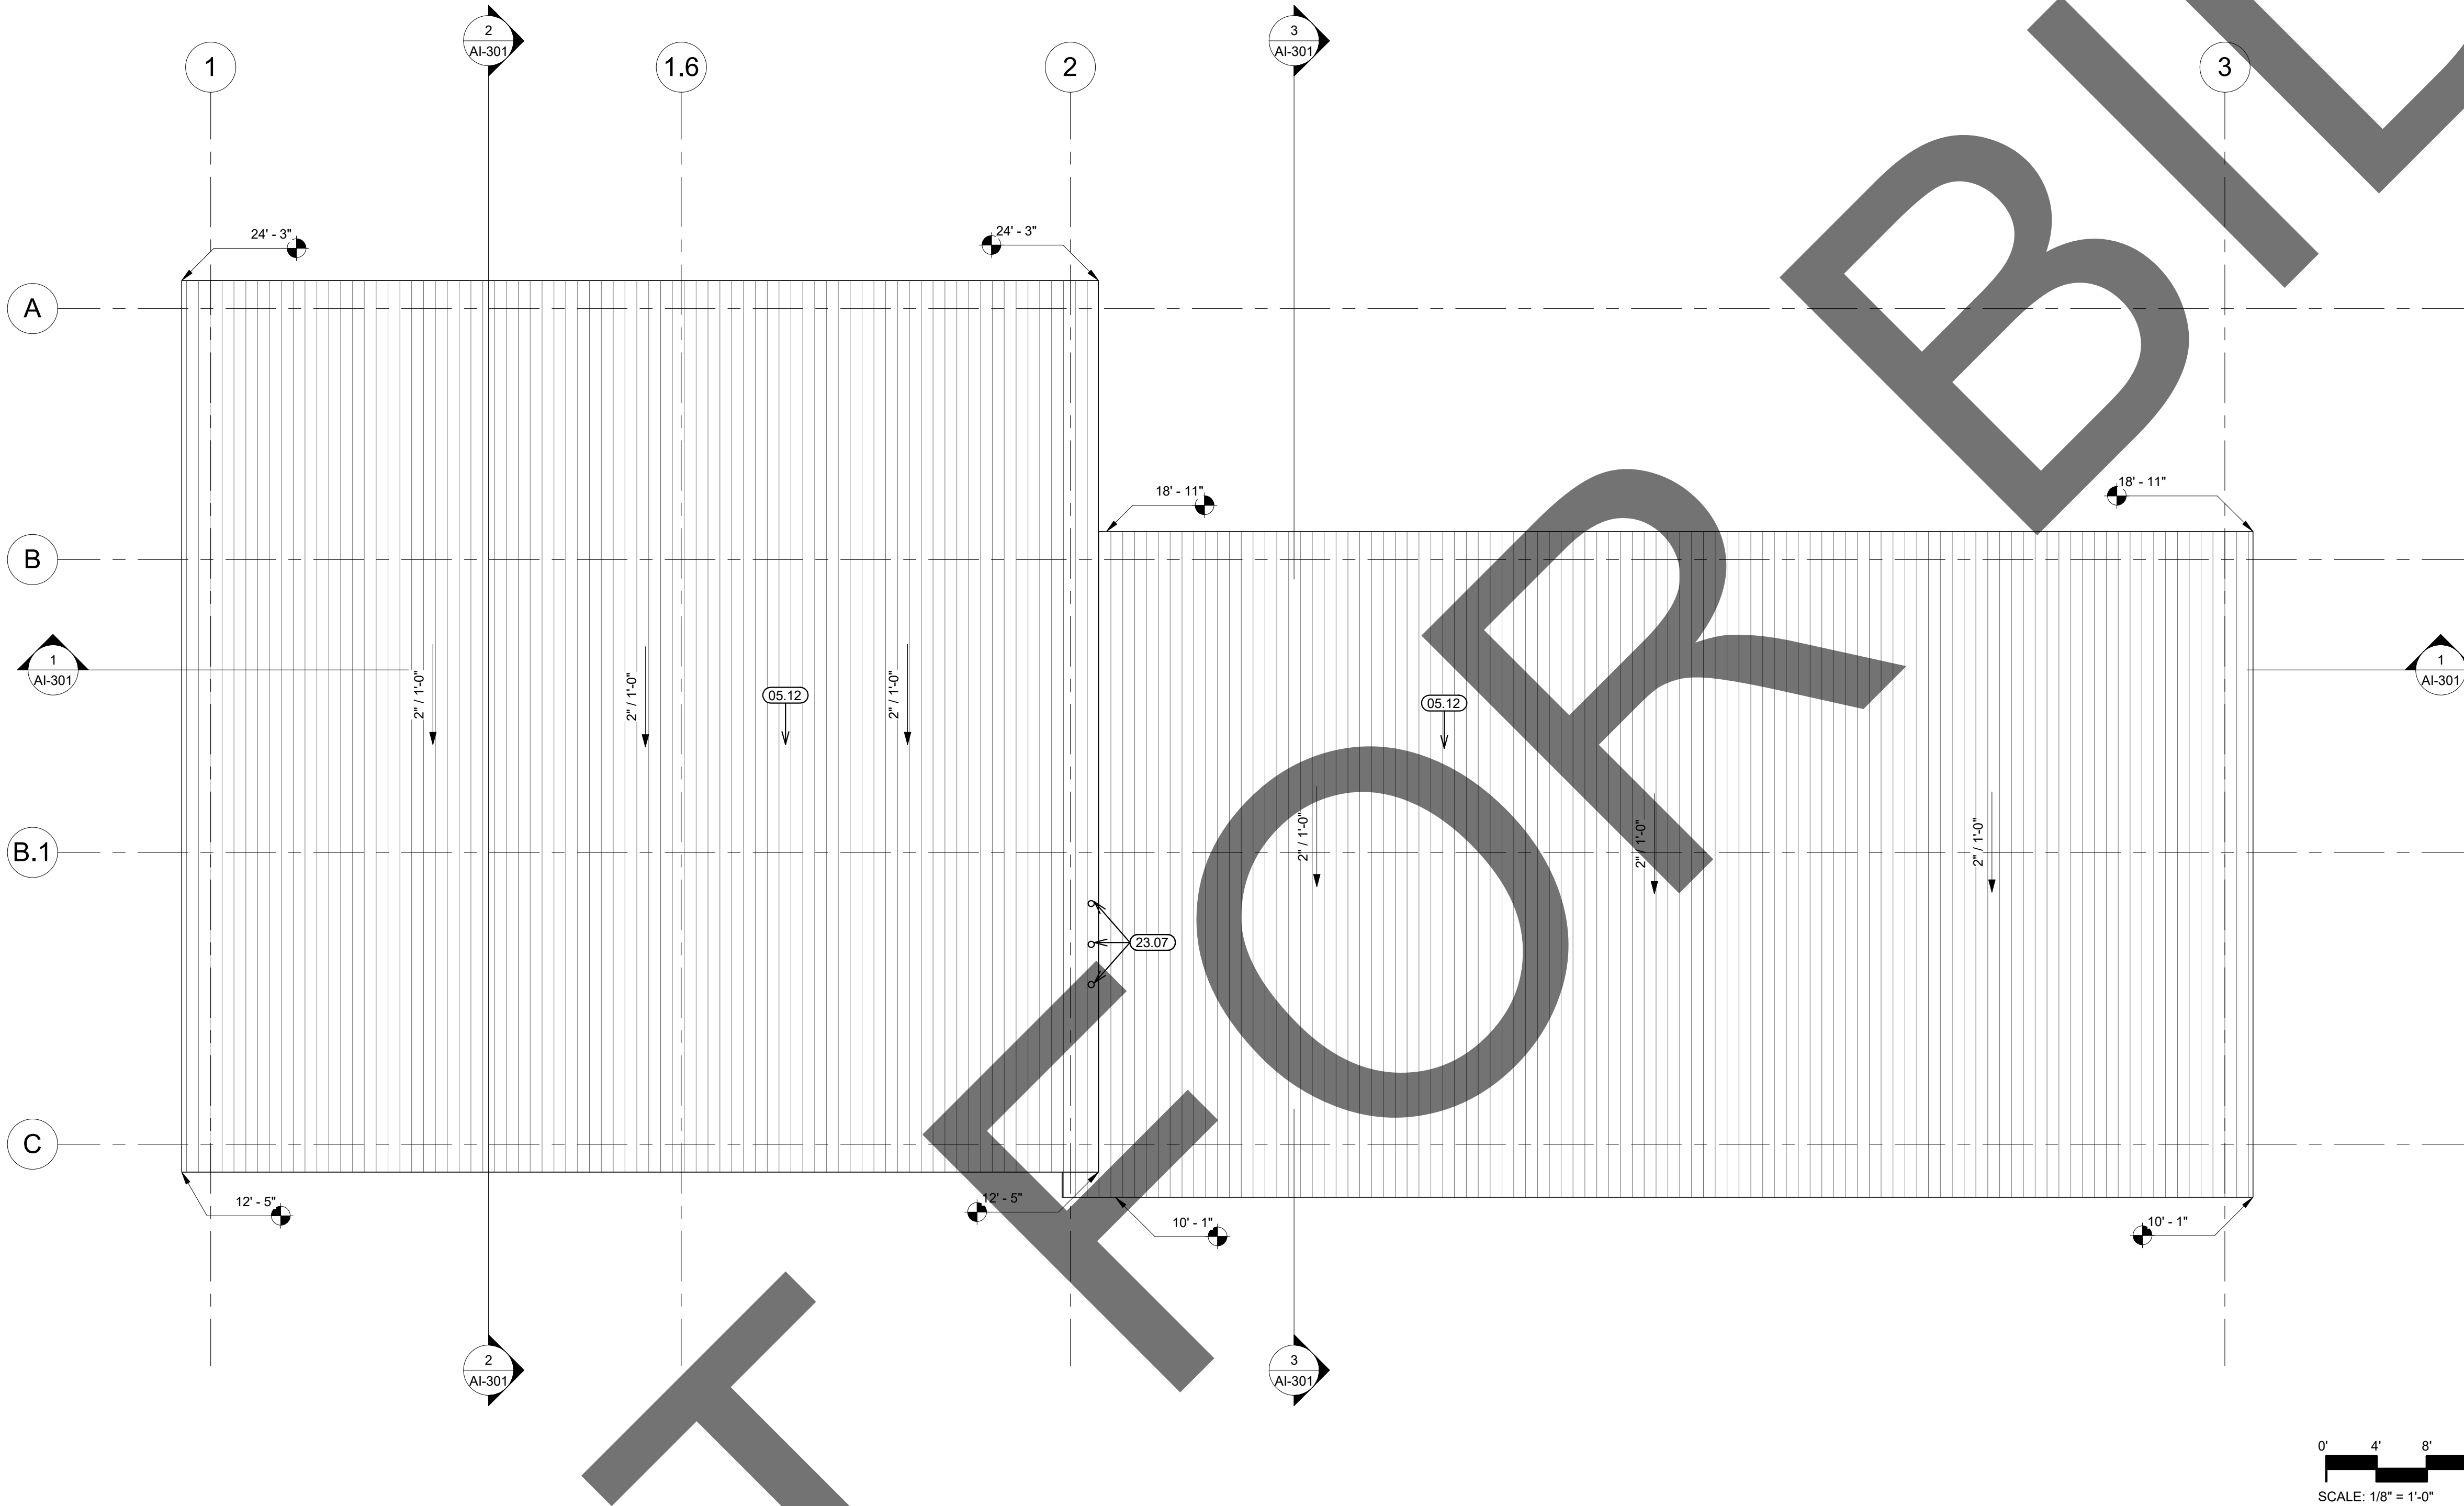

Roof Plan	SCALE		1
	1/8" = 1'-0"		

KEYNOTE LEGEND

CSI #	KEYNOTE TEXT
05.12	Standing Seam Metal Roof
23.07	Dryer Vent Through Roof

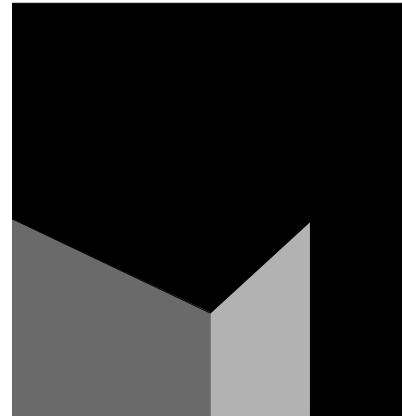

architecture
interiors
planning

MILLER

1177 Idaho Street, Suite 200
Redlands, CA 92374
Phone: 909-335-7400
Fax: 909-335-7299
info@miller-aip.com



owner approval

initials	date	phase

REVISIONS/ADDENDA

#	Date	Comment
---	------	---------

ANIMAL CARE CENTER

18313 VALLEY BLVD.
BLOOMINGTON, CA 92313

SAN BERNARDINO COUNTY

385 N. ARROWHEAD AVENUE
SAN BERNARDINO, CA 92415
PHONE: 1-888-818-8968

PROJECT INFORMATION


Project Number:	2200065
Drawn By:	SP
Checked By:	GWM
Issue Date:	2/29/24


SHEET NAME

ROOF PLAN

SHEET NUMBER


AI-105

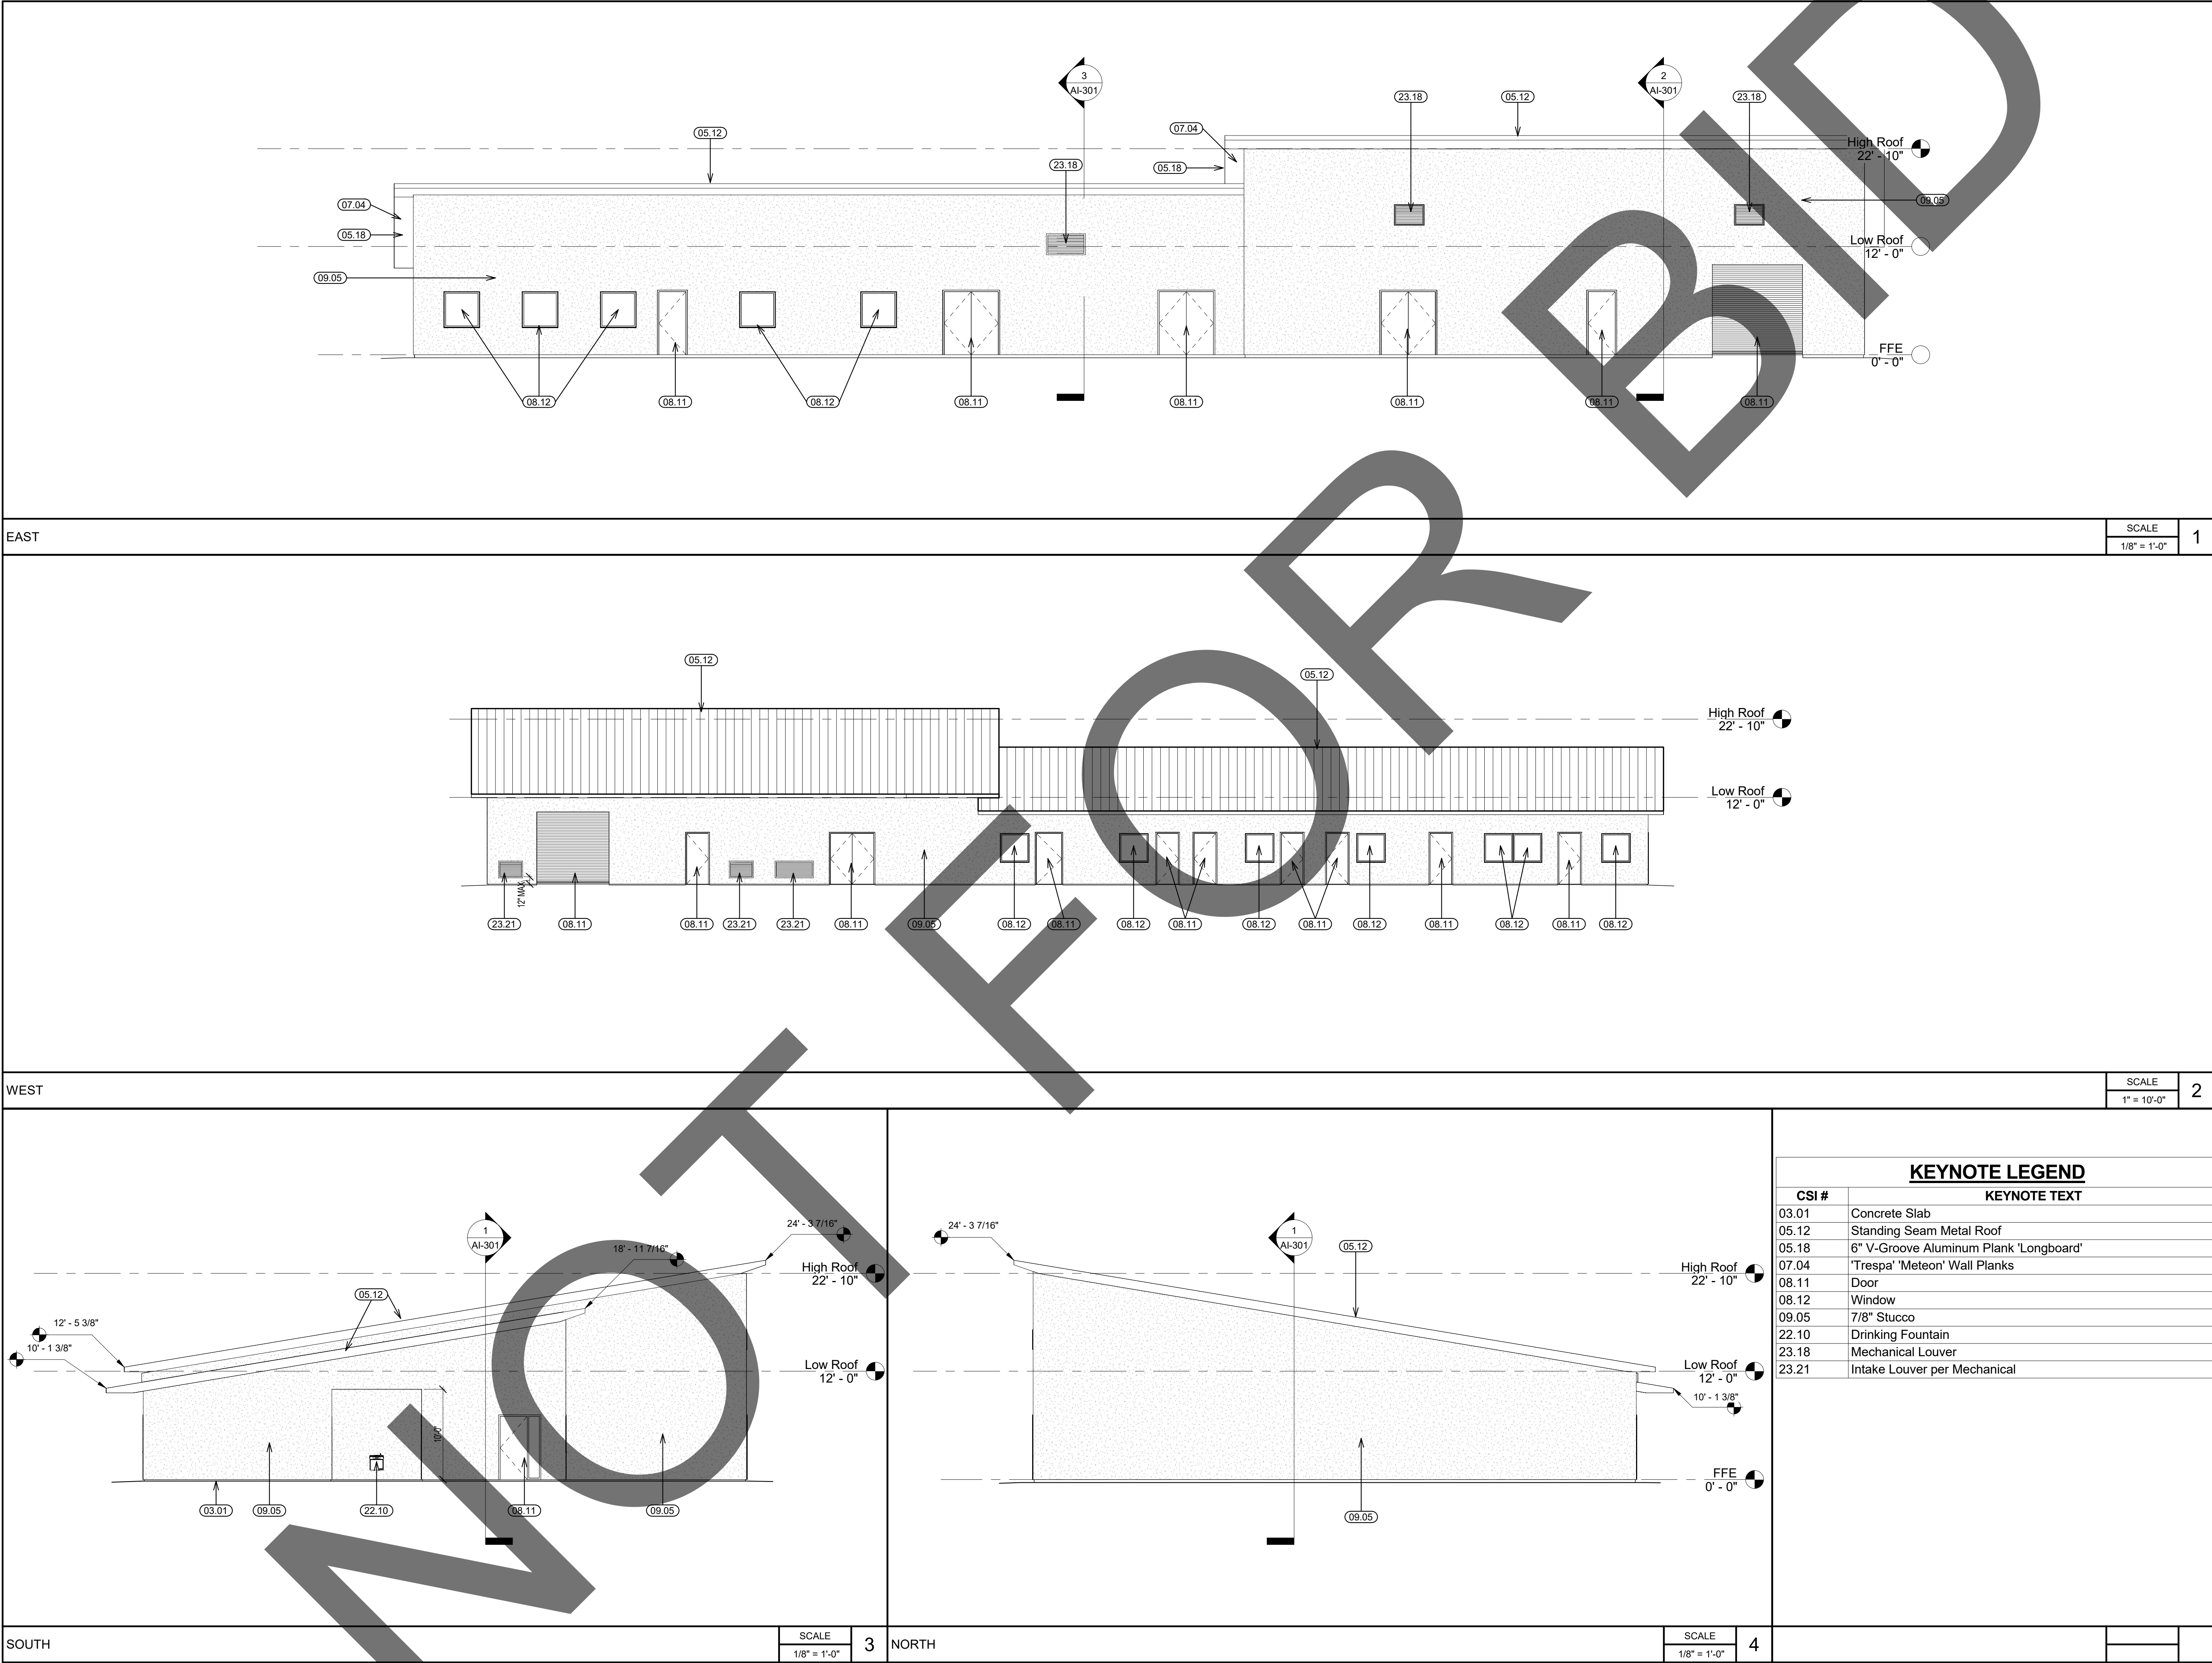

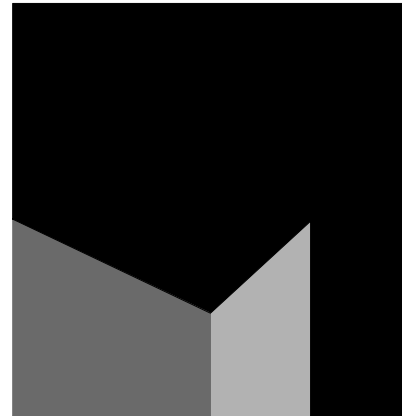

architecture
interiors
planning

1177 Idaho Street, Suite 200
Redlands, CA 92374
Phone: 909-335-7400
Fax: 909-335-7299
info@miller-aip.com

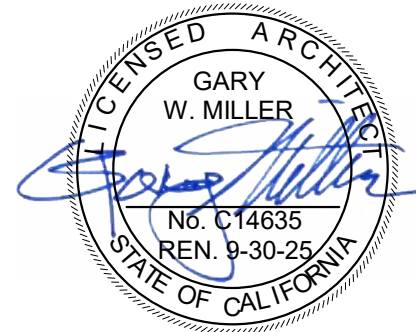

owner approval		
initials	date	phase

REVISIONS/ADDENDA		
#	Date	Comment

ANIMAL CARE CENTER

18313 VALLEY BLVD.
BLOOMINGTON, CA 92313

SAN BERNARDINO COUNTY

385 N. ARROWHEAD AVENUE
SAN BERNARDINO, CA 92415
PHONE: 1-888-818-8988

PROJECT INFORMATION	
Project Number:	2200065
Drawn By:	Author
Checked By:	GWM
Issue Date:	2/29/24


SHEET NAME

EXTERIOR
ELEVATIONS

SHEET NUMBER

AI-201


Sheet Of Sheets

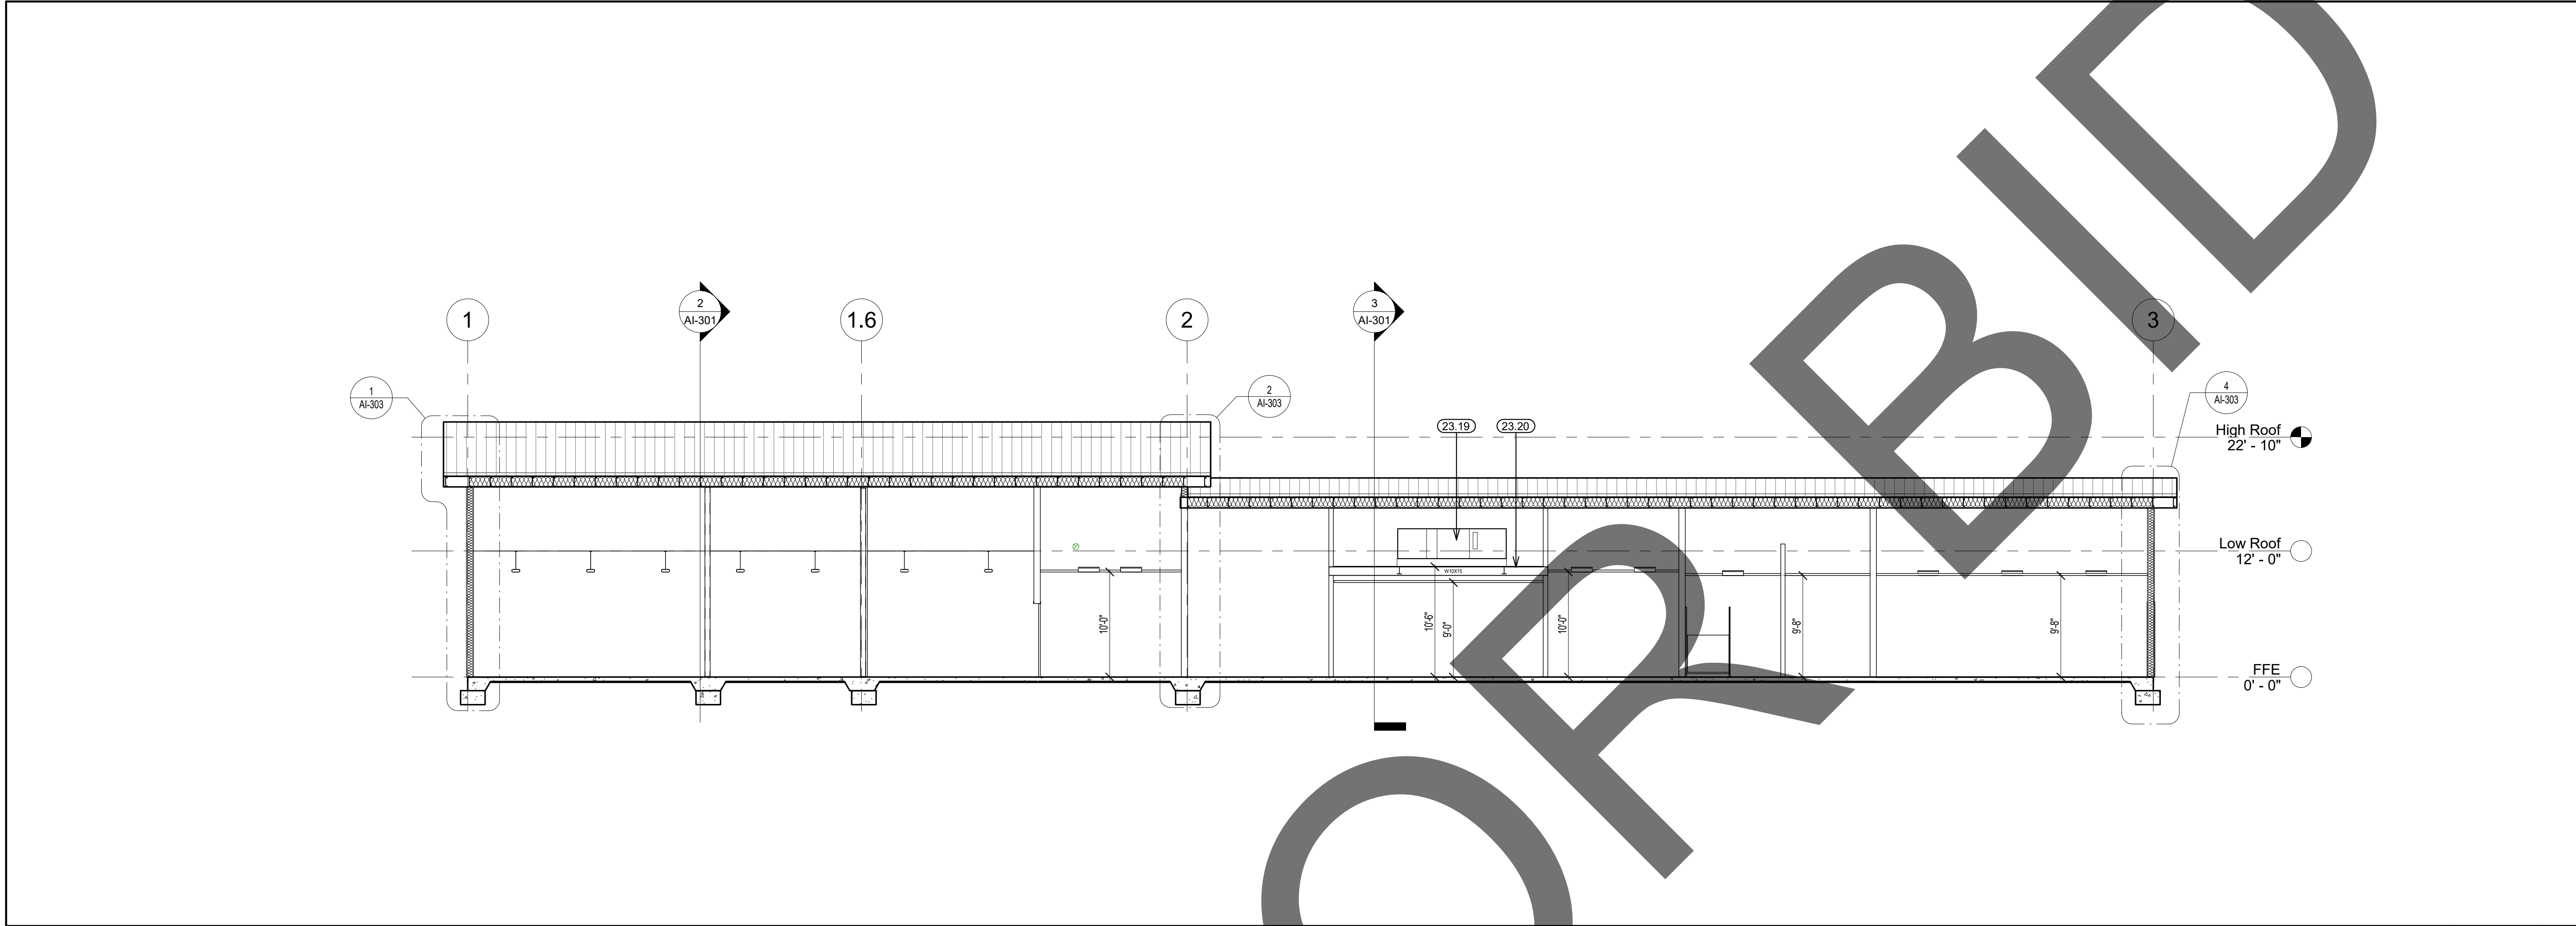

NORTH/ SOUTH BUILDING SECTION

SCALE
1/8" = 1'-0"


1

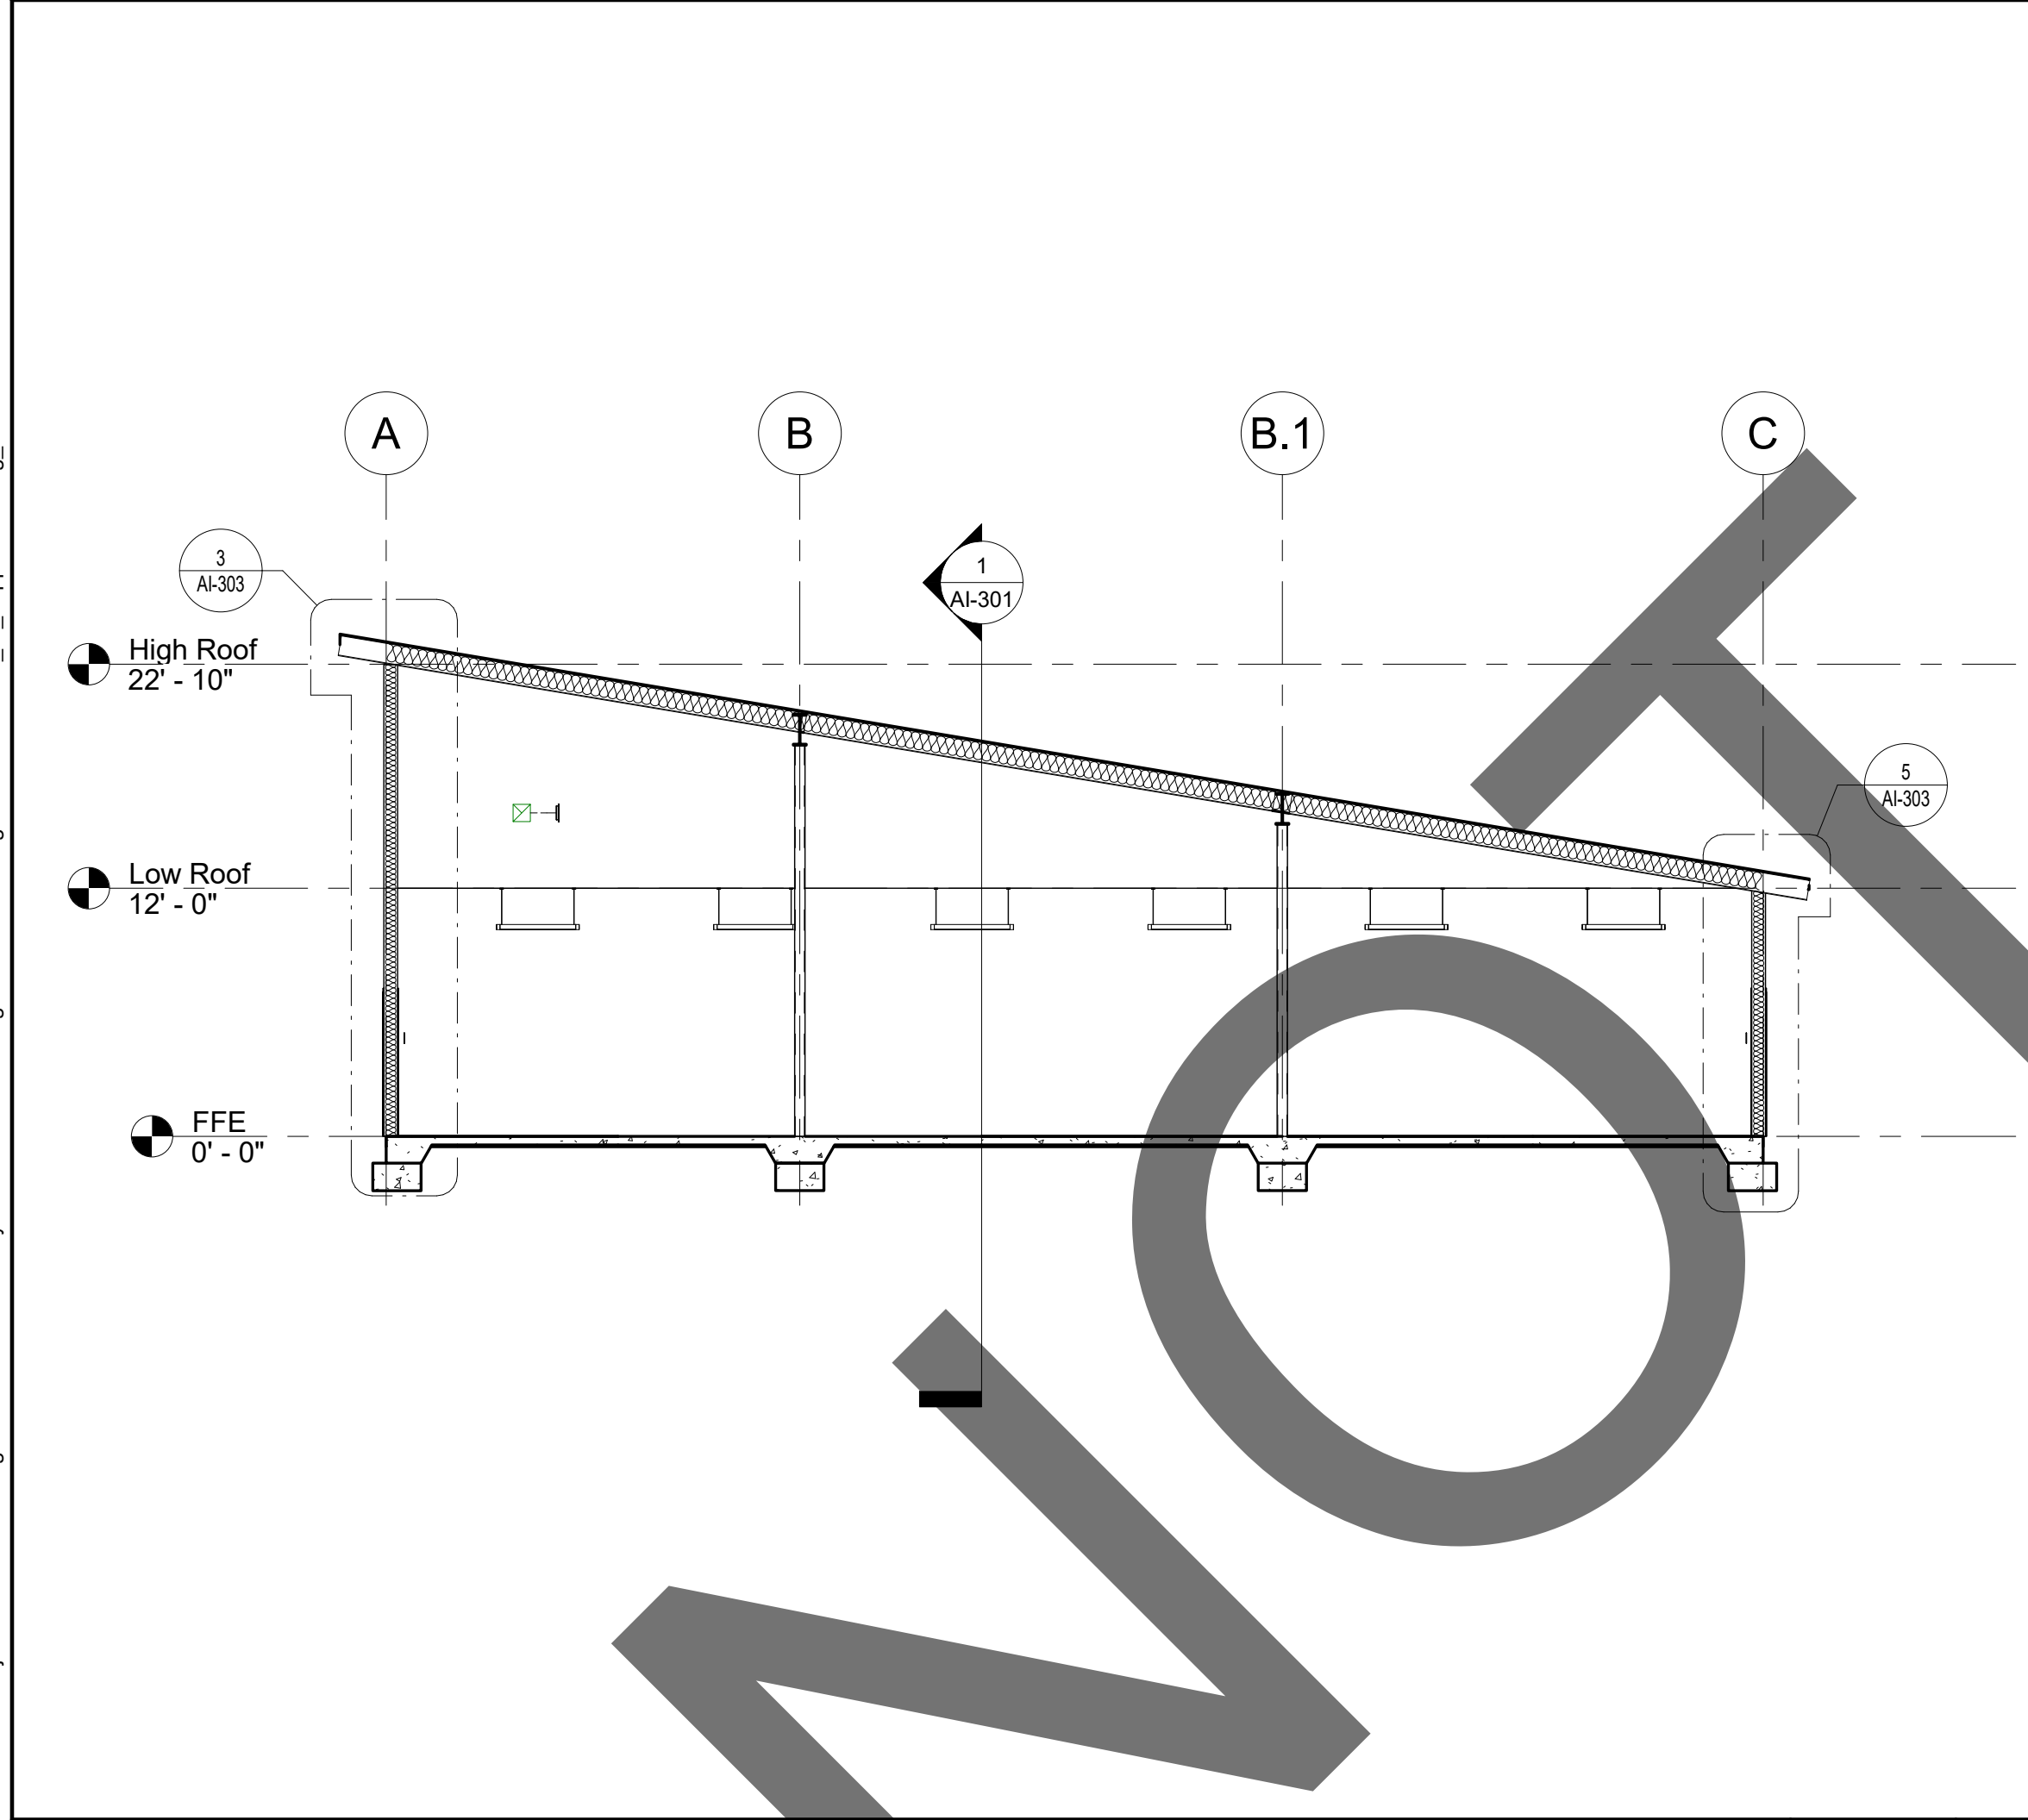

EAST/ WEST BUILDING SECTION 2

SCALE
1/8" = 1'-0"

2

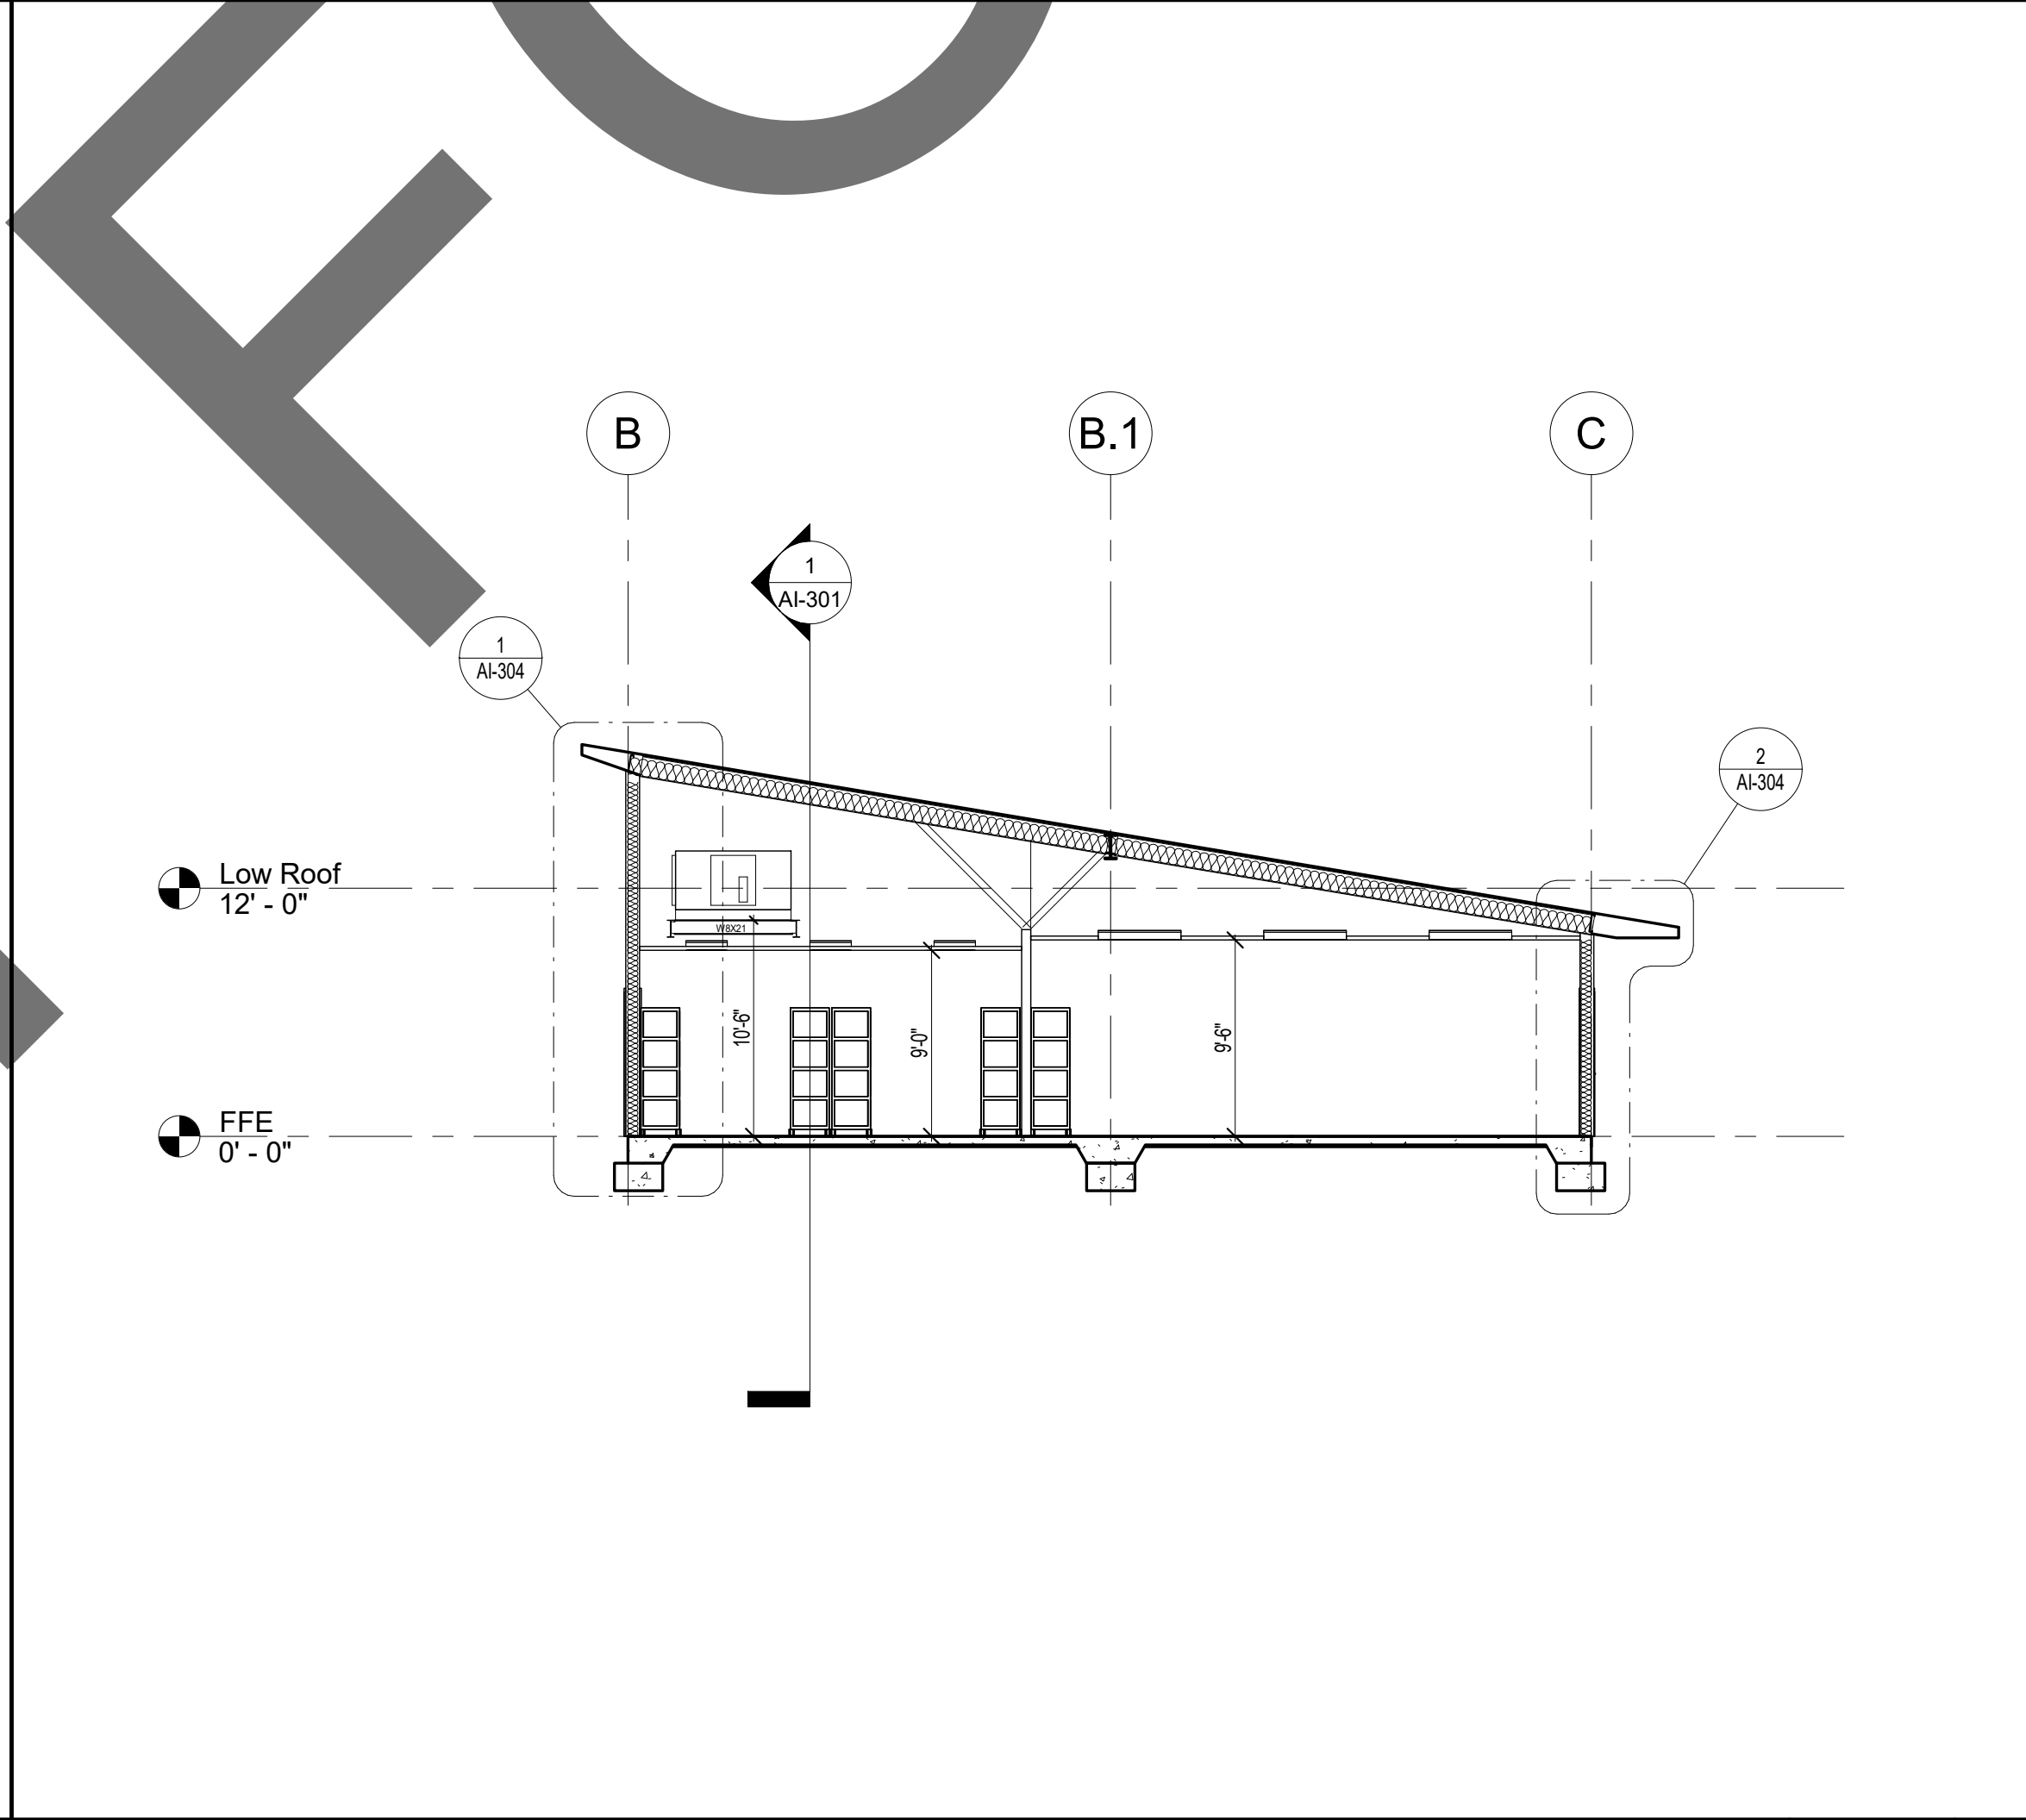

EAST/ WEST BUILDING SECTION 3

SCALE
1/8" = 1'-0"


3

KEYNOTE LEGEND

CSI #	KEYNOTE TEXT
23.19	Air Handling Unit per Mechanical Drawings
23.20	Mechanical Platform see Structural Drawings



1177 Idaho Street, Suite 200
Redlands, CA 92374
Phone: 909-335-7400
Fax: 909-335-7299
info@miller-aip.com

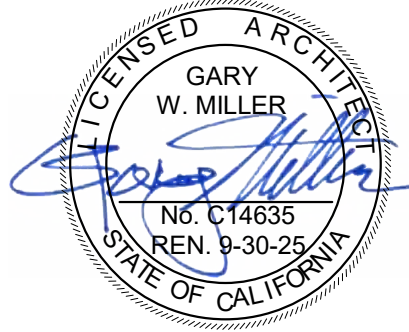

owner approval

initials	date	phase

REVISIONS/ADDENDA

#	Date	Comment
---	------	---------

ANIMAL CARE CENTER

18313 VALLEY BLVD.
BLOOMINGTON, CA 92313

SAN BERNARDINO COUNTY

385 N. ARROWHEAD AVENUE
SAN BERNARDINO, CA 92415
PHONE: 1-888-818-8988

PROJECT INFORMATION

Project Number:	2200065
Drawn By:	Author
Checked By:	GWM
Issue Date:	2/29/24


SHEET NAME

BUILDING
SECTIONS

SHEET NUMBER

AI-301

Sheet Of Sheets

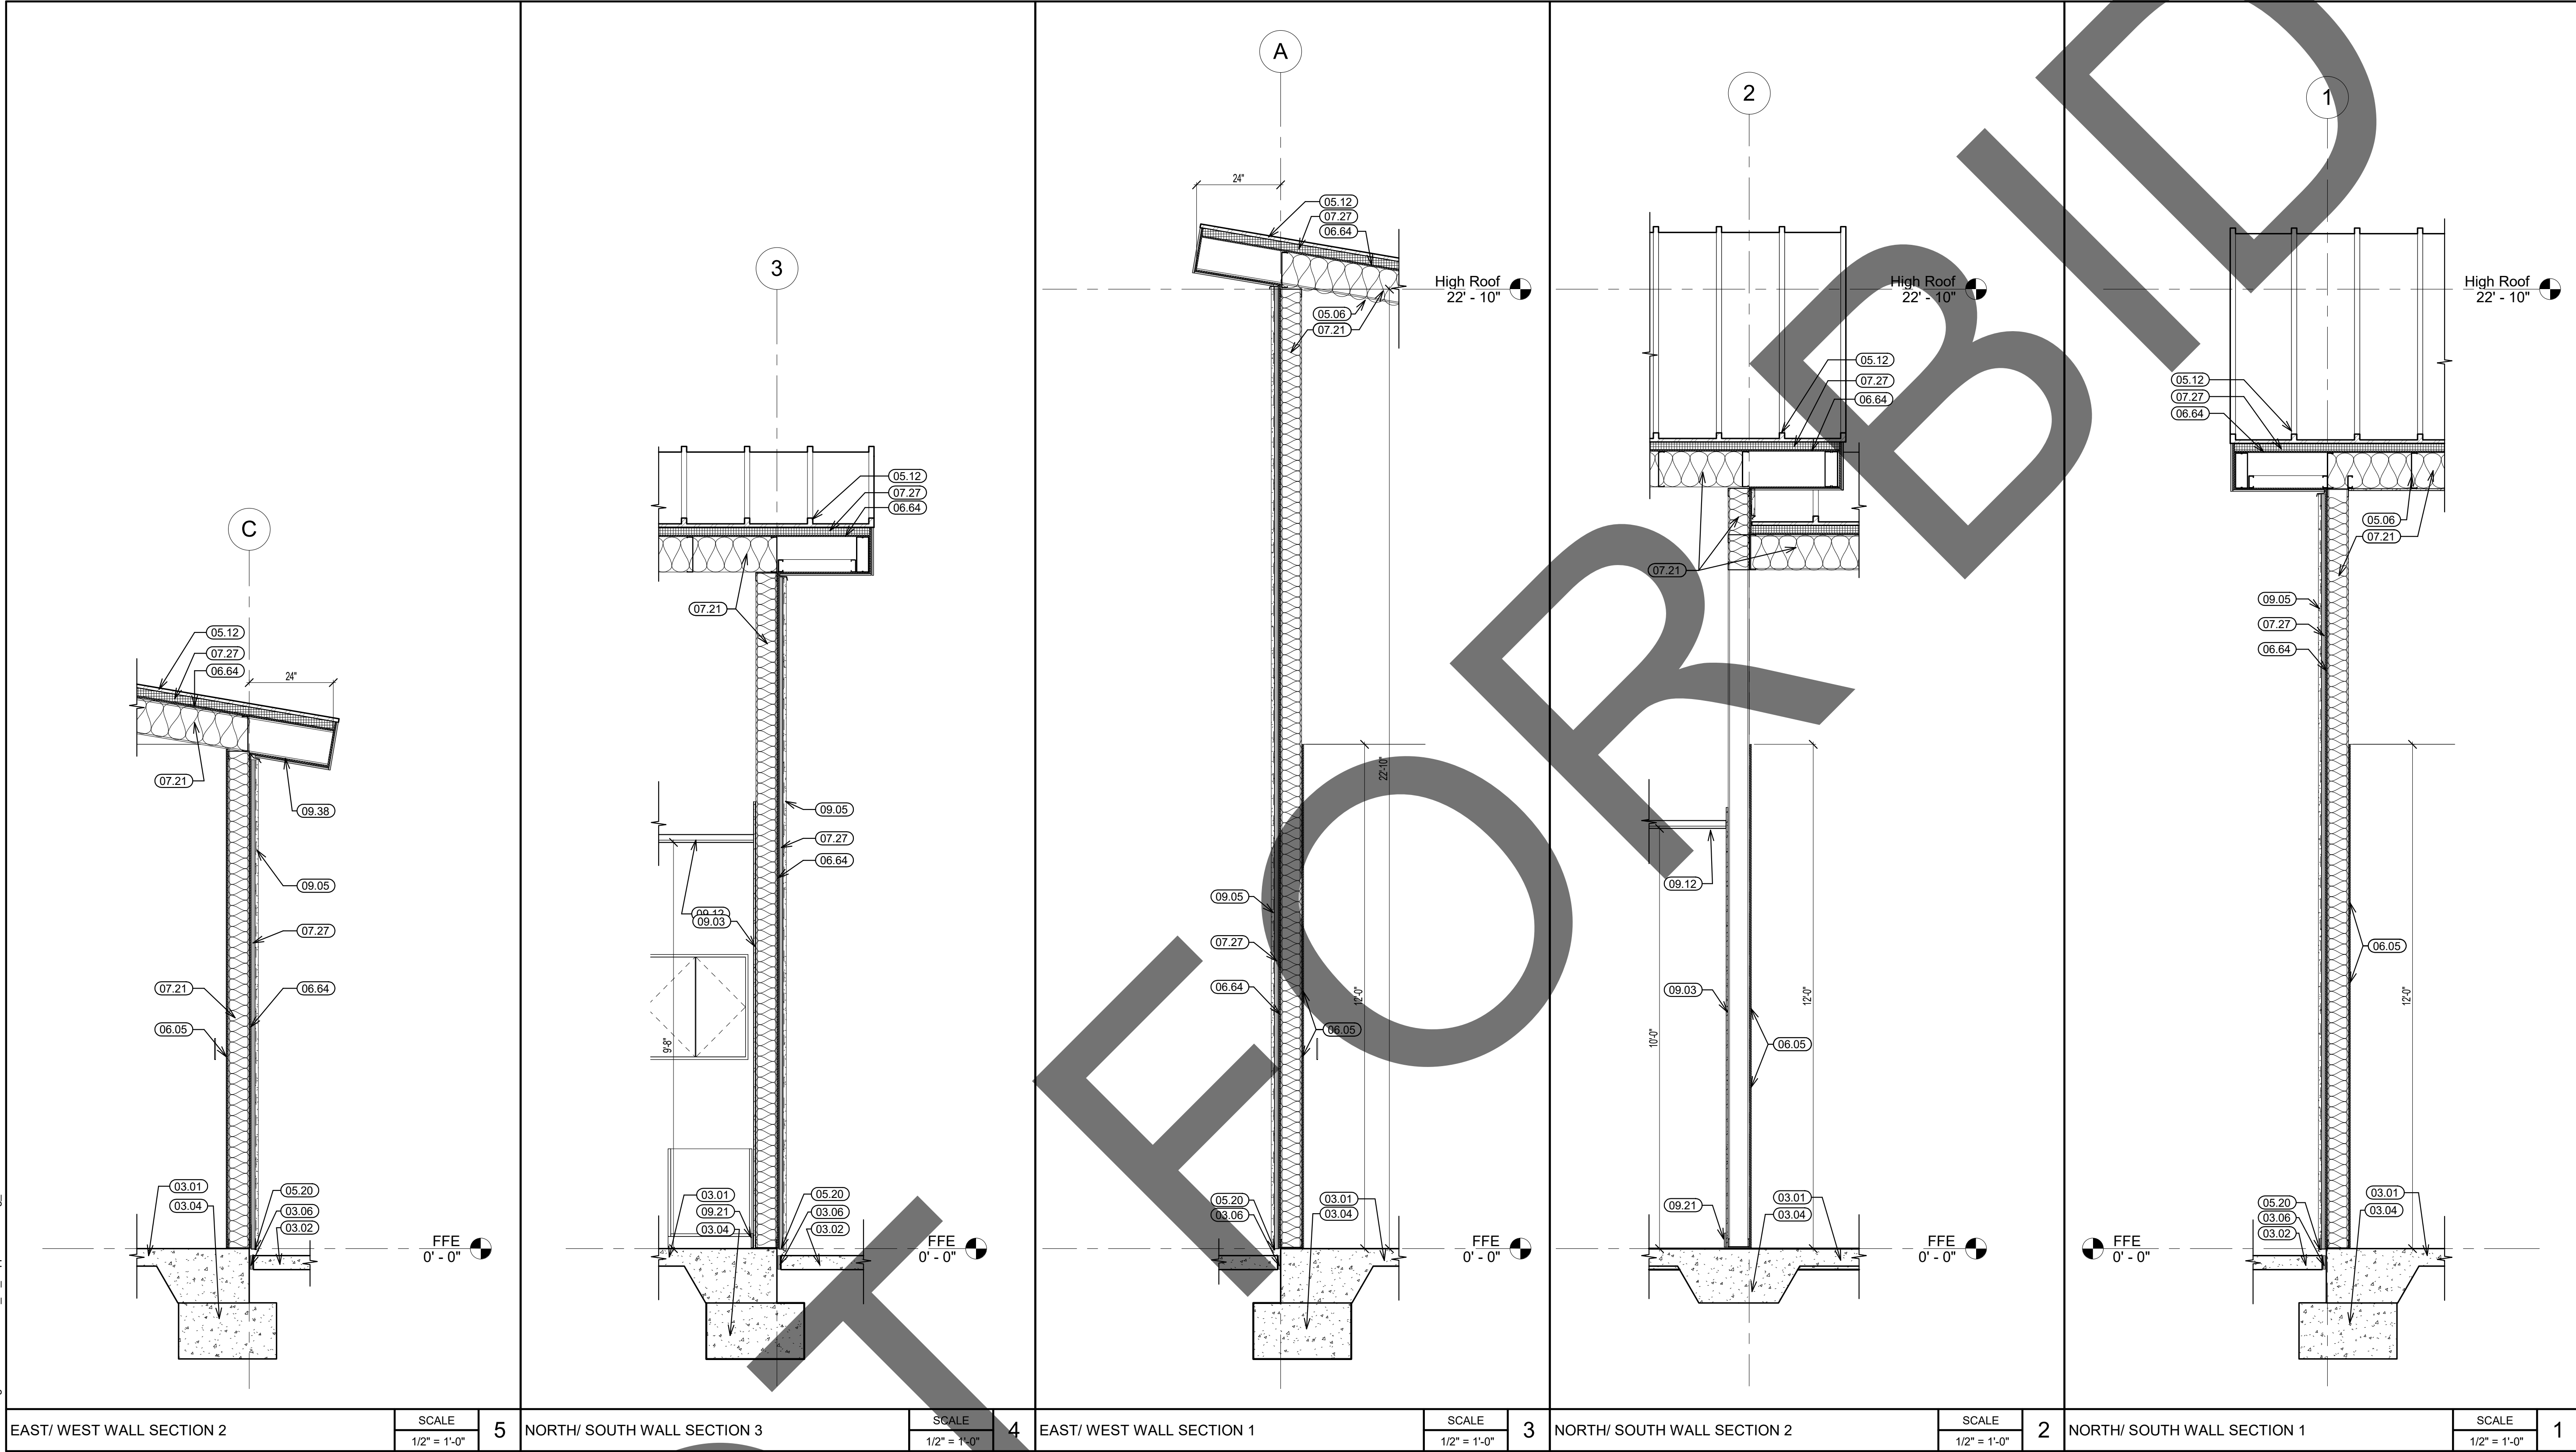

KEYNOTE LEGEND	
CSI #	KEYNOTE TEXT
03.01	Concrete Slab
03.02	Exterior Concrete
03.04	Concrete Footing
03.06	Expansion Joint
05.06	Metal Rafters
05.12	Standing Seam Metal Roof
05.20	Galvanized Stucco Screed
06.05	1/2" OSB Protection Board
06.64	Plywood Sheathing
07.21	Batt Insulation
07.27	Rigid Insulation
09.03	5/8" Gypsum Board
09.05	7/8" Stucco
09.12	Suspended Ceiling w/ Acoustical Panels
09.21	Resilient Base
09.38	Hardie Soffit Board



architecture
interiors
planning

1177 Idaho Street, Suite 200
Redlands, CA 92374
Phone: 909-335-7400
Fax: 909-335-7299
info@miller-aip.com



owner approval		
initials	date	phase

REVISIONS/ADDENDA		
#	Date	Comment

ANIMAL CARE CENTER

18313 VALLEY BLVD.
BLOOMINGTON, CA 92313

SAN BERNARDINO COUNTY

385 N. ARROWHEAD AVENUE
SAN BERNARDINO, CA 92415
PHONE: 1-888-818-8988

PROJECT INFORMATION	
Project Number:	2200065
Drawn By:	Author
Checked By:	GWM
Issue Date:	2/29/24

SHEET NAME

WALL SECTIONS

SHEET NUMBER

AI-303

Sheet Of Sheets



**1177 Idaho Street, Suite 200
Redlands, CA 92374
Phone: 909-335-7400
Fax: 909-335-7299
info@miller-aip.com**



initials	date	phase

#	Date	Comment
1	2/24	PCC Response #1













385 N. ARROWHEAD AVENUE
SAN BERNARDINO, CA 92415
PHONE: 1-888-818-8988

<u>KEYNOTE LEGEND</u>	
CSI #	KEYNOTE TEXT
06.60	Lavatory Counter Top w/ 4" Splash And Returns At Sides
08.01	Hollow Metal Door & Metal Frame
09.11	Ceramic Tile Wainscot and Base
09.27	Finish per Schedule
10.07	Toilet Partition
10.08	Urinal Screen
10.10	Toilet Tissue Dispenser
10.12	Sanitary Napkin Dispenser
10.28	Grab Bar
10.29	36" Grab Bar
10.30	42" Grab Bar
10.34	Mirror w/ Frame
10.36	ADA Shower Seat
22.01	ADA Shower Controls
22.05	Floor Drain - See Plumbing Drawings
22.29	ADA Toilet
22.32	Urinal

Project Number:	2200065
Drawn By:	Author
Checked By:	GWM
Issue Date:	2/29/24

ENLARGED
PLANS /
INTERIOR
ELEVATIONS

Sheet Of Sheets

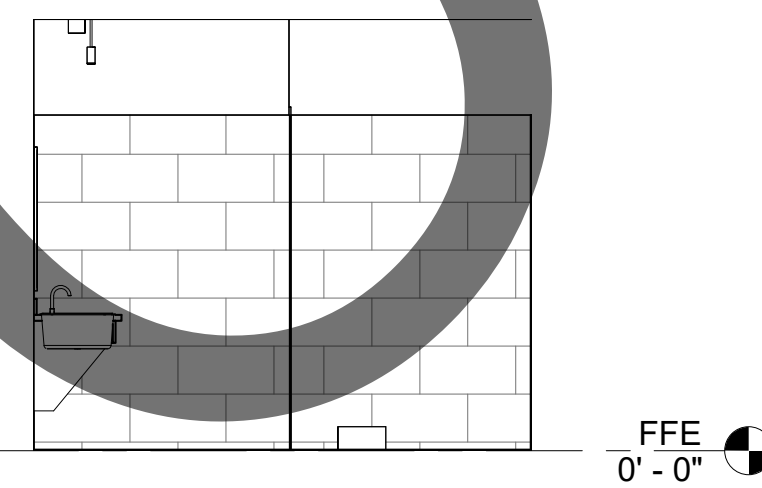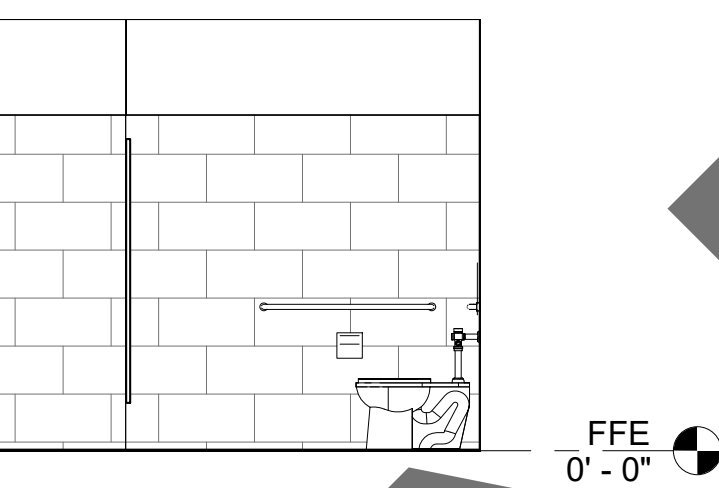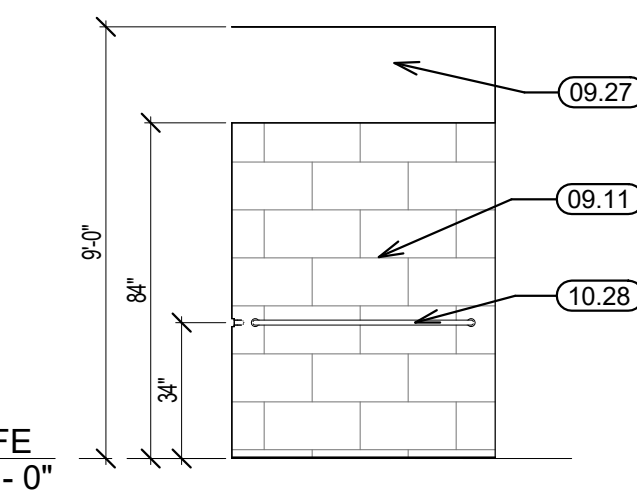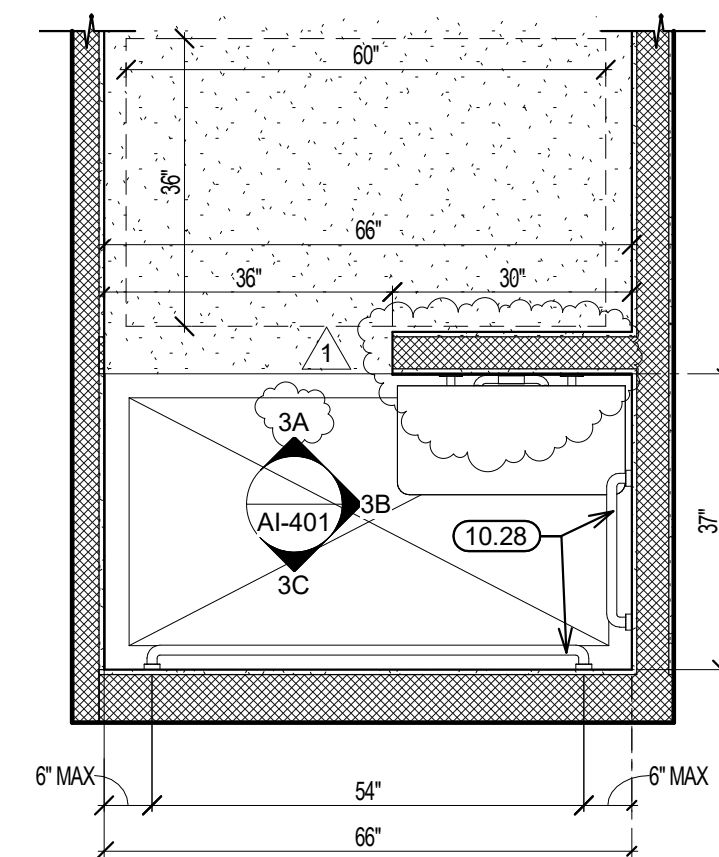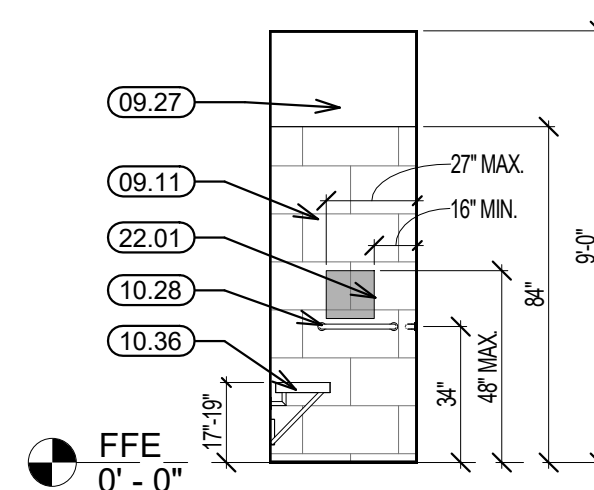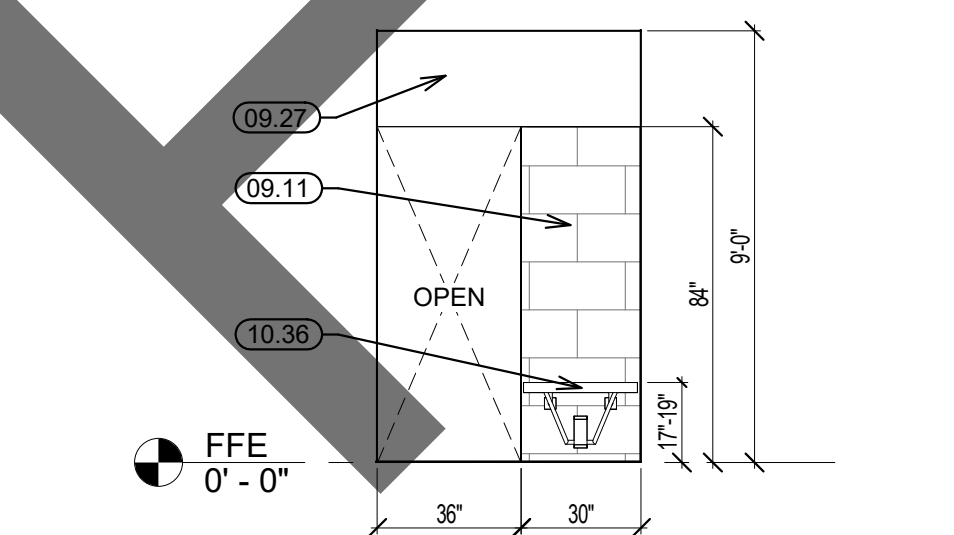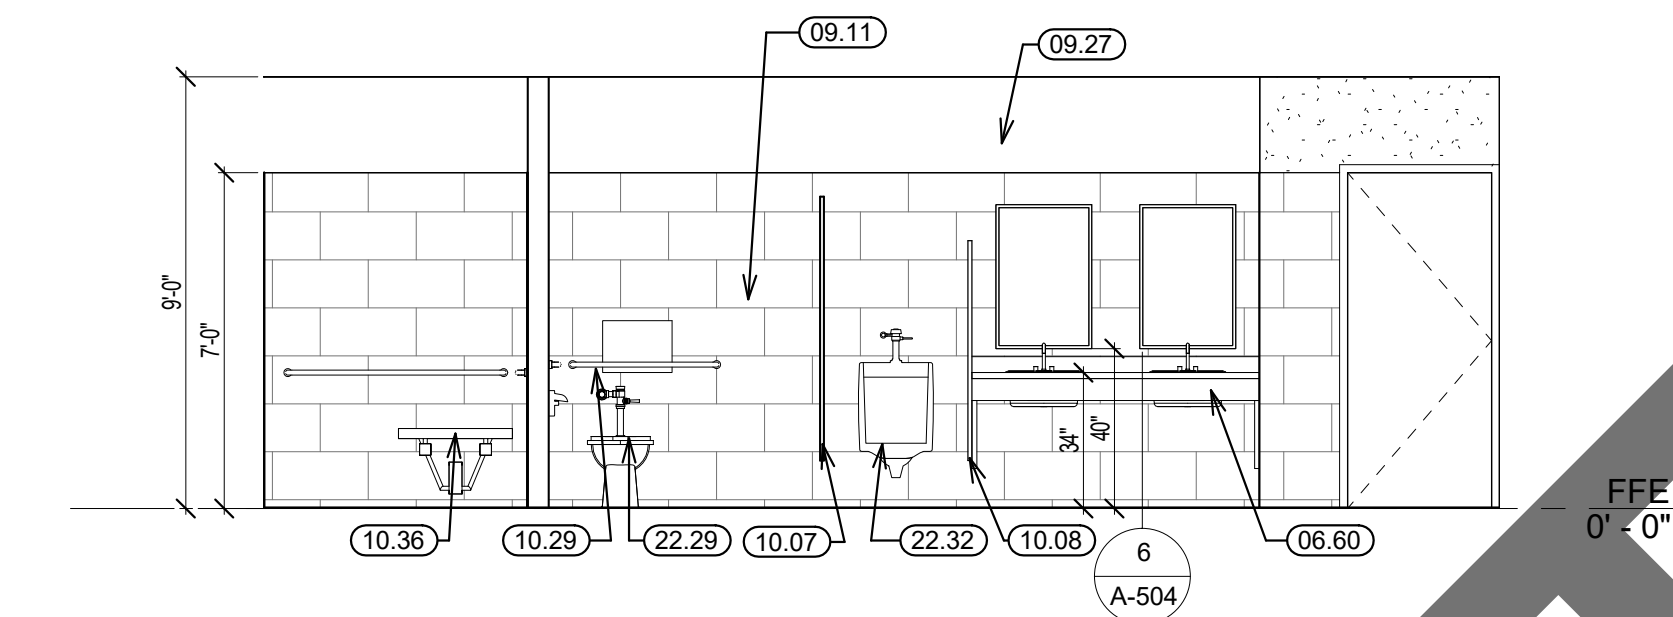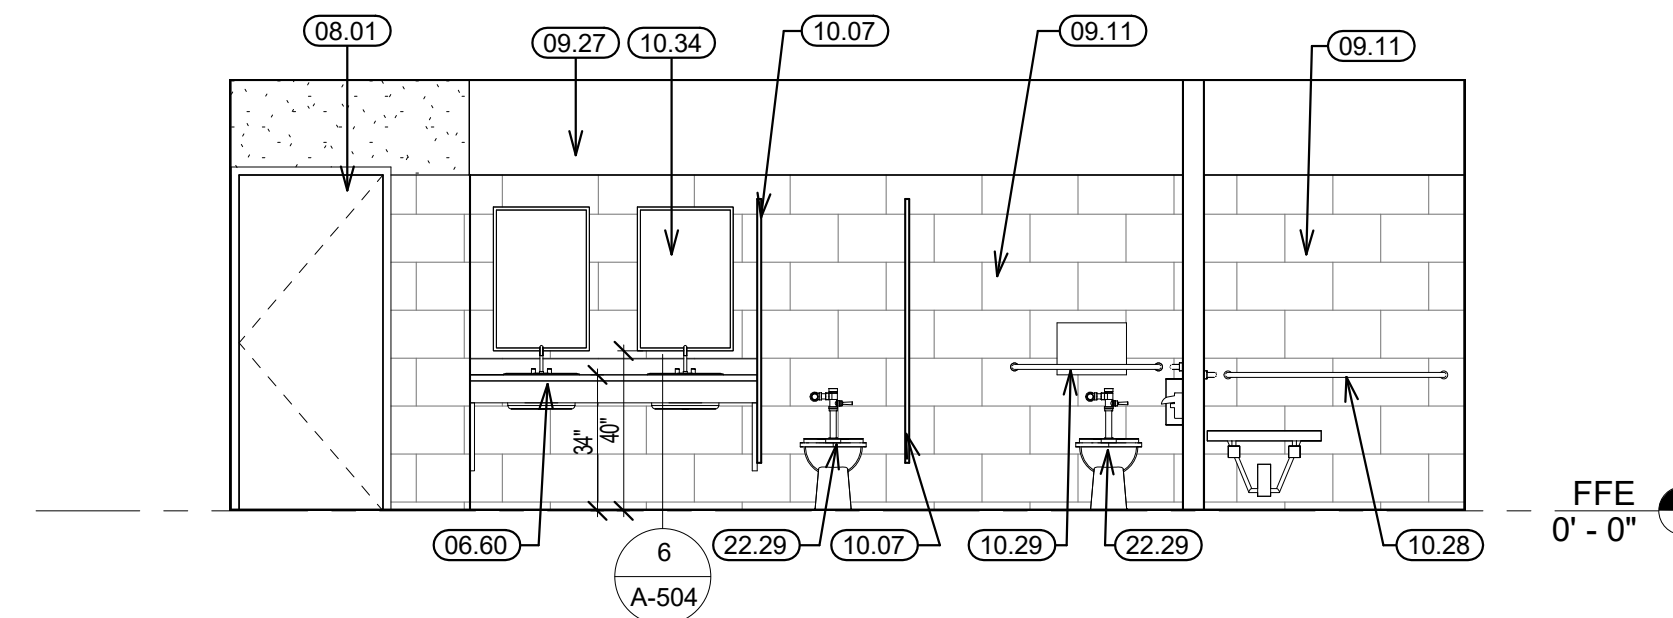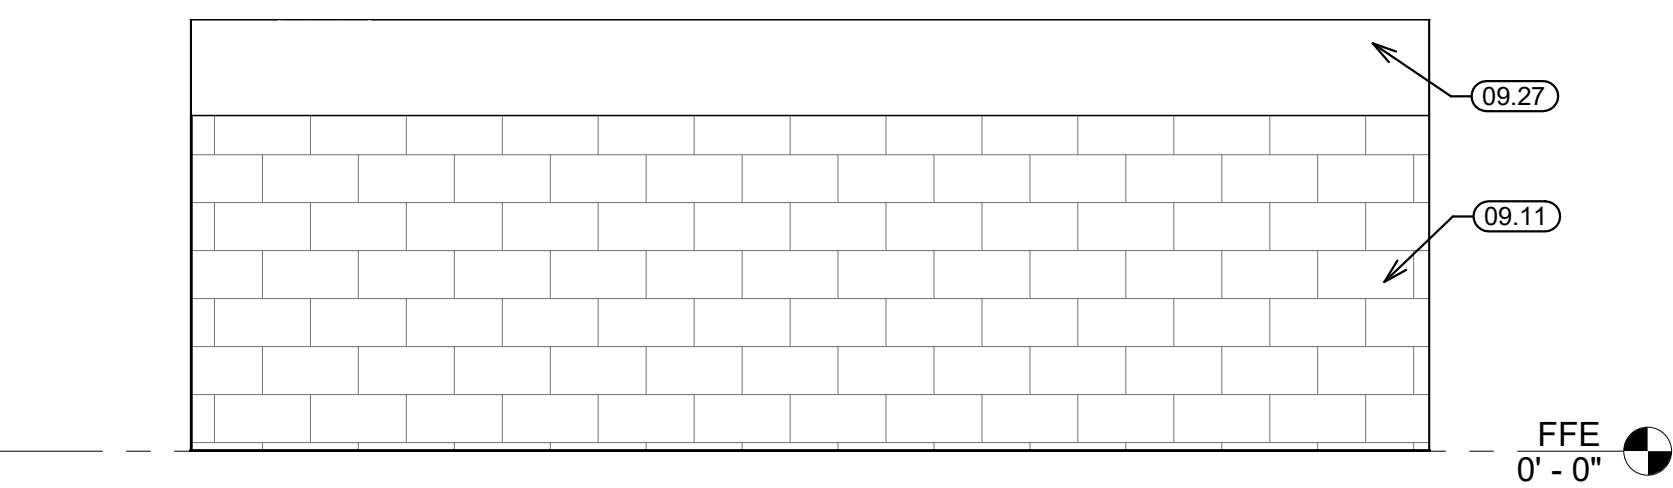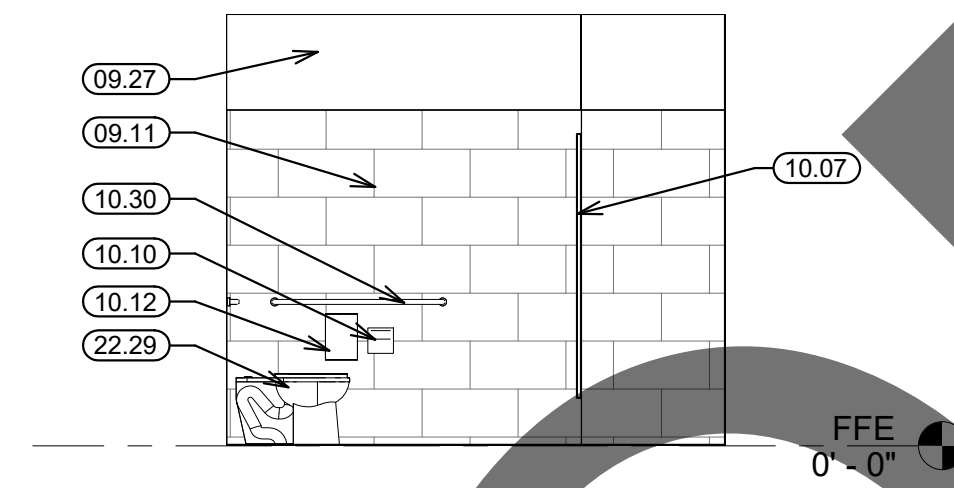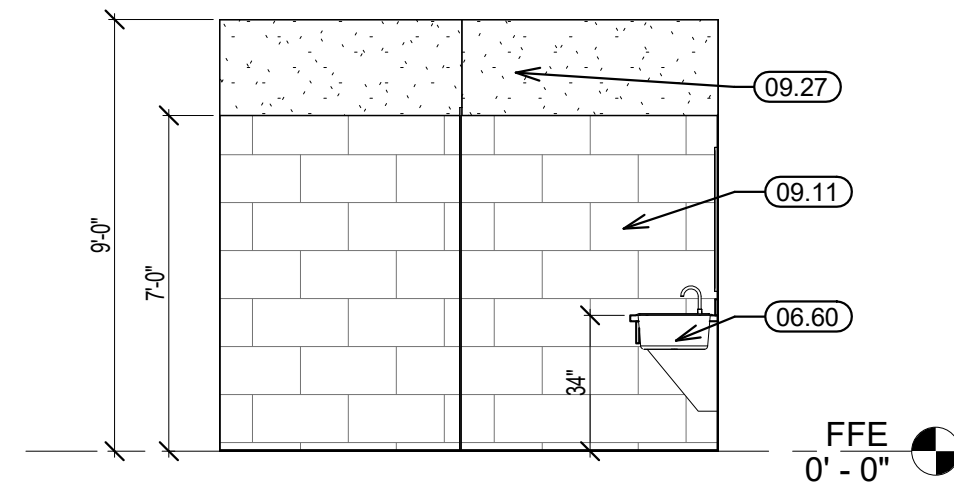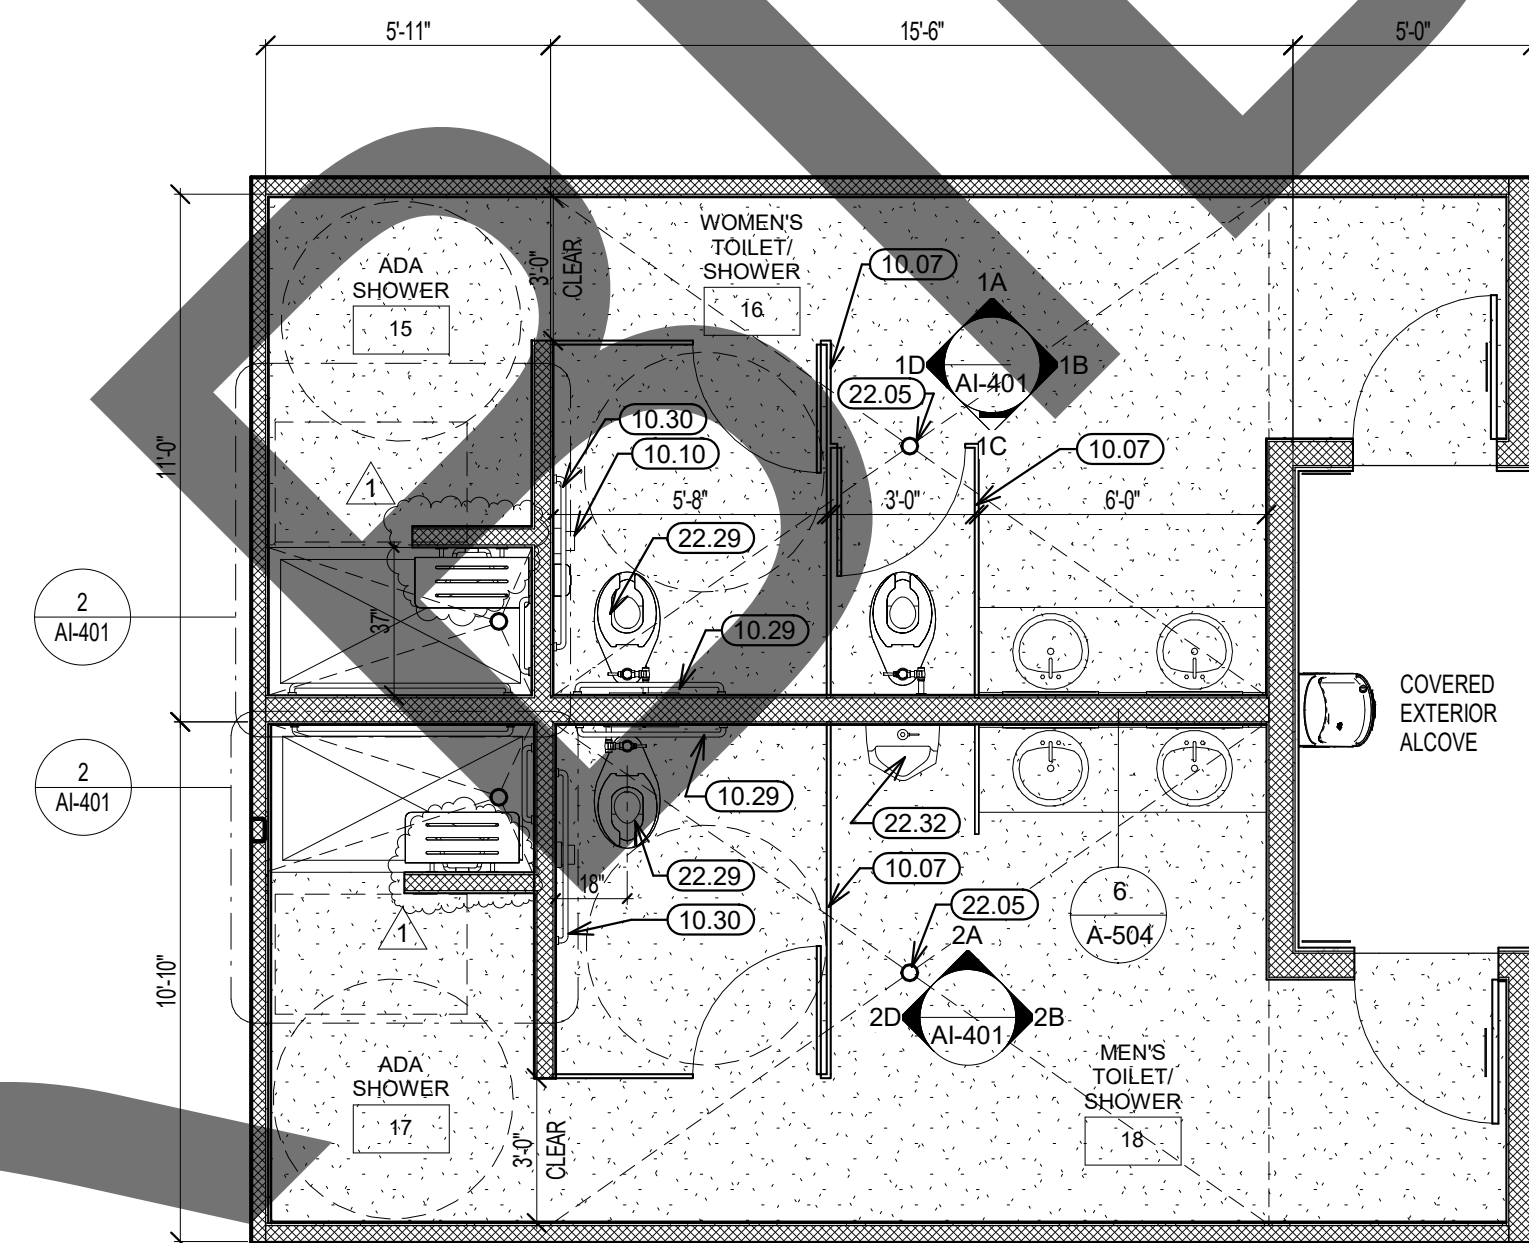

Shower Seats shall be a folding type, shall be installed on the side wall adjacent to the controls, and shall extend from the back wall to a point within 3 inches of the compartment entry. When folded, the seat shall extend 6" Max from the mounting wall.

ADA SHOWER NORTH WALL

ADDITIONAL ACCESSIBLE SHOWER NOTES:

2D MENS TOILET/SHOWER WEST

MENS TOILET/SHOWER EAST

SCALE 2A ENLARGED ADA SHOWER

SCALE
1/4" = 1'-0"

3A ADA SHOWER WEST WALL

3A	AD

ENLARGED ADA ROLL-IN SHOWER

ENLARGE

2A ENLARGED ADA SHOWER

2A	ENI
----	-----

3A ADA SHOWER WEST WALL

3A	AD

ENLARGED ADA ROLL-IN SHOWER

ENLARGE

2A ENLARGED ADA SHOWER



2A	ENI
----	-----

3A ADA SHOWER WEST WALL

3A	AD

ENLARGED ADA ROLL-IN SHOWER

ENLARGE

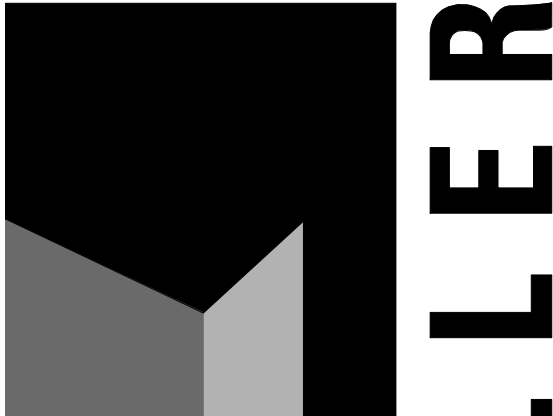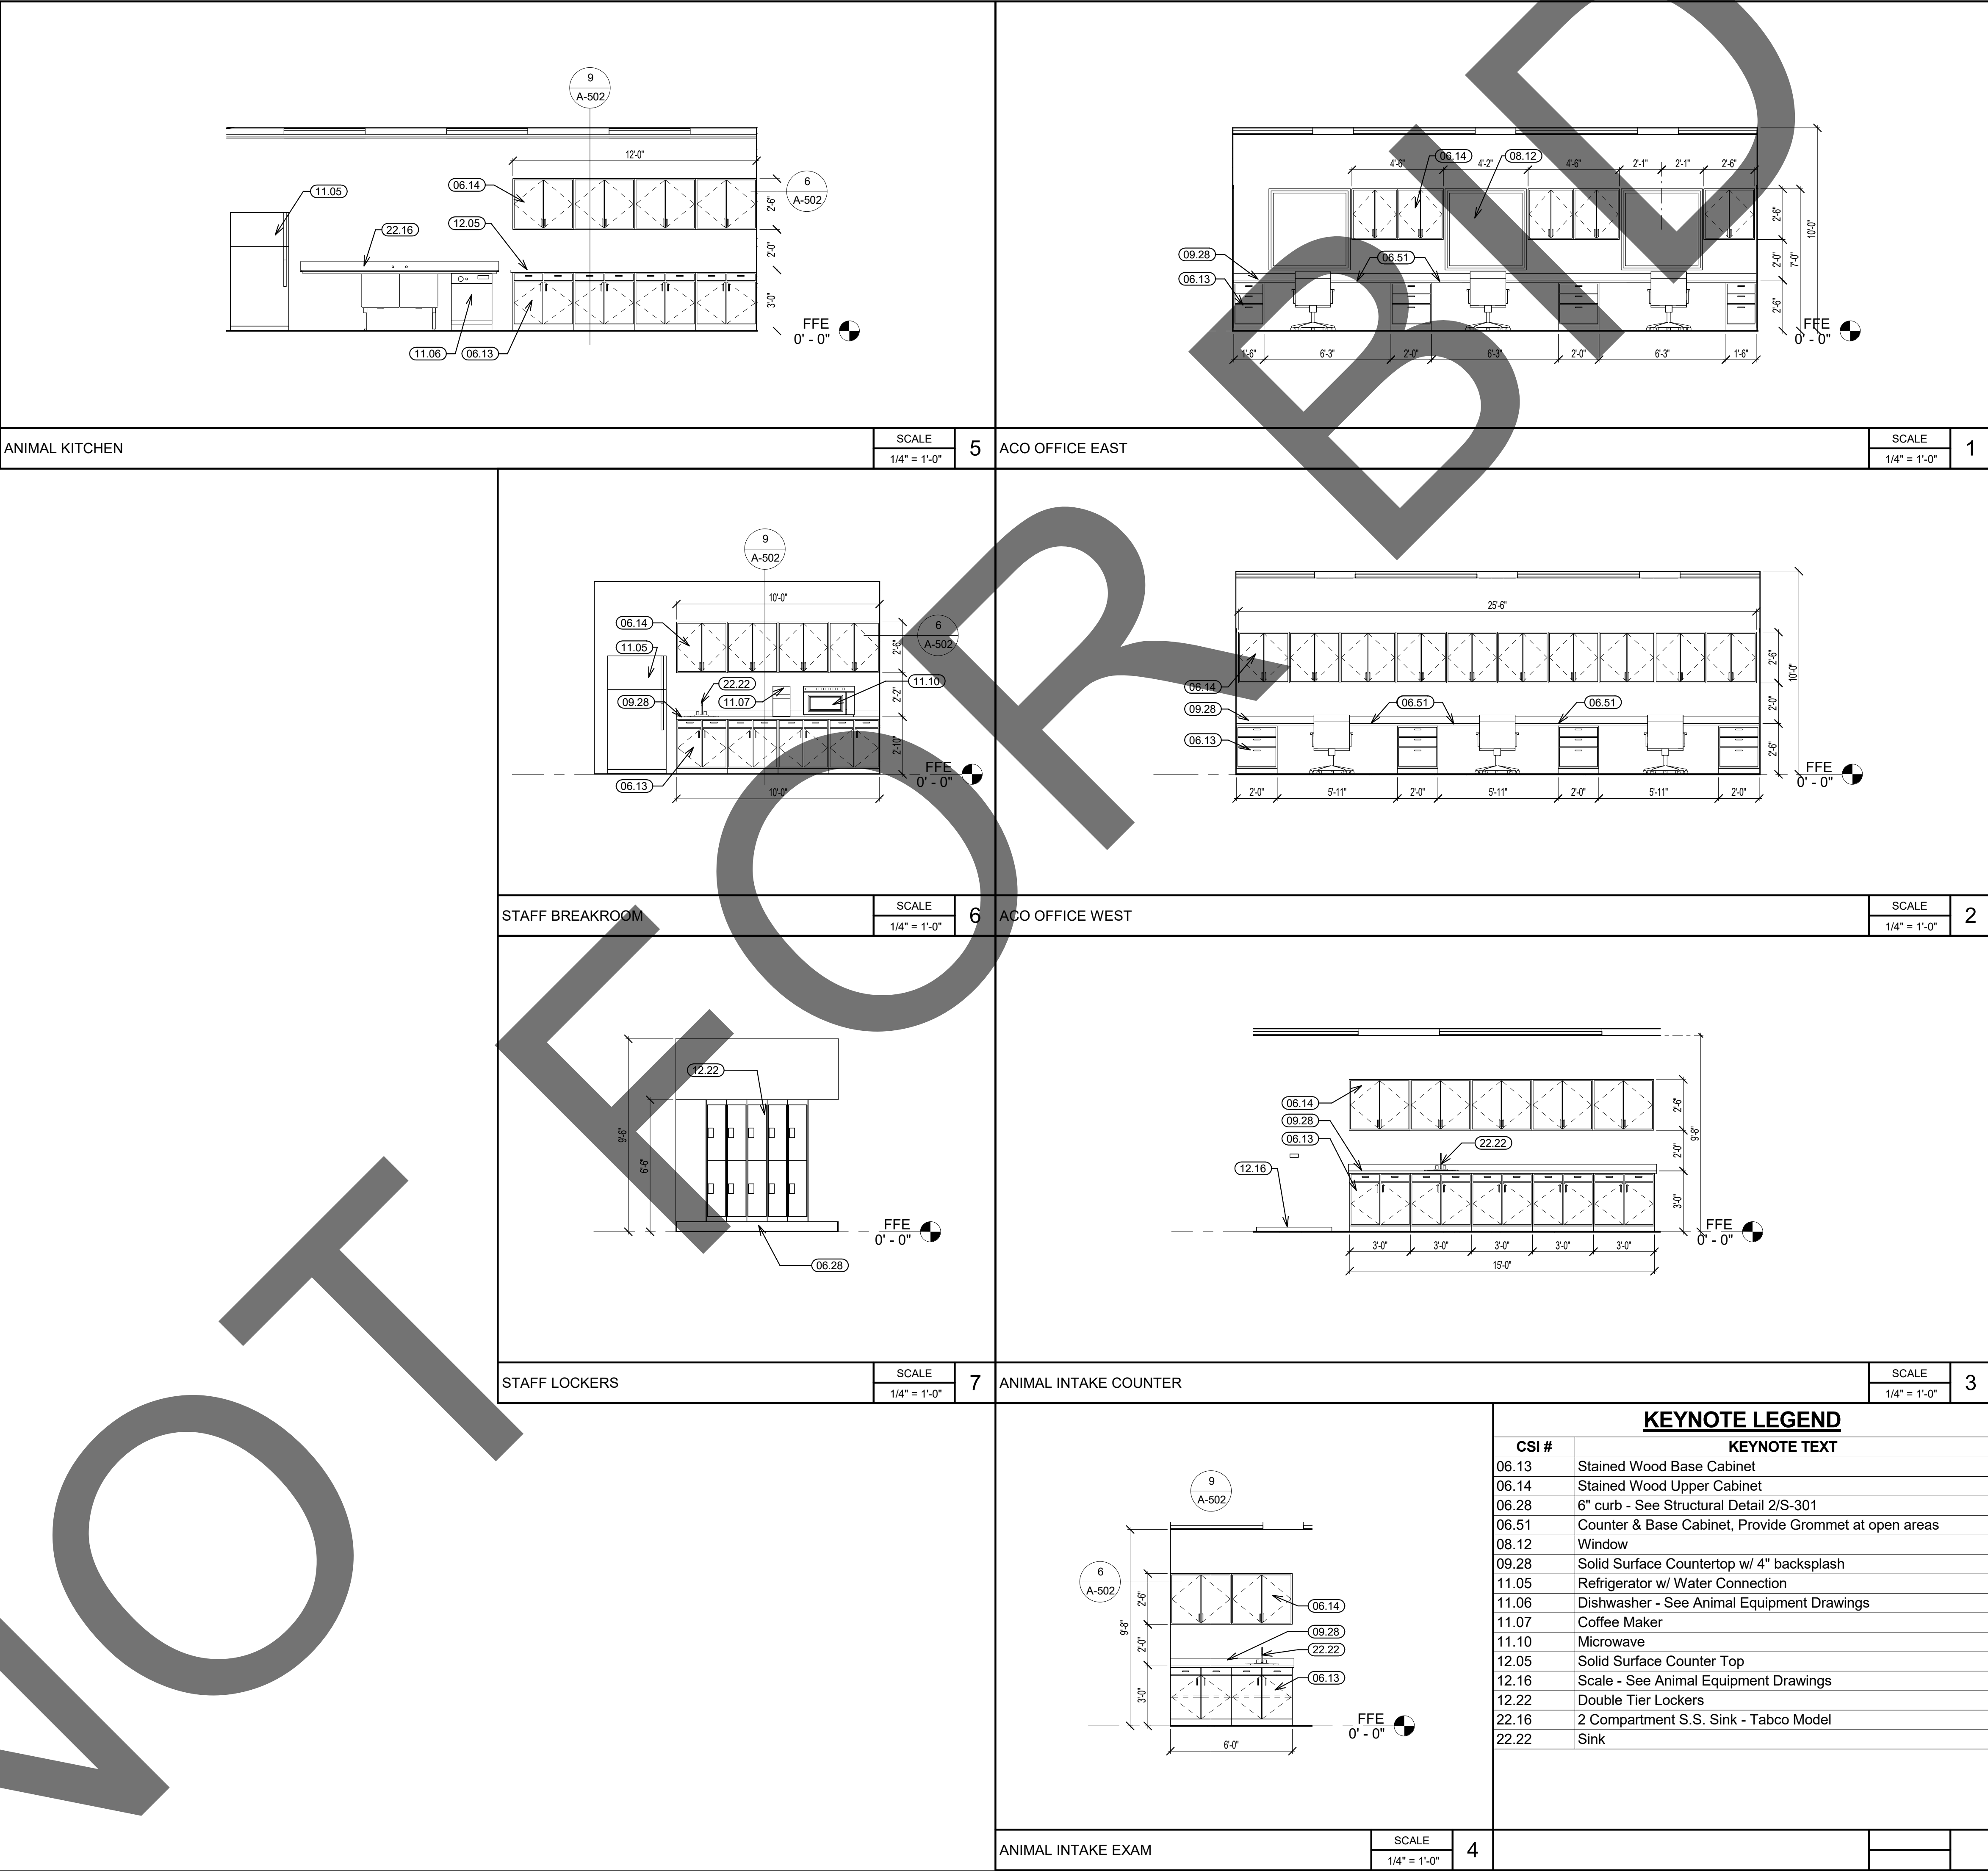

architecture
interiors
planning

1177 Idaho Street, Suite 200
Redlands, CA 92374
Phone: 909-335-7400
Fax: 909-335-7299
info@miller-aip.com



OWNER APPROVAL

INITIALS	DATE	PHASE

REVISIONS/ADDENDA

#	Date	Comment
---	------	---------

ANIMAL CARE CENTER

18313 VALLEY BLVD.
BLOOMINGTON, CA 92313

SAN BERNARDINO COUNTY

385 N. Arrowhead Ave., 3rd Floor
San Bernardino, CA 92415

PROJECT INFORMATION

Project Number:	2200065
Drawn By:	Author
Checked By:	GWM
Issue Date:	2/29/24

SHEET NAME


ENLARGED
PLANS /
INTERIOR
ELEVATIONS

SHEET NUMBER


AI-402

Sheet Of Sheets


DOOR SCHEDULE															
DOOR NUMBER	TYPE	PAIR OR SINGL E	SIZE		DOOR		FRAME		DETAIL				FIRE RATING	HW GROUP	REMARKS
			WIDTH	HEIGHT	FINISH	MATERIAL	FINISH	MATERIAL	HEAD	JAMB 1	JAMB 2	SILL			
1A	A	S	10' - 0"	10' - 0"	F	M	F	M	15/A-502	16/A-502		17/A-502			
1B	B	S	3' - 0"	7' - 0"	F	M	F	M	17/A-501	18/A-501					
1C	A	S	10' - 0"	10' - 0"	F	M	F	M	15/A-502	16/A-502		17/A-502			
1D	B	S	3' - 0"	7' - 0"	F	M	F	M	17/A-501	18/A-501					
2	C	P	6' - 0"	7' - 0"	F	M	F	M	17/A-501	18/A-501					
2B	C	P	6' - 0"	7' - 0"	F	M	F	M	17/A-501	18/A-501					
3	D	S	3' - 0"	7' - 0"	SCF	WD	F	M	17/A-501	18/A-501					
7	D	S	3' - 0"	7' - 0"	F	M	F	M	17/A-501	18/A-501					
8	C	P	6' - 0"	7' - 0"	F	M	F	M	17/A-501	18/A-501					
9	D	S	3' - 0"	7' - 0"	SCF	WD	F	M	17/A-501	18/A-501					
9A	C	P	6' - 0"	7' - 0"	F	M	F	M	17/A-501	18/A-501					
10	D	S	3' - 0"	7' - 0"	SCF	WD	F	M	17/A-501	18/A-501					
11	D	S	3' - 0"	7' - 0"	F	M	F	M	17/A-501	18/A-501					
12	D	S	3' - 0"	7' - 0"	F	M	F	M	17/A-501	18/A-501					
14A	E	S	3' - 0"	7' - 0"	F	M	F	M	17/A-501	18/A-501					
14B	E	S	3' - 0"	7' - 0"	SCF	WD	F	M	17/A-501	18/A-501					
14K			2' - 8"	5' - 6"	F	M	F	M					1 HR		NIS
14N			2' - 8"	5' - 6"	F	M	F	M					1 HR		NIS
16	B	S	3' - 0"	7' - 0"	SCF	WD	F	M	17/A-501	18/A-501					
18	B	S	3' - 0"	7' - 0"	SCF	WD	F	M	17/A-501	18/A-501					
20	B	S	3' - 0"	7' - 0"	F	M	F	M	17/A-501	18/A-501					
21	B	S	3' - 0"	7' - 0"	F	M	F	M	17/A-501	18/A-501					
21A	B	S	3' - 0"	7' - 0"	F	M	F	M	17/A-501	18/A-501					
22	B	S	3' - 0"	7' - 0"	F	M	F	M	17/A-501	18/A-501					
23	B	S	3' - 0"	7' - 0"	F	M	F	M	17/A-501	18/A-501					
24	B	S	3' - 0"	7' - 0"	F	M	F	M	17/A-501	18/A-501					
25	B	S	3' - 0"	7' - 0"	F	M	F	M	17/A-501	18/A-501					
26	B	S	3' - 6"	7' - 0"	F	M	F	M	17/A-501	18/A-501					

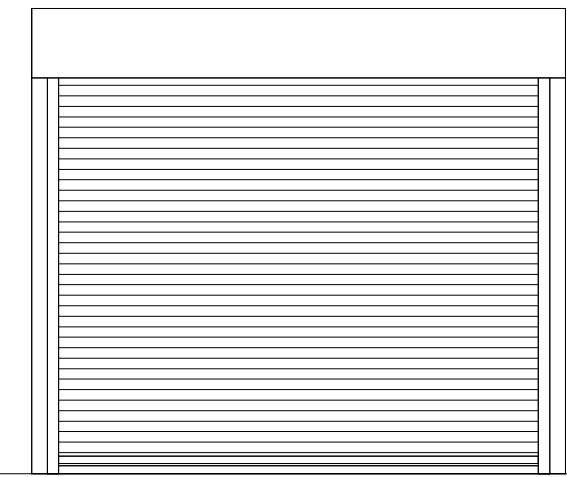


A OVERHEAD DOOR

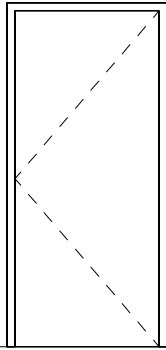


B SINGLE FLUSH EXTERIOR DOOR

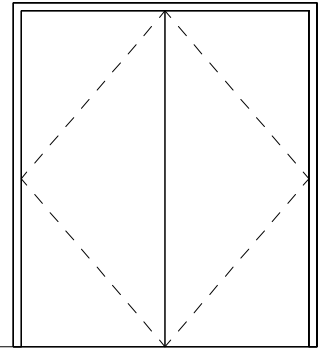

C DOUBLE FLUSH EXTERIOR DOOR

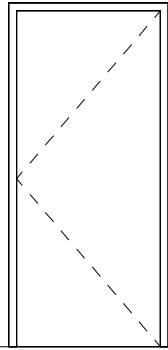

D SINGLE FLUSH INTERIOR DOOR

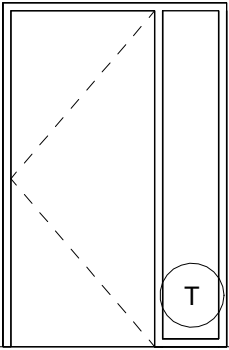

E SINGLE FLUSH EXT/INTERIOR DOOR W/SIDELITE


FLOOR LINE

1/4" = 1'-0"

DOOR TYPES

T TEMPERED GLAZING

WINDOW SCHEDULE												
MARK	WINDOW TYPE	SIZE		GLAZING	FRAME		FIRE RATING	DETAILS				REMARKS
		WIDTH	HEIGHT		MATERIAL	FINISH		HEAD	JAMB 1	JAMB 2	SILL	
I1	A	4' - 0"	4' - 0"	3	AL	F		1/A-501	10/A-501			
I2	A	4' - 0"	4' - 0"	3	AL	F		1/A-501	10/A-501			

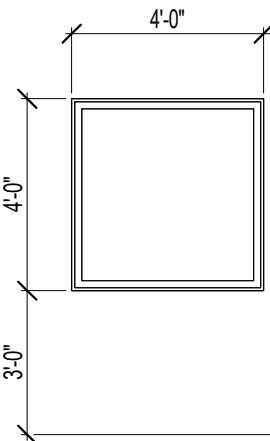

A

WINDOW TYPES

T TEMPERED GLAZING

1/4" = 1'-0"

DOOR GENERAL NOTES:

- EXIT DOORS SHALL BE OPERABLE FROM THE INSIDE WITHOUT THE USE OF A KEY OR SPECIAL KNOWLEDGE OR EFFORT.
- GLASS AND GLAZING SHALL COMPLY WITH CBC CHAPTER 24.
- MAXIMUM EFFORT TO OPERATE DOORS:
EXTERIOR - 5.0 LBS
INTERIOR - 5.0 LBS
- VERIFY ALL DOOR FRAME THROAT SIZES WITH FINISHED WALL THICKNESS PRIOR TO ORDERING FRAMES.
- ALL HAND ACTIVATED DOOR OPENING HARDWARE AT LATCHING OR LOCKING DOORS ON THE ACCESSIBLE PATH OF TRAVEL SHALL BE OPERABLE WITH SINGLE EFFORT LEVER TYPE HARDWARE, PANIC BARS, PUSH/PULL ACTIVATING BARS OR OTHER HARDWARE DESIGNED TO PROVIDE PASSAGE WITHOUT REQUIRING THE ABILITY TO GRASP THE HARDWARE.
- MAIN ENTRY DOOR SHALL BE PROVIDED WITH AN INDICATING FLAG LOCK AND REQUIRED DECAL ON HEADER STATING, "THIS DOOR TO REMAIN UNLOCKED WHEN THIS SPACE IS OCCUPIED PER CBC 1010.1.9.3
- FIRE DOORS SHALL BE LATCHED AN SELF OR AUTOMATIC-CLOSING IN ACCORDANCE WITH SECTION 716.2.6.1.
- CHUTE INTAKE DOORS SHALL BE POSITIVE LATCHING, REMAINING LATCHED AND CLOSED IN THE EVENT OF LATCH SPRING FAILURE DURING A FIRE EMERGENCY.
- ALL UNIT NUMBERS TO BE A MIN. OF 4" HIGH INSTALLED ON A CONTRASTING BACKGROUND.

DOOR SCHEDULE LEGEND:

DOOR:

MATERIAL

AL ALUMINUM
WD WOOD
M METAL
G GLASS
V VINYL

FINISH

SCF STAIN & CLEAR FINISH
P PAINT
F FACTORY APPLIED
T TEMPERED GLASS
E EXISTING FINISH

FRAME:

MATERIAL

AL ALUMINUM
HM HOLLOW METAL
M METAL
E EXISTING

FINISH

P PAINT
F FACTORY APPLIED
E EXISTING FINISH

REMARKS:

R1 ACCESSIBILITY SIGN
R2 PANIC DEVICE
R3 CARD READER
R4 METAL KICK PLATES
R5 PANIC DEVICE
R6 SMOKE GASKET
R7 WEATHERSTRIP
R8 CLOSER

FOR

NOT

WINDOW

GLAZING:

- TEMPERED GLASS
- WIRE GLASS
- DUAL GLAZING
- SINGLE GLAZING
- FIRE PROTECTION RATED GLAZING

FRAME

MATERIAL:

AL ALUMINUM
HM HOLLOW METAL
E EXISTING
VL VINYL FRAME MATERIAL

FINISH:


P PAINTED
F FACTORY APPLIED
E EXISTING FINISH

GLAZING NOTES

- ALL EXTERIOR GLAZING TO COMPLY WITH THE FOLLOWING TITLE 24 REQUIREMENTS:
A. U-FACTOR: 0.00
B. SHGC: 0.00
C. VT: 0.00
- ALL EXTERIOSOLARBAN 70XL SOLEXIA 1-INCH INSULATED LOW-E VITRO OR EQUAL

STOREFRONT NOTES:


- T DENOTES TEMPERED GLASS
- 10 CUSTOM WINDOW SEE WINDOW SCHEDULE
- 1 PRE-MANUFACTURED WINDOWS SEE WINDOW SCHEDULE

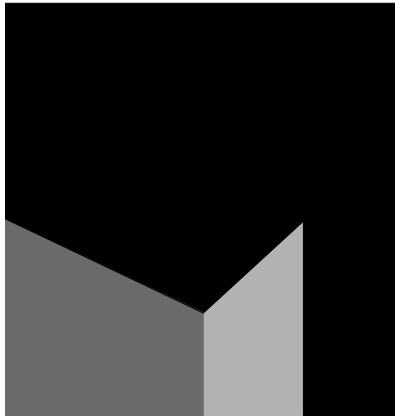

architecture
interiors
planning

MILLER

1177 Idaho Street, Suite 200
Redlands, CA 92374
Phone: 909-335-7400
Fax: 909-335-7299
info@miller-aip.com

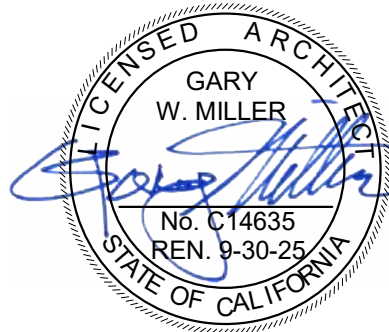

owner approval

initials	date	phase

REVISIONS/ADDENDA

#	Date	Comment
---	------	---------

ANIMAL CARE CENTER

18313 VALLEY BLVD.
BLOOMINGTON, CA 92313

SAN BERNARDINO COUNTY

385 N. ARROWHEAD AVENUE
SAN BERNARDINO, CA 92415
PHONE: 1-888-818-8988

PROJECT INFORMATION

Project Number: 2200065
Drawn By: Author
Checked By: GWM
Issue Date: 2/29/24

SHEET NAME

DOOR /
WINDOW
SCHEDULE

SHEET NUMBER

AI-601

Sheet Of Sheets

FINISH SCHEDULE														
ROOM NUMBER	ROOM NAME	FLOOR	BASE	WALL FINISH				WAINSCOT FINISH				CEILING MATERIAL	CEILING HEIGHT	REMARKS
				A	B	C	D	A	B	C	D			
1	DISASTER STORAGE	F4	B1	W1	W1	W1	W1					C3	12' - 0"	
2	GENERAL STORAGE	F4	B1	W1	W1	W1	W1					C3	12' - 0"	
3	FILE ROOM	F4	B1	W1	W1	W1	W1					C1	10' - 0"	
4	TRAP STORAGE	F4	B1	W1	W1	W1	W1					C3	0"	
5	EVENT STORAGE	F4	B1	W1	W1	W1	W1					C3	0"	
6	CARRIER STORAGE	F4	B1	W1	W1	W1	W1					C3	0"	
7	MAINTENANCE ROOM	F4	B1	W1	W1	W1	W1					C1	10' - 0"	
8	MECHANICAL/ ELECTRICAL	F4	B1	W1	W1	W1	W1					C3		
9	FOOD AND LITTER STORAGE	F4	B1	W1	W1	W1	W1					C1	9' - 0"	
10	BEHAVIOR	F5	B4	W1	W1	W1	W1	W4	W4	W4	W4	C1	10' - 0"	
11	DOG HOLDING	F5	B4	W1	W1	W1	W1	W4	W4	W4	W4	C1		
12	CAT HOLDING	F5	B4	W1	W1	W1	W1	W4	W4	W4	W4	C1	9' - 8"	
14	ACO OFFICE	F5	B4	W1	W1	W1	W1	W4	W4	W4	W4	C1	9' - 8"	
15	ADA SHOWER	F2	B3	W1	W1	W1	W1	W2	W2	W2	W2	C2	9' - 0"	
16	WOMEN'S TOILET/ SHOWER	F2	B3	W1	W1	W1	W1	W2	W2	W2	W2	C2	9' - 0"	
17	ADA SHOWER	F2	B3	W1	W1	W1	W1	W2	W2	W2	W2	C2	9' - 0"	
18	MEN'S TOILET/ SHOWER	F2	B3	W1	W1	W1	W1	W2	W2	W2	W2	C2	9' - 0"	
19	LOCKER ALCOVE	F2	B3	W1	W1	W1	W1					C1	9' - 6"	
20	STAFF BREAKROOM	F2	B3	W1	W1	W1	W1					C1	9' - 6"	
21	ANIMAL INTAKE EXAM	F5	B4	W1	W1	W1	W1	W4	W4	W4	W4	C1	9' - 8"	
22	PHOTO ROOM	F2	B3	W1	W1	W1	W1					C1	9' - 6"	
23	GROOMING ROOM	F2	B3	W1	W1	W1	W1	W4	W4	W4	W4	C1	9' - 6"	
24	HALL	F4	B1	W1	W1	W1	W1					C1	10' - 0"	
25	ANIMAL KITCHEN	F6	B5	W1	W1	W1	W1	W4	W4	W4	W4	C1	9' - 6"	
26	LAUNDRY	F4	B1	W1	W1	W1	W1					C1	10' - 0"	
27	MDF	F3	B1	W1	W1	W1	W1					C1	9' - 0"	

FLOOR MATERIAL:

F1 CARPET
F2 CERAMIC TILE
F3 VINYL TILE
F4 SEALED CONCRETE
F5 EPOXY
F6 PORCELAIN TILE

BASE MATERIAL:

B1 RUBBER CONE BASE
B2 CARPET
B3 CERAMIC TILE
B4 EPOXY RESIN COVERED
B5 PORCELAIN TILE

WALL MATERIAL:

W1 GYPSUM BOARD - TEXTURED AND PAINTED
W2 CERAMIC TILE
W3 EXPOSED FRAMING
W4 FRP

CEILING:

C1 SUSPENDED ACOUSTICAL CEILING
C2 GYPSUM BOARD - TEXTURED AND PAINTED
C3 EXPOSED FRAMING
C4 CERAMIC GUARD ACOUSTICAL CEILING

REMARKS:

R1 W2 WAINSCOTING TO BE 8'-0"
R2 W4 WAINSCOTING TO BE 4'-0"
R3 2" CMU @ BACKS
R4 X
R5 X
R6 X

GENERAL NOTES:

1. INTERIOR FINISH MATERIALS SHALL COMPLY WITH 2022 CBC CHAPTER 12.
2. WATER RESISTANT GYPSUM BOARD COMPLYING WITH 2022 CBC SECTION 2509 TO BE USED IN TOILET ROOMS.
3. GYPSUM BOARD TO BE 5/8" TYPE "X" UNLESS NOTED OTHERWISE.



architecture
interiors
planning

1177 Idaho Street, Suite 200
Redlands, CA 92374
Phone: 909-335-7400
Fax: 909-335-7299
info@miller-aip.com



owner approval		
initials	date	phase

REVISIONS/ADDENDA

#	Date	Comment
---	------	---------

ANIMAL CARE CENTER

18313 VALLEY BLVD.
BLOOMINGTON, CA 92313

SAN BERNARDINO COUNTY

385 N. ARROWHEAD AVENUE
SAN BERNARDINO, CA 92415
PHONE: 1-888-818-8988

PROJECT INFORMATION	
Project Number:	2200065
Drawn By:	Author
Checked By:	GWM
Issue Date:	2/29/24



SHEET NAME

FINISH
SCHEDULE

SHEET NUMBER

AI-602

FLOOR PLAN - ADOPTION DOG BUILDING 5, 6, & 7

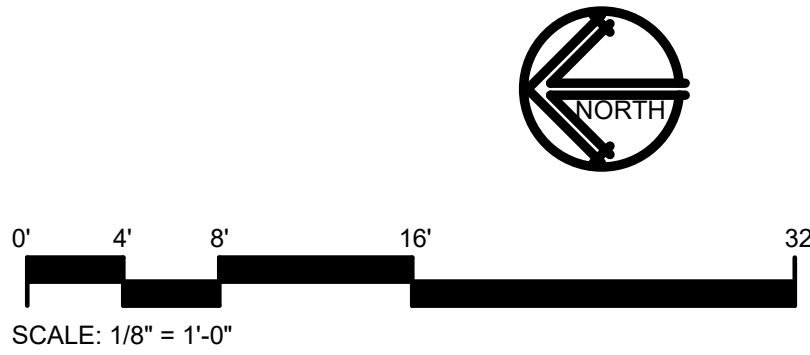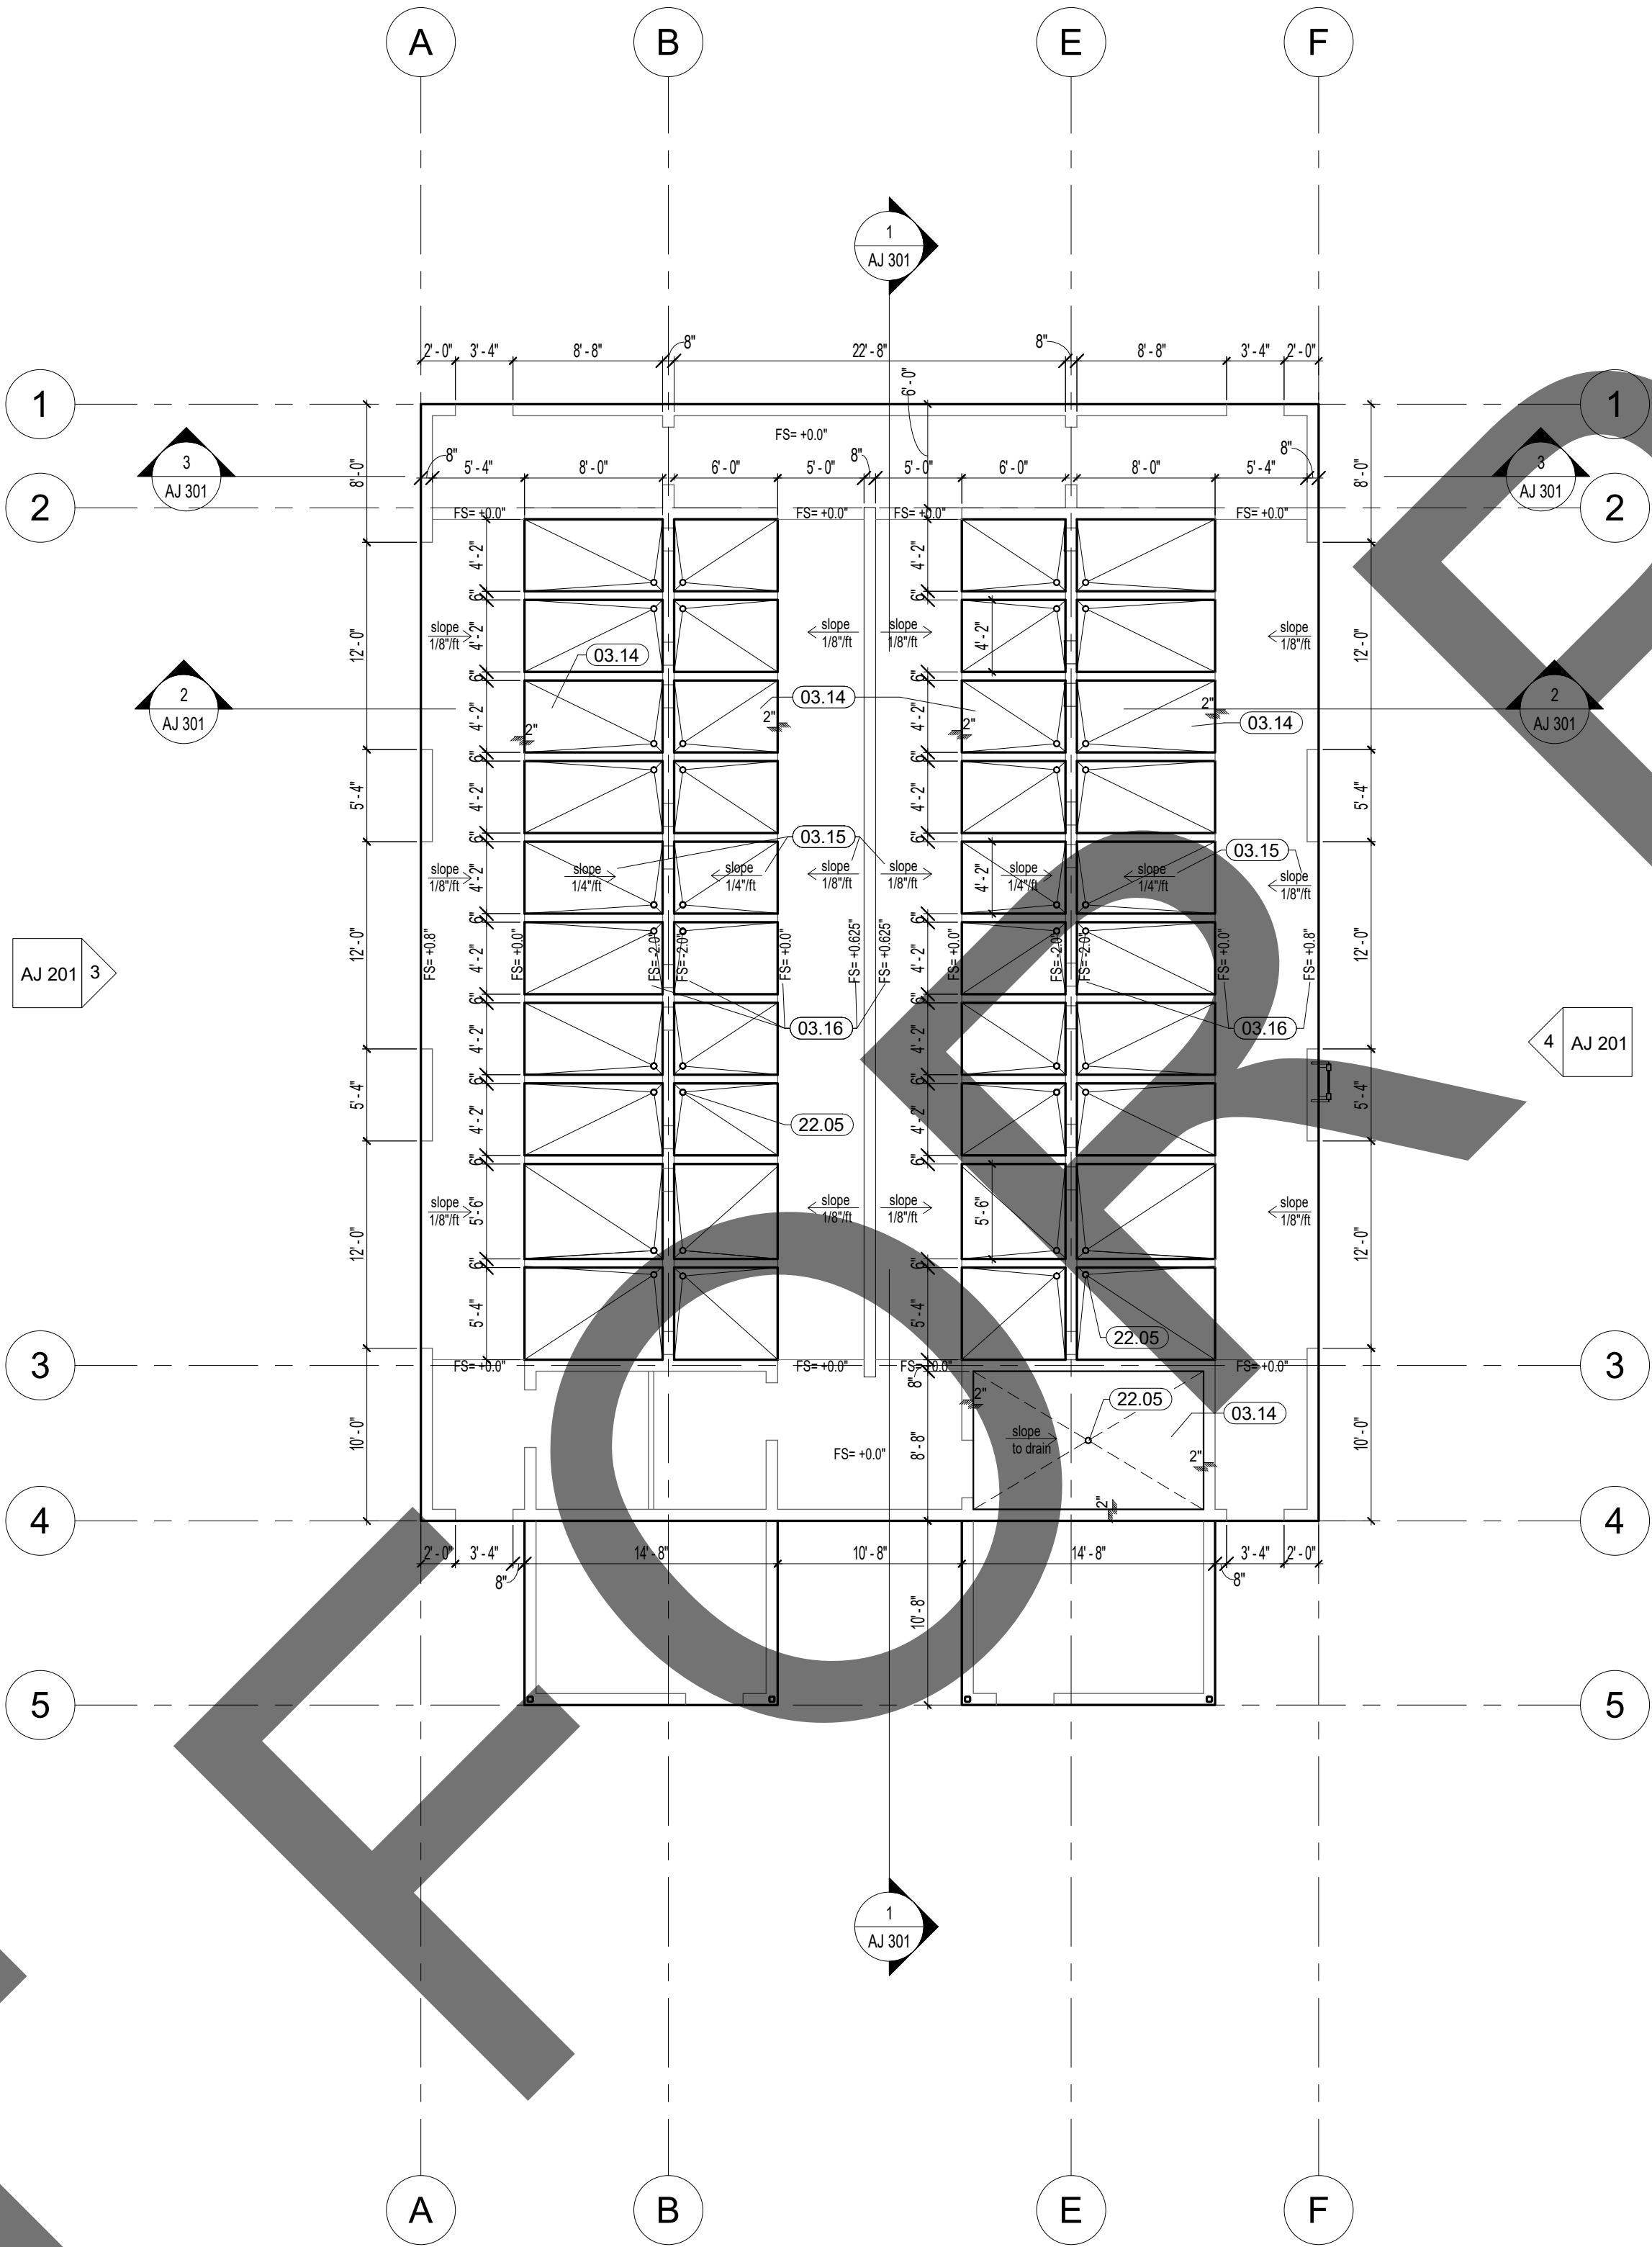

SCALE	1
1/8" = 1'-0"	

GENERAL LAYOUT PLAN NOTES:

- COORDINATE UNDERSLAB WASTE LINE DRAINS WITH PLUMBING DRAWINGS.
- COORDINATE FOUNDATION PLAN AND FOOTING DETAILS WITH STRUCTURAL DRAWINGS.
- COORDINATE UNDERSLAB POWER AND DATA REQUIREMENTS, CONDUIT ETC. WITH ELECTRICAL DRAWINGS.
- PROVIDE DEPRESSED SLAB AND SLOPES AS INDICATED ON DRAWING.

KEYNOTE LEGEND

CSI #	KEYNOTE TEXT
03.14	Depress Slab as Shown
03.15	Slope Indicates Final Slab Finish
03.16	Finish Surface Spot Elevation
22.05	Floor Drain - See Plumbing Drawings

GENERAL - LAYOUT PLAN NOTES

SCALE
12" = 1'-0"



architecture
interiors
planning

1177 Idaho Street, Suite 200
Redlands, CA 92374
Phone: 909-335-7400
Fax: 909-335-7299
info@miller-aip.com



owner approval

initials	date	phase

REVISIONS/ADDENDA

#	Date	Comment
---	------	---------

ANIMAL CARE CENTER

18313 VALLEY BLVD. BLOOMINGTON, CA 92313

SAN BERNARDINO COUNTY

385 N. ARROWHEAD AVENUE
SAN BERNARDINO, CA 92415
PHONE: 1-888-818-8988

PROJECT INFORMATION

Project Number:	2200065
Drawn By:	Author
Checked By:	GWM
Issue Date:	2/29/24

SHEET NAME


ADOPTION
LAYOUT PLAN

SHEET NUMBER

AJ100

Sheet Of Sheets

FLOOR PLAN - ADOPTION DOG BUILDING 5, 6, & 7

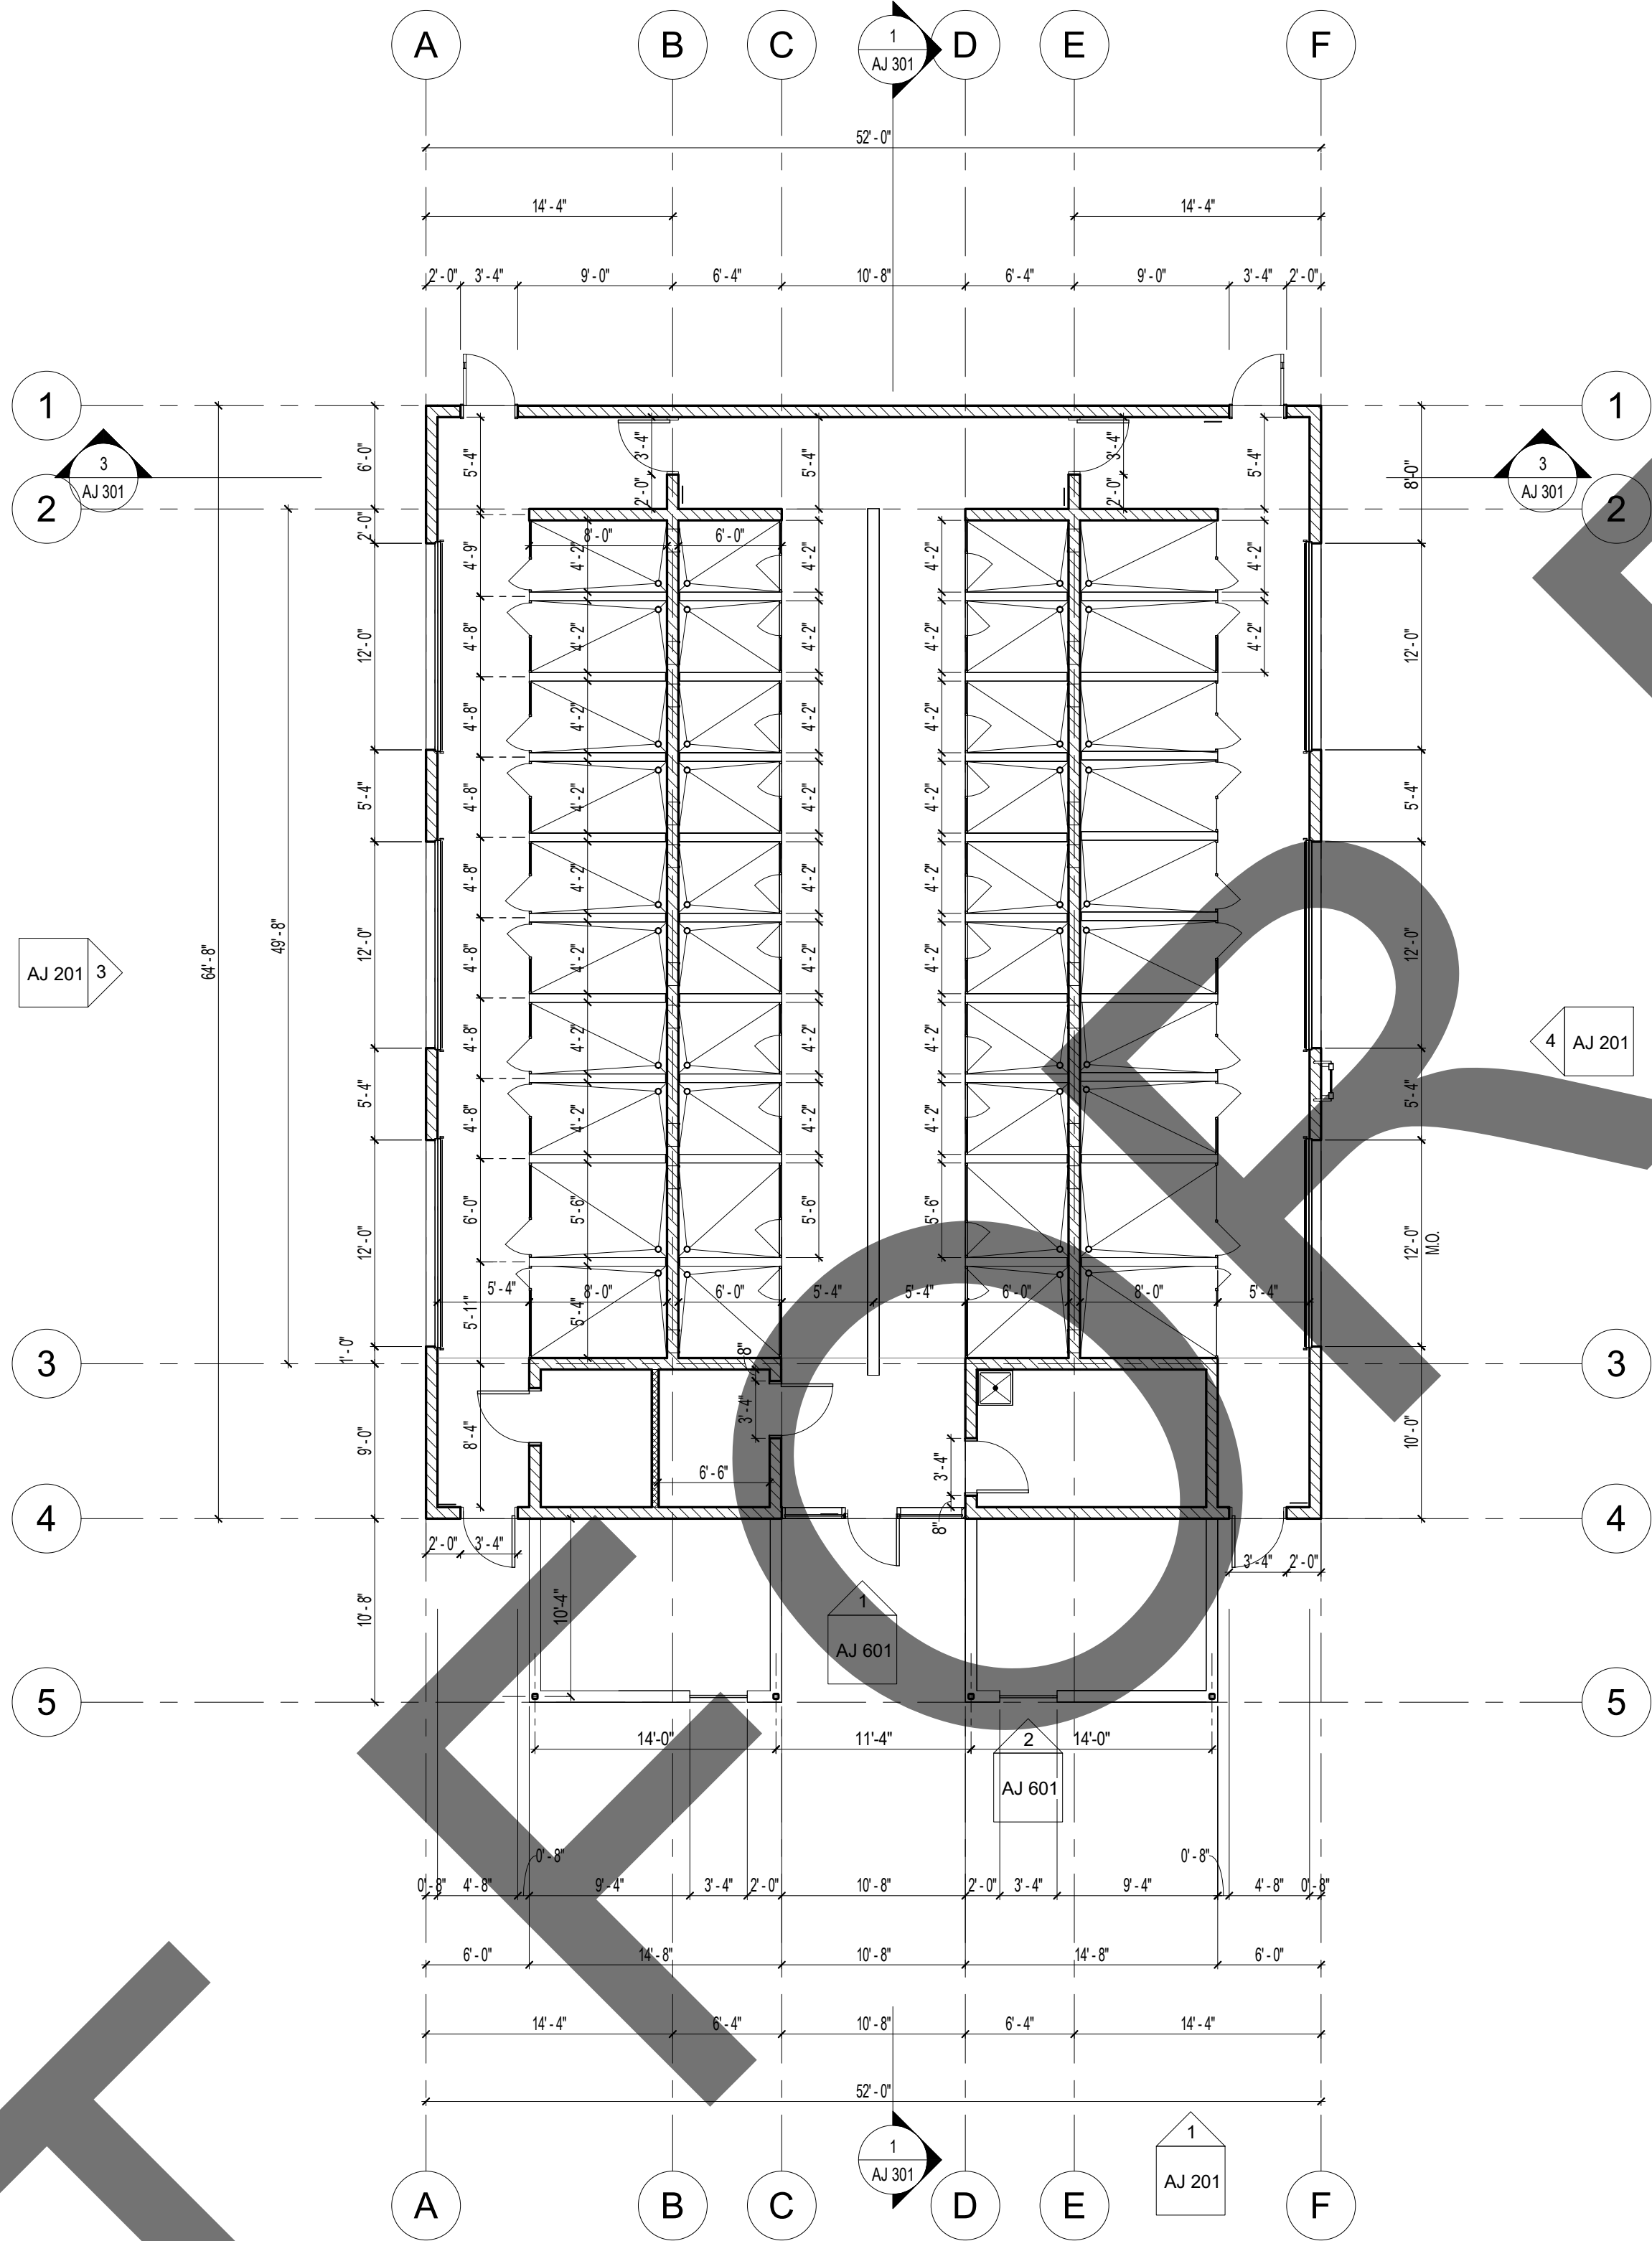


GENERAL LAYOUT PLAN NOTES:

1. COORDINATE UNDERSLAB WASTE LINE DRAINS WITH PLUMBING DRAWINGS.
2. COORDINATE FOUNDATION PLAN AND FOOTING DETAILS WITH STRUCTURAL DRAWINGS.
3. COORDINATE UNDERSLAB POWER AND DATA REQUIREMENTS, CONDUIT ETC. WITH ELECTRICAL DRAWINGS.
- W-1 6" STEEL STUDS @ 16" O.C. W/ R-19 BATT, R-14 RIGID INSULATION & TRFSPA EXT.
4. PROVIDE DEPRESSED SLAB AND SLOPES AS INDICATED ON DRAWING.
- W-2 6" STEEL STUDS @ 16" O.C. W/ R-19 BATT, R-14 RIGID INSULATION & STUCCO EXT.
- W-3 3 5/8" STEEL STUDS @ 24" O.C. GYP. BD. BOTH SIDES
- W-4 4" STEEL STUDS @ 16" O.C. GYP. BD. BOTH SIDES
- W-5 6" STEEL STUDS @ 16" O.C. w/ 5/8" GYP. BD. BOTH SIDES
- W-6 8" MASONRY CMU BLOCK
- W-7 6" STEEL STUDS, SPACING PER STRUCTURAL, FINISH PER ELVATIONS
- W-8 6" MASONRY CMU BLOCK

GENERAL LAYOUT PLAN NOTES


SCALE
1/8" = 1'-0"

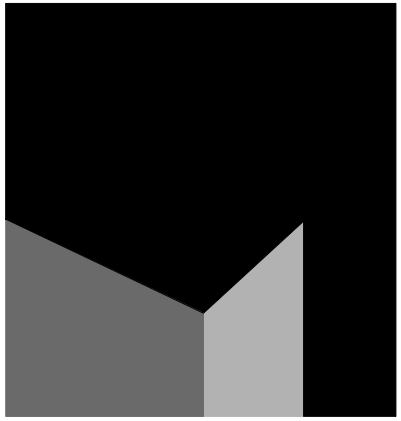

architecture
interiors
planning

MILLER

1177 Idaho Street, Suite 200
Redlands, CA 92374
Phone: 909-335-7400
Fax: 909-335-7299
info@miller-aip.com

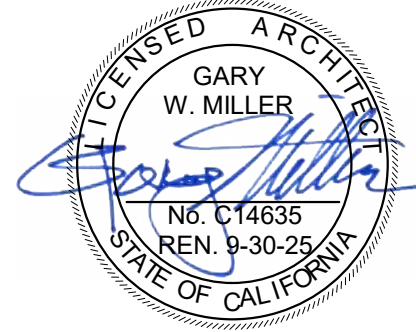

owner approval

initials	date	phase

REVISIONS/ADDENDA

#	Date	Comment
---	------	---------

ANIMAL CARE CENTER

18313 VALLEY BLVD. BLOOMINGTON, CA 92313

SAN BERNARDINO COUNTY

385 N. ARROWHEAD AVENUE
SAN BERNARDINO, CA 92415
PHONE: 1-888-818-8988

PROJECT INFORMATION

Project Number: 2200065
Drawn By: PF
Checked By: GWM
Issue Date: 2/29/24

SHEET NAME

ADOPTION DOG
BUILDING
DIMENSION
FLOOR PLAN

SHEET NUMBER

AJ 101

Sheet Of Sheets



**1177 Idaho Street, Suite 200
Redlands, CA 92374
Phone: 909-335-7400
Fax: 909-335-7299
info@miller-aip.com**



owner approval

initials	date	phase

REVISIONS/ADDENDA

#	Date	Comment
---	------	---------

ANIMAL CARE CENTER

18313 VALLEY BLVD. BLOOMINGTON, CA 92313

SAN BERNARDINO COUNTY

385 N. ARROWHEAD AVENUE
SAN BERNARDINO, CA 92415
PHONE: 1-888-818-8988

PROJECT INFORMATION

Project Number:	2200065
Drawn By:	Author
Checked By:	GWM
Issue Date:	2/29/24



SHEET NAME

ADOPTION DOG BUILDING ANNOTATION FLOOR PLAN

SHEET NUMBER

AJ 102

Sheet Of Sheets

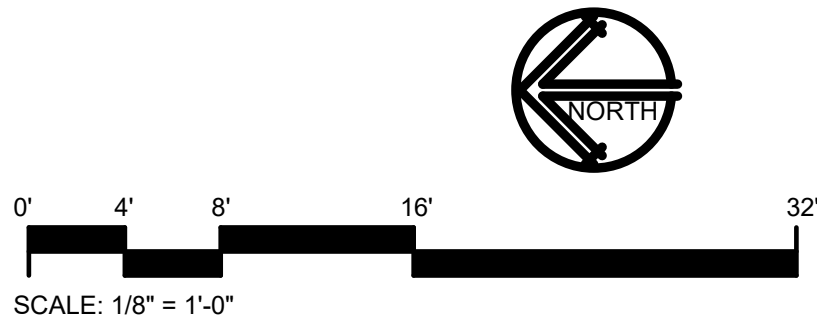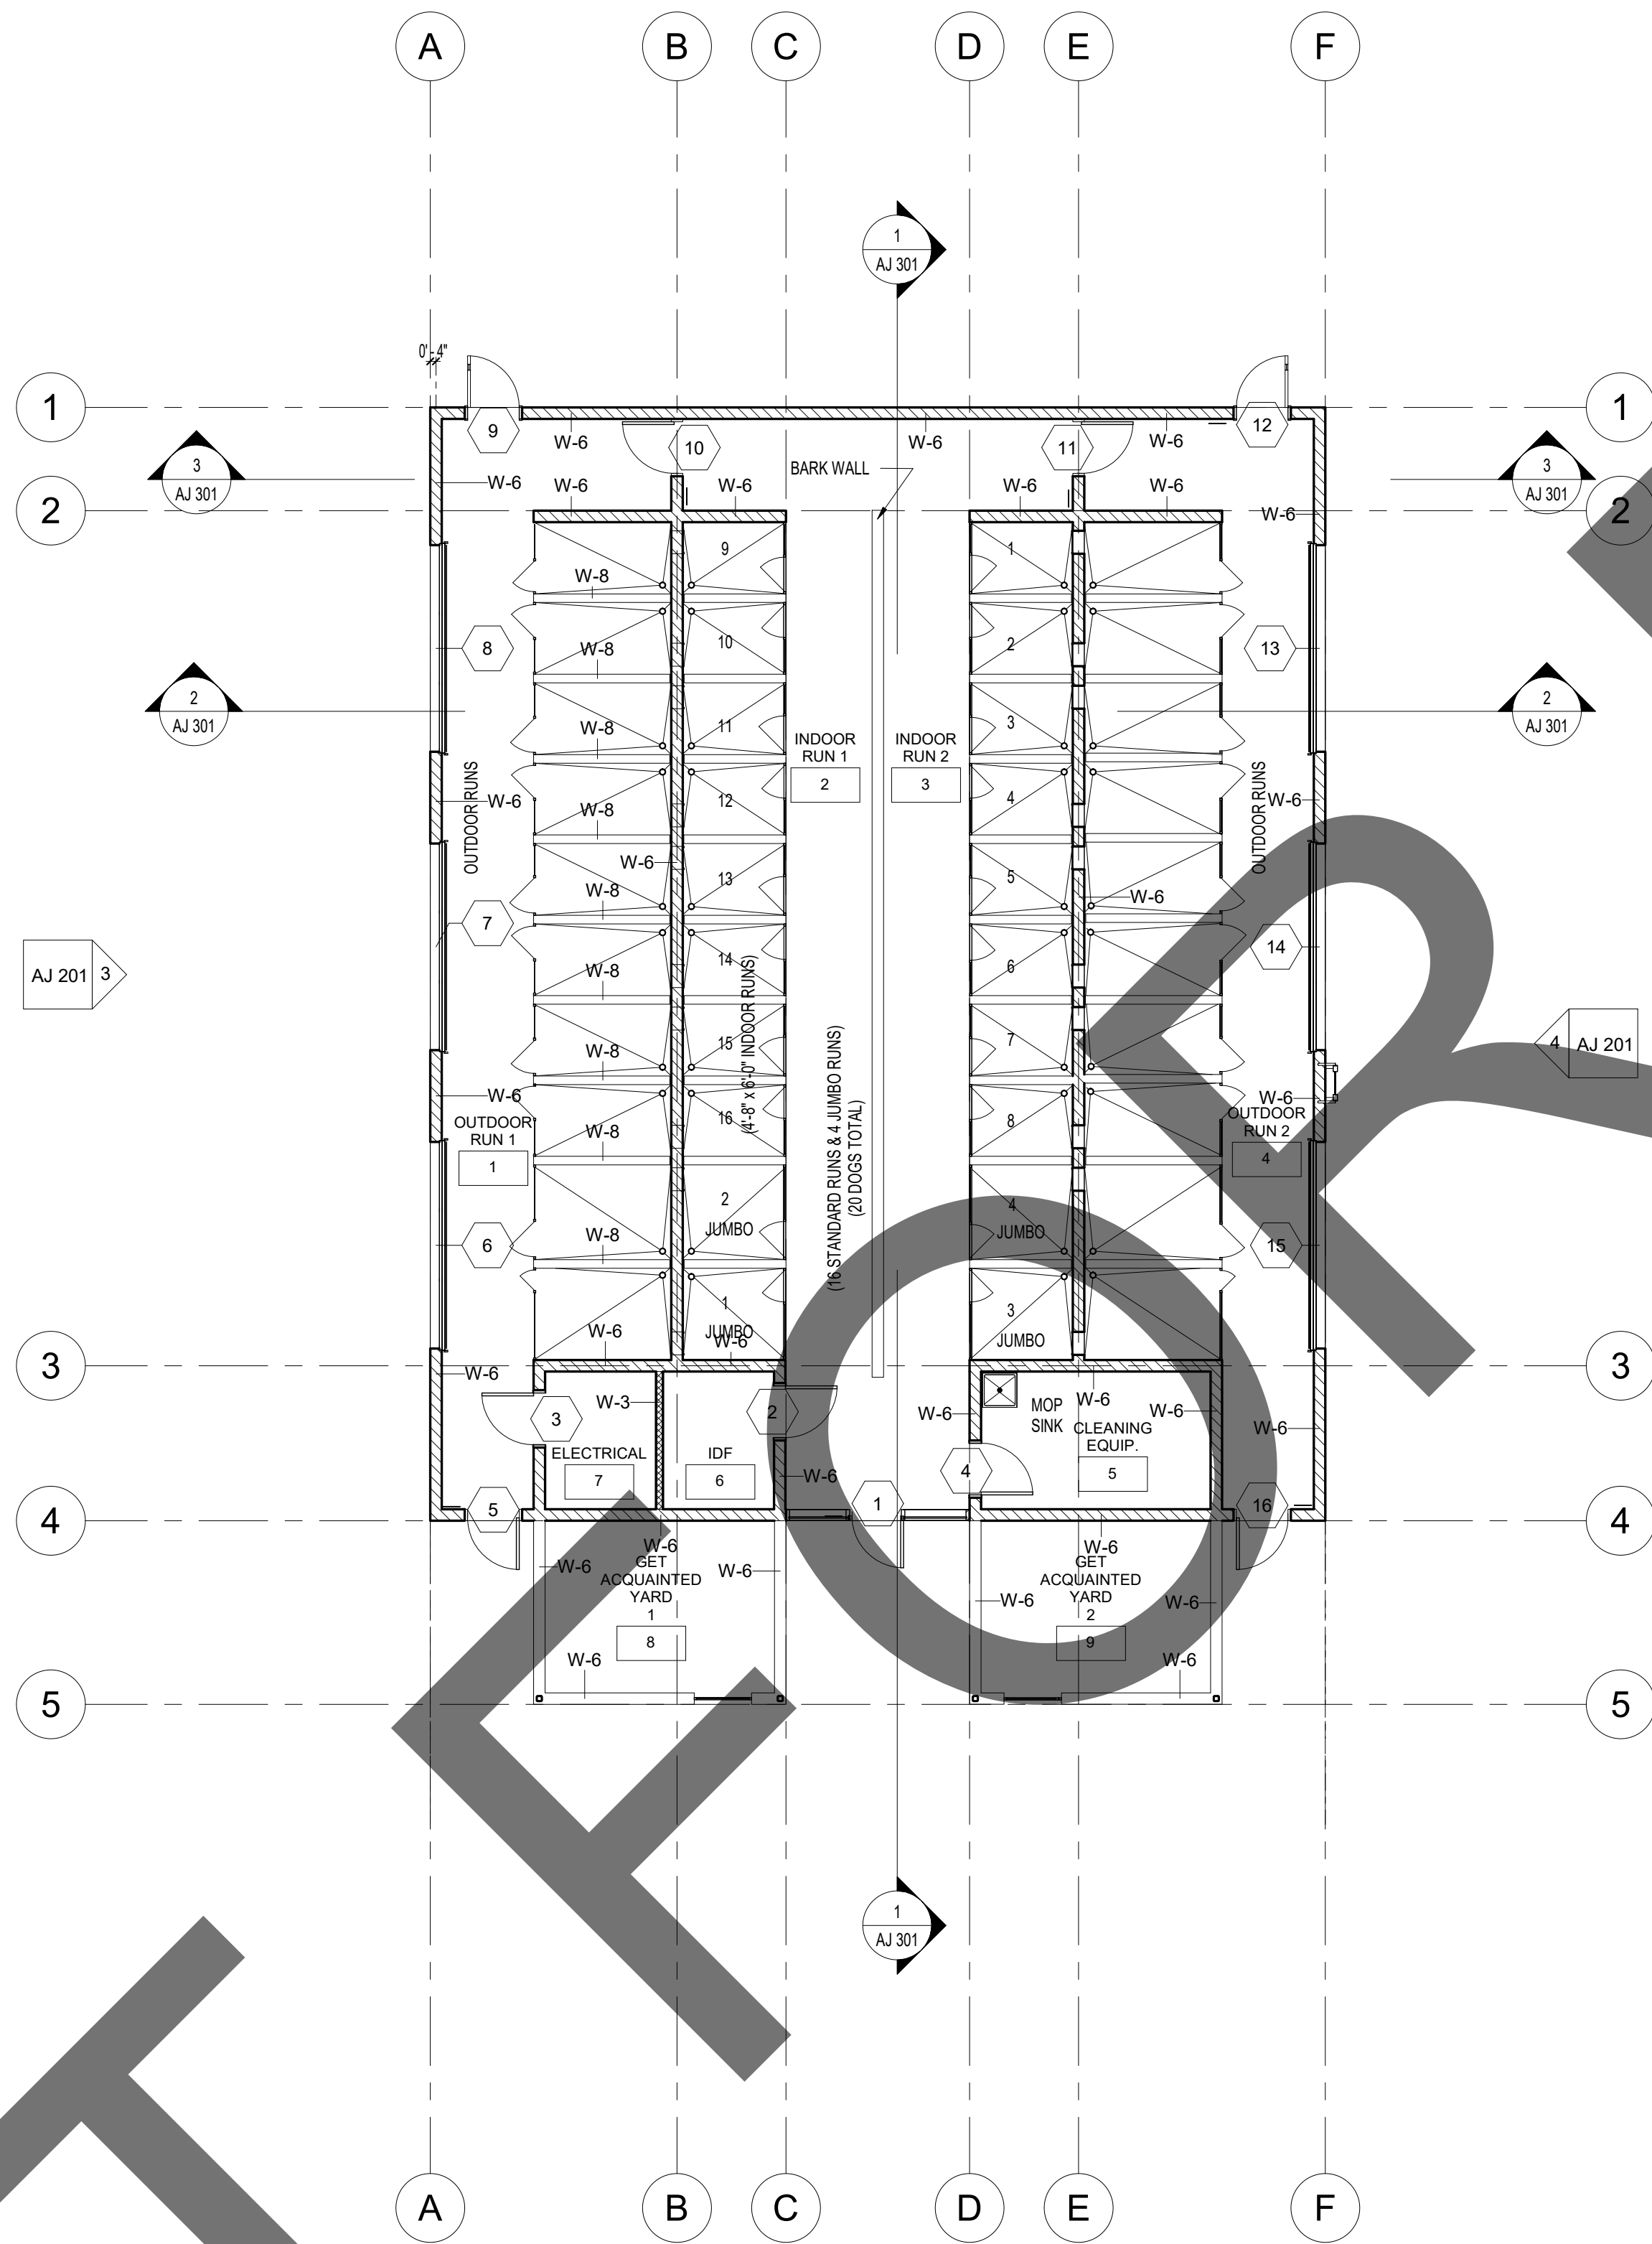

FLOOR PLAN - ADOPTION DOG BUILDING 5, 6, & 7

SCALE	1
1/8" = 1'-0"	

GENERAL FLOOR PLAN NOTES:

1. QUANTITIES LISTED ON THESE DOCUMENTS ARE FOR AGENCY APPROVAL ONLY. THE CONTRACTOR IS RESPONSIBLE FOR VERIFYING ALL QUANTITIES FOR BIDDING PURPOSES.
2. FINISH: PREPARE SUB-FLOOR AND LEAVE IN BROOM CLEAN CONDITION TO RECEIVE NEW FINISH AS REQUIRED. FLOOR SHALL BE LEVEL AND FREE OF DIPS, DIMPLES AND JOINTS.
3. REFER TO MECHANICAL, ELECTRICAL, AND PLUMBING DRAWINGS FOR ADDITIONAL SCOPE.

WALL TYPE LEGEND

 STEEL STUDS PER SCHEDULE
 CMU MASONRY UNIT

WALL TYPE SCHEDULE

W-1	6" STEEL STUDS @ 16" O.C. W/ R-19 BATT, R-14 RIGID INSULATION & TRESPA EXT.
W-2	6" STEEL STUDS @ 16" O.C. W/ R-19 BATT, R-14 RIGID INSULATION & STUCCO EXT.
W-3	3/8" STEEL STUDS @ 24" O.C. GYP. BD. BOTH SIDES
W-4	4" STEEL STUDS @ 16" O.C. GYP. BD. BOTH SIDES
W-5	6" STEEL STUDS @ 16" O.C. w/ 5/8" GYP. BD. BOTH SIDES
W-6	8" MASONRY CMU BLOCK
W-7	6" STEEL STUDS, SPACING PER STRUCTURAL, FINISH PER ELEVATIONS
W-8	6" MASONRY CMU BLOCK

KEYNOTE LEGEND

CSI #	KEYNOTE TEXT
-------	--------------


GENERAL - FLOOR PLAN NOTES

SCALE
12" = 1'-0"

WALL TYPE SCHEDULE

SCALE

1/4" = 1'-0"

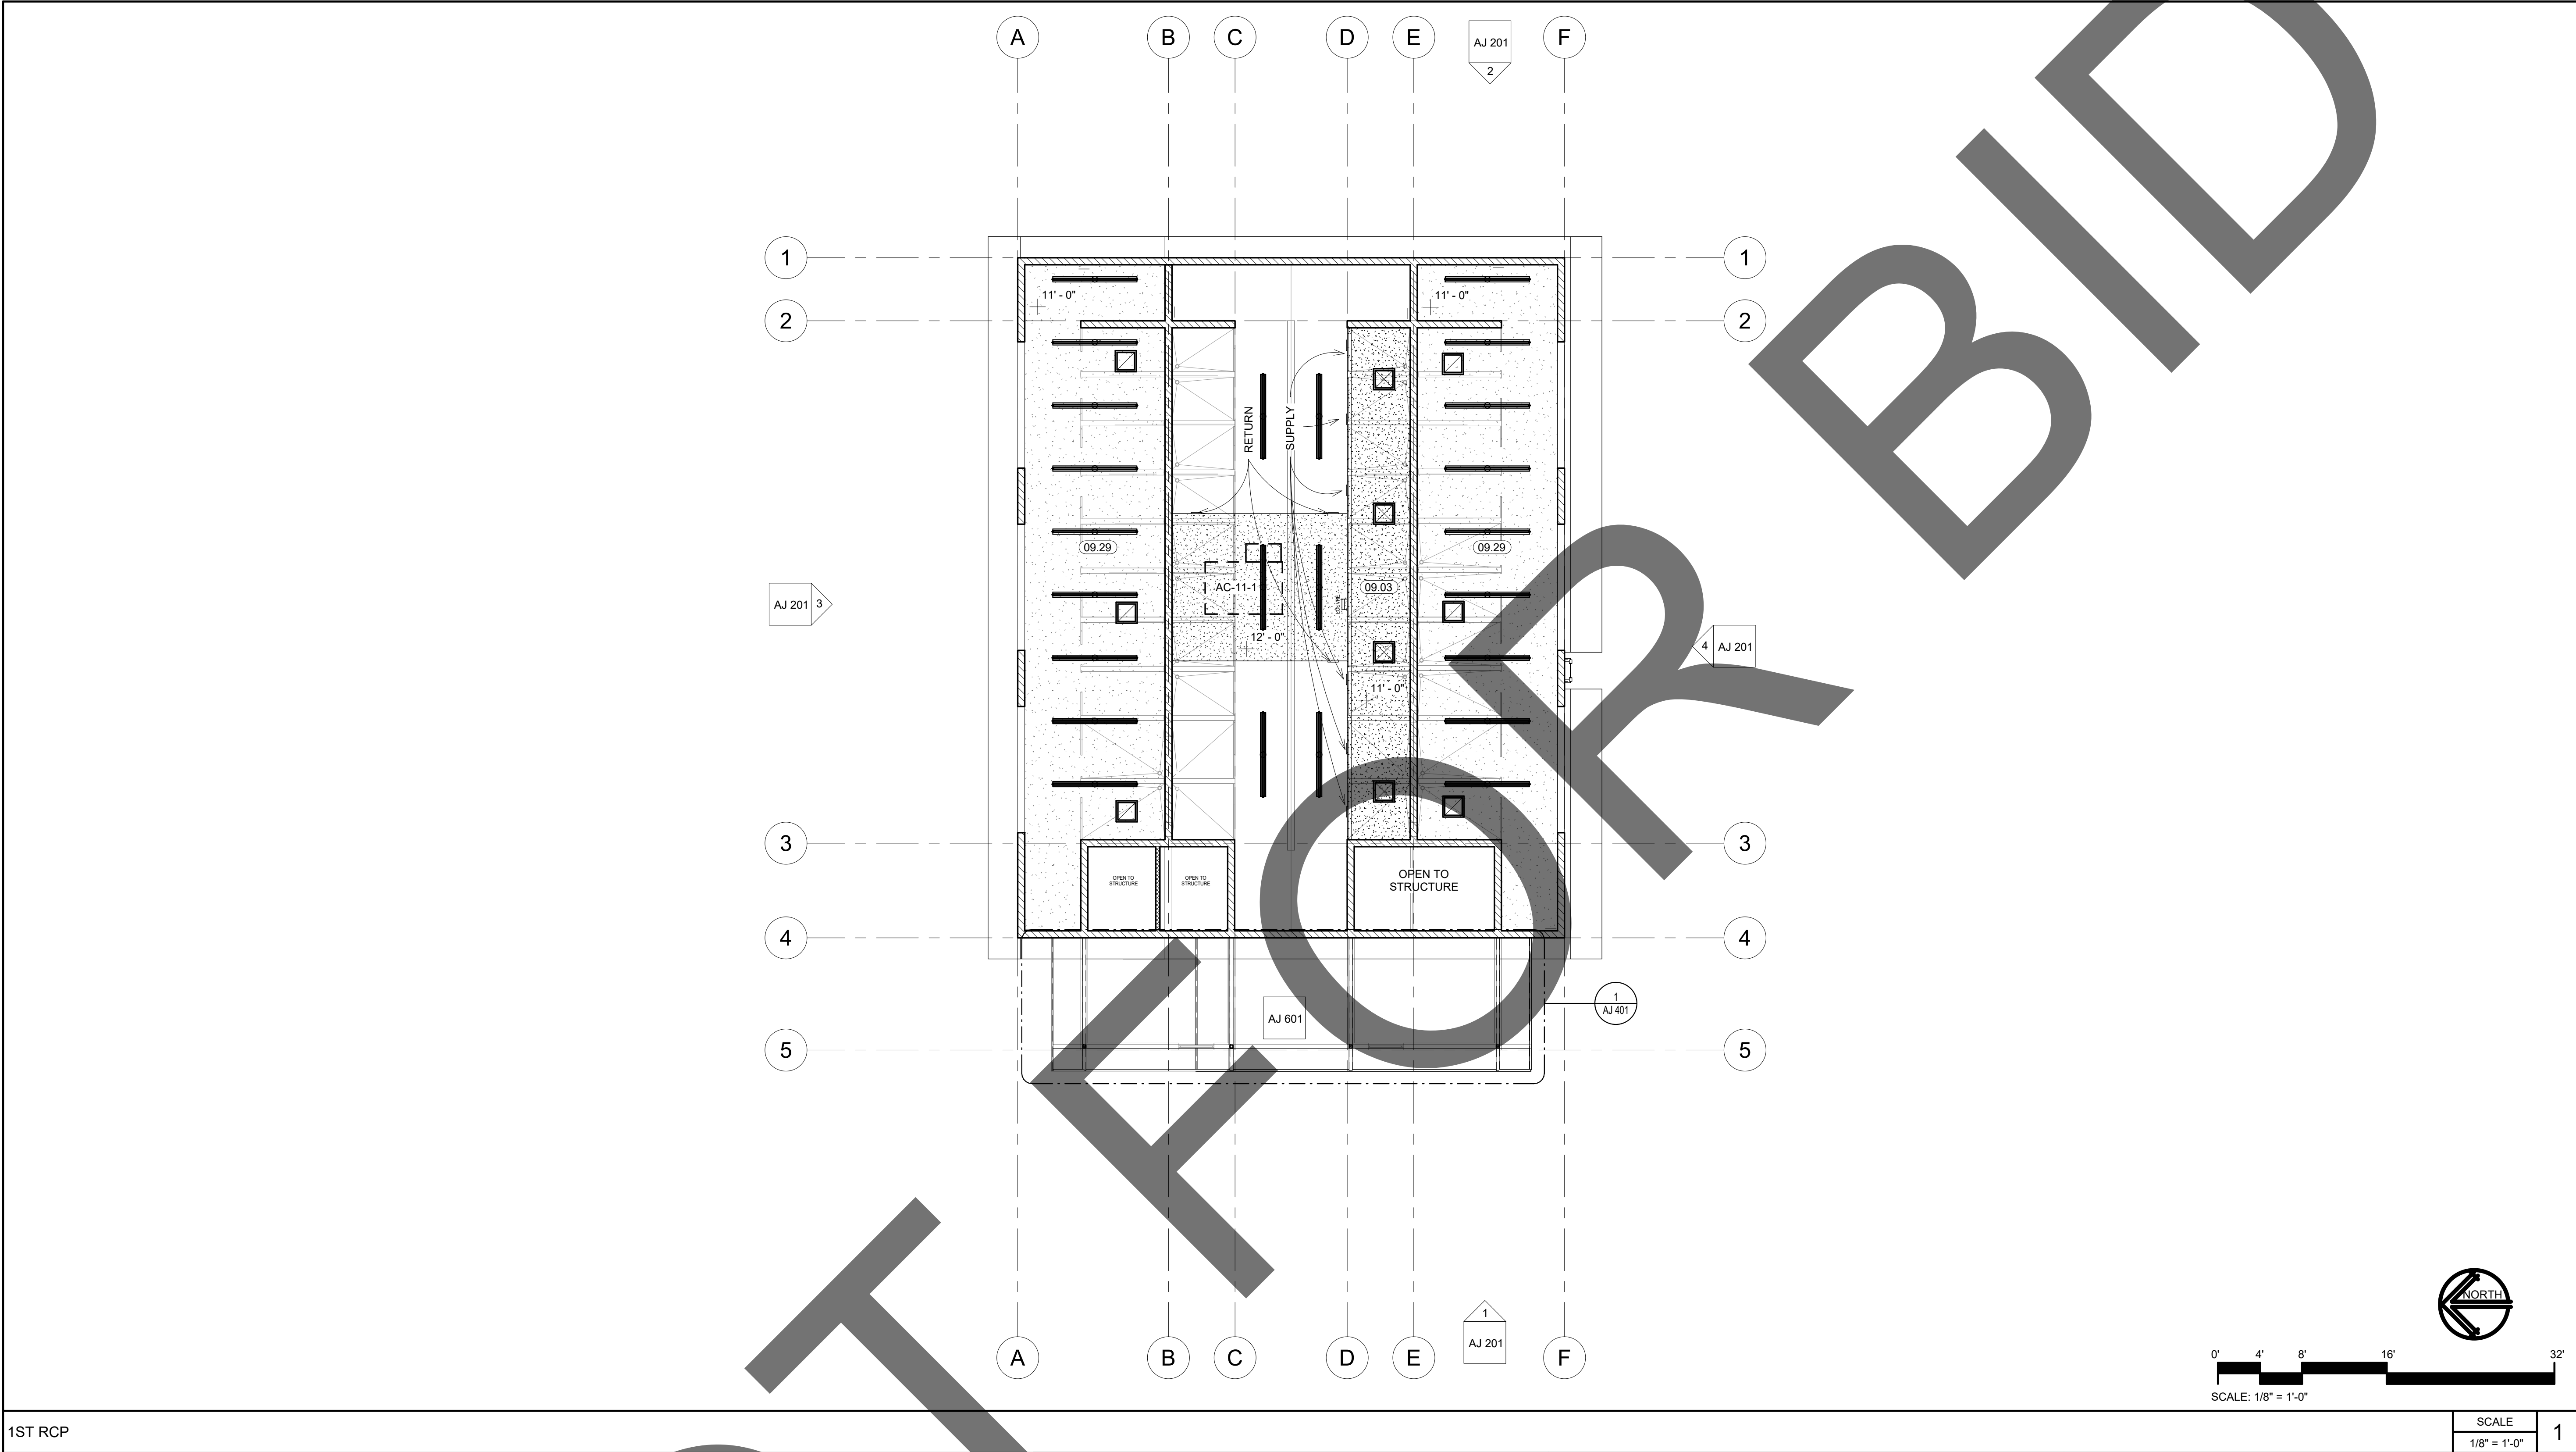

1ST RCP

REFLECTED CEILING PLAN LEGEND:

- 2x2 ACT SUSPENDED CEILING
- GYPSUM BOARD CEILING
- ARMSTRONG CERAMAGARD W/ ALUM. GRID
- CEMENT BOARD CEILING PAINTED
- PENDANT LIGHT FIXTURE. SEE ELECTRICAL
- RECESSED LIGHT FIXTURE. SEE ELECTRICAL
- SURFACE MOUNTED LIGHT FIXTURE. SEE ELECTRICAL
- EXIT SIGN. SEE ELECTRICAL DRAWINGS.
- EXHAUST. SEE ELECTRICAL DRAWINGS.
- SUPPLY / RETURN GRILLE. SEE MECHANICAL
- 0'-0" + CEILING HEIGHT

CEILING LEGEND

SCALE
1/8" = 1'-0"

REFLECTED CEILING PLAN NOTES:


- QUANTITIES LISTED ON THESE DOCUMENTS ARE FOR AGENCY APPROVAL ONLY. THE CONTRACTOR IS RESPONSIBLE FOR VERIFYING ALL QUANTITIES FOR BIDDING PURPOSES.
- ALL NEW WORK SHALL CONFORM TO CURRENT BUILDING STANDARDS, UNLESS NOTED OTHERWISE.
- CONTRACTOR TO VERIFY EXISTING CONSTRUCTION WITHIN THE SCOPE OF WORK TO ENSURE CONFORMANCE WITH NOTED RATINGS AND LOCAL CODES. RETROFIT NON-CONFORMING CONSTRUCTION AS REQUIRED.
- SUSPENSION SYSTEM TO BE "PRELUDE XL" AS MANUFACTURED BY ARMSTRONG WORLD INDUSTRIES, INC. OR EQUAL AS APPROVED BY ARCHITECT.
- PERIODIC INSPECTION OF THE CEILING SUSPENSION SYSTEM SHALL BE PROVIDED IN ACCORDANCE WITH MANUFACTURER'S REQUIREMENTS FOR SPECIFIED COMPONENTS AND CEILING ANCHORAGE SYSTEM.
- REFER TO MECHANICAL, ELECTRICAL, AND PLUMBING DRAWINGS FOR ADDITIONAL SCOPE.

GENERAL - RCP NOTES


SCALE
12" = 1'-0"

KEYNOTE LEGEND

CSI #	KEYNOTE TEXT
09.03	5/8" Gypsum Board
09.29	'Armstrong Ceramaguard' w/ Aluminum Grid

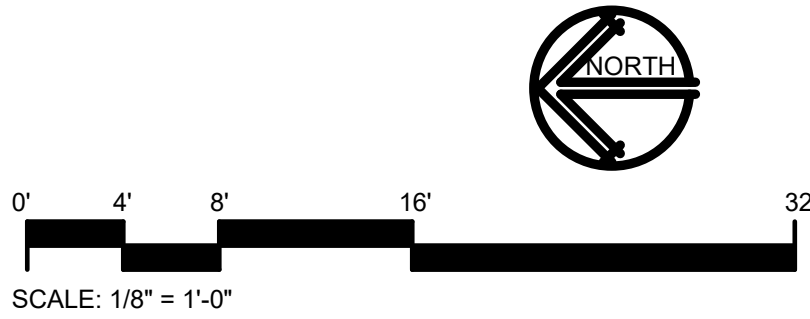

1177 Idaho Street, Suite 200
Redlands, CA 92374
Phone: 909-335-7400
Fax: 909-335-7299
info@miller-aip.com

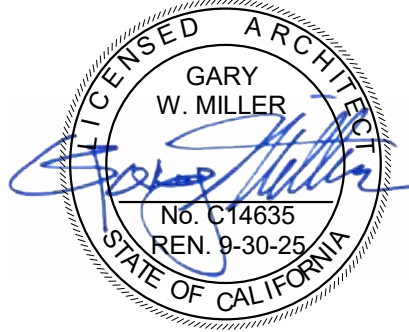

owner approval

initials	date	phase

REVISIONS/ADDENDA

#	Date	Comment
---	------	---------

ANIMAL CARE CENTER

18313 VALLEY BLVD. BLOOMINGTON, CA 92313

SAN BERNARDINO COUNTY

385 N. ARROWHEAD AVENUE
SAN BERNARDINO, CA 92415
PHONE: 1-888-818-8988

PROJECT INFORMATION

Project Number:	2200065
Drawn By:	Author
Checked By:	GWM
Issue Date:	2/29/24

SHEET NAME

ADOPTION DOG BUILDINGS RCP

SHEET NUMBER

AJ 103

Sheet Of Sheets