




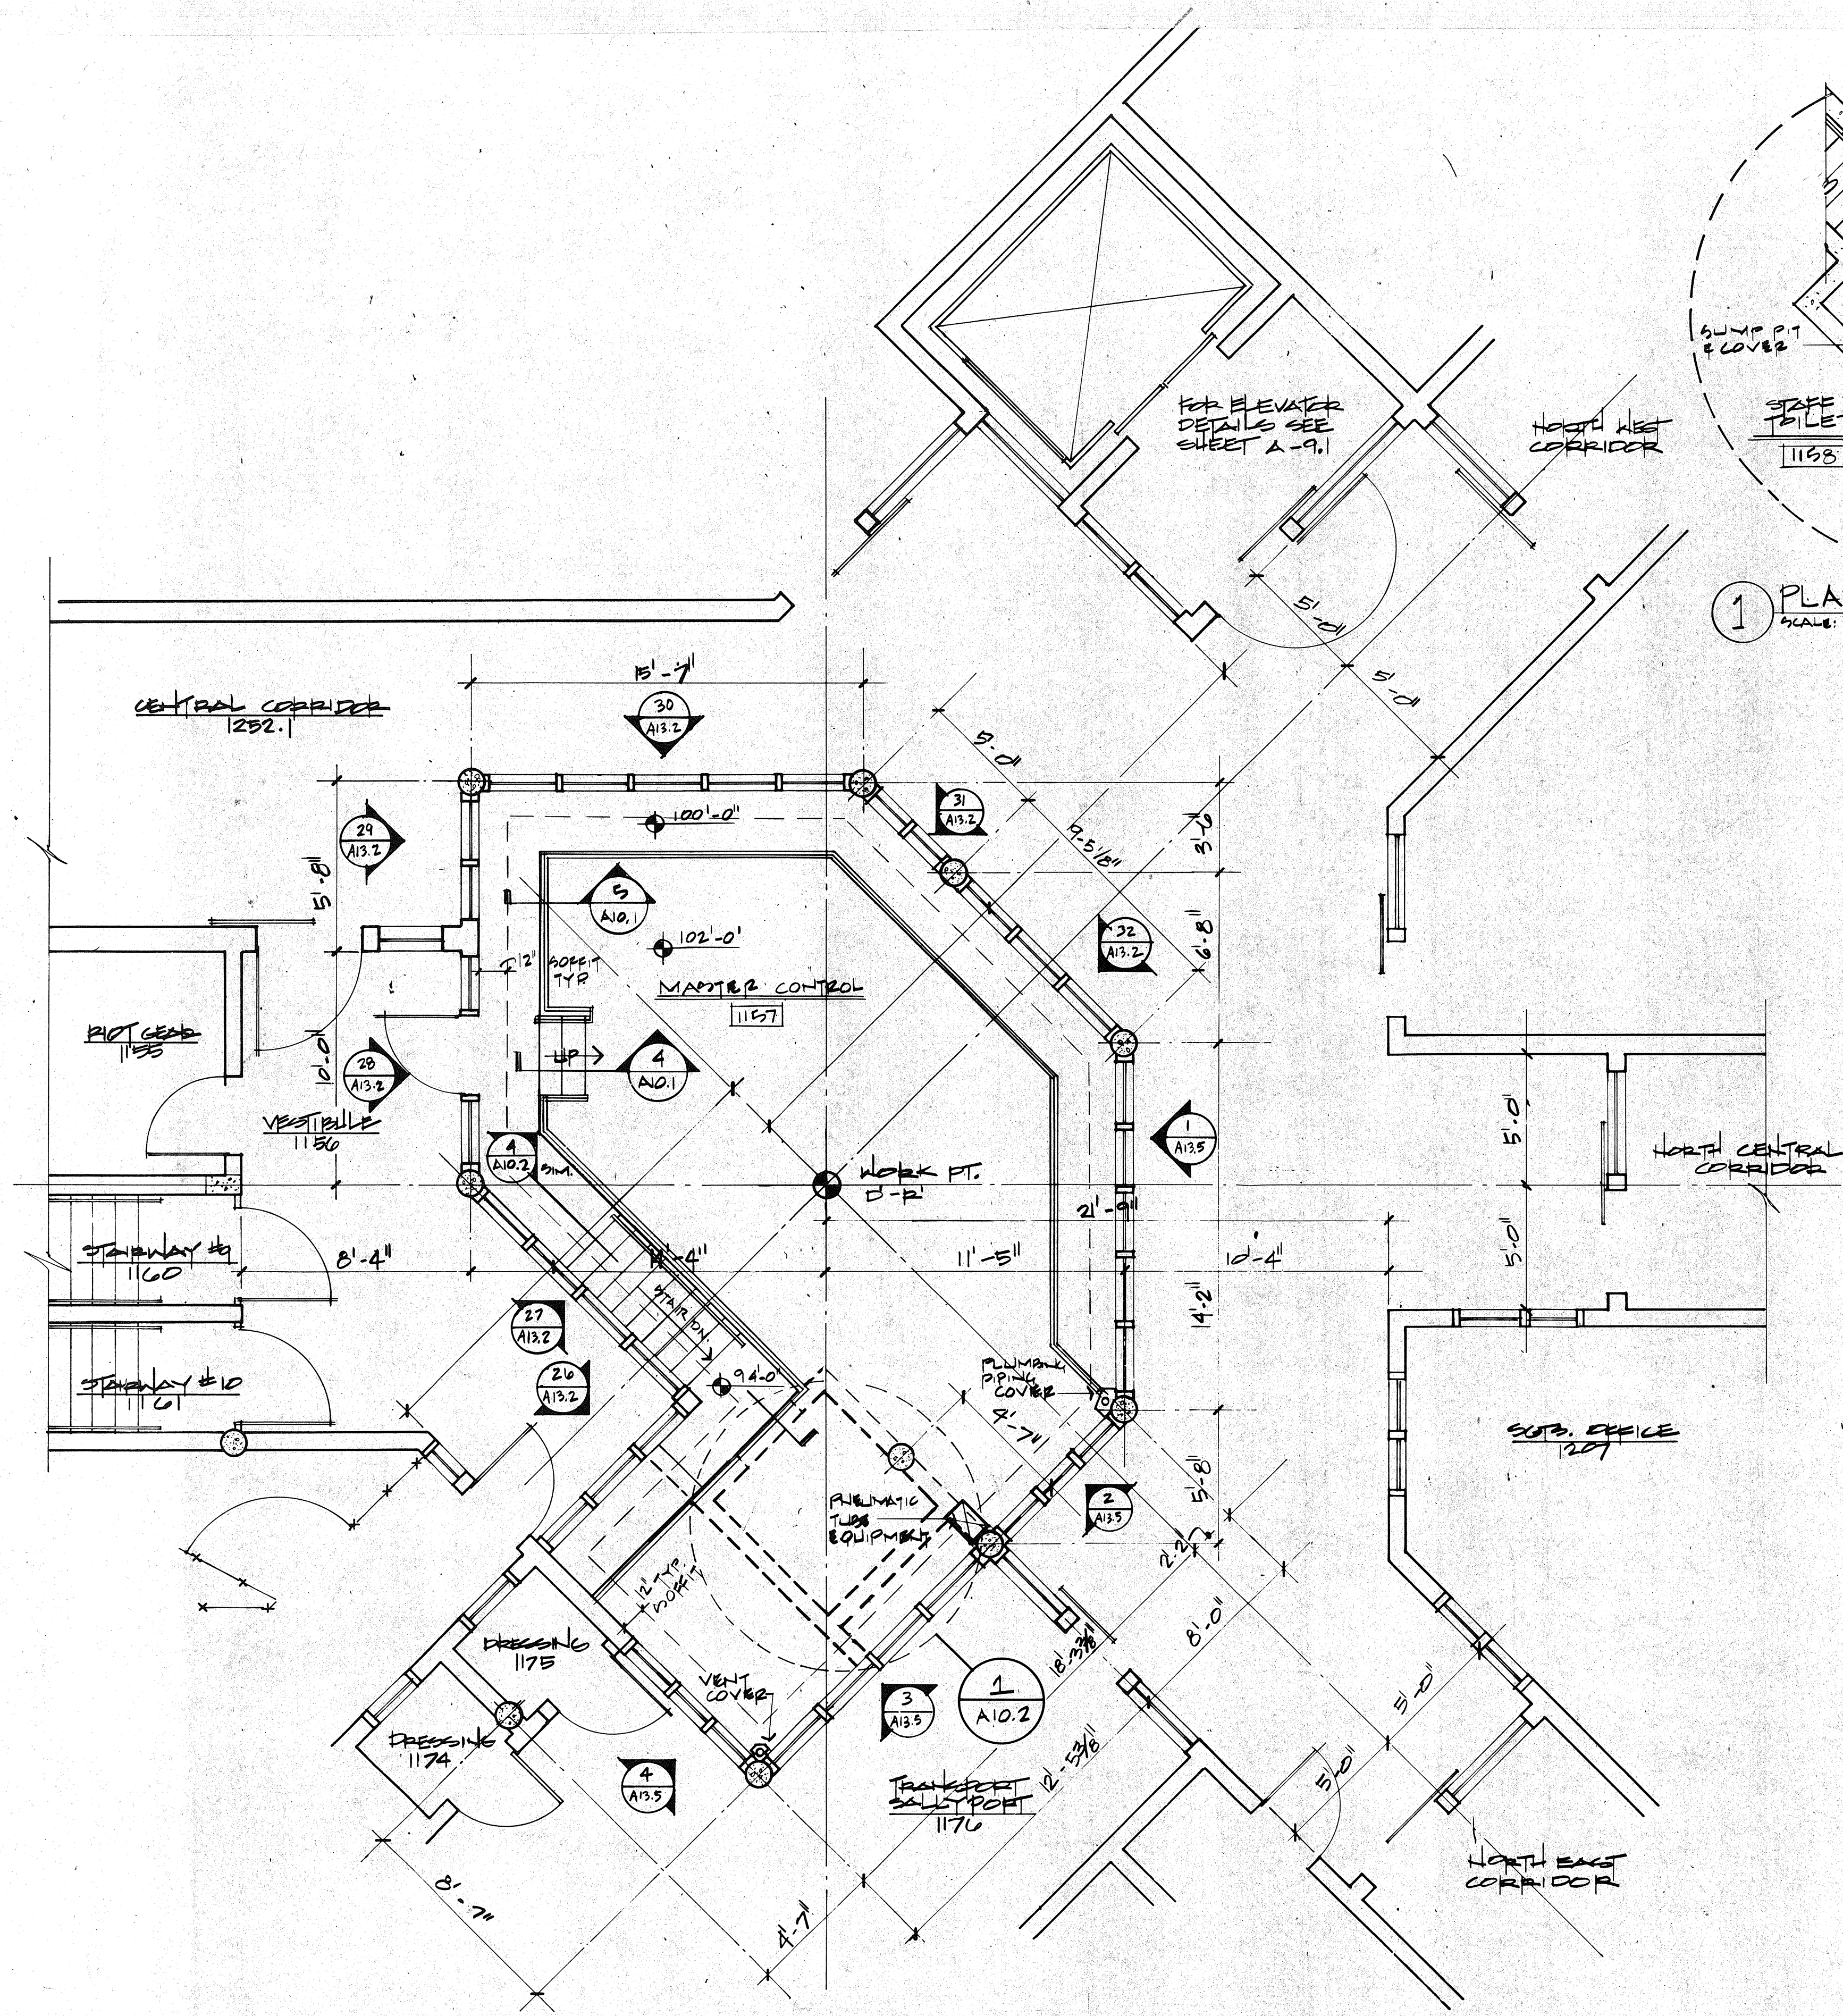


2 MASTER CONTROL ROOM - LEVEL 1 FLOOR PLAN
SCALE: 1/4" = 1'-0"

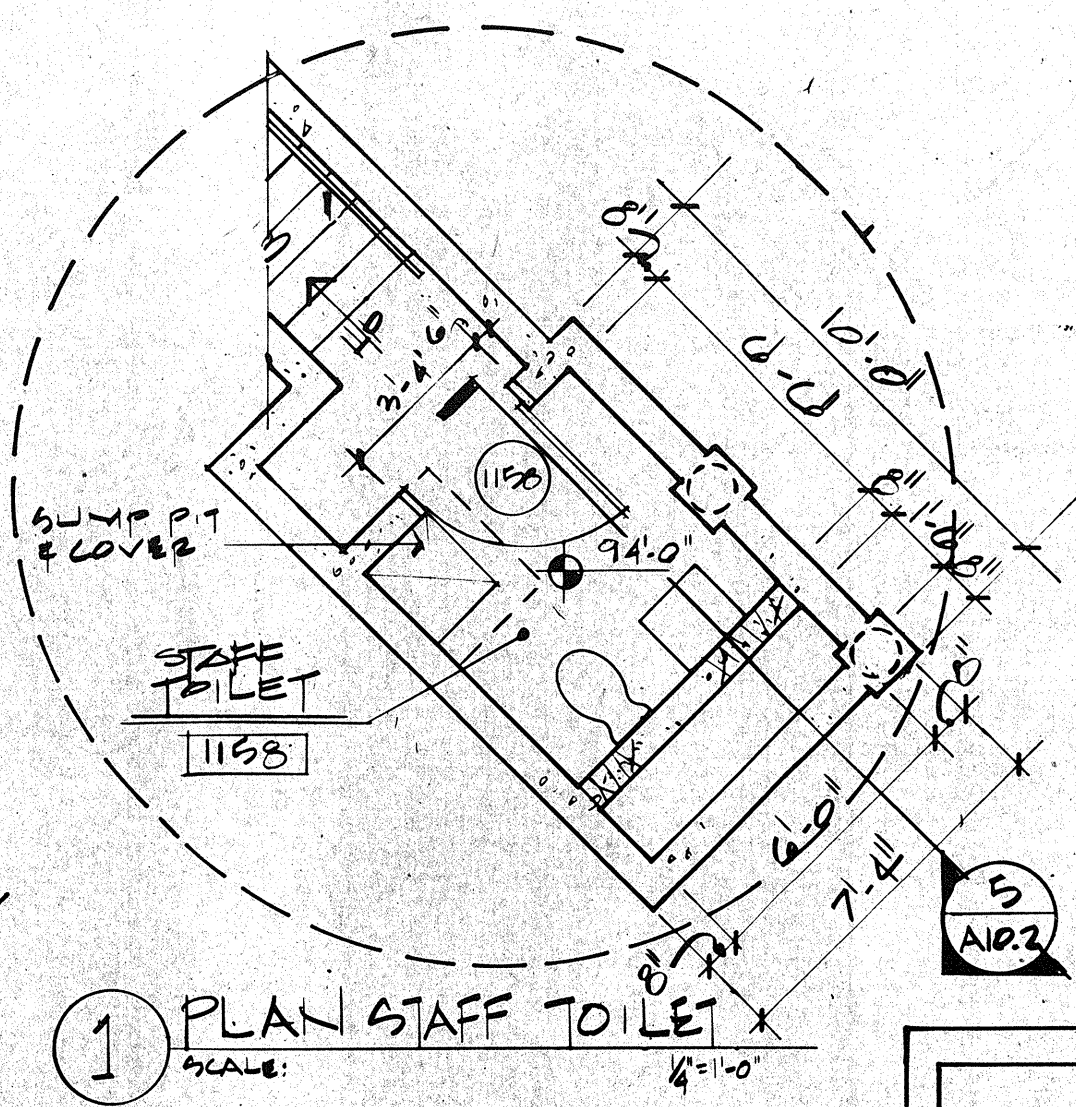


1 PLAN STAFF TOILET
SCALE: 1/4" = 1'-0"

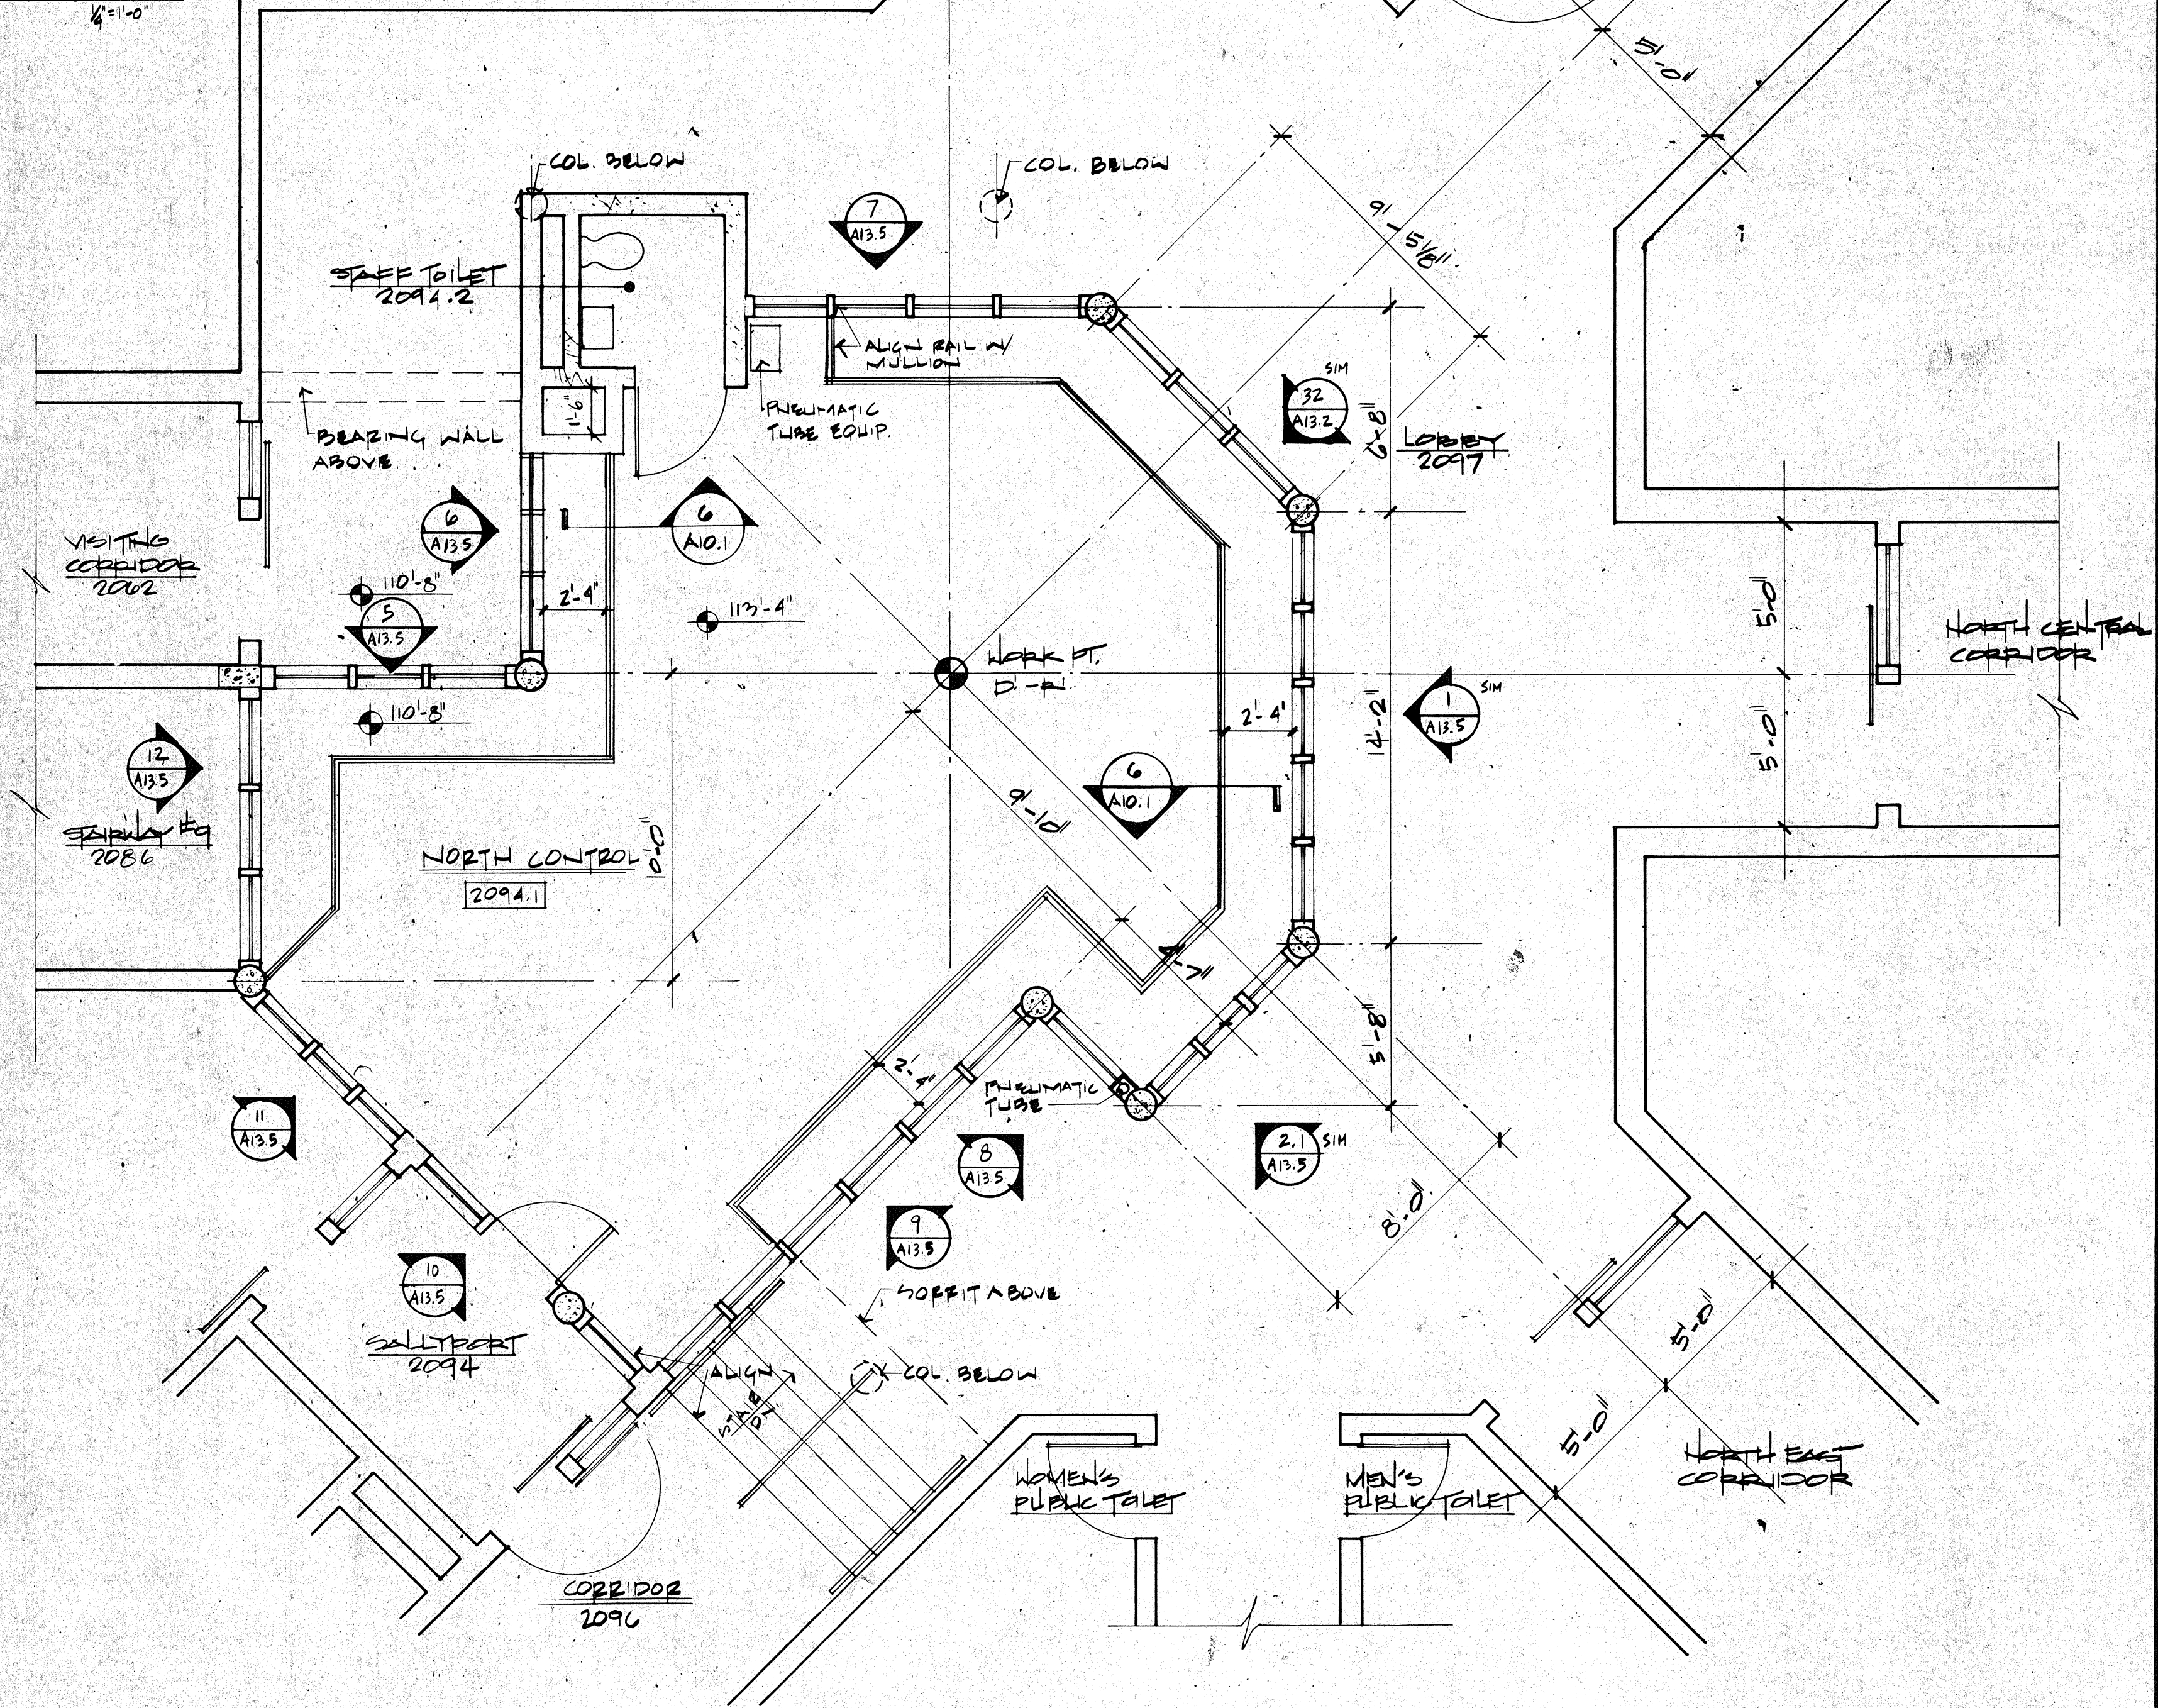


3 NORTH CONTROL ROOM - LEVEL 2 FLOOR PLAN
SCALE: 1/4" = 1'-0"

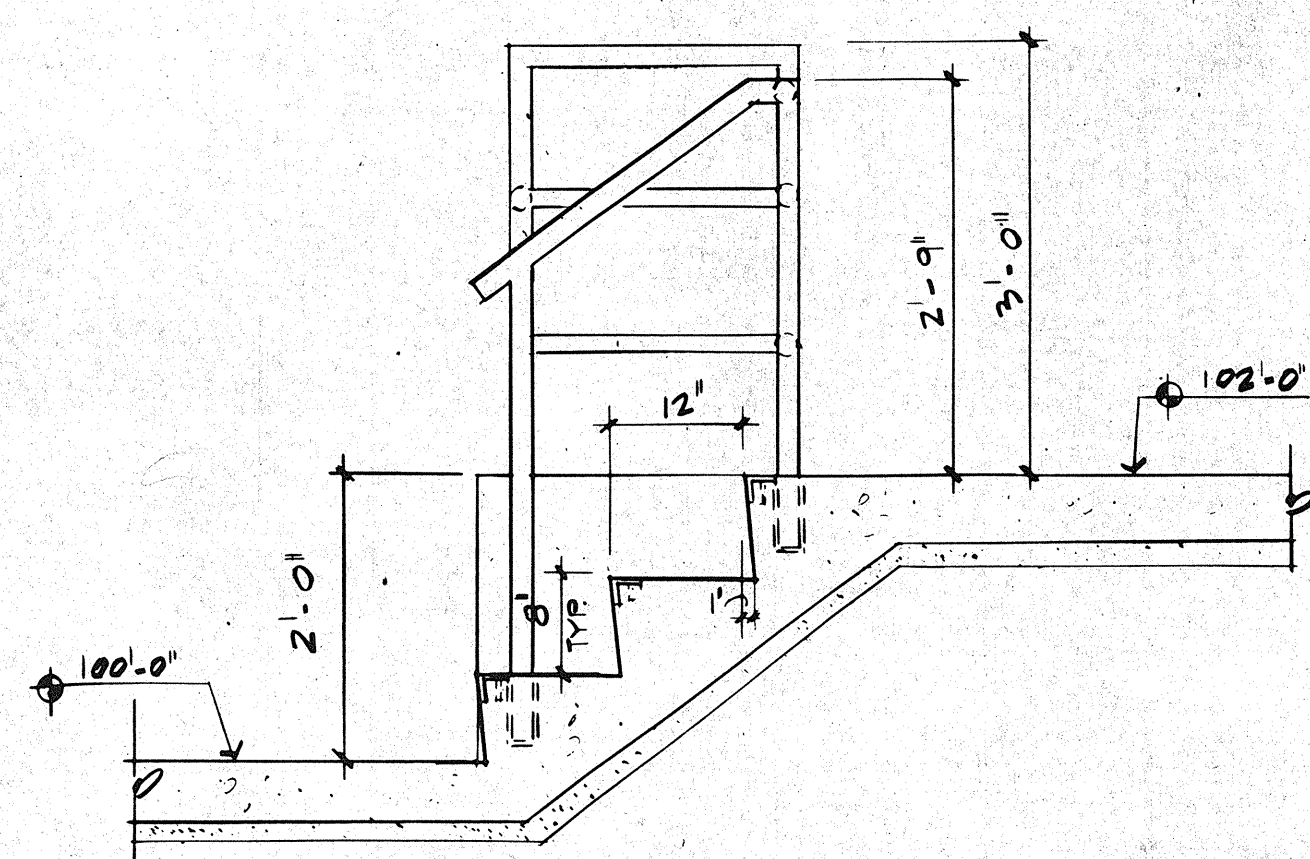


4 SECTION THRU STAIR
SCALE: 1/4" = 1'-0"

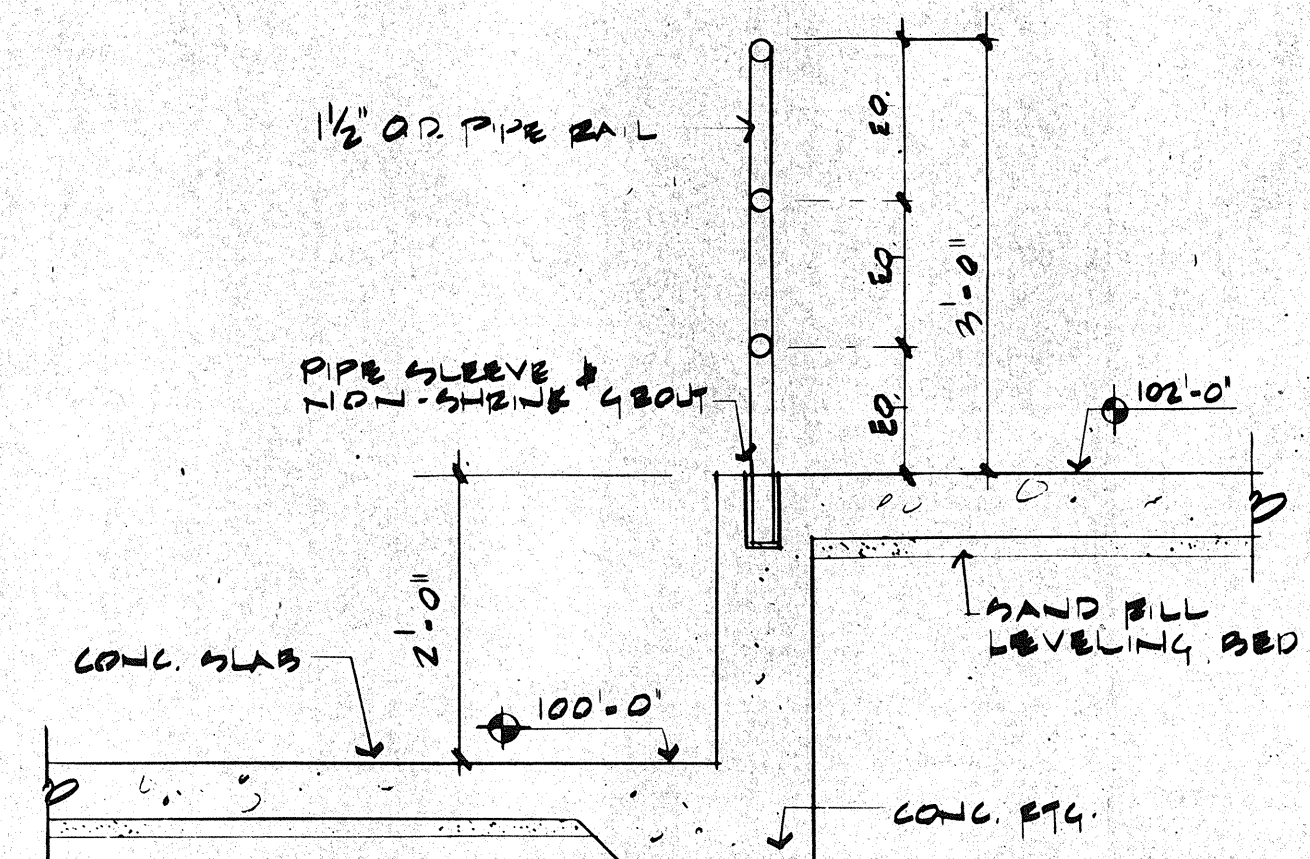

5 SECTION THRU RAISED PLATFORM
SCALE: 1/4" = 1'-0"

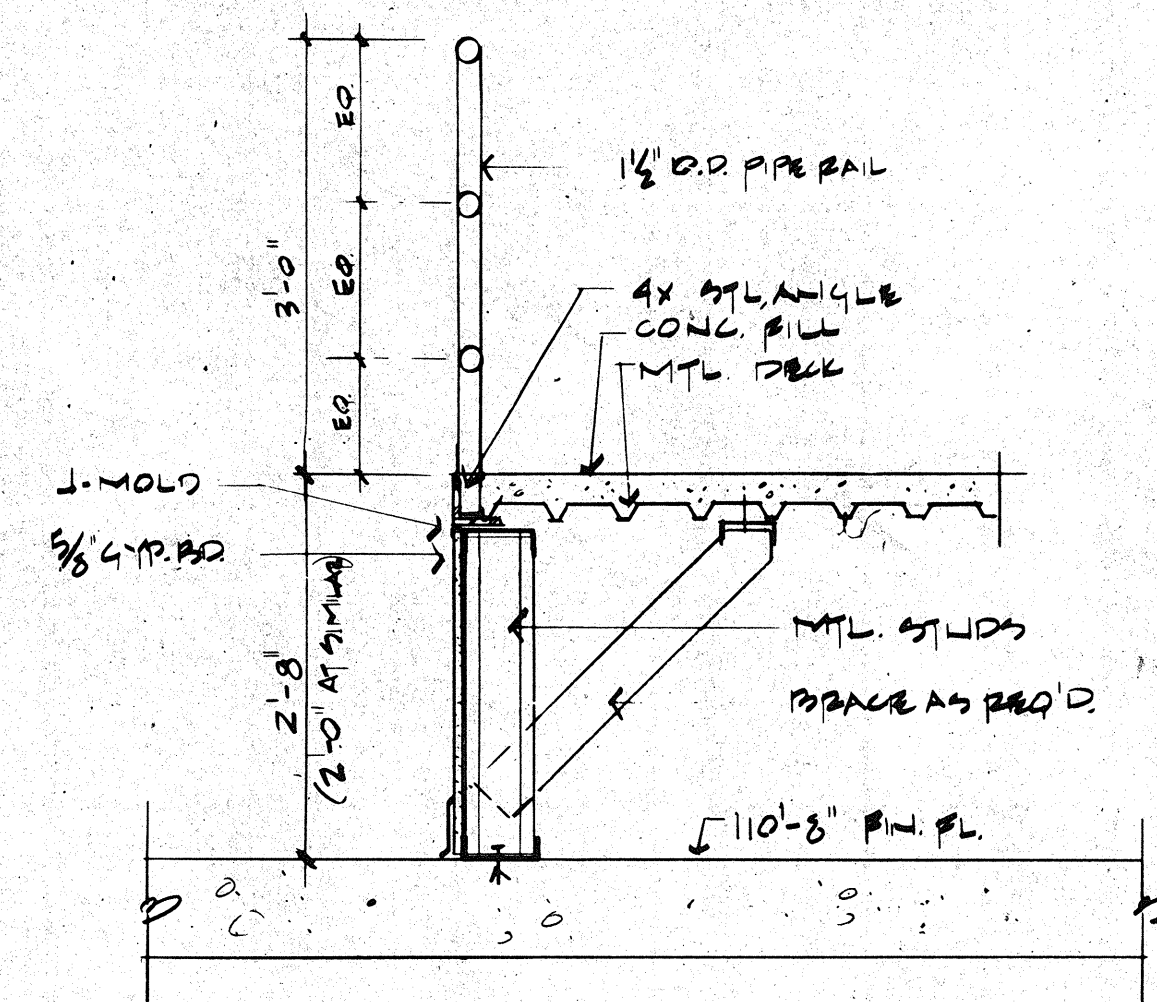

6 SECTION THRU RAISED FLOOR
SCALE: 1/4" = 1'-0"

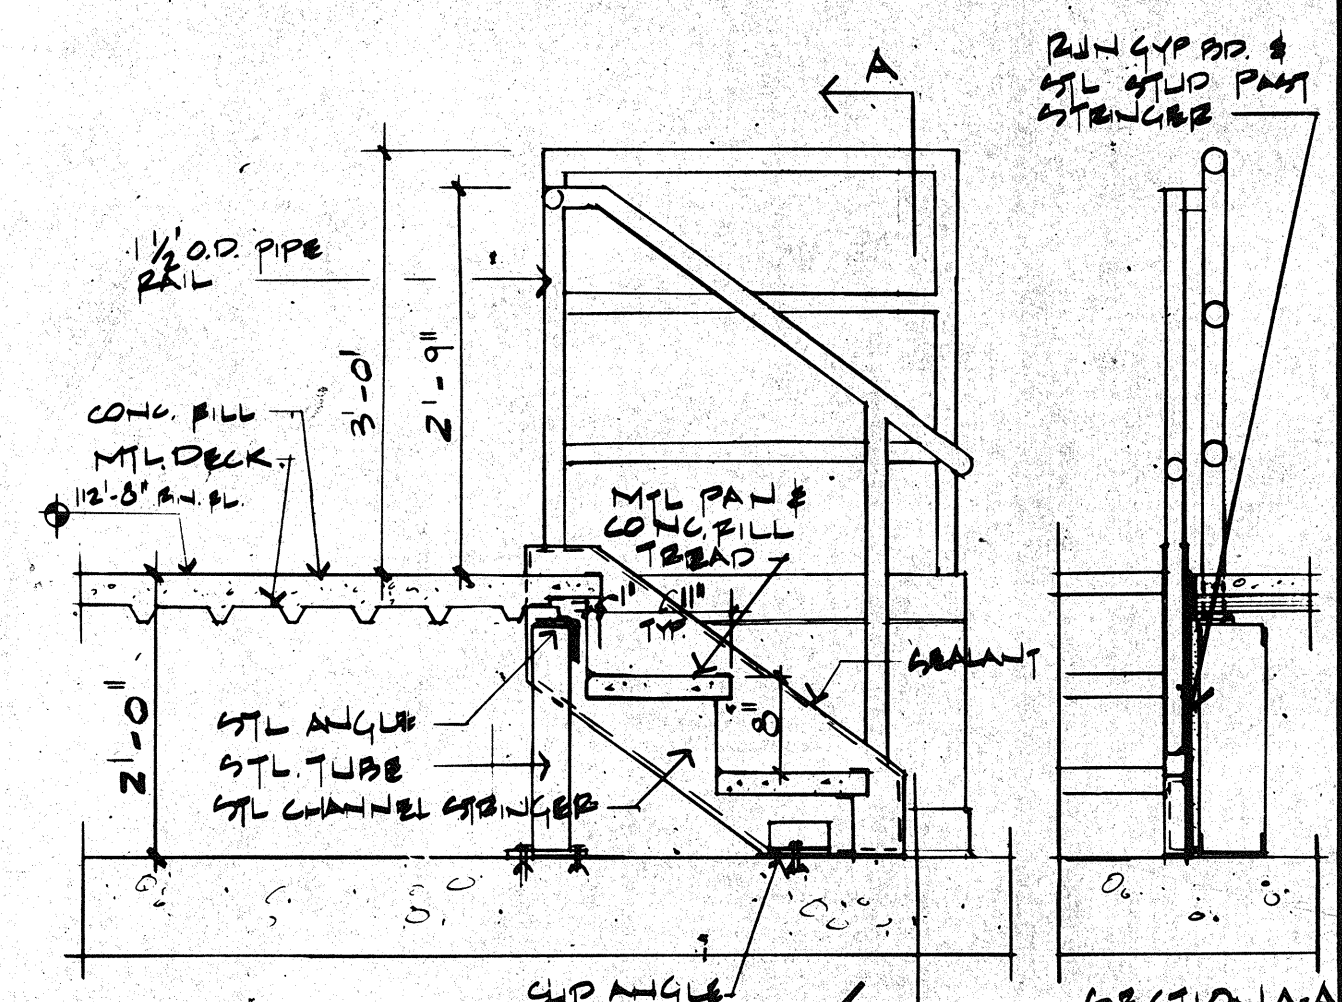

7 RAISED FLOOR STAIR SECTION
SCALE: 1/4" = 1'-0"


RF ROSSER FABRAP INTERNATIONAL
Comprehensive Services for Building
Design and Technology
Atlanta Savannah Tampa

Revisions
No. Date Description
1 2/17/89 ADDENDA POSTED/ISSUED FOR CONSTRUCTION

ROSSER FABRAP INTERNATIONAL
Criminal Justice Architecture Technology Planning Interiors
Mechanical Electrical Planning Security & Civil Engineering

JUSTICE SYSTEMS INCORPORATED
Criminal Justice Operations Programming
JOHNSON & NIELSEN
Structural Engineering

WEST - VALLEY - DETENTION - CENTER
FOR THE COUNTY OF SAN BERNARDINO - CALIFORNIA
HARRY MANS, COUNTY ADMINISTRATION OFFICER
FLOYD TIDWELL, SHERIFF
BOARD OF SUPERVISORS
John E. Bunker, Chairman, Board of Supervisors
Stanley Green, Supervisor, Third District
Robert Hammond, Supervisor, First District
Robert Hammond, Supervisor, Second District
Robert Hammond, Supervisor, Fourth District

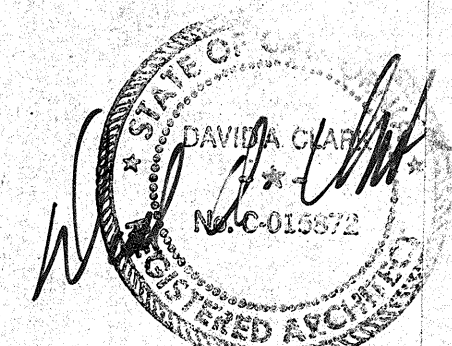

CONTROL ROOM
1/4" SCALE PLANS

Job No. 88058.24
Date 10/11/88
A1